


FILE NAME: I:\Projects\MEG\05050.00\Drawings\5-06-121.dwg PLOT TIME: Wed, 27 Nov 2019 - 3:25pm LAST SAVE: Wed, 27 Nov 2019 - 3:24pm BY: mlls

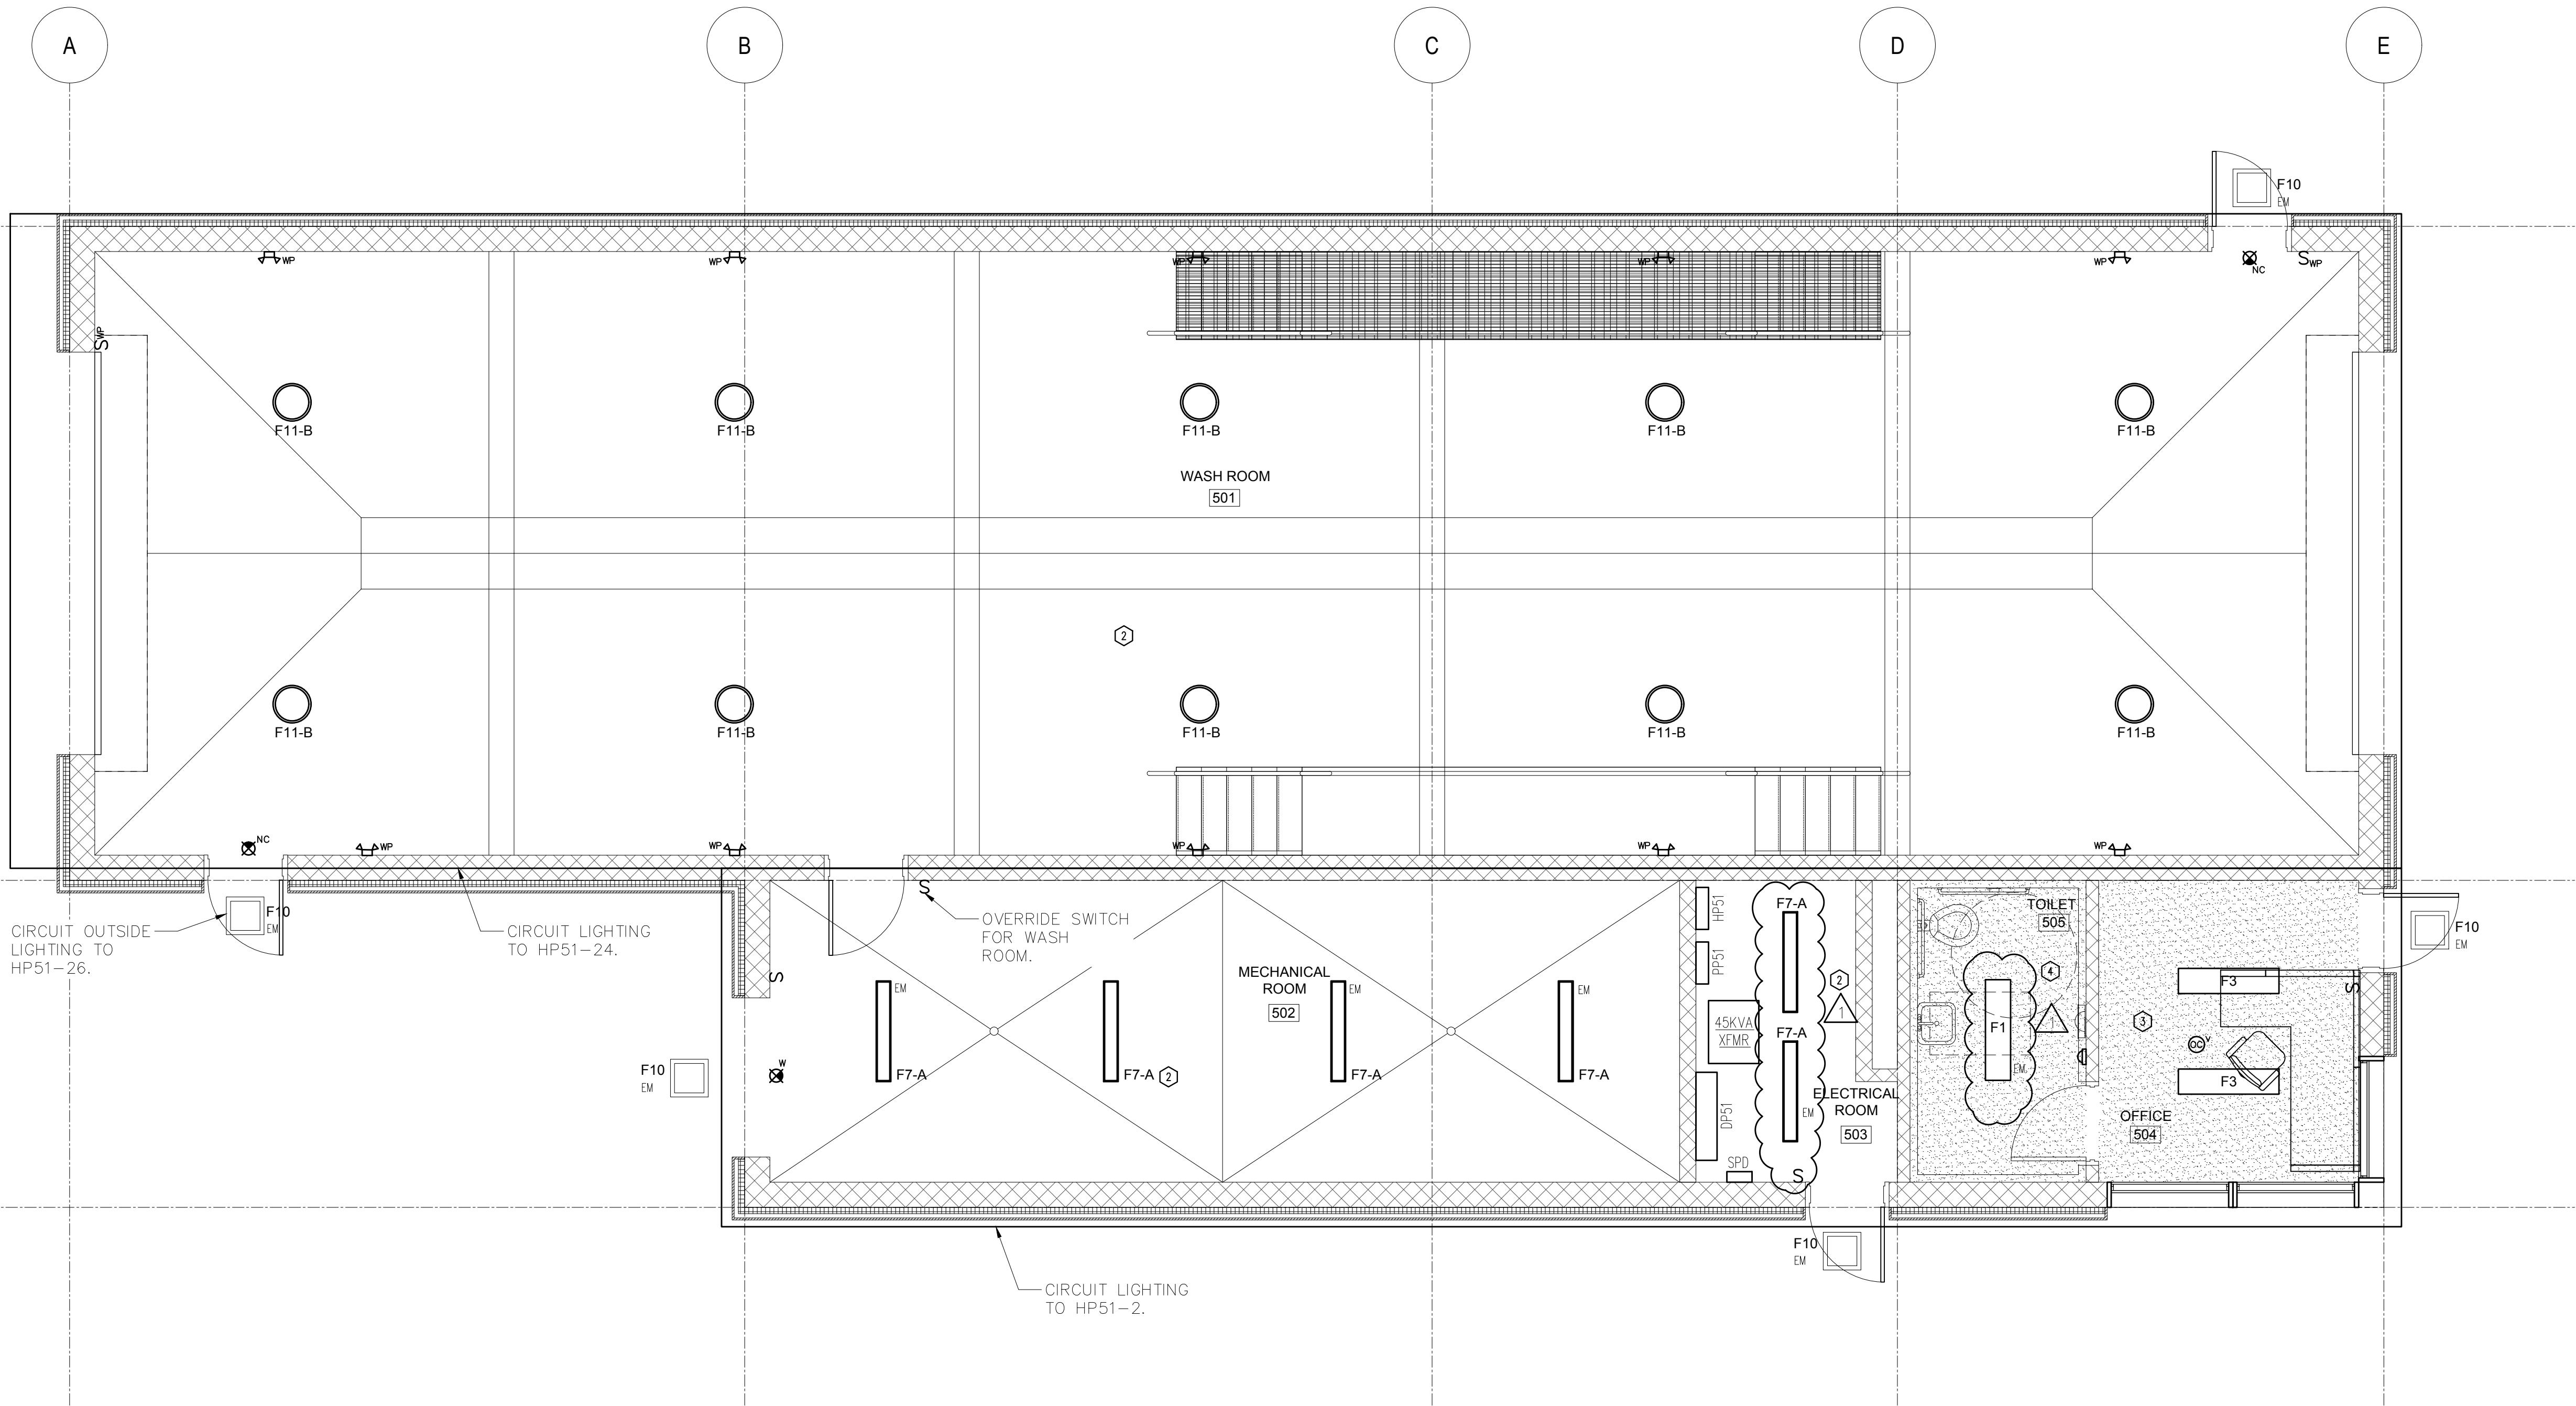


LIGHTING CONTROL LEGEND

- ① - TIME CLOCK WITH OCCUPANCY SENSOR OVERRIDE AFTER HOURS. (NOT USED)
- ② - LINE VOLTAGE ON/OFF WALL SWITCHING.
- ③ - LOW VOLTAGE MANUAL ON WALL SWITCH WITH CEILING MOUNT VACANCY.
- ④ - LOW VOLTAGE WALL SWITCH OCCUPANCY SENSOR.

ADD ALTERNATE #1

ALL WORK ASSOCIATED WITH BUILDING 5 SHALL BE PRICED AS PART OF ADD ALTERNATE #1.

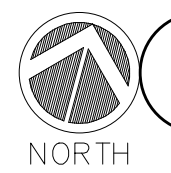


1 ELECTRICAL BUILDING 05 LIGHTING PLAN

SCALE: 1/4" = 1'-0"

NOTES:

- 1.) SEE DRAWINGS 0.06.604 & 0.06.605 FOR LIGHTING FIXTURE SCHEDULE, LIGHTING CONTROL DESIGN INTENT & LIGHTING SYSTEM FUNCTIONAL TESTING/COMMISSIONING NOTES.
- 2.) ALL CONDUITS IN WASH ROOM AND MECHANICAL ROOM SHALL BE SCHEDULE 80 PVC.

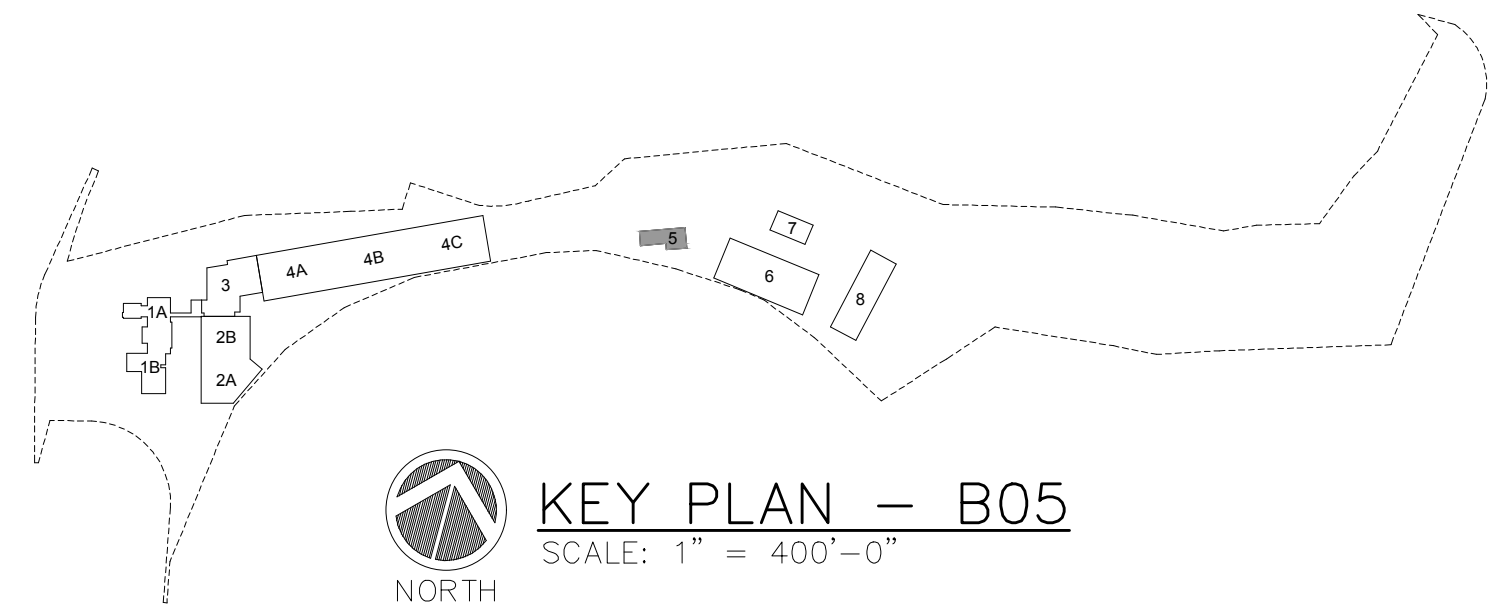

KEY PLAN - B05

SCALE: 1" = 400'-0"

WARNING - IT IS A VIOLATION OF NEW YORK STATE EDUCATIONAL LAW, SECTION 7209.2, FOR ANY PERSON, UNLESS HE IS ACTING UNDER THE DIRECTION OF A LICENSED PROFESSIONAL ENGINEER OR LAND SURVEYOR, TO ALTER THIS DOCUMENT IN ANY WAY. IF ALTERED, THE ALTERING PERSON SHALL COMPLY WITH THE REQUIREMENTS OF NEW YORK EDUCATIONAL LAW, SECTION 7209.2

COPYRIGHT © 2019, McLAREN ENGINEERING GROUP

STV 100 Years
STV Architects, P.C.
225 Park Avenue South
New York, NY 10003
(212) 777-4400 FAX: (212) 473-2780
www.stvinc.com


OLA Consulting Engineers
50 Broadway,
Hawthorne, NY 10532
914.747.2800
8 West 38th Street,
Suite 501
New York, NY 10018
646.648.4110
ola.com NMEG0050.00

Gannett Fleming
FACILITIES CONSULTANT

IQ
Imbiano-Quigley
Landscape Architects
31 Monmouth Ave., 7th Floor
White Plains, New York 10601
admin@iqlandscape.com
(914) 232-6090

PROJECT
**COUNTY OF ROCKLAND
CAPITAL PROJECT NO. 1307
HIGHWAY DEPARTMENT /
EMERGENCY OPERATIONS FACILITY**
COUNTY OF ROCKLAND, NEW YORK

McLaren ENGINEERING GROUP
applied ingenuity
M. G. McLaren Engineering
and Land Surveying P.C.
530 Chestnut Ridge Road, Woodcliff Lake, NJ 07677
T: 201.775.6000 F: 201.746.8522 www.mgmclaren.com

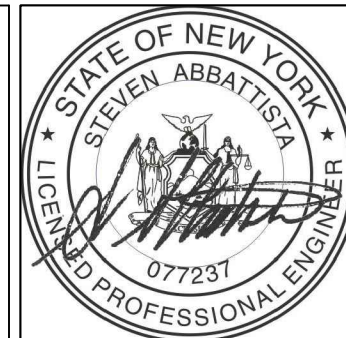

ELECTRICAL BUILDING 05 LIGHTING PLAN

No.	DATE	ADDENDUM 07 REVISION	BY
1	11/27/19		VB

PROJECT NO. 130439
SCALE As indicated
DATE OCTOBER 30, 2019
DRAWN BY CT
CHECKED BY ML
APPROVED BY DS

ISSUED FOR
BID SET
DRAWING NO.
5.06.121
OF SHTS