




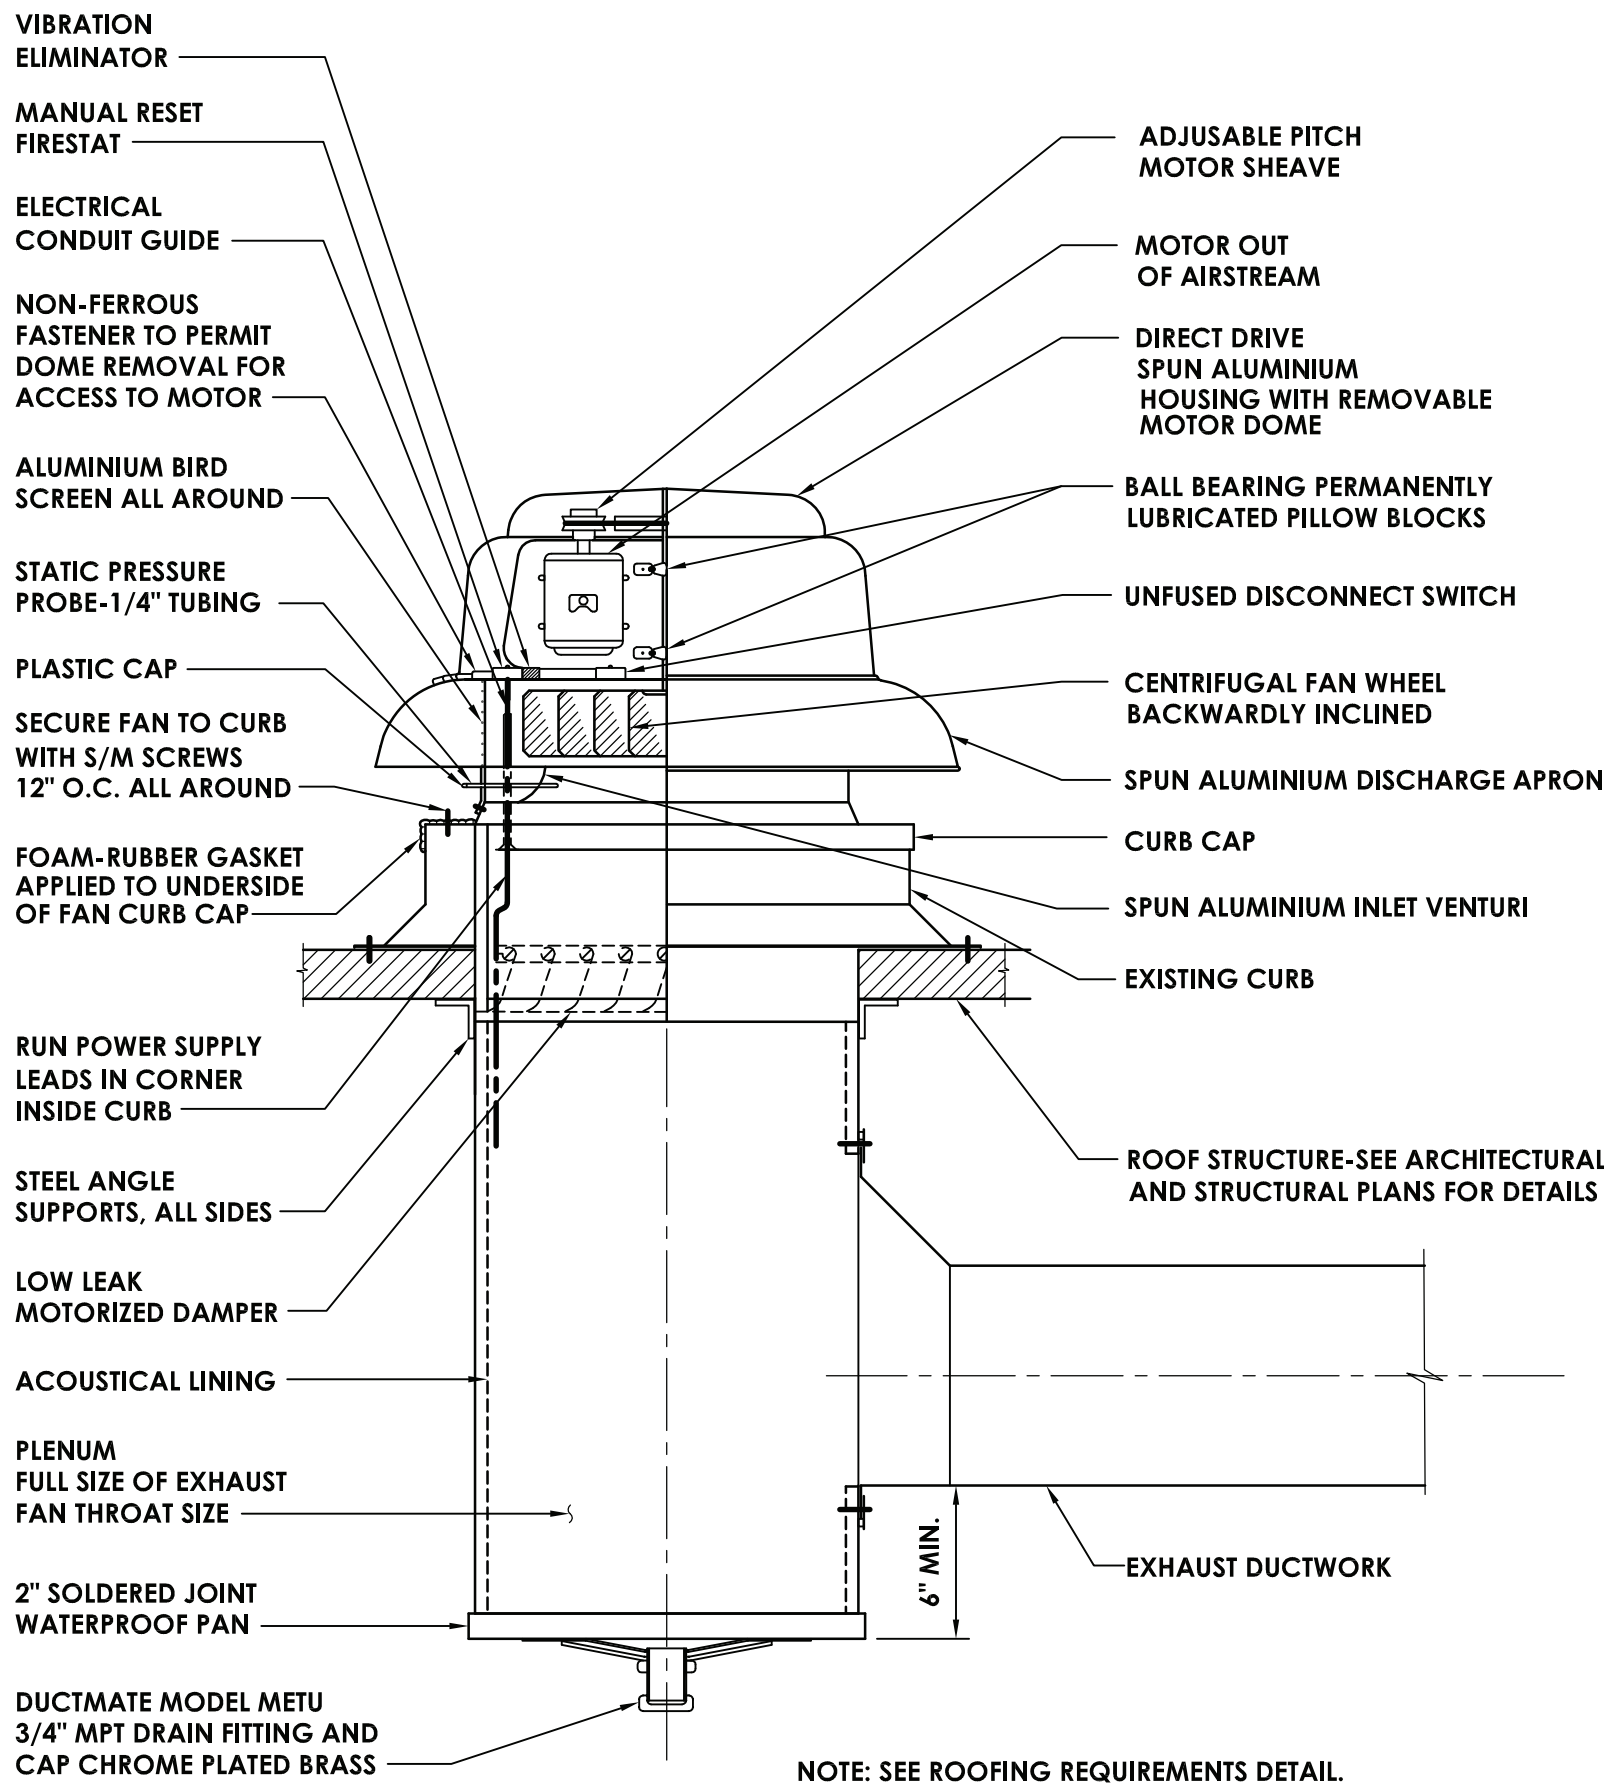


6 EXHAUST FAN DETAIL
H201 NOT TO SCALE

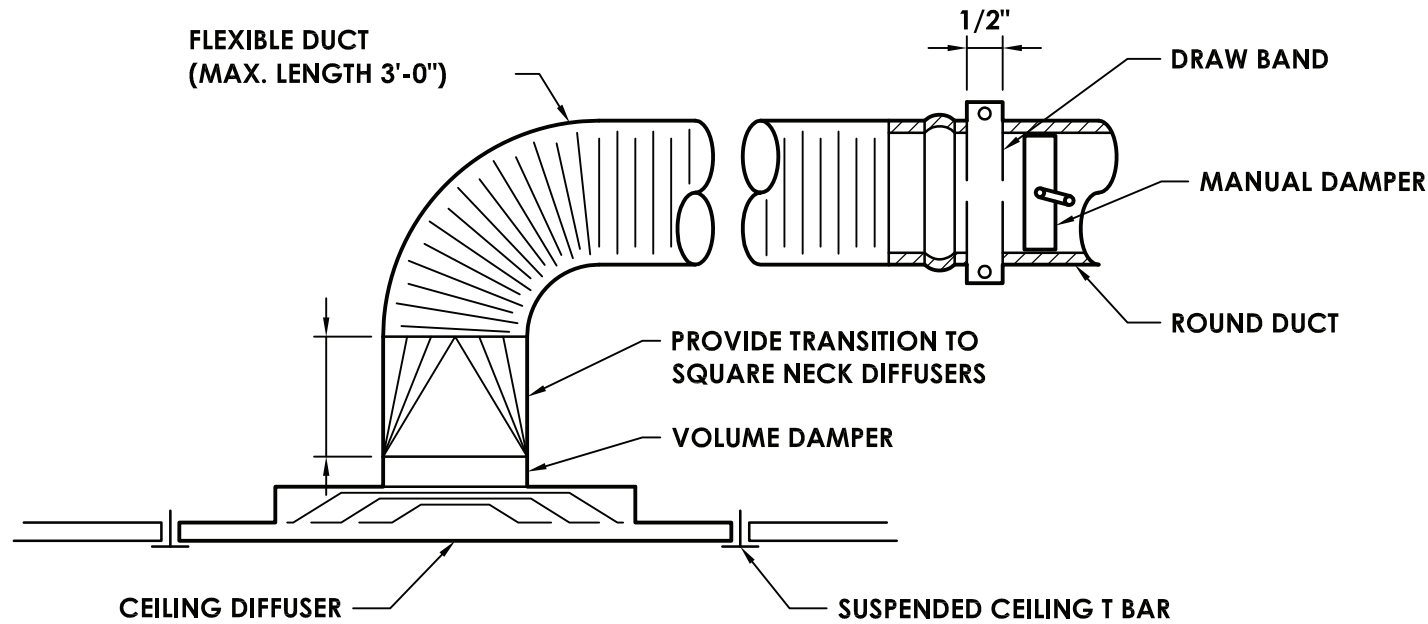

7 DIFFUSER DETAIL
H201 NOT TO SCALE

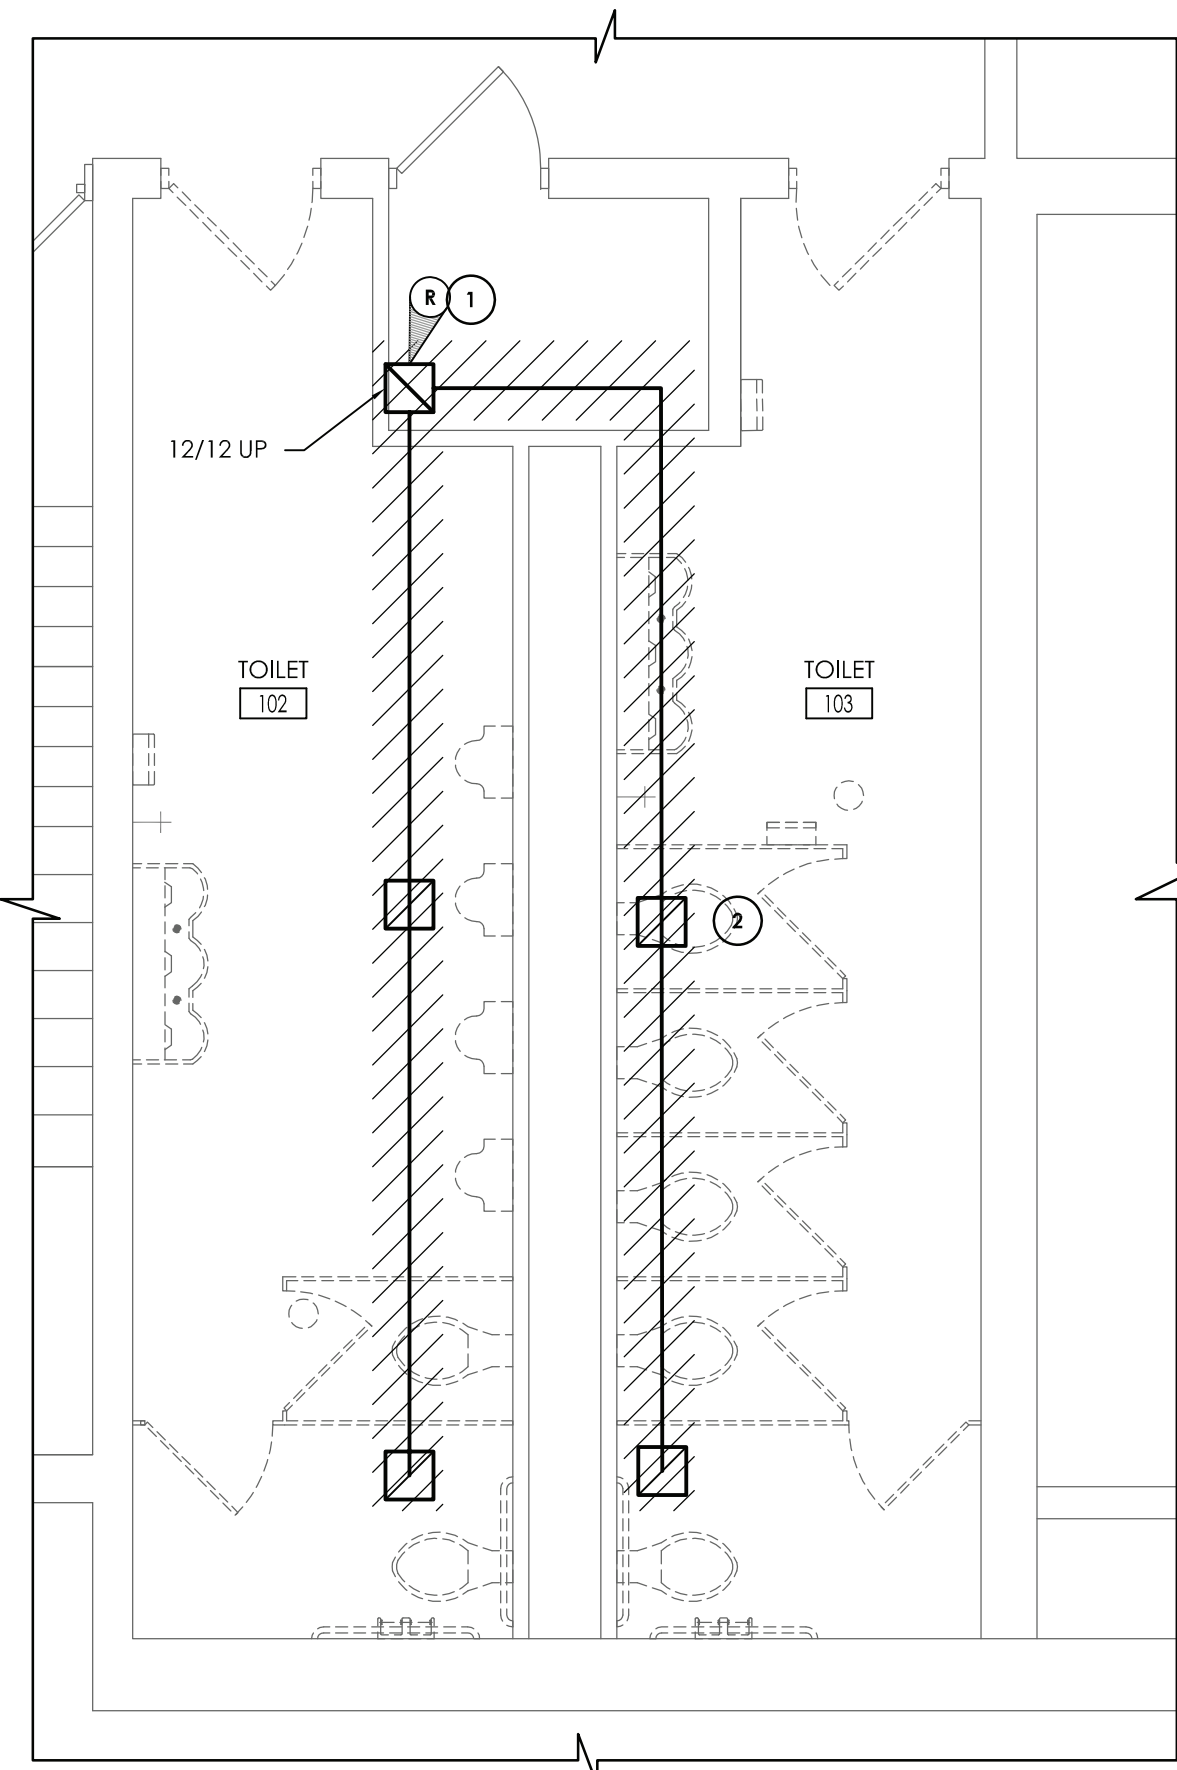

1 TOILET ROOMS #102 & #103 DEMOLITION PLAN
H201 SCALE: 1/4" = 1'-0"

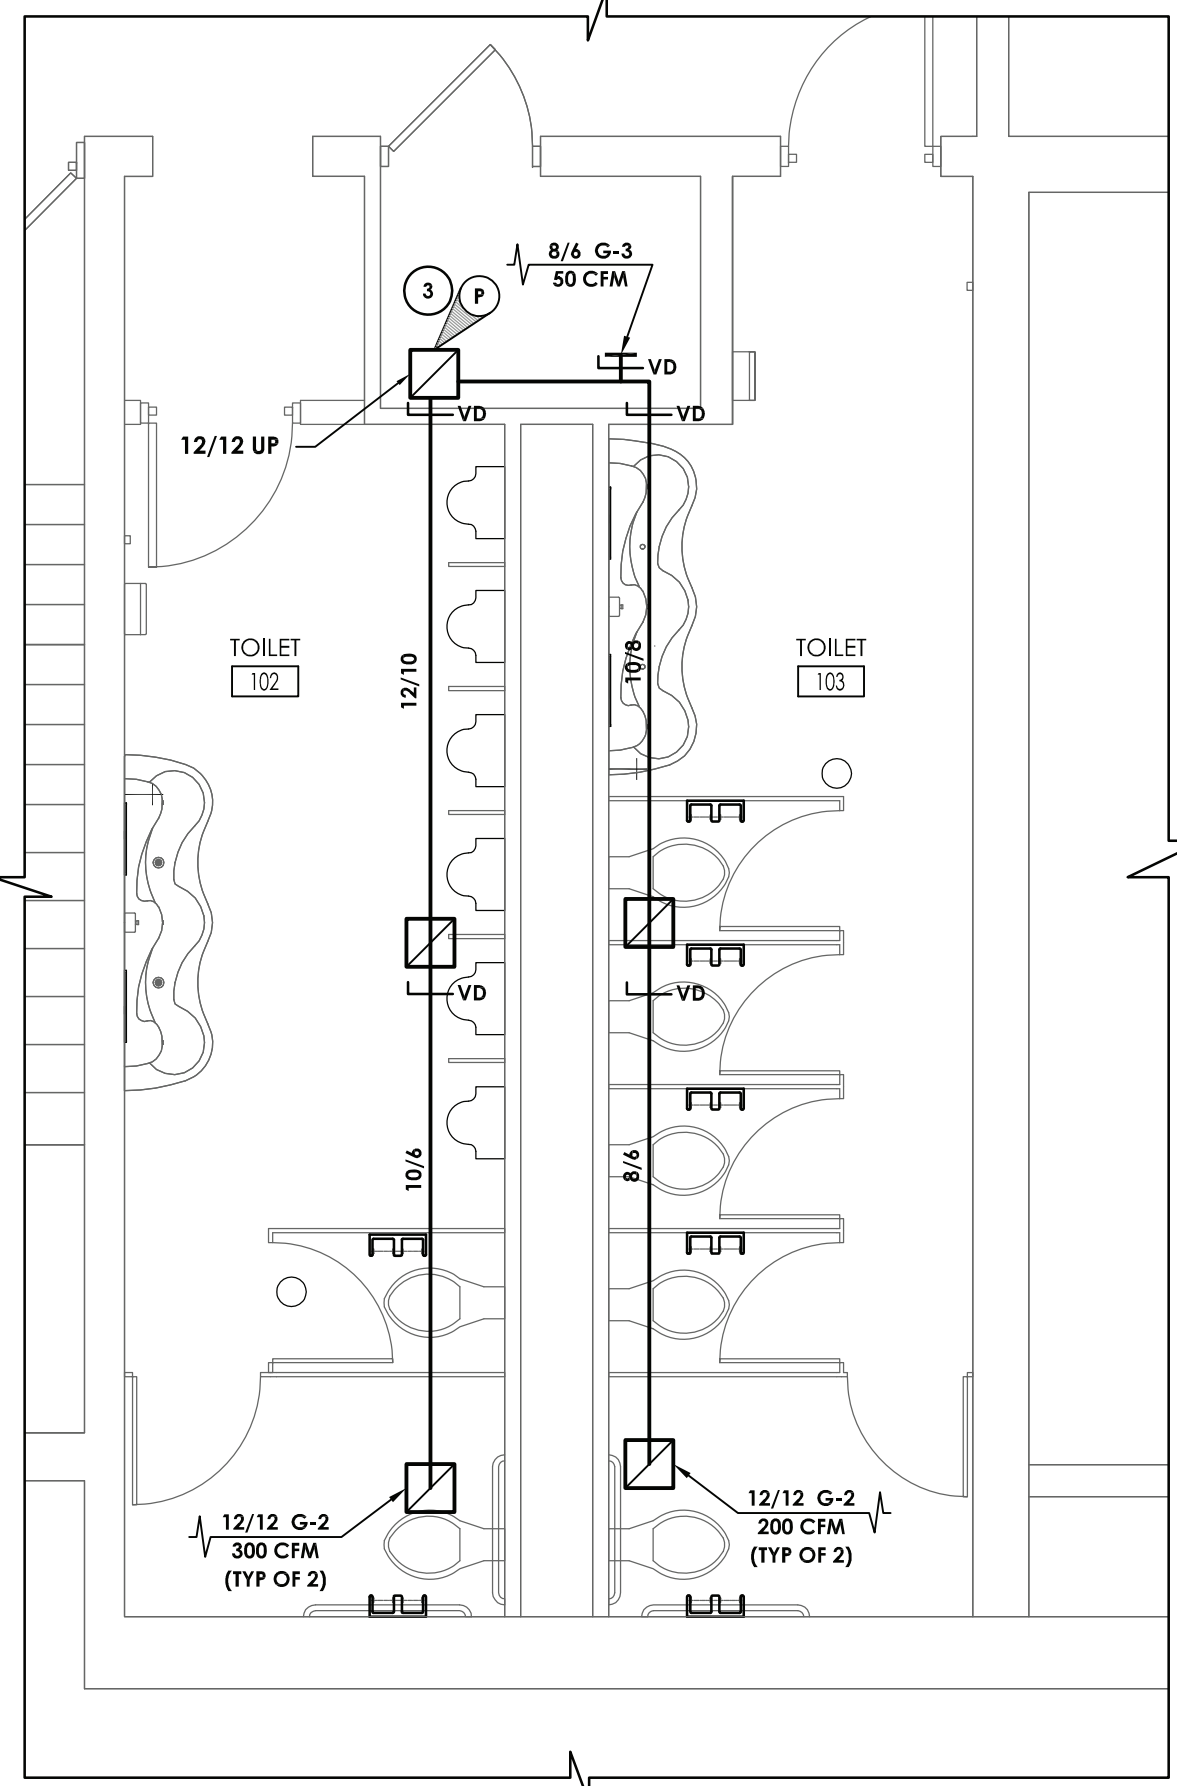


2 TOILET ROOMS #102 & #103 NEW WORK PLAN
H201 SCALE: 1/4" = 1'-0"

REGISTERS, GRILLES, AND DIFFUSERS


MARK	APPLICATION	MATERIAL	TYPE	FINISH	DESIGN EQUIP.	REMARKS
G-2	RETURN/EA	STEEL	SURFACE MOUNT	WHITE	PRICE \$30	-
G-3	RETURN/EA	STEEL	DUCT GRILLE	WHITE	PRICE \$30	-

FAN SCHEDULE

MARK	LOCATION	SERVICE	TYPE	ROOF OPENING (IN.)	CFM	SP IN W.G.	RPM	ELECTRICAL DATA			TYPICAL UNIT MFG & MODEL NO.	REMARKS:
								BHP / HP	VOLTS	PHASE		
EF-GF-18	ROOF	TOILETS	DOWN BLAST	20.5x20.5	3,000	0.7	833	0.48 / 0.75	208	3	GREENHECK GB-200	1,2,3
REMARKS: 1. PROVIDE DISCONNECT. 2. ALUMINUM BIRD SCREEN. 3. HINGED BASE.												

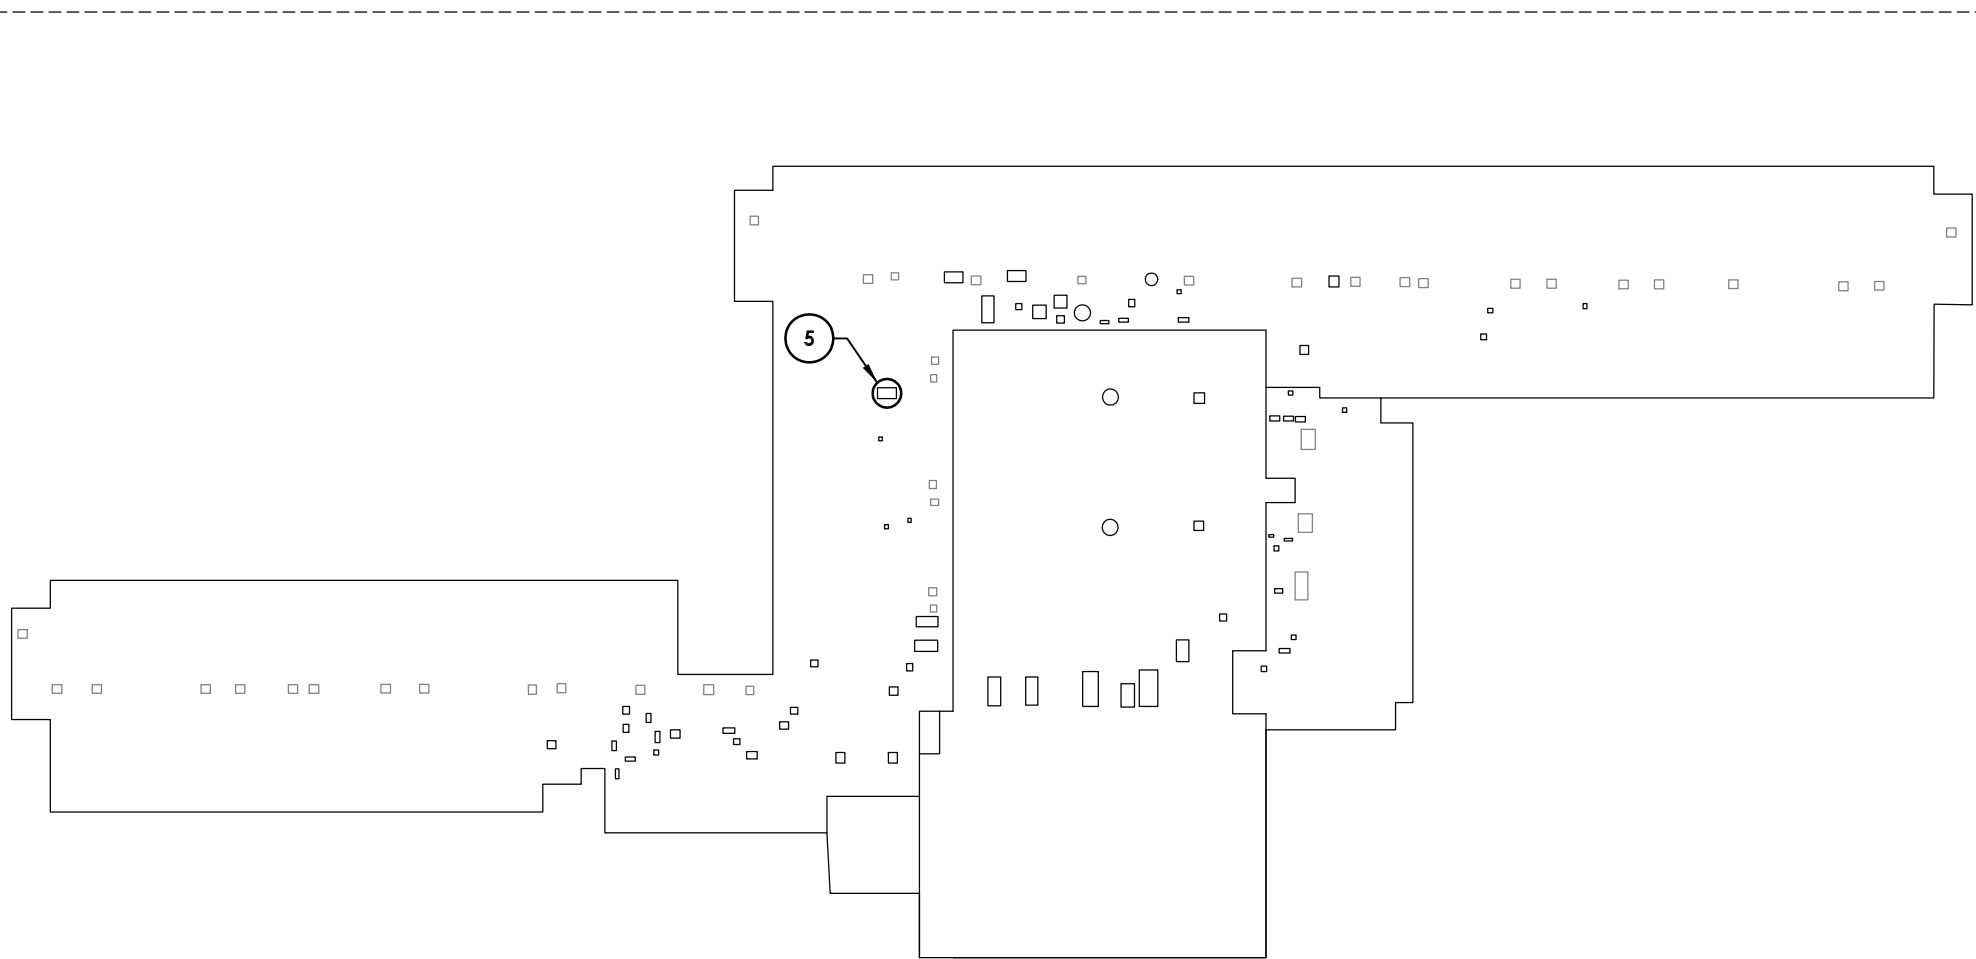

5 ROOF PLAN
H201 SCALE: 1/64" = 1'-0"

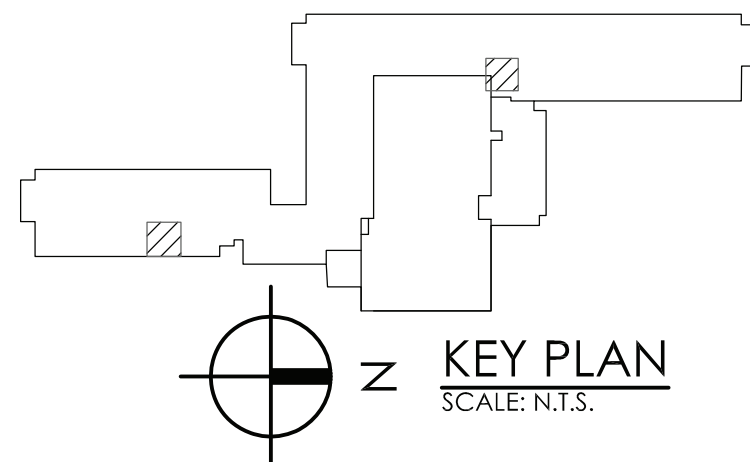

KEY PLAN
SCALE: N.T.S.

KEY NOTES:

- 1 REMOVE DUCTWORK TO EXHAUST RISER. PREPARE DUCTWORK FOR NEW CONSTRUCTION.
- 2 REMOVE EXISTING RETURN GRILLES.
- 3 CONNECT NEW DUCTWORK TO EXISTING RISER. FIELD VERIFY RISER SIZE.
- 4 EXISTING EXHAUST GRILLE TO REMAIN.
- 5 REMOVE AND REPLACE EF-GF-18. MAINTAIN EXISTING CONTROLS. MODIFY EXISTING CURB FOR NEW FAN.

REVISIONS	NO.	DATE	BY	CHKD	DESCRIPTION
	1	11/30/2020	LU	CG	3RD DORE CONSTRUCTION DOCUMENTS SUBMISSION
	2	01/07/2021	-	-	ADDENDUM #1
	3	03/27/2021	JG	JP	ISSUED FOR BID

ENVIRONMENTAL CONSULTANT

ADELAIDE ENVIRONMENTAL
HEALTH ASSOCIATES INC.
1511 ROUTE 22, SUITE C24
BREWSTER, NY 10509
TEL 845.278.7710
FAX 845.278.7750

CARMEL CENTRAL SCHOOL DISTRICT

81 SOUTH STREET, P.O. BOX 296, PATTERSON, NEW YORK 12563

CARMEL HIGH SCHOOL SED#: 48.01.02.06.0.003.022

GEORGE FISCHER MIDDLE SCHOOL SED#: 48.01.02.06.0.008.018

MATTHEW PATTERSON SCHOOL SED#: 48.01.02.06.0.010.013

KENT ELEMENTARY SCHOOL SED#: 48.01.02.06.0.001.017

KENT PRIMARY SCHOOL SED#: 48.01.02.06.0.004.016

DATE	DRAWN	CHECKED
11/30/2020	ZBH	JJM
SCALE	AS NOTED	
SHEET TITLE		
HVAC DEMOLITION, NEW WORK, DETAILS, AND SCHEDULES PLAN		

PROJECT NUMBER
70019.00

GF
H201

DRAWING NUMBER