
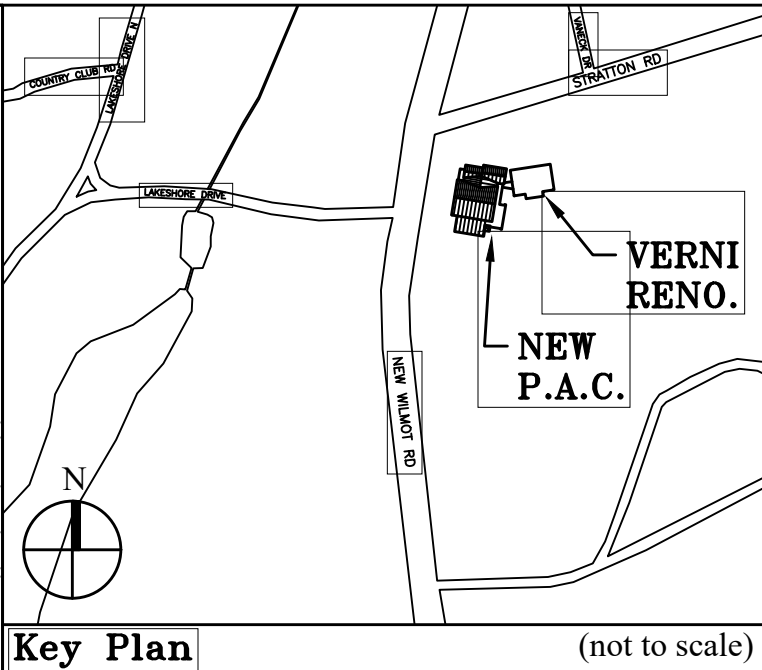


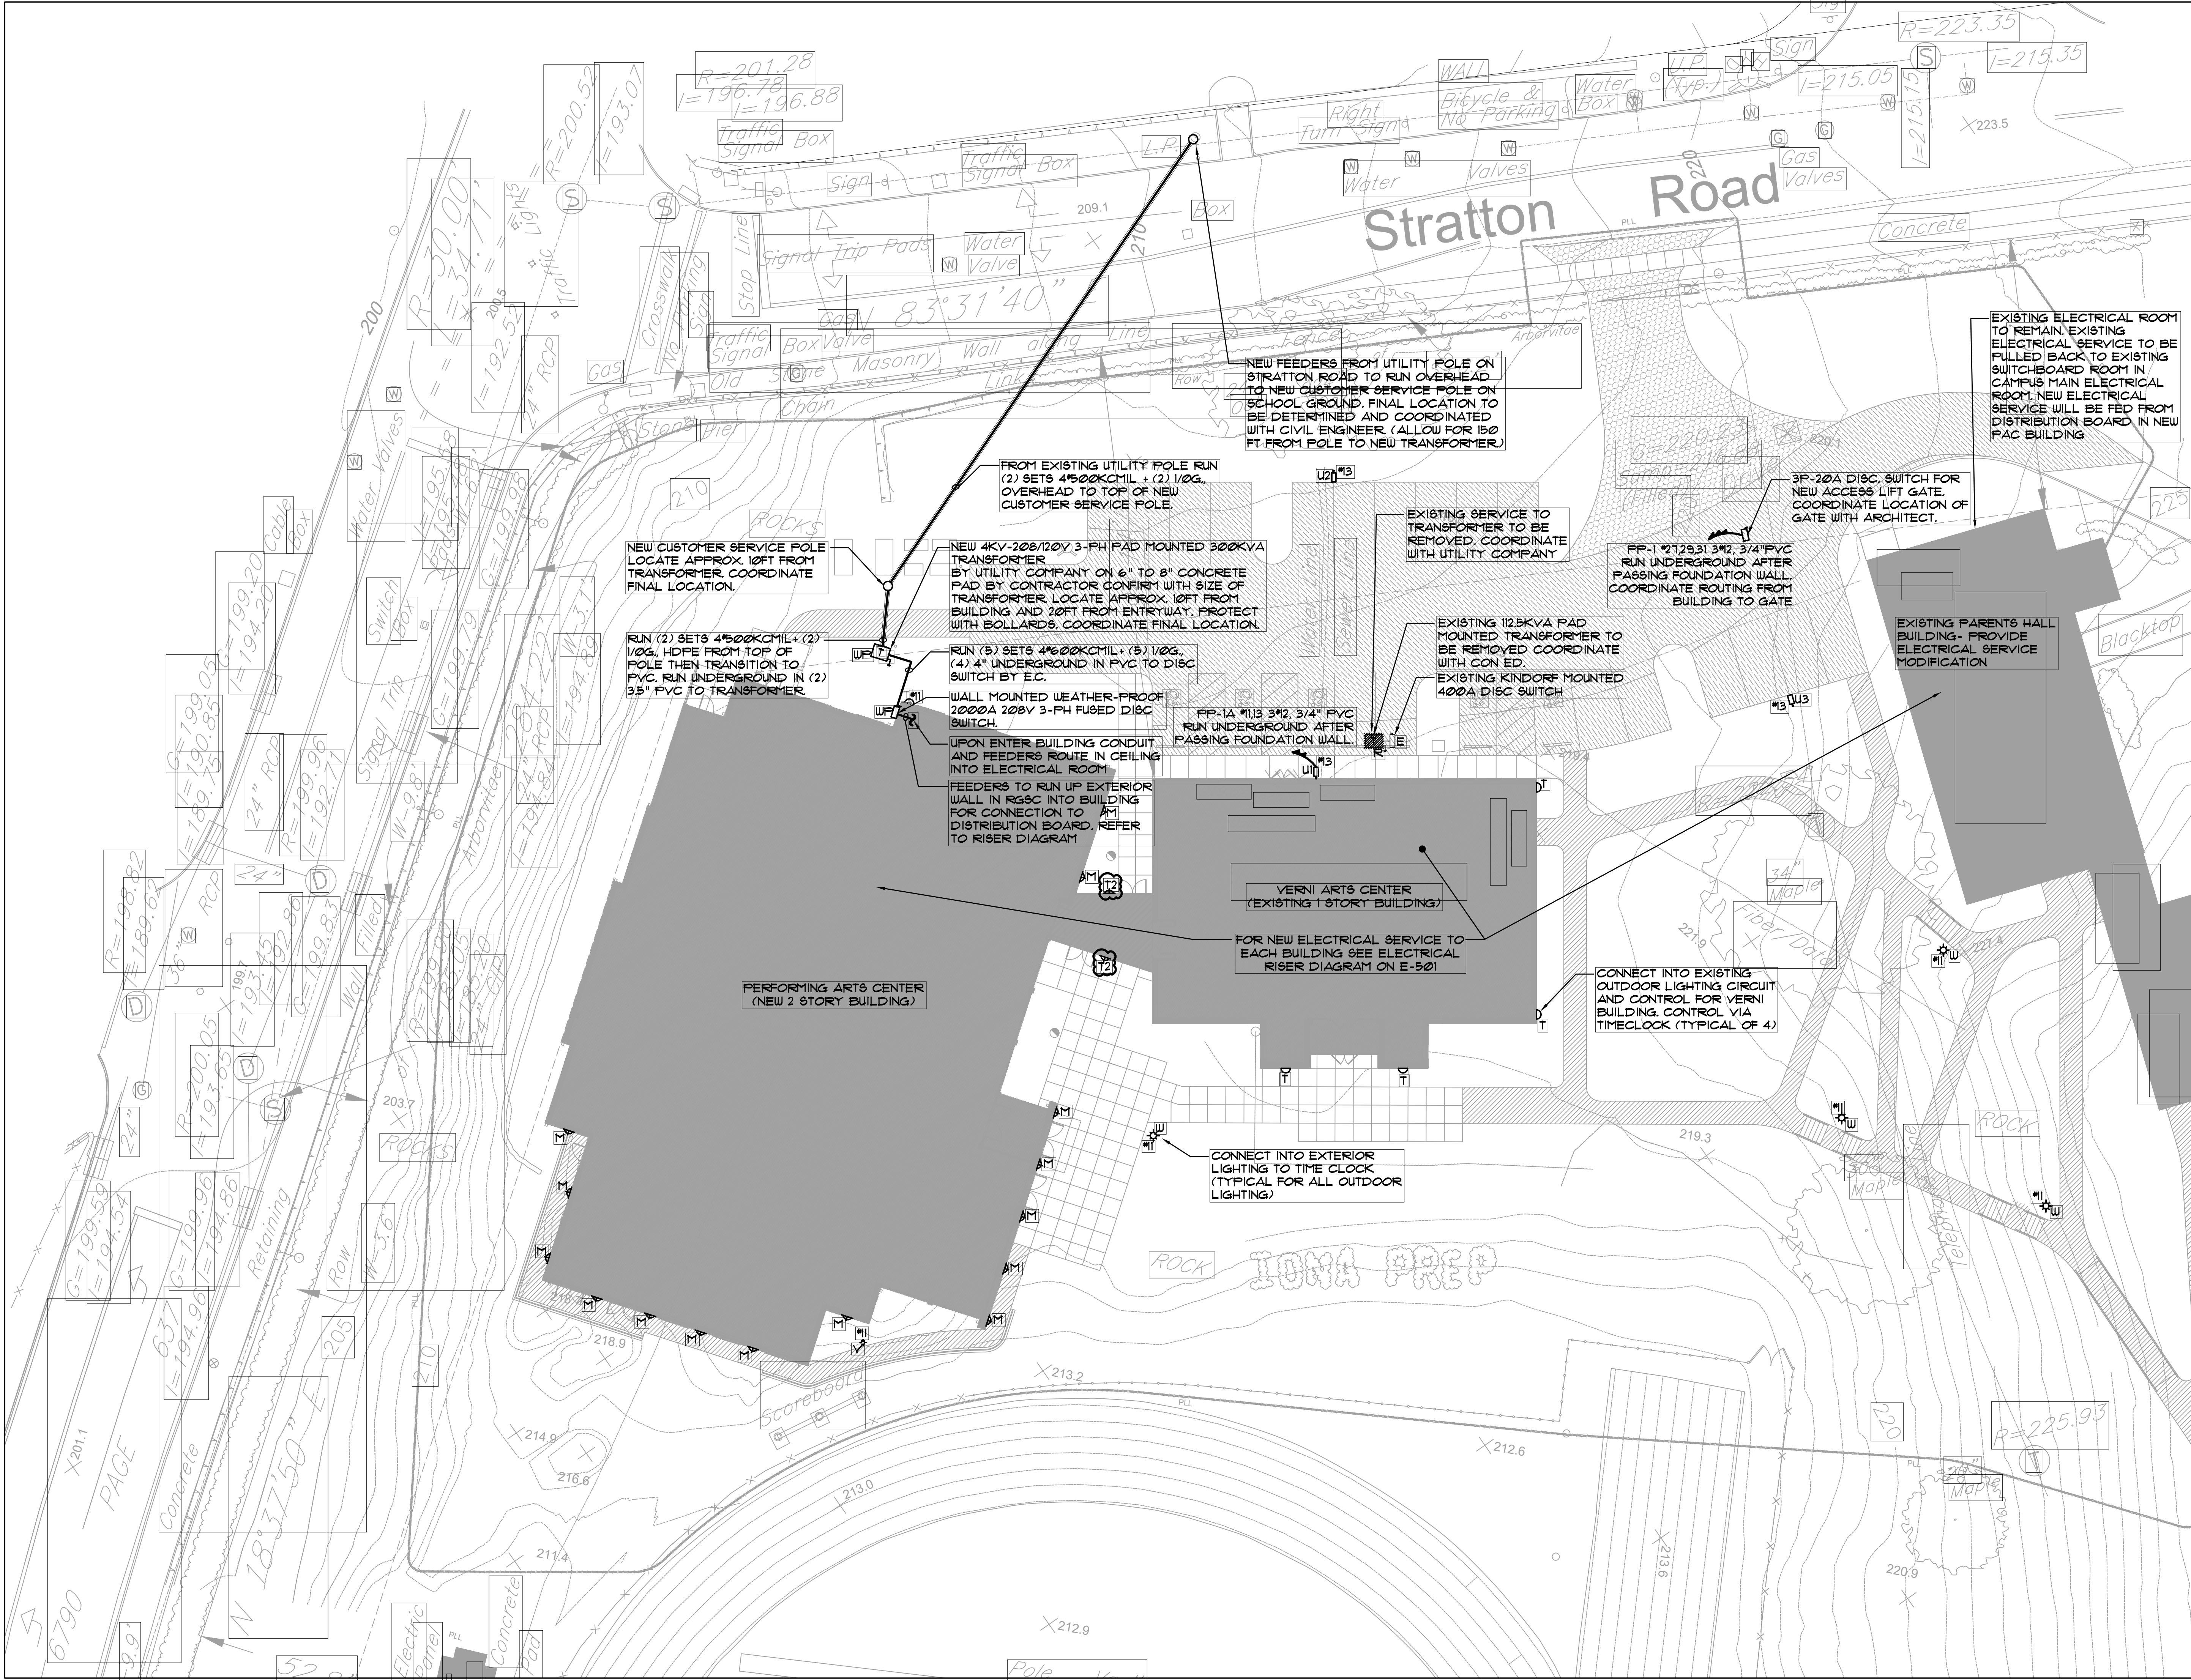

9. 6/09/2021 RE-ISSUED FOR BUILDING PERMIT REVIEW		
8. 6/09/2021 BID ADDENDUM 1		
7. 6/01/2021 ISSUED FOR BID		
6. 5/07/2021 RE-ISSUED FOR BUILDING PERMIT REVIEW		
5. 2/01/2021 ISSUED FOR BUILDING PERMIT REVIEW		
4. 10/14/2020 ISSUED FOR PLANNING BOARD REVIEW		
3. 9/23/2020 RESUBMITTED FOR ZONING REVIEW		
2. 8/28/2020 ISSUED FOR PRELIMINARY DOB REVIEW		
1. 1/10/2020 ISSUED FOR DD ESTIMATE		
No.	Date	Revision/Submission
STRUCTURAL & SITE CIVIL ENGINEER		
DOMINICK R PILLA ASSOCIATES, P.C. 143 MAIN STREET NYACK, NY 10960 845-727-7793		
MEP ENGINEER		
JMV CONSULTING ENGINEERING, P.C. 37 W. 38 STREET, STE 703 NEW YORK, NY 10018 212-852-9855		
ROOFING CONSULTANT		
WATSKY ASSOCIATES 20 MADISON AVENUE VALHALLA, NY 10595 914-948-3450		
Stamp		
Project Title		
IONA PREPARATORY SCHOOL ADDITION AND ALTERATION TO THE PAUL VERNI FINE ARTS CENTER		
Project Address		
IONA PREPARATORY SCHOOL 255 Wilmot Road New Rochelle, NY 10804		
Drawing Title		
ELECTRICAL SITE PLAN		
Scale	Job No.	Date
1/16"=1'-0"	1618	04/03/2019
Drawn	E-105	
Peter Gisolfi Associates Architects Landscape Architects, LLP 566 Warburton Avenue Hastings on Hudson, NY 10706 914 478 3677		
PETER GISOLFI ASSOCIATES		