

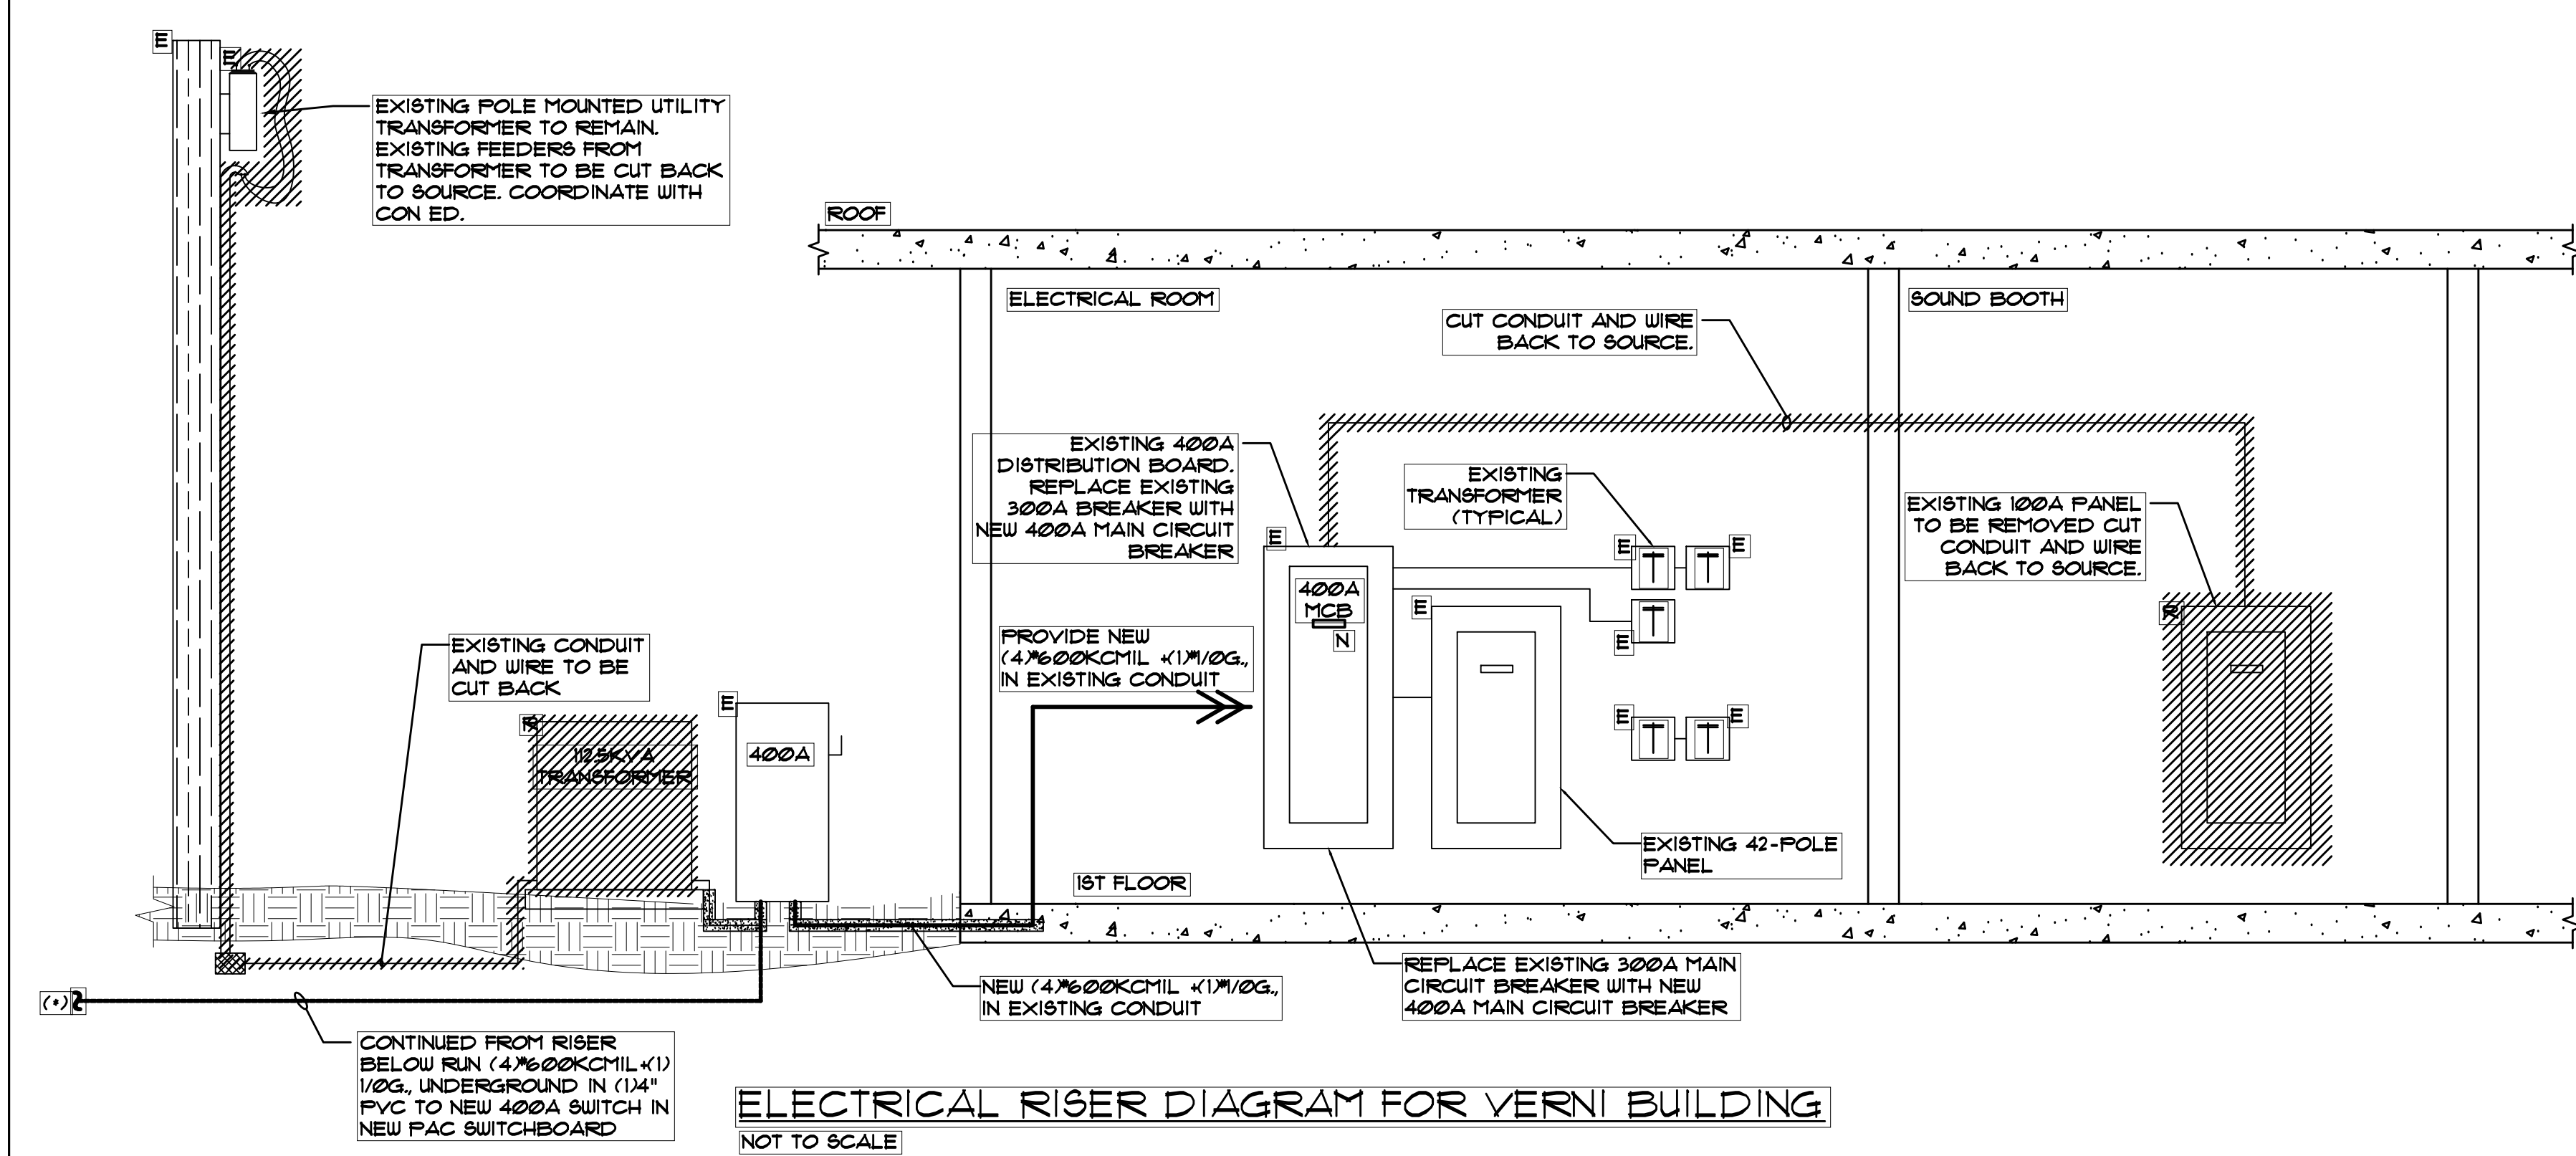


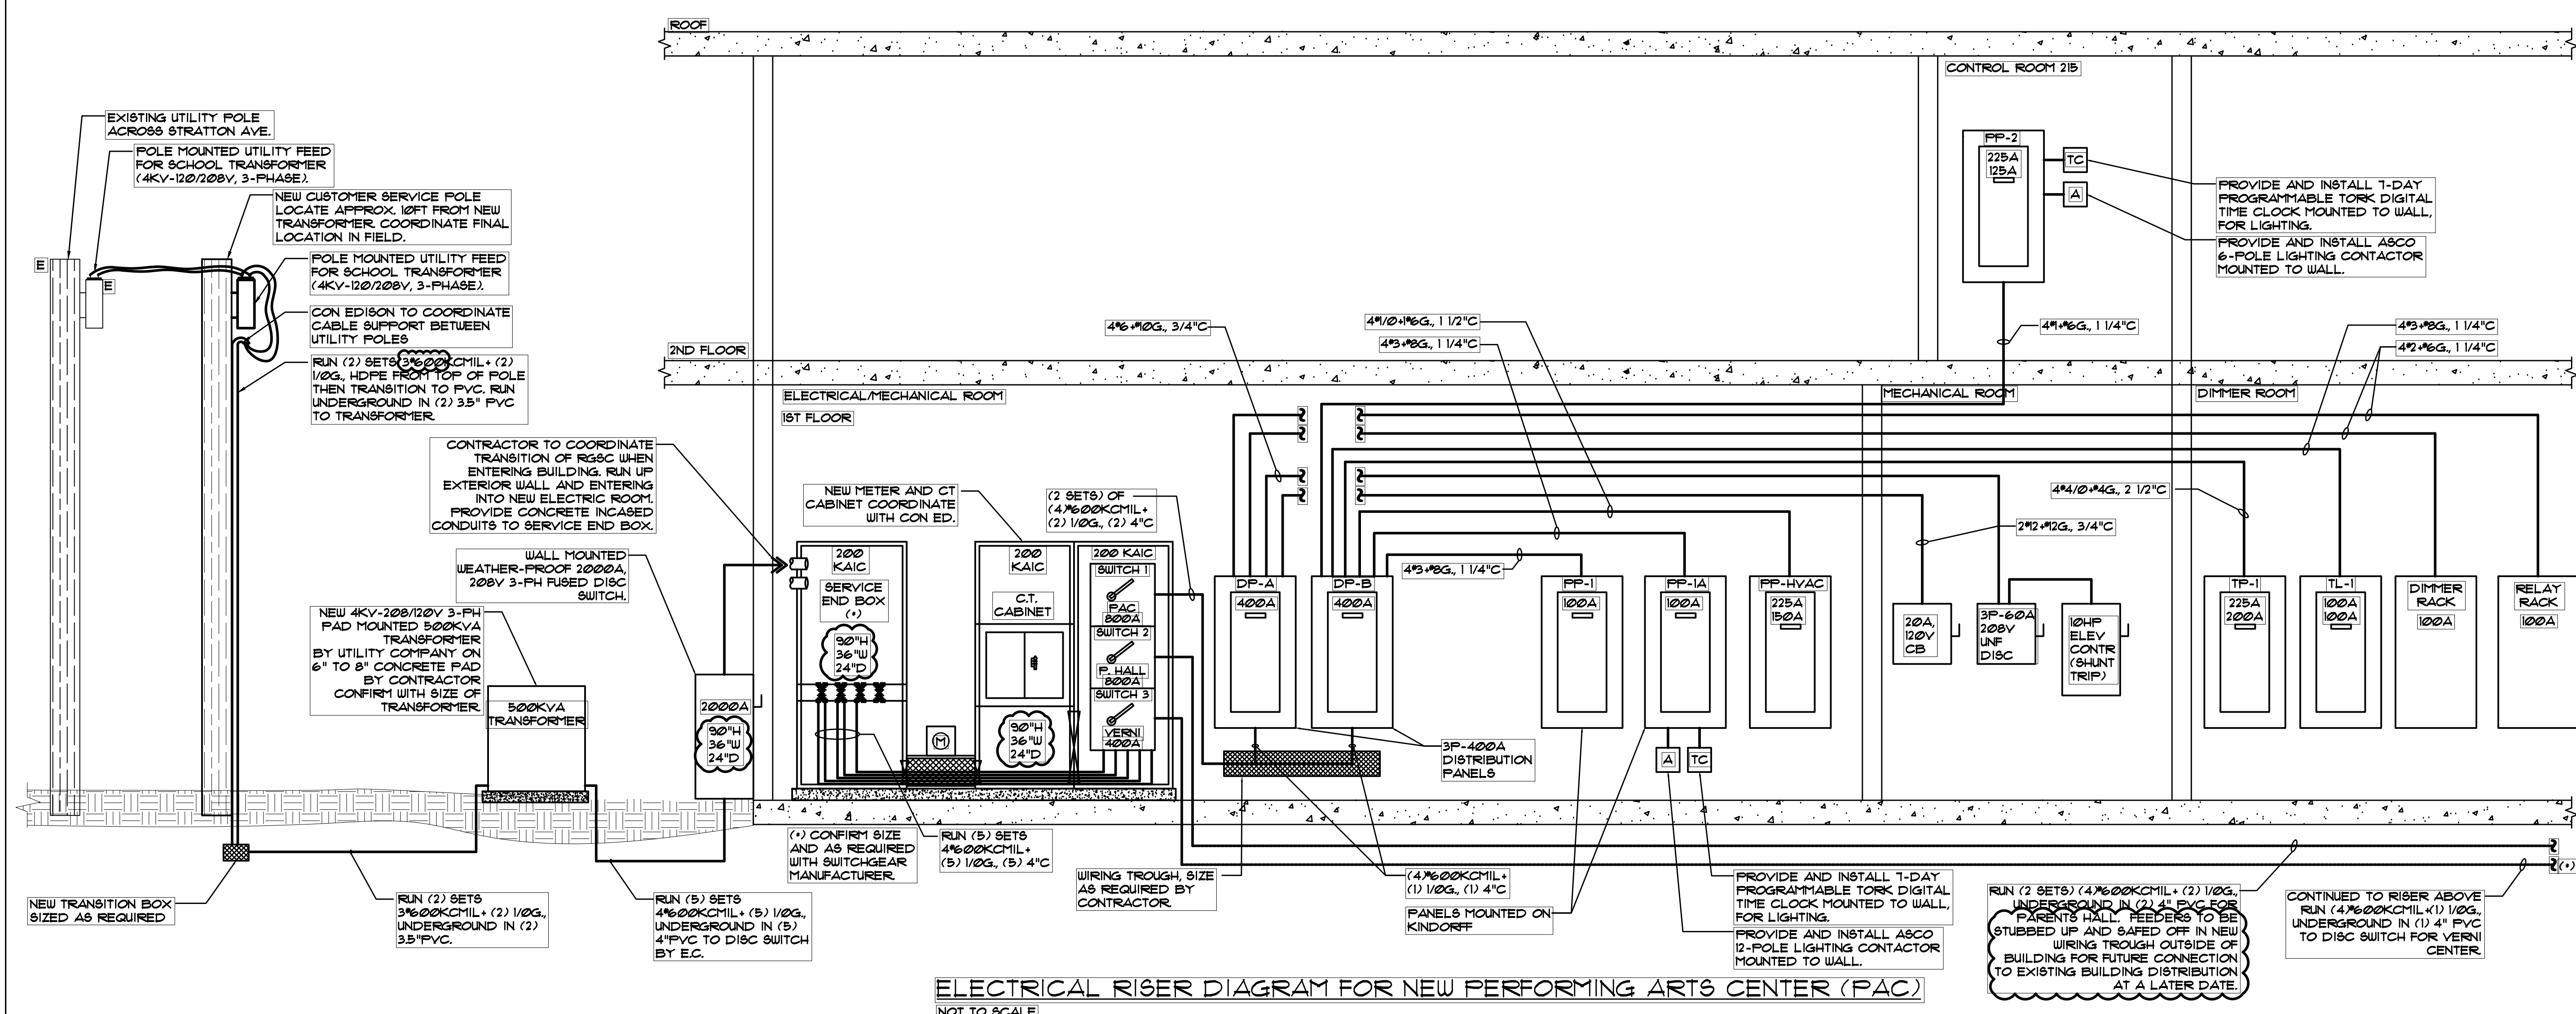

- ELECTRICAL RISER DIAGRAM NOTES:**
1. RISER DIAGRAM IS DIAGRAMMATIC. CONTRACTOR SHALL PERFORM A PRE-DEMOLITION OR CONSTRUCTION SURVEY OF THE EXISTING CIRCUITING AND PANELBOARDS SERVING THE EXISTING SPACE.
 2. CIRCUITING AND CIRCUIT BREAKERS IN EXISTING PANELBOARDS, NOT EFFECTED BY DEMOLITION SHALL REMAIN UNLESS NOTED. CONTRACTOR TO TRACE AND FIELD VERIFY EXISTING CIRCUITS THAT ARE TO REMAIN OR BE RELOCATED WITH PANEL. EXTEND/TRANSFER CIRCUITS BEING RELOCATED WITH EXISTING PANEL TO NEW LOCATIONS AS REQUIRED.
 3. EXISTING PANELBOARDS, CIRCUITRY, CIRCUIT BREAKERS, MISC. EQUIPMENT, ETC. NOT AFFECTED BY DEMOLITION SHALL REMAIN UNLESS NOTED. CONTRACTOR TO TRACE AND FIELD VERIFY EXISTING CIRCUITS THAT ARE TO REMAIN OR RELOCATED WITH PANELS.
 4. CONTRACTOR SHALL PROVIDE AND INSTALL FULL BOXES AND EXTEND EXISTING WIRING/CONDUIT AS REQUIRED FOR CONNECTION OF NEW/EXISTING CIRCUITS TO PANELS.
 5. REFER TO NEW/EXISTING PANEL SCHEDULES ON DRAWING E-601 FOR BRANCH CIRCUIT WIRING.
 6. CONTRACTOR SHALL REVIEW EXISTING ELECTRIC CLOSET CONDITIONS AND ADVISE ENGINEER OF ANY CONFLICTS OMISSIONS OR ADDITIONAL REQUIREMENTS THAT MAY BE REQUIRED.
 7. CONTRACTOR TO PROVIDE SHOP DRAWINGS OF COORDINATED ELECTRICAL ROOM LAYOUTS INCLUDING EQUIPMENT SIZES, ELEVATIONS AND MOUNTING DETAILS OF PANELBOARDS, RELAY PANELS, DISCONNECT SWITCHES, ETC.
 8. CONTRACTOR SHALL COORDINATE NEW CONDUIT ROUTINGS WITH ARCHITECT SERVING NEW AND EXISTING EQUIPMENT SCHEDULED TO REMAIN.

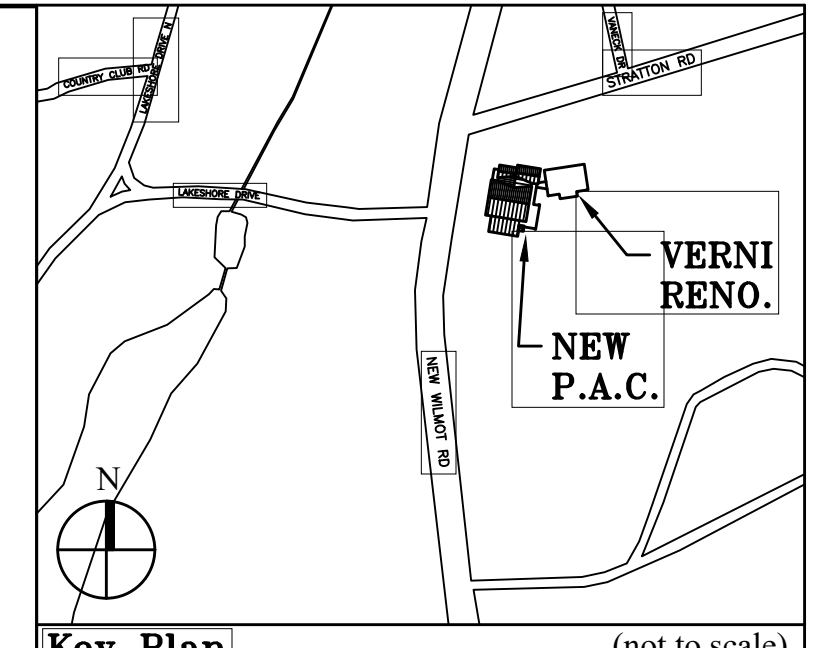

9.	6/09/2021	RE-ISSUED FOR BUILDING PERMIT REVIEW
8.	6/09/2021	BID ADDENDUM 1
7.	6/01/2021	ISSUED FOR BID
6.	5/07/2021	RE-ISSUED FOR BUILDING PERMIT REVIEW
5.	2/01/2021	ISSUED FOR BUILDING PERMIT REVIEW
4.	10/14/2020	ISSUED FOR PLANNING BOARD REVIEW
3.	9/23/2020	RESUBMITTED FOR ZONING REVIEW
2.	8/28/2020	ISSUED FOR PRELIMINARY DOB REVIEW
1.	1/10/2020	ISSUED FOR DD ESTIMATE
No.	Date	Revision/Submission
STRUCTURAL & SITE CIVIL ENGINEER		
DOMINICK R PILLIA		
ASSOCIATES, P.C.		
143 MAIN STREET		
NYACK, NY 10960		
845-727-7793		
MEP ENGINEER		
JMV CONSULTING		
ENGINEERING, P.C.		
37 W. 38 STREET, STE 703		
NEW YORK, NY 10018		
212-852-9855		
ROOFING CONSULTANT		
WATSKY ASSOCIATES		
20 MADISON AVENUE		
VALHALLA, NY 10595		
914-948-3450		
Stamp		
Project Title		
IONA PREPARATORY SCHOOL		
ADDITION AND ALTERATION TO THE		
PAUL VERNI FINE ARTS CENTER		
Project Address		
IONA PREPARATORY SCHOOL		
255 Wilmot Road		
New Rochelle, NY 10804		
Drawing Title		
ELECTRICAL RISER		
DIAGRAM		
Scale	Job No.	Date
NTS	1818	04/03/2019
Drawn	E-501	
Peter Gisolfi Associates		
Architects Landscape Architects, LLP		
566 Warburton Avenue		
Hastings on Hudson, NY 10706		
914 478 3677		
PETER GISOLFI ASSOCIATES		