


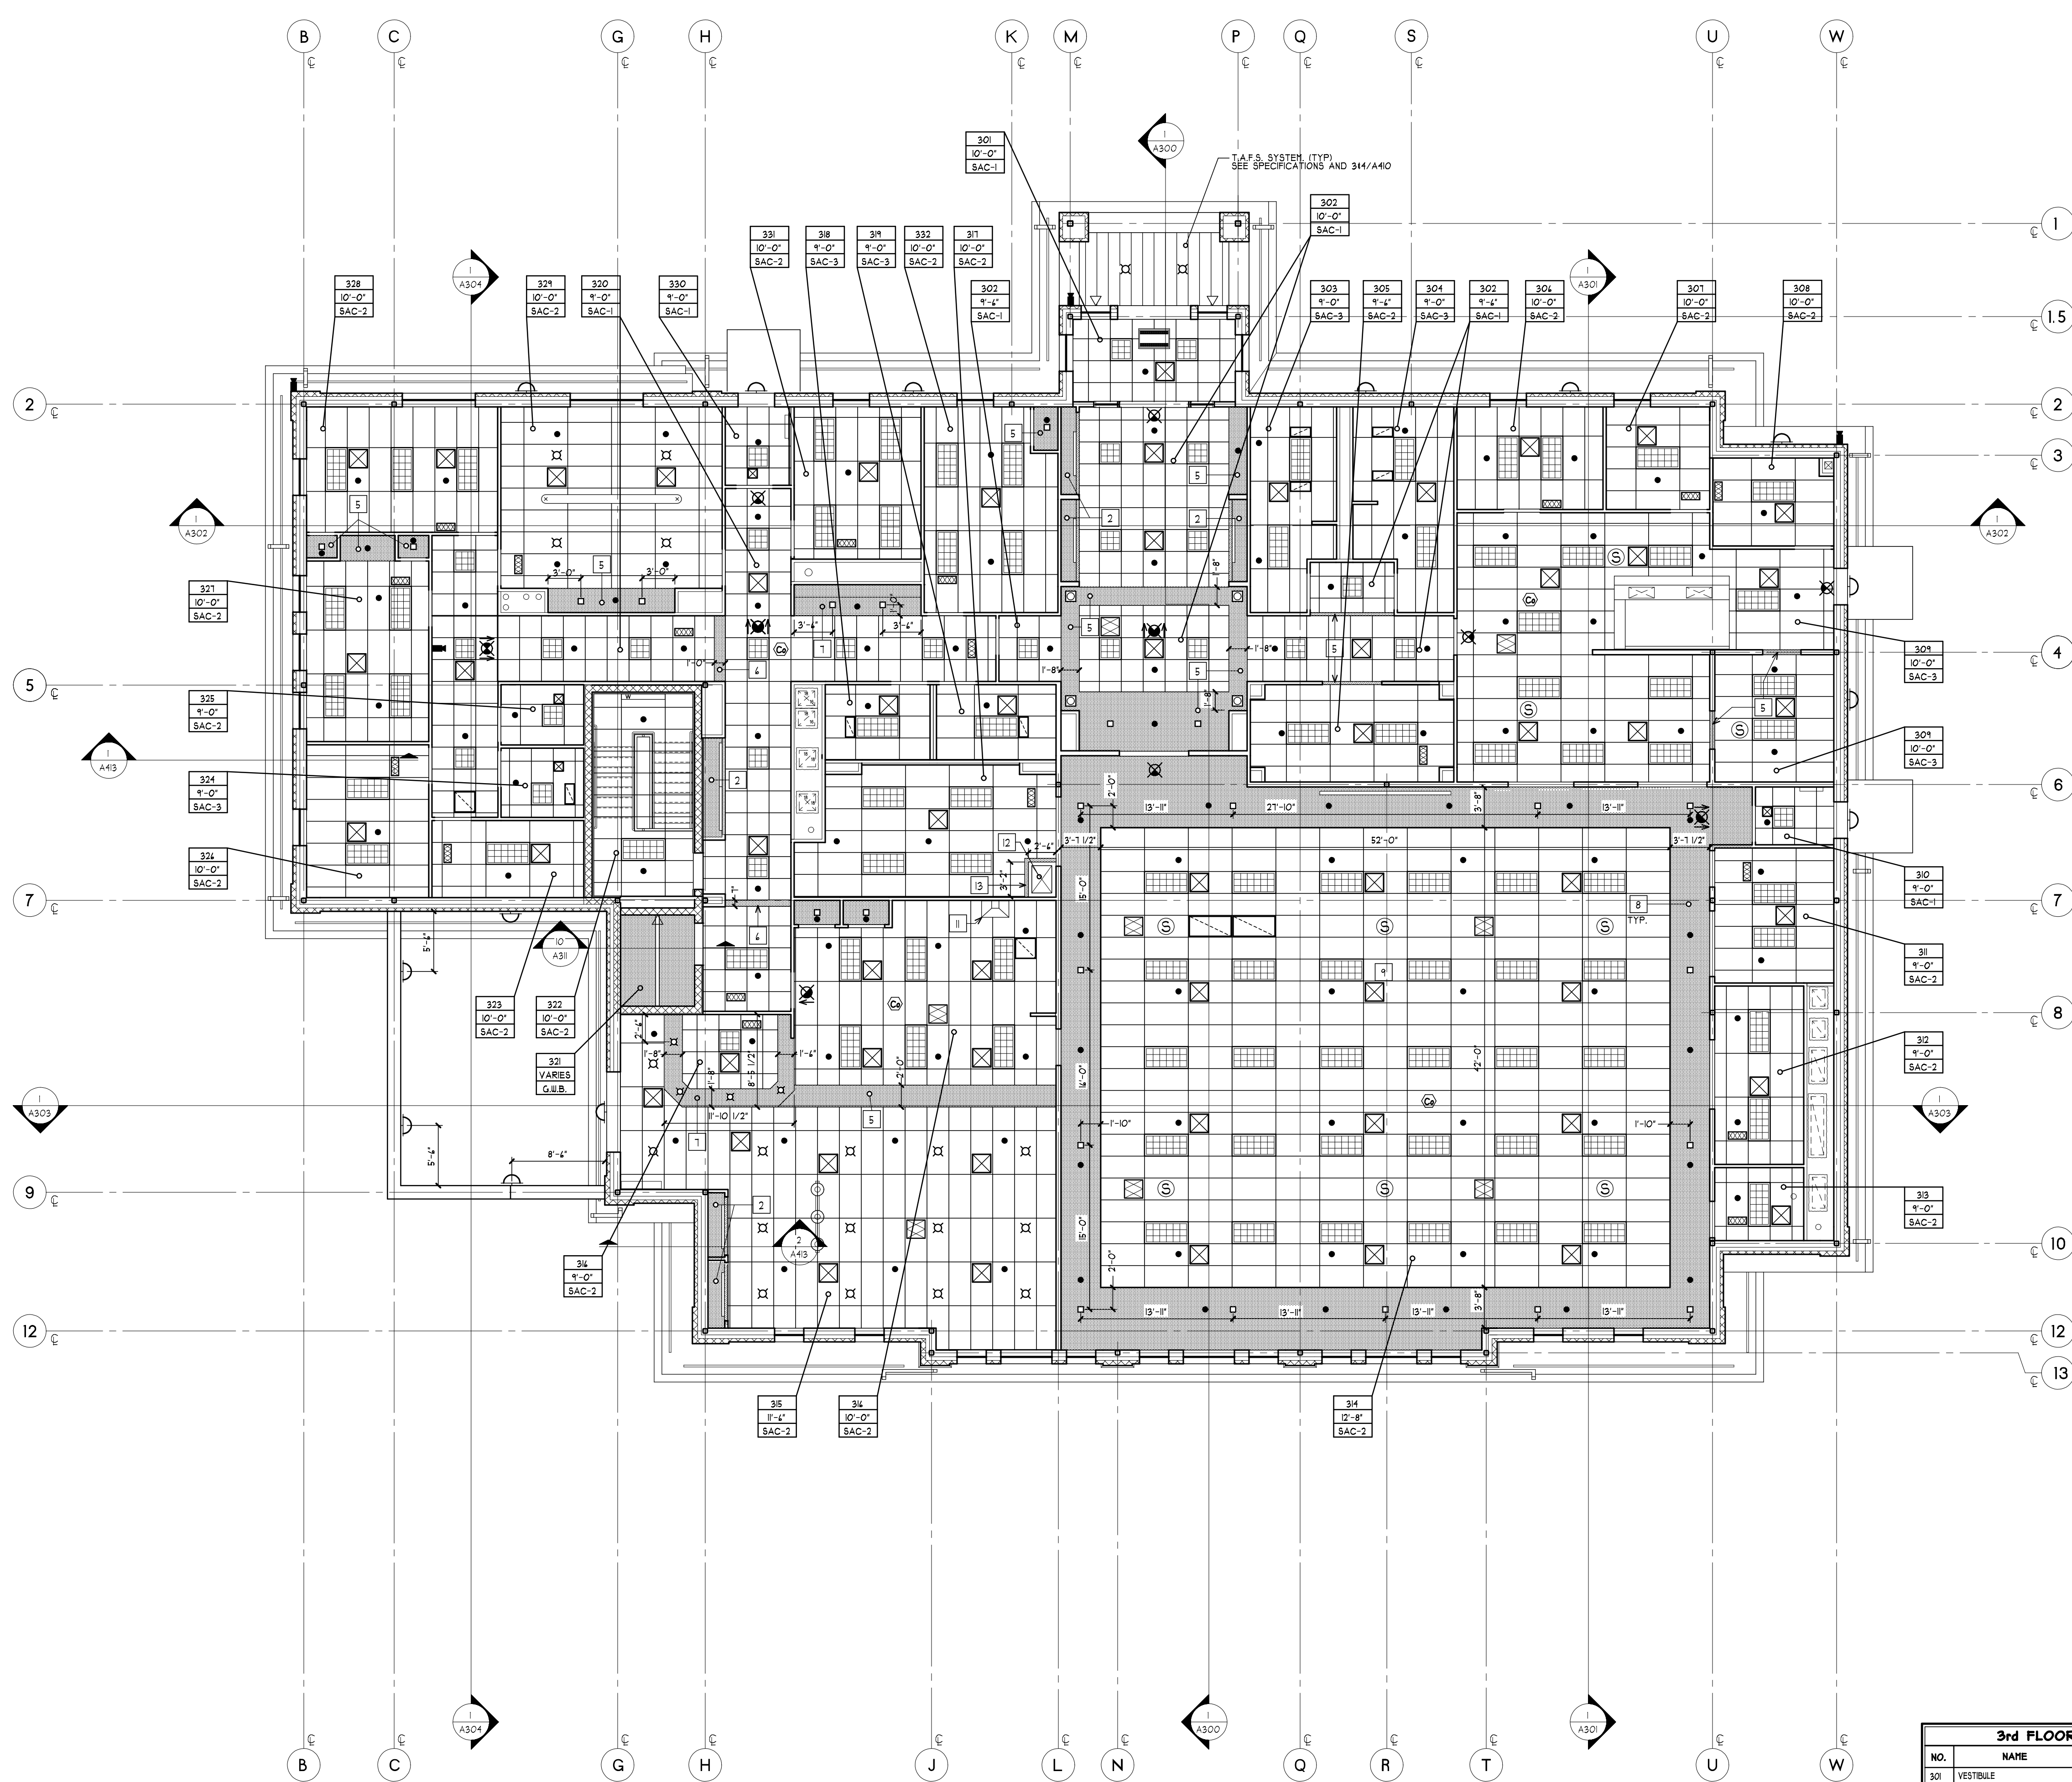

3rd FLOOR
REFLECTED CEILING PLAN
SCALE: 1/8" = 1'-0"



3rd FLOOR ROOM LEGEND			
NO.	NAME	NO.	NAME
301	VESTIBULE	348	CLOSET
302	LOBBY	311	TABLE/CHAIR STORAGE
303	PUBLIC MEN'S LAVATORY	318	WOMEN'S LAVATORY
304	PUBLIC WOMEN'S LAVATORY	319	MEN'S LAVATORY
305	COAT ROOM	320	CORRIDOR
306	PANTRY	321	ELEVATOR
307	REFRIGERATED STORAGE	322	STAIR
308	DISH STORAGE	323	FIRE PREVENTION STORAGE
309	KITCHEN	324	JANITOR
310	VESTIBULE	325	HOUSEKEEPING
311	SERVICE CENTER	326	ASSISTANT CHIEF'S
312	STORAGE	327	JUNIOR OFFICERS
313	AV	328	CHIEF'S OFFICE
314	MEETING/TRAINING	329	CONFERENCE ROOM
315	MEMBERS ROOM	330	VESTIBULE
316	KITCHENETTE	331	PRESIDENT/VP OFFICE
317	CLOSET	332	BUSINESS OFFICE
318	CLOSET	333	WORK AREA

REFLECTED CEILING LEGEND

GENERAL:

- ROOM NUMBER
- CEILING HEIGHT
- CEILING MATERIAL
- G.W.B. CEILING
- S.A.C.-1
ACT CEILING 2X2
CENTER IN ROOM (TYP)
- S.A.C.-2
ACT CEILING 2X4
CENTER IN ROOM (TYP)
- S.A.C.-3
ACT CEILING 2X4
CENTER IN ROOM (TYP)

LIGHTING:

- 2'x4' LAY-IN
- 2'x2' LAY-IN
- SURFACE MOUNT OR PENDANT MOUNT
LIGHT FIXTURE
(SEE ELECTRICAL DRAWINGS)
- LIGHT FIXTURE. SEE ELECTRICAL DRAWINGS
- UNDER COUNTER LIGHT FIXTURE
- WALL MOUNTED FIXTURE
- RECESSED DOWN LIGHT
- EXIT LIGHT
(FILL INDICATES LETTERED SIDE)
(ARROW INDICATES DIRECTION)

ME&P:

- CLG. DIFFUSER GRILLE
2'x2'
- EXHAUST GRILLE
SEE MECHANICAL DWGS FOR SIZES
- PLENUM RETURN AIR GRILLE
SEE MECHANICAL DWGS FOR SIZES
- SEE 'M' DRAWINGS
- DUCTLESS SPLIT HEAT PUMP
SEE MECHANICAL DRAWINGS
- UNIT HEATER
SEE MECHANICAL DRAWINGS
- EXPOSED SPRINKLER
HEAD
- RECESSED SPRINKLER HEAD
- SIDE WALL SPRINKLER HEAD
SEE SPRINKLER DRAWINGS
- DROP SPRINKLER HEAD
SEE SPRINKLER DRAWINGS
- COMBINATION COMPRESSED AIR
DROP AND ELECTRIC POWER
DROP. SEE PLUMBING AND
ELECTRICAL DRAWINGS. FIELD
VERIFY LOCATION WITH OWNER
(TYP)
- ELECTRIC POWER DROP
SEE ELECTRICAL DRAWINGS
(FIELD VERIFY LOCATION W/
OWNER (TYP))
- COMPRESSED AIR
WALL MOUNTED TAP (SEE
PLUMBING DRAWINGS)
(FIELD VERIFY LOCATION W/
OWNER (TYP))
- SMOKE DETECTOR
(SEE ELECTRICAL DRAWINGS)
- HEAT DETECTOR
(SEE ELECTRICAL DRAWINGS)
- CEILING FAN
- CARBON MONOXIDE DETECTOR
(SEE ELECTRICAL DRAWINGS)
- SPEAKER
SEE ELECTRICAL DRAWINGS FOR
EXTENT OF INSTALLATION
- FUTURE SECURITY CAMERA
SEE ELECTRICAL DRAWINGS FOR
EXTENT OF INSTALLATION

GENERAL NOTES

- SEE BUILDING SECTIONS AND ELEVATIONS FOR LIGHT
FIXTURE HEIGHTS. U.O.N.
- REFER TO ME&P AND FIRE PROTECTION DRAWINGS
FOR ADDITIONAL INFORMATION.

RCP KEY NOTES

- SEE 1/A120 FOR SHOWER SOFFIT NOTES
- DISPLAY CASE. SEE DETAIL 1/A130
- G.W.B. SOFFIT # 8'-4"
- G.W.B. SOFFIT # 1'-4"
- G.W.B. SOFFIT # 9'-0"
- G.W.B. SOFFIT # 8'-8"
- G.W.B. SOFFIT # 8'-0"
- G.W.B. SOFFIT # 11'-4"
- PROJECTOR MOUNT SEE A100'S AND EQUIPMENT
SCHEDULE.
- G.W.B. SOFFIT # 1'-4"
- PROVIDE A S.S. DUCTWORK EXTENSION TO ABOVE THE S.A.C.
OF THE SAME MATERIAL AS THE RANGE HOOD DUCT.
- 22X30 INSULATED ACCESS HATCH. COORDINATE WITH TRUSS
LOCATION. SEE SPECIFICATIONS
- G.W.B. SOFFIT # 4" BELOW S.A.C. HEIGHT. 3 1/2" METAL
STUDS WITH 5/8" SHEETROCK (TYP) OPENING TO BE
SHEETROCK UP TO UNDERSIDE OF TRUSS SHEATHING AT
ACCESS HATCH. COORDINATE ALL DIMENSIONS WITH ACCESS
HATCH PLACEMENT AND TRUSS LOCATION.

MA

MITCHELL
ASSOCIATES
ARCHITECTS
PLLC

24 THACHER PARK ROAD
VOORHEESVILLE, NY 12186
(518) 745-4571 FAX (518) 745-2950
WWW.MITCHELL-ARCHITECTS.COM

EMERGENCY
SERVICE

FACILITIES

CONSULTANTS:

INSITE ENGINEERING SURVEYING
& LANDSCAPE ARCHITECTURE, P.C.
3 GARRETT PLACE
CARMEL, NY 10512
(845) 225-4100 FAX: (845) 225-9171

CRAIG A. MALONEY, P.E.
STRUCTURAL ENGINEERING CONSULTANT
3 BENEDICT COURT
BALLSTON SPA, NY 12020
(518) 584-4444 FAX: (518) 584-9955

GERARD ASSOCIATES
CONSULTING ENGINEERS, P.C.
MECHANICAL, PLUMBING,
AND ELECTRICAL
223 MAIN STREET
GOSHEN, NY 10924
(845) 291-2112 FAX: (845) 291-1939

COPYRIGHT 2002
MITCHELL ASSOCIATES ARCHITECTS
UNAUTHORIZED ALTERATION OR ADDITION
TO THIS DOCUMENT IS A VIOLATION OF LAW

NEW STATION
FOR
PUTNAM VALLEY
FIRE STATION #1

OSCAWANA LAKE ROAD
PUTNAM VALLEY, NEW YORK

REVISION HISTORY

DATE	DESCRIPTION

3rd FLOOR
REFLECTED CEILING PLAN

SCALE: 1/8" = 1'-0"
DWG. BY: JDA
DWG. DATE: 8/14/2020
STATUS: BID DRAWINGS

A602