



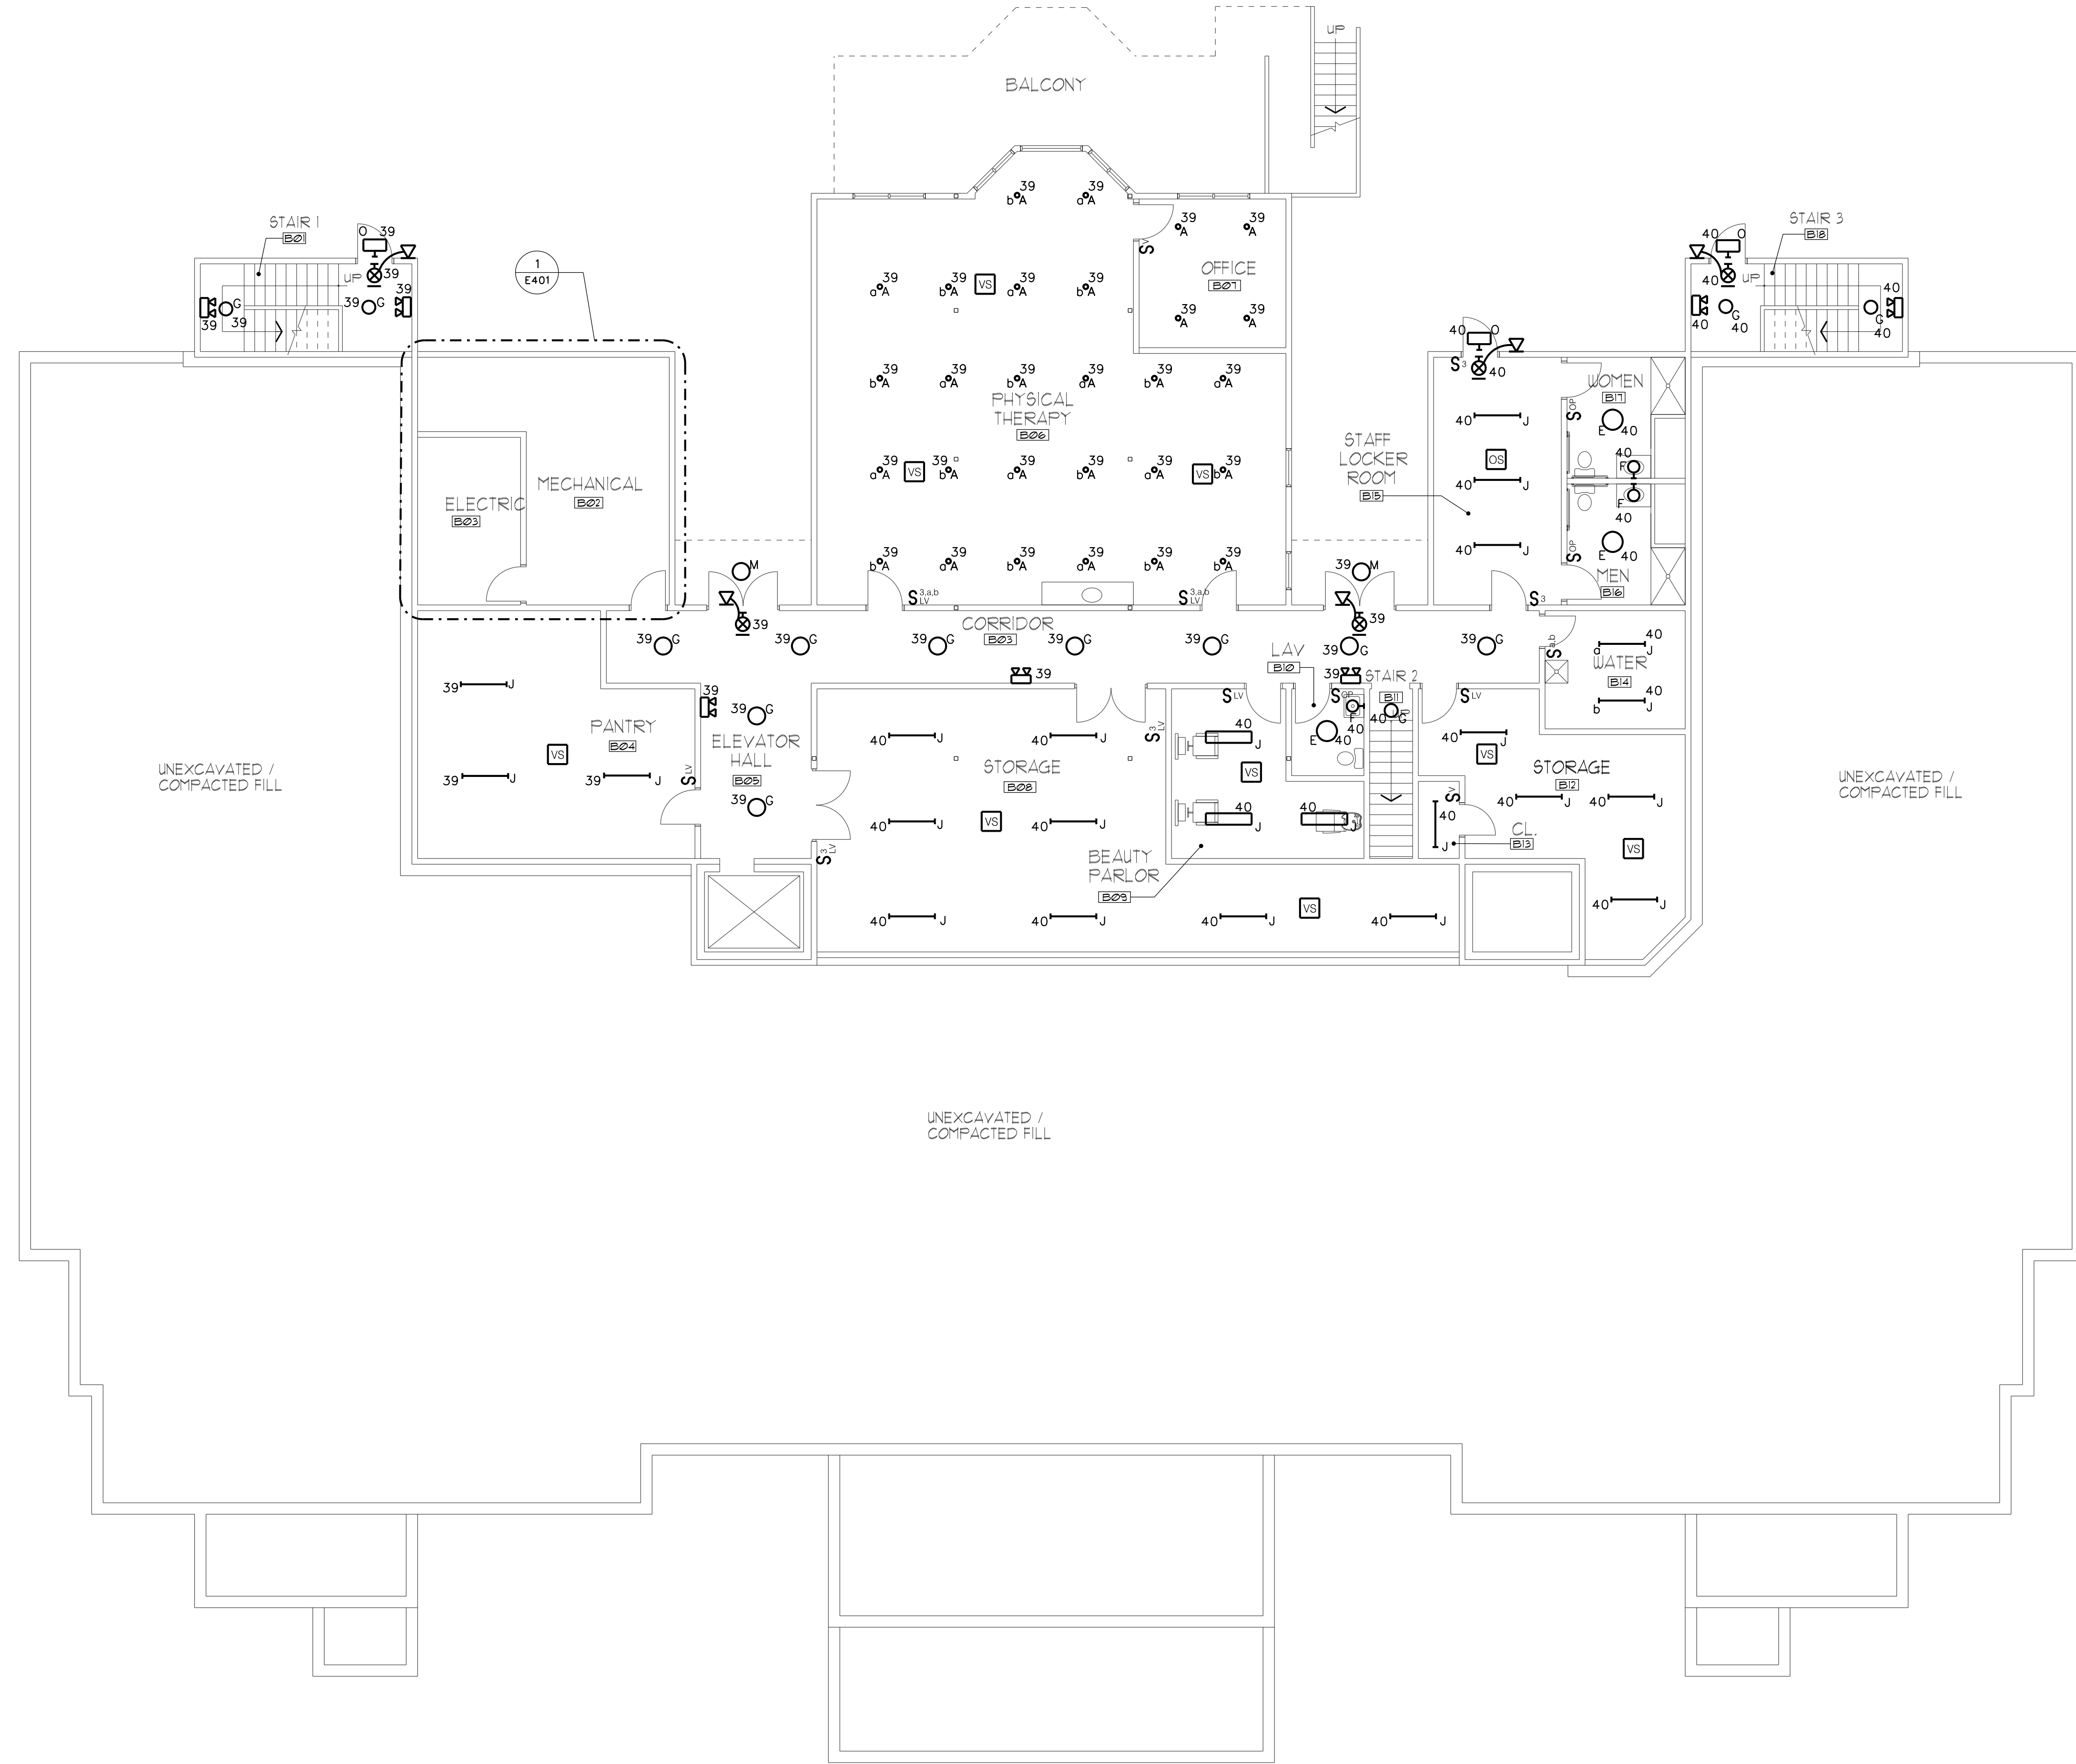

- GENERAL NOTES:**
- A. UNLESS OTHERWISE NOTED, ALL BRANCH CIRCUIT WIRING SHALL BE 2"X12" WITH (1)"X12", TYPE MC CABLE.
 - B. REFER TO ONE-LINE DIAGRAM, SCHEDULES AND DETAILS FOR ADDITIONAL INFORMATION AND REQUIREMENTS.
 - C. ALL EXTERIOR BUILDING MOUNTED LIGHT FIXTURES SHALL BE CIRCUITED TO PANEL 'PB-1' AND CONNECTED TO TIME CLOCK CONTROLS.
 - D. REFER TO ENLARGED PLANS FOR TYPICAL DEVICE LAYOUT AND ADDITIONAL REQUIREMENTS.
 - E. ALL LUMINAIRES SHALL BE CIRCUITED TO PANEL 'PB-1', UNLESS OTHERWISE NOTED.

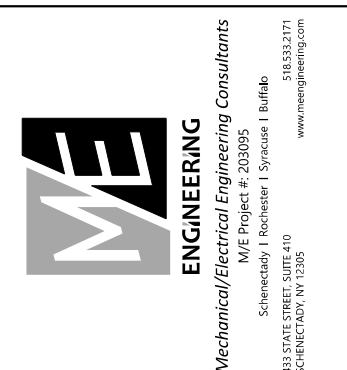

DATE: 9/18/2020
REVISION: 10/23/2020
ADDENDUM 1

PROJECT NO. 2020095
DESIGNED BY: CUE
DRAWN BY: CUE
CHECKED BY: RSA
SCALE: AS NOTED
NOTES:

**BASEMENT ELECTRICAL
LIGHTING PLAN**

**HARRIS A. SANDERS
ARCHITECTS, P.C.**
252 WASHINGTON AVENUE, ALBANY, NEW YORK 12210
L'DOR ADULT CARE FACILITY
156 WEST CLARKSTOWN ROAD
NEW CITY, N.Y. 10956

SHEET NO.
E201

1 BASEMENT FLOOR PLAN
SCALE: 1/8"=1'-0"
NORTH
0 4' 8' 16'