


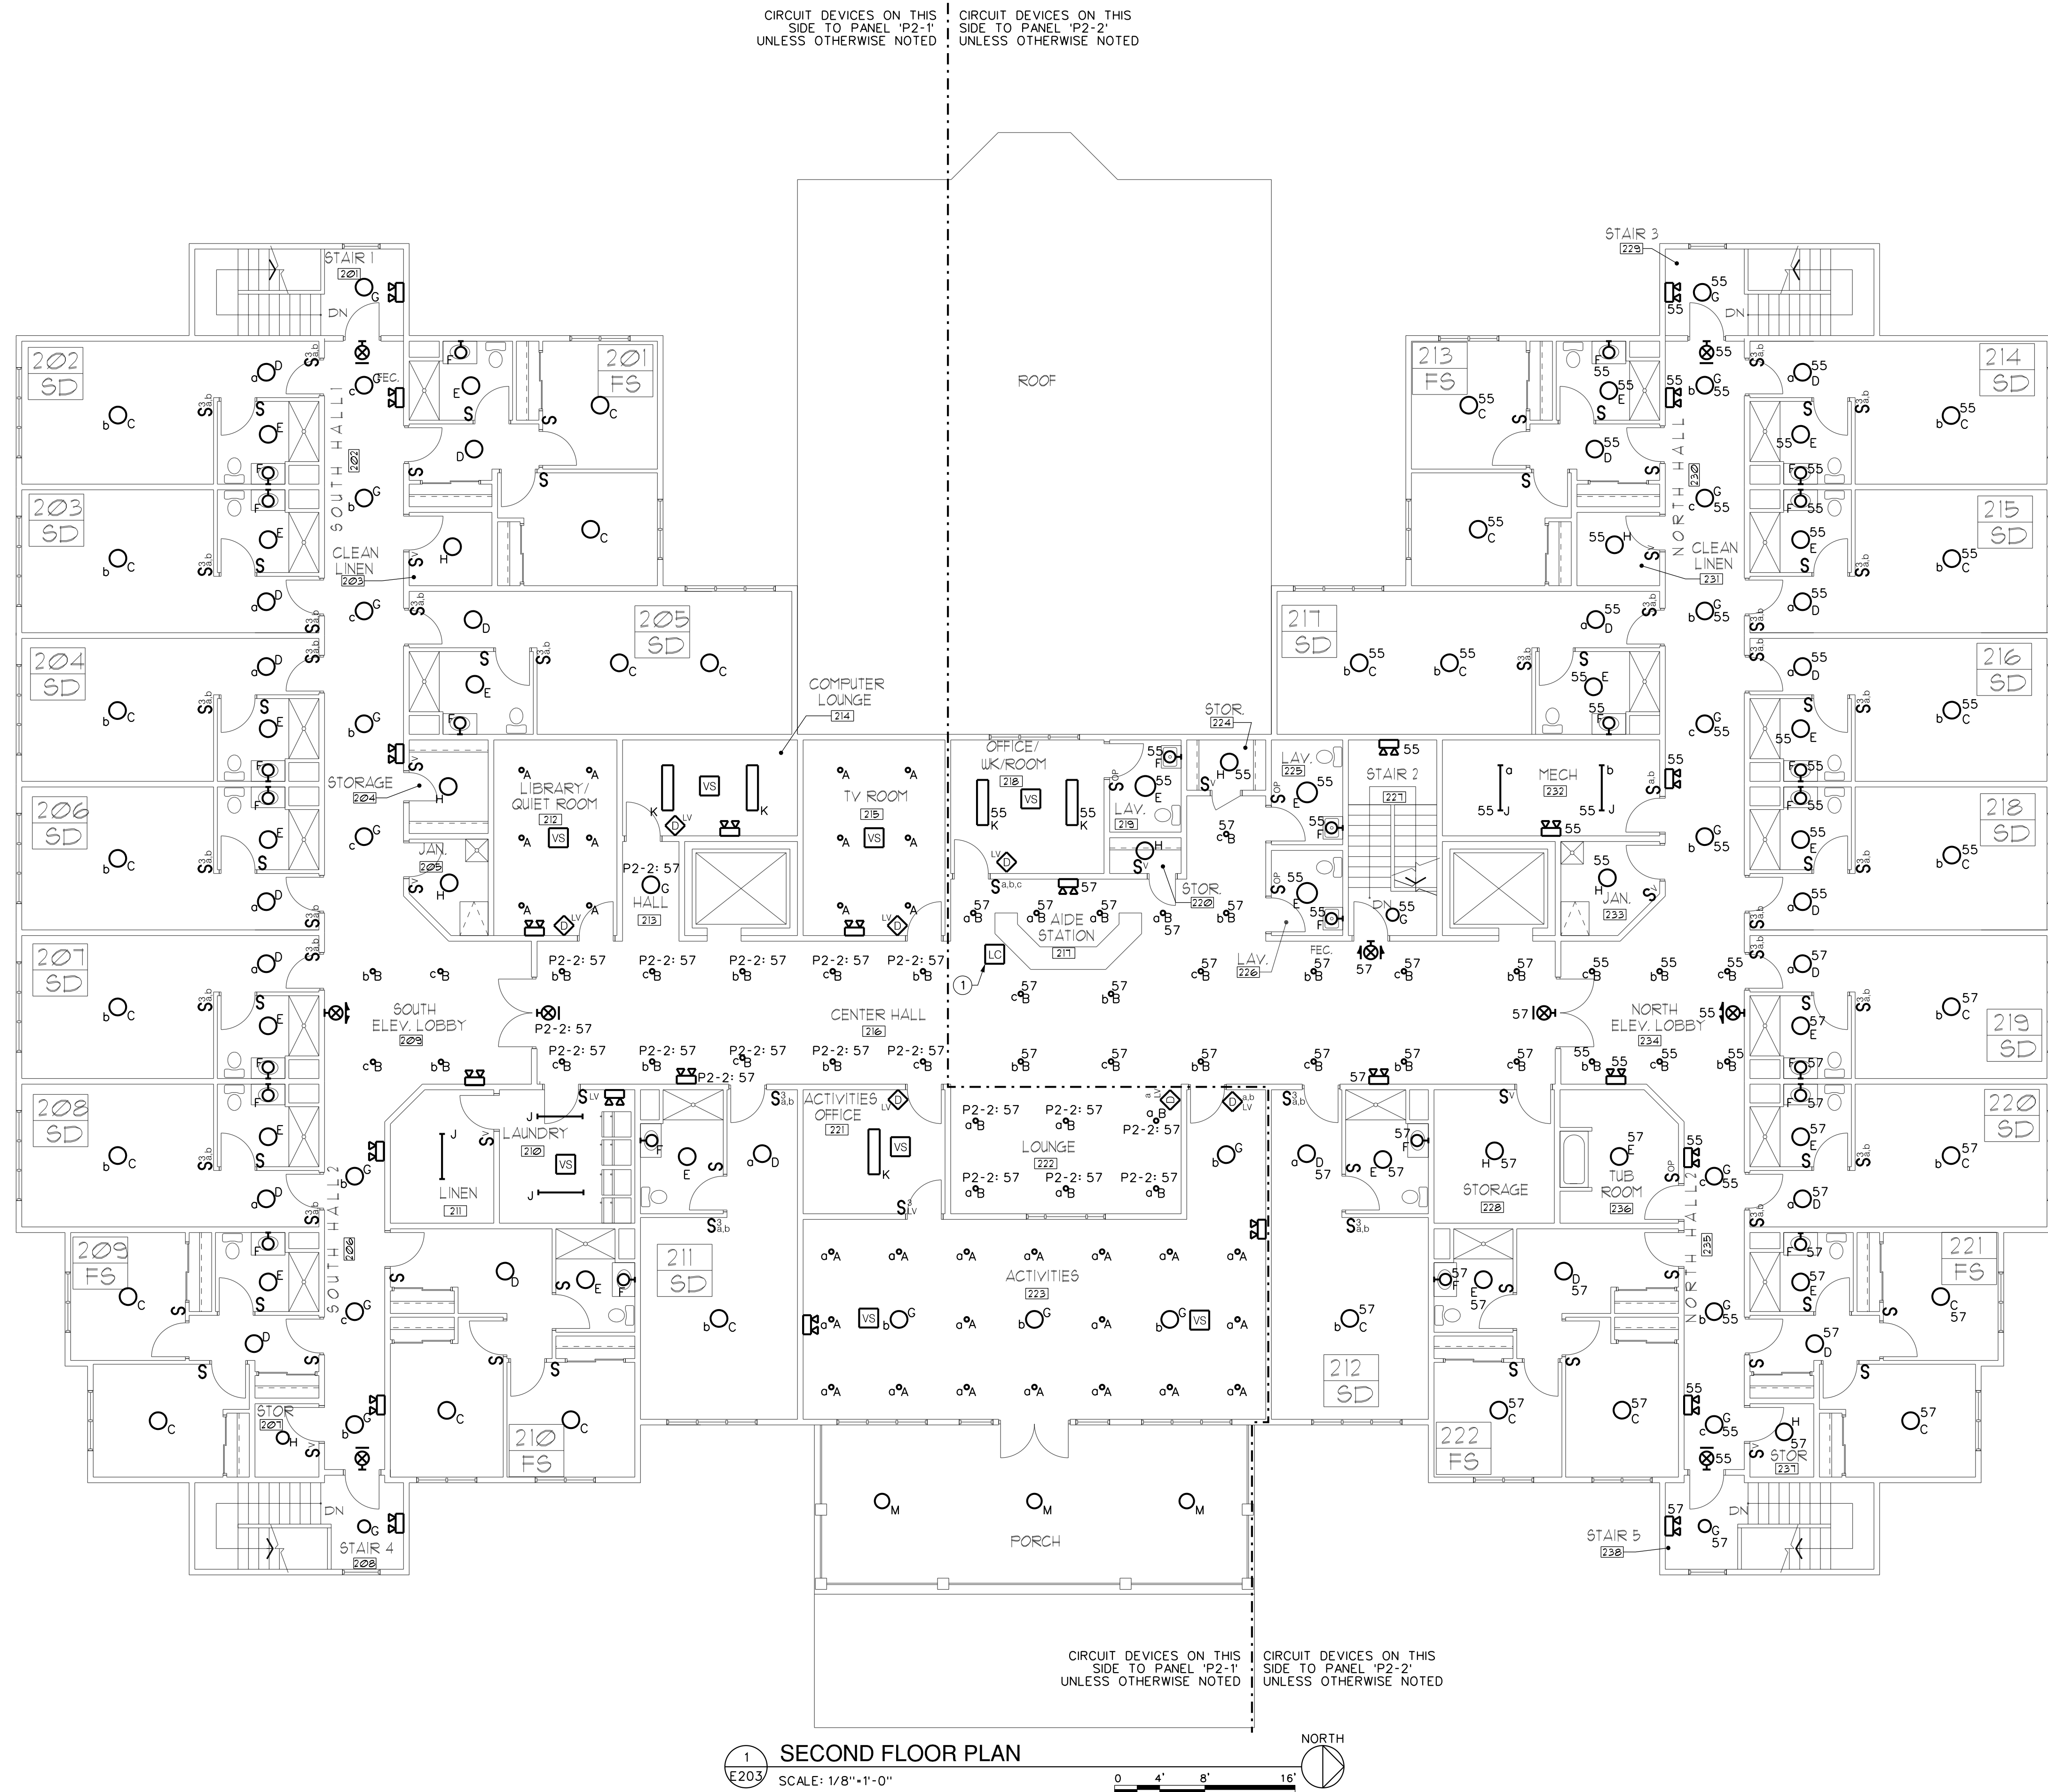

- GENERAL NOTES:**
- A. UNLESS OTHERWISE NOTED, ALL BRANCH CIRCUIT WIRING SHALL BE (2)*12 WITH (1)*12G, TYPE MC CABLE CIRCUITED TO PANEL INDICATED ON PLAN VIEW.
- B. REFER TO ONE-LINE DIAGRAM, SCHEDULES AND DETAILS FOR ADDITIONAL INFORMATION AND REQUIREMENTS.
- C. ALL EXTERIOR BUILDING MOUNTED LIGHT FIXTURES SHALL BE CIRCUITED TO PANEL XXX AND CONNECTED TO TIME CLOCK CONTROLS.
- DRAWING NOTES:**
- ① PROVIDE LIGHTING CONTACTOR ABOVE CEILING TO CONTROL SWITCH LEG C & D THROUGHOUT THE CORRIDOR AS SHOWN.

 ME ENGINEERING Mechanical/Electrical Engineering Consultants NY: Project # 20095 Schenectady, NY 12305 Tel: 518.351.7171 www.meengr.com	DATE: 9/18/2020 REVISION: 10/19/2020 ADDENDUM 1	PROJECT NO. 200905 DESIGNED BY: CUE DRAWN BY: CUE CHECKED BY: RSA SCALE: AS NOTED NOTES:	SECOND FLOOR PLAN ELECTRICAL LIGHTING PLAN	HARRIS A. SANDERS ARCHITECTS, P.C. 252 WASHINGTON AVENUE, ALBANY, NEW YORK 12210 L'DOR ADULT CARE FACILITY 156 WEST CLARKSTOWN ROAD NEW CITY, N.Y. 10956	SET NO.
E203					