

CONDUIT AND COPPER CABLE SCHEDULE							
FEEDER RATING	4 WIRE FEEDERS WITH GROUNDING CONDUCTOR		• SETS	WIRE SIZE (PER SET)		3 WIRE FEEDERS WITH GROUNDING CONDUCTOR	
	IDENTIFIER	CONDUIT SIZE		PHASE & NEUT	GROUND	IDENTIFIER	CONDUIT SIZE
20	A	1/2"	1	12	12	A1	1/2"
30	B	3/4"	1	10	10	B1	3/4"
40	C	3/4"	1	8	10	C1	3/4"
50,60	D	1"	1	6	10	D1	1"
70	E	1-1/4"	1	4	8	E1	1-1/4"
80	F	1-1/4"	1	3	8	F1	1-1/4"
90,100	G	1-1/2"	1	2	8	G1	1-1/4"
110	H	1-1/2"	1	2	6	H1	1-1/4"
125	I	2"	1	1	6	I1	1-1/2"
150	J	2"	1	1/0	6	J1	2"
175	K	2"	1	2/0	6	K1	2"
200	L	2-1/2"	1	3/0	6	L1	2"
225	M	2-1/2"	1	4/0	4	M1	2-1/2"
250	N	3"	1	250 KCMIL	4	N1	2-1/2"
300	O	3"	1	350 KCMIL	4	O1	3"
350	P	4"	1	500 KCMIL	2	P1	4"
400	Q	4"	1	500 KCMIL	2	Q1	4"
450	R	2-1/2"	2	4/0	2	R1	2-1/2"
500	S	3"	2	250 KCMIL	2	S1	2-1/2"
600	T	3"	2	350 KCMIL	1/0	T1	3"
700	U	4"	2	500 KCMIL	1/0	U1	4"
800	V	4"	2	500 KCMIL	1/0	V1	4"
1000	W	4"	3	500 KCMIL	2/0	W1	4"
1200	X	4"	3	600 KCMIL	3/0	X1	4"

GENERAL NOTES

1. IF IDENTIFIER ON ONE-LINE DIAGRAM SHOWS CONDUCTORS SIZED WELL ABOVE OVERCURRENT PROTECTION, VOLTAGE DROP HAS BEEN ACCOUNTED FOR.


2. WHERE MULTIPLE SETS ARE SPECIFIED, PROVIDE 3 PHASE, NEUTRAL AND GROUNDING CONDUCTOR IN EACH CONDUIT. CONDUCTORS AND CONDUITS SHALL BE OF EQUAL LENGTHS AND OF SAME MANUFACTURER.

- DRAWING NOTES:
- 1

PROVIDE CONTROL WIRING AND PROGRAMMING FOR ELEVATOR PRE-TRANSFER SIGNAL. COMPLY WITH ELEVATOR MANUFACTURER'S REQUIREMENTS.
- 2

PROVIDE CONTROL WIRING FOR INTERFACE WITH BUILDING MANAGEMENT SYSTEM (BMS). COORDINATE WITH DIV. 23.
- 3

PROVIDE (2) 1-1/2" CONDUITS AND ALL REQUIRED CONTROL WIRING, BATTERY CHARGING CIRCUIT(S), ETC. REFER TO SPECIFICATION SECTION 263213.

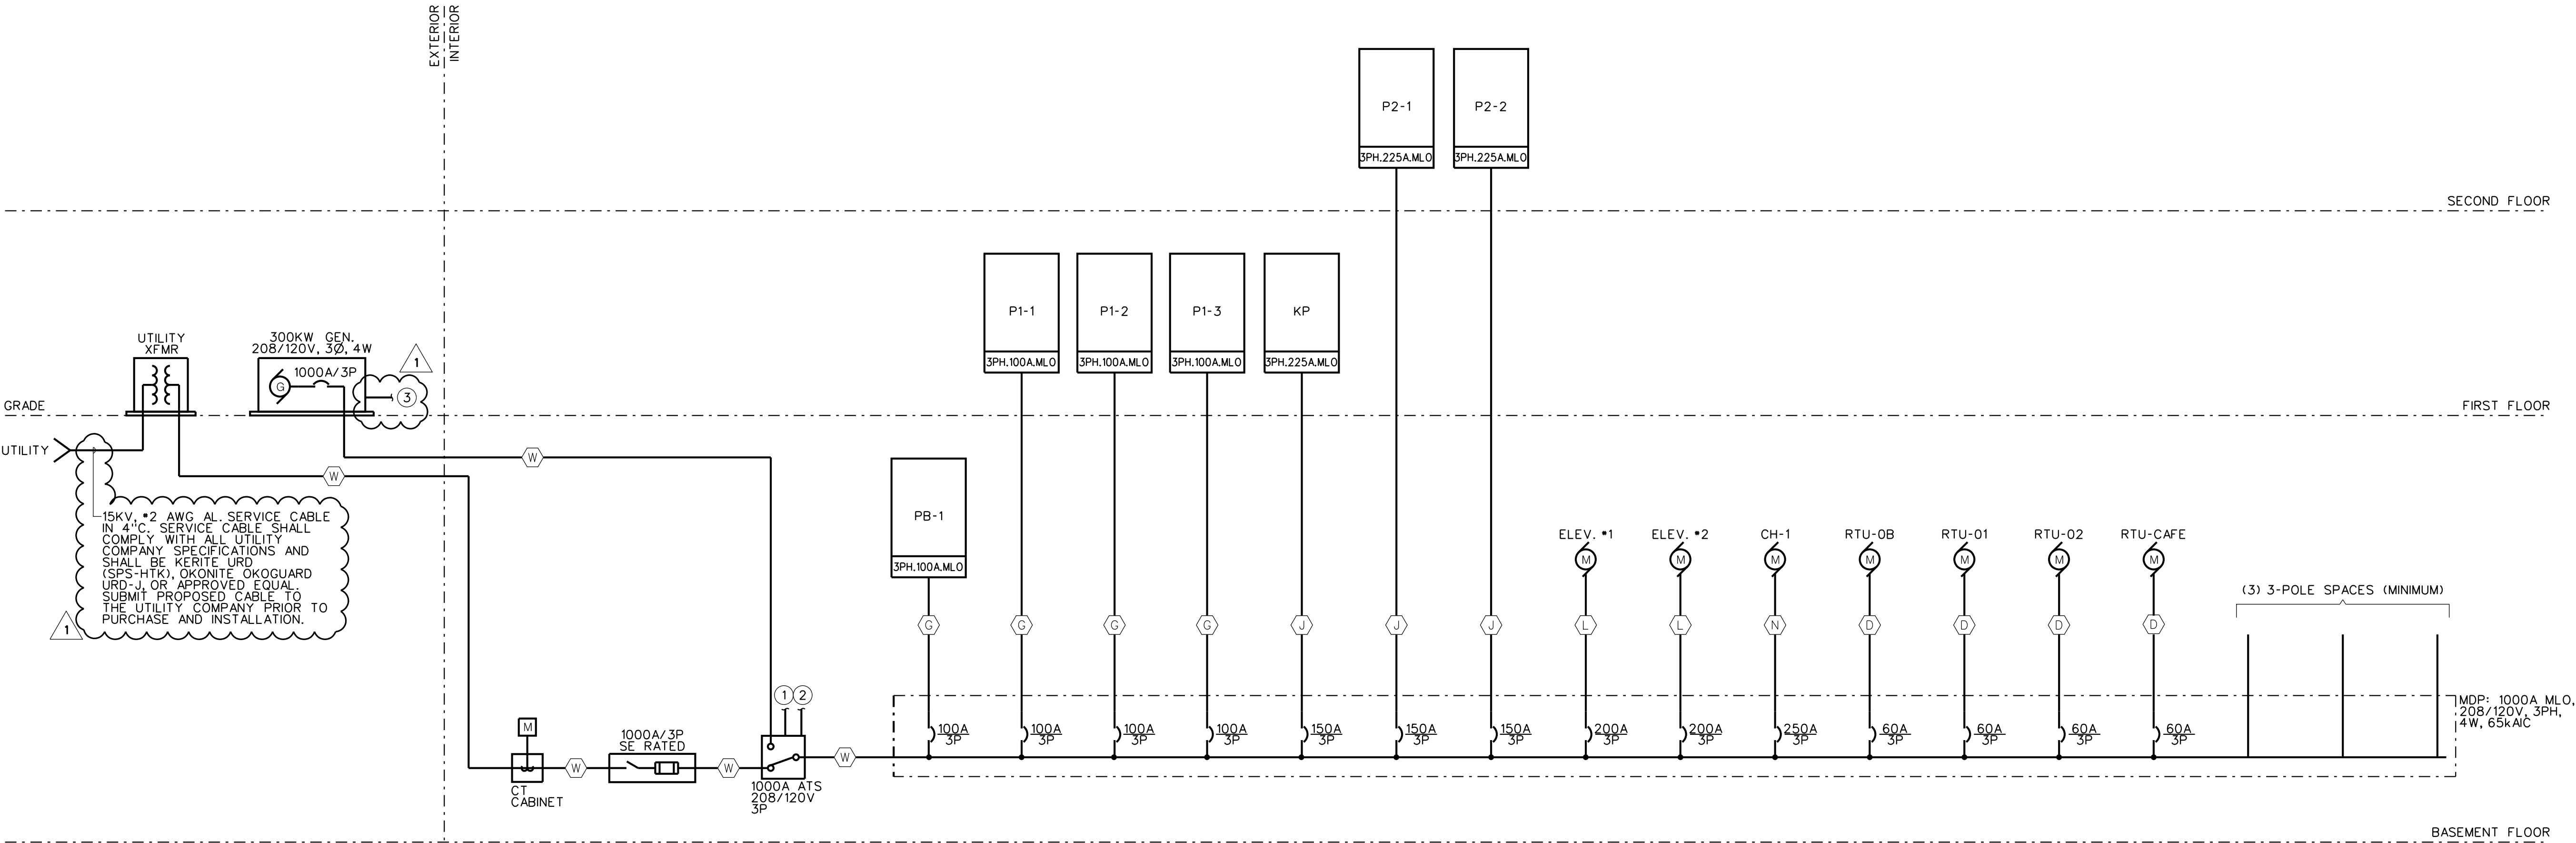

ONE-LINE DIAGRAM
SCALE: NONE

ME ENGINEERING
Mechanical/Electrical Engineering Consultants
NY Reg. # 20005
Schenectady County, NY
12305-1177
www.meengr.com

DATE: 9/18/2020
REVISION: 10/23/2020
ADDENDUM 1

PROJECT NO: 2020095
DESIGNED BY: CUE
DRAWN BY: CUE
CHECKED BY: RSA
SCALE: AS NOTED
NOTES:

HARRIS A. SANDERS
ARCHITECTS, P.C.
252 WASHINGTON AVENUE, ALBANY, NEW YORK 12210

L'DOR ADULT CARE FACILITY
156 WEST CLARKSTOWN ROAD
NEW CITY, N.Y. 10956

SET NO:
E501

BID SET 9-18-20