


GENERAL NOTES:

A. ALL CONDENSATE PIPING TO BE 3/4" UNLESS OTHERWISE NOTED

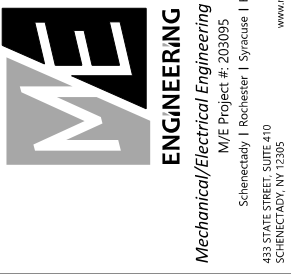

DATE: 9/19/2020
REVISION: 10/22/2020
ADDENDUM 1

PROJECT NO. 2020095
DESIGNED BY: CUE
DRAWN BY: CUE
CHECKED BY: RSA
SCALE: AS NOTED
NOTES:

SECOND FLOOR
MECHANICAL PIPING PLAN


HARRIS A. SANDERS
ARCHITECTS, P.C.
252 WASHINGTON AVENUE, ALBANY, NEW YORK 12210

L'DOR ADULT CARE FACILITY
156 WEST CLARKSTOWN ROAD
NEW CITY, N.Y. 10956

SHEET NO.

M203

BID SET 9-18-20

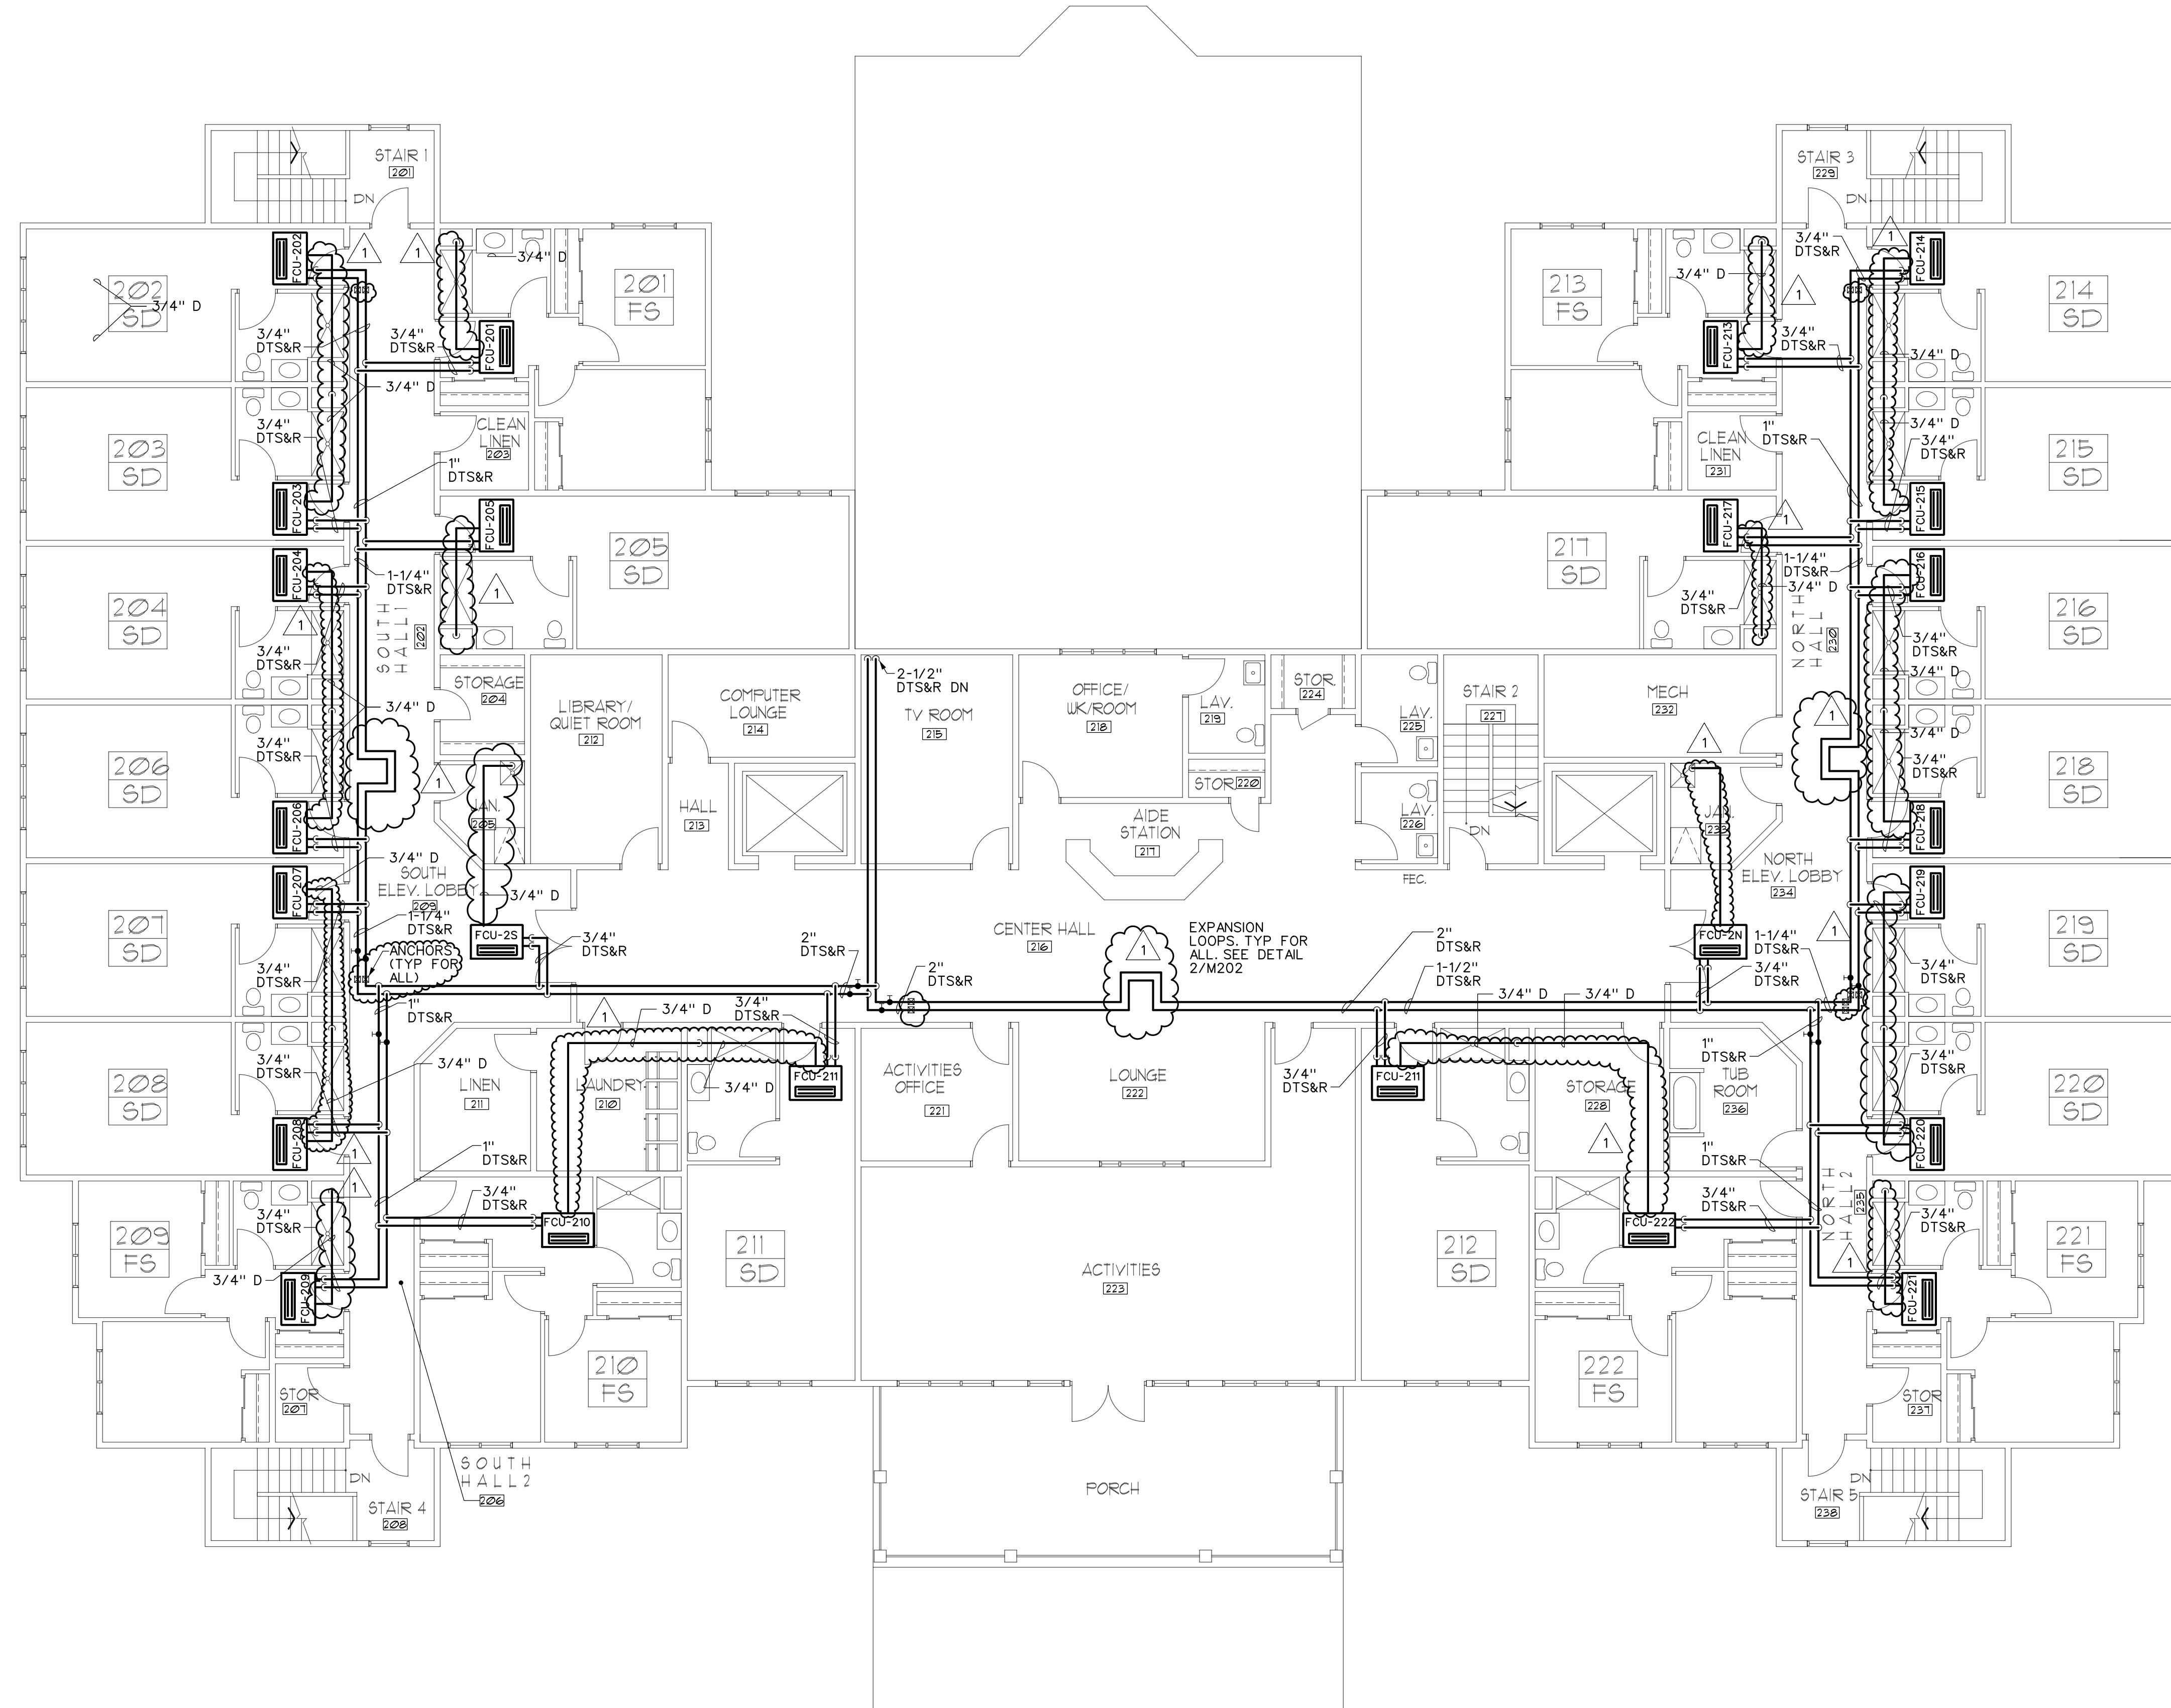

1 SECOND FLOOR MECHANICAL PIPING PLAN
SCALE: 1/8"=1'-0" NORTH