



1 BASEMENT FLOOR PLAN
SCALE: 1/8"=1'-0"

- GENERAL NOTES:**
- A. UNLESS OTHERWISE NOTED, ALL BRANCH CIRCUIT WIRING SHALL BE (2)X12 WITH (1)X12 GROUND, TYPE NM CABLE. ALL BRANCH CIRCUIT WIRING WITHIN MECH/ELEC SPACES AND OTHER UNFINISHED SPACES SHALL BE TYPE MC CABLE.
 - B. COORDINATE SINGLE POINT OF CONNECTION (FOR DATA, PHONE, AND CABLE TV) WITH SERVICE PROVIDER. PROVIDE CABLEING AND OUTLET PER SERVICE PROVIDER'S INSTRUCTIONS.
 - C. REFER TO ONE-LINE DIAGRAM, SCHEDULES AND DETAILS FOR ADDITIONAL INFORMATION AND REQUIREMENTS.
 - D. REFER TO ENLARGED PLANS FOR TYPICAL DEVICE LAYOUT AND ADDITIONAL REQUIREMENTS.
 - E. ELECTRICAL CONTRACTOR TO PROVIDE DATA CABLES BACK TO ELECTRICAL RM IN BASEMENT. DATA RACKS BY OTHERS.
 - F. ALL EQUIPMENT AND DEVICES SHALL BE CIRCUITED TO PANEL 'PB-1', UNLESS OTHERWISE NOTED.
- DRAWING NOTES:**
- 1 PROVIDE DEDICATED RECEPTACLE AND BRANCH CIRCUIT FOR EXERCISE EQUIPMENT.

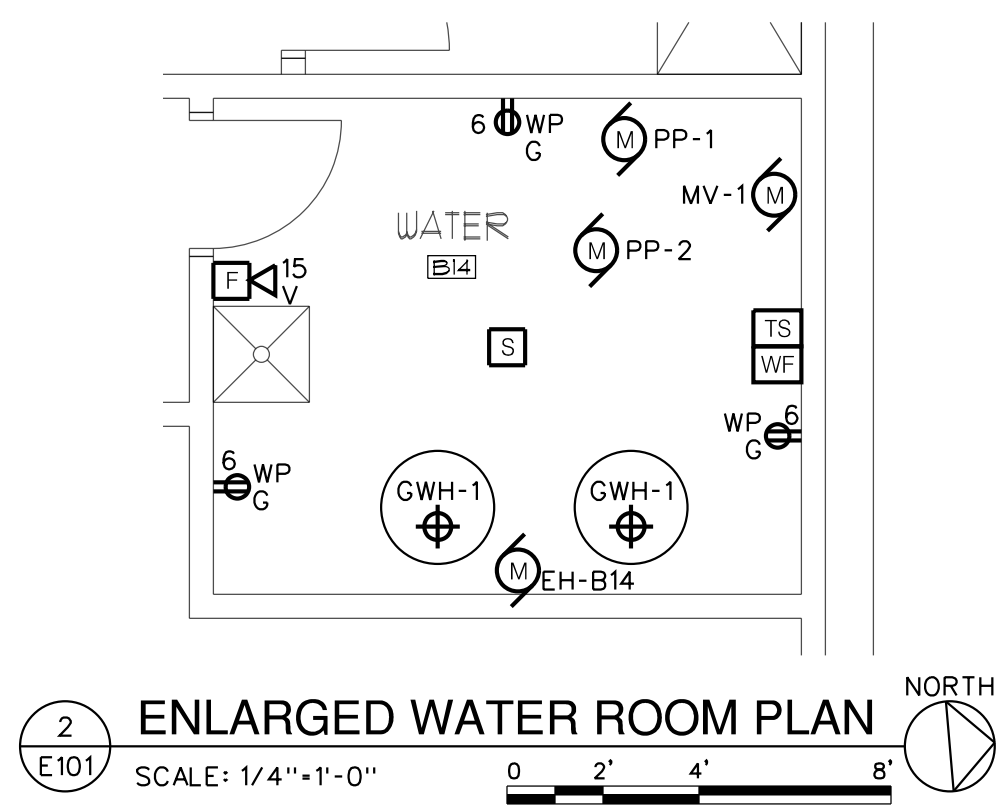

2 ENLARGED WATER ROOM PLAN
SCALE: 1/4"=1'-0"




ME
ENGINEERING
Mechanical/Electrical Engineering Consultants
NY Reg. # 20005 E. J. J. J.
Schenectady, NY 12305
518.537.1777
www.meengr.com

DATE: 9/18/2020
REVISION:

PROJECT NO.	200095
DESIGNED BY:	CUE
DRAWN BY:	CUE
CHECKED BY:	PSA
SCALE:	AS NOTED
NOTES:	

**HARRIS A. SANDERS
ARCHITECTS, P.C.**
252 WASHINGTON AVENUE, ALBANY, NEW YORK 12210

L'DOR ADULT CARE FACILITY
156 WEST CLARKSTOWN ROAD
NEW CITY, N.Y. 10956



STATE OF NEW YORK
MICHAEL R. SULLIVAN
077887-1
PROFESSIONAL ENGINEER

SHEET NO.
E101

BID SET 9-18-20