


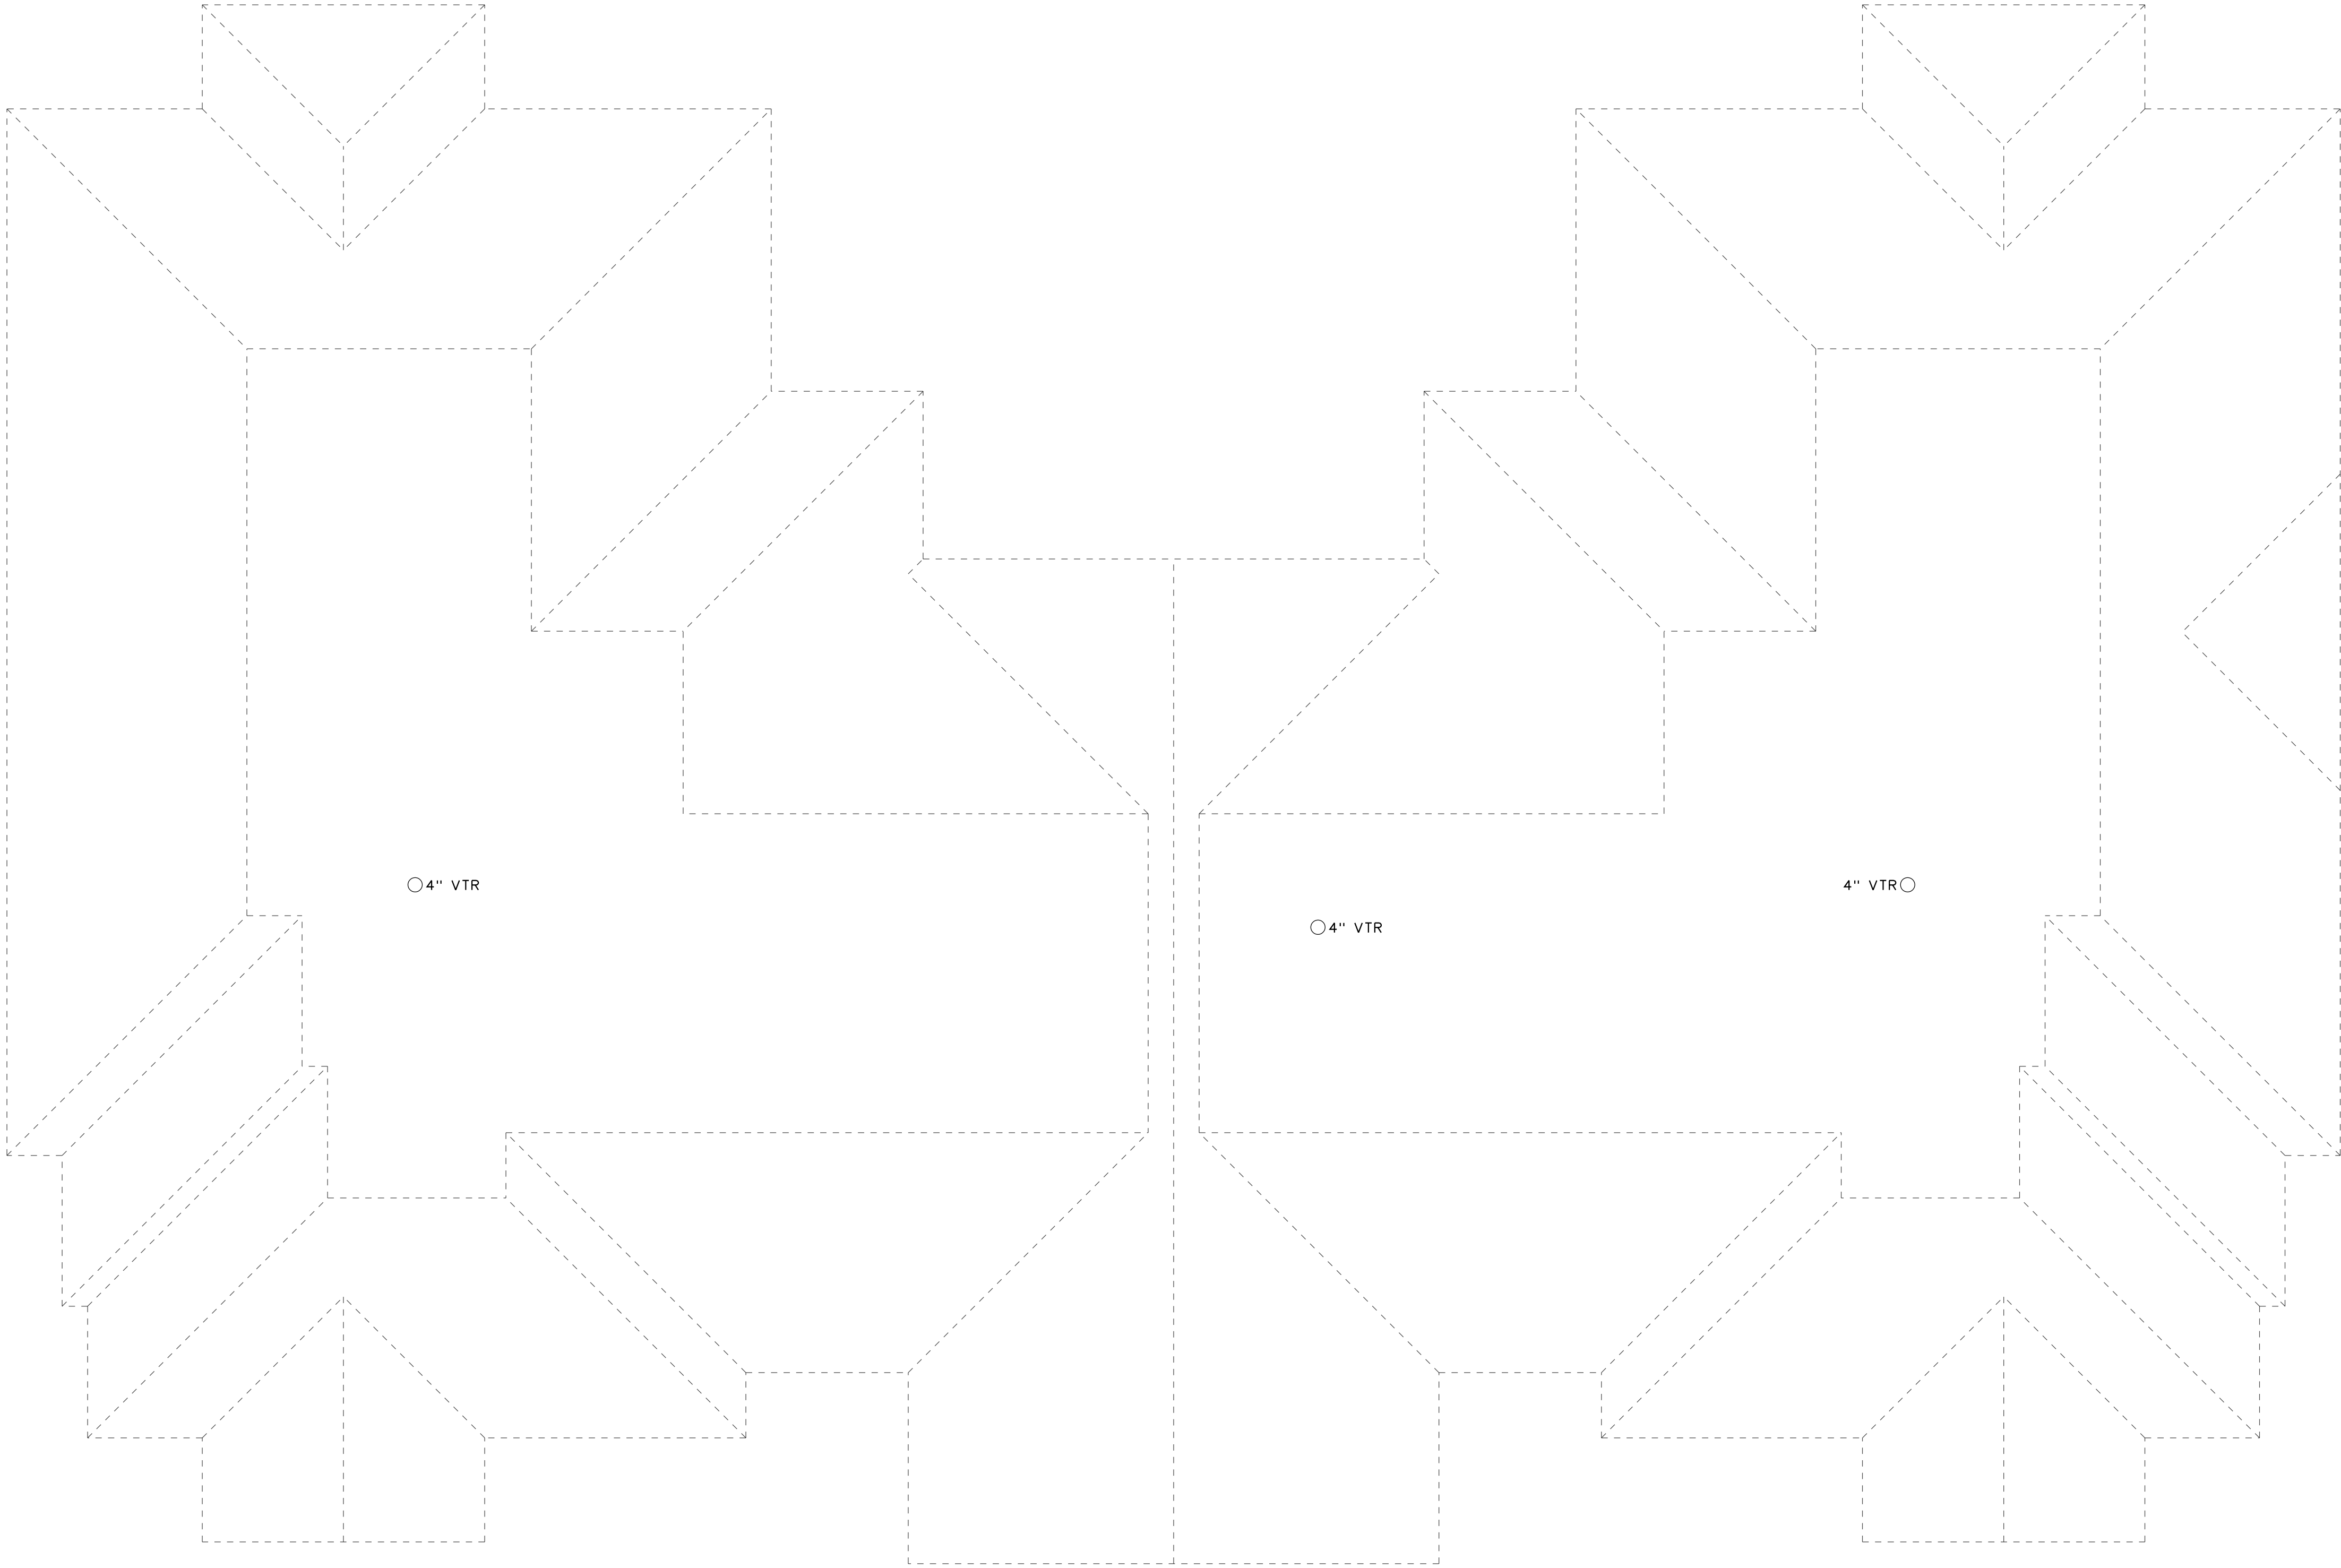

GENERAL NOTES:

- A. ALL PIPING IS ABOVE THE CEILING UNLESS OTHERWISE INDICATED.
- B. ALL PIPING SHALL BE INSTALLED CONCEALED UNLESS OTHERWISE INDICATED.
- C. COORDINATE ALL WORK WITH OTHER TRADES PRIOR TO BEGINNING WORK.
- D. ALL SANITARY PIPING SHALL SLOPE AT MINIMUM 1%.
- E. ALL STORM PIPING SHALL SLOPE AT MINIMUM 2% UNLESS OTHERWISE NOTED.
- F. PROVIDE LINK SEAL SEALING SLEEVES AT ALL LOCATIONS WHERE PIPING PENETRATES EXTERIOR WALLS AND FLOOR SLABS ON GRADE.

DRAWING NOTES:

- 1 2" WET VENT
- 2



DATE: 9/18/2020
REVISION:

PROJECT NO.	2020095
DESIGNED BY:	MJC
DRAWN BY:	MJC
CHECKED BY:	PCA
SCALE:	AS NOTED
NOTES:	

ROOF PLAN

HARRIS A. SANDERS
ARCHITECTS, P.C.
252 WASHINGTON AVENUE, ALBANY, NEW YORK 12210

L'DOR ADULT CARE FACILITY
156 WEST CLARKSTOWN ROAD
NEW CITY, N.Y. 10956



SHEET NO.

P104