



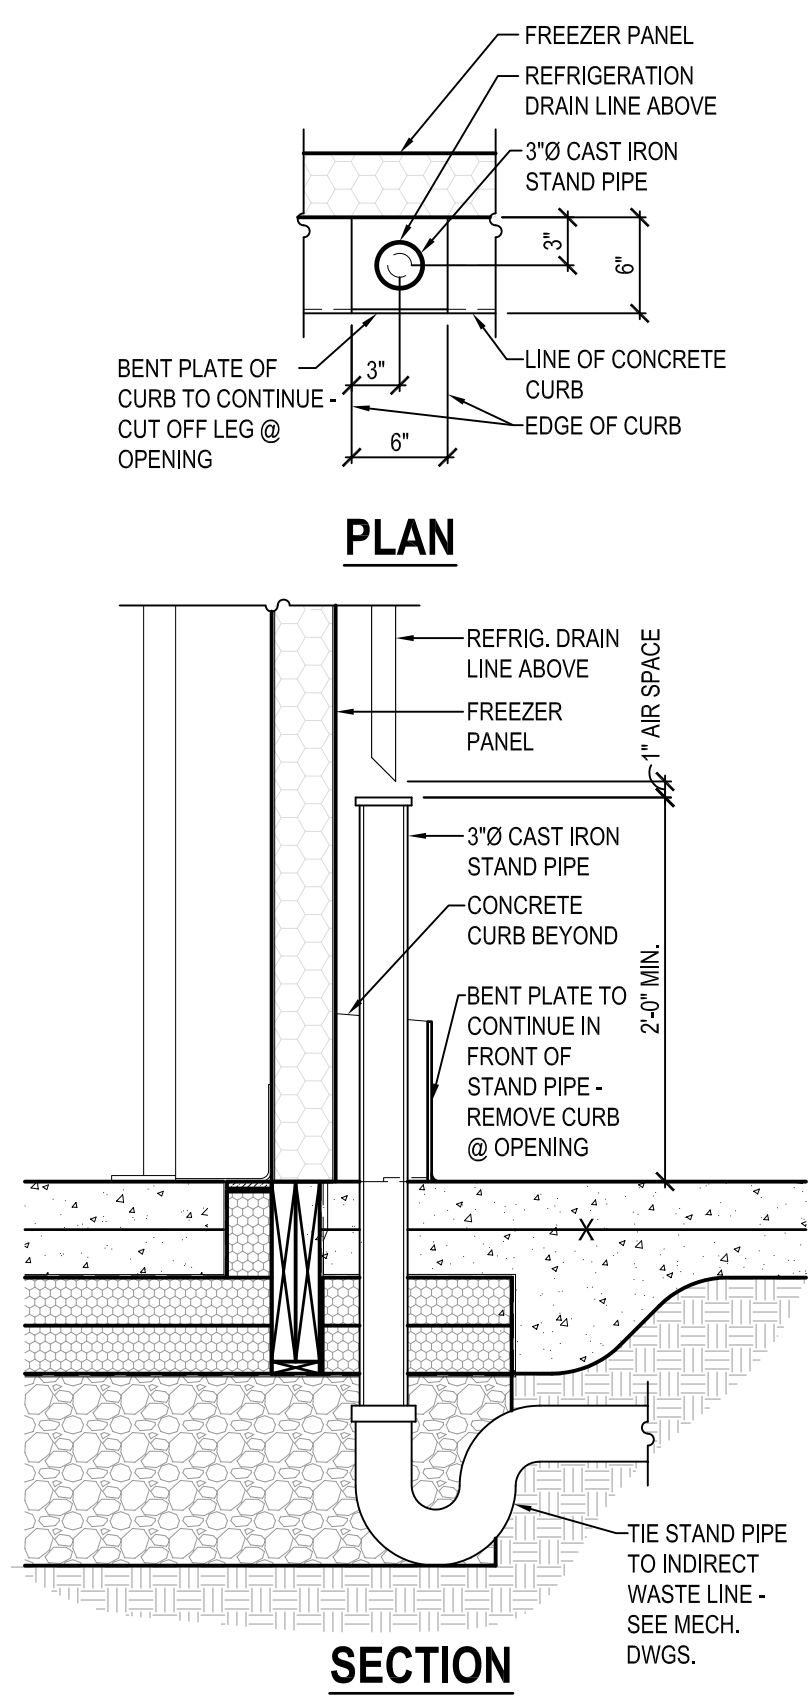


F STANDPIPE DETAILS
SCALE: 1"=1'-0"

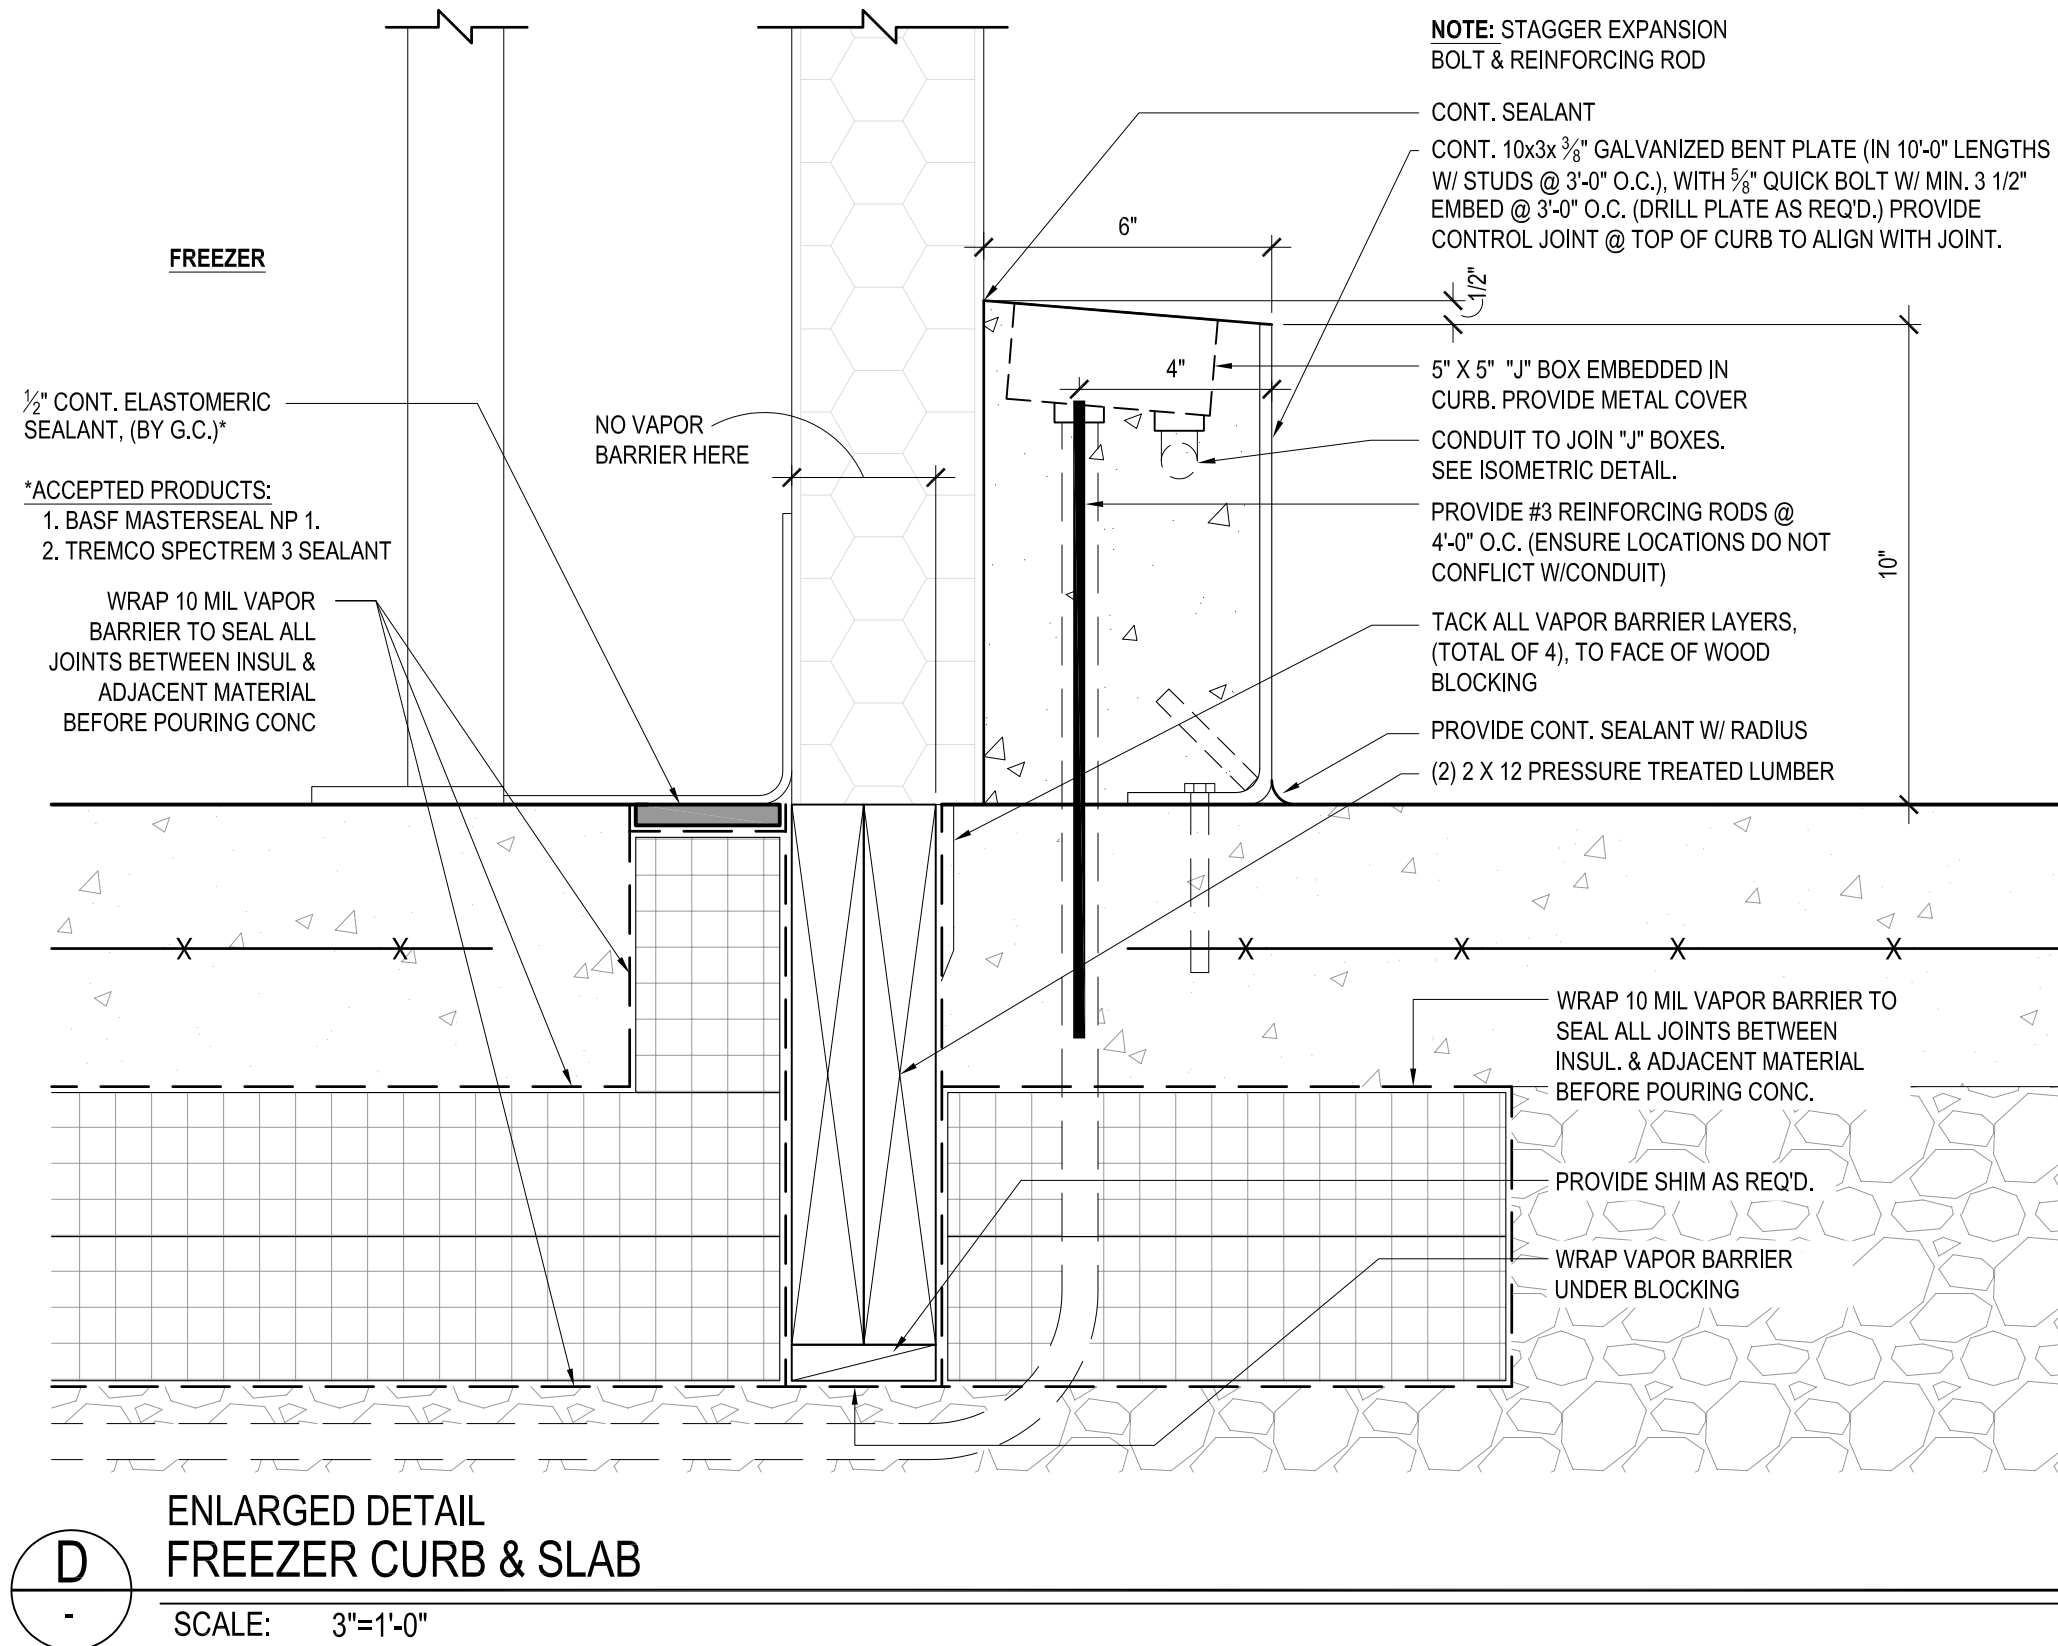


THERMAL BREAK RETURN LOCATION:
2 1/2\"/>


B FREEZER HIGH SPEED DOOR THRESHOLD PLAN DETAIL
SCALE: 1 1/2\"=1'-0"

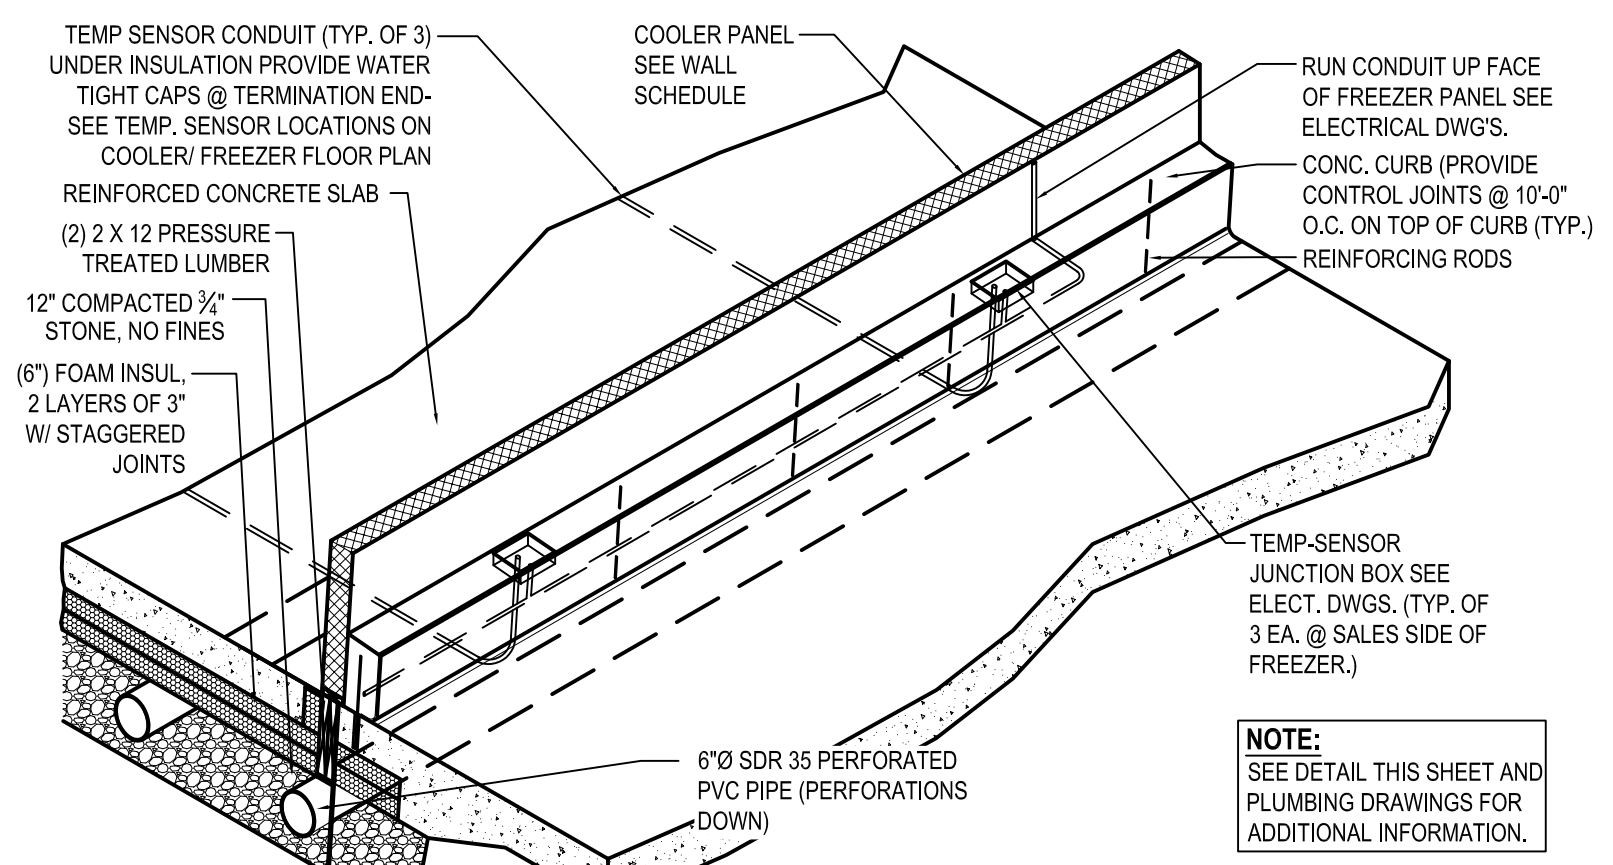


E PARTIAL ISOMETRIC FREEZER CURB & SLAB
SCALE: 1/2\"=1'-0"

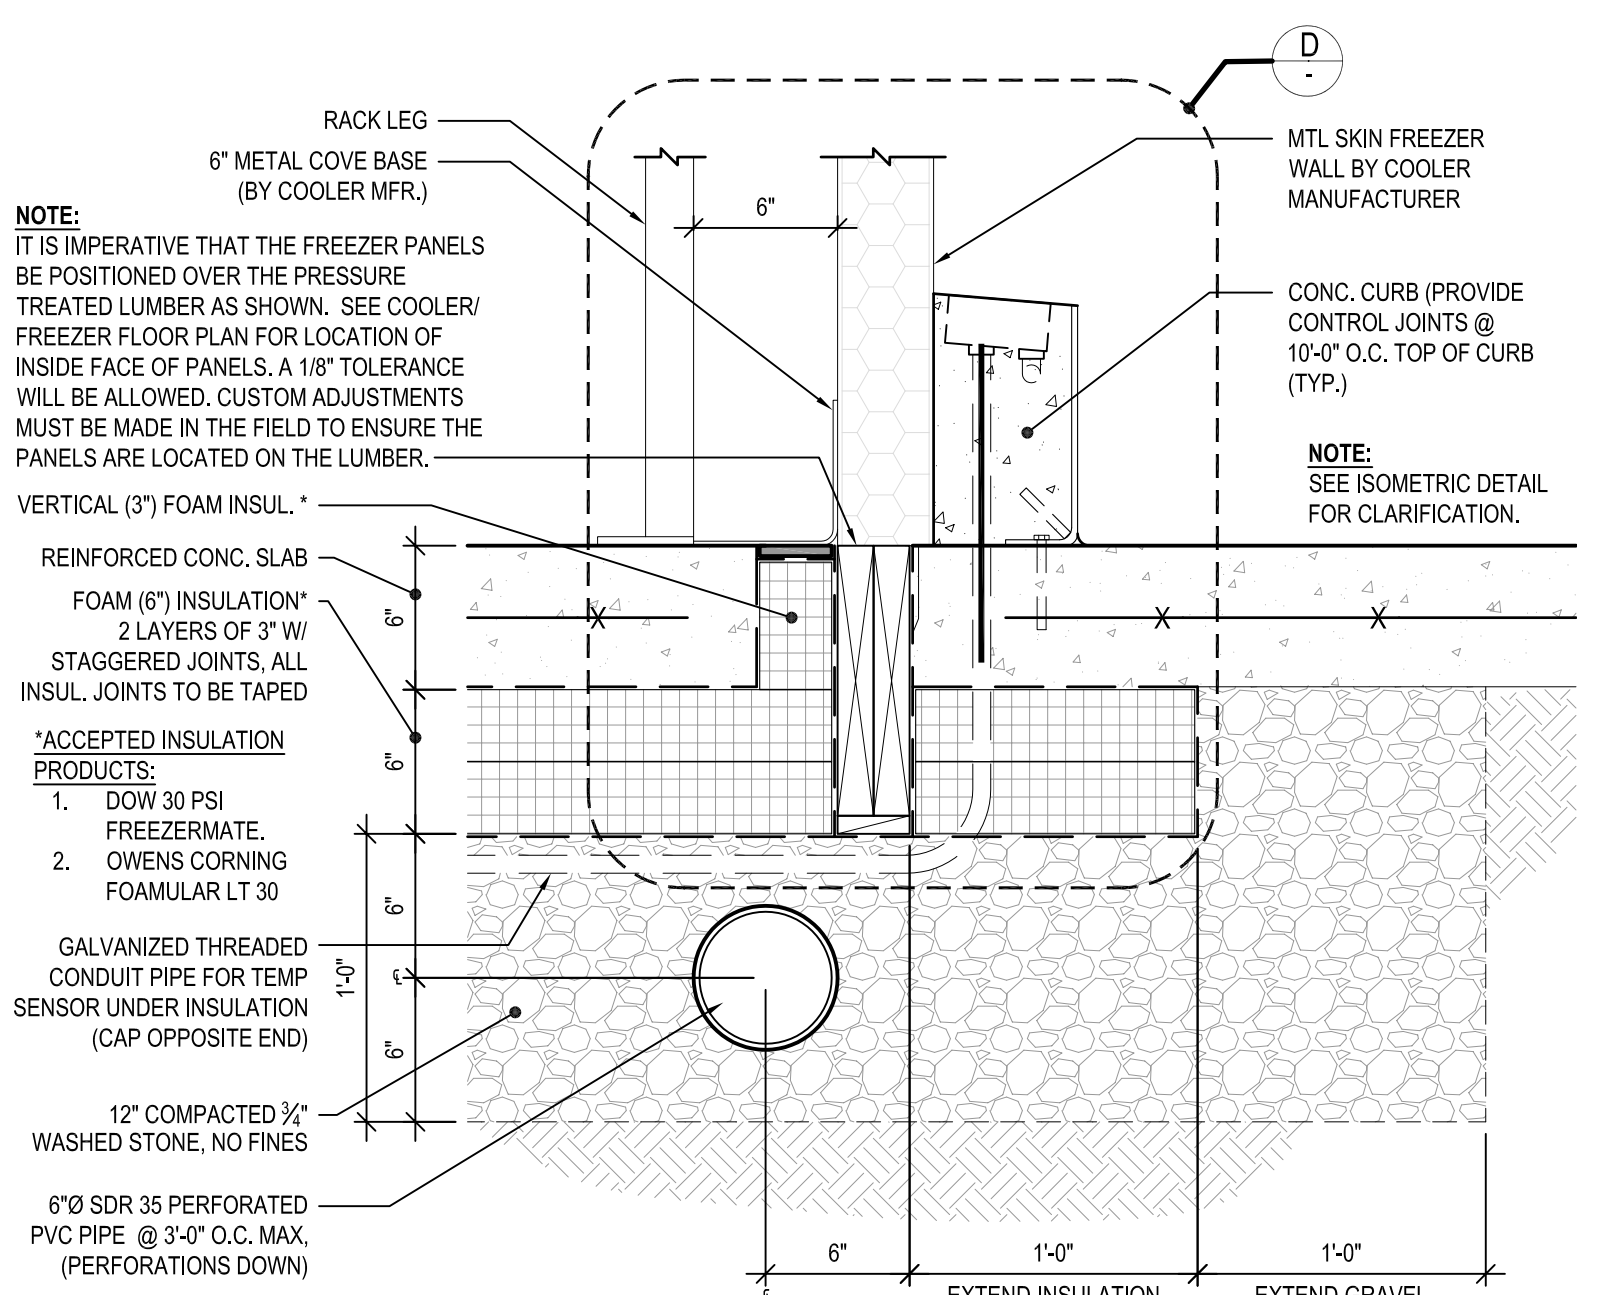


C FREEZER CURB & SLAB
SCALE: 1 1/2\"=1'-0"

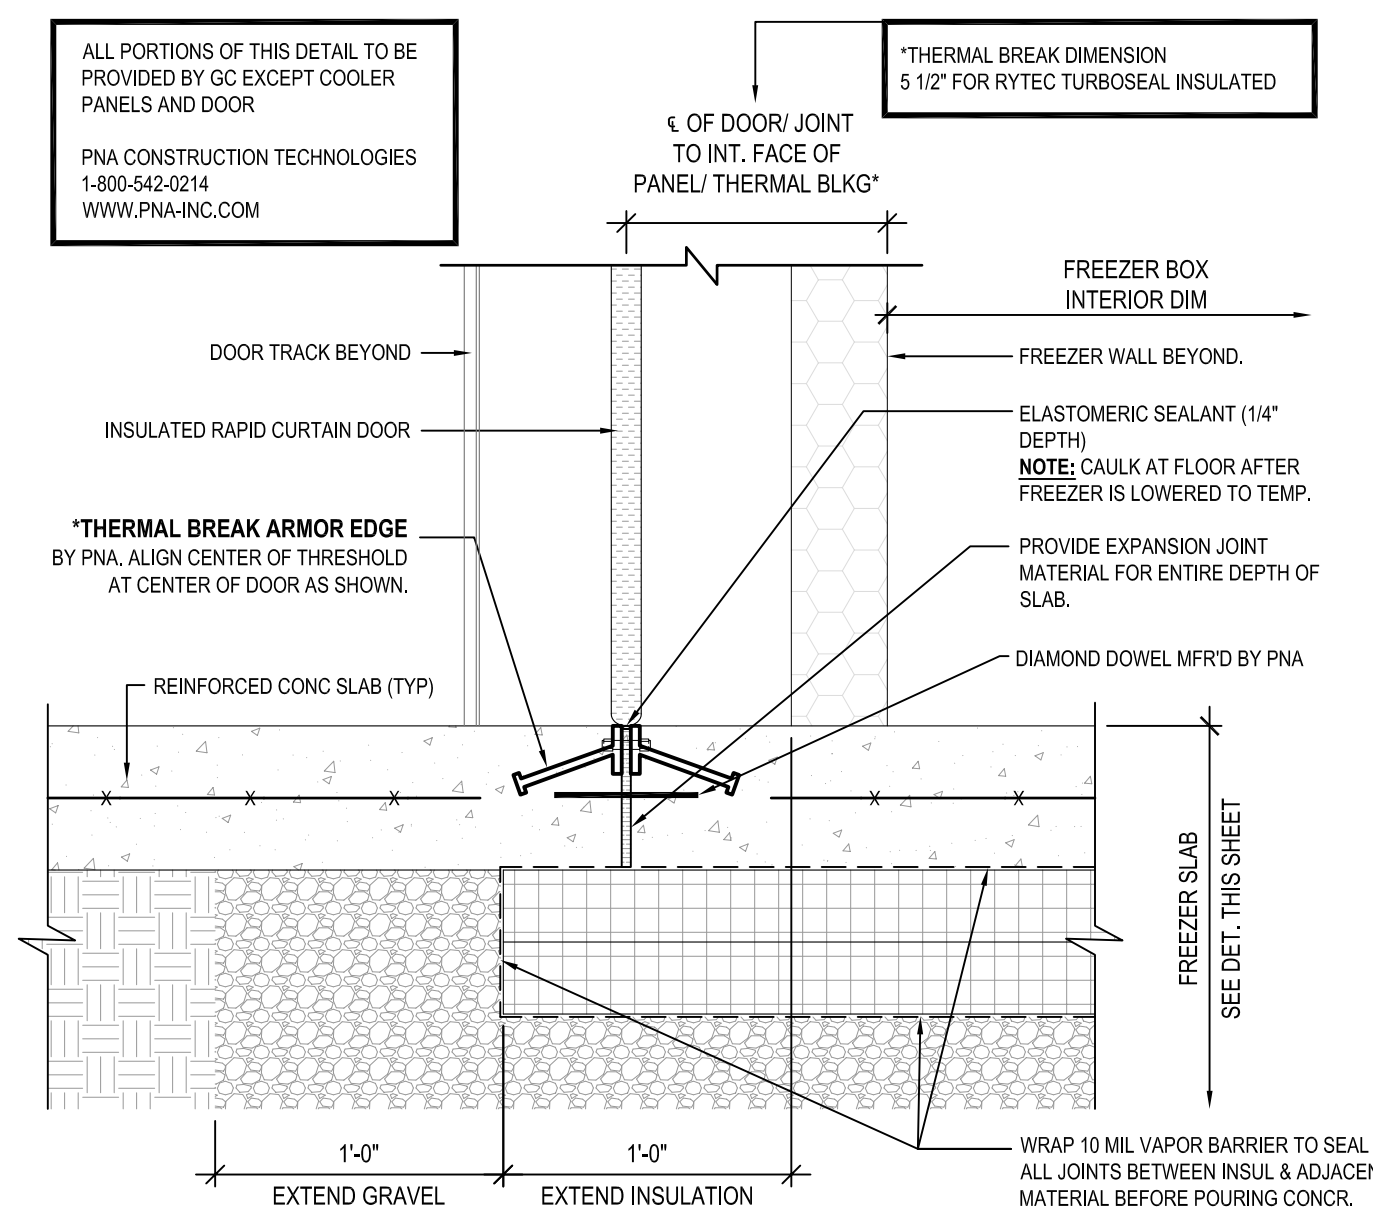

B1 FREEZER HIGH SPEED DOOR SILL PLATE
SCALE: 1 1/2\"=1'-0"

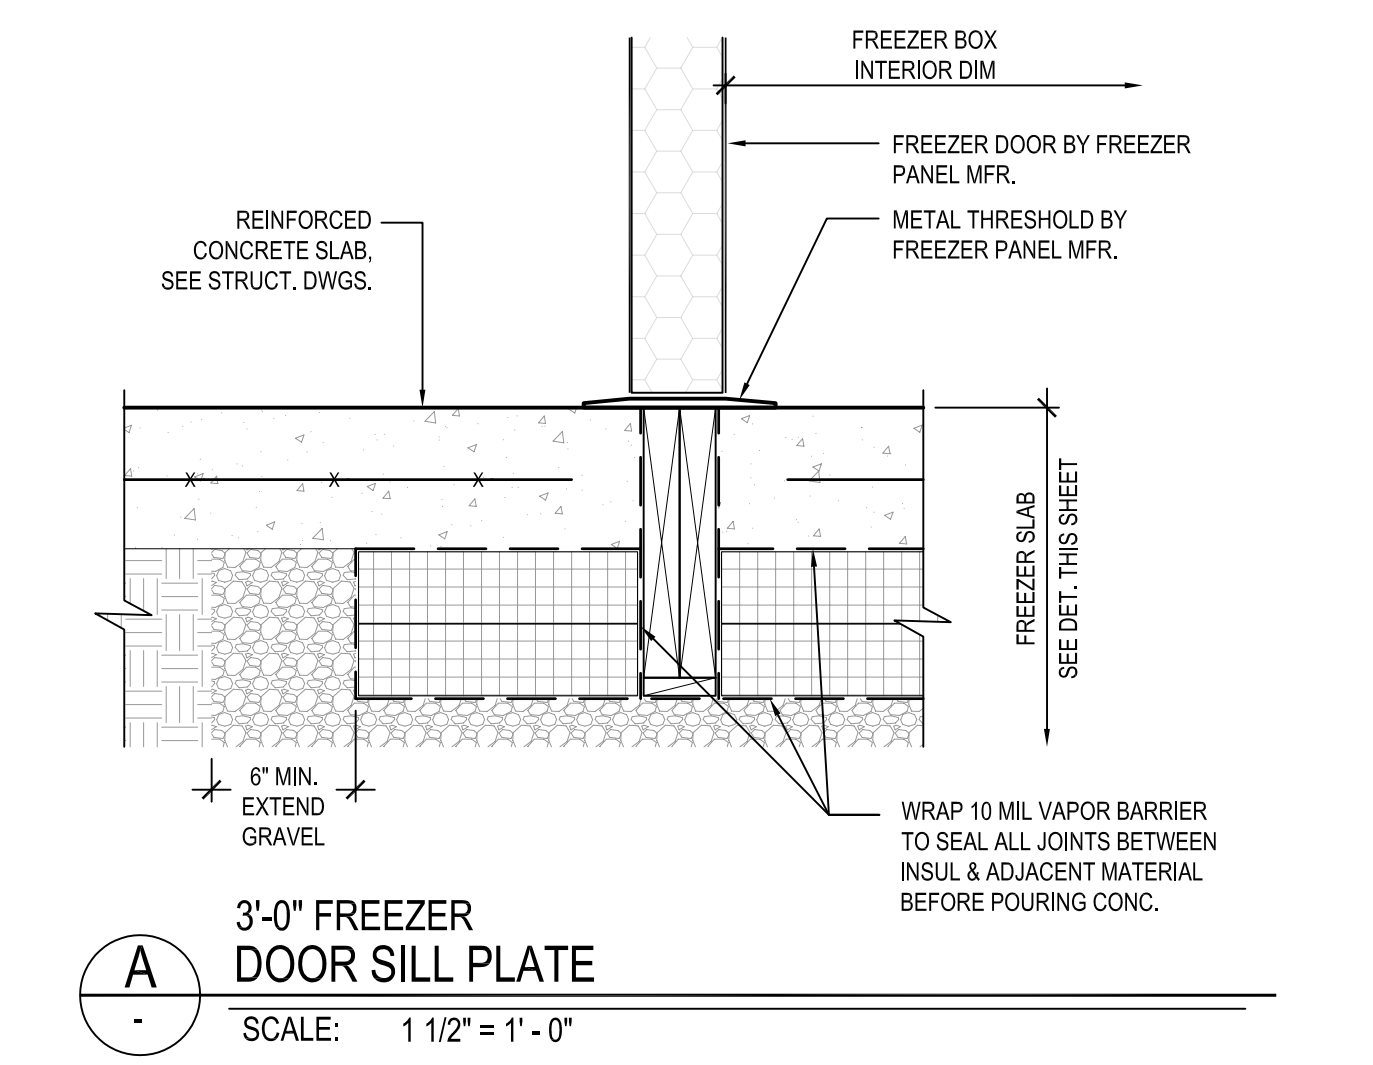


A 3'-0\"/>

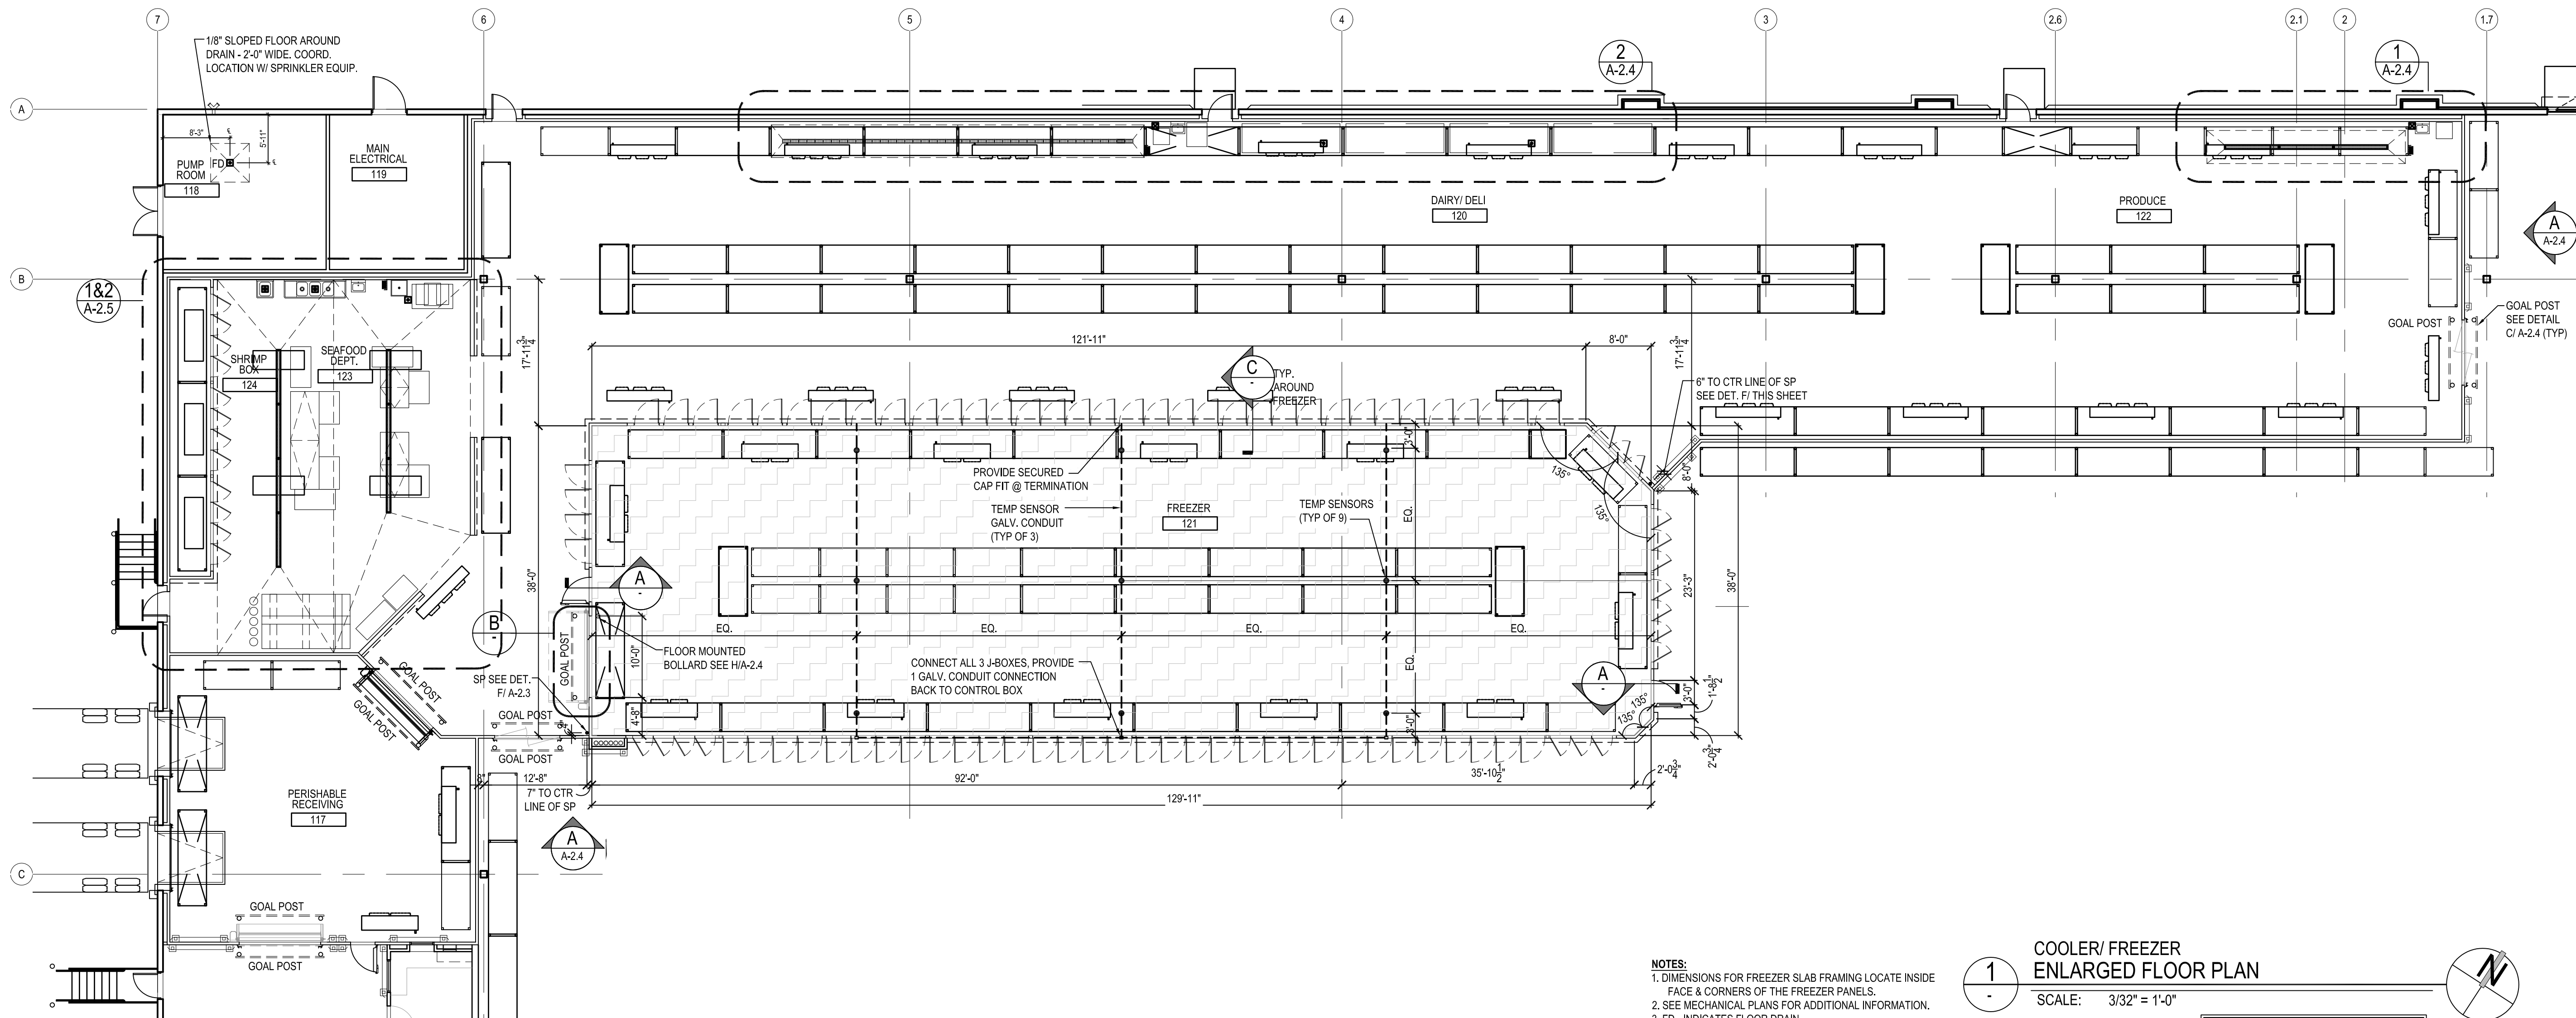

NOTES:
1. DIMENSIONS FOR FREEZER SLAB FRAMING LOCATE INSIDE FACE & CORNERS OF THE FREEZER PANELS.
2. SEE MECHANICAL PLANS FOR ADDITIONAL INFORMATION.
3. FD - INDICATES FLOOR DRAIN.
4. FS - INDICATES FLOOR SINK.
5. SP - INDICATES STAND PIPE.
6. CO - INDICATES CLEAN OUT.
6. HD - INDICATES HUB DRAIN.

1 COOLER/ FREEZER ENLARGED FLOOR PLAN
SCALE: 3/32\"=1'-0"

LEGEND	
	INDICATES FREEZER SLAB. SEE DETAIL C/A-2.3

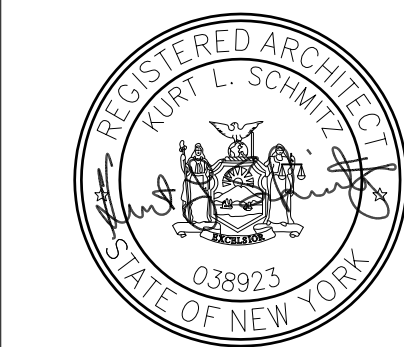

KLS ARCHITECT

Restaurant Depot / BREWSTER, NY

BREWSTER NY 10509
THESE DOCUMENTS CONTAIN INFORMATION PROPRIETARY TO ADA ARCHITECTS, INC.
UNAUTHORIZED USE OF THESE DOCUMENTS IS EXPRESSLY PROHIBITED UNLESS AGREED UPON IN WRITING.

REVISIONS

#	DATE	TYPE
1		
2		
3		
4		
5		
6		
7		
8		
9		
10		

ENLARGED COOLER/ FREEZER PLAN & DETAILS

DATE: 9/10/2020
JOB NO. 19230

A-2.3
SHEET NO.