



KLS
ARCHITECT

Restaurant Depot / BREWSTER, NY

17710 Dancer Avenue
Lakewood, Ohio 44107
Phone (216) 521-5151 • Fax (216) 521-4824 • www.adamarchitects.com

THESE DOCUMENTS CONTAIN INFORMATION PROPRIETARY TO ADA ARCHITECTS, INC.
UNAUTHORIZED USE OF THESE DOCUMENTS IS EXPRESSLY PROHIBITED UNLESS AGREED UPON IN WRITING.


DANBURY ROAD (LOT 48) BLOCK 0002)

REVISIONS


PARTIAL FLOOR
PLANS - PLUMBING

DATE: 9/10/2020
JOB NO. 19230


P4.1
SHEET NO.

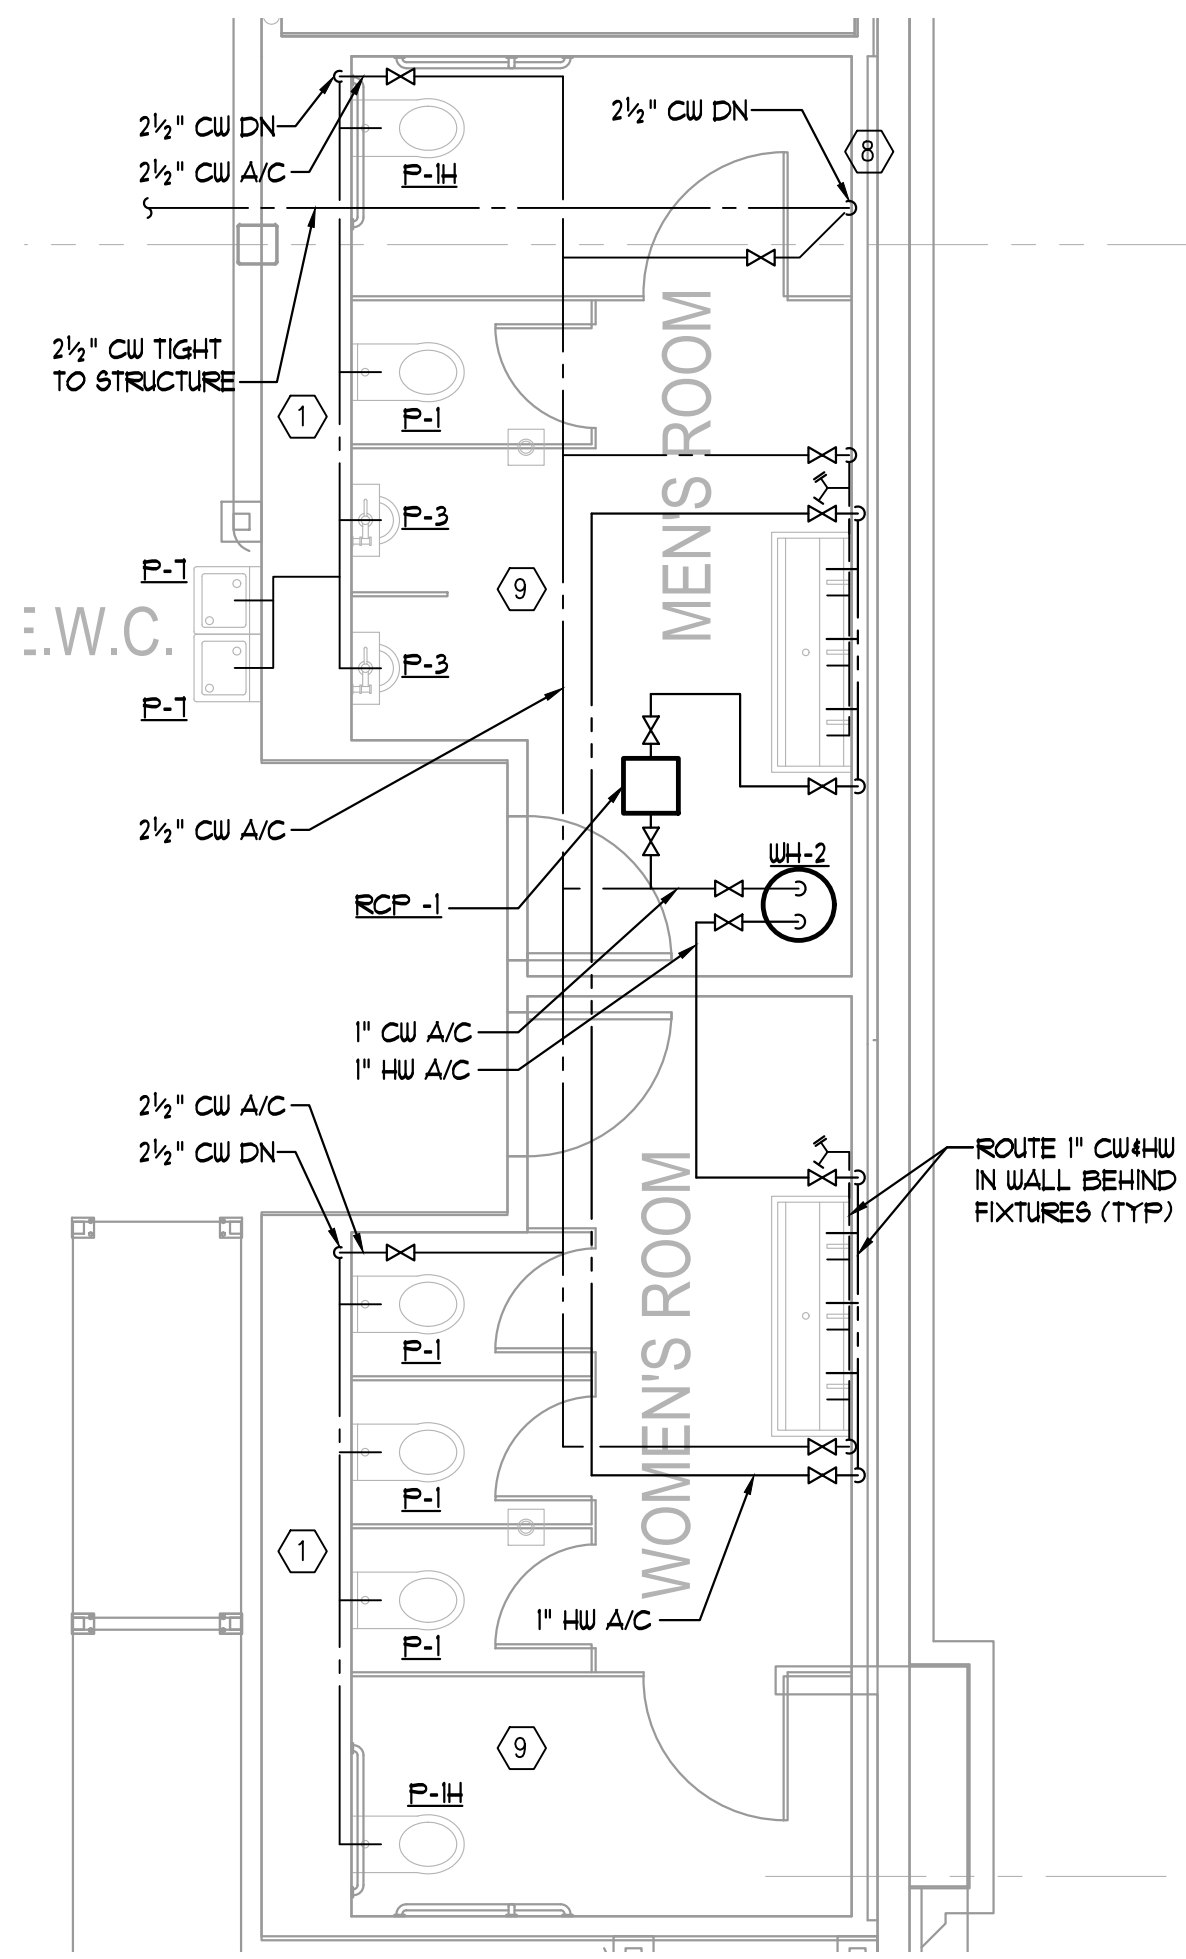


1 PARTIAL FLOOR PLAN - SAN & VENT
P4.1 1/4" = 1'-0"

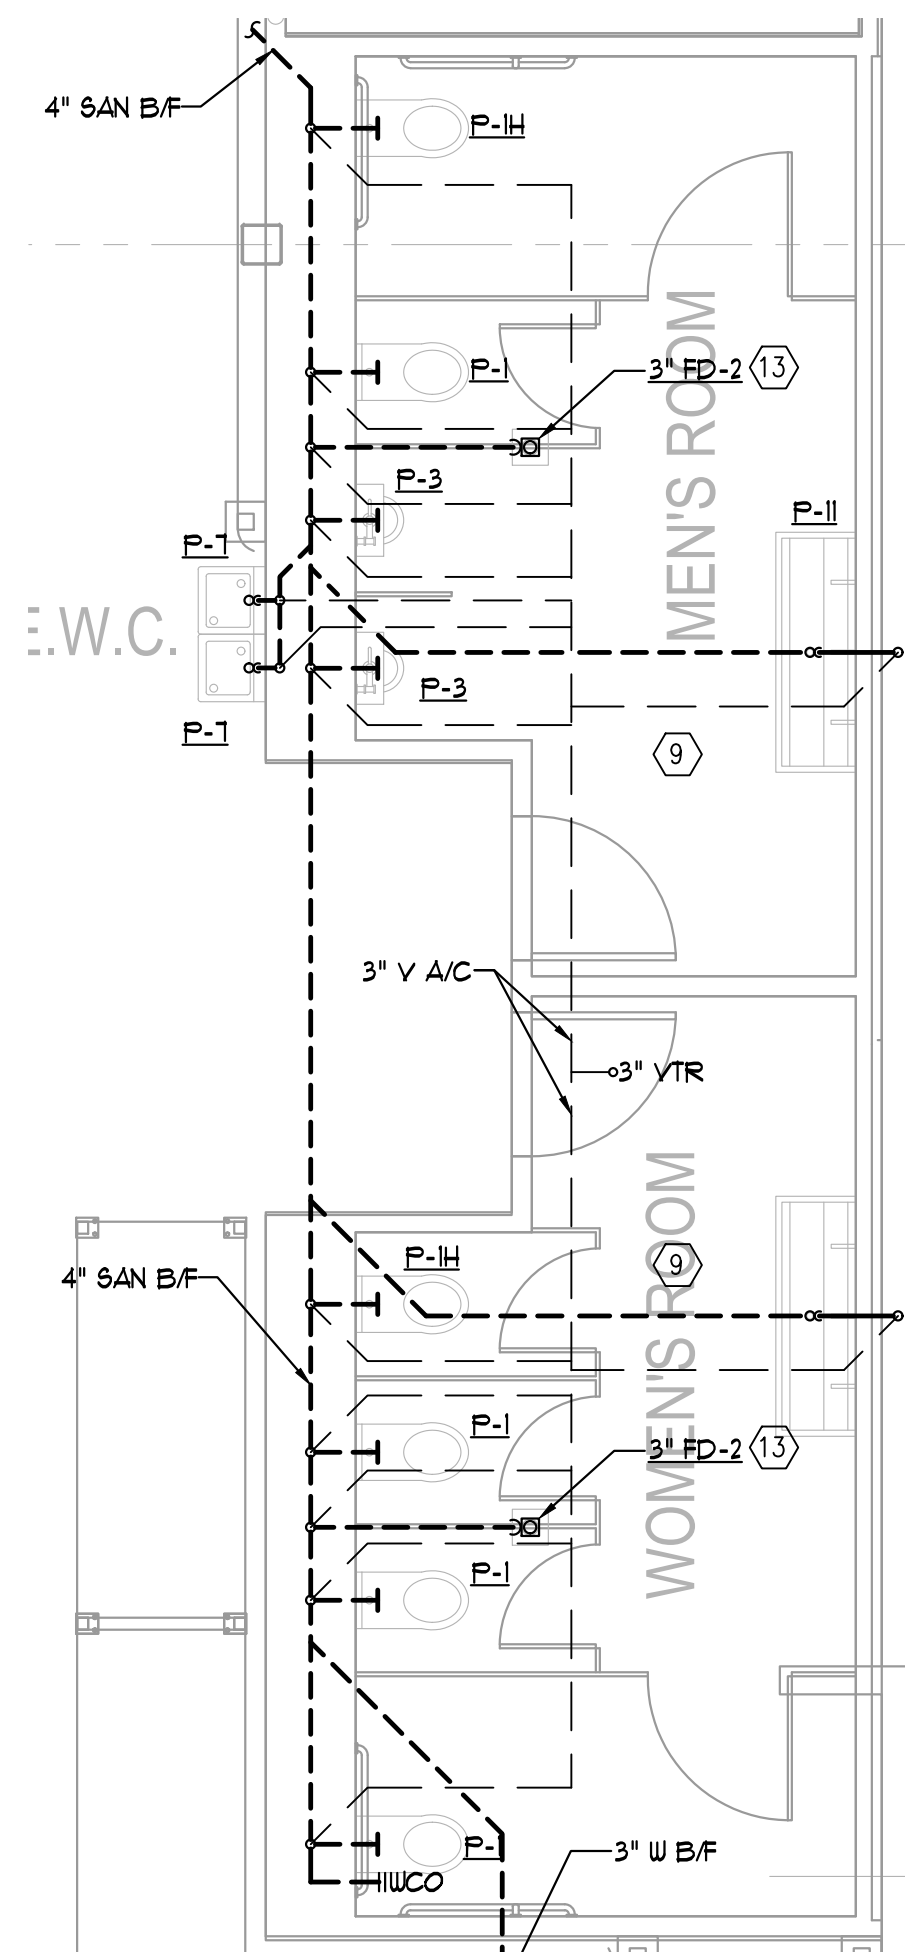


2 PARTIAL FLOOR PLAN - DOMESTIC WATER
P4.1 1/4" = 1'-0"

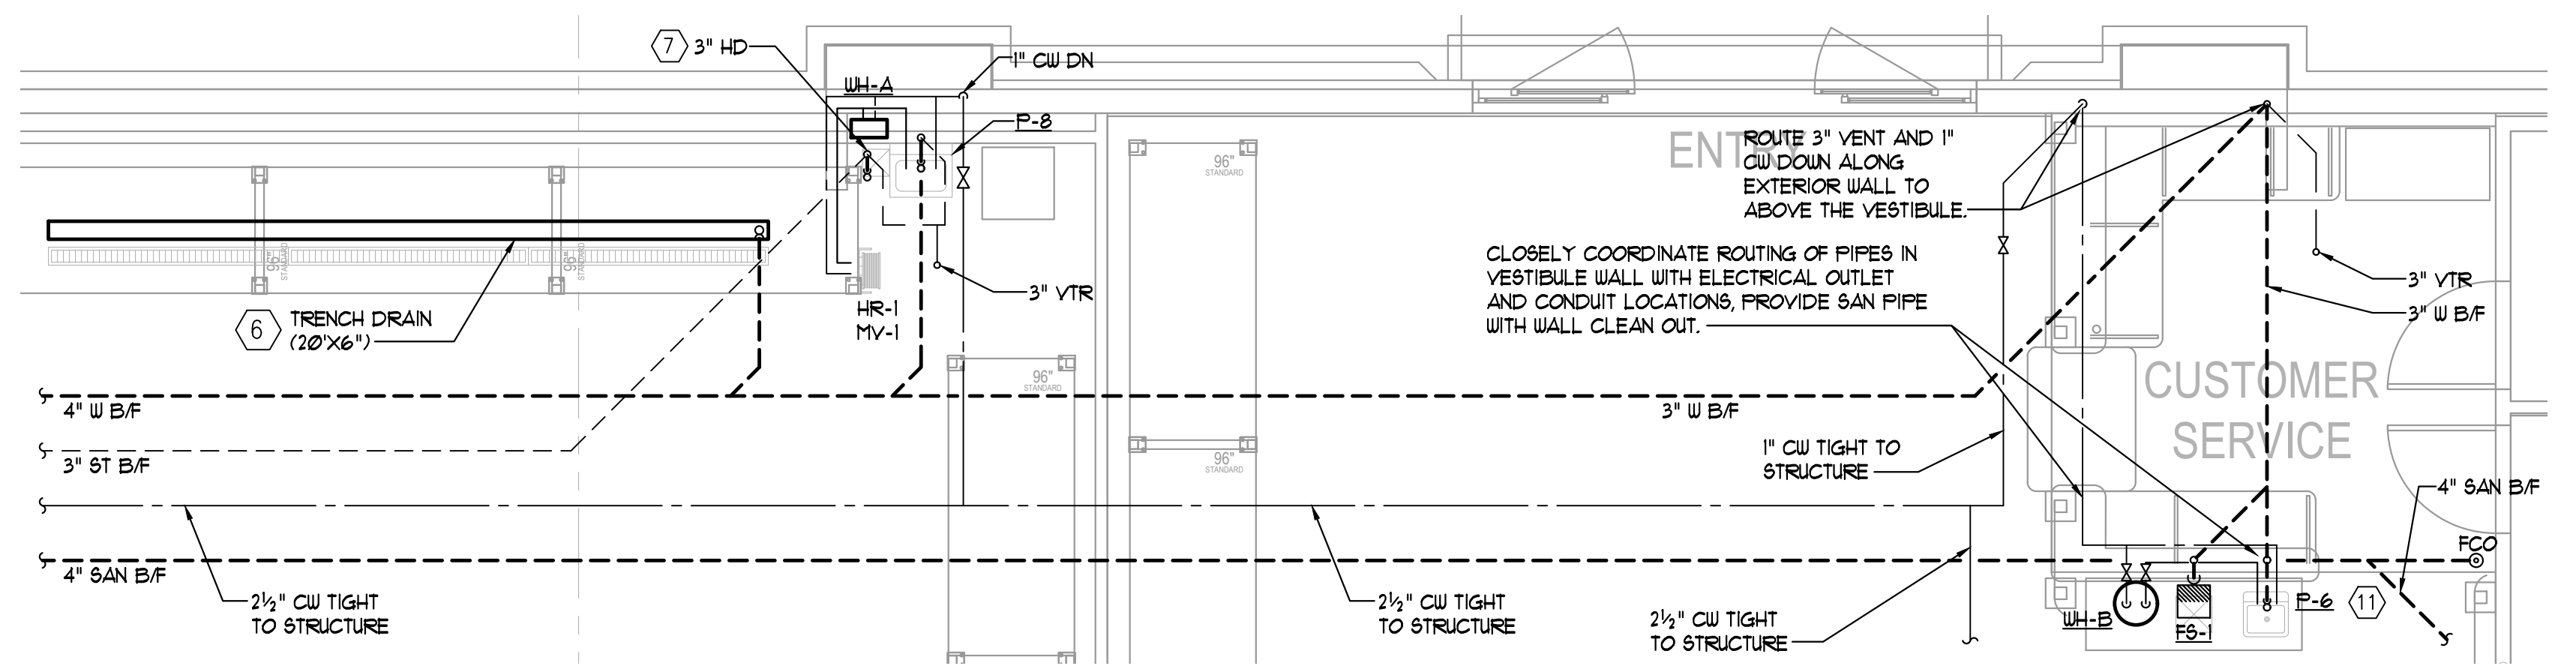


7 PARTIAL FLOOR PLAN - PLUMBING
P4.1 1/4" = 1'-0"

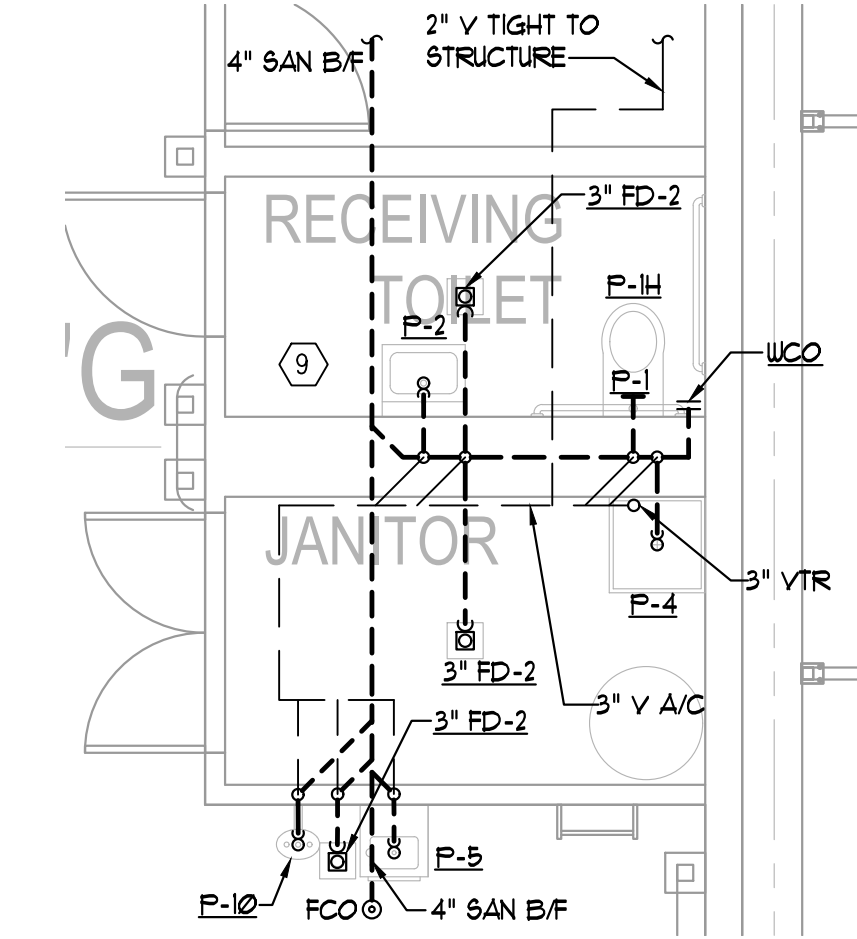


5 PARTIAL FLOOR PLAN - SAN & VENT
P4.1 1/4" = 1'-0"

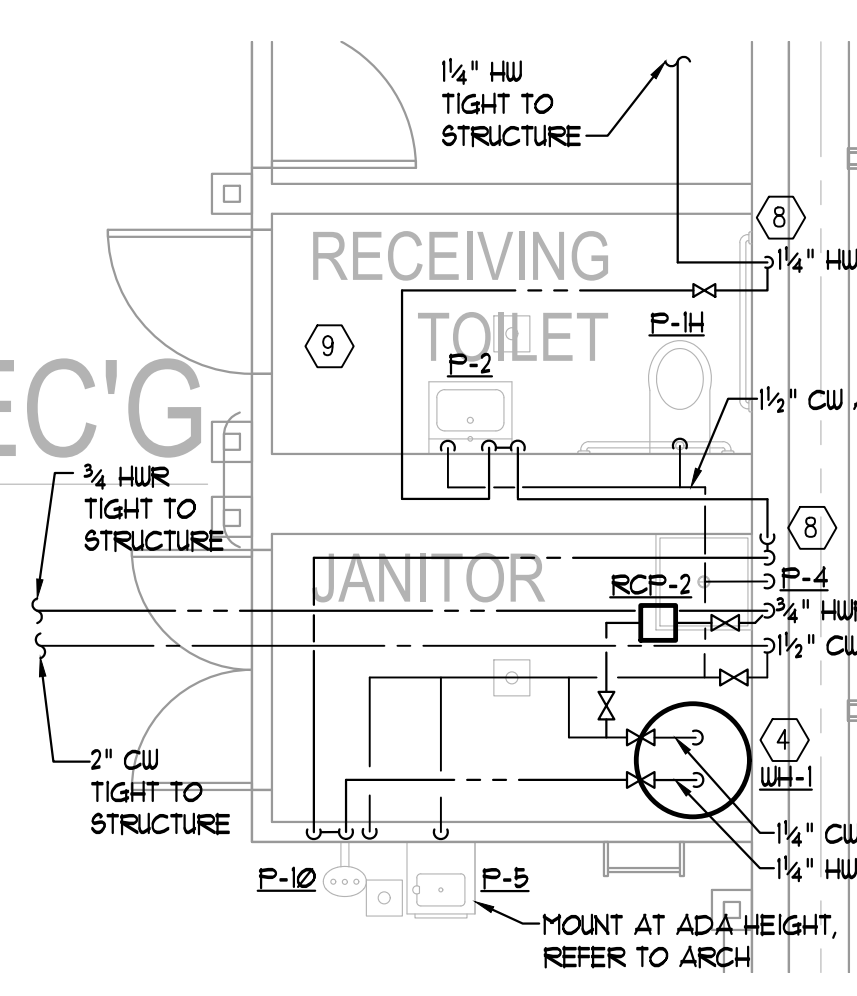


6 PARTIAL FLOOR PLAN - DOMESTIC WATER
P4.1 1/4" = 1'-0"

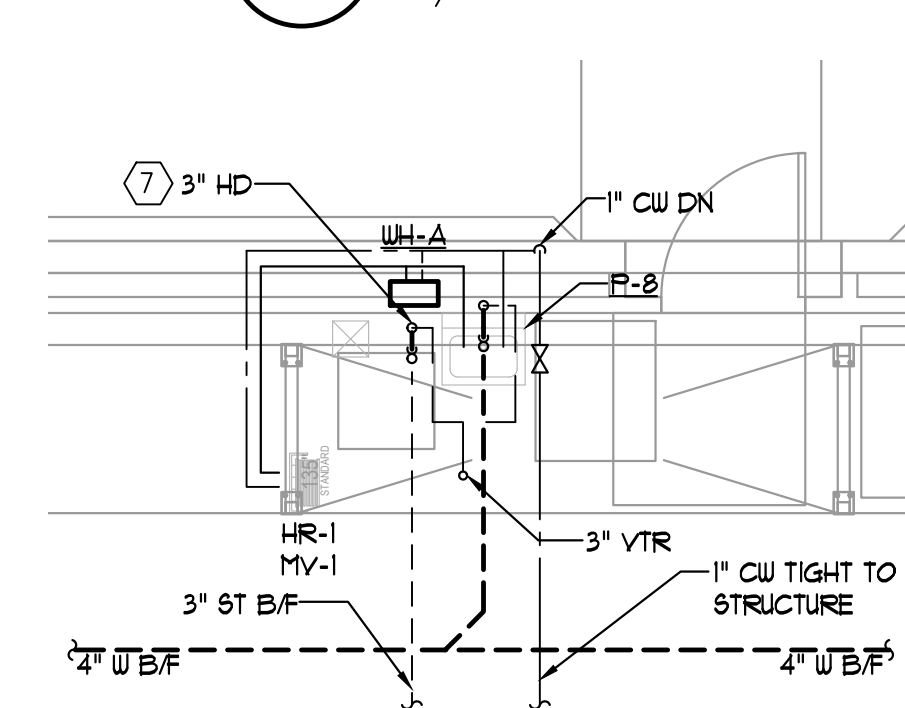


8 PARTIAL FLOOR PLAN - PLUMBING
P4.1 1/4" = 1'-0"

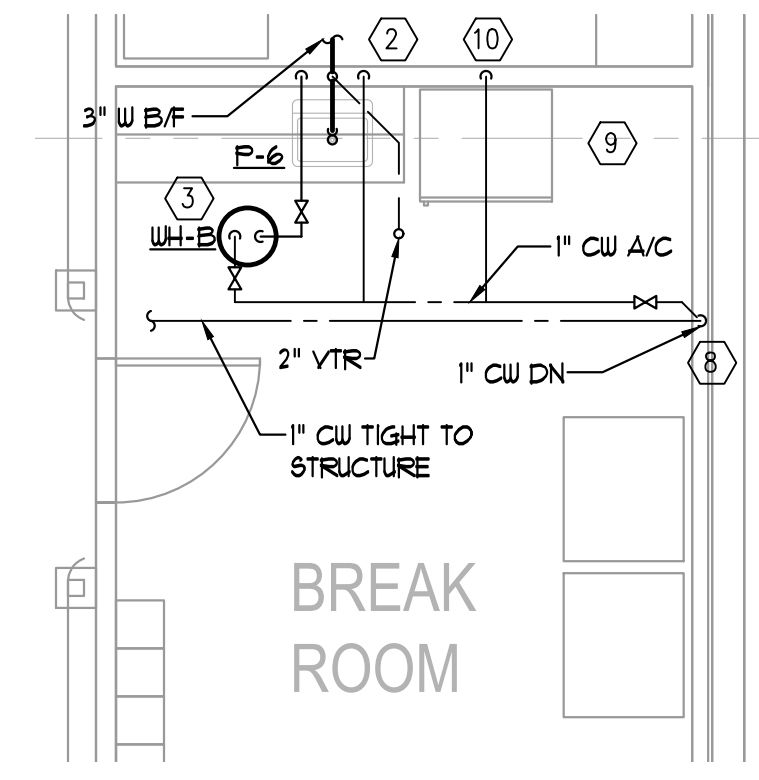

9 PARTIAL FLOOR PLAN - PLUMBING
P4.1 1/4" = 1'-0"

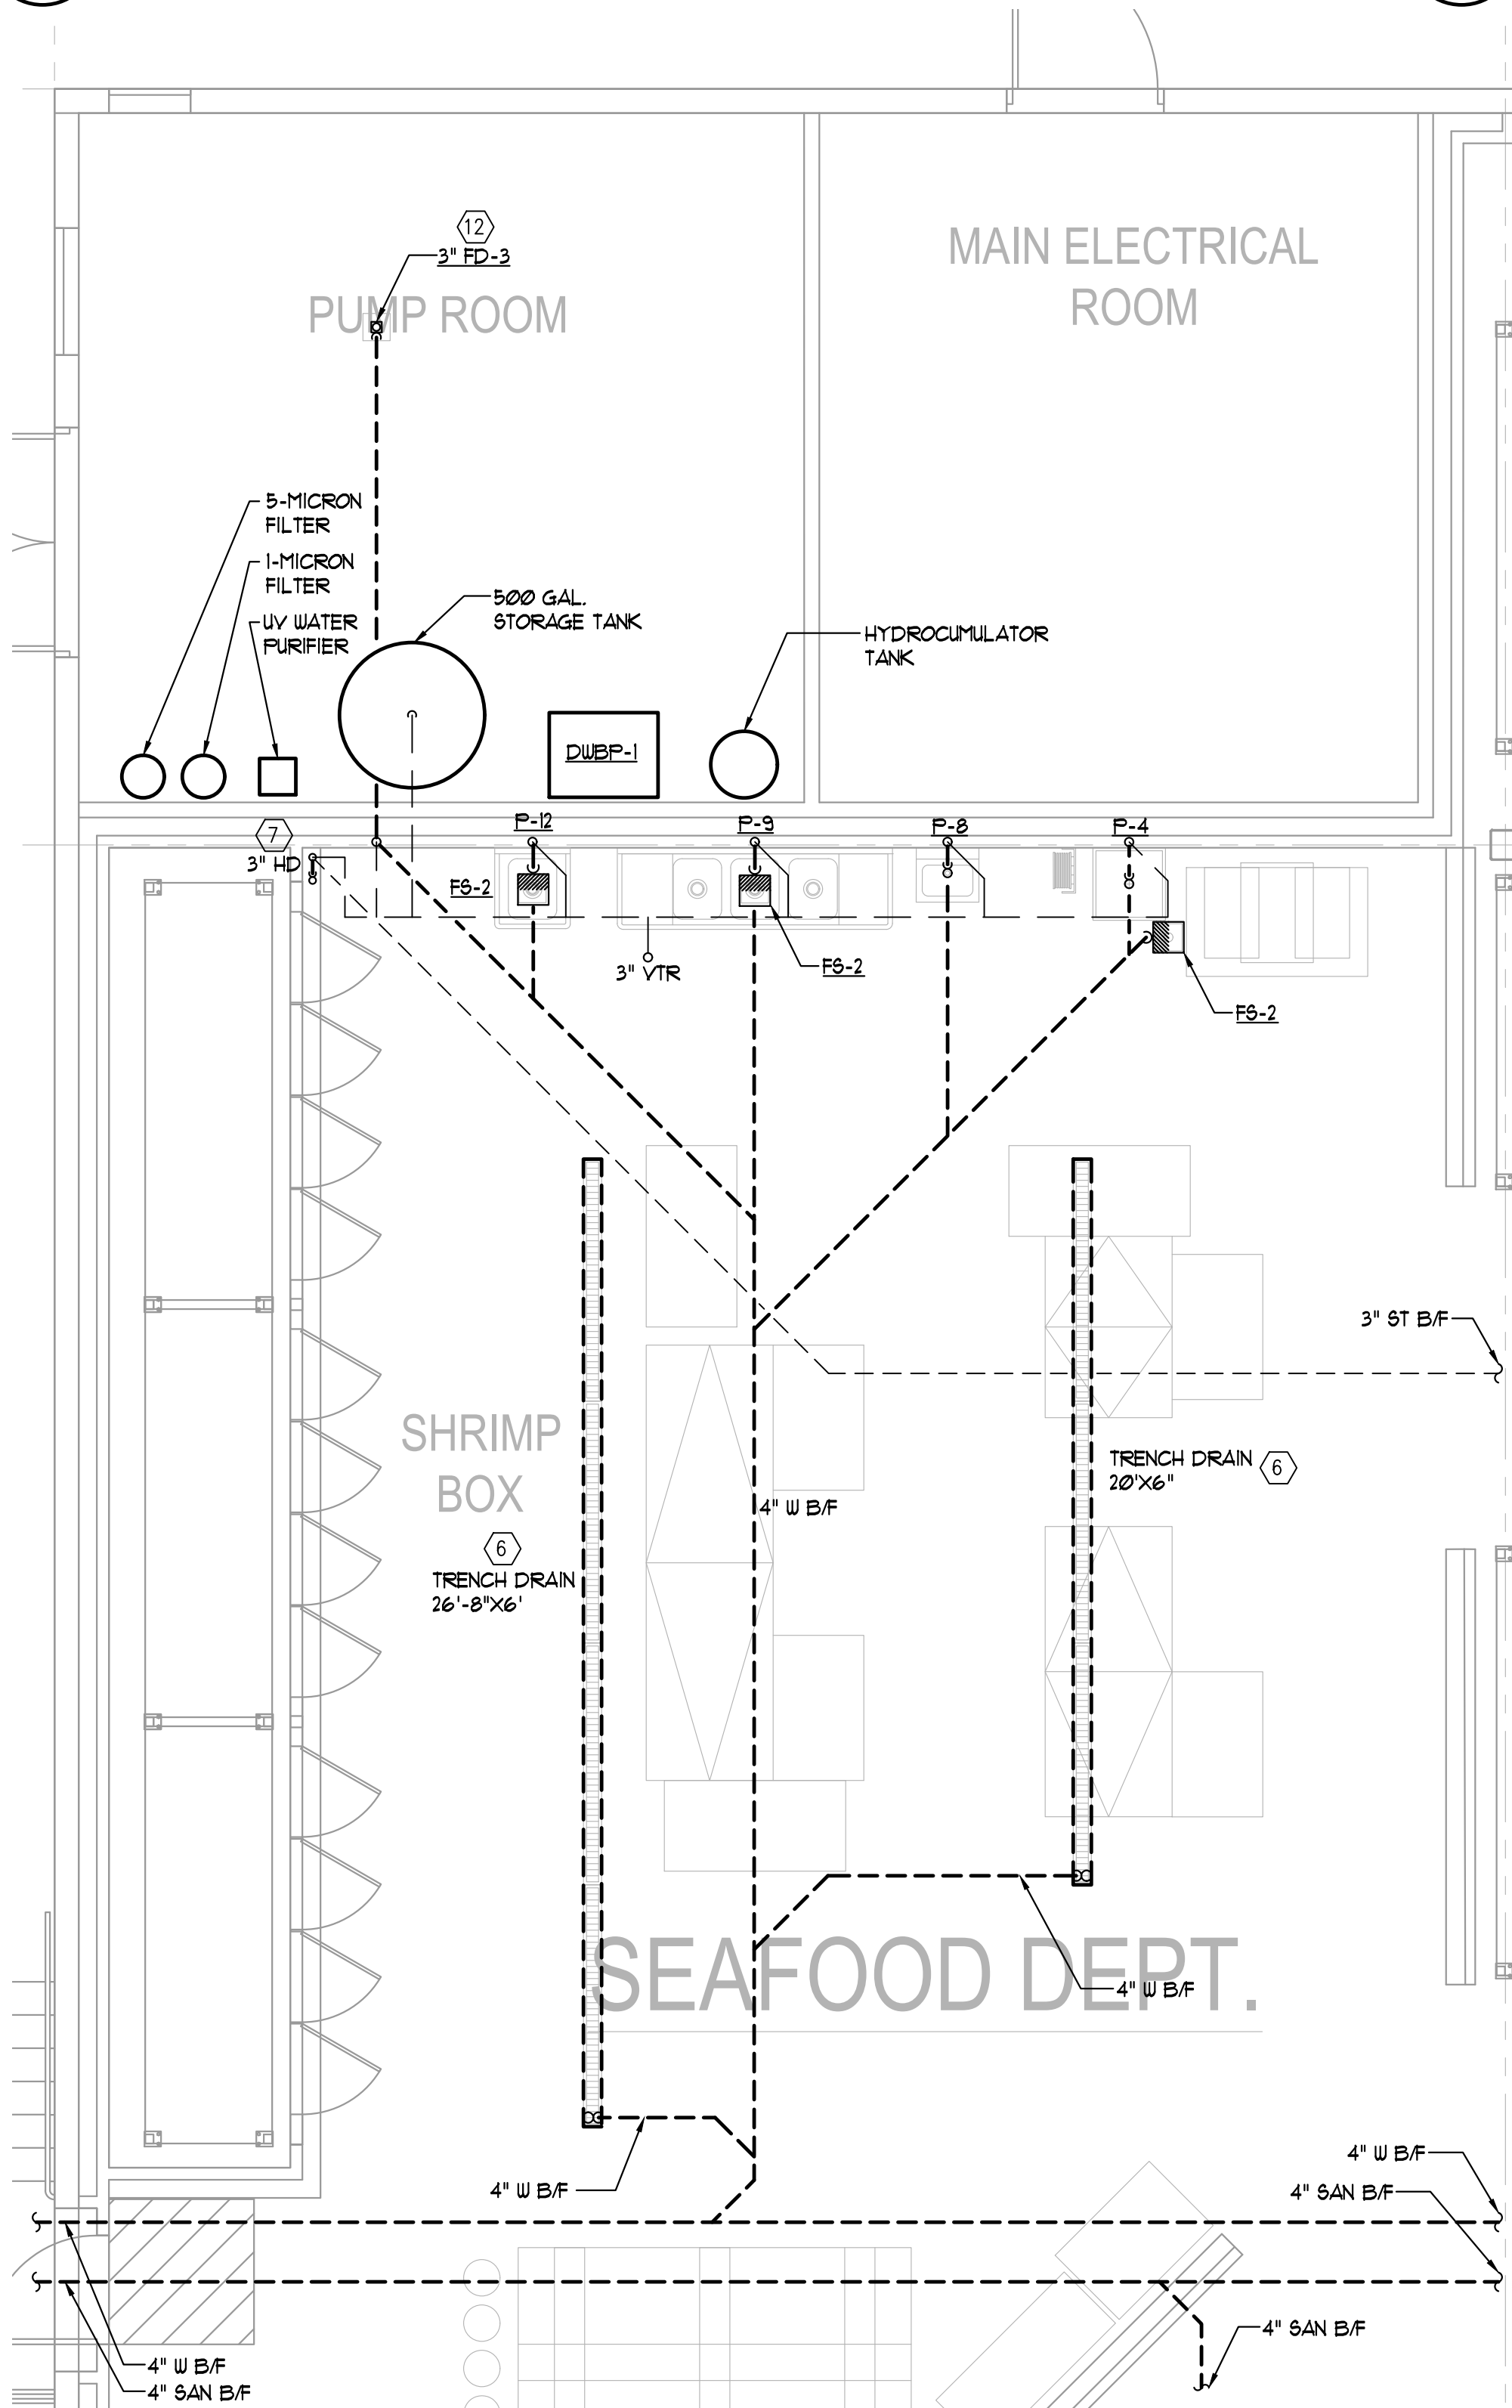

3 PARTIAL FLOOR PLAN - SAN & VENT
P4.1 1/4" = 1'-0"

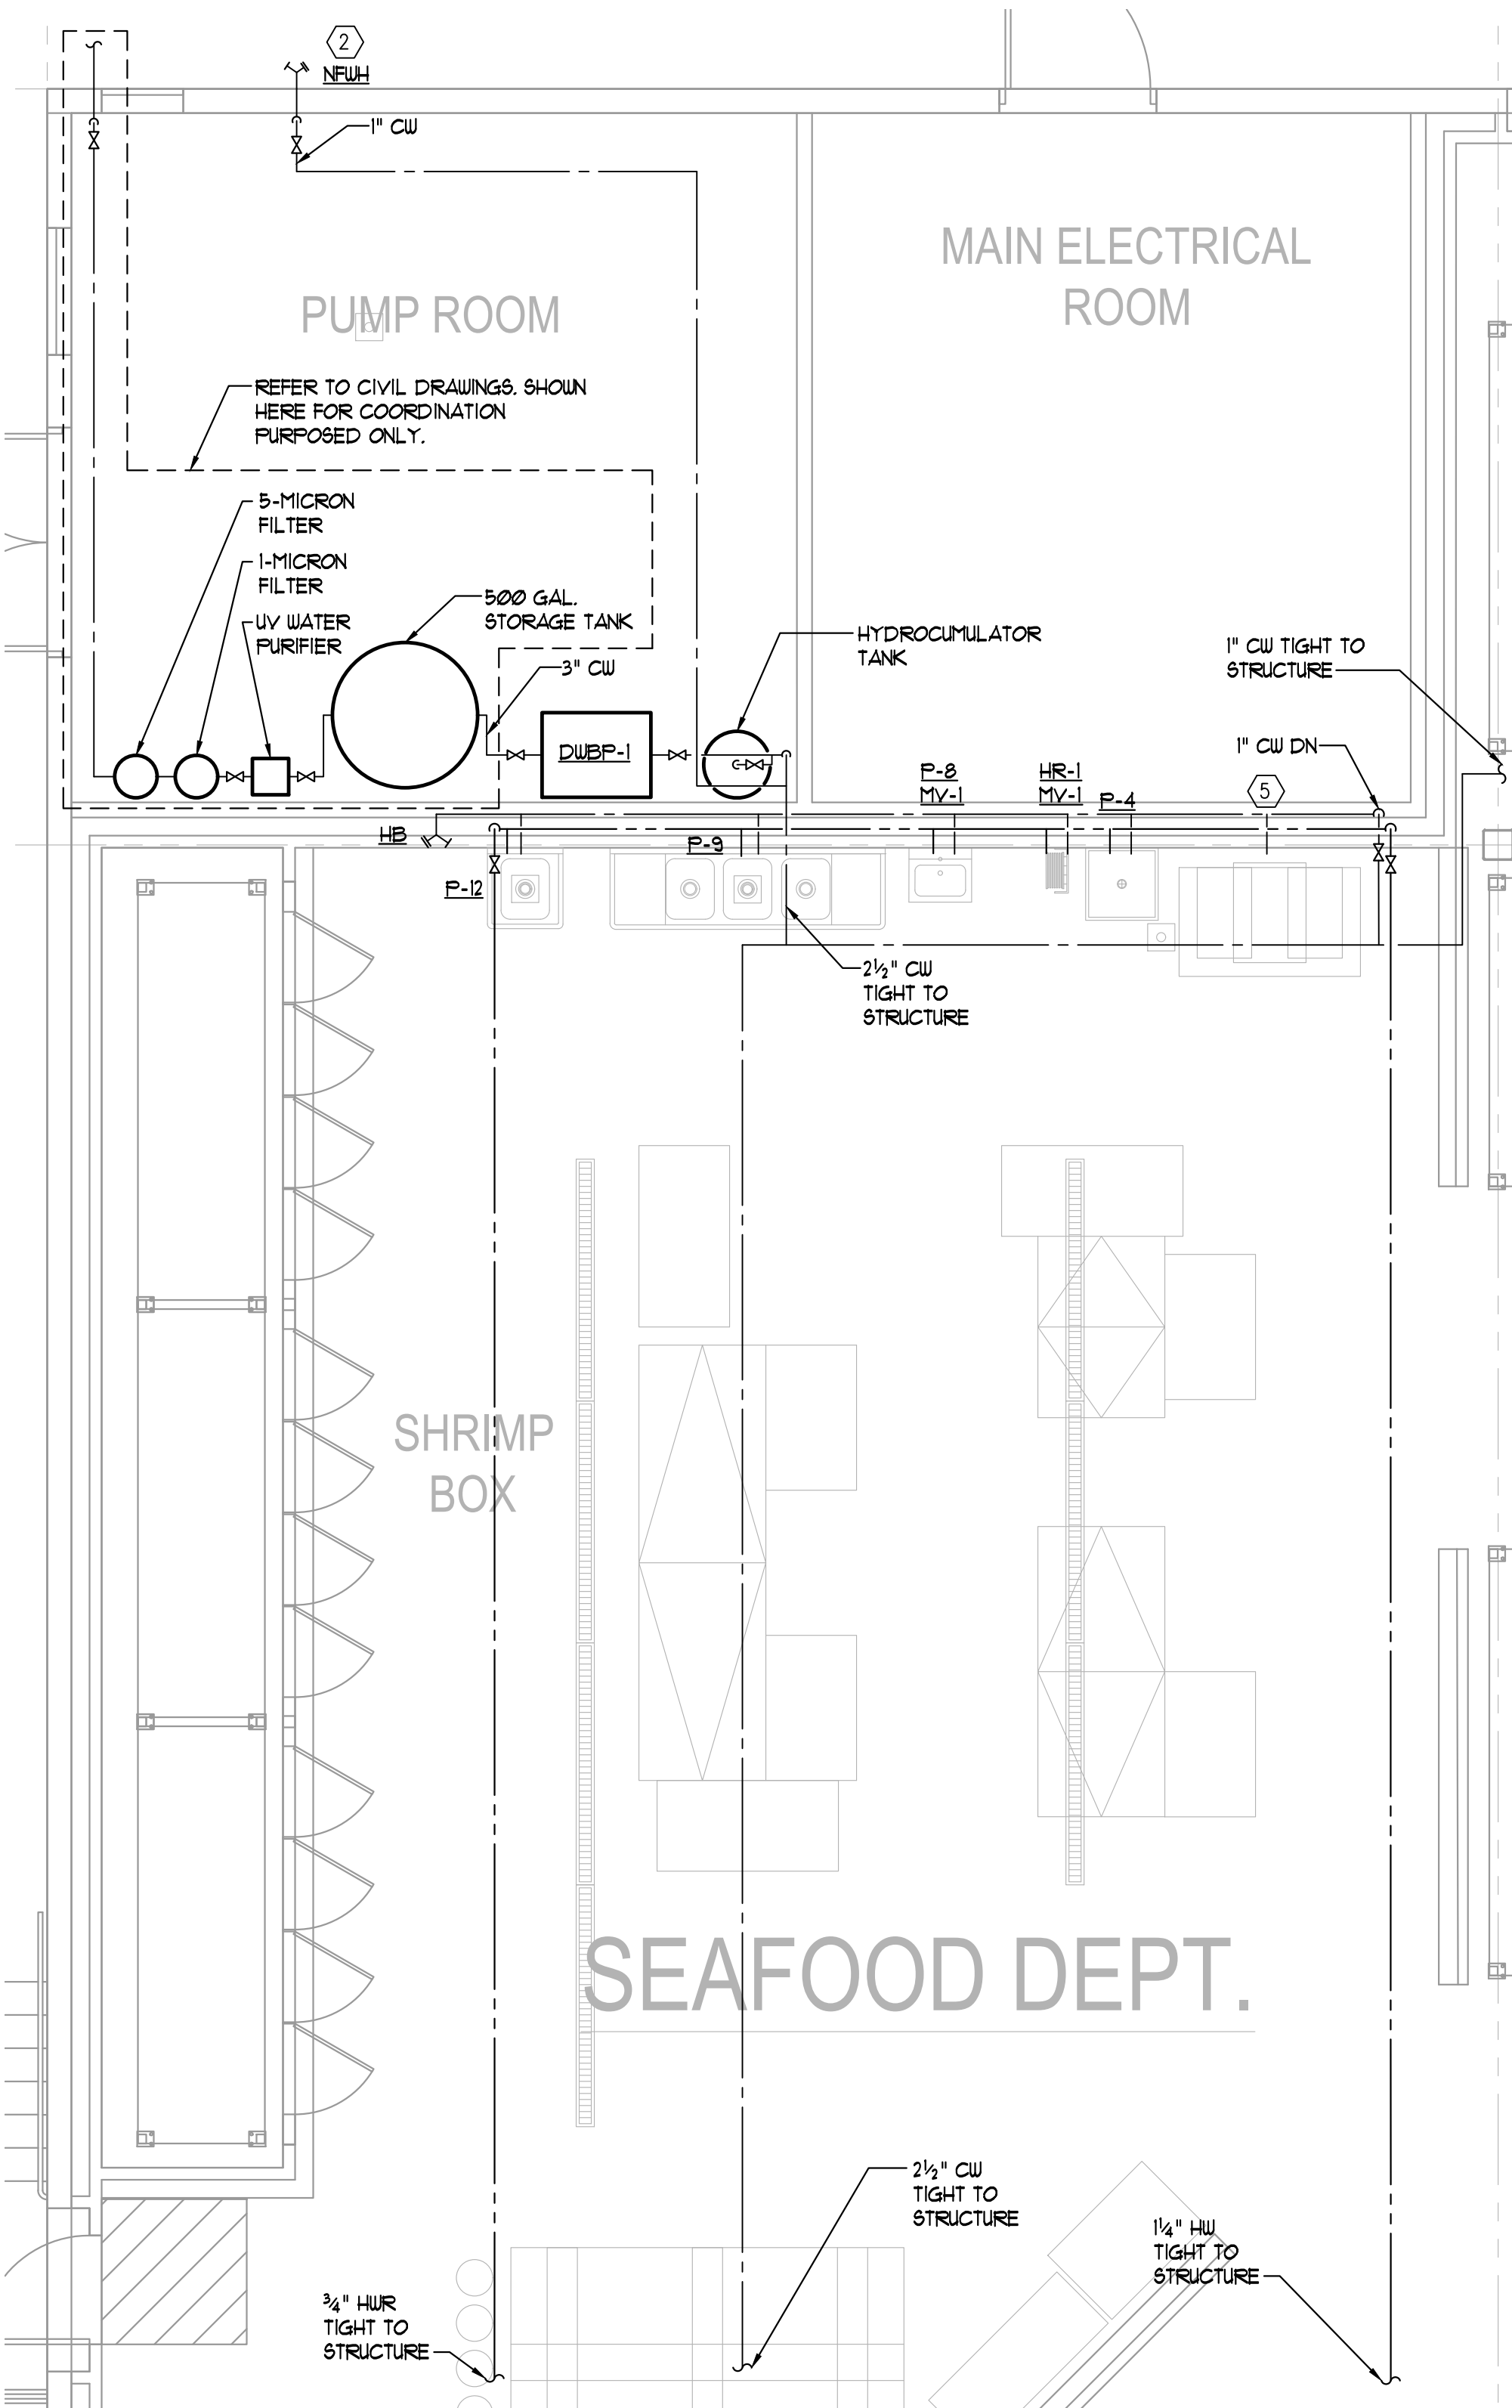

4 PARTIAL FLOOR PLAN - DOMESTIC WATER
P4.1 1/4" = 1'-0"

KEY NOTES
(APPLIES THIS SHEET ONLY)

- 1 WATER LINE SHALL BE RUN WITHIN PLUMBING CHASE.
- 2 REFER TO 1/P7.1 FOR BREAK SINK INSTALLATION DETAIL.
- 3 REFER TO 2/P7.1 FOR WATER HEATER INSTALLATION DETAIL.
- 4 REFER TO 3/P7.1 FOR WATER HEATER INSTALLATION DETAIL.
- 5 PROVIDE 1" CW LINE WITH SHUT-OFF VALVE AND BACK FLOW PREVENTOR (WATTS 007LF) FOR ICE MACHINE. COORDINATE INSTALLATION LOCATION WITH ARCHITECT AND OWNERS REP. REFER TO 4/P7.1.
- 6 COORDINATE THE FINAL LOCATION OF TRENCH DRAIN WITH ARCHITECTURAL.
- 7 PROVIDE A HUB DRAIN EXTENDED ABOVE SLAB FOR CONDENSATE DRAINAGE. PROVIDE A MINIMUM 1" AIR GAP BETWEEN DRAIN AND CONDENSATE PIPING.
- 8 ALL PIPES ROUTED FROM THE RESTROOMS/OFFICE AREA UP TO THE JOISTS SHALL BE ROUTED TIGHT AGAINST THE WALL.
- 9 ROUTE ALL WATER AND VENT PIPING SERVING THE RESTROOM/OFFICE AREA UNDER THE PLYWOOD CAP.
- 10 PROVIDE 1" CW LINE WITH SHUT-OFF VALVE AND BACK FLOW PREVENTOR (WATTS 007LF) FOR OWNER PROVIDED EQUIPMENT. COORDINATE INSTALLATION LOCATION WITH ARCHITECT AND OWNERS REP.
- 11 PROVIDE 1/2" CW LINE WITH WATTS SD-3 BFP & SHUT-OFF VALVE FOR COFFEE MAKER. COORDINATE INSTALLATION LOCATION WITH ARCHITECT AND OWNERS REP. PLUMBING CONTRACTOR SHALL MAKE FINAL CONNECTION TO COFFEE MAKER.
- 12 CLOSELY COORDINATE THE FINAL LOCATION OF THE FLOOR DRAIN WITH THE FIRE PROTECTION SUB. FLOOR DRAINS SHALL NOT BE LOCATED UNDER FIRE PROTECTION EQUIPMENT.