


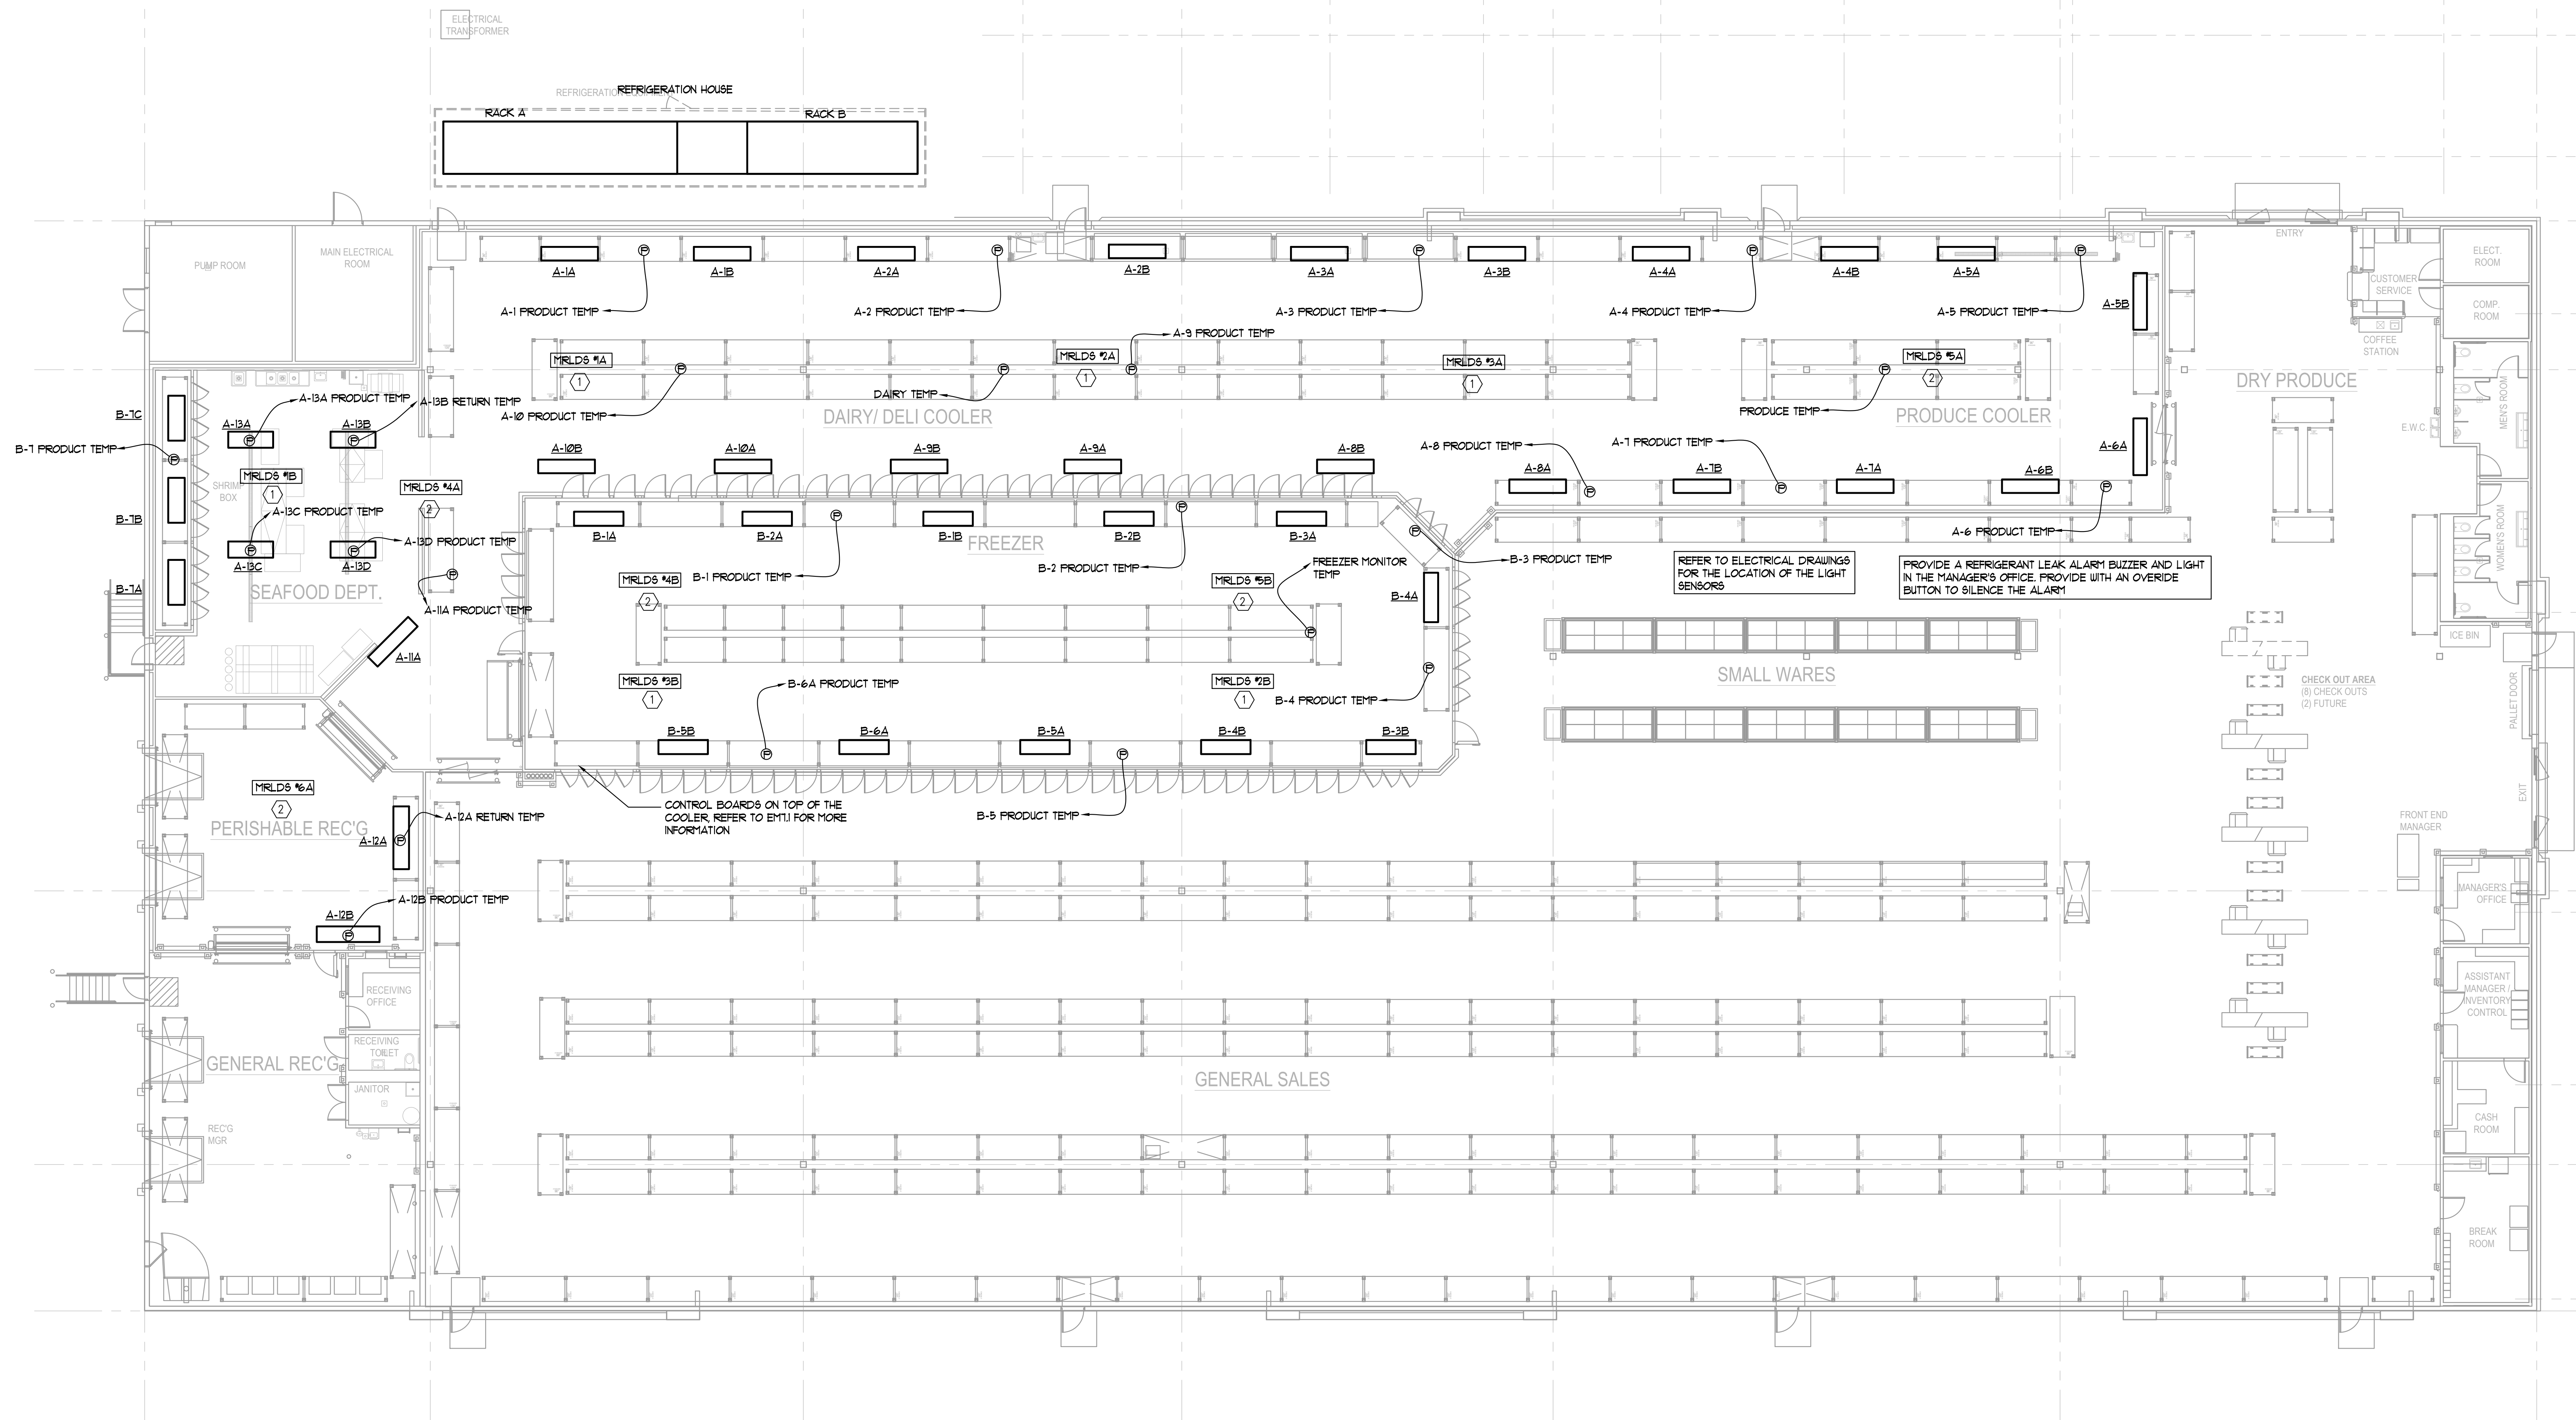

1 FLOOR PLAN – REFRIGERATION SENSOR LOCATIONS
R1.2 3/32" = 1'-0"

GENERAL NOTES
(APPLIES TO ALL SHEETS)
1. COORDINATE THE FINAL LOCATION OF ALL SENSORS WITH THE RACKING MANUFACTURER AND OWNER'S REP.

KEY NOTES
(APPLIES THIS SHEET ONLY)
1. MODULAR REFRIGERANT LEAK DETECTOR SENSOR (MRLDS) LOCATED ON TOP OF FREEZER/COOLER. LOCATE UNDER REFRIGERANT LINES, FIELD COORDINATE EXACT LOCATION. INSTALL PER MANUFACTURER'S RECOMMENDATIONS.
2. MODULAR REFRIGERANT LEAK DETECTOR SENSOR (MRLDS) IN THE FREEZER/COOLER. INSTALL APPROXIMATELY 18" BELOW THE CEILING. FIELD COORDINATE EXACT LOCATION. INSTALL PER MANUFACTURER'S RECOMMENDATIONS.



KLS
ARCHITECT

Restaurant Depot / BREWSTER, NY

DANBURY ROAD LOT 48 | BLOCK 0002 | BREWSTER NY 10509

17710 Dairland Avenue | Lakewood, Ohio 44107
Phone (216) 521-5151 • Fax (216) 521-4824 • www.klsarchitects.com

THESE DOCUMENTS CONTAIN INFORMATION PROPRIETARY TO KLS ARCHITECTS, INC.
UNAUTHORIZED USE OF THESE DOCUMENTS IS EXPRESSLY PROHIBITED UNLESS AGREED UPON IN WRITING.

REVISIONS

#	DATE	TYPE
1		
2		
3		
4		
5		
6		
7		
8		
9		
10		

FLOOR PLAN -
REFRIGERATION
SENSOR LOCATIONS

DATE: 9/10/2020
JOB NO. 19230

R1.2
SHEET NO.