




13 SERVICE GROUND
E500 NOT TO SCALE

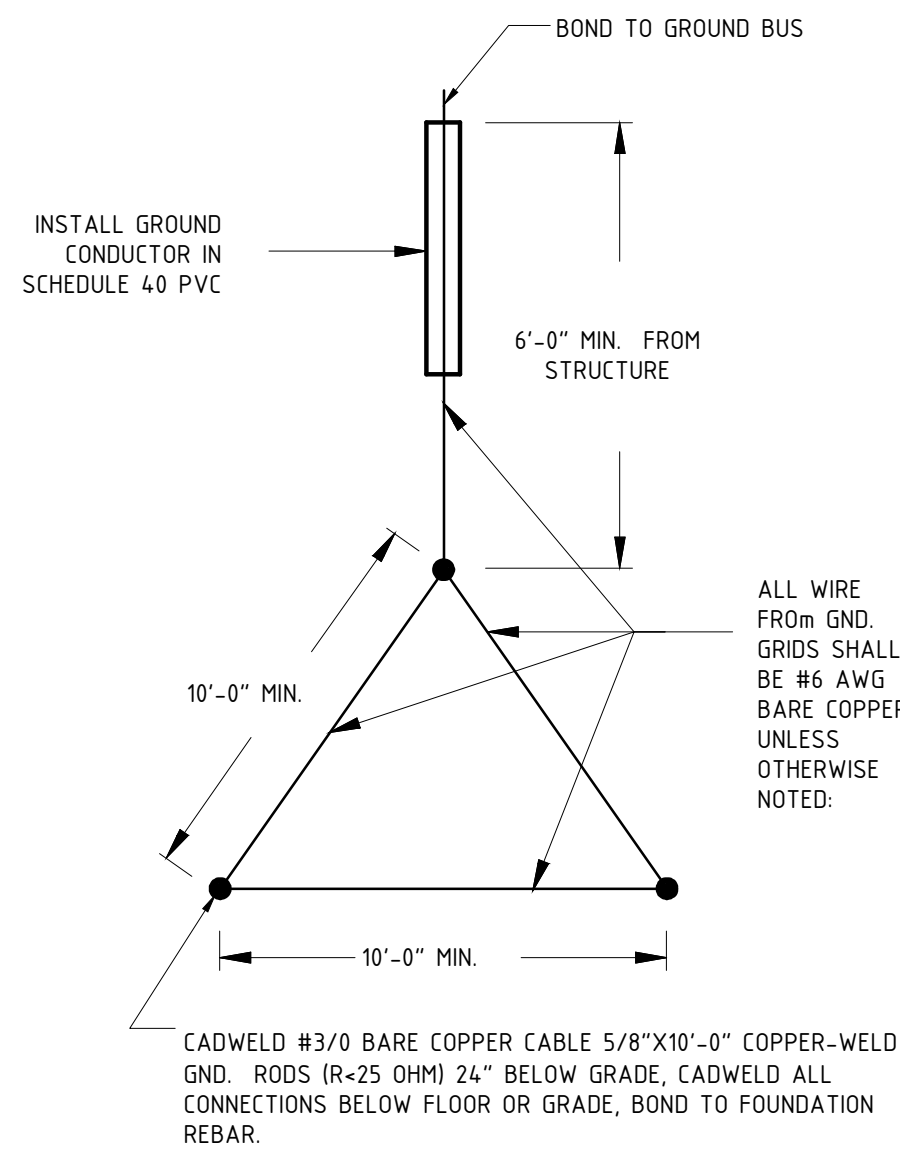


13 SERVICE GROUND
E500 NOT TO SCALE

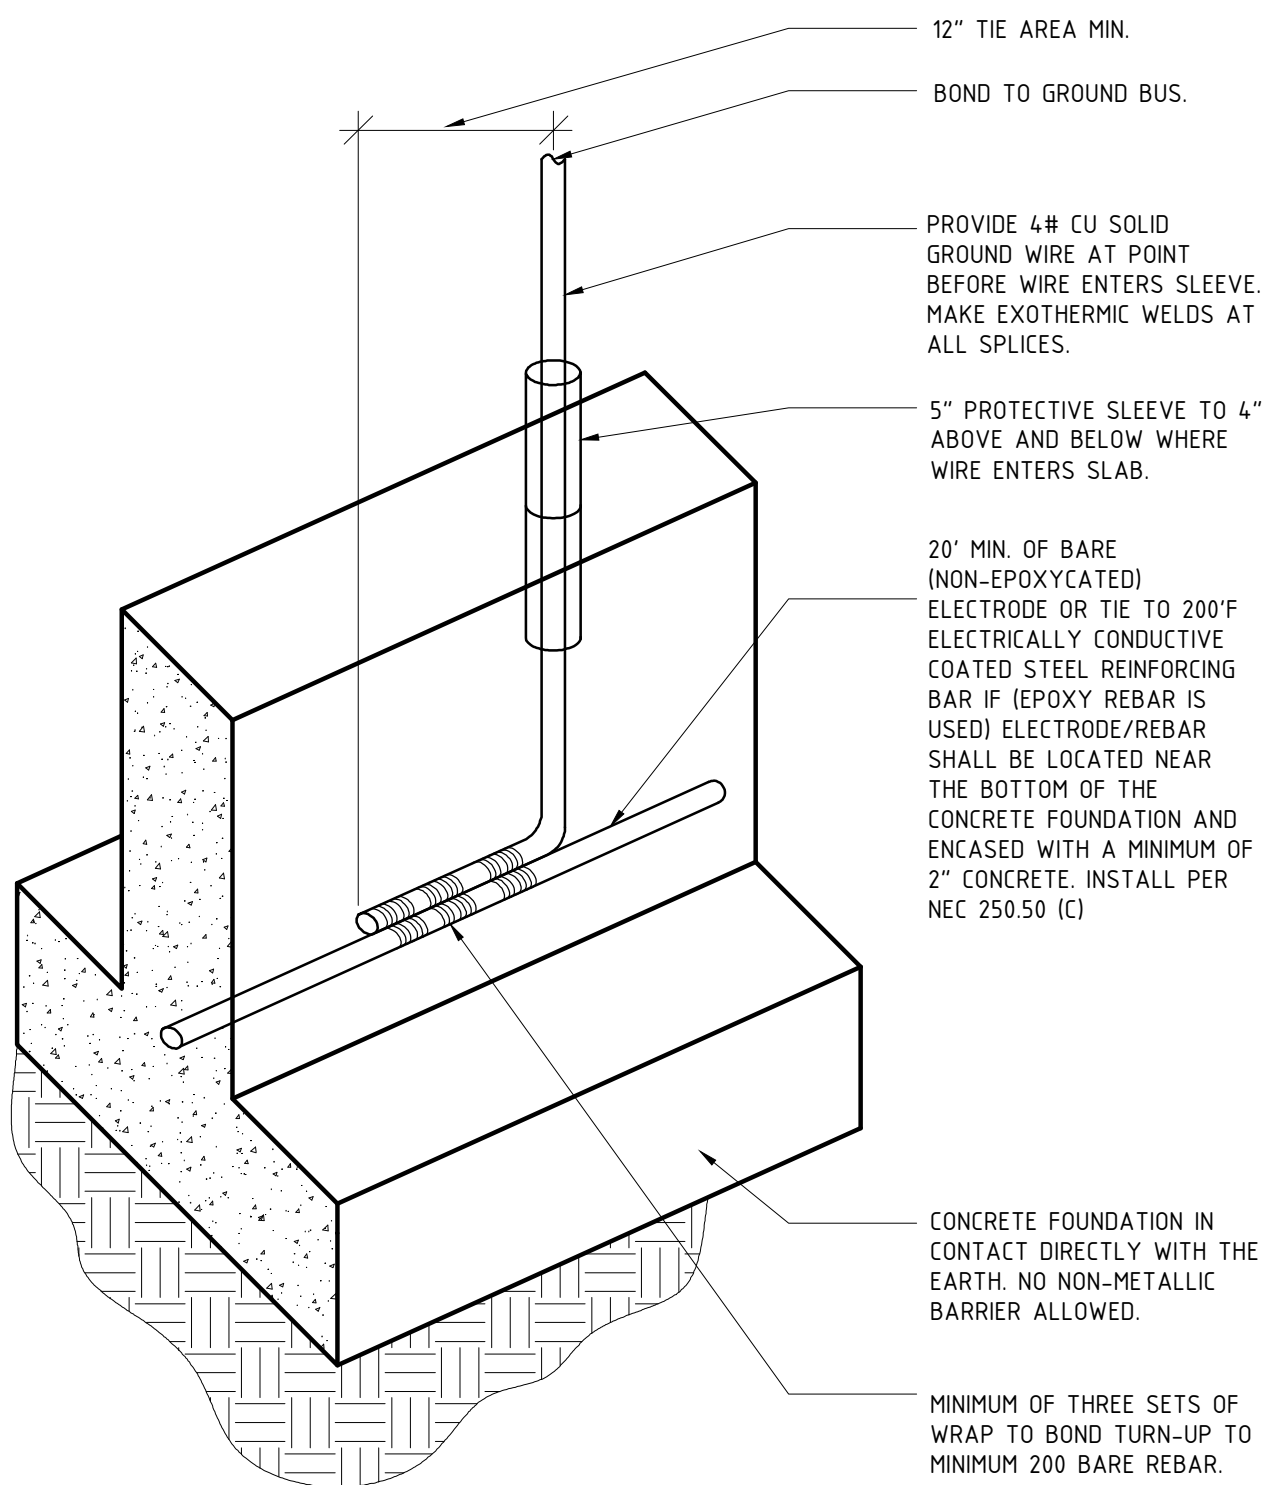


14
E500

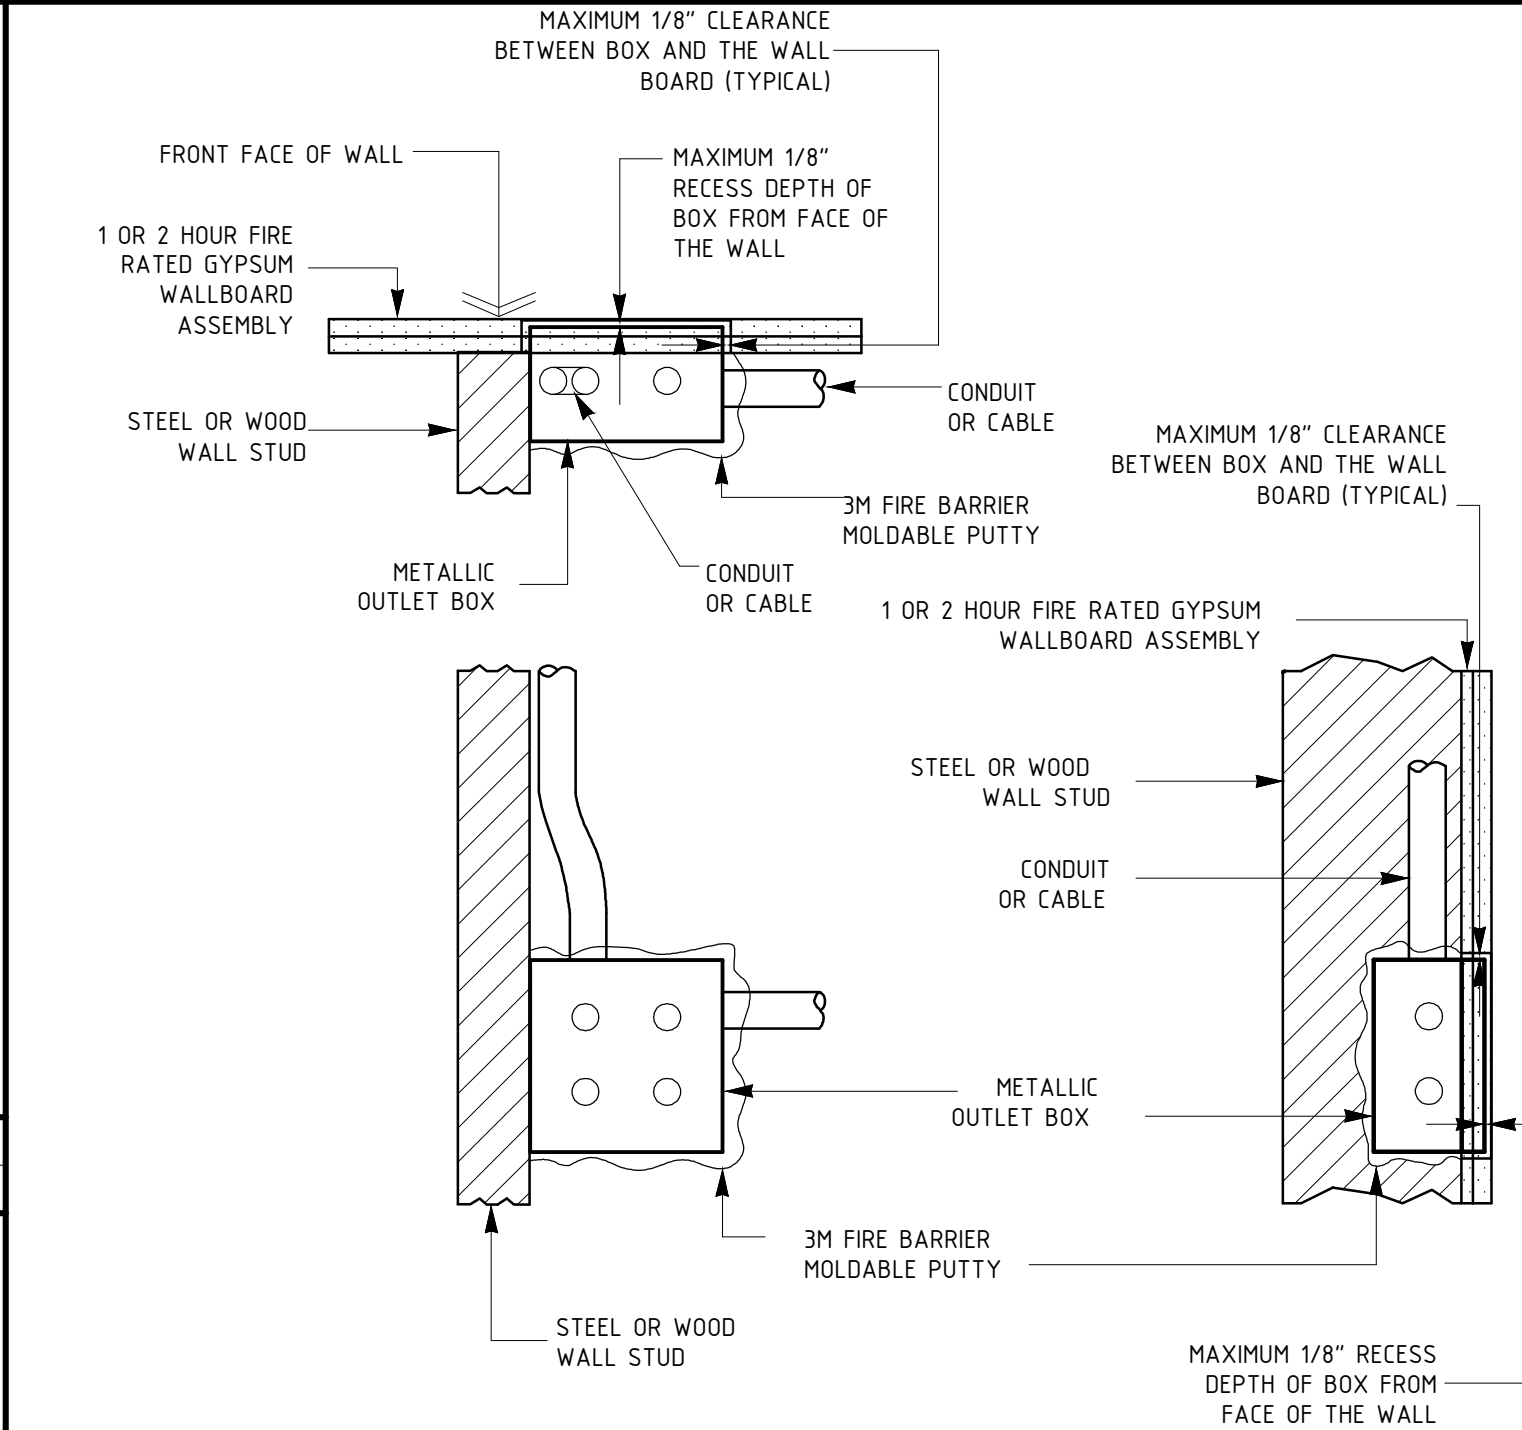

21 DEVICE BOX DETAIL 1
E500 NOT TO SCALE

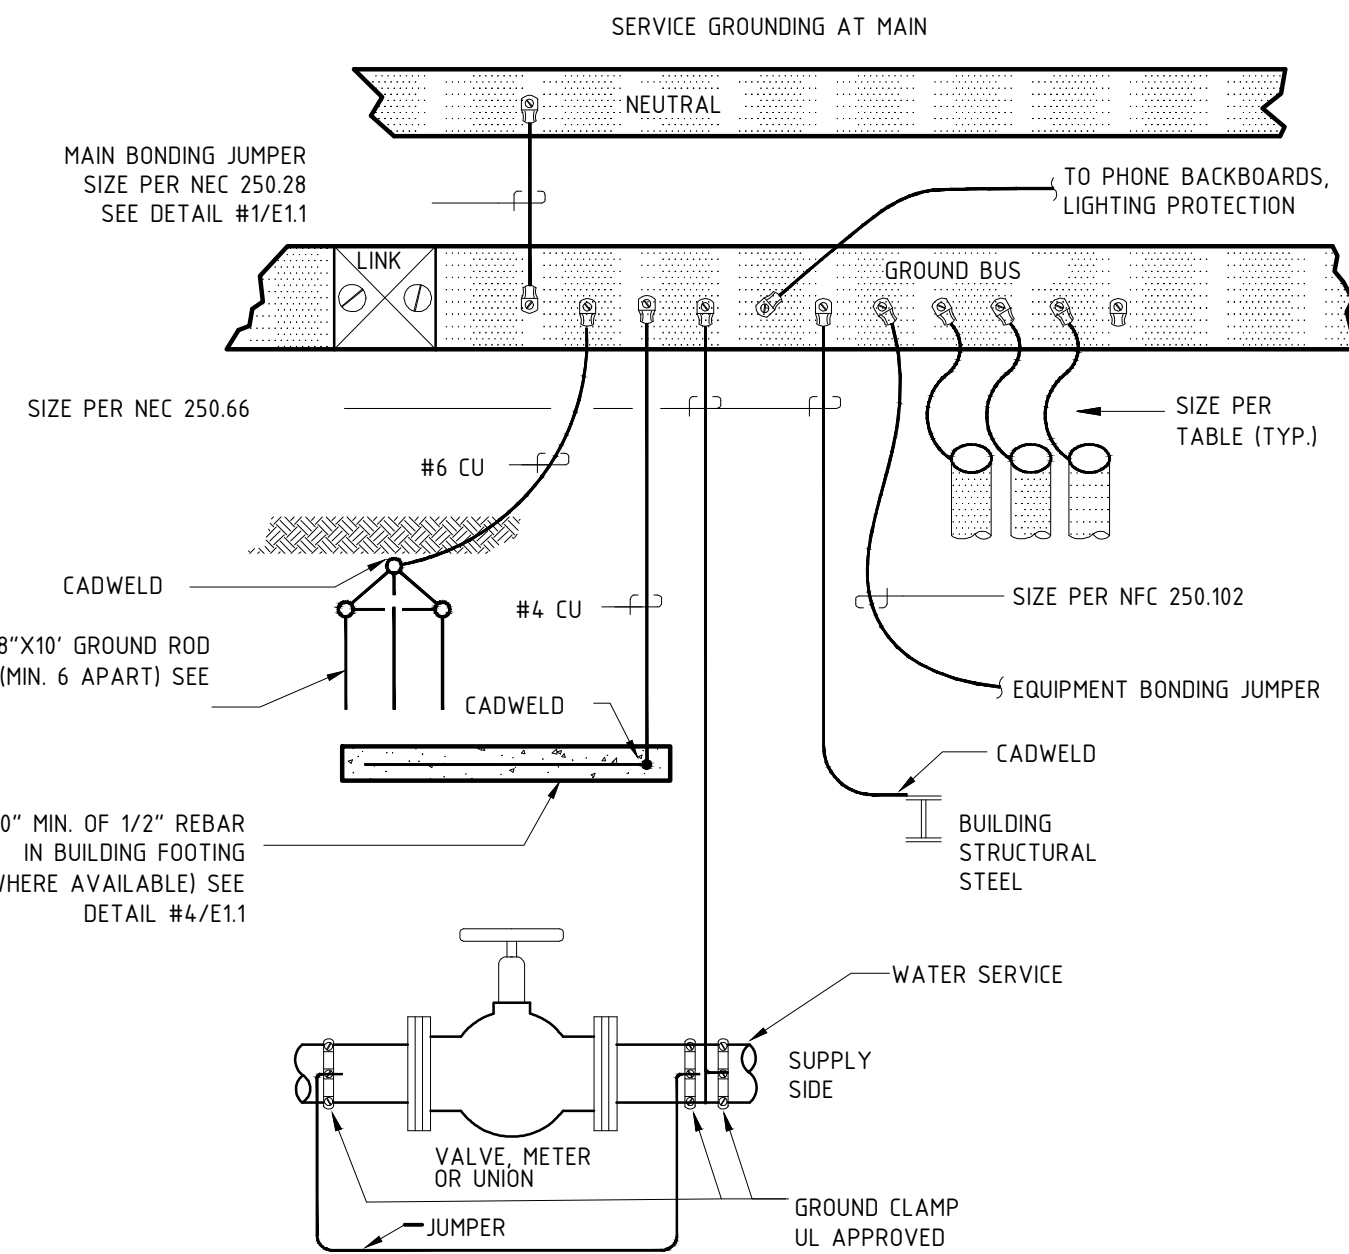


23 SERVICE GROUND CONNECTIONS
E500 NOT TO SCALE

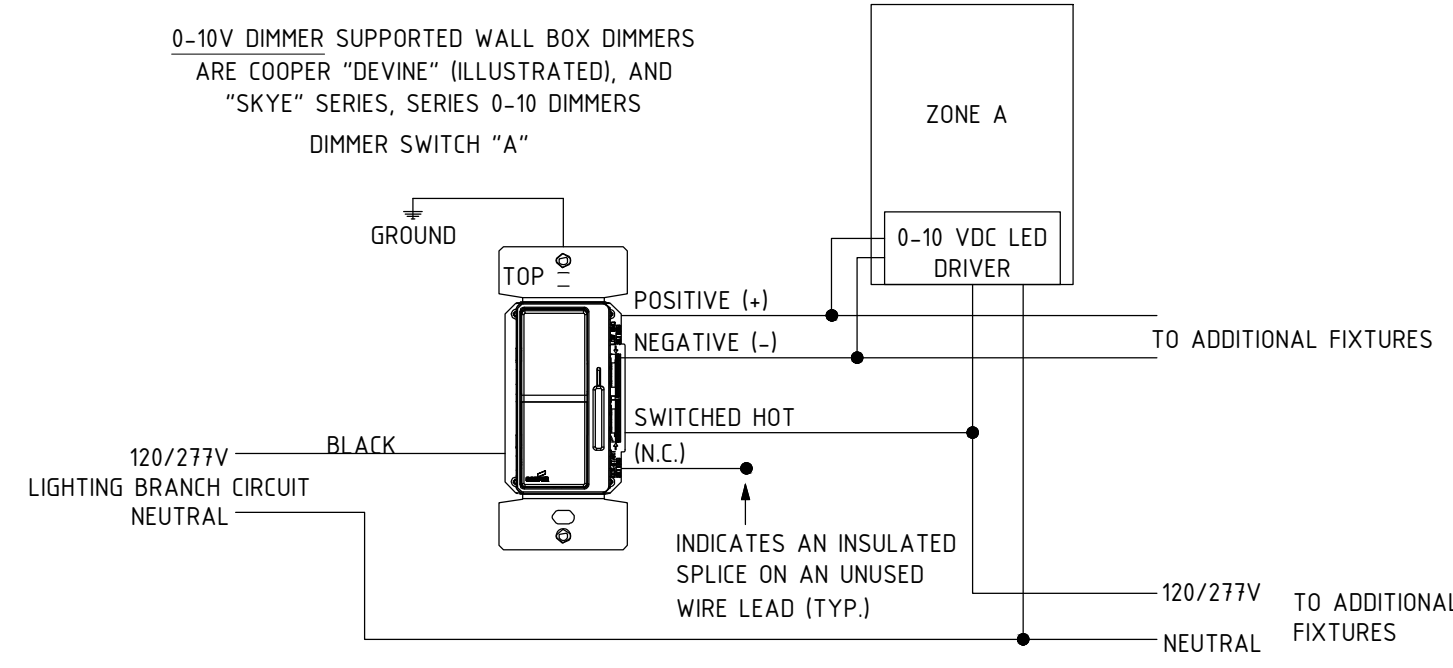


NOTE: ZONE B SIMILAR


24 10V DIMMER CONTROLS
E500 NOT TO SCALE

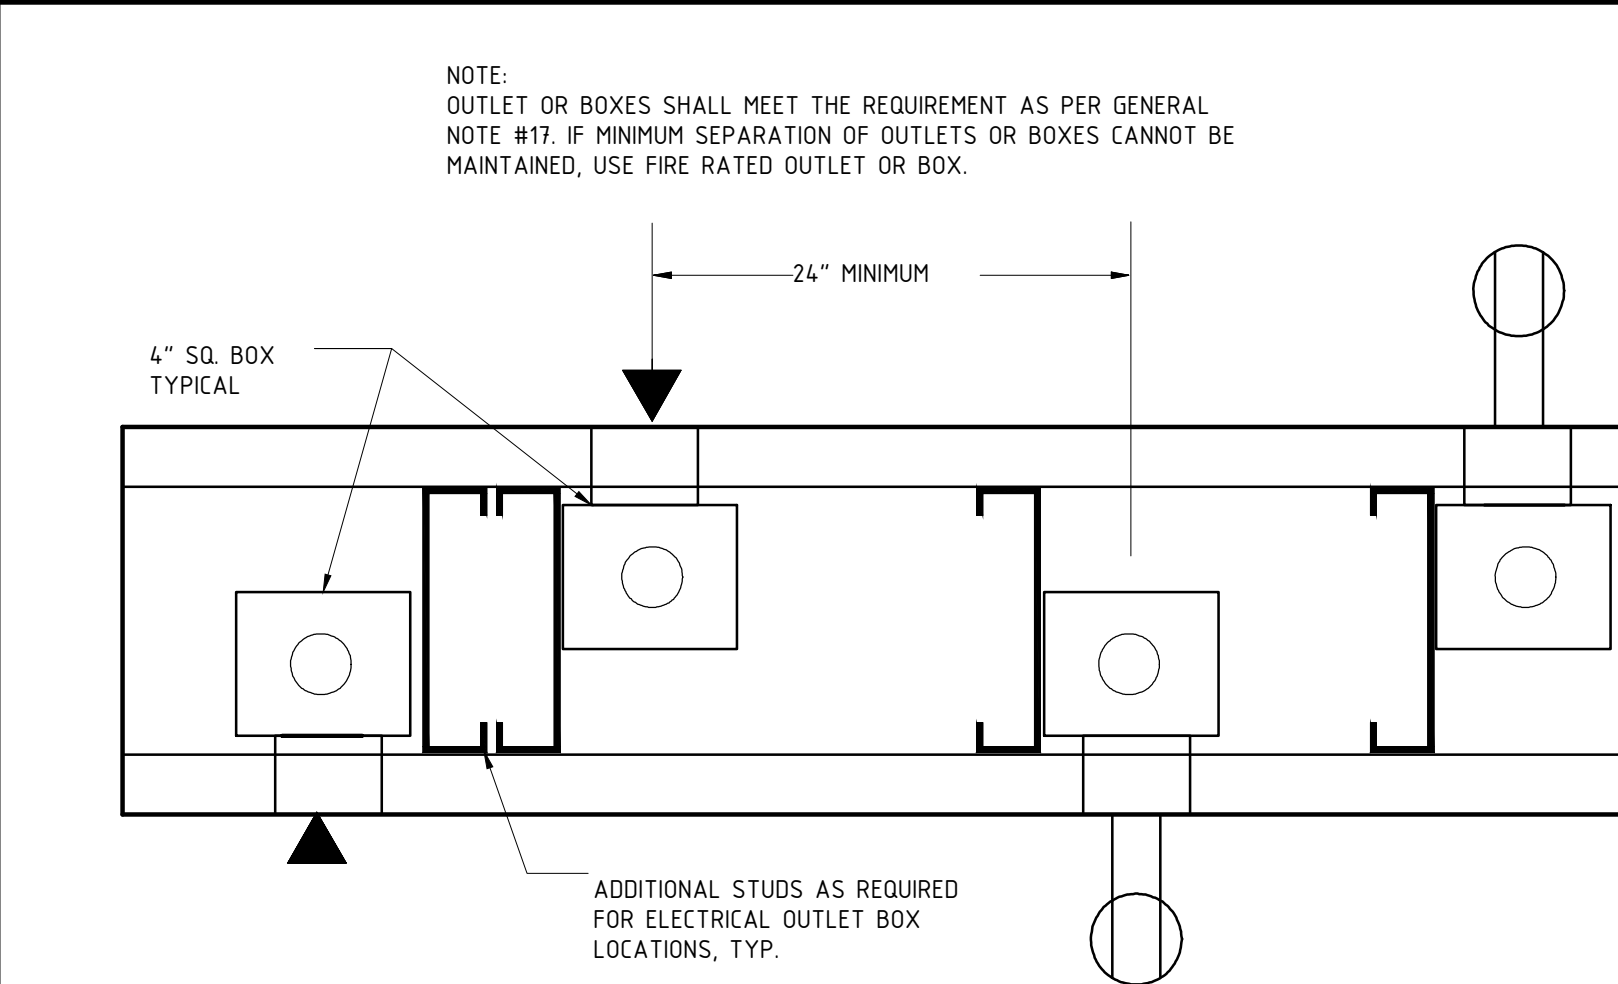


31 DEVICE BOX DETAIL 2
E500 NOT TO SCALE

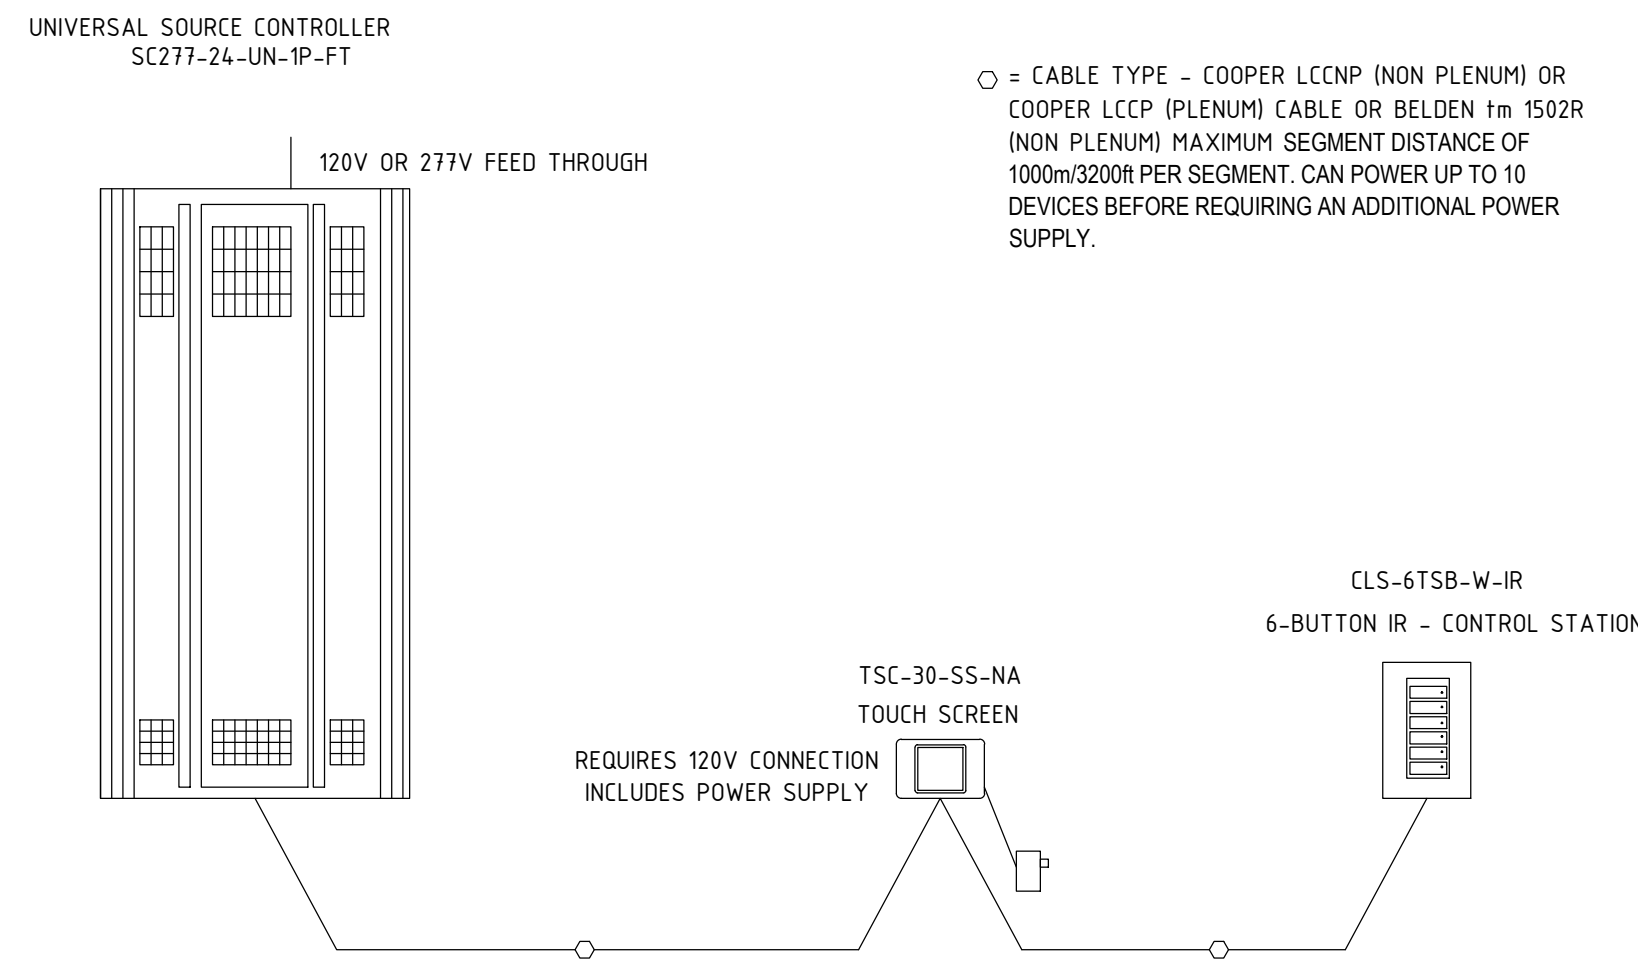


33 MAIN AREA LIGHTING CONTROLS
E500 NOT TO SCALE

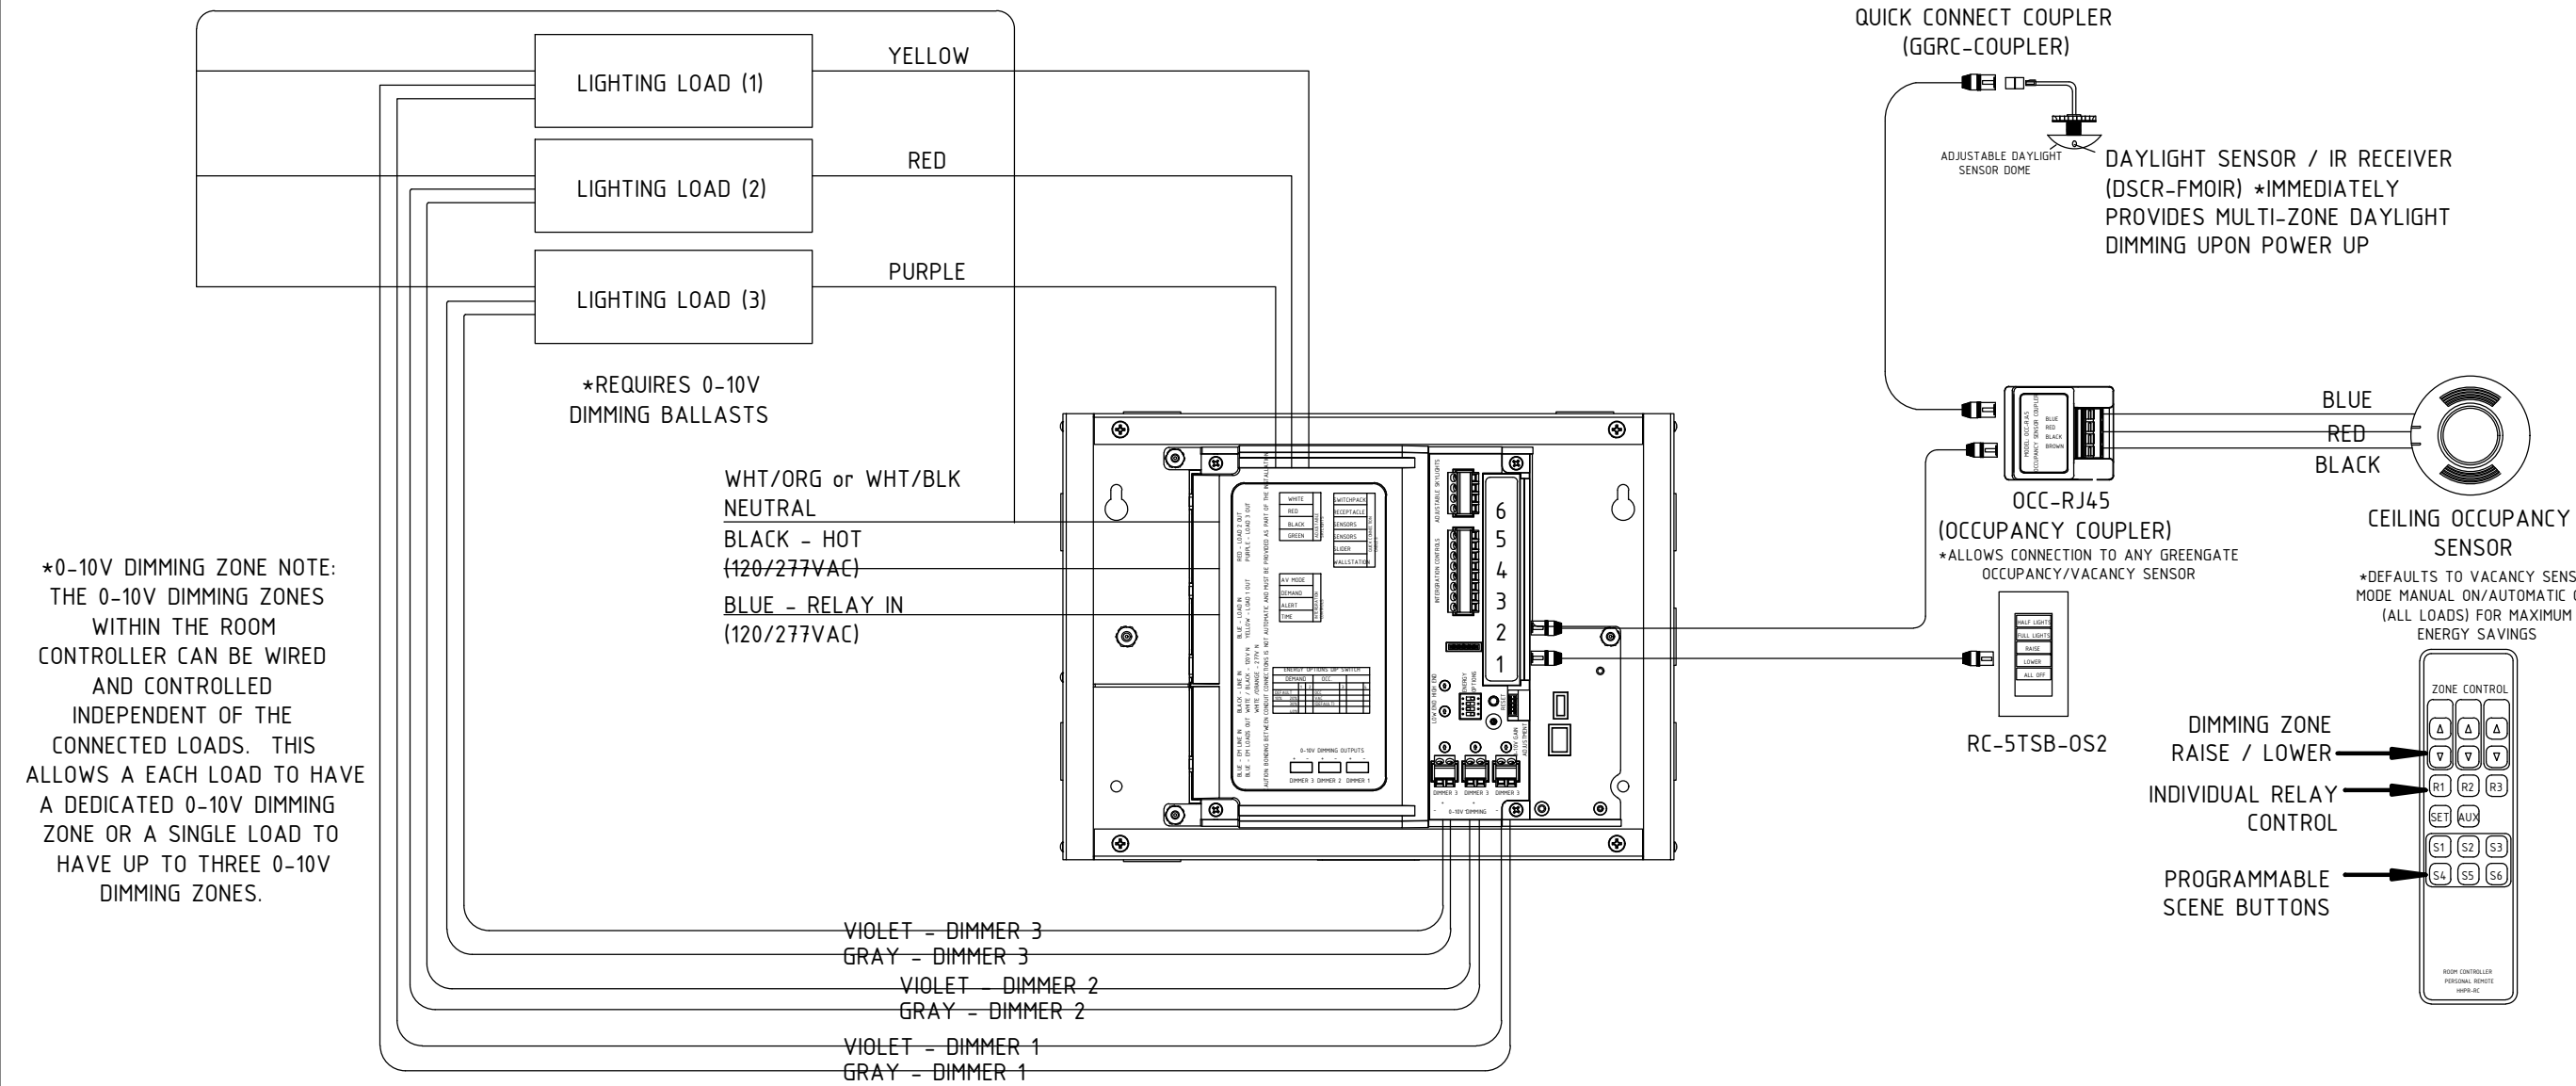

34 FITNESS ROOM LIGHTING CONTROLS
E500 NOT TO SCALE

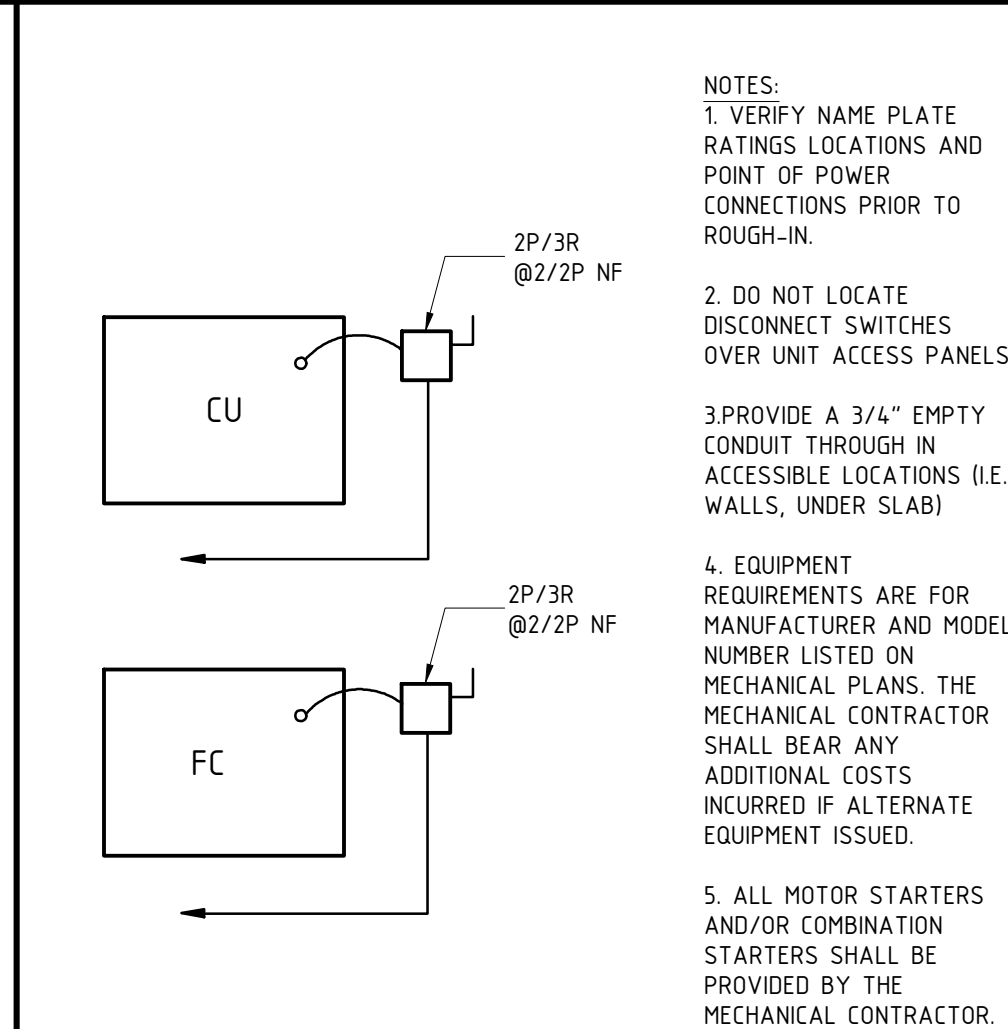

41
E500

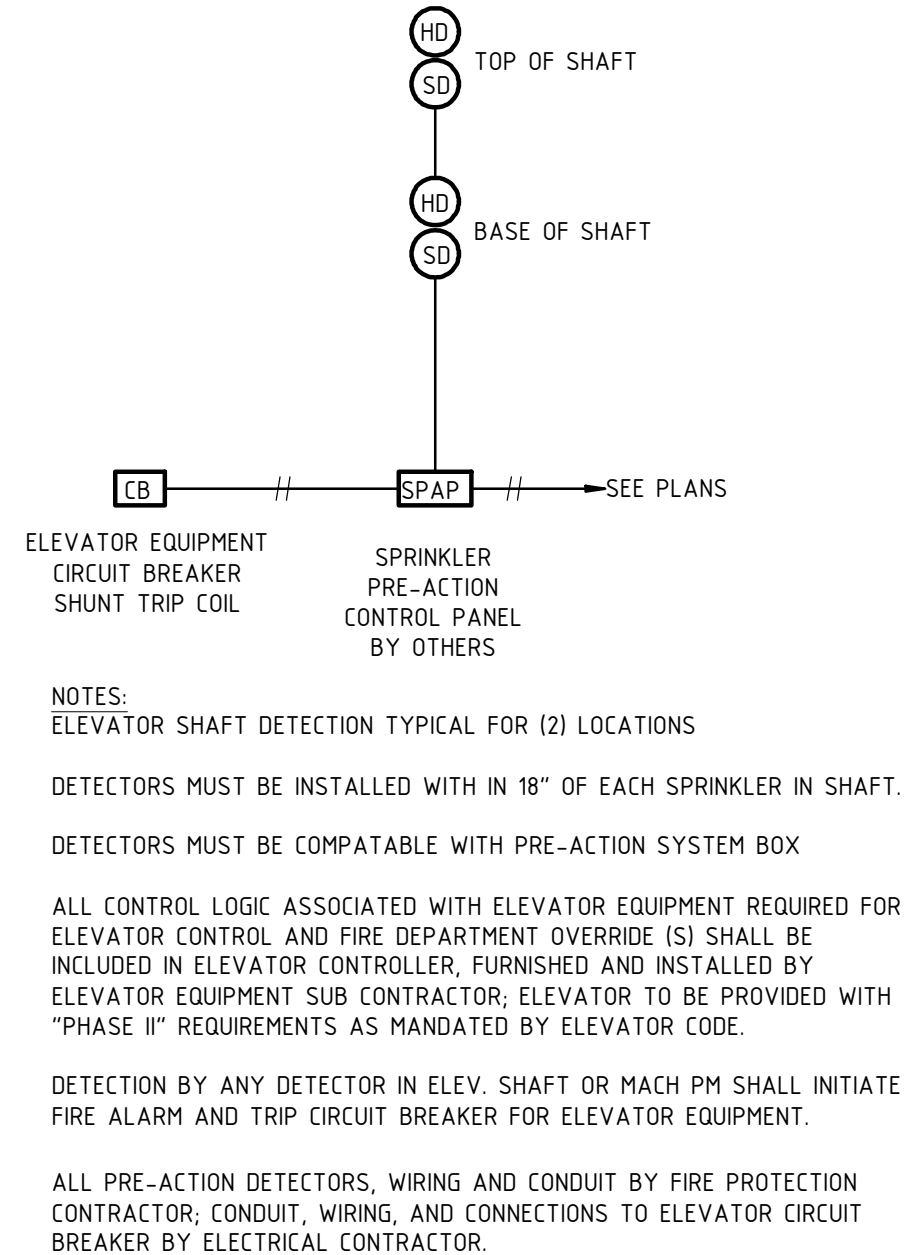

43
E500 NOT TO SCALE

ae
architects, p.c.

7301 Barberry Lane
Manlius, New York 13104
315-415-9988

A NEW 108-ROOM COURTYARD BY MARRIOTT HOTEL & SUITES

Turner Road
Woodbury, New York
location #12121

for

RAINBOW ENTERPRISES

4758 Highway 28
Cooperstown, NY

REVISION DATES

2/19/2016

UNAUTHORIZED ALTERATIONS OR ADDITIONS TO THIS DRAWING ARE A VIOLATION OF STATE EDUCATION LAW ARTICLES 145 AND 147.

THIS DRAWING IS AN INSTRUMENT OF SERVICE FOR RAINBOW ENTERPRISES, AND MAY NOT BE REPRODUCED WITHOUT THE EXPRESS CONSENT OF THE OWNER AND THE ARCHITECT

DRAWING TITLE

ELECTRICAL DETAILS

DATE

MARCH 1, 2021

PROJECT NUMBER

17971

SHEET NUMBER

E500