


1

PARTIAL BASEMENT FLOOR PLAN - NEW WORK

SCALE: 1/8"=1'-0"

ELECTRICAL NEW WORK NOTES:

1 PROVIDE NEW CABINET HEATER AND APPURTENANCES AS SCHEDULED.

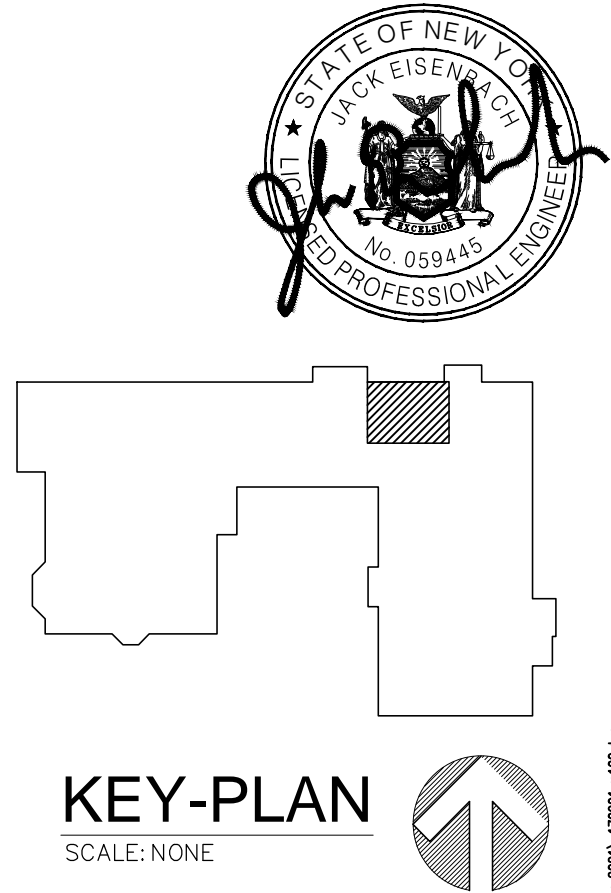

CABINET HEATER SCHEDULE – HOT WATER 180F EWT														
UNIT NO.	LOCATION	TYPE	CFM	CAPACITY MBH	GPM	TEMP DROP DEG F	PRESS DROP FT HD	E.A.T. DEG F	L.A.T. DEG F	FAN MOTOR				DESIGN EQUIPMENT/REMARKS
										RPM	HP	VOLTS	PHASE	
CH-1														NOT USED
CH-2														NOT USED
CH-3														NOT USED
CH-4														NOT USED
CH-5	SEE M100A	VERTICAL	220	10	1.0	20	0.5	60	130	1050	1/60	120	1	RF-200-03

REMARKS:

- (1) MANUFACTURED BY ZEHNDER RITTLING OR APPROVED EQUAL
(2) PROVIDE HANGERS AND SUPPORTS, ANCHORS AS REQUIRED FROM STRUCTURE ABOVE

ADDENDUM #4 IFB-6569A



FILE PATH – N:\1 – PROJECT DIRECTORIES\Yonkers Public Schools\9 School 9\Y170901 Boiler System Replacement YPS 10816\Additional Work.1 for 2021\Y170901.m100.dwg

DATE: 1.25.2021
SCALE: AS-NOTED
PROJECT NO: Y170901

YONKERS PUBLIC SCHOOLS
BUILDING RENOVATIONS AND
SITework AT
SCHOOL 9

53 FAIRVIEW STREET, YONKERS N.Y. 10703
S.E.D.# 86-25-00-01-0-009-009

Eisenbach & Ruhke Engineering, P.C.
291 Genesee Street, Utica - NY 13501 Ph: 315-735-1916
Fax: 315-735-6365 www.erengr.com

PROJECT NO: Y170901
DRAWN BY: ER

YPS NO. 10816
FROM DRAWING M100

SHEET NO: M100A

STATE OF NEW YORK
JACK EISENBACH
LICENSED PROFESSIONAL ENGINEER
No. 059445