

LIST OF BACKFLOW PREVENTER APPURTENANCES	
MARK	DESCRIPTION
1	RESILIENT SEATED GATE VALVE
2	TAMPER PROOF RESILIENT SEATED GATE VALVE WITH TAMPER SWITCH
3	STRAINER
4	4" RPZ BACKFLOW PREVENTER - WATTS SERIES 909
5	WATER METER (PER WATER DEPARTMENT)
6	2" TEST OUTLET VALVE
7	PRESSURE REDUCING VALVE
8	AIR GAP (JR SMITH 3955)
9	FUNNEL (JR SMITH 3811)
10	8" DOUBLE CHECK DETECTOR ASSEMBLY-WATTS SERIES 709 DCDA

- GENERAL NOTES - BACKFLOW PREVENTER:**
- LOCATION OF BACKFLOW DEVICES SHALL HAVE ADEQUATE HEAT AND LIGHT.
 - BACKFLOW DEVICES SHALL BE PROTECTED FROM FLOODING.
 - BACKFLOW DEVICES AND WATER METER SHALL BE TESTED AFTER INSTALLATION.
 - OWNER SHALL ARRANGE FOR BACKFLOW DEVICES TO BE TESTED ANNUALLY BY A CERTIFIED TESTER.
 - ANY REVISIONS OR ALTERATION OF THESE PLANS WITHOUT THE EXPRESSED WRITTEN CONSENT OF THE SIGNING ENGINEER IS A VIOLATION OF SECTION 7209 OF THE NEW YORK STATE EDUCATION LAW.

- BACKFLOW PREVENTER FILING REQUIREMENTS**
- A. THIS CONTRACTOR SHALL BE RESPONSIBLE FOR HIRING A LICENCED ENGINEER TO FILE ALL APPLICATIONS, PERMITS AND FILING FEES WITH THE AUTHORITIES HAVING JURISDICTION OVER THE WORK.**
- B. THE FOLLOWING LIST SERVES AS THE MINIMUM FILING REQUIREMENTS. FAILURE TO LIST ANY ITEM DOES NOT RELIEVE THE CONTRACTOR FROM FULFILLING THAT REQUIREMENT.**
- CERTIFICATE OF RESOLUTION OF LETTER OF AUTHORIZATION FROM OWNER/USER TO EXECUTE FILING.
 - PREPARE AND SUBMIT FORM DOH-347 WITH PLANS, PROFESSIONAL ENGINEERS REPORT AND SPECIFICATIONS WITH ENGINEER'S SEAL. FILE WITH HEALTH DEPARTMENT AND WATER DEPARTMENT.
 - FILING FEES, PER DEVICE.
 - EVIDENCE OF CONFORMANCE TO NEW YORK STATE SANITARY CODE, PART 5 AND CHAPTER 873 OF THE LAWS OF WESTCHESTER COUNTY.

LEGEND	
---	NEW PIPING, FIXTURES, ETC.
---	COLD WATER PIPING
---	HOT WATER PIPING
---	HOT WATER RETURN PIPING
---	PLUMBING VENT PIPING
---	SAN
---	SANITARY PIPING (UNDERGROUND)
---	PD
---	PUMP DISCHARGE PIPING
---	UPD
---	UNDERGROUND PUMP DISCHARGE PIPING
---	ST
---	STORM PIPING
---	UST
---	STORM PIPING (UNDERGROUND)
---	G
---	UNINTERRUPTIBLE GAS PIPING
---	UG
---	UNINTERRUPTIBLE GAS PIPING (UNDERGROUND)
---	W
---	WATER SERVICE PIPING
---	F
---	FIRE PROTECTION PIPING
---	SP
---	SPRINKLER PIPING
---	SPRINKLER HEAD
---	FLOW DIRECTION WITHIN PIPE
---	CLEANOUT
---	CLEANOUT DECK PLATE
---	SHUT-OFF VALVE
---	COMBINATION BALANCING & SHUT-OFF VALVE
---	OS & Y VALVE
---	OS & Y VALVE WITH TAMPER SWITCH
---	CHECK VALVE
---	GAS SHUT OFF COCK
---	SIDEWALL SPRINKLER HEAD
---	PIPE CONNS. (BOTTOM, TOP 45 OR 90, PIPE UP)
---	PLUMBING FIXTURE IDENTIFICATION
---	BACKFLOW PREVENTER APPURTENANCE IDENTIFICATION
---	P.C.
---	PLUMBING CONTRACTOR
---	G.C.
---	GENERAL CONTRACTOR
---	HVAC
---	HVAC CONTRACTOR
---	VTR
---	VENT THRU ROOF
---	FAI
---	FRESH AIR INTAKE
---	FD
---	FLOOR DRAIN
---	PRV
---	PRESSURE REDUCING VALVE
---	CIRCULATOR PUMP IDENTIFICATION
---	SUMP PUMP IDENTIFICATION
---	HOT WATER HEATER IDENTIFICATION
---	POINT OF CONNECTION
---	DRAWING, DETAIL, SECTION NUMBER
---	SECTION IDENTIFICATION

PLUMBING FIXTURE SCHEDULE						
MARK	DESCRIPTION	BRANCH SIZE				
		W	V	H	C	
A1	WALL MOUNTED WATER CLOSET (FLUSH VALVE)	4"	2"	-	1"	
A2	WALL MOUNTED WATER CLOSET (FLUSH VALVE) (HANDICAPPED)	4"	2"	-	1"	
A3	FLOOR MOUNTED WATER CLOSET (FLUSH VALVE) (HANDICAPPED)	4"	2"	-	1"	
A4	FLOOR MOUNTED CHILD'S WATER CLOSET (FLUSH VALVE)	4"	2"	-	1"	
B1	SINGLE SINK UNIT (HANDICAPPED)	1-1/2"	1-1/2"	1/2"	1/2"	
B2	DOUBLE SINK UNIT (HANDICAPPED)	1-1/2"	1-1/2"	1/2"	1/2"	
B3	TRIPPLE SINK UNIT (HANDICAPPED)	1-1/2"	1-1/2"	1/2"	1/2"	
B4	COUNTERTOP CLASSROOM SINK (HANDICAPPED)	1-1/2"	1-1/2"	1/2"	1/2"	
B5	MAKER SPACE SINK	1-1/2"	1-1/2"	1/2"	1/2"	
B6	HEALTH SUITE SINK (HANDICAPPED)	1-1/2"	1-1/2"	1/2"	1/2"	
B7	ART SINK (SINGLE)	1-1/2"	1-1/2"	1/2"	1/2"	
B8	FACULTY SINK (HANDICAPPED)	1-1/2"	1-1/2"	1/2"	1/2"	
B9	MUSIC ROOM SINK	1-1/2"	1-1/2"	1/2"	1/2"	
B10	PRE-K/ K SINK	1-1/2"	1-1/2"	1/2"	1/2"	
C	URINAL - WALL MOUNTED	3"	2"	-	1/2"	
D1	SINGLE WATER COOLER (HANDICAPPED) W/ BOTTLE FILL	2"	1-1/2"	-	1/2"	
D2	DOUBLE WATER COOLER (HANDICAPPED) W/ BOTTLE FILL	2"	1-1/2"	-	1/2"	
D3	DOUBLE BOTTLE FILLING STATION	2"	1-1/2"	-	1/2"	
E	MOP RECEPTOR	3"	3"	3/4"	3/4"	
F	SHOWER	2"	1-1/2"	1/2"	1/2"	
G1	LABORATORY COUNTER MOUNTED SINK	2"	1-1/2"	-	1/2"	
G2	LABORATORY COUNTER MOUNTED SINK (TEACHER'S)	2"	1-1/2"	1/2"	1/2"	
H	EYE WASH	2"	1-1/2"	1/2"	1/2"	

BUILDING STRUCTURE FIREPROOFING:

THE BUILDING STRUCTURE WILL BE PROTECTED BY 2" FIREPROOFING THROUGHOUT. THIS CONTRACTOR SHALL ISSUE COORDINATION DRAWINGS ACCORDING TO THE STRICT SCHEDULE OUTLINED IN THE FRONT END DOCUMENTS. ALL HANGERS FOR PIPING, CONDUIT, DUCTWORK, EQUIPMENT, ETC. MUST BE IN PLACE BEFORE FIREPROOFING TAKES PLACE. THE INSTALLATION OF HANGERS AFTER THE FACT THAT REQUIRES THE RE-APPLICATION OF FIREPROOFING WILL BE AT THE EXPENSE OF THIS CONTRACTOR.

BASEMENT WATERPROOFING:

REFER TO STRUCTURAL DRAWINGS AND ARCHITECTURAL DRAWINGS FOR SLAB/ WALL THICKNESS AND PENETRATION DETAILS. COORDINATE WITH G.C.

NEW COMMUNITY SCHOOL AT THE ST DENIS SITE

YONKERS JOINT SCHOOL CONSTRUCTION BOARD

121 McLean Avenue
Yonkers, NY 10705

KG+D listen imagine build

KG+D . ARCHITECTS PC

285 MAIN STREET MOUNT KISCO, NEW YORK, 10549
P.914.666.5900 KGDARCHITECTS.COM

NY SED PROJECT CONTROL NO.

66-23-00-01-0-346-001


CONSTRUCTION DOCUMENTS

bga

BARILE GALLAGHER & ASSOCIATES

CONSULTING ENGINEERS

99 MARBLE AVE. PLEASANTVILLE, NY 10570
914.326.0099 GENERAL@BGA-ENG.COM WWW.BGA-ENG.COM

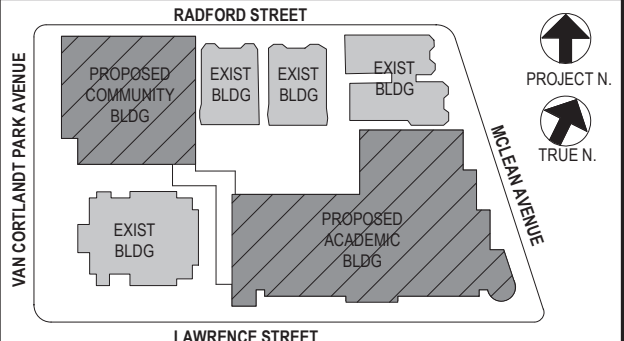

NOTE: ALL IDEAS, DESIGN, WORKS, AND PLANS INDICATED OR REPRESENTED BY THIS DRAWING ARE OWNED BY AND ARE THE PROPERTY OF KATYER GARRETT & ASSOCIATES ARCHITECTS PC (KGA) AND ARE HEREBY GRANTED FOR USE ON THE PROJECT. NONE OF SUCH IDEAS, DESIGN, WORKS, OR PLANS SHALL BE USED BY OR DISCLOSED TO ANY PURPOSE WHATSOEVER WITHOUT THE WRITTEN PERMISSION OF KGA.

WRITTEN DIMENSIONS ON THIS DRAWING SHALL HAVE PRECEDENCE OVER SCALED DIMENSIONS. CONTRACTOR SHALL VERIFY ALL ACTUAL DIMENSIONS AND CONDITIONS ON THE JOB AND THE ARCHITECT MUST BE NOTIFIED OF ANY VARIATIONS FROM DIMENSIONS AND CONDITIONS SHOWN. SHOP DETAILS MUST BE SUBMITTED TO THIS OFFICE FOR APPROVAL BEFORE PROCEEDING WITH FABRICATION.

ALTERATIONS BY ANY PERSON IN ANY WAY OF ANY ITEM CONTAINED ON THIS DOCUMENT, UNLESS ACTING UNDER THE DIRECTION OF THE LICENSED ARCHITECT, ENGINEER, PROFESSIONAL, OR ARCHITECT, IS A VIOLATION OF TITLE 16, SECTION 16-1.5 OF THE NEW YORK STATE LAW. COPYRIGHT KATYER GARRETT & ASSOCIATES ARCHITECTS & ENGINEERS, PC. ALL RIGHTS RESERVED.

Professional Seal

4	11/01/2021	ISSUED TO BID
3	07/14/2021	CONSTRUCTION DOCS-NYSED
2	12/15/2020	DESIGN DEVELOPMENT
1	08/31/2020	SCHEMATIC DESIGN
No	Date	Issue

Sheet Title

Legend, Schedule, Notes, and
Basement Floor Plumbing Plan

Job No. 2019-1026 Date 11/18/20

Scale AS NOTED Drawn / Checked BGA/ BGA

Sheet Number

P200

BEFORE FABRICATION THIS CONTRACTOR SHALL VERIFY ALL MEASUREMENTS AND CONDITIONS ON JOB AND COORDINATE HIS WORK WITH THE WORK OF ALL OTHER CONTRACTORS