



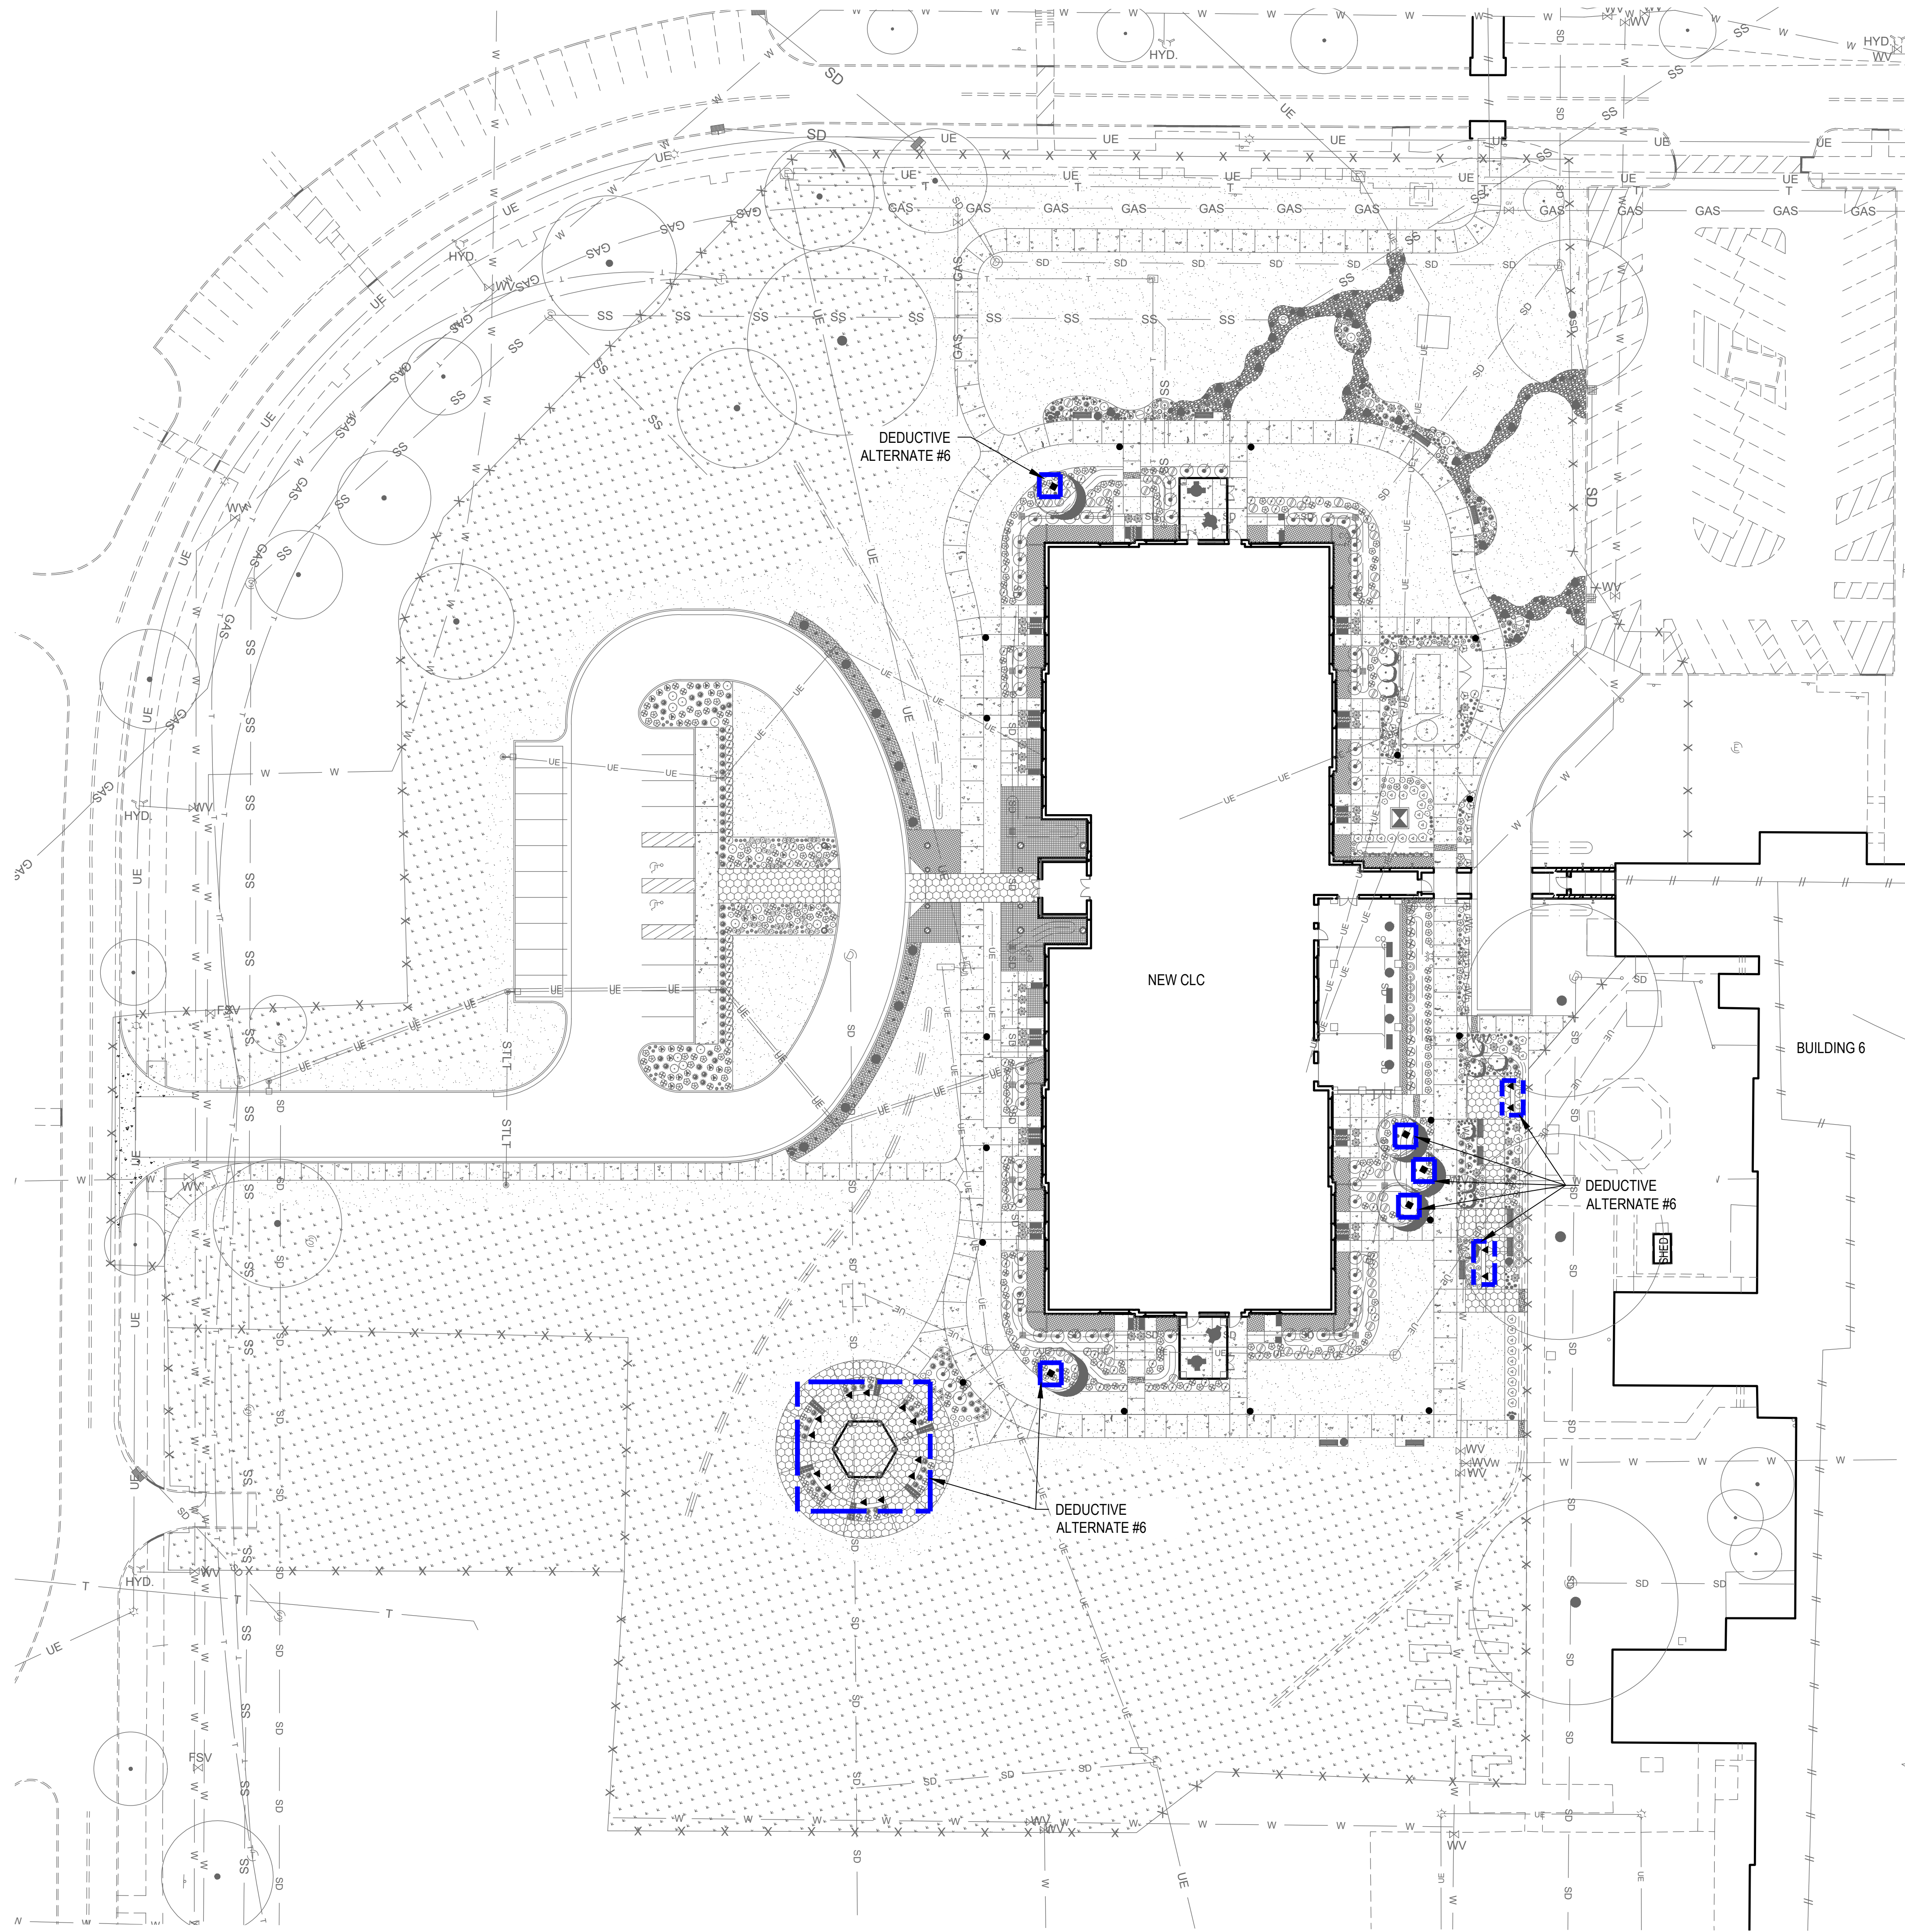

LANDSCAPE LIGHTING SCHEDULE

SYMBOL	TYPE	MANUFACTURER	CONTACT	PRODUCT NAME	COLOR/FINISH	NOTES	QTY
■	FLOOD LIGHT	KIM LIGHTING OR APPROVED EQUAL		ELL271DB-PL-EP17	DARK BRONZE		5
●	LIGHTED BOLLARD	KIM LIGHTING OR APPROVED EQUAL		B30 TRADITIONAL BOLLARDS	DARK BRONZE		17
▲	LANDSCAPE WALL LIGHT	KIM LIGHTING OR APPROVED EQUAL		EL807 WALL LIGHT	DARK BRONZE		16

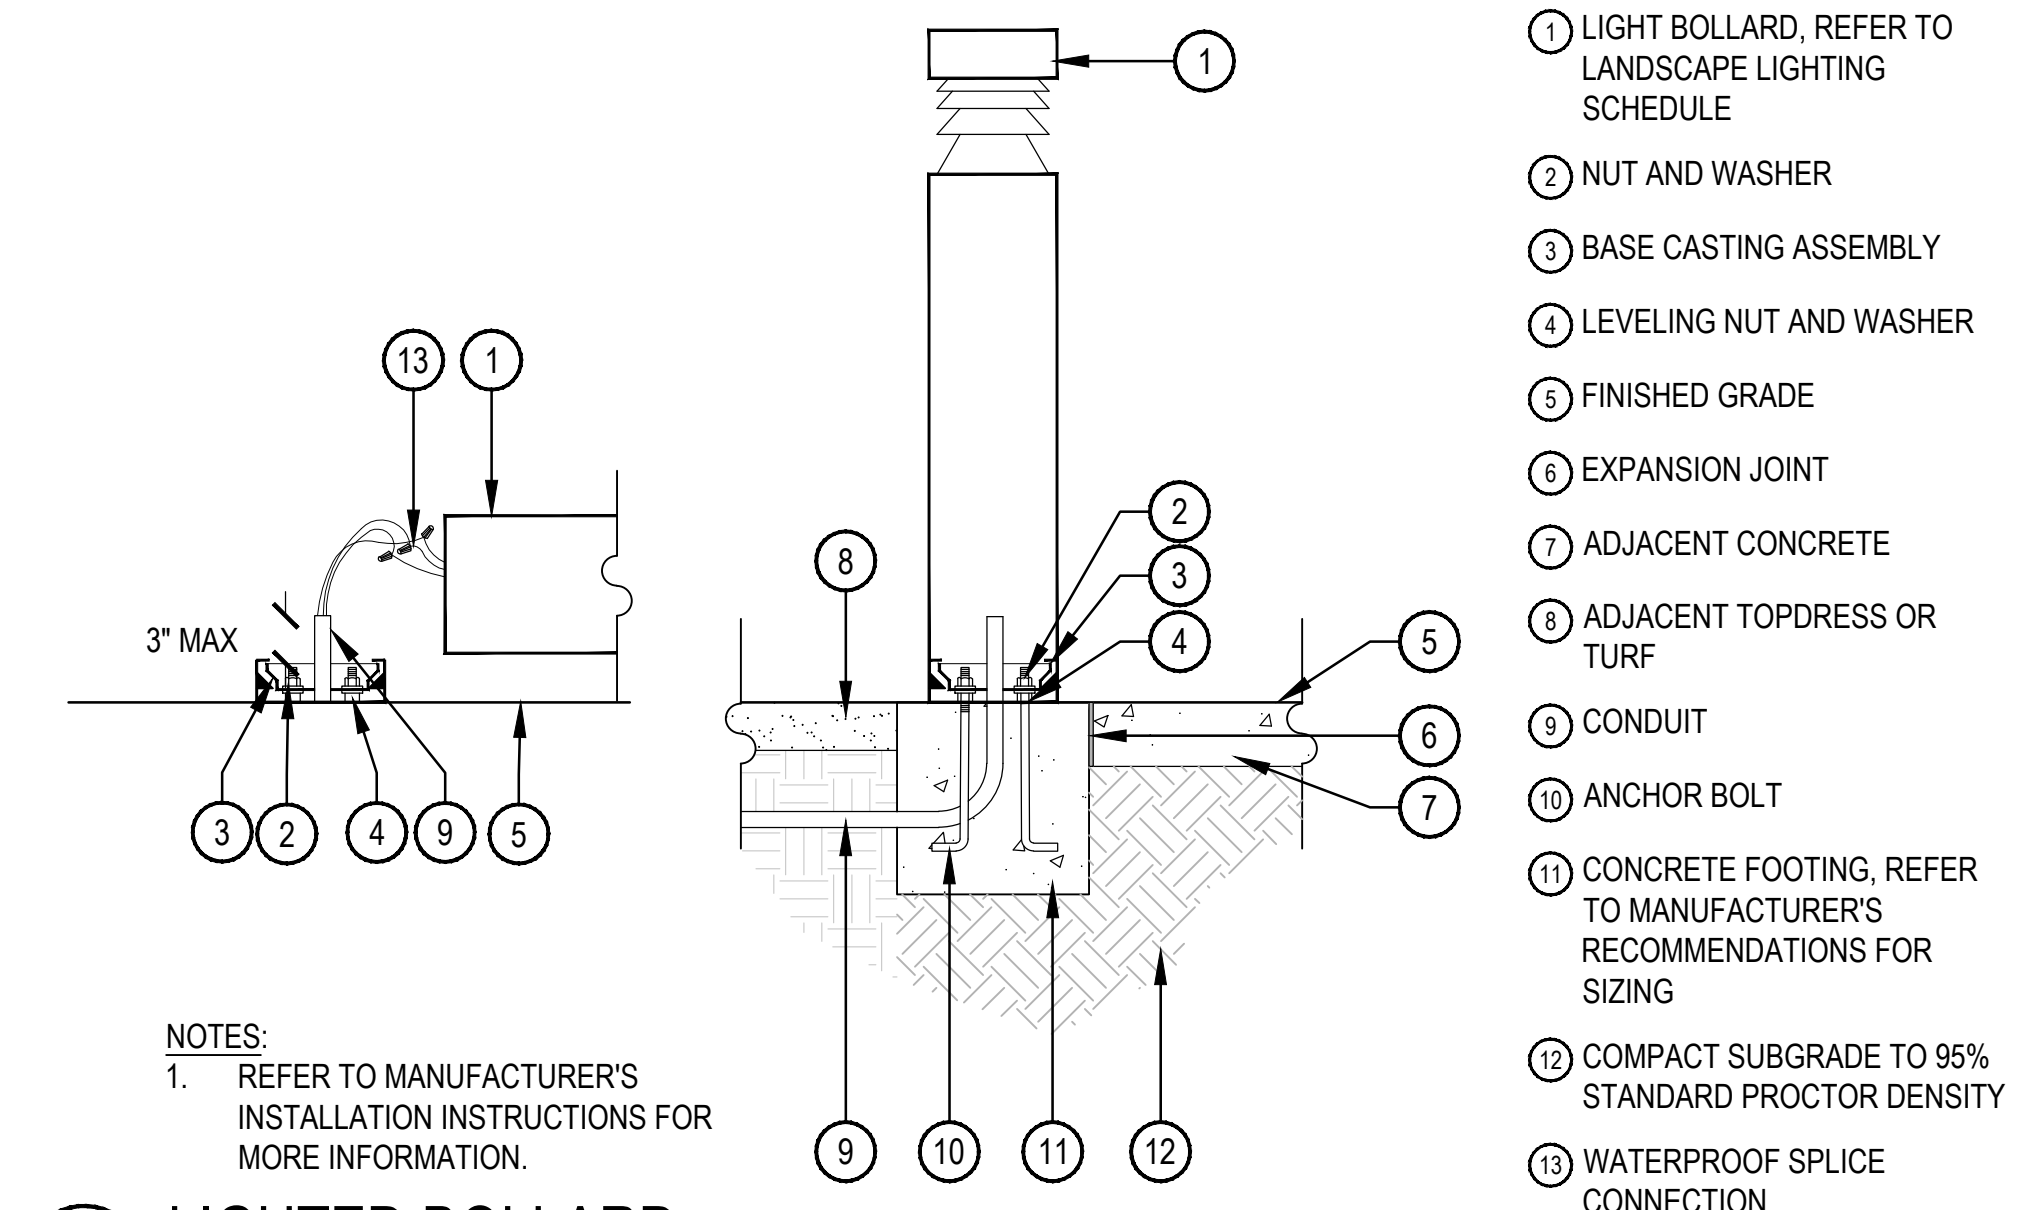

NOTES:
1. REFER TO MANUFACTURER'S INSTALLATION INSTRUCTIONS FOR MORE INFORMATION.

C7 LIGHTED BOLLARD

SCALE: 1" = 1'-0"

DEDUCTIVE ALTERNATES:

(DEDUCTIVE ALTERNATES ARE CASCADING AND MUST BE EXERCISED IN THE ORDER PRESENTED) FOR DETAILS OF EACH DEDUCTIVE SEE COVER SHEET ON G1000

- DEDUCTIVE ALTERNATE #1: REDUCE WATER AND ICE SHIELD COVERAGE
- DEDUCTIVE ALTERNATE #2: ELIMINATE TUNNEL (EAST LEG)
- DEDUCTIVE ALTERNATE #3: ELIMINATE FAUX WINDOWS AT CLEARSTORY
- DEDUCTIVE ALTERNATE #4: ELIMINATE WORK AT B6 CORRIDOR
- DEDUCTIVE ALTERNATE #5: ELIMINATE CONCRETE
- DEDUCTIVE ALTERNATE #6: ELIMINATE LANDSCAPE
- DEDUCTIVE ALTERNATE #7: REDUCE PLATFORM AT CHILLER
- DEDUCTIVE ALTERNATE #8: ELIMINATE NVR SECURITY
- DEDUCTIVE ALTERNATE #9: ELIMINATE LARGE PORCH
- DEDUCTIVE ALTERNATE #10: ELIMINATE SMALL PORCH A
- DEDUCTIVE ALTERNATE #11: ELIMINATE SMALL PORCH B
- DEDUCTIVE ALTERNATE #12: ELIMINATE ENTRANCE CANOPY
- DEDUCTIVE ALTERNATE #13: ELIMINATE FENCE/FAUX ROOFS AT RESIDENT ROOMS
- DEDUCTIVE ALTERNATE #14: ELIMINATE PATIENT LIFTS TRACK EXTENSION
- DEDUCTIVE ALTERNATE #15: ELIMINATE POROUS ASPHALT / PARKING / PORTION OF DRIVE ENTRANCE
- DEDUCTIVE ALTERNATE #16: ELIMINATE EXTERIOR SIGNAGE

SCALE 1" = 30'

LL201 LANDSCAPE LIGHTING PLAN

	CONSULTANT		ARCHITECT/ENGINEER OF RECORD			STAMP 	Office of Construction and Facilities Management VA U.S. Department of Veterans Affairs	Drawing Title LANDSCAPE LIGHTING PLAN - DEDUCTIVE ALTERNATE #6 ELIMINATE LANDSCAPE	Phase ISSUED FOR CONSTRUCTION	Project Title NEW COMMUNITY LIVING CENTER	Project Number 620-334
	Landscape Architect 418 North Tule Avenue Tucson, AZ 85701 (520) 622-9555 Josh Orth, PLA		Protective Design Specialist 240 West 35th St, Suite 1004 New York, NY 10001 (212) 967-4890 Corinne Tan, SE	Structural 315 West James Street, Suite 102 Lancaster, PA 17603 (717) 481-2991 Jason Vannoy, SE, PE				MEP 350 North Roo Street, Suite 203 Tampa, FL 33609 (813) 289-4700 Nicholas Stephenson, PE	Approved:		Location 2094 Albany Post Road, Montrose, NY 10548
Issue Date 05/09/2022		Checked JMO	Drawn MSJD								

BM 360.054-18-824 Landscape Entire Facility/654-18-824 Landscape Entire Facility.rvt 5/14/2020 10:10:28 AM