

A

B

C


D

E

F

7/21/2021 3:54:27 PM

BM 360-620-334 New Community Living Center/620-334 CLC-Arch.rvt

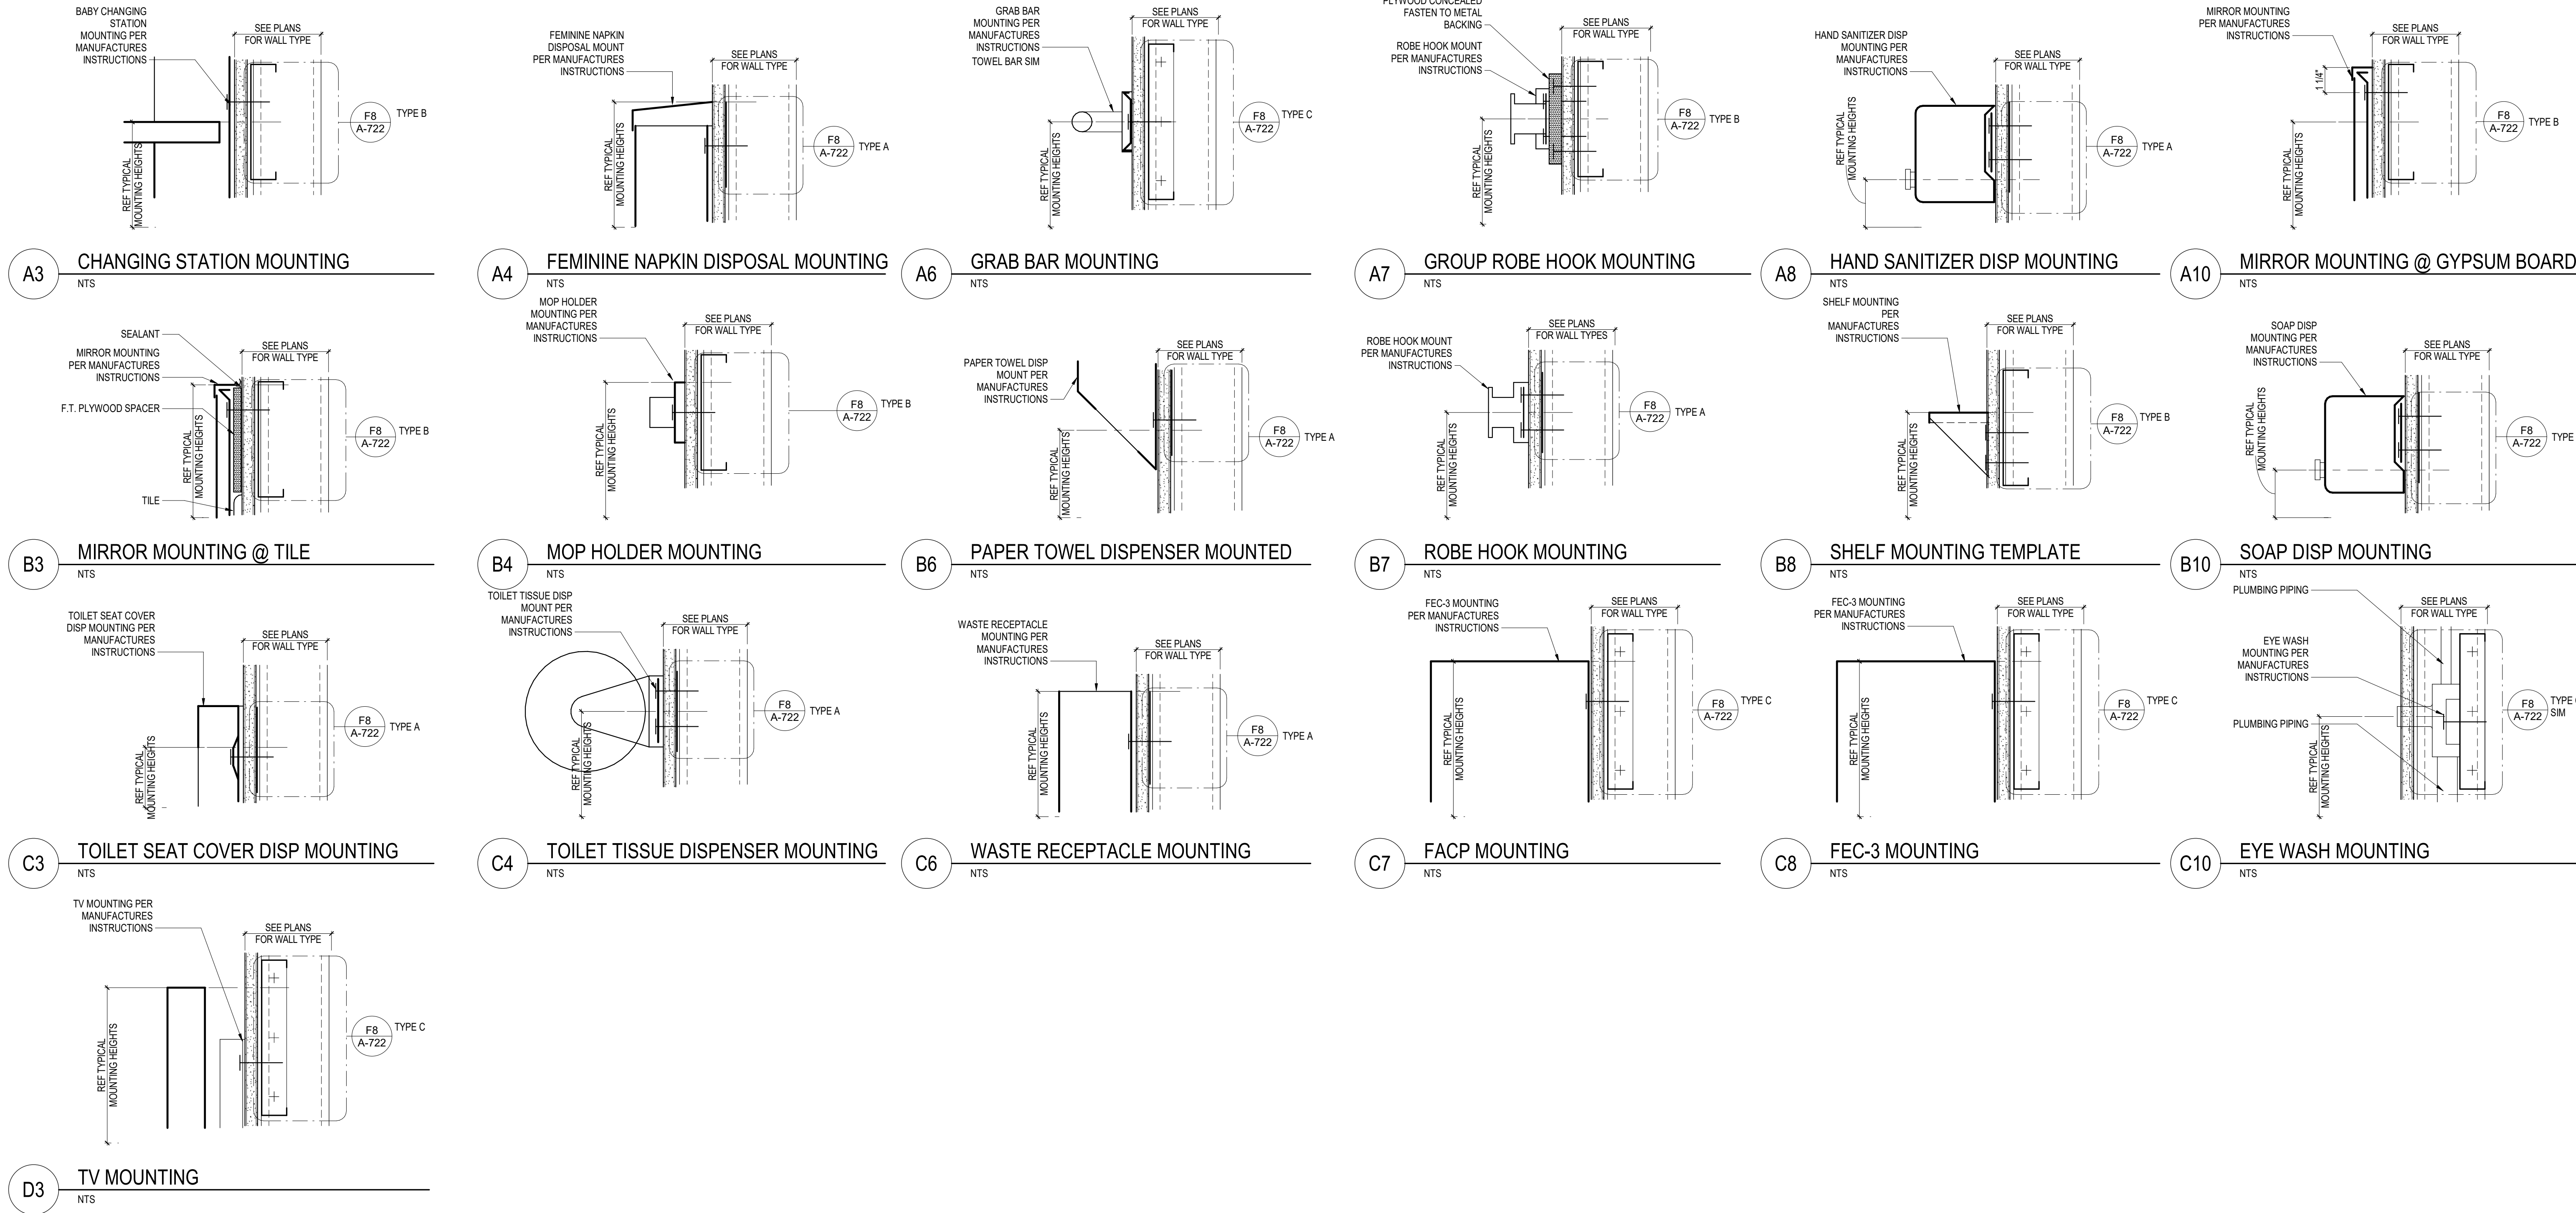

ACCESSORY MOUNTING DIAGRAM

SCALE: 1/4" = 1'-0"

ACCESSORY TYPE	EMERGENCY EYEWASH / SHOWER	EMERGENCY EYEWASH	RECESSED OR SURFACE MOUNTED F.E. CABINET	PANIC / CALL BUTTON, DOOR OPERATORS	INTERCOMM	ROOM SIGNAGE MOUNT ON LATCH SIDE OF DOOR	FIRE ALARM PULL STATION	FIRE ALARM HORN & STROB	FIRE ALARM CONTROL PANEL / ANNUNCIATOR	SWITCHES, DATA & PHONE JACKS, OUTLETS, & KEY SWITCHES	WALL HYDRANTS HOSE BIBBS	UTILITY CENTER, PLUMBING CONNECTION	FIRE DEPT CONNECTION	TELEPHONE, WALL MOUNTED	NURSE CALL	WALL-MOUNTED TELEVISION
MOUNTING DETAIL - REFER TO SHEET A-722FB, UNO	C	C	C1/A-722 RECESSED & SEMI-RECESSED A1000 F.E. ONLY	J-BOX	J-BOX SURFACE MOUNTED C1/A-722 RECESSED	A	J-BOX	J-BOX	J-BOX SURFACE MOUNTED C1/A-722 RECESSED	J-BOX	A	J-BOX	J-BOX	A	J-BOX	C
DRAWING DESIGNATION	PS210 P-706 P-707 FREE STANDING	P2000 P-708 WALL MOUNTED P-709 PEDESTAL MOUNTED	FEC-1 RECESSED FEC-2 SEMI-RECESSED STAINLESS STEEL DOOR MOUNTED FEC-3 SURFACE MOUNTED FEC-4 STAINLESS STEEL SURFACE MOUNTED FE SURFACE MOUNTED WALL BRACKET	TWS TOUCHLESS WALL SWITCH PP PUSH PLATE OR ACCESS CONTROL DEVICES		SEE SIGNAGE SCHEDULE	SEE FIRE ALARM SYSTEM DRAWINGS & SPECIFICATIONS	SEE FIRE ALARM SYSTEM DRAWINGS & SPECIFICATIONS	SEE FIRE ALARM SYSTEM DRAWINGS & SPECIFICATIONS	SEE ELECTRICAL DRAWINGS & SPECIFICATIONS KS KEY SWITCH	P-801 WALL HYDRANT P-802 LAWN FACET	P8710 WATER SUPPLY BOXES		A1012 TELEPHONE, WALL MOUNTED, 1 LINE A1013 TELEPHONE, WALL MOUNTED, MULTIPLE LINE A1014 TELEPHONE, WALL MOUNTED, 1 LINE WITH SPEAKER A1017 TELEPHONE, WALL MOUNTED, MULTIPLE LINE WITH SPEAKER A1018 TELEPHONE, WALL MOUNTED, WATERPROOF A1019 TELEPHONE, WALL MOUNTED, MULTILINE, CORDLESS		A5212 BRACKET, TELEVISION, WALL-MOUNTED, TILT/ANGLE A5220 BRACKET, TELEVISION, WALL BACKING M0512 TELEVISION, HDTV, LARGE SCREEN, 60"

ACCESSORY NOTES:

1. ACCESSORIES LISTED MAY HAVE GAPS IN ALPHANUMERIC LISTING.
2. ACCESSORIES CAN APPEAR ON FLOOR PLANS OR INTERIOR ELEVATIONS.
3. SOME ACCESSORIES SHOWN ON THIS SHEET MAY NOT BE USED IN THE PROJECT.
4. NOT ALL ACCESSORIES ARE C/FOL. REFER TO CONTRACT DOCUMENTS FOR ITEMS TO PROVIDED & INSTALLED BY CONTRACTOR.
5. LOCATIONS OF ACCESSORIES SHOWN ON FLOOR PLANS AND INTERIOR ELEVATIONS ARE RECOMMENDED LOCATIONS FOR C/FOL OR C/FOL ITEMS.

CONSULTANT

NORRIS DESIGN
Landscape Architect
416 North Toole Avenue
Tucson, AZ 85711
(520) 622-6565
Josh Orth, PLA

HINMAN
Protective Design Specialist
240 West 5th St, Suite 1004
New York, NY 10001
(212) 967-4890
Corinne Tan, SE


C.S. Davidson, Inc.
Structural
515 West James Street, Suite 102
Lancaster, PA 17603
(717) 481-2991
Jason Vannoy, SE, PE

MES GROUP
MEP
550 North Roo Street, Suite 203
Tampa, FL 33609
(813) 289-4700
Nicholas Stephenson, PE

ARCHITECT/ENGINEER OF RECORD

A/E:
TRIPLE C - The A/E Group
201 E. Jefferson Street, Suite 200
Syracuse, NY 13202
(315) 484-5958
Mat Perkins

STAMP

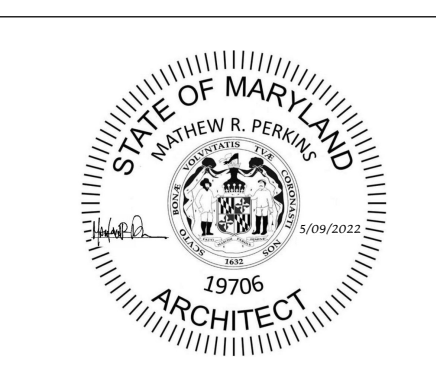

Office of
Construction
and Facilities
Management

VA U.S. Department
of Veterans Affairs

Drawing Title
TYPICAL MOUNTING HEIGHTS

Approved:

Phase
ISSUED FOR
CONSTRUCTION

FULLY SPRINKLERED

Project Title
NEW COMMUNITY LIVING
CENTER

Location
2094 Albany Post Road, Montrose, NY 10548

Issue Date
05/09/2022

Checked
Checker

Drawn
Author

Project Number
620-334
Building Number
CLC
Drawing Number
A-731