


UNDERGROUND PIPING NOTE
ALL UNDERGROUND PIPING, VALVES, FITTINGS, DIMENSIONS, ETC. ARE SHOWN FOR REFERENCE ONLY. REFER TO CIVIL DRAWINGS FOR EXACT LOCATIONS, TYPES, AND SIZES OF ALL COMPONENTS IN ADDITION TO DETAILS OF CONSTRUCTION.

SYMBOL KEY	
	EXISTING PIPING TO REMAIN
	EXISTING PIPING TO BE REMOVED
	NEW PIPING
	1" ARM-OVER TO NEW SPRINKLER FROM EXISTING 1" OUTLET
	CONNECT TO EXISTING PIPE AND/OR FITTING
	EXISTING SPRINKLER AND ARM-OVER TO BE DEMOLISHED BACK TO OUTLET ON BRANCH LINE UNLESS SHOWN OTHERWISE
	ORD/5.6/SR
	ORD/5.6/SR
	ORD/5.6/QR
	INT/5.6/QR
	APPROXIMATE CENTER LINE ELEVATION OF EXISTING PIPE ABOVE FINISHED FLOOR
	RECOMMENDED CENTER LINE ELEVATION OF NEW PIPE ABOVE FINISHED FLOOR
	RISE FROM LEFT TO RIGHT AND DROP FROM RIGHT TO LEFT
	NOT IN SCOPE

SEE SHEET FP2 FOR NOTES, DETAILS, AND SPECIFICATION

ALL ARM-OVERS TO NEW SPRINKLERS ARE 1" DIAMETER

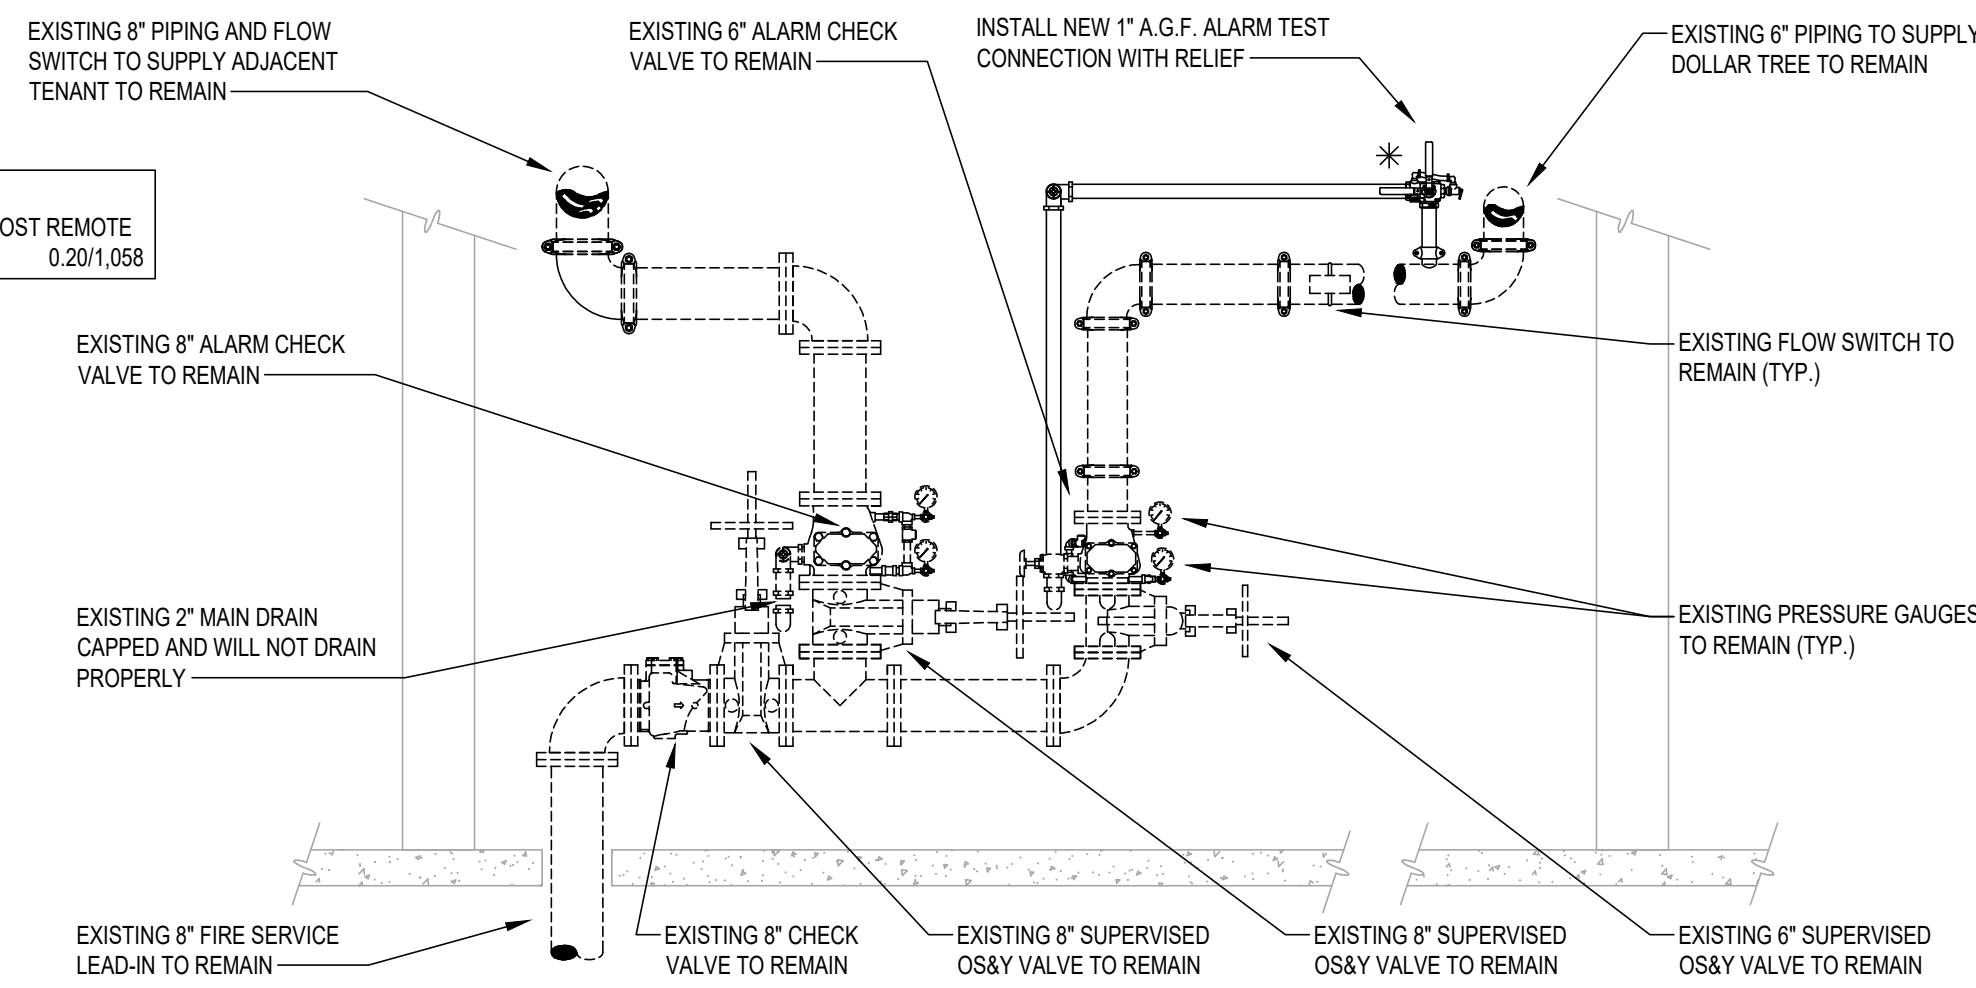

ELEVATION AT EXISTING BUILDING FIRE SPRINKLER RISER
(FOR REFERENCE ONLY)

FIRE SPRINKLER PLAN - NEW WORK
SCALE: 1/8" = 1'-0"
FIN. FLOOR ELEV. = 100'-0"

ENGINEER OF RECORD:
JAMES L. KINLOUGH, P.E.
LICENSE NO. 103071
JDK CONSULTANTS, P.C.
PROFESSIONAL ENGINEERS, P.C.
215 WEST 40TH ST., 10TH FLOOR
NEW YORK, NY 10018
PHONE: 212-216-9096
CORPORATE CERTIFICATE OF AUTHORITY
NO. 41103
WARNING: IT IS A VIOLATION OF THE NEW YORK STATE EDUCATION LAW, ARTICLE 141B, SECTION 7209 FOR ANY PERSON, UNLESS ACTING UNDER THE DIRECTION OF A LICENSED PROFESSIONAL ENGINEER, TO ALTER THIS DOCUMENT IN ANY WAY.



DOLLAR TREE
166 S. LIBERTY DRIVE - DEAL #13216 | STORE #2573
STONY POINT, NY 10980
FIRE SPRINKLER PLAN - NEW WORK AND EXISTING RISER ELEVATION

project
drawing

sheet

FP1

cd
215 WEST 40TH STREET, 10TH FLOOR
NEW YORK, NY 10018
212-216-9096
www.cdconsultants.com

date	project	designed	drawn	checked
06/15/2022	202277/012416	NY	NY	NY
description	by	date	mark	revisions

Dean Associates
Architects Incorporated
Architecture & Interior Design
7 Kimball Lane Suite 16
Ipswich MA 01940
p: 781.397.8092 f: 781.397.8094
www.deanassociates.com