


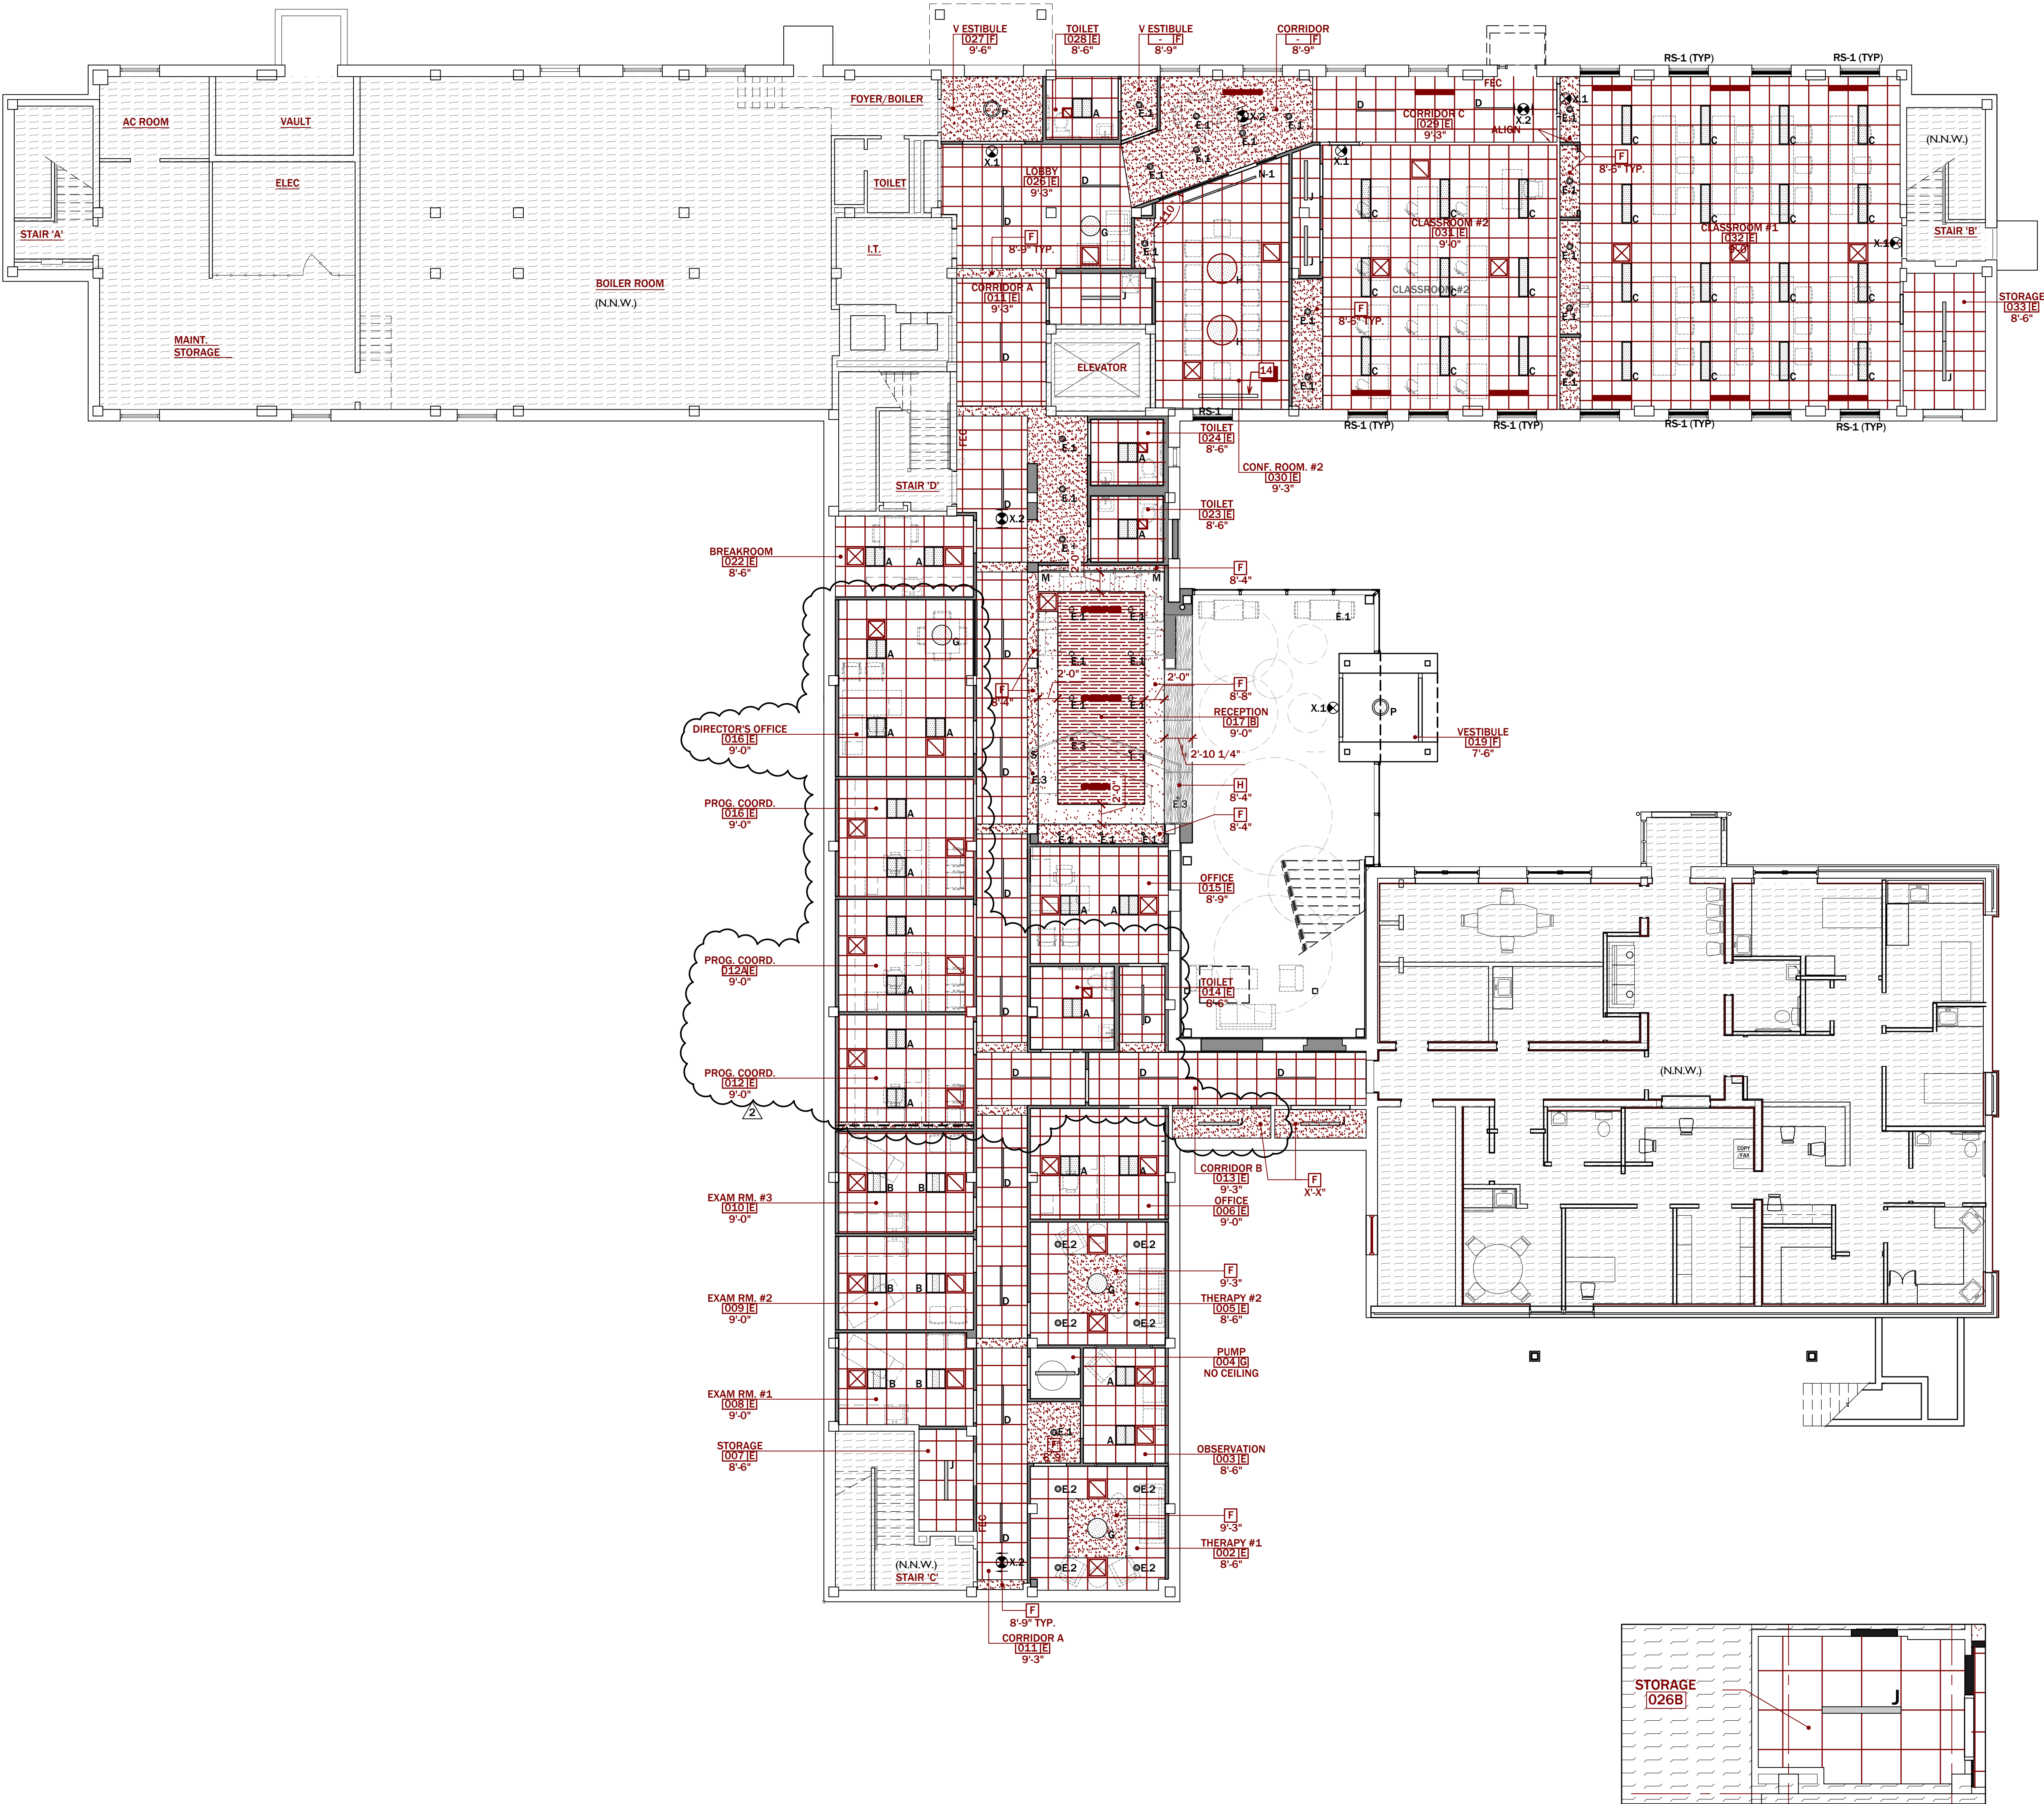

1 GROUND FLOOR PLAN
A2.1 SCALE 1 / 8 " = 1 ' - 0 "

2 STORAGE RCP (ALTERNATE)
A2.1 SCALE 1 / 4 " = 1 ' - 0 "

REFLECTED CEILING PLAN GENERAL NOTES

- ALL A.C.T. TO BE HUNG @ A.F.F. UNLESS OTHERWISE NOTED.
- TYP. A.C.T. STARTING POINT TO BE LOCATED BY CENTERING ONE TILE IN CENTER OF EACH ROOM (UNLESS OTHERWISE NOTED).
- ALL G.W.B. CEILINGS TO BE HUNG @ A.F.F. UNLESS OTHERWISE NOTED.
- ALL CASED OPENING SOFFITS SHALL BE @ A.F.F. UNLESS OTHERWISE NOTED.
- THIS R.C.P. IS FOR LOCATION & COORDINATION PURPOSES OF HVAC AND ELECTRICAL FIXTURES; REFER TO HVAC & ELEC. PLANS FOR FIXTURE TYPE & DESIGNATION.
- CENTER ALL FIXTURES IN ROOMS OR CEILING TILES UNLESS OTHERWISE NOTED.
- ALL OFFICES, CONFERENCE ROOMS, CLASSROOMS, & MULTIPURPOSE ROOM THAT HAVE WINDOWS ARE TO RECEIVE ROLLER SHADES. SEE RCP FOR TYPICAL LOCATIONS OF ROLLER SHADES & FINISH SCHEDULE FOR DETAILS.

REFLECTED CEILING PLAN LEGEND

- GYPSUM BOARD CEILING
- 2X2 ACOUSTICAL CEILING TILE
- NOT IN SCOPE
- EXPOSED CEILINGS
- SUPPLY DIFFUSER - SEE MECHANICAL DRAWINGS
- RETURN REGISTER - SEE MECHANICAL DRAWINGS
- LINEAR SUPPLY DIFFUSER - SEE MECHANICAL DRAWINGS
- ROLLER SHADES - SEE FINISH SCHEDULE FOR MORE DETAILS

ROOM TAG FINISH KEYNOTES

- ACT-1: NOT USED.
- ACT-2: SEE FINISH SCHEDULE FOR MORE DETAILS.
- ACT-3: SEE FINISH SCHEDULE FOR MORE DETAILS.
- ACT-4: SEE FINISH SCHEDULE FOR MORE DETAILS.
- ACT-5: SEE FINISH SCHEDULE FOR MORE DETAILS.
- GYP BD CEILING, PAINTED. SEE FINISH SCHEDULE & FINISH NOTES ON 11.0 SHEETS FOR DETAILS
- EXPOSED CEILING, PAINTED. SEE FINISH SCHEDULE FOR DETAILS
- PL-1 WRAPPED. SEE FINISH SCHEDULE FOR DETAILS

ROOM TAG LEGEND


- ROOM NUMBER
- CEILING TYPE
- ROOM HEIGHT

LIGHT FIXTURE LEGEND

- 'A'_FLUXWERX, RAILS, 2x2
- 'B'_SIGNIFY, DAY-BRITE, 2x2
- 'C'_FLUXWERX, RAILS, 1x4
- 'D'_FOCAL POINT, SEEM 2, LINEAR LED
- 'E.1'_FOCAL POINT, ID+, 3.5" DOWNLIGHT, G.W.B. & DECORATIVE CEILING PANELS
- 'E.2'_FOCAL POINT, ID+, 3.5" DOWNLIGHT, ACT
- 'E.3'_FOCAL POINT, ID+, 3.5" DOWNLIGHT, RECEPTION DESK, DIFFERENT OPTICS?
- 'F.1'_LIGHTOLIER, C3C, CALCULITE, 3" CYLINDER, STEM MNT.
- 'F.2'_LIGHTOLIER, C6, CALCULITE, 6" CYLINDER, STEM MNT.
- 'G'_FOCAL POINT, SKYDOME EDGE, 2" DIA
- 'H'_LUMOS, MINI PROFILE RING UP + DOWN LIGHT, 3" DIA
- 'J'_DAY-BRITE, 4" or 8" SURFACE MNT. STORAGE ROOM LINEAR
- 'K'_ELIO, LOOK OUTER ETCHED, BACKLIT MIRROR
- 'L'_LIGHTOLIER, PENDANT MNT. ADJ. LED TRACKLIGHT
- 'M'_6", VODE, WINGRAIL, CEILING-WALL ARM
- 'N'_FOCALPOINT, SEEM 1, LINEAR LED
- 'P'_FLUXWERX, PORTAL SURFACE 9", ADJ. LED
- 'Q'_GARDCO, EXTERIOR WALL PACK, SMALL PROFILE LED
- 'R'_VISIONEERING, LR7A-WET LOCATION, 2x2
- 'S'_MP LIGHTING, 106S, LINEAR LED, CONCEALED IN MILLWORK
- 'T'_LUMIGRID ASTRA, T.L.S. SINGLE SIDED, BACKLIGHTING FOR STAINED GLASS
- 'X.1'_EXIT SIGN, EDGE LIT, WALL MNT., RED LETTERS, SINGLE FACE and/or DIRECTIONAL
- 'X.2'_EXIT SIGN, EDGE LIT, CEILING MNT., RED LETTERS, SINGLE/DOUBLE FACE and/or DIRECTIONAL

REFLECTED CEILING PLAN KEYNOTES

- SCHEDULED CEILING PANEL, 3'-0" DIAMETER
- SCHEDULED CEILING PANEL, 4'-0" DIAMETER
- SCHEDULED CEILING PANEL, 5'-0" DIAMETER
- SCHEDULED CEILING PANEL, 6'-0" DIAMETER
- SCHEDULED CEILING PANEL, 8'-0" DIAMETER
- SCHEDULED CEILING PANEL, 12'-0" DIAMETER
- SCHEDULED CEILING PANEL, 24'-0" DIAMETER
- LINE OF SCHEDULED DUCT, GC TO COORDINATE INTERFACE WITH SCHEDULED CEILING PANELS, STRUCTURAL ELEMENTS, ETC. COORDINATE ALL CLEARANCES REQUIRED FOR THE VARIOUS CEILING/MEP ITEMS AND REPORT ANY DISCREPANCIES TO THE ARCHITECT IF/AS THEY OCCUR
- SCHEDULED LIGHT FIXTURE AND/OR MEP DEVICE IN ROOM BELOW
- SCHEDULED SOLAR SHADE. SEE FINISH SCHEDULE, SPECS AND DETAILS ON SHEET A9.2/A9.4 FOR MORE INFORMATION
- SCHEDULED BLACKOUT SHADE. SEE FINISH SCHEDULE, SPECS AND DETAILS ON SHEET A9.4 FOR MORE INFORMATION
- SCHEDULED PROJECTION SCREEN. SEE SPECS AND DETAILS ON SHEET A9.2/A9.4 FOR MORE INFORMATION
- CEILING J-BOX TO POWER ELECTRIC SHADES. SEE MEP DRAWINGS FOR MORE INFORMATION
- SCHEDULED PROJECTION SCREEN FOR CONFERENCE ROOM, PURCHASED BY OWNER'S IT DEPT

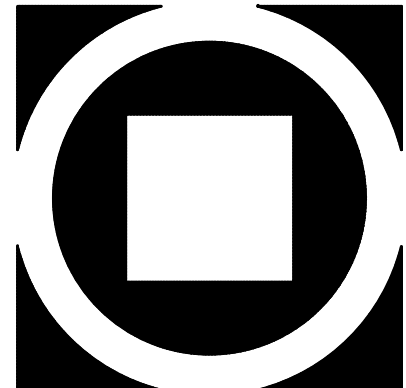

KIMMEL BOGRETTE
Architecture + Site
Blue Bell, PA 19422
482 N. 2nd Street, Suite 200
Phone: 610.834.7805
Fax: 610.834.7815
© COPYRIGHT 2021 KIMMEL BOGRETTE ARCHITECTURE + SITE, INC. ALL RIGHTS RESERVED

MOUNT SAINT MARY COLLEGE, GUZMAN HALL
COMMUNITY WELLNESS CENTER
330 POWELL AVE.
NEWBURGH, NY 12550

Bid Issue Date:
8.9.2021
Drawn By:
SLJ/MSP
Checked By:
JHL/G
Scale:

Sheet Name: REFLECTED CEILING PLAN
Progress Prints:
Revisions:
Bid Revision #2 - 11.22.21

A6.1