


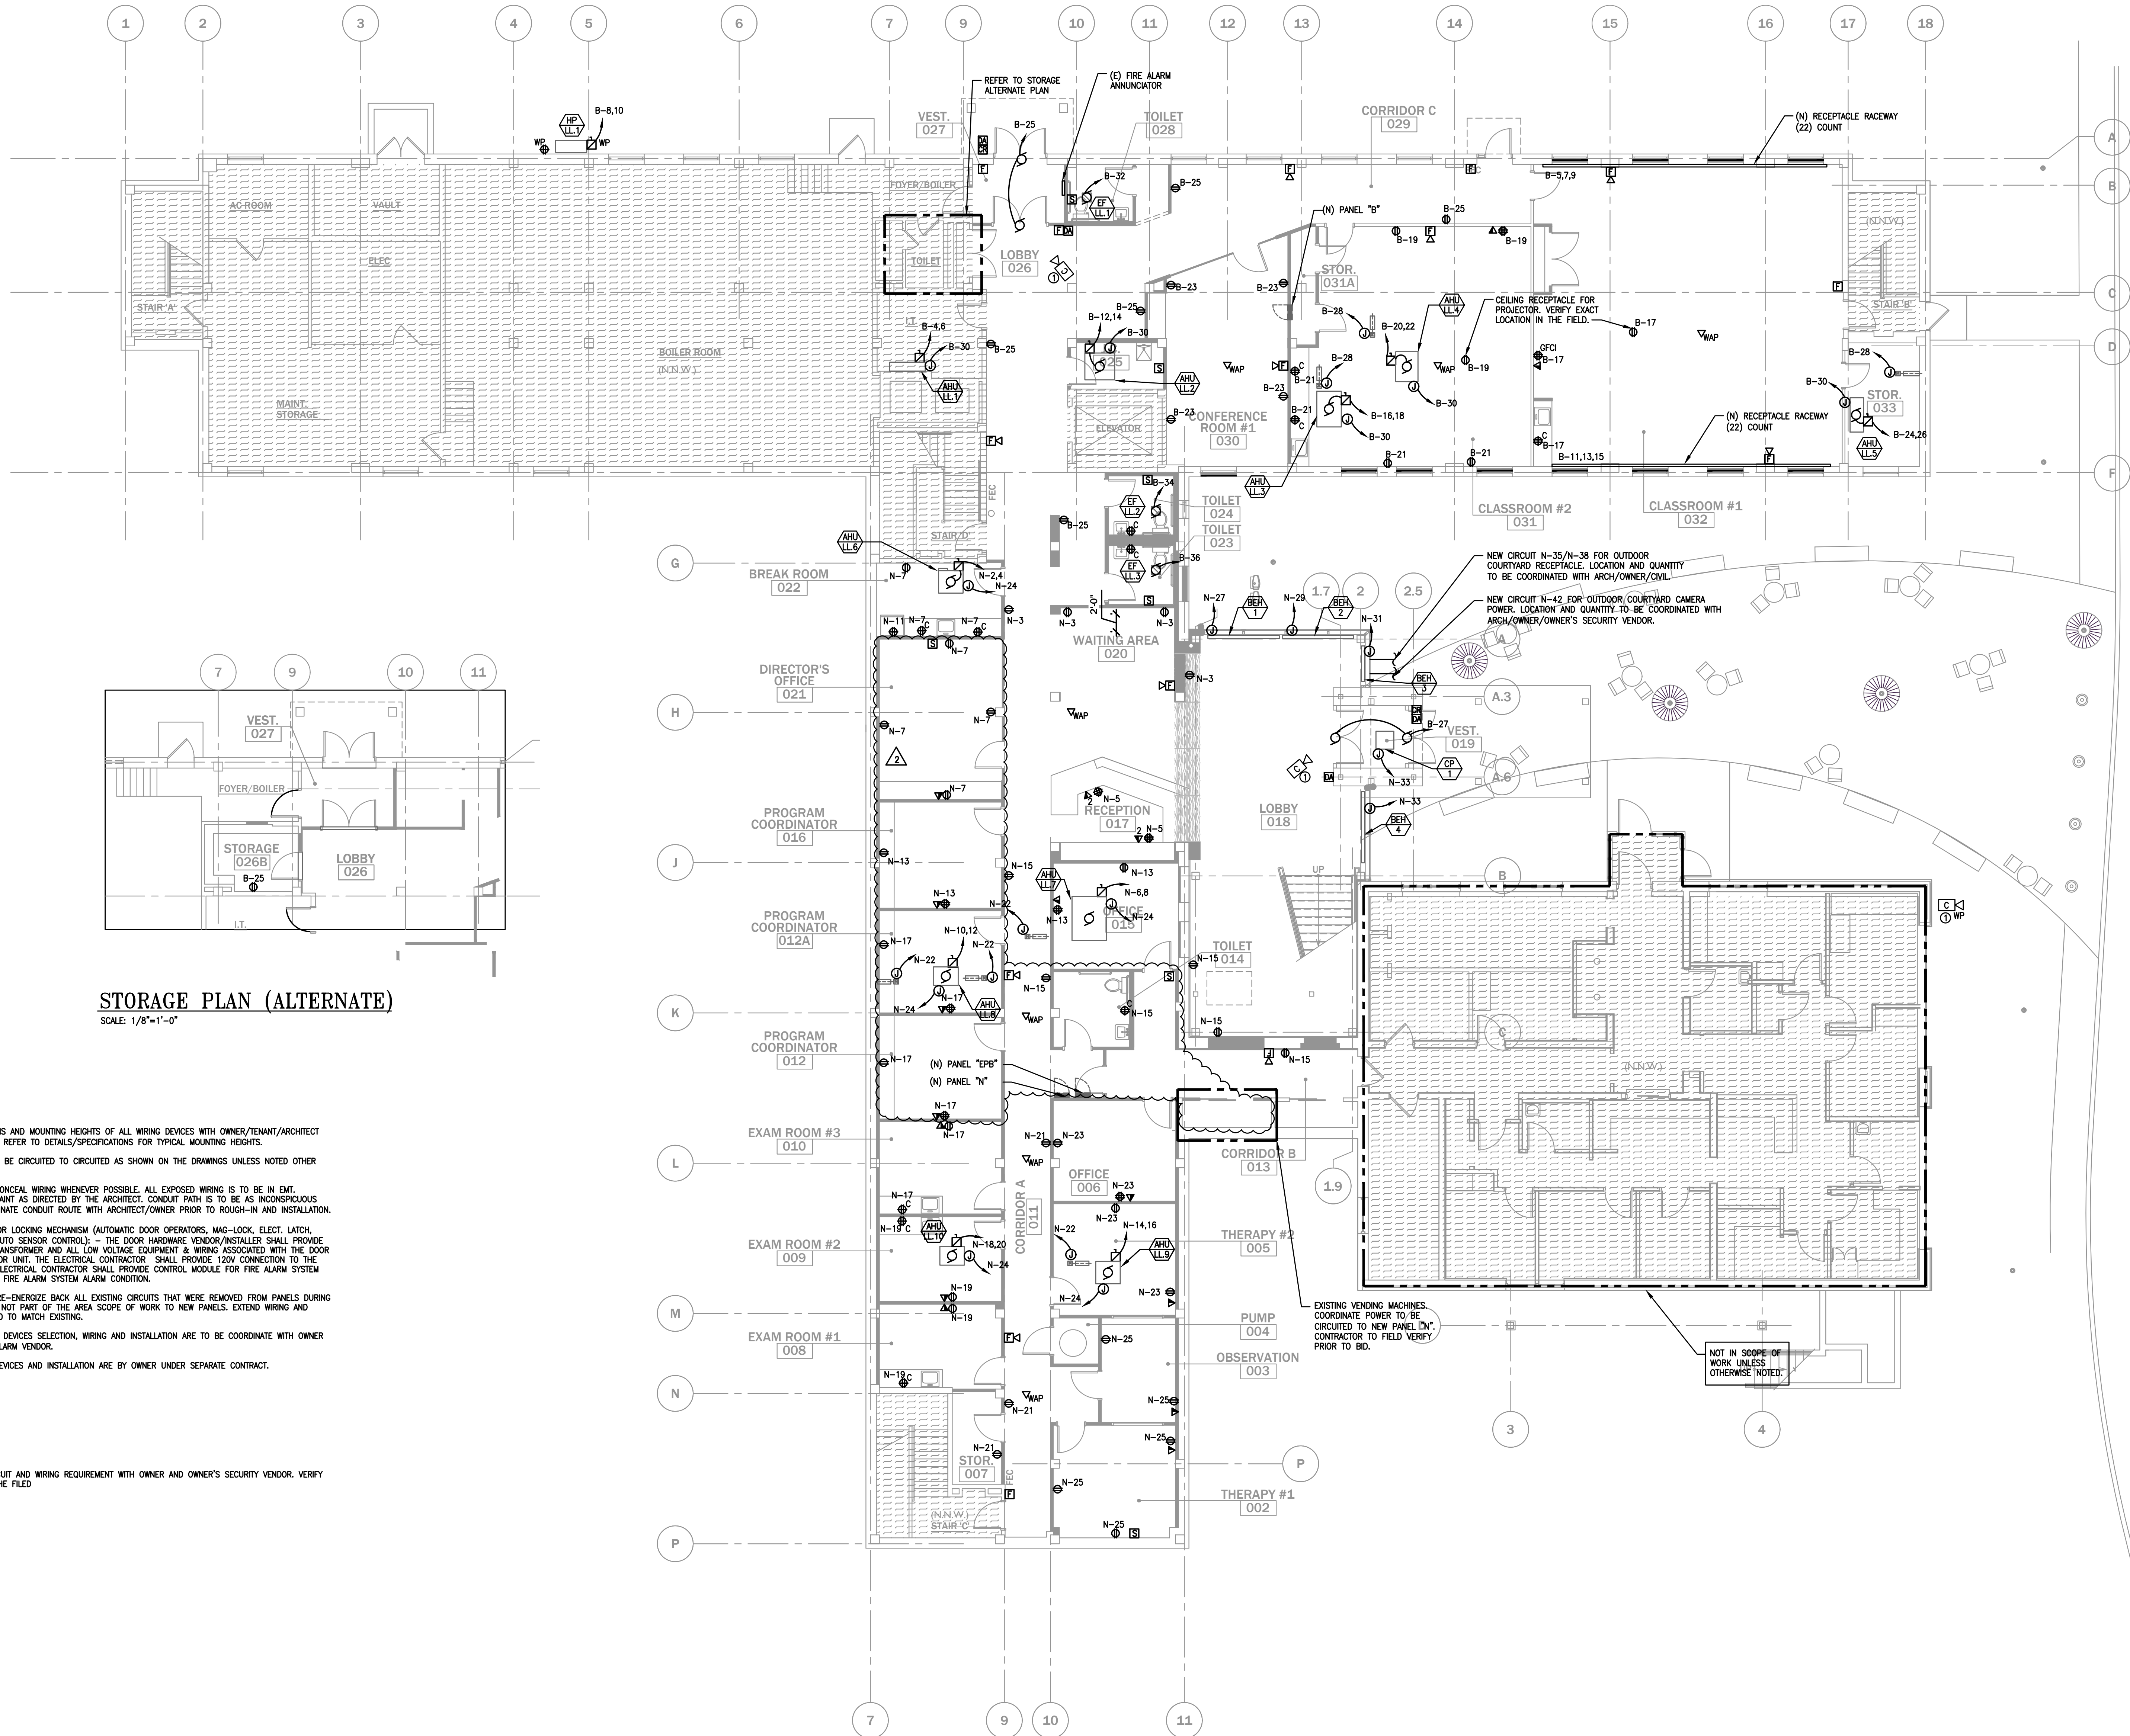

STORAGE PLAN (ALTERNATE)
SCALE: 1/8"=1'-0"

GROUND FLOOR - POWER PLAN
SCALE: 1/8"=1'-0"

THE DELIVERY OF THIS DRAWING SHOULD NOT BE CONSTRUED TO PROVIDE AN EXPRESS WARRANTY OR GUARANTEE TO ANYONE THAT ALL THE DIMENSIONS AND DETAILS ARE EXACT OR TO INDICATE THAT THE USE OF THIS DRAWING IMPLIES THE REVIEW AND APPROVAL BY THE DESIGN PROFESSIONAL OF ANY FUTURE USE. ANY USE OF THIS INFORMATION WITHOUT THE WRITTEN APPROVAL BY THE DESIGN PROFESSIONAL IS AT THE SOLE RISK AND LIABILITY OF THE USER. THE DESIGN PROFESSIONAL RESERVES THE RIGHT TO REMOVE OUR PROFESSIONAL SEAL AND/OR TITLE BLOCK.

NOTICE
THE SCHEDULES AND DRAWINGS REPRESENT ONLY CERTAIN REQUIREMENTS OF THE PROJECT. THERE ARE ADDITIONAL REQUIREMENTS IN THE SPECIFICATIONS BOOKLET WHICH THE CONTRACTOR IS BOUND TO PROVIDE. A SUPPLIER OR CONTRACTOR'S PRICING, WHICH IS BASED ONLY ON DRAWINGS OR SCHEDULES, MAY LEAVE IMPORTANT COSTS UNACCOUNTED FOR WHICH WILL ULTIMATELY BE THE CONTRACTOR OR SUPPLIER'S RESPONSIBILITY TO PROVIDE.

- ELECTRICAL NOTES:**
- COORDINATE LOCATIONS AND MOUNTING HEIGHTS OF ALL WIRING DEVICES WITH OWNER/TENANT/ARCHITECT PRIOR TO ROUGH-IN. REFER TO DETAILS/SPECIFICATIONS FOR TYPICAL MOUNTING HEIGHTS.
 - ALL CIRCUITS ARE TO BE CIRCUITED TO CIRCUITED AS SHOWN ON THE DRAWINGS UNLESS NOTED OTHER WISE.
 - CONTRACTOR IS TO CONCEAL WIRING WHENEVER POSSIBLE. ALL EXPOSED WIRING IS TO BE IN EMT. CONTRACTOR IS TO PAINT AS DIRECTED BY THE ARCHITECT. CONDUIT PATH IS TO BE AS INCONSPICUOUS AS POSSIBLE. COORDINATE CONDUIT ROUTE WITH ARCHITECT/OWNER PRIOR TO ROUGH-IN AND INSTALLATION.
 - CONNECTIONS TO DOOR LOCKING MECHANISM (AUTOMATIC DOOR OPERATORS, MAG-LOCK, ELECT. LATCH, ELECTRICAL STRIKE, AUTO SENSOR CONTROL) - THE DOOR HARDWARE VENDOR/INSTALLER SHALL PROVIDE THE LOW VOLTAGE TRANSFORMER AND ALL LOW VOLTAGE EQUIPMENT & WIRING ASSOCIATED WITH THE DOOR FOR A COMPLETE DOOR UNIT. THE ELECTRICAL CONTRACTOR SHALL PROVIDE 120V CONNECTION TO THE TRANSFORMER. THE ELECTRICAL CONTRACTOR SHALL PROVIDE CONTROL MODULE FOR FIRE ALARM SYSTEM DOOR RELEASE UPON FIRE ALARM SYSTEM ALARM CONDITION.
 - CONTRACTOR SHALL RE-ENERGIZE BACK ALL EXISTING CIRCUITS THAT WERE REMOVED FROM PANELS DURING DEMOLITION BUT ARE NOT PART OF THE AREA SCOPE OF WORK TO NEW PANELS. EXTEND WIRING AND CONDUIT AS REQUIRED TO MATCH EXISTING.
 - ALL NEW FIRE ALARM DEVICES SELECTION, WIRING AND INSTALLATION ARE TO BE COORDINATE WITH OWNER AND OWNER'S FIRE ALARM VENDOR.
 - ALL NEW SECURITY DEVICES AND INSTALLATION ARE BY OWNER UNDER SEPARATE CONTRACT.

- KEYNOTES:**
- ① COORDINATE ANY CIRCUIT AND WIRING REQUIREMENT WITH OWNER AND OWNER'S SECURITY VENDOR. VERIFY EXACT LOCATION IN THE FIELD

KIMMEL BOGRETTE
Architecture + Site
482 Morrisown Road, Suite 200
Blue Bell, PA 19422
Phone: 610.834.7805
Facsimile: 610.834.7815
© COPYRIGHT 2021 KIMMEL BOGRETTE ARCHITECTURE + SITE, INC. ALL RIGHTS RESERVED

McHUGH
ENGINEERING ASSOCIATES, INC.
1250 Appleton Road, Suite 200
Bryn Mawr, PA 19003
Phone: 610.353.2222
Fax: 610.353.2223

**MOUNT SAINT MARY COLLEGE, GUZMAN HALL
COMMUNITY WELLNESS CENTER**

330 POWELL AVE.
NEWBURGH, NY 12550

Construction Issue Date:	Drawn By: AFM/PZ/PR	Checked By:	Scale: AS NOTED
Progress Prints:	Bid Set 08/09/21		
Revisions:			
	Δ Bid Revision #2 11/22/21		

Sheet Name: GROUND FLOOR PLAN -
POWER - ELECTRICAL

Revisions:

E1.3