




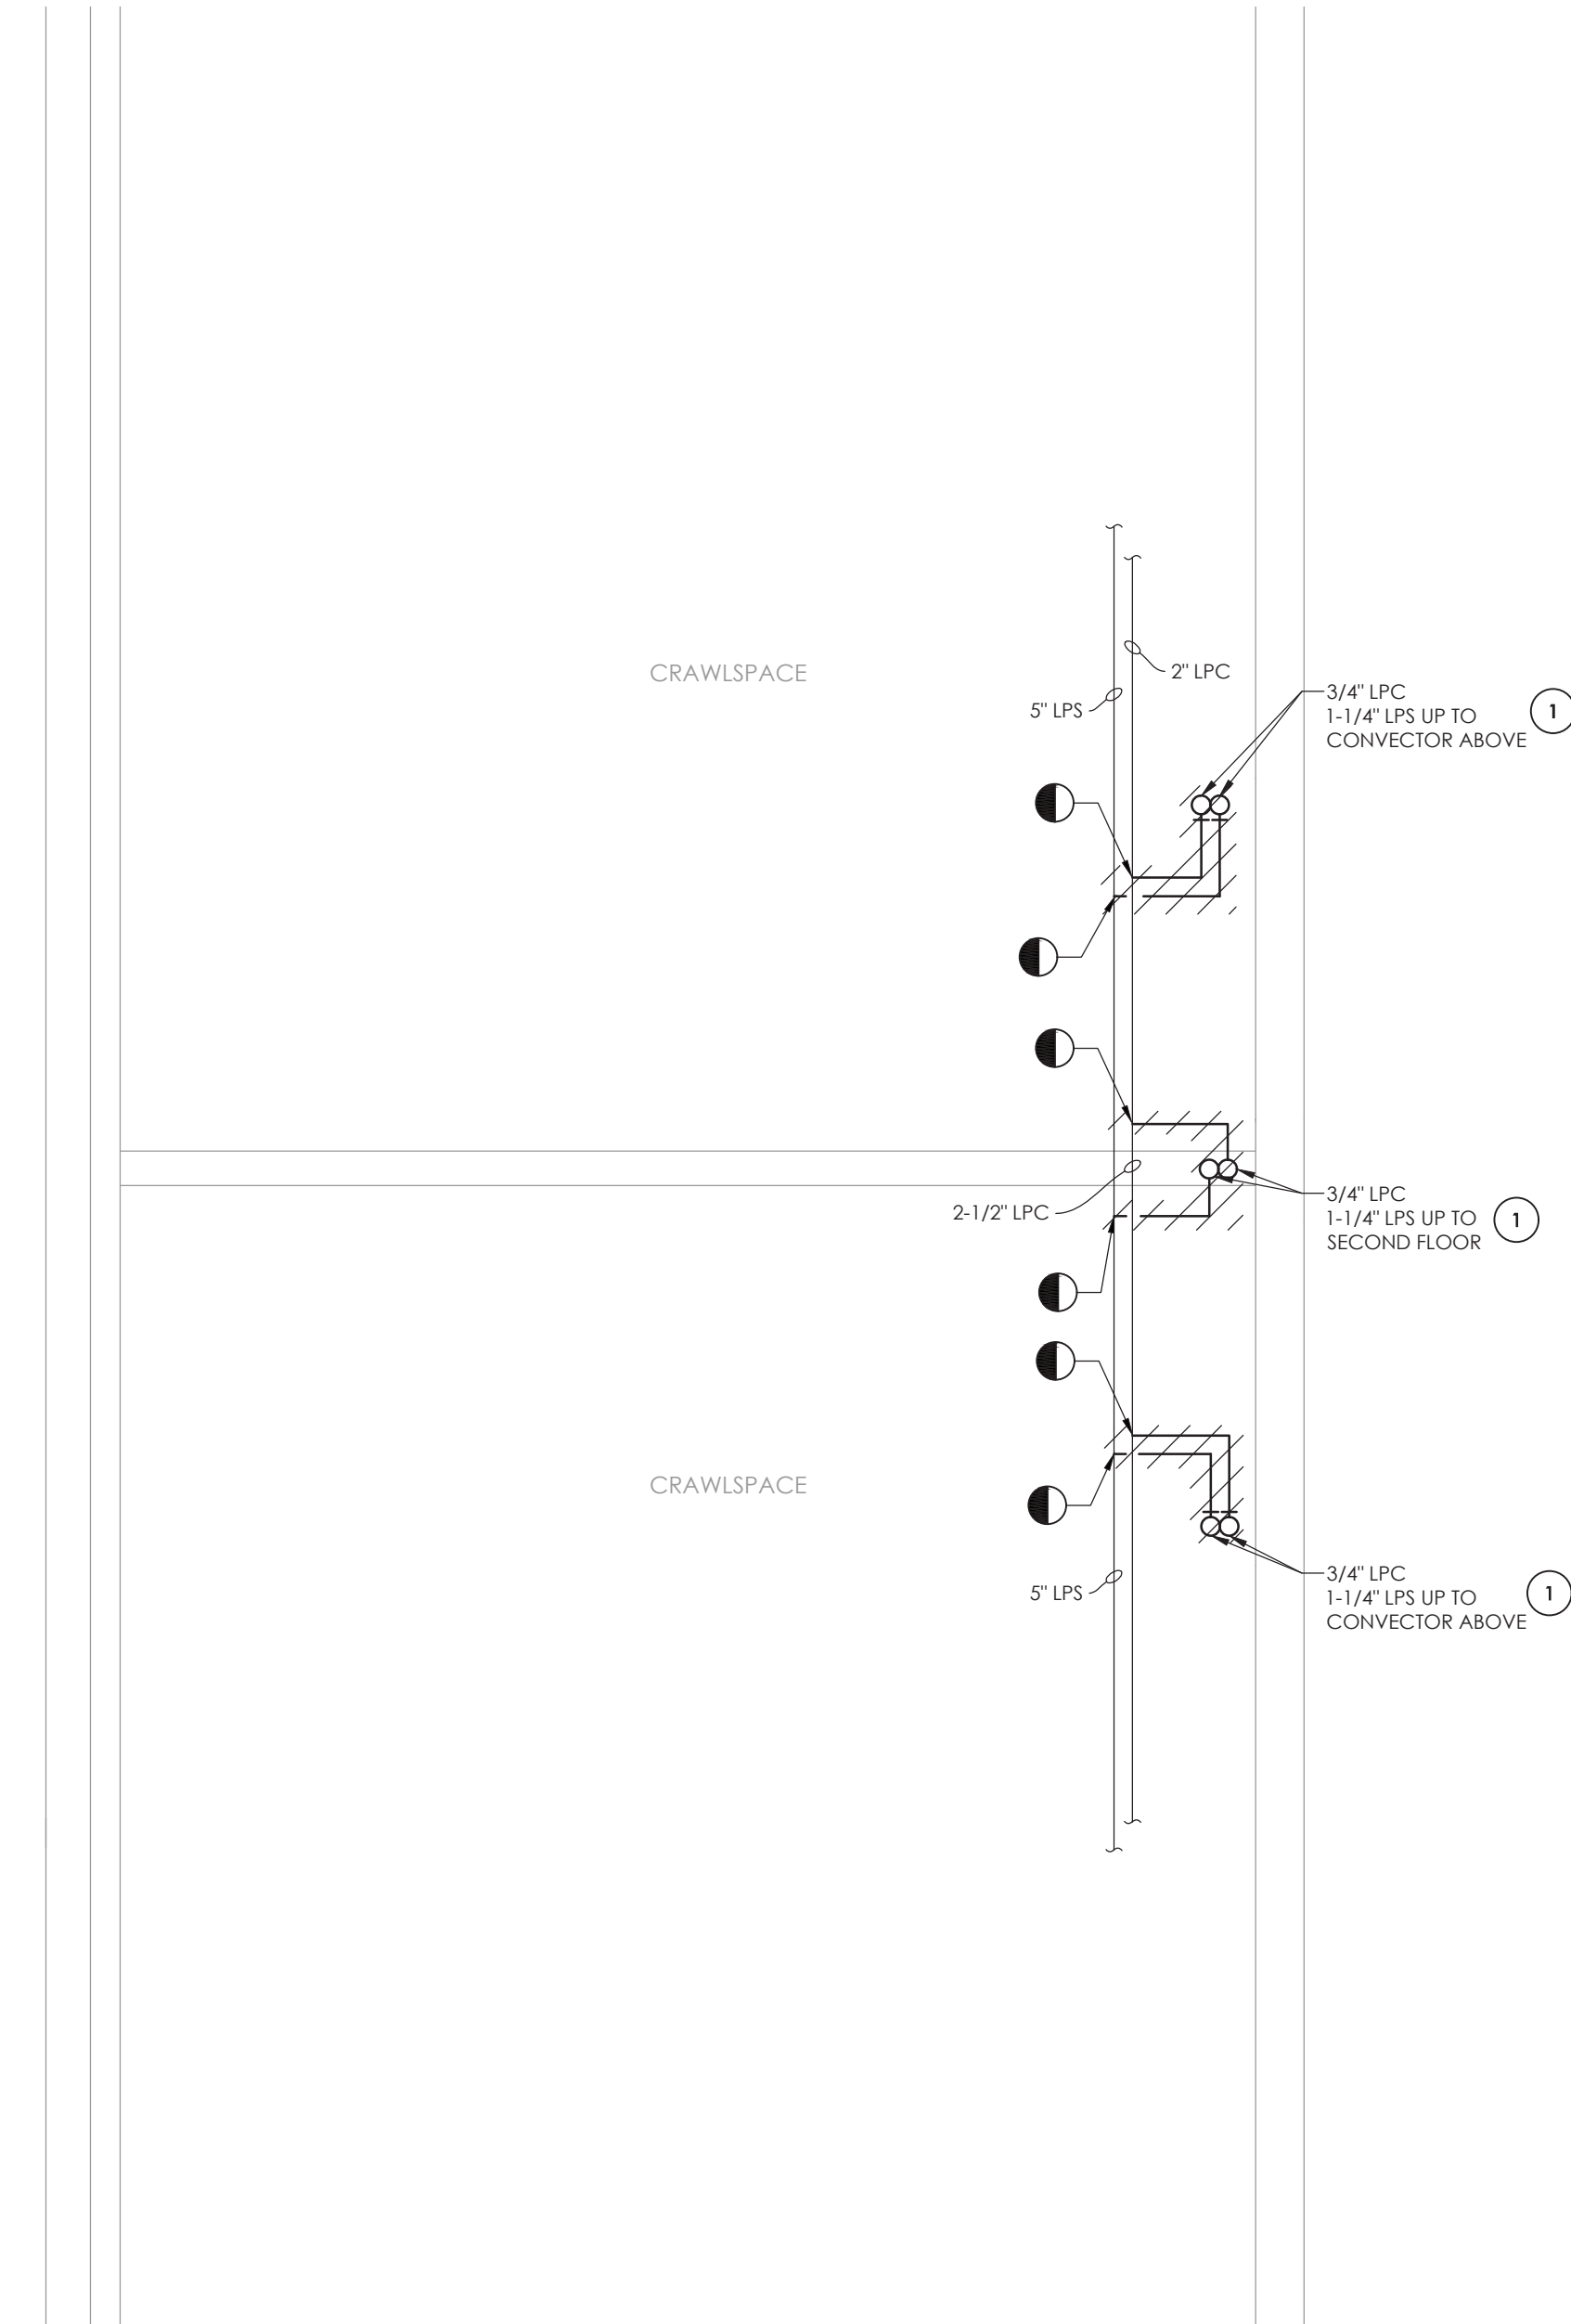


1 CRAWLSPACE BELOW T-1 AND T-2 HVAC DEMOLITION PLAN
SCALE: 1/4" = 1'-0"

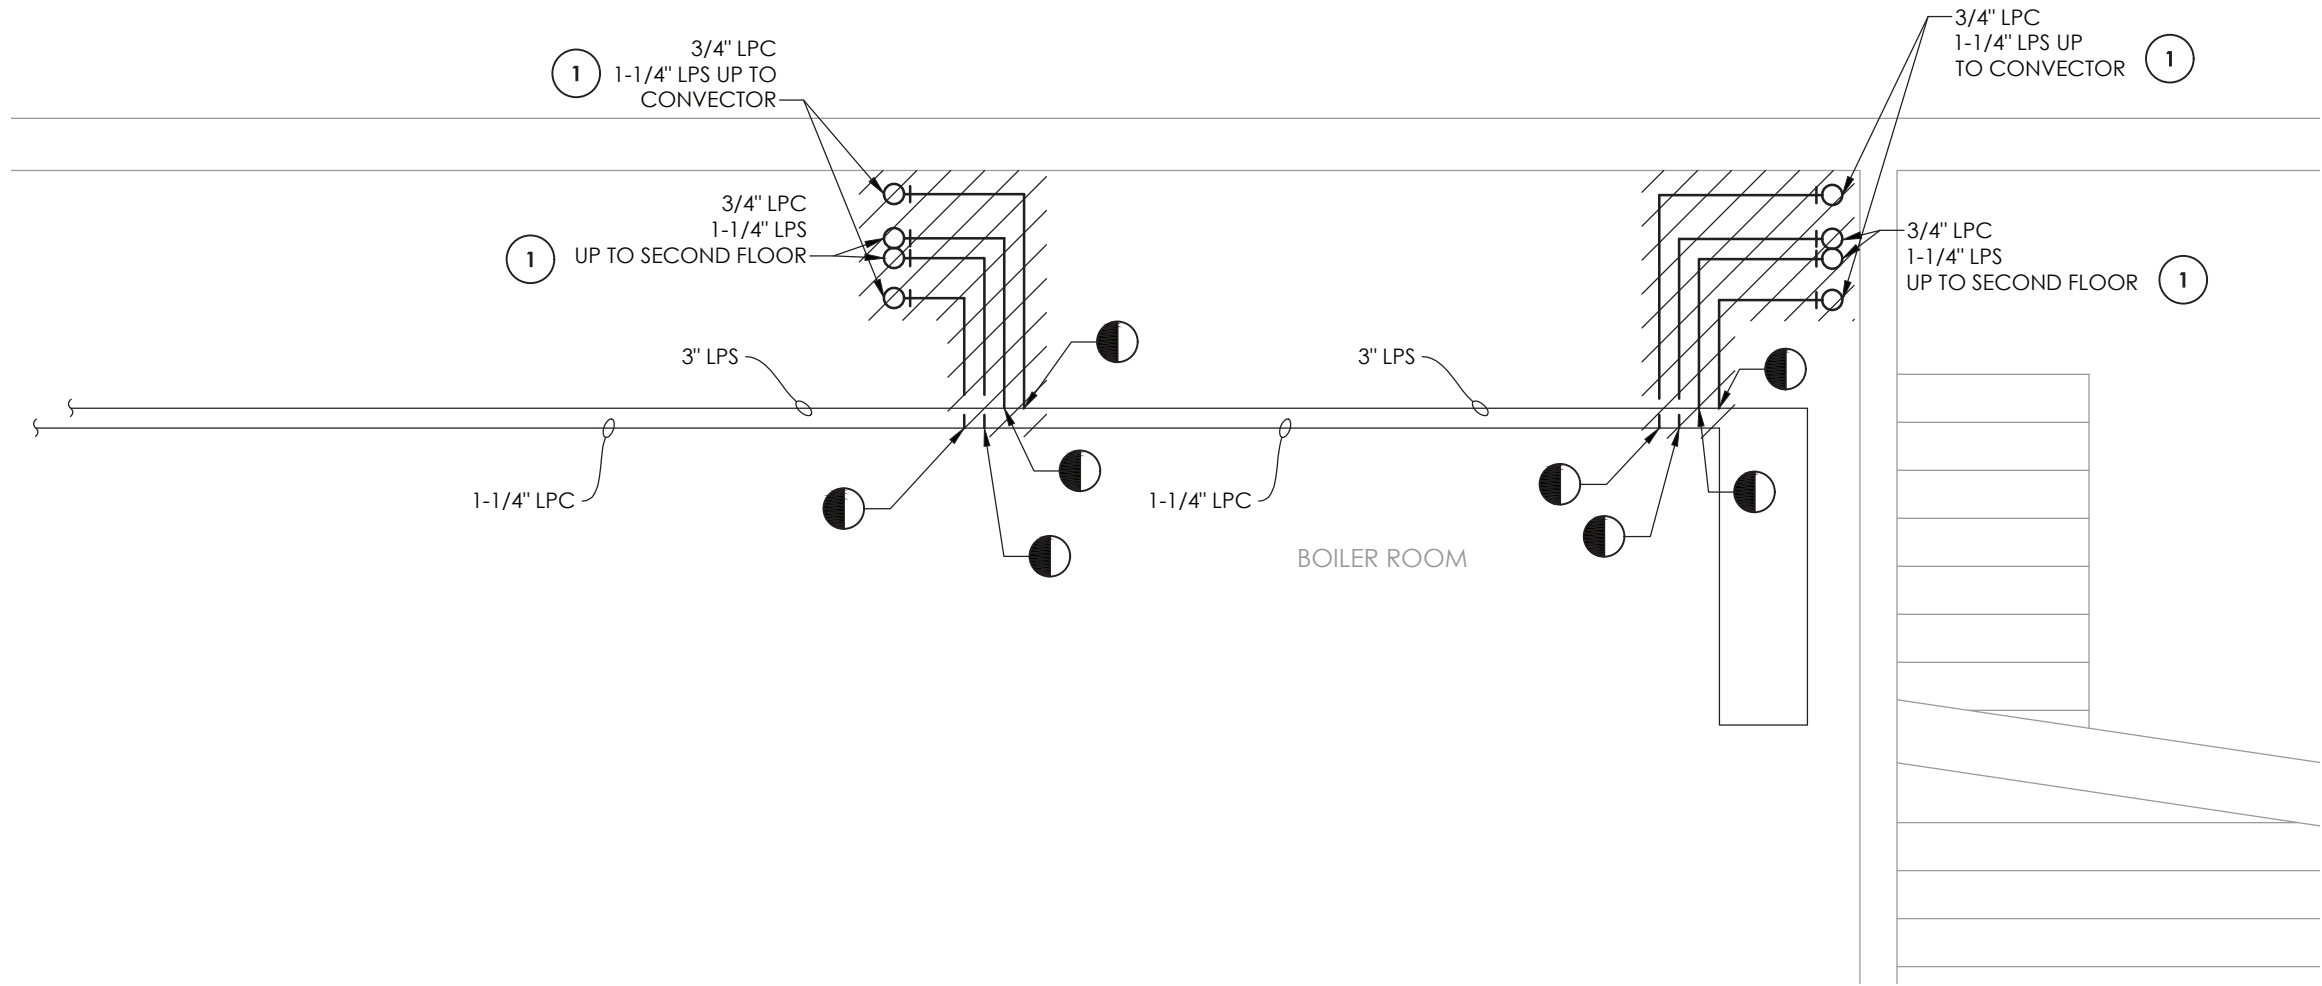

2 BOILER ROOM BELOW T-11 AND T-12 HVAC DEMOLITION PLAN
SCALE: 1/4" = 1'-0"

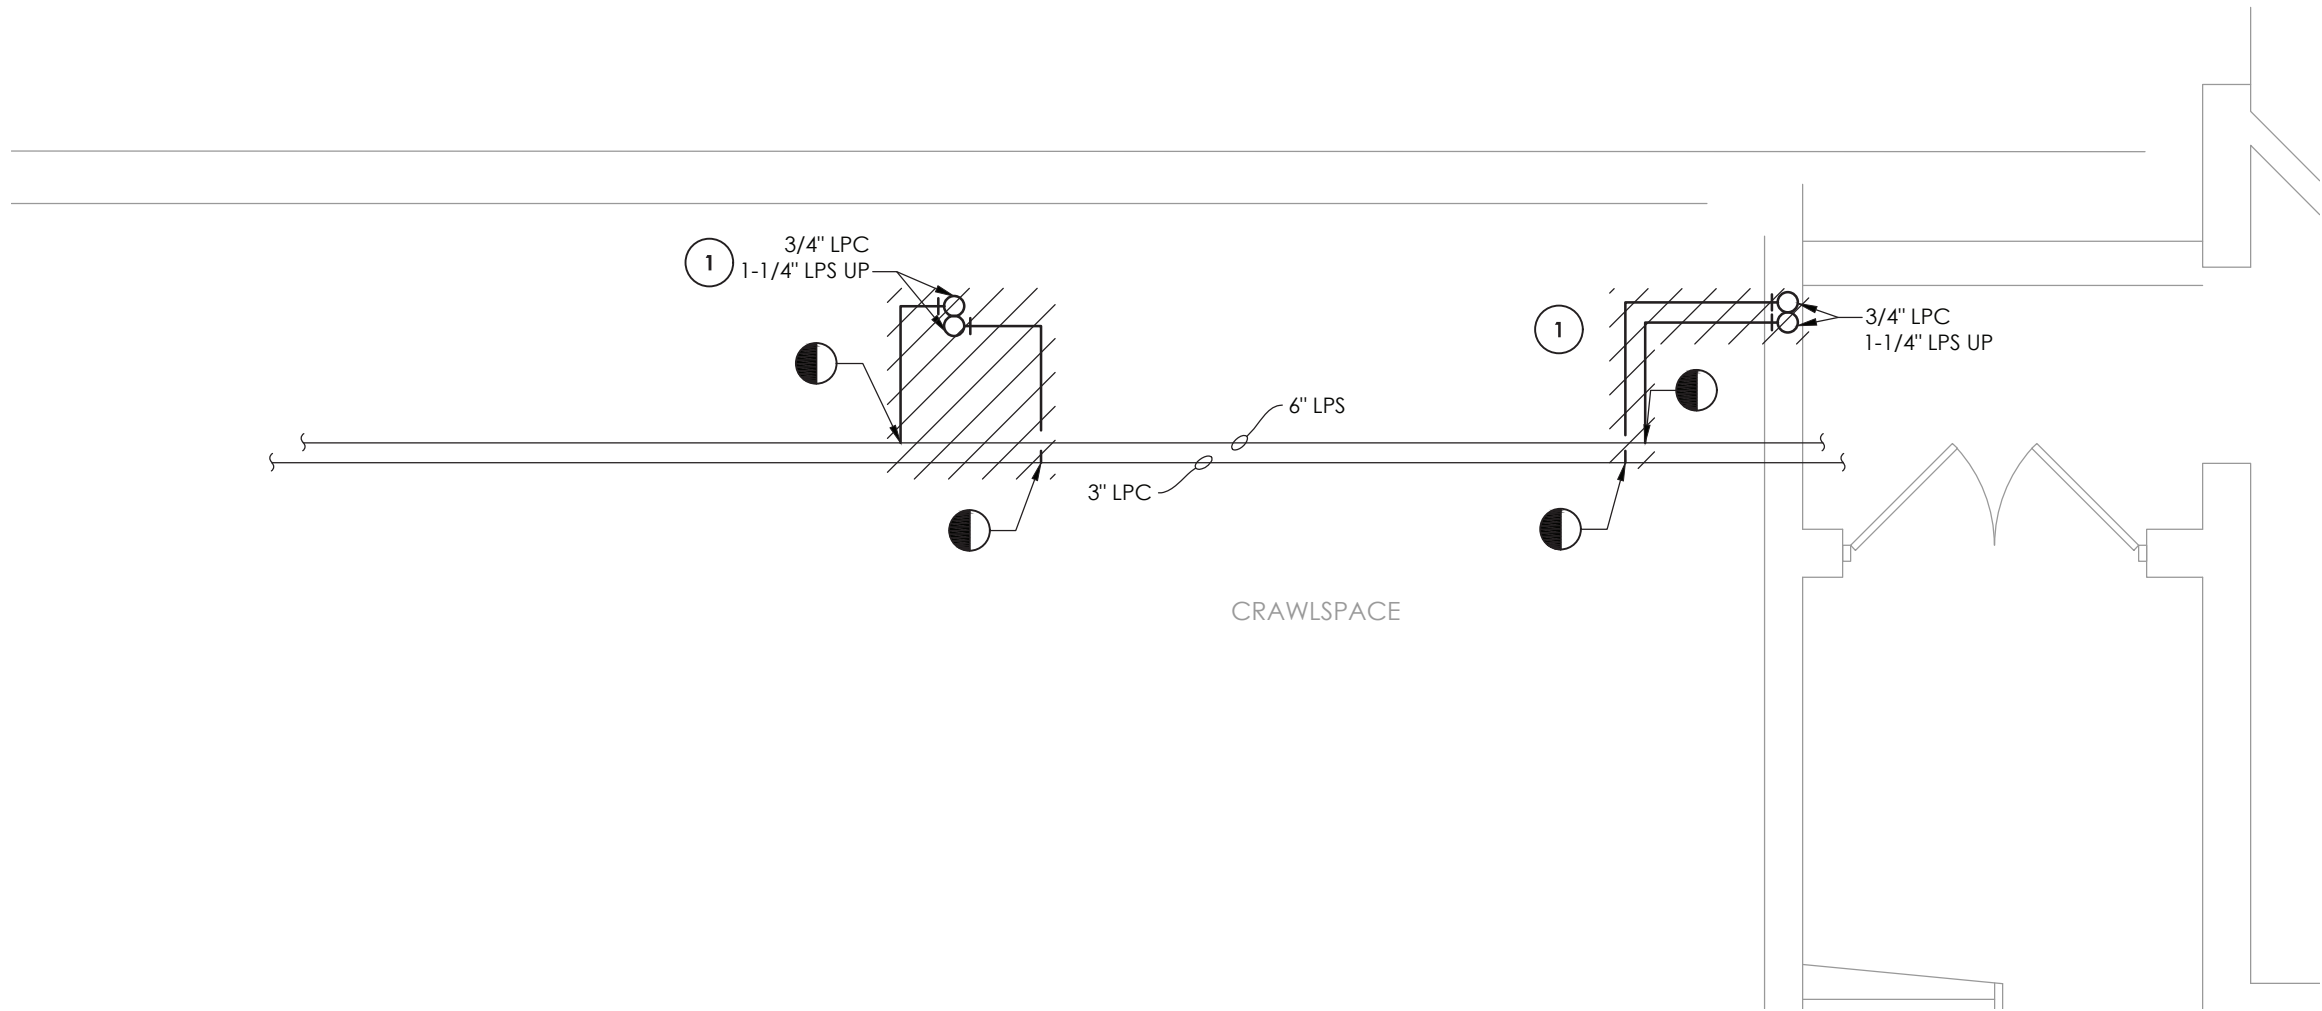

3 CRAWLSPACE BELOW T-15 AND T-16 HVAC DEMOLITION PLAN
SCALE: 1/4" = 1'-0"

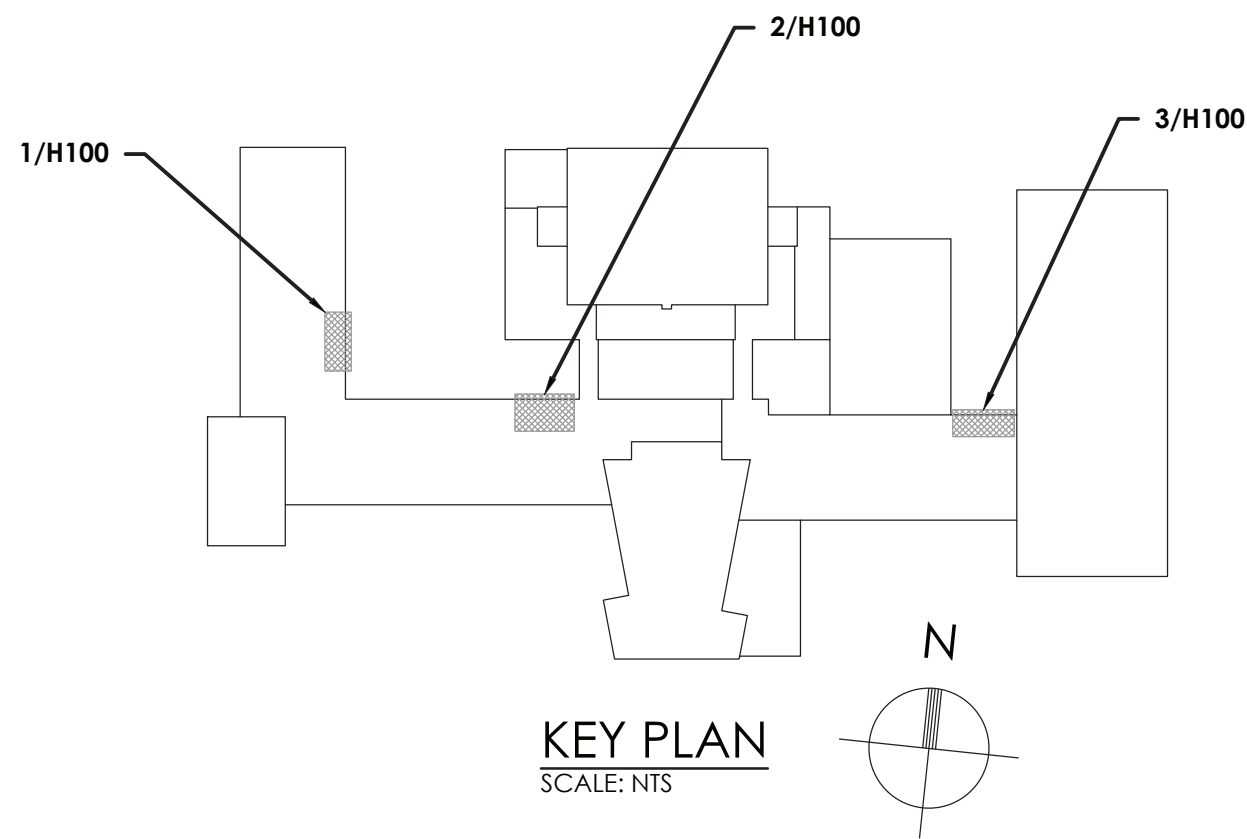

KEY NOTES:
1 REMOVE EXISTING STEAM AND CONDENSATE PIPING BACK TO MAIN.
PREPARE FOR NEW WORK.

CPL
CPLteam.com
ARCHITECTURE • ENGINEERING • PLANNING
50 FRONT STREET, SUITE 202
NEWBURGH, NEW YORK 12550
TEL (800) 274-9000

REVISIONS	NO.	DATE	BY	DESCRIPTION




POUGHKEEPSIE CITY SCHOOL DISTRICT
2020 CAPITAL IMPROVEMENT PROJECT
PHASE 1B: BUILDING IMPROVEMENTS


- POUGHKEEPSIE HIGH SCHOOL: SED# 13-15-00-01-0-007-018
- POUGHKEEPSIE MIDDLE SCHOOL: SED# 13-15-00-01-0-008-021
- POUGHKEEPSIE JUNIOR HIGH SCHOOL: SED# 13-15-00-01-0-009-024
- KREGER ELEMENTARY SCHOOL: SED# 13-15-00-01-0-004-014
- MORSE ELEMENTARY SCHOOL: SED# 13-15-00-01-0-002-014
- WARRING ELEMENTARY SCHOOL: SED# 13-15-00-01-0-005-013
- WARRING ELEMENTARY SCHOOL: SED# 13-15-00-01-0-006-014
- WARRING ELEMENTARY SCHOOL: SED# 13-15-00-01-0-001-014

DATE	DRAWN	CHECKED
10/20/2021	BKM	AJS
SCALE	AS NOTED	
SHEET TITLE	HIGH SCHOOL CRAWLSPACE HVAC DEMOLITION PLANS	


PROJECT NUMBER
14078.09
PHS
H100
DRAWING NUMBER

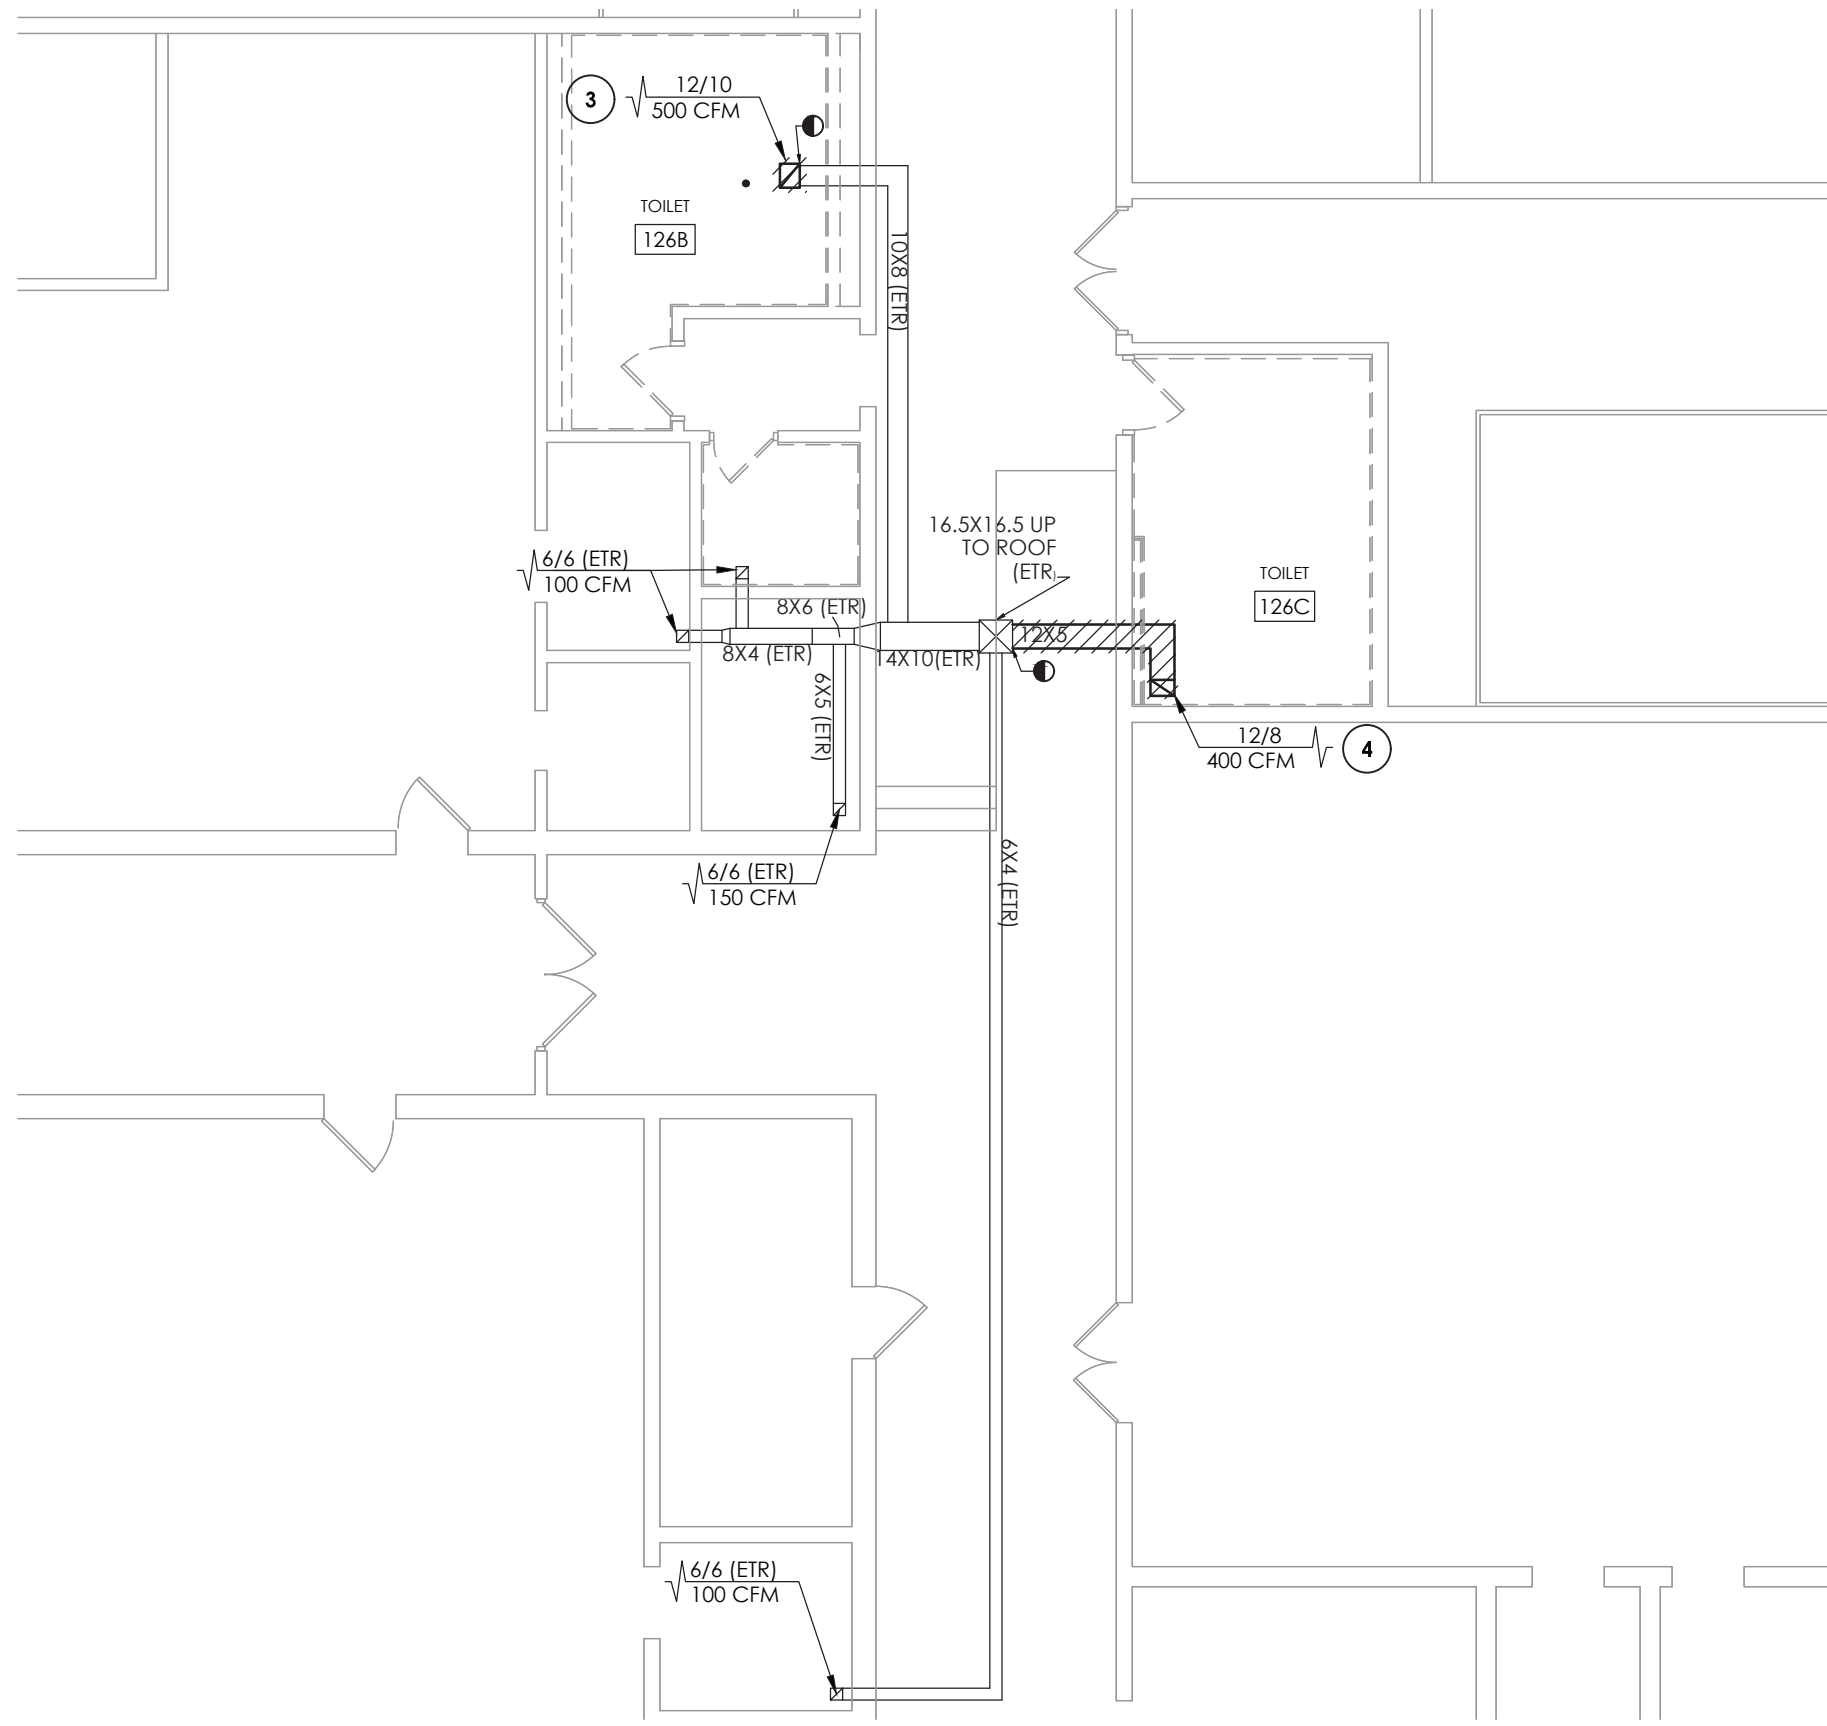


1
H101A
TOILET ROOMS T-9 AND T-10 DEMOLITION PLAN
SCALE: 1/8" = 1'-0"

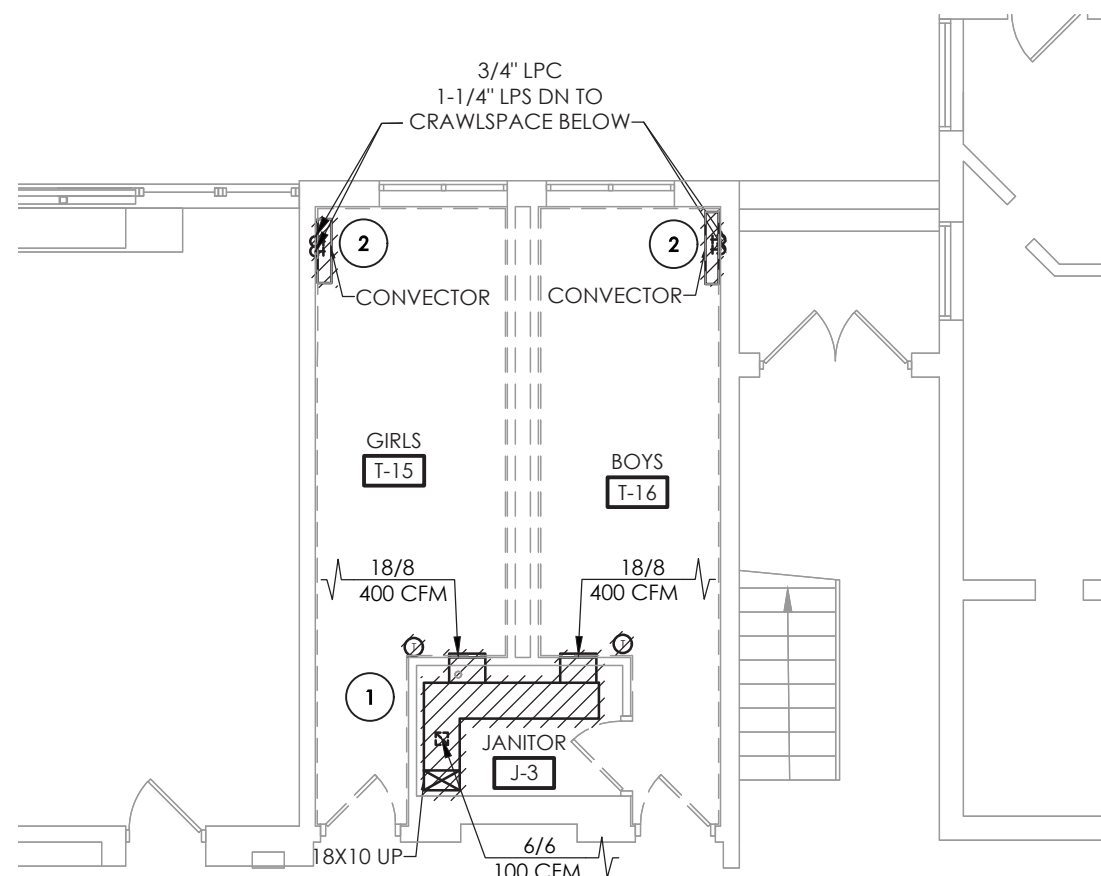


5
H101A
TOILET ROOMS T-15 AND T-16 DEMOLITION PLAN
SCALE: 1/8" = 1'-0"

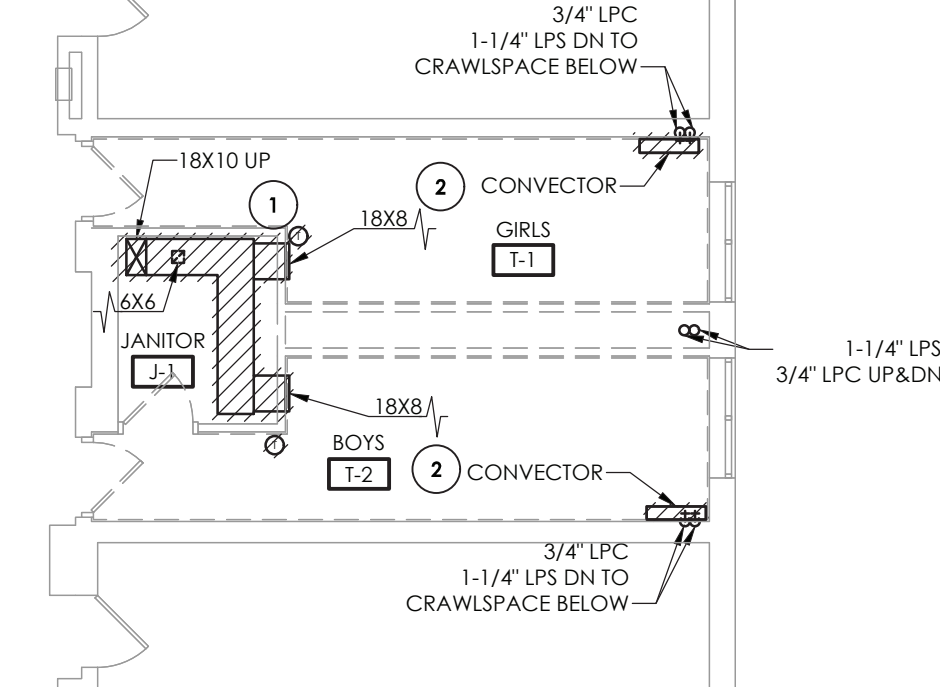

2
H101A
TOILET ROOMS T-1 AND T-2 DEMOLITION PLAN
SCALE: 1/8" = 1'-0"

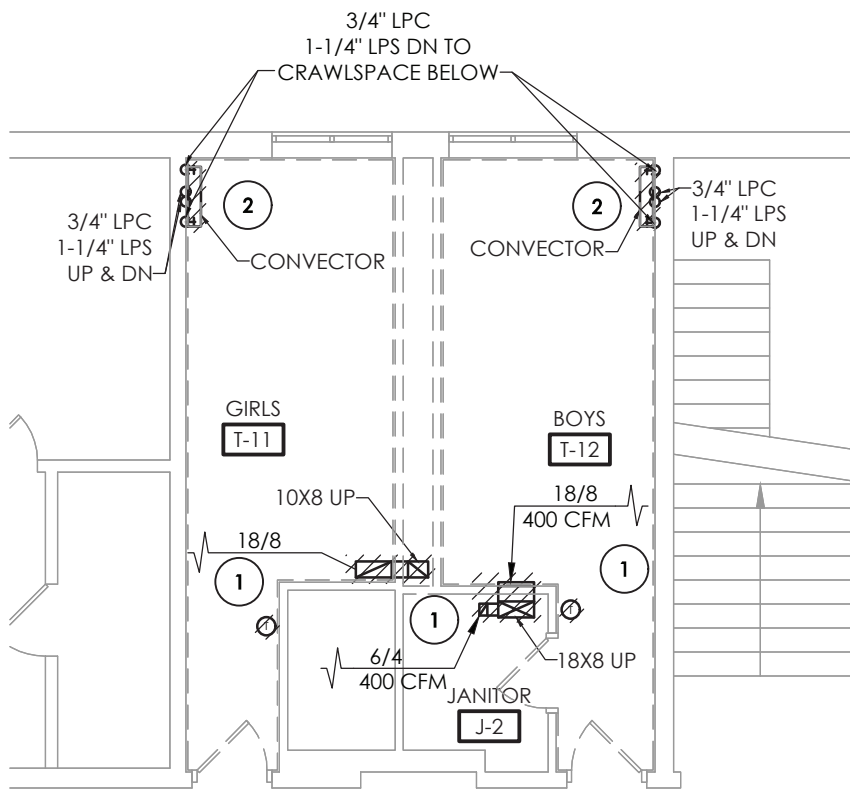


3
H101A
TOILET ROOMS T-11 AND T-12 DEMOLITION PLAN
SCALE: 1/8" = 1'-0"

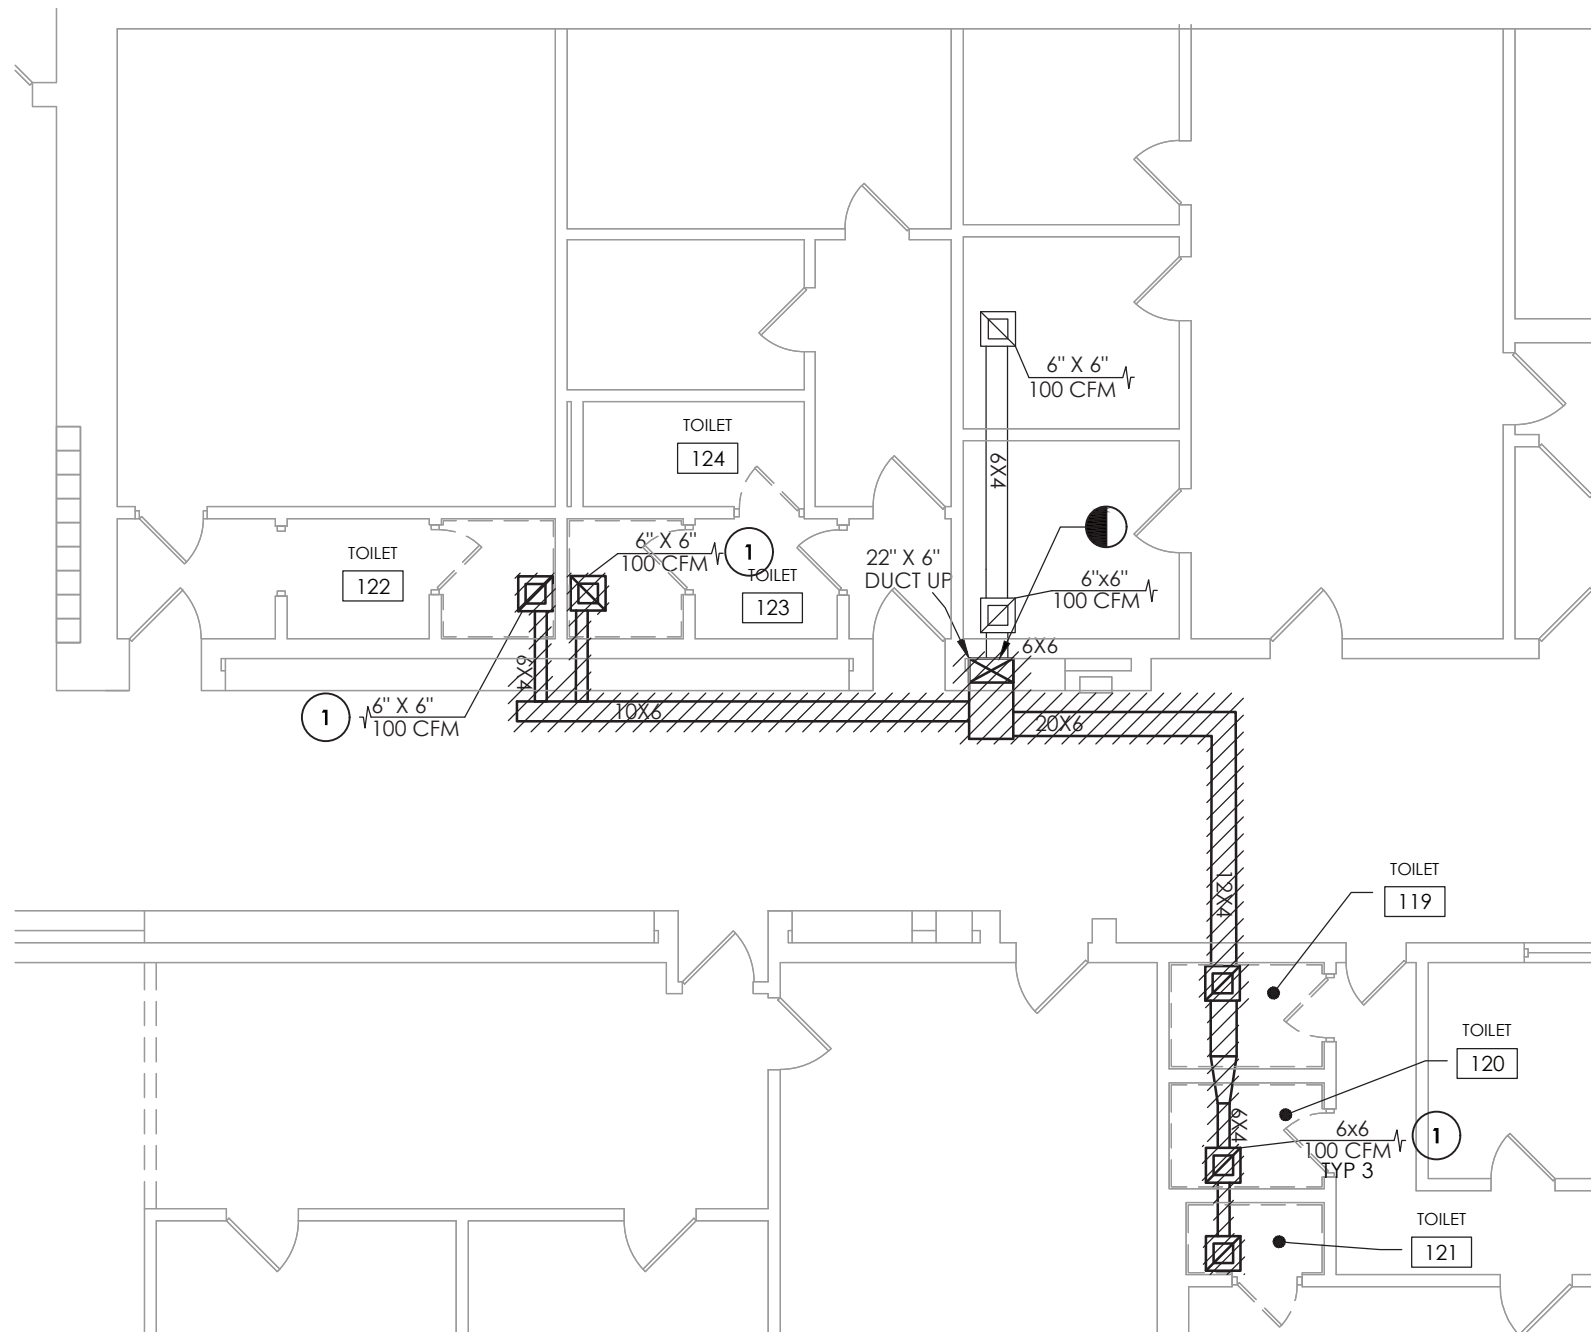


6
H101A
TOILET ROOM 5 DEMOLITION PLAN
SCALE: 1/8" = 1'-0"


- GENERAL NOTES:**
1. FIELD VERIFY EXACT DUCT AND PIPING LOCATIONS AND SIZES PRIOR TO DEMOLITION AND COORDINATE SPECIFIC POINTS OF REMOVAL LOCATIONS BASED ON NEW UNIT DIMENSIONS AND CONFIGURATIONS
- KEY NOTES:**
- 1 REMOVE EXISTING GRILLE AND EXHAUST DUCTWORK IN ITS ENTIRETY UP TO EXHAUST FAN ON ROOF. PREPARE FOR NEW WORK.
 - 2 REMOVE EXISTING CONVECTOR IN ITS ENTIRETY INCLUDING COVER, CONTROLS, AND PIPING BACK TO MAIN. PREPARE FOR NEW WORK.
 - 3 REMOVE EXISTING GRILLE. ALL DUCTWORK TO REMAIN. PREPARE FOR NEW WORK.
 - 4 REMOVE EXISTING GRILLE AND EXHAUST DUCTWORK UP TO POINT INDICATED. PREPARE FOR NEW WORK.

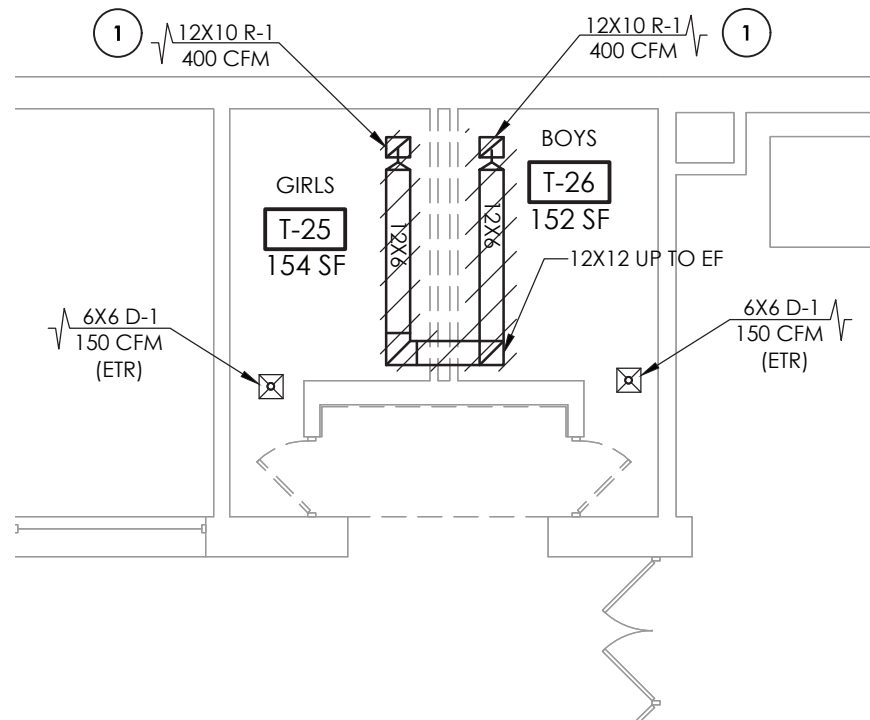

4
H101A
TOILET ROOM DEMOLITION PLAN
SCALE: 1/8" = 1'-0"

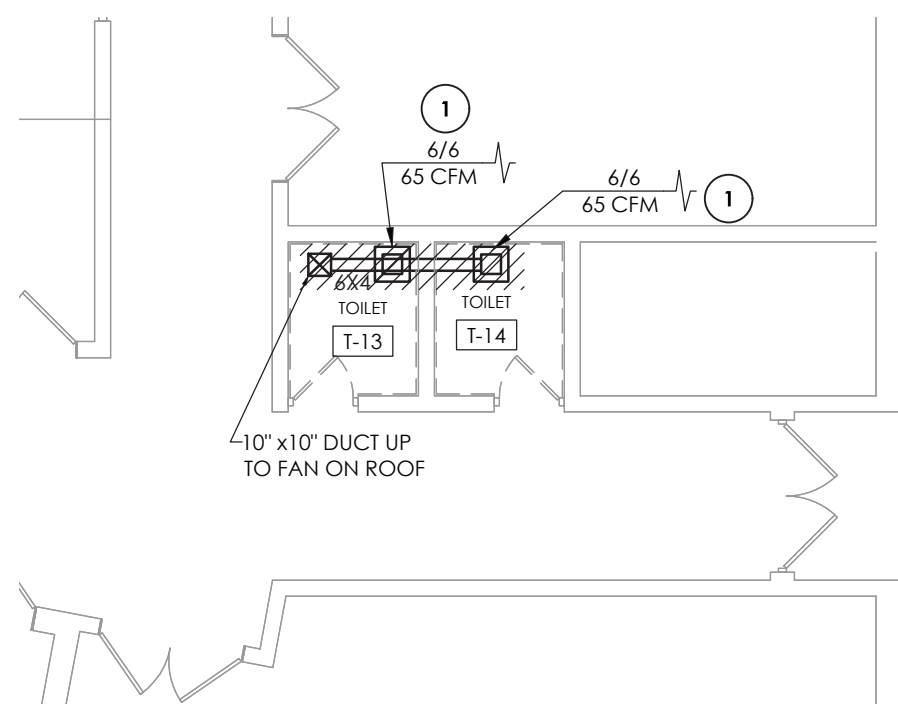

7
H101A
TOILET ROOMS T-13 AND T-14 DEMOLITION PLAN
SCALE: 1/8" = 1'-0"

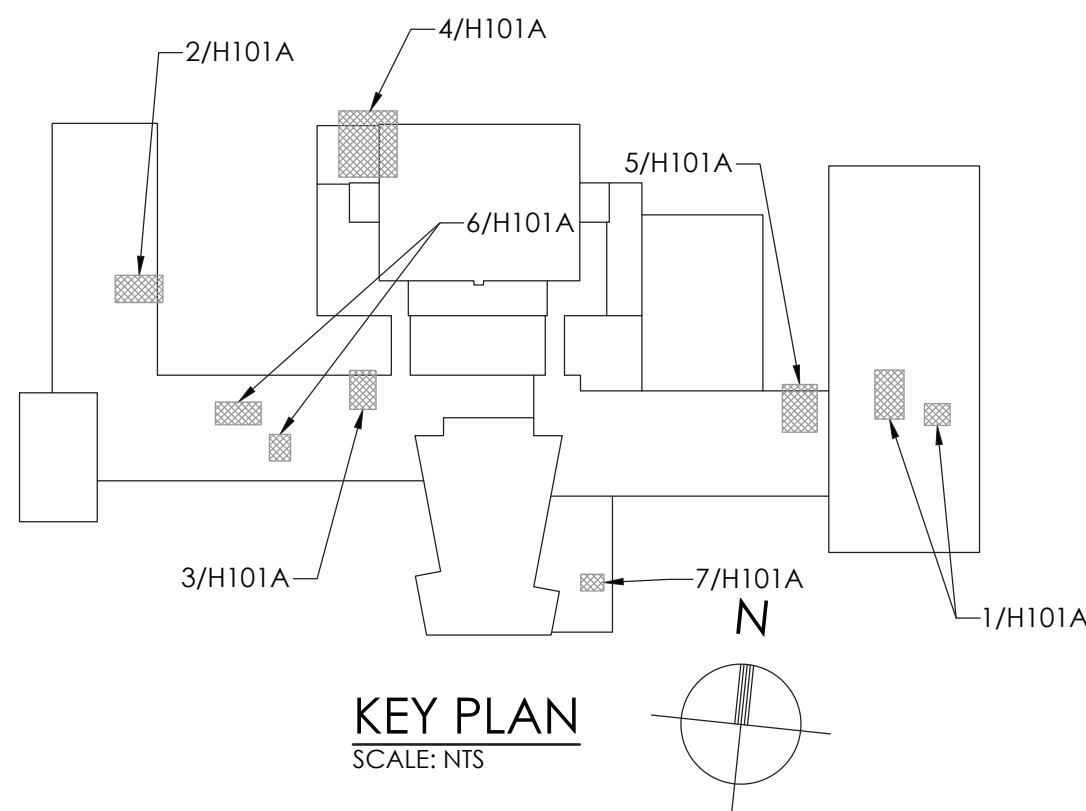

CPLteam.com
ARCHITECTURE • ENGINEERING • PLANNING

50 FRONT STREET, SUITE 202
NEWBURGH, NEW YORK 12550
TEL (800) 274-9000

REVISIONS	NO.	DATE	BY	DESCRIPTION



POUGHKEEPSIE CITY SCHOOL DISTRICT
2020 CAPITAL IMPROVEMENT PROJECT
PHASE 1B: BUILDING IMPROVEMENTS

POUGHKEEPSIE HIGH SCHOOL: SED# 13-15-00-01-0-007-018
POUGHKEEPSIE MIDDLE SCHOOL: SED# 13-15-00-01-0-008-021
POUGHKEEPSIE ELEMENTARY SCHOOL: SED# 13-15-00-01-0-009-014
KREGER ELEMENTARY SCHOOL: SED# 13-15-00-01-0-004-014
MORSE ELEMENTARY SCHOOL: SED# 13-15-00-01-0-002-014
WARRING ELEMENTARY SCHOOL: SED# 13-15-00-01-0-005-013
COLUMBIUS ELEMENTARY SCHOOL: SED# 13-15-00-01-0-001-014

DATE	DRAWN	CHECKED
10/20/2021	BKM	AJS


SCALE: AS NOTED

SHEET TITLE

HIGH SCHOOL FIRST FLOOR HVAC TOILET ROOM DEMOLITION PLANS A

PROJECT NUMBER
14078.09


PHS
H101A
DRAWING NUMBER

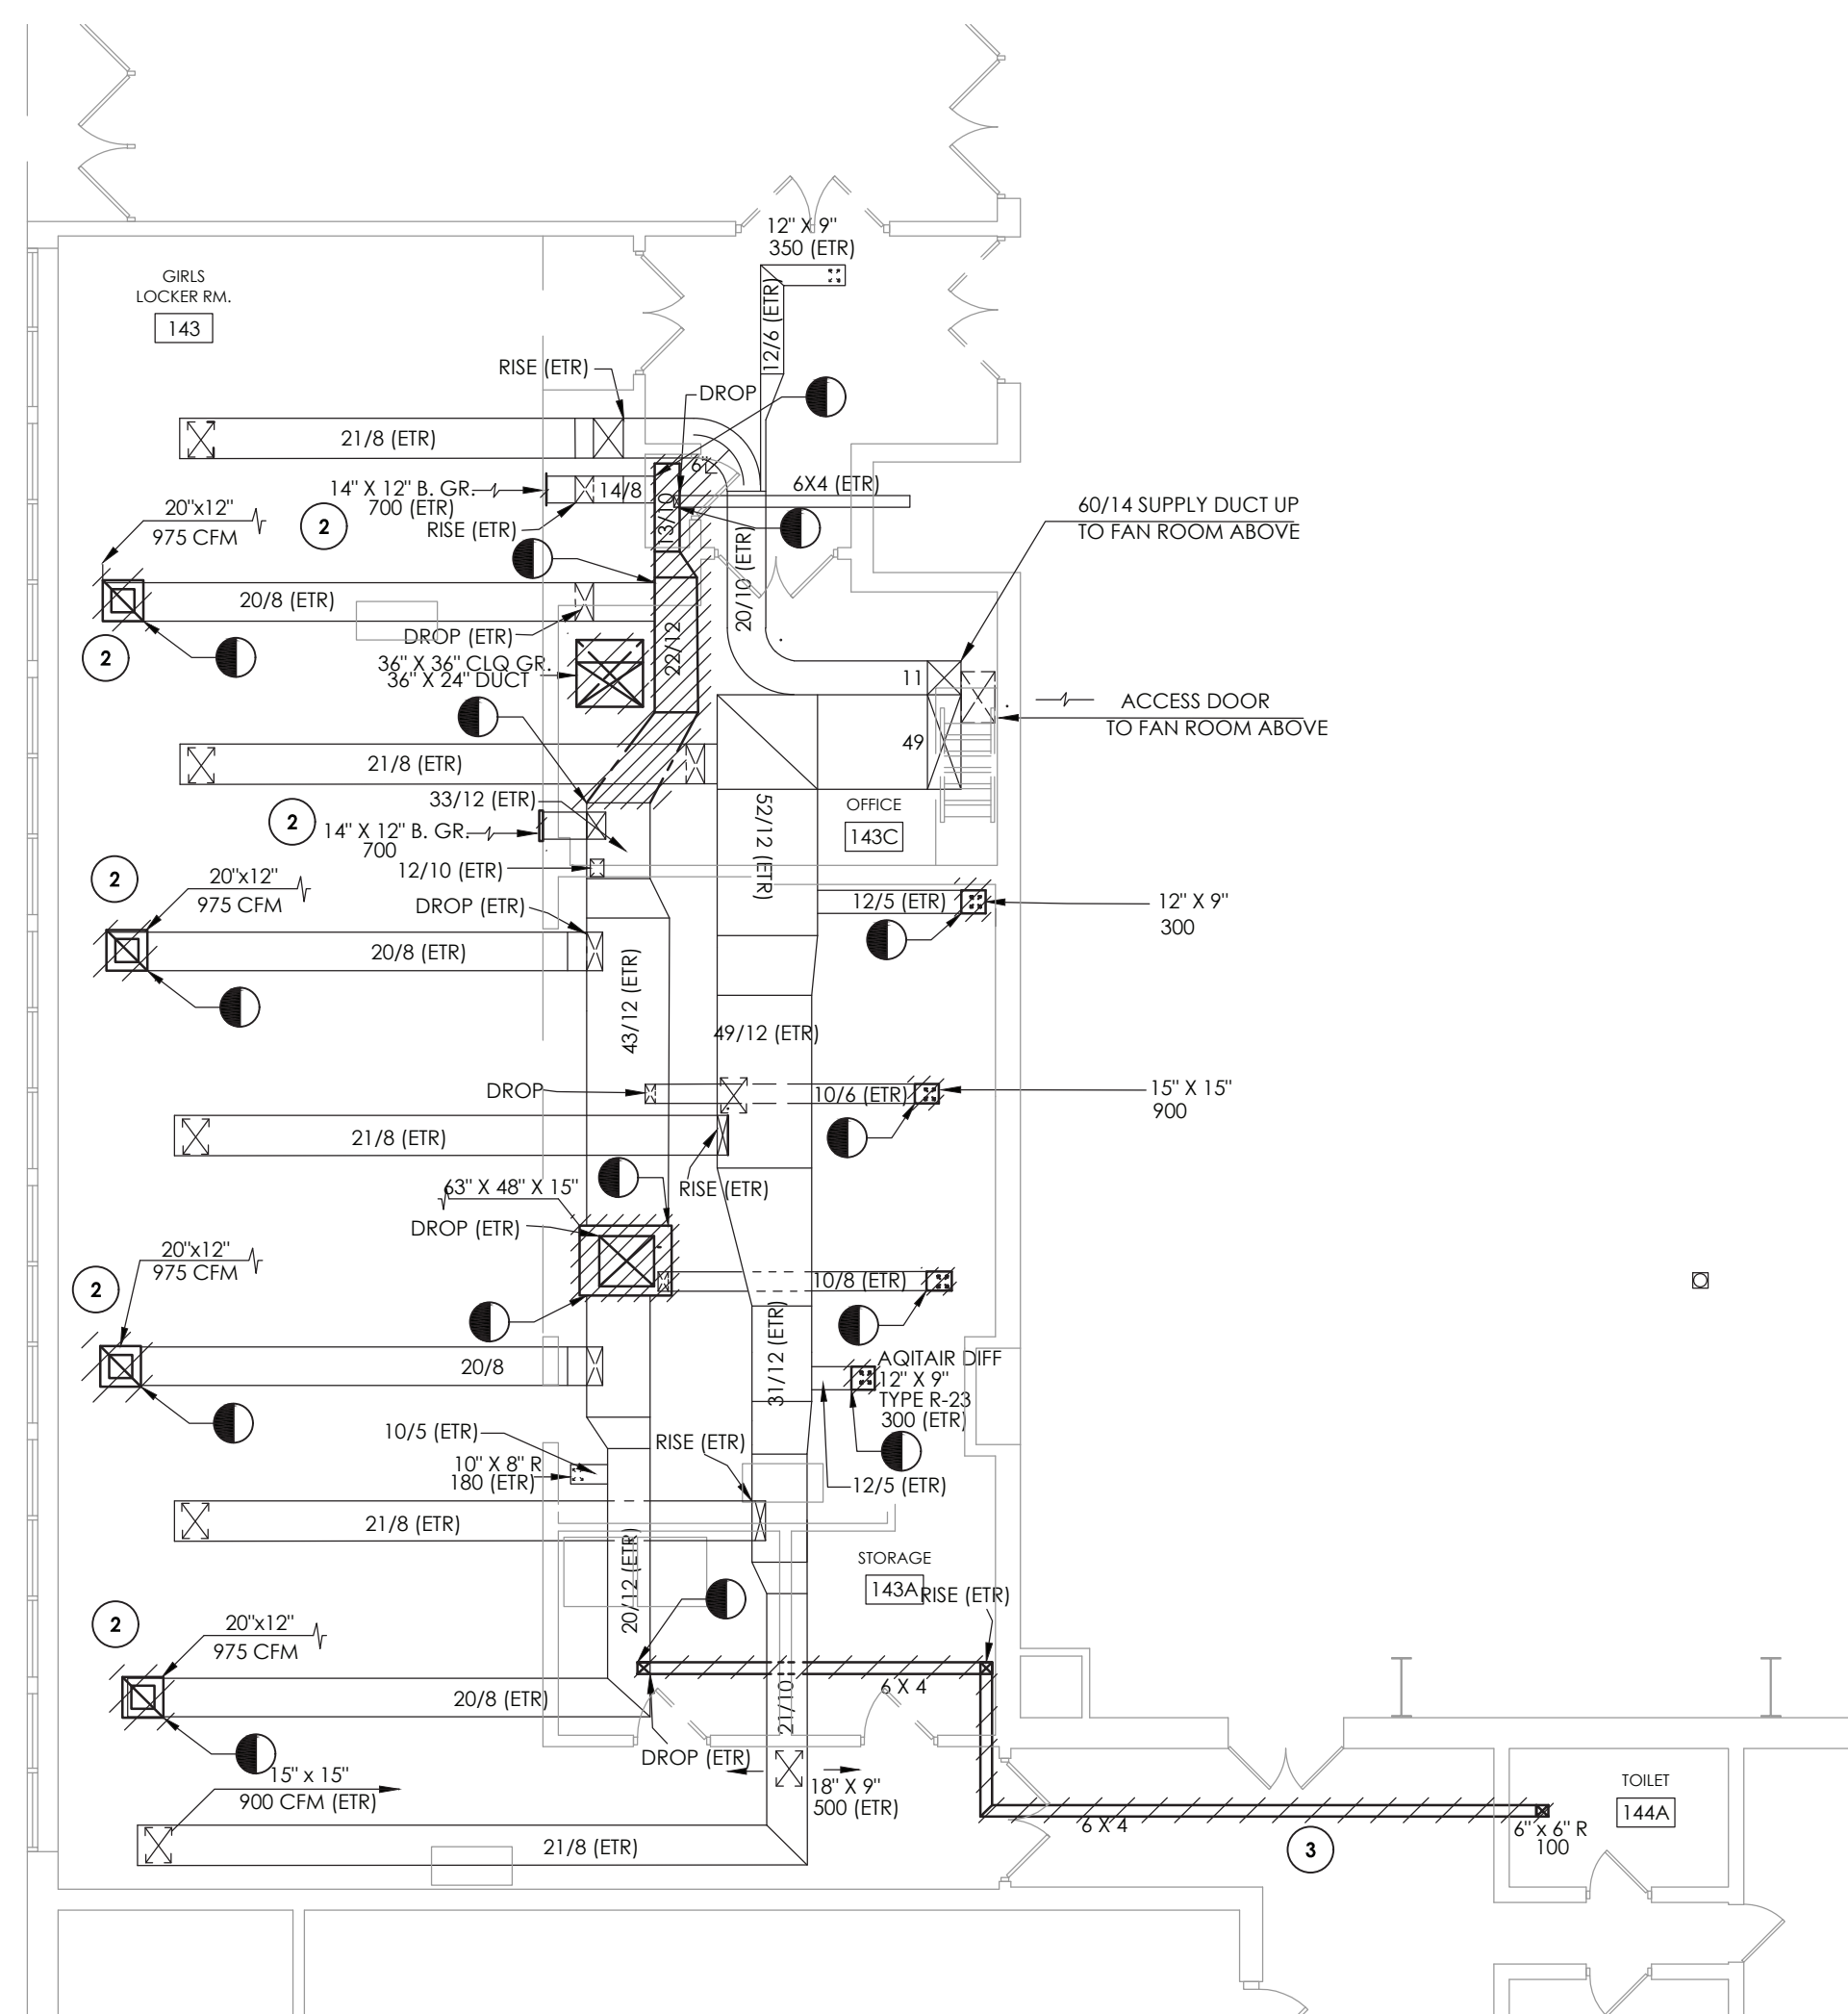


7
H101B

GIRLS' LOCKER ROOM HVAC DEMOLITION PLAN

SCALE: 1/8" = 1'-0"

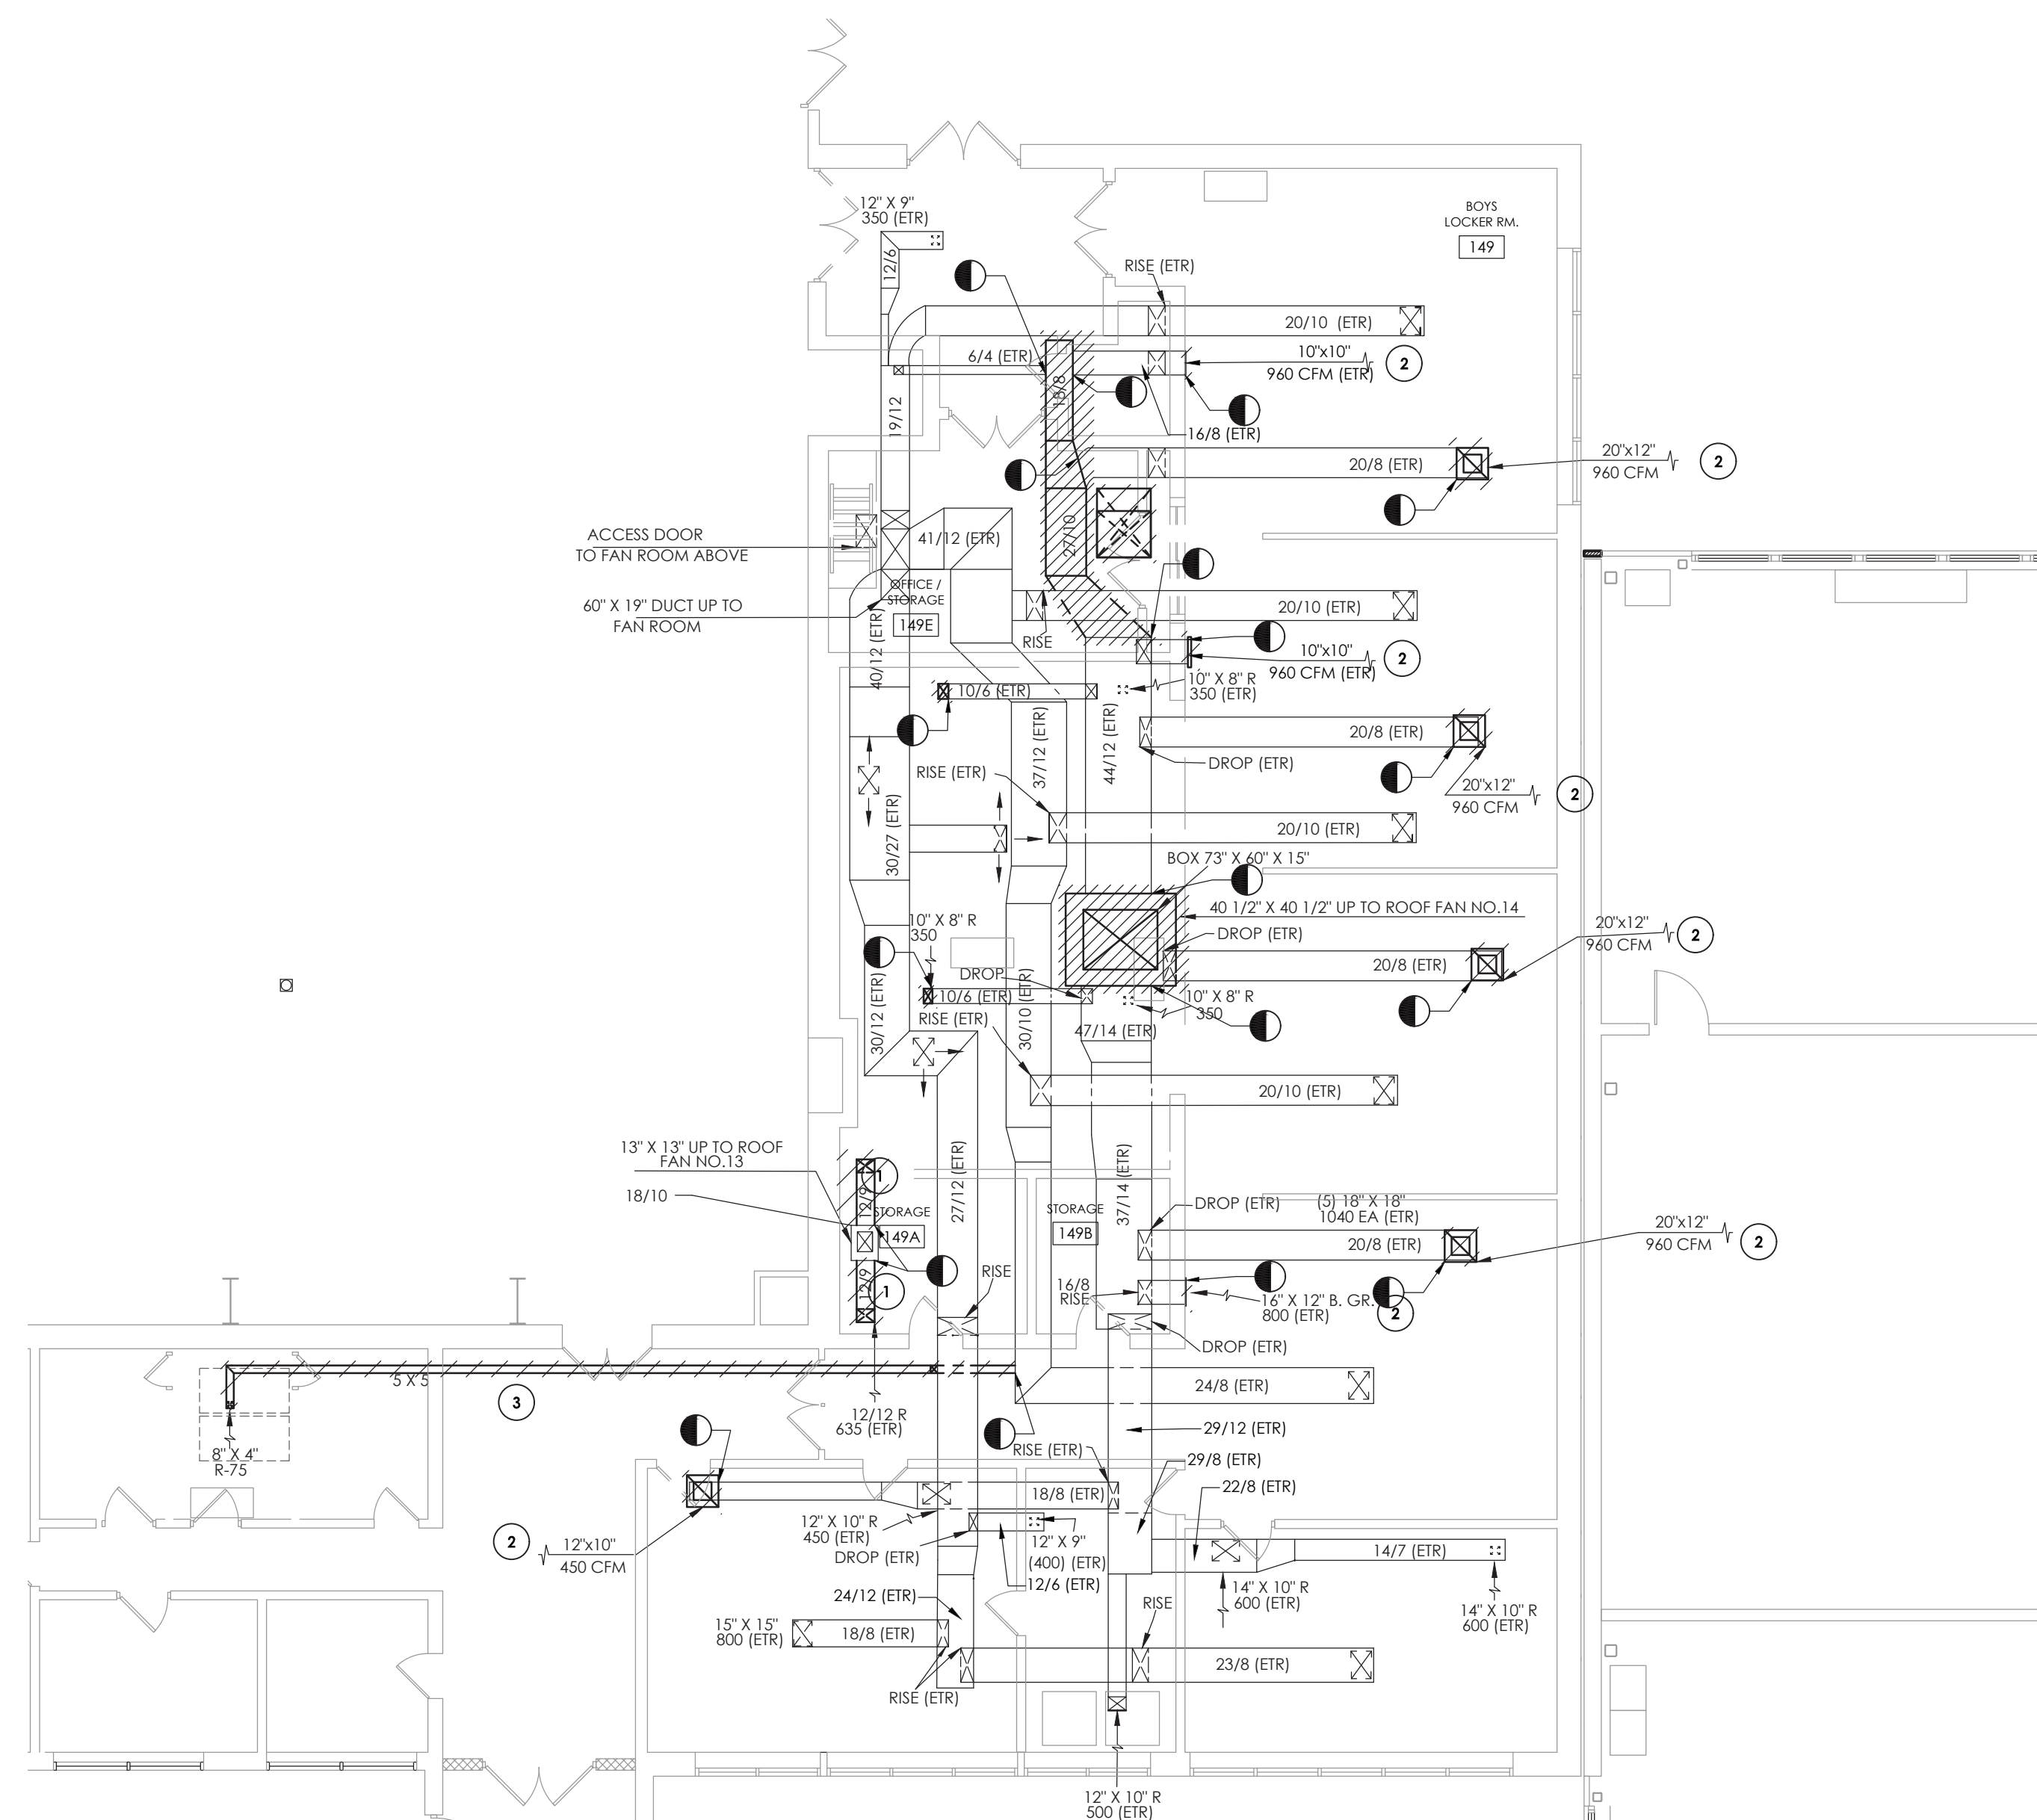

8 **BOYS' LOCKER ROOM HVAC DEMOLITION PLAN**
 H101B SCALE: 1/8" = 1'-0"

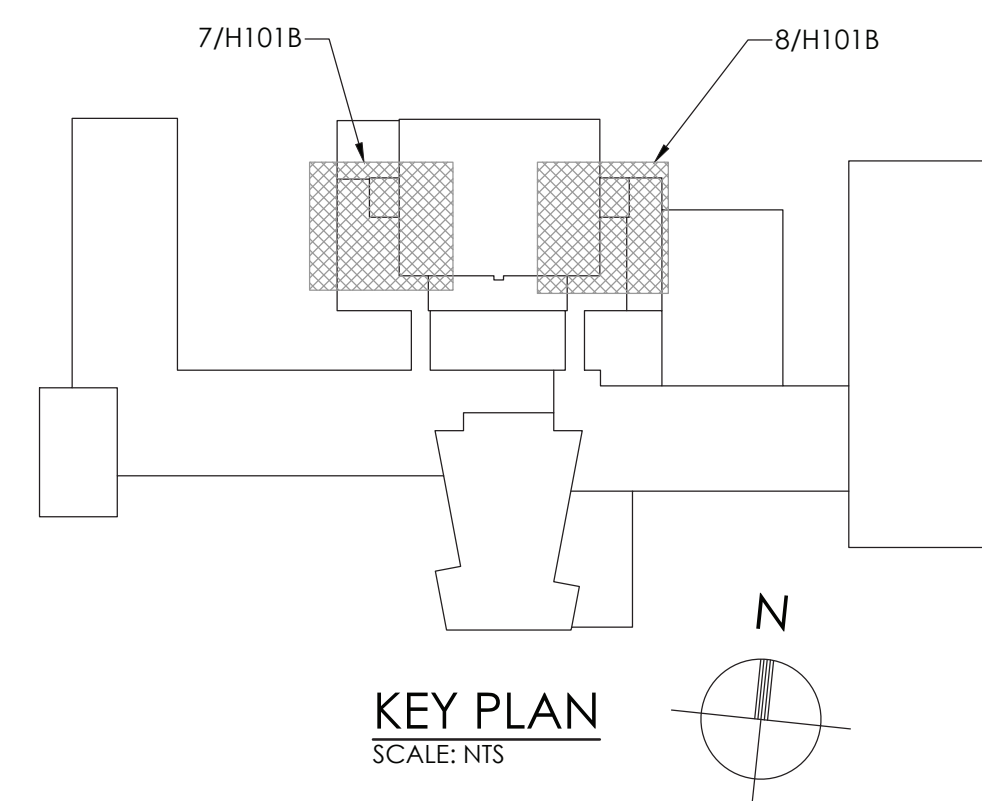

GENERAL NOTES:

- 1. FIELD VERIFY EXACT DUCT AND PIPING LOCATIONS AND SIZES PRIOR TO DEMOLITION AND COORDINATE SPECIFIC POINTS OF REMOVAL LOCATIONS BASED ON NEW UNIT DIMENSIONS AND CONFIGURATIONS**

KEY NOTES:

- ① REMOVE EXISTING GRILLE AND EXHAUST DUCTWORK IN ITS ENTIRETY UP TO EXHAUST FAN ON ROOF. PREPARE FOR NEW WORK.
- ② REMOVE EXISTING GRILLE. ALL DUCTWORK TO REMAIN. PREPARE FOR NEW WORK.
- ③ REMOVE EXISTING GRILLE AND EXHAUST DUCTWORK TO POINT INDICATED. PREPARE FOR NEW WORK.



CPLteam.com
ARCHITECTURE ■ ENGINEERING ■ PLANNING

50 FRONT STREET, SUITE 202
NEWBURGH, NEW YORK 12550
TEL (800) 274-9000

[illegible]

POUGHKEEPSIE CITY SCHOOL DISTRICT
2020 CAPITAL IMPROVEMENT PROJECT
PHASE 1B: BUILDING IMPROVEMENTS

- ☐ POUGHKEEPSIE HIGH SCHOOL: SED# 13-15-00-01-0-007-018
☐ POUGHKEEPSIE MIDDLE SCHOOL: SED# 13-15-00-01-0-015-021
☐ CLINTON ELEMENTARY SCHOOL: SED# 13-15-00-01-0-004-014
☐ KRIEGER ELEMENTARY SCHOOL: SED# 13-15-00-01-0-006-014
☐ MORSE ELEMENTARY SCHOOL: SED# 13-15-00-01-0-002-014
☐ WARRING ELEMENTARY SCHOOL: SED# 13-15-00-01-0-005-013
☐ SMART EARLY LEARNING CENTER: SED# 13-15-00-01-0-008-022

DATE	DRAWN	CHECKED
10/20/2021	BKM	AJS


SCALE AS NOTED

SHEET TITLE
HIGH SCHOOL FIRST
FLOOR LOCKER ROOMS
DEMOLITION PLANS


PROJECT NUMBER
14078.09

PHS
H101B


DRAWING NUMBER

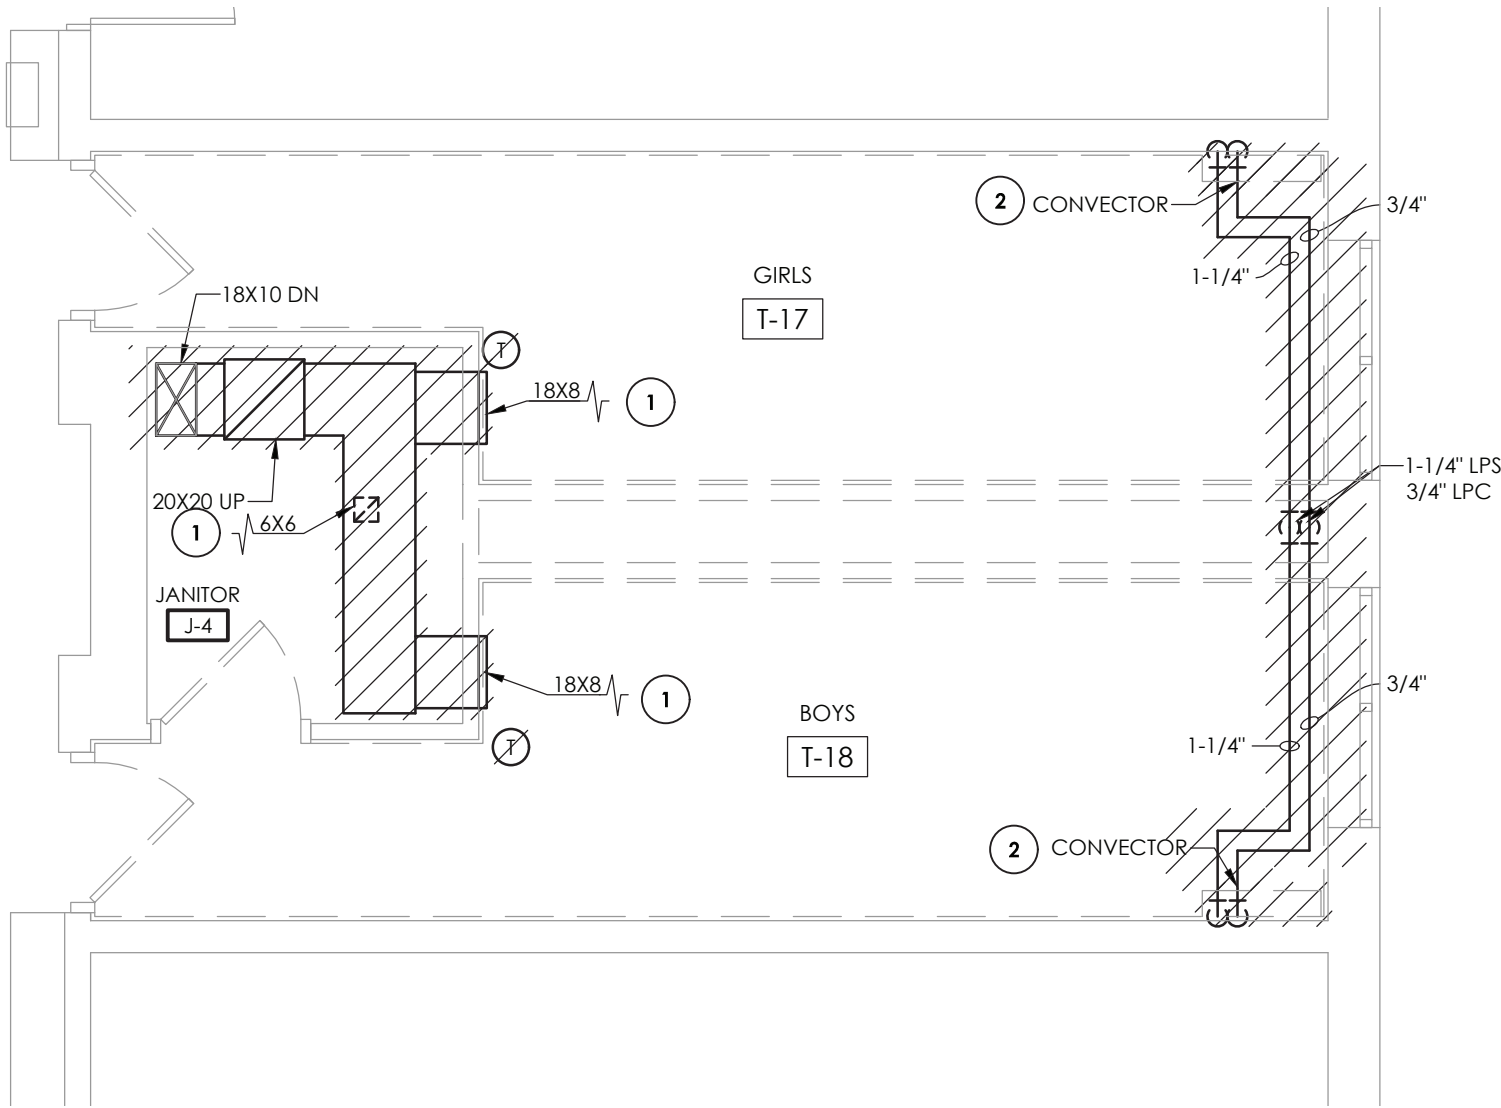


1
H102
TOILET ROOMS T-17 AND
T-18 DEMOLITION PLAN
SCALE: 1/4" = 1'-0"

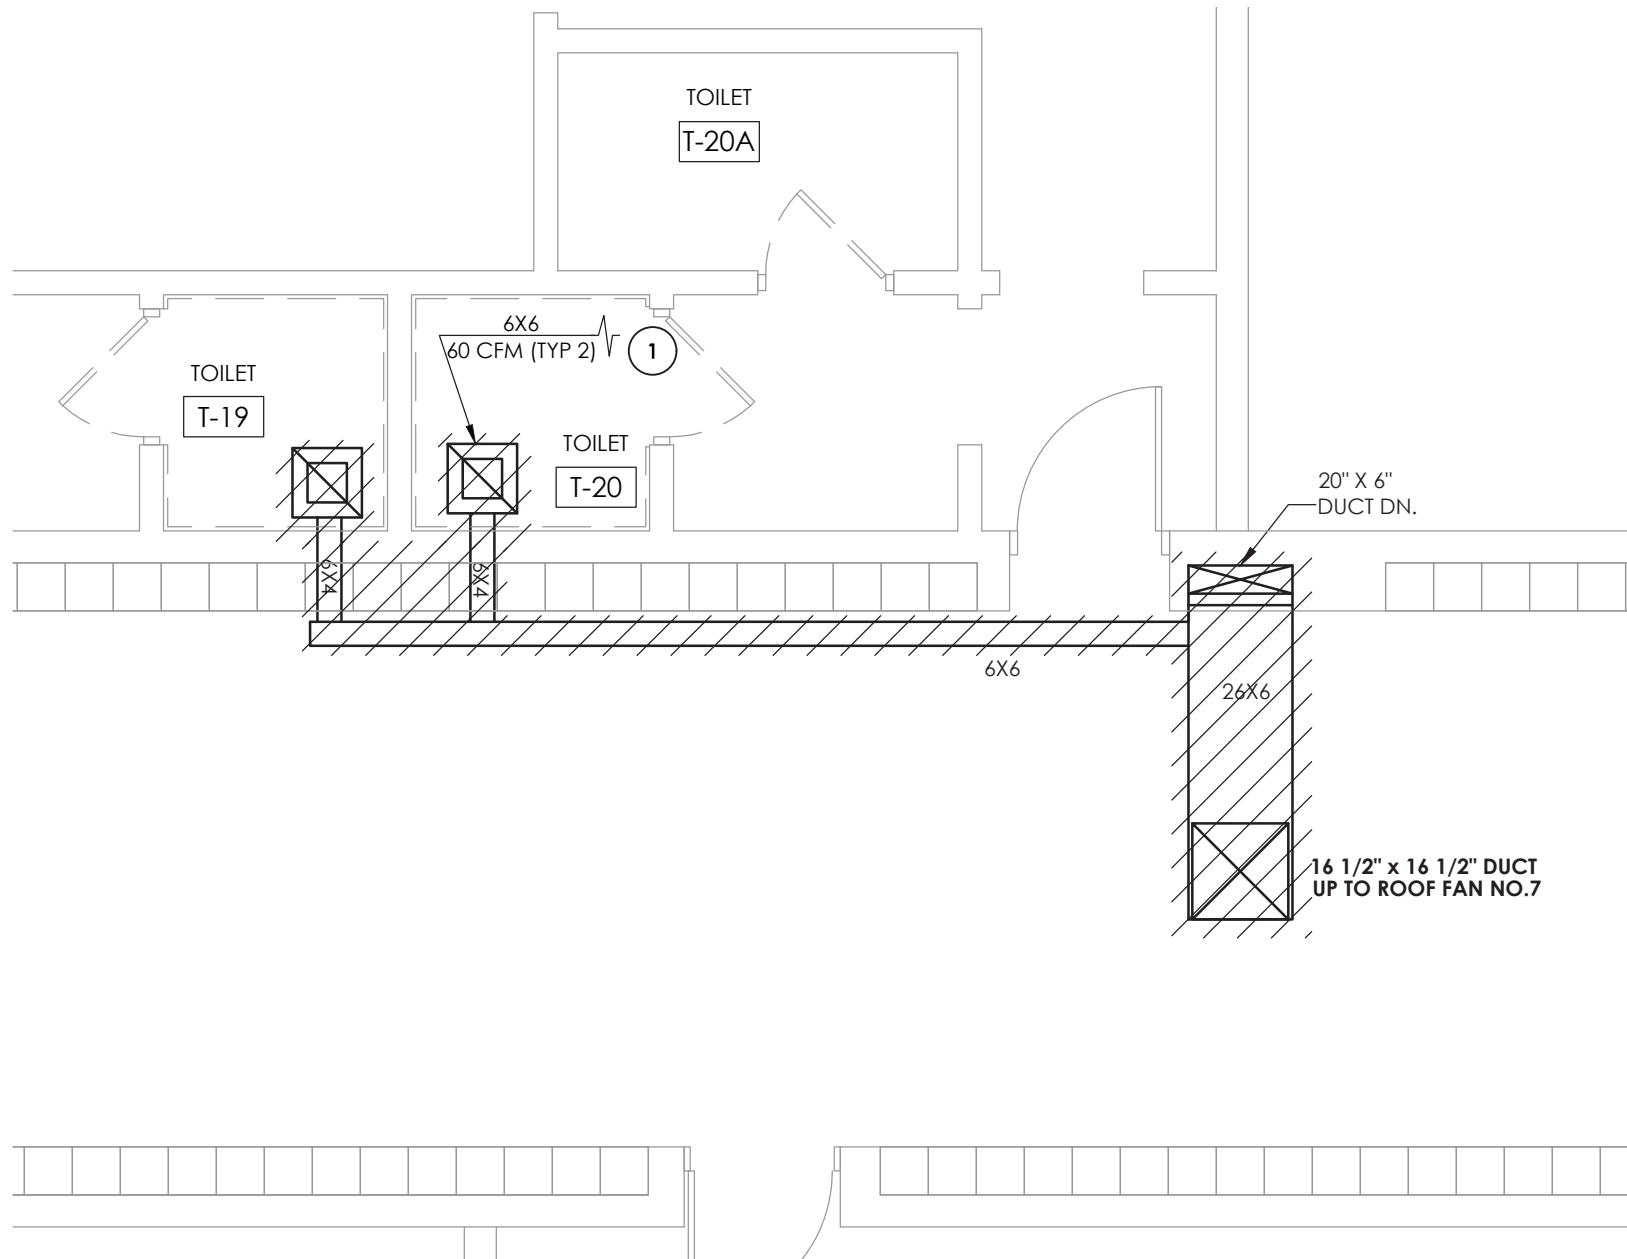

2
H102
TOILET ROOM 12 DEMOLITION PLAN
SCALE: 1/4" = 1'-0"

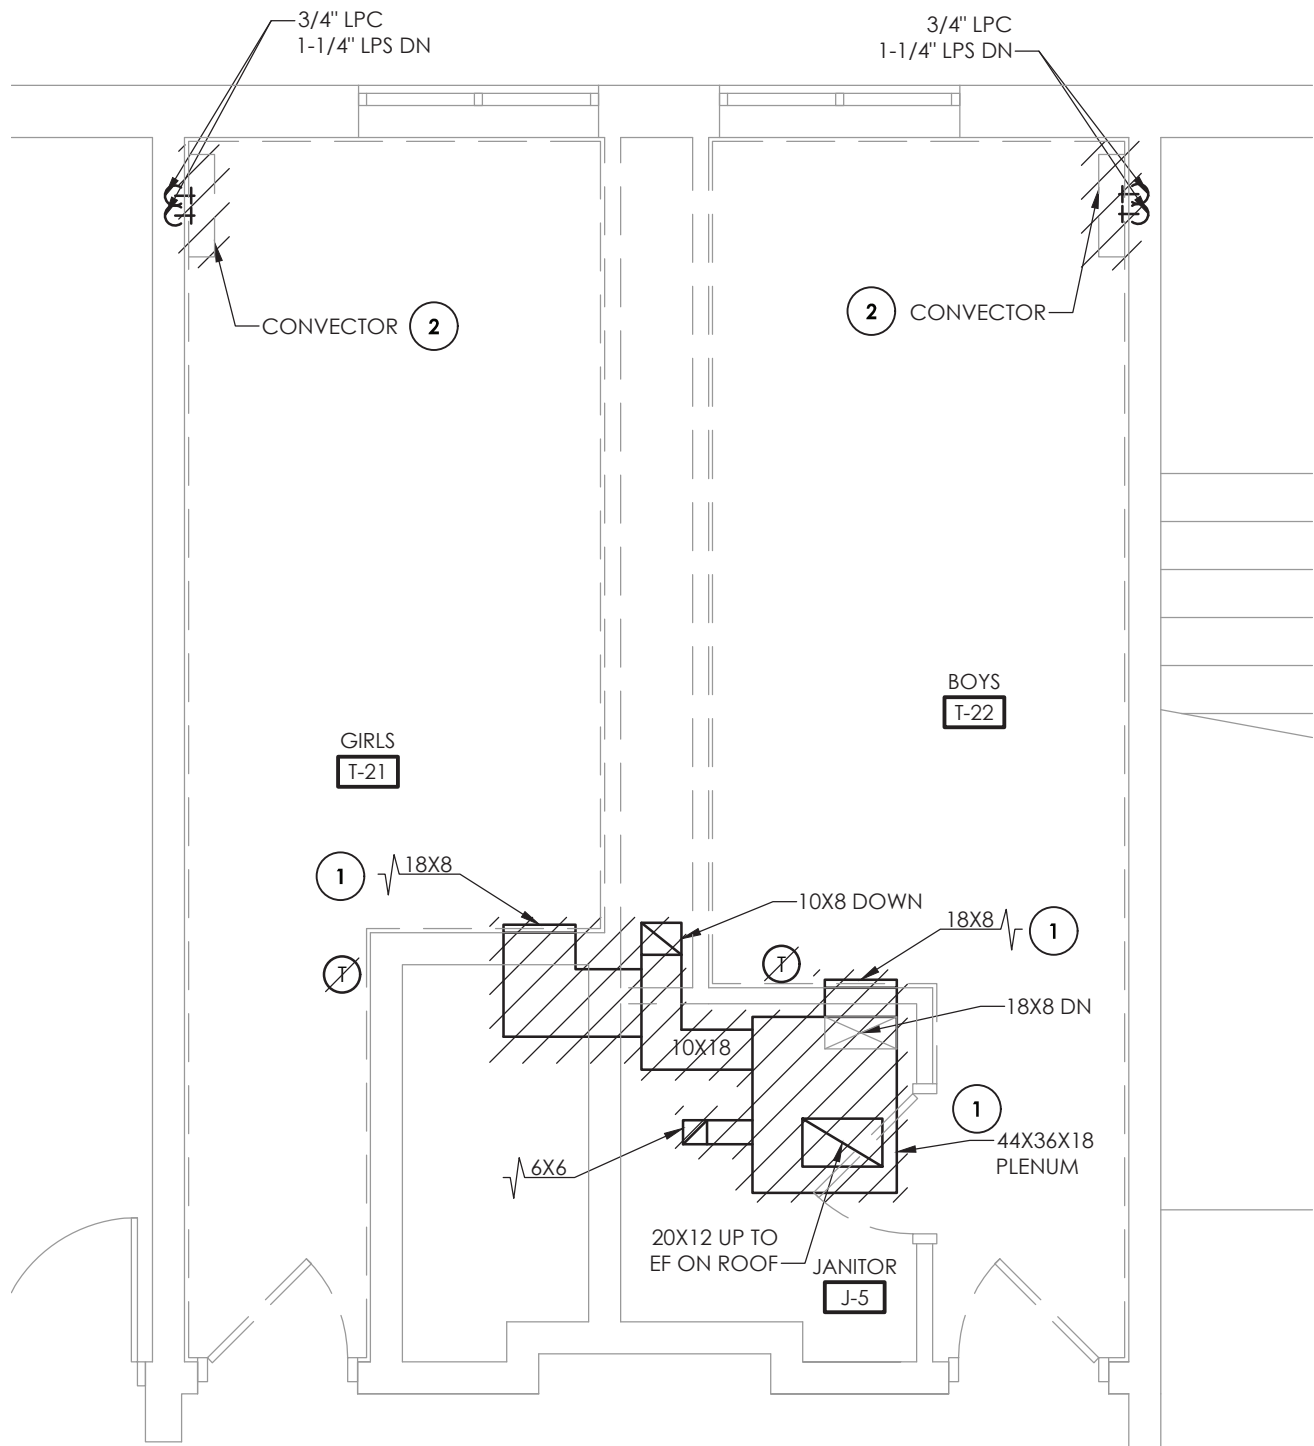

3
H102
TOILET ROOMS T-21 AND
T-22 DEMOLITION PLAN
SCALE: 1/8" = 1'-0"

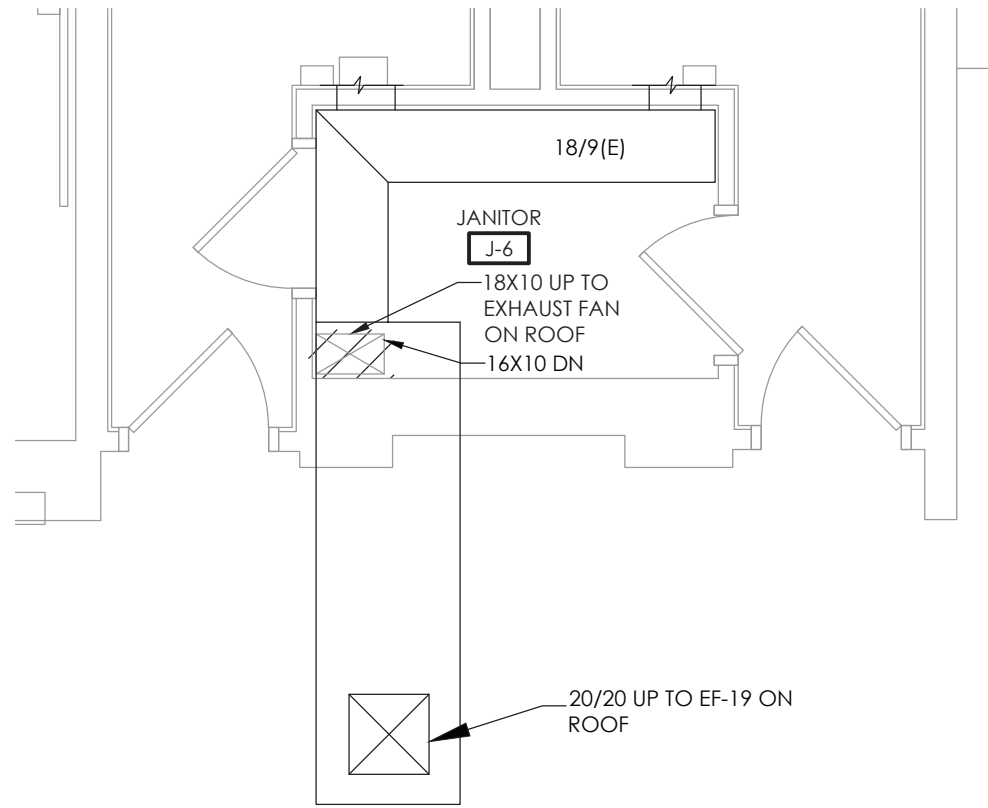


4
H102
TOILET ROOMS T-23 AND
T-24 DEMOLITION PLAN
SCALE: 1/4" = 1'-0"

GENERAL NOTES:

1. FIELD VERIFY EXACT DUCT AND PIPING LOCATIONS AND SIZES PRIOR TO DEMOLITION AND COORDINATE SPECIFIC POINTS OF REMOVAL LOCATIONS BASED ON NEW UNIT DIMENSIONS AND CONFIGURATIONS

KEY NOTES:

- 1 REMOVE EXISTING GRILLE AND EXHAUST DUCTWORK IN ITS ENTIRETY UP TO EXHAUST FAN ON ROOF. PREPARE FOR NEW WORK.
- 2 REMOVE EXISTING CONVECTOR IN ITS ENTIRETY INCLUDING COVER, CONTROLS, AND PIPING BACK TO MAIN. PREPARE FOR NEW WORK.

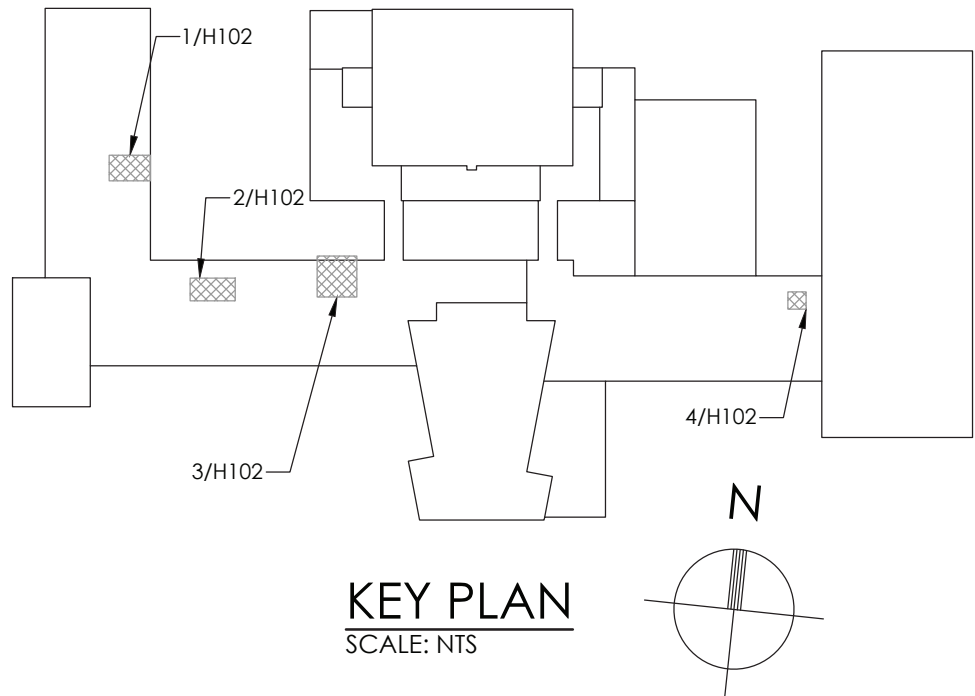

CPL
CPLteam.com
ARCHITECTURE • ENGINEERING • PLANNING
50 FRONT STREET, SUITE 202
NEWBURGH, NEW YORK 12550
TEL (800) 274-9000

REVISIONS	DESCRIPTION	
	NO.	DATE






POUGHKEEPSIE CITY SCHOOL DISTRICT
2020 CAPITAL IMPROVEMENT PROJECT
PHASE 1B: BUILDING IMPROVEMENTS

- POUGHKEEPSIE HIGH SCHOOL: SED# 13-15-00-01-0-007-018
- POUGHKEEPSIE MIDDLE SCHOOL: SED# 13-15-00-01-0-008-021
- POUGHKEEPSIE JUNIOR HIGH SCHOOL: SED# 13-15-00-01-0-009-021
- KREGER ELEMENTARY SCHOOL: SED# 13-15-00-01-0-004-014
- MORSE ELEMENTARY SCHOOL: SED# 13-15-00-01-0-002-014
- WARRING ELEMENTARY SCHOOL: SED# 13-15-00-01-0-005-013
- WARRING ELEMENTARY SCHOOL: SED# 13-15-00-01-0-006-013
- WARRING ELEMENTARY SCHOOL: SED# 13-15-00-01-0-001-014

DATE	DRAWN	CHECKED
10/20/2021	BKM	AJS
SCALE: AS NOTED		
SHEET TITLE		
HIGH SCHOOL SECOND FLOOR HVAC TOILET ROOM DEMOLITION PLANS		

PROJECT NUMBER
14078.09
PHS
H102A
DRAWING NUMBER

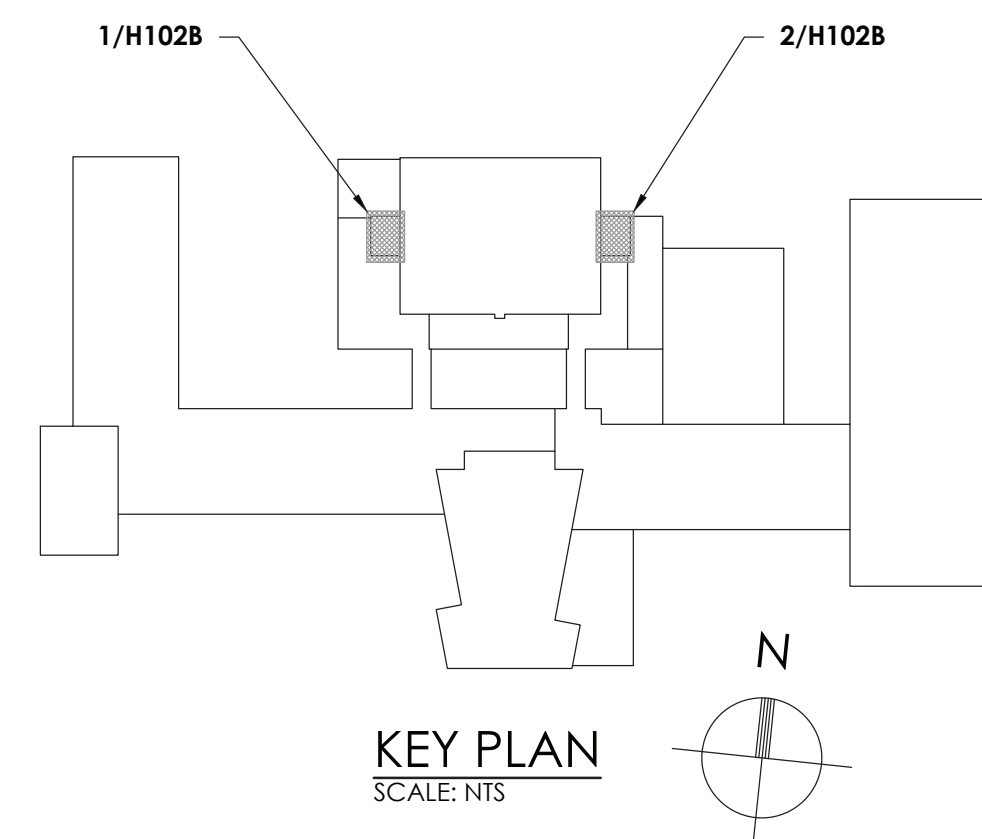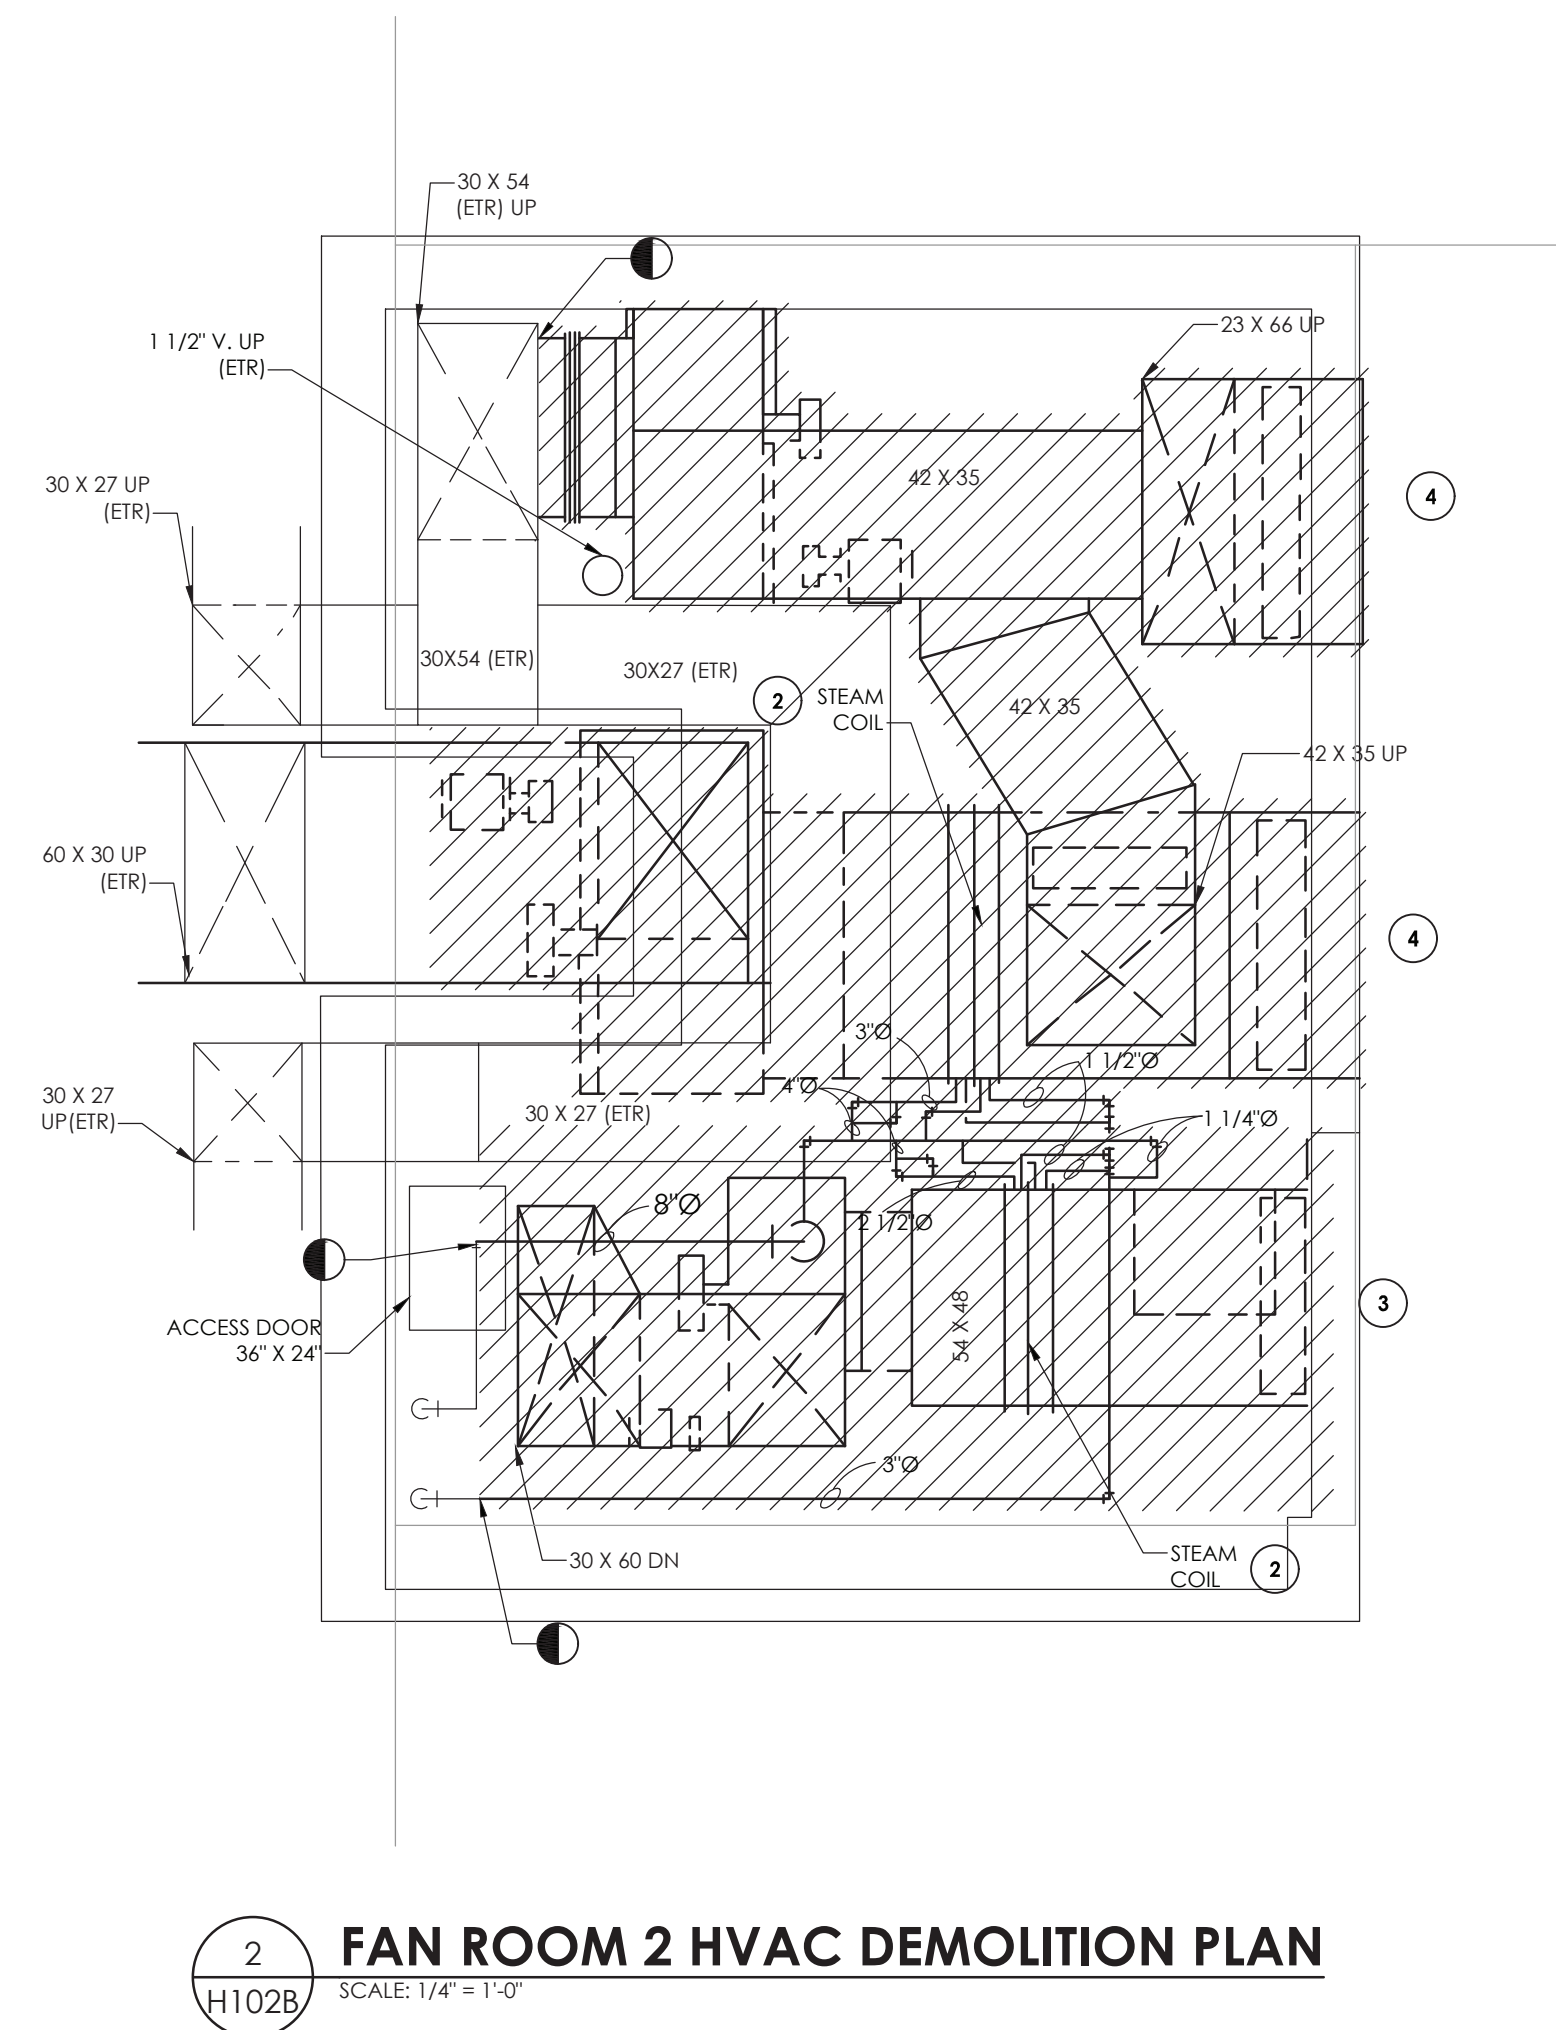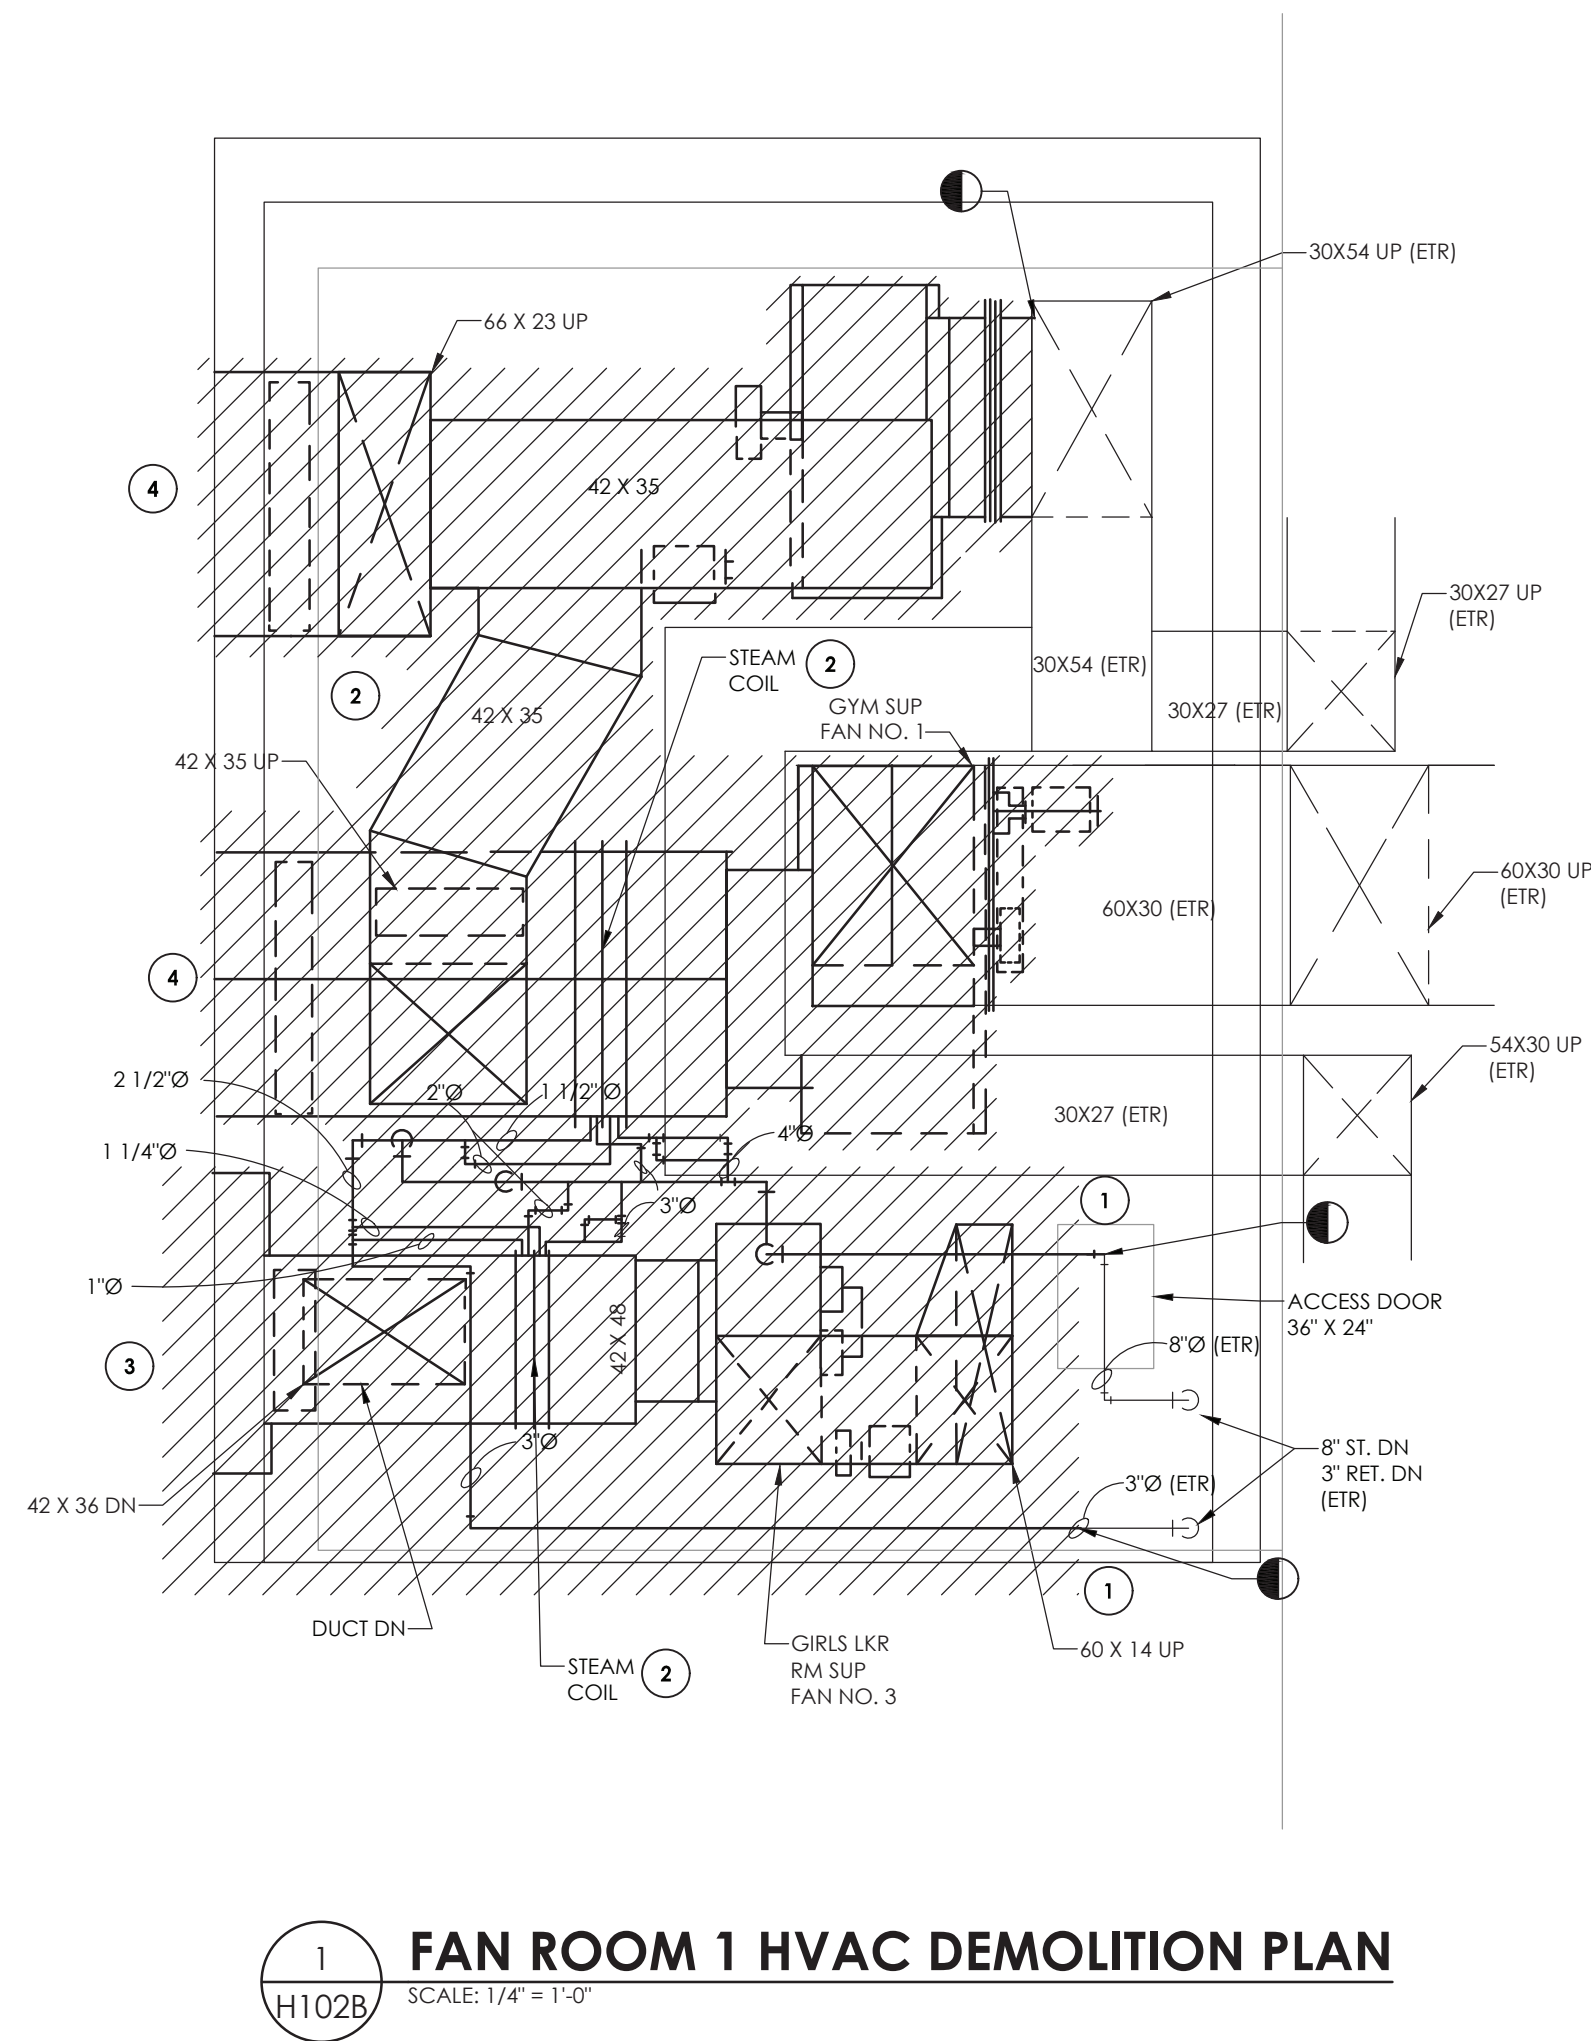

GENERAL NOTES:

1. FIELD VERIFY EXACT DUCT AND PIPING LOCATIONS AND SIZES PRIOR TO DEMOLITION AND COORDINATE SPECIFIC POINTS OF REMOVAL LOCATIONS BASED ON NEW UNIT DIMENSIONS AND CONFIGURATIONS

KEY NOTES:

- ① REMOVE EXISTING STEAM COIL PIPING AND CONDENSATE RETURN PIPING TO POINT INDICATED.
- ② REMOVE EXISTING LOCKER ROOM SUPPLY FAN & RETURN FAN IN THEIR ENTIRETY.
- ③ REMOVE EXISTING LOUVER AND INFILL WITH CONSTRUCTION TO MATCH EXISTING.
- ④ REMOVE EXISTING LOUVER. MODIFY EXISTING OPENING TO ACCOMMODATE NEW DUCTWORK.



CPLteam.com
ARCHITECTURE ■ ENGINEERING ■ PLANNING

100 FRONT STREET, SUITE 202
BROOKLYN, NEW YORK 11201
TEL (800) 274-9000

REVISIONS			DESCRIPTION
NO.	DATE	BY	

POUGHKEEPSIE CITY SCHOOL DISTRICT
2020 CAPITAL IMPROVEMENT PROJECT
PHASE 1B: BUILDING IMPROVEMENTS

- ☐ POW/KEESPEE MIDDLE SCHOOL: SED# 13-15-00-01-0-01-5-02
☐ CLINTON ELEMENTARY SCHOOL: SED# 13-15-00-01-0-004-014
☐ KRIEGER ELEMENTARY SCHOOL: SED# 13-15-00-01-0-006-014
☐ MORSE ELEMENTARY SCHOOL: SED# 13-15-00-01-0-002-014
☐ WARREN ELEMENTARY SCHOOL: SED# 13-15-00-01-0-005-013
☐ SMITH EARLY LEARNING CENTER: SED# 13-15-00-01-0-008-022
☐ COLUMBUS ELEMENTARY SCHOOL: SED# 13-15-00-01-0-001-014

DATE	DRAWN	CHECKED
10/20/2021	BKM	AJS
SCALE AS NOTED		


SHEET TITLE
HIGH SCHOOL FAN
ROOM DEMOLITION
PLANS

PROJECT NUMBER

14078.09

PHS
1102B

DRAWING NUMBER

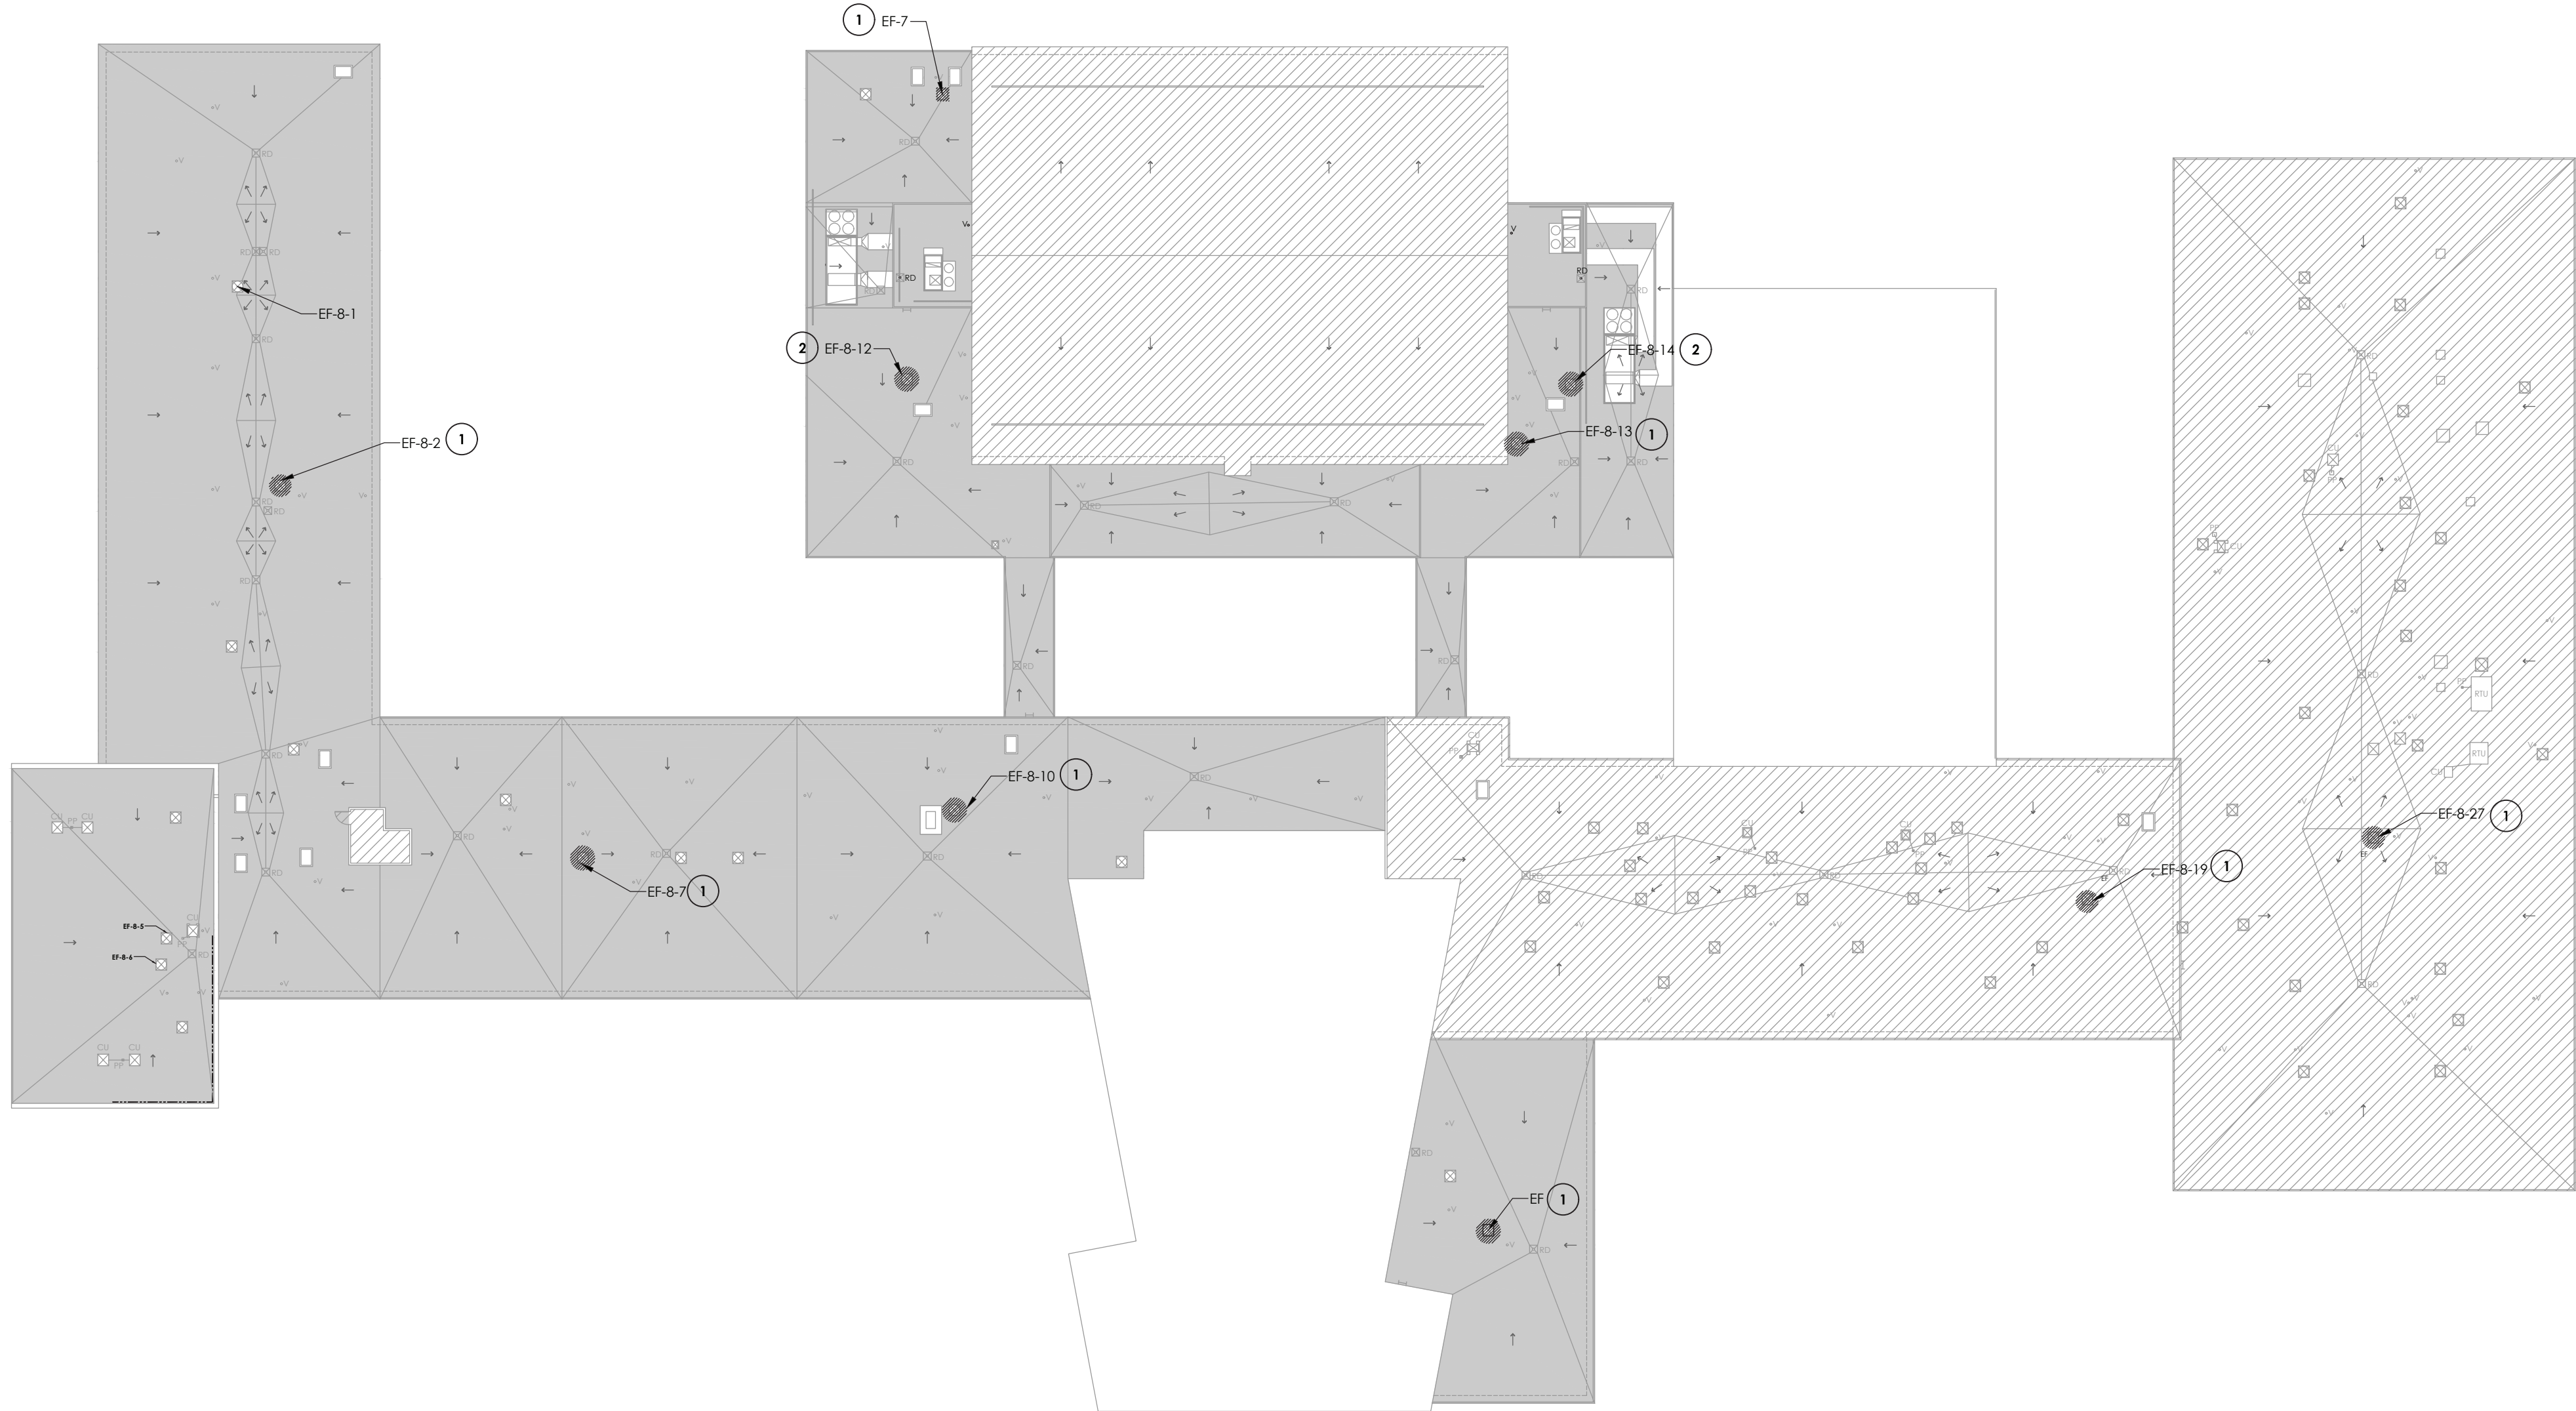

1
H103
ROOF HVAC DEMOLITION PLAN
SCALE: 1/32" = 1'-0"

GENERAL NOTES:

1. FIELD VERIFY EXACT DUCT AND PIPING LOCATIONS AND SIZES PRIOR TO DEMOLITION AND COORDINATE SPECIFIC POINTS OF REMOVAL LOCATIONS BASED ON NEW UNIT DIMENSIONS AND CONFIGURATIONS

KEY NOTES:

- 1 REMOVE EXISTING EXHAUST FAN IN ITS ENTIRETY INCLUDING CURB, CONTROLS, AND ALL ASSOCIATED DUCTWORK. PREPARE FOR NEW WORK.
- 2 REMOVE EXISTING EXHAUST FAN IN ITS ENTIRETY INCLUDING CURB, CONTROLS, AND ALL ASSOCIATED DUCTWORK. COORDINATE ROOF PATCHING WITH G.C. MAINTAIN ALL EXISTING ROOF WARRANTIES.

CPL
CPLteam.com
ARCHITECTURE • ENGINEERING • PLANNING
50 FRONT STREET, SUITE 202
NEWBURGH, NEW YORK 12550
TEL (800) 274-9000


REVISIONS		NO.	DATE	BY	DESCRIPTION




POUGHKEEPSIE CITY SCHOOL DISTRICT
2020 CAPITAL IMPROVEMENT PROJECT
PHASE 1B: BUILDING IMPROVEMENTS
POUGHKEEPSIE HIGH SCHOOL: SED# 13-15-00-01-0-007-018
POUGHKEEPSIE MIDDLE SCHOOL: SED# 13-15-00-01-0-004-021
POUGHKEEPSIE ELEMENTARY SCHOOL: SED# 13-15-00-01-0-004-014
KREGER ELEMENTARY SCHOOL: SED# 13-15-00-01-0-004-014
MORSE ELEMENTARY SCHOOL: SED# 13-15-00-01-0-002-014
WARRING ELEMENTARY SCHOOL: SED# 13-15-00-01-0-005-013
WARRING ELEMENTARY SCHOOL: SED# 13-15-00-01-0-005-013
COLUMBUS ELEMENTARY SCHOOL: SED# 13-15-00-01-0-001-014

DATE	DRAWN	CHECKED
10/20/2021	BKM	AJS
SCALE: AS NOTED		
SHEET TITLE		
HIGH SCHOOL HVAC ROOF DEMOLITION PLAN		


PROJECT NUMBER
14078.09
PHS
H103
DRAWING NUMBER

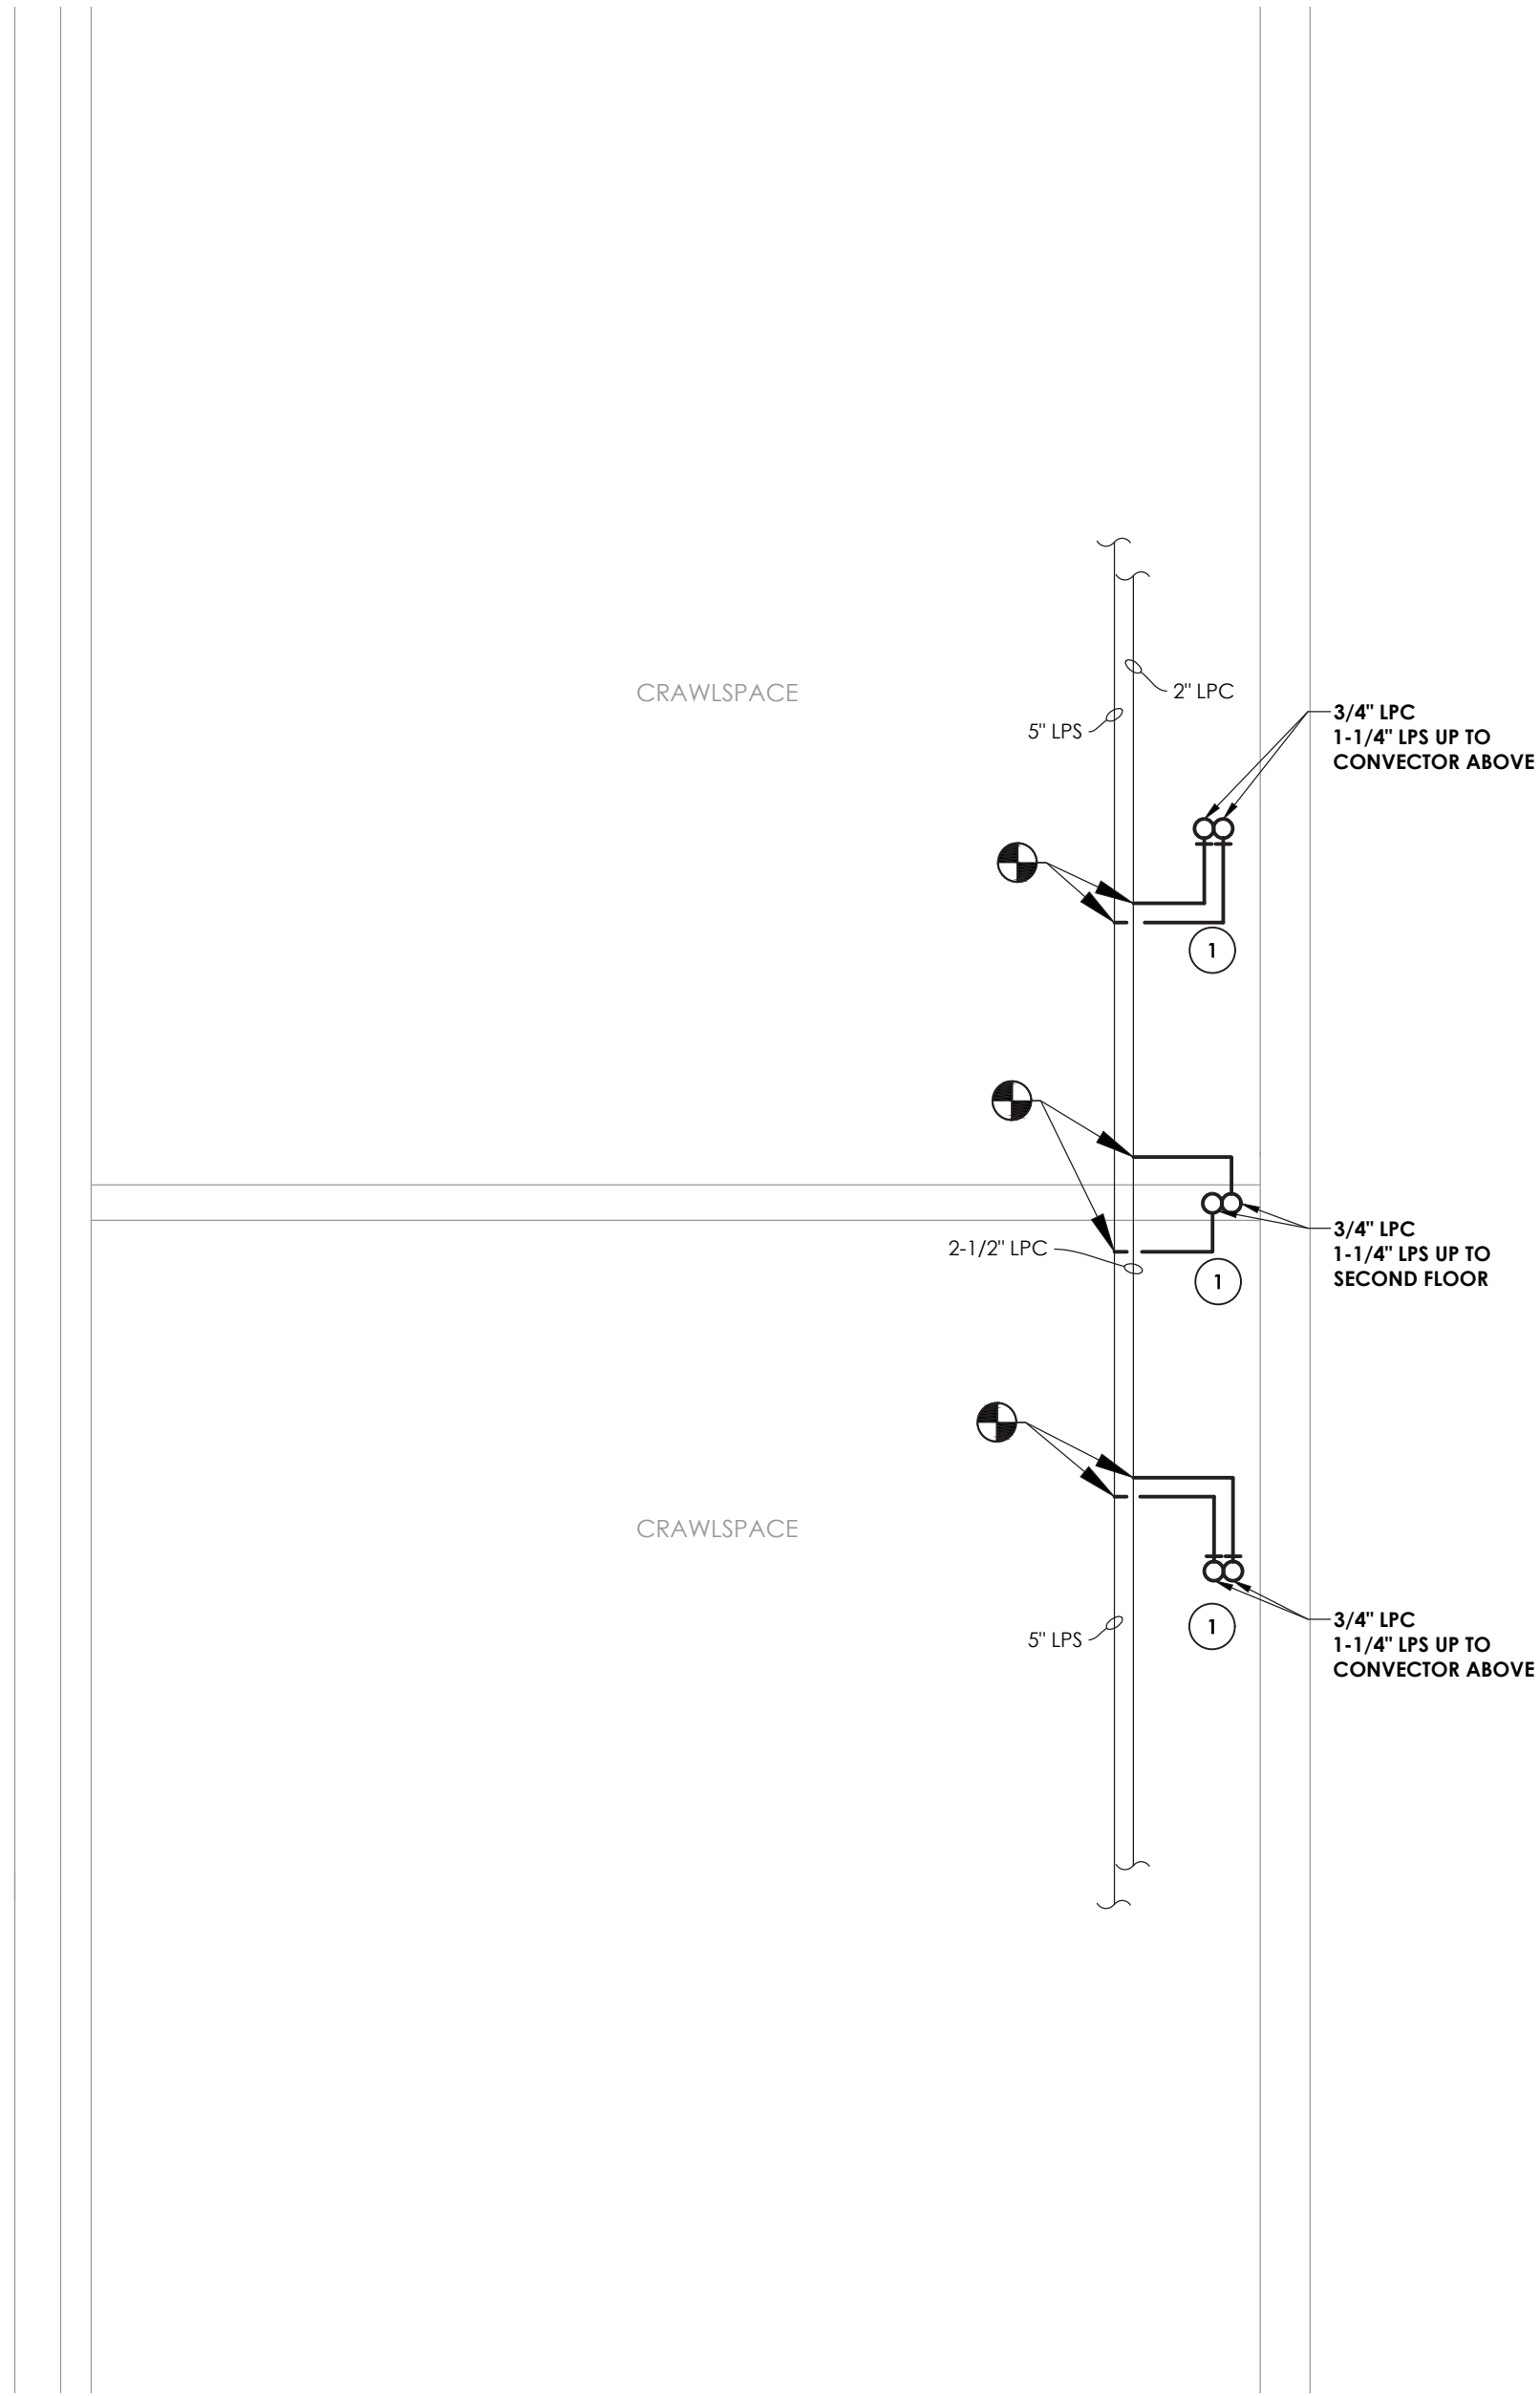


1
H200
CRAWLSPACE BELOW T-1 AND T-2 HVAC NEW WORK PLAN
SCALE: 1/4" = 1'-0"

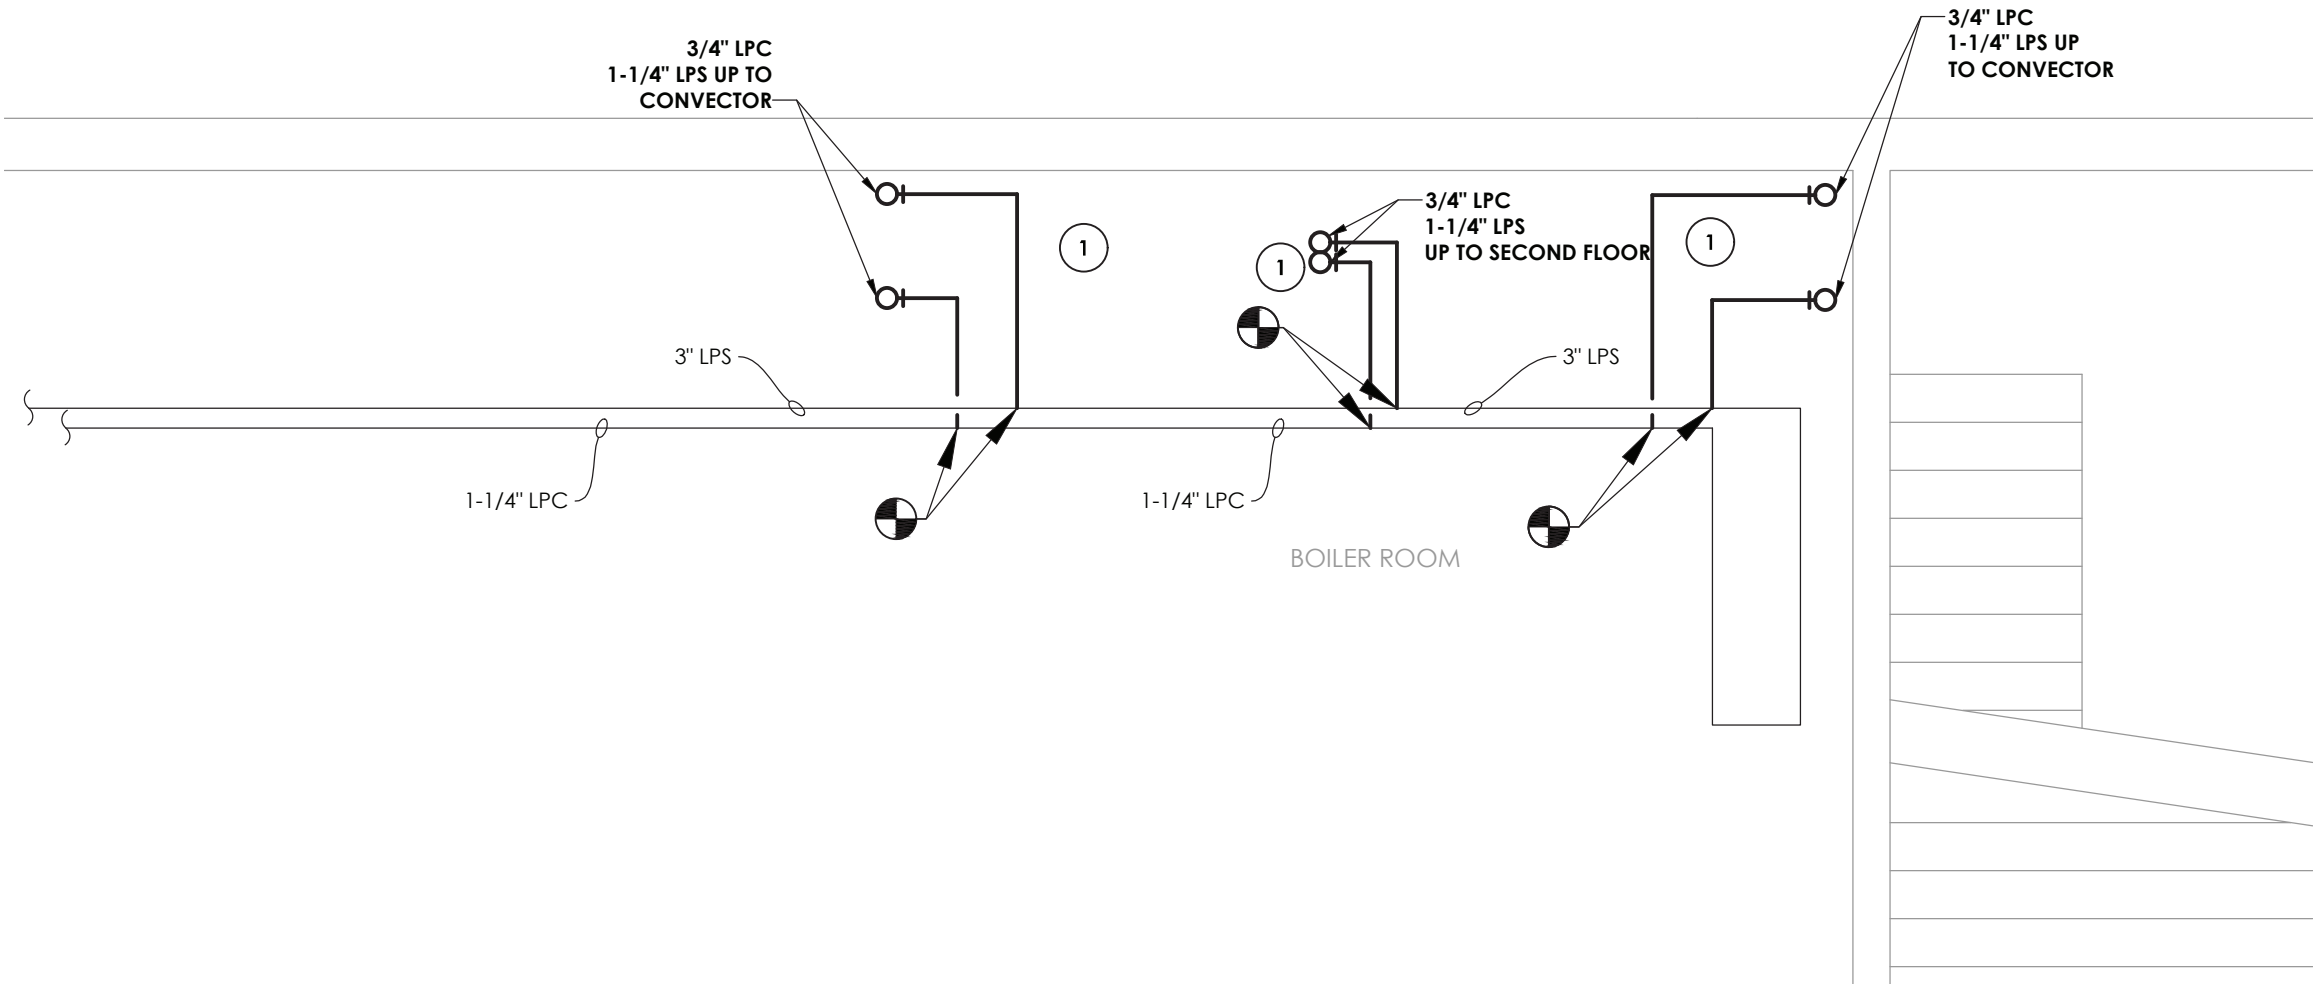

2
H200
CRAWLSPACE BELOW T-11 AND T-12 HVAC NEW WORK PLAN
SCALE: 1/4" = 1'-0"

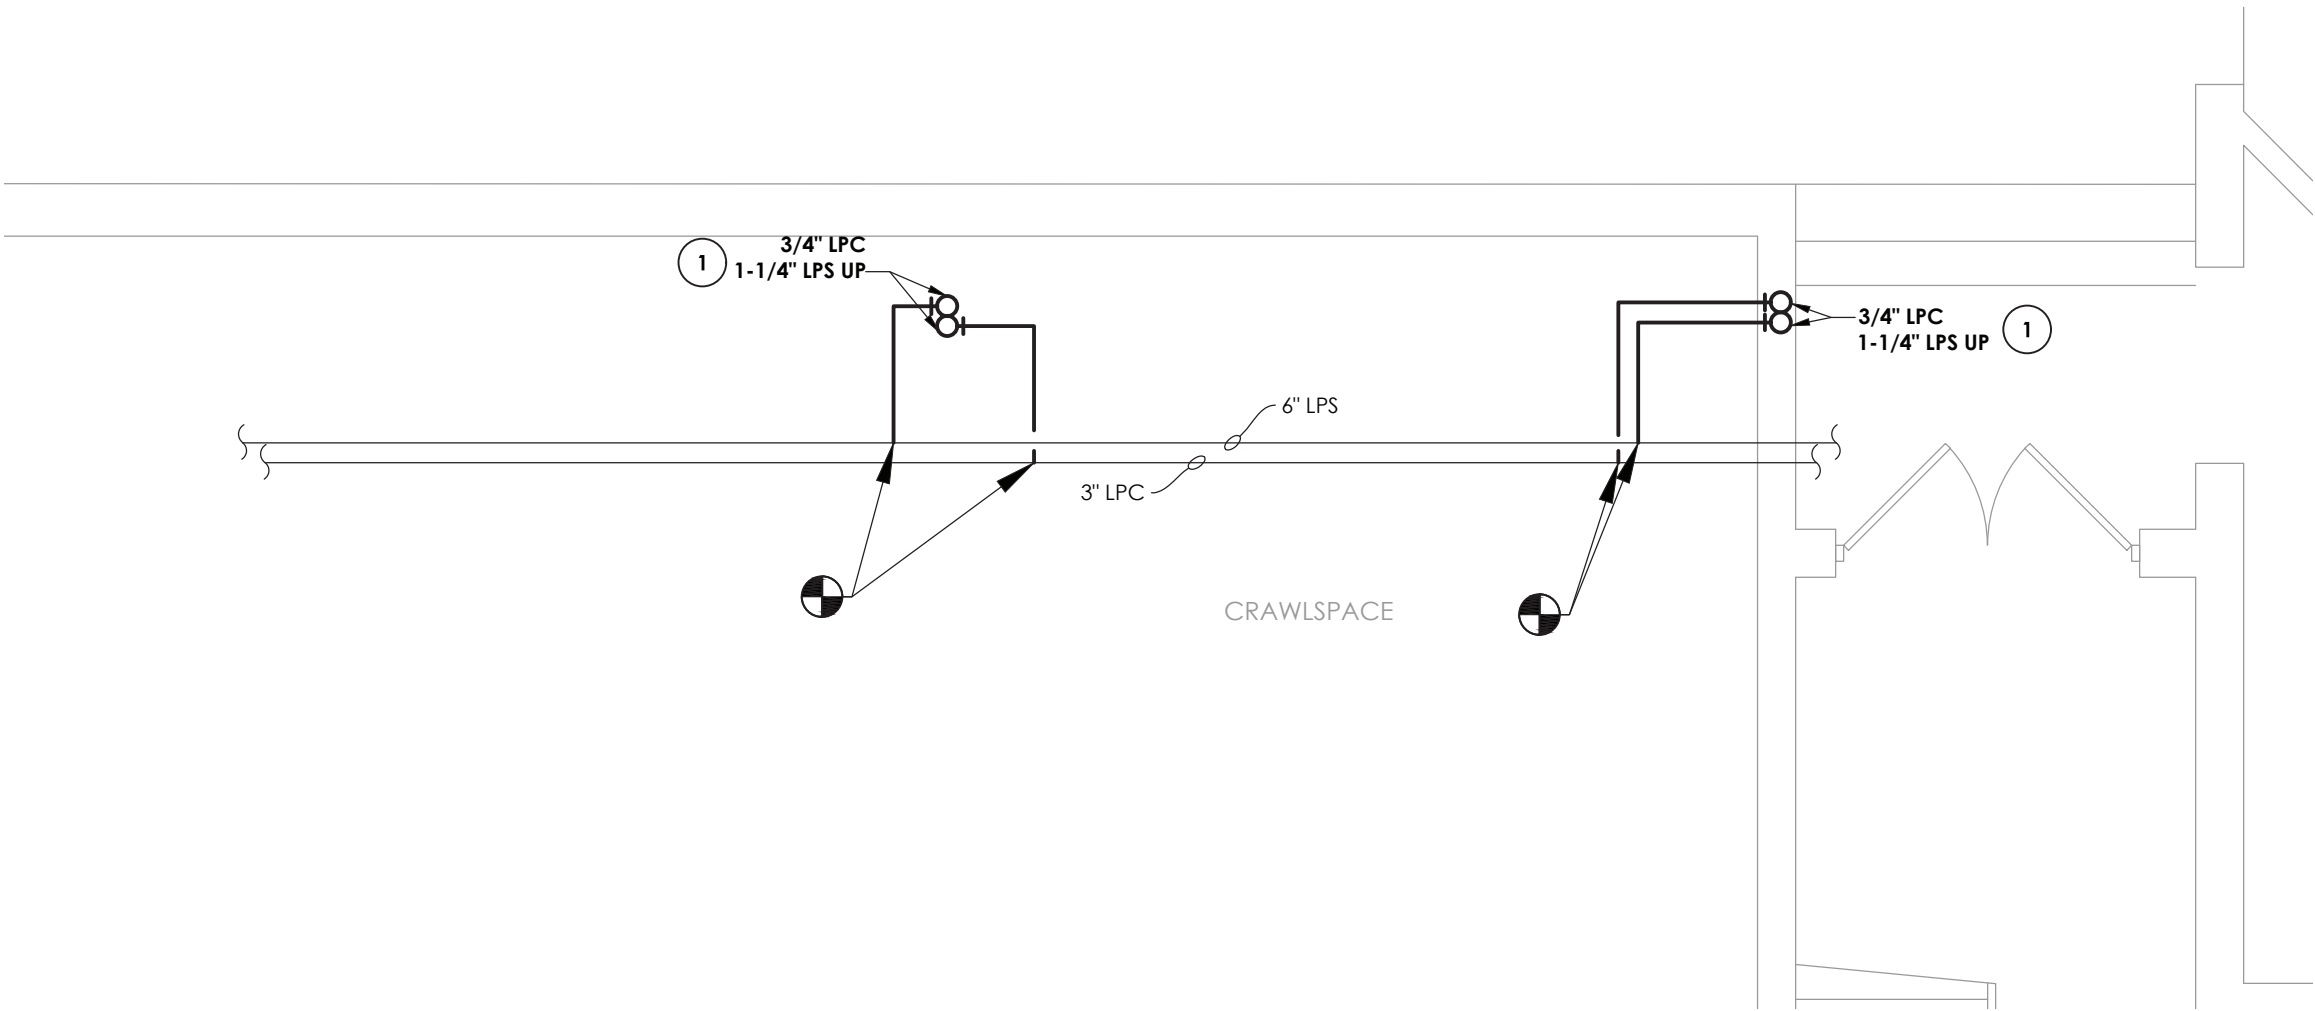

3
H200
CRAWLSPACE BELOW T-15 AND T-16 HVAC NEW WORK PLAN
SCALE: 1/4" = 1'-0"

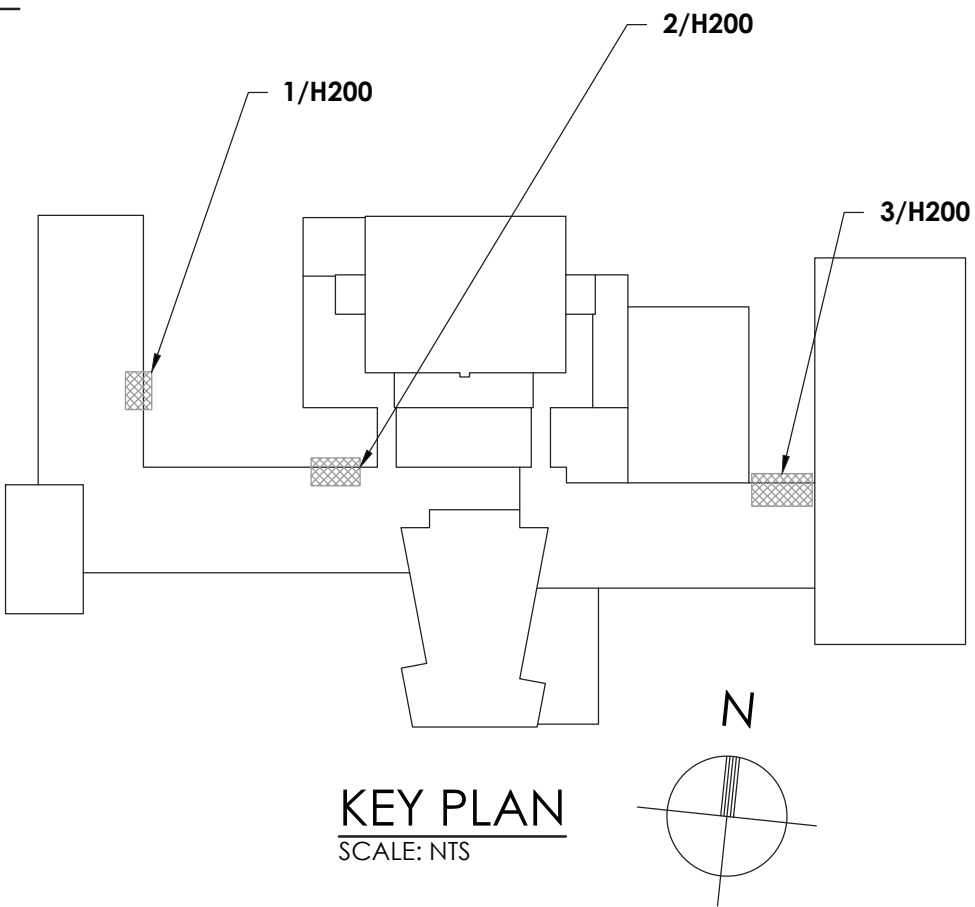

KEY PLAN
SCALE: NTS

GENERAL NOTE:

1. ALL CONTROLS WORK SHALL BE PERFORMED BY TECHNICAL BUILDING SERVICES, INC.
CONTACT: ED ROCKSTROH
(P): (518) 885-4444
(E): edrockstroh@tbscontrols.com

KEY NOTES:

- 1 CONNECT NEW PIPING TO EXISTING MAINS FROM ROOM ABOVE.



CPLteam.com
ARCHITECTURE • ENGINEERING • PLANNING

50 FRONT STREET, SUITE 202
NEWBURGH, NEW YORK 12550
TEL (800) 274-9000

REVISIONS	DESCRIPTION	
	NO.	DATE




POUGHKEEPSIE CITY SCHOOL DISTRICT
2020 CAPITAL IMPROVEMENT PROJECT
PHASE 1B: BUILDING IMPROVEMENTS

- POUGHKEEPSIE HIGH SCHOOL: SED# 13-15-00-01-0-007-018
- POUGHKEEPSIE MIDDLE SCHOOL: SED# 13-15-00-01-0-008-021
- POUGHKEEPSIE ELEMENTARY SCHOOL: SED# 13-15-00-01-0-009-014
- KREGER ELEMENTARY SCHOOL: SED# 13-15-00-01-0-004-014
- MORSE ELEMENTARY SCHOOL: SED# 13-15-00-01-0-002-014
- WARRING ELEMENTARY SCHOOL: SED# 13-15-00-01-0-005-013
- COLLINSVILLE ELEMENTARY SCHOOL: SED# 13-15-00-01-0-001-014

DATE	DRAWN	CHECKED
10/20/2021	BKM	AJS
SCALE: AS NOTED		
SHEET TITLE		
HIGH SCHOOL CRAWLSPACE HVAC DEMOLITION PLANS		

PROJECT NUMBER
14078.09

PHS
H200
DRAWING NUMBER

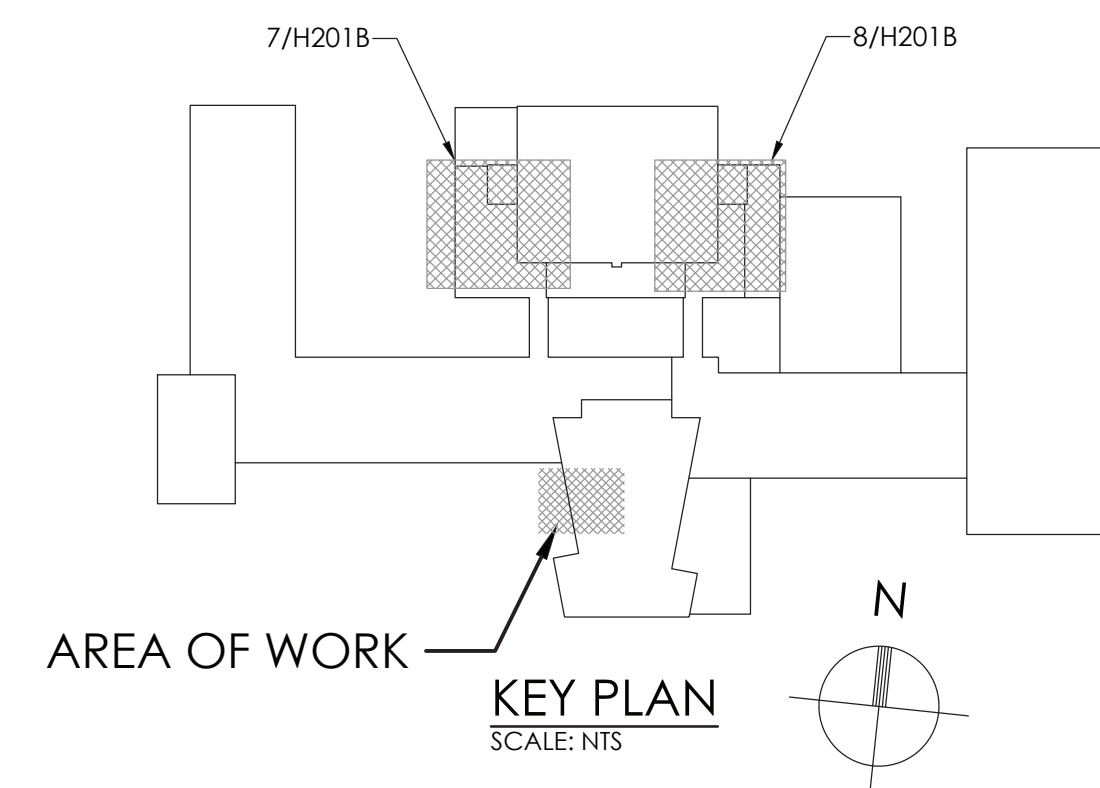

GENERAL NOTE:

1. ALL CONTROLS WORK SHALL BE PERFORMED BY TECHNICAL BUILDING SERVICES, INC.
CONTACT: ED ROCKSTROH
(P): (518) 885-4444
(E): edrockstroh@bscontrols.com
2. ALT 1A: INSTALL INSULATION ON EXISTING DUCTS FOR PHS-RTU-3 & PHS-RTU-4.

KEY NOTES:


1. INSTALL NEW GRILLES.
2. ADD NEW DUCT WORK AND CONNECT TO EXISTING EXHAUST FAN WHERE INDICATED.
3. RELOCATE AND MODIFY DUCTWORK AS NECESSARY TO RECONNECT EXISTING EXHAUST DUCTWORK AND GRILLES TO NEW.

[illegible]


**POUGHKEEPSIE CITY SCHOOL DISTRICT
2020 CAPITAL IMPROVEMENT PROJECT
PHASE 1B: BUILDING IMPROVEMENTS**

- Poughkeepsie High School, SEDF: 13-15-0001-0-0007-018
- Poughkeepsie Junior High School, SEDF: 13-15-0001-0-0007-018
- Clinton Elementary School, SEDF: 13-15-0001-0-0004-014
- Krueger Elementary School, SEDF: 13-15-0001-0-0004-014
- Morse Elementary School, SEDF: 13-15-0001-0-0002-014
- Poughkeepsie Middle School, SEDF: 13-15-0001-0-0002-014
- Smith Early Learning Center, SEDF: 13-15-0001-0-0008-022
- Columbus Elementary School, SEDF: 13-15-0001-0-0001-014

DATE 10/20/2021	DRAWN BKM	CHECKED AJS
SCALE AS NOTED		
SHEET TITLE HIGH SCHOOL FIRST FLOOR LOCKER ROOMS NEW WORK PLANS		

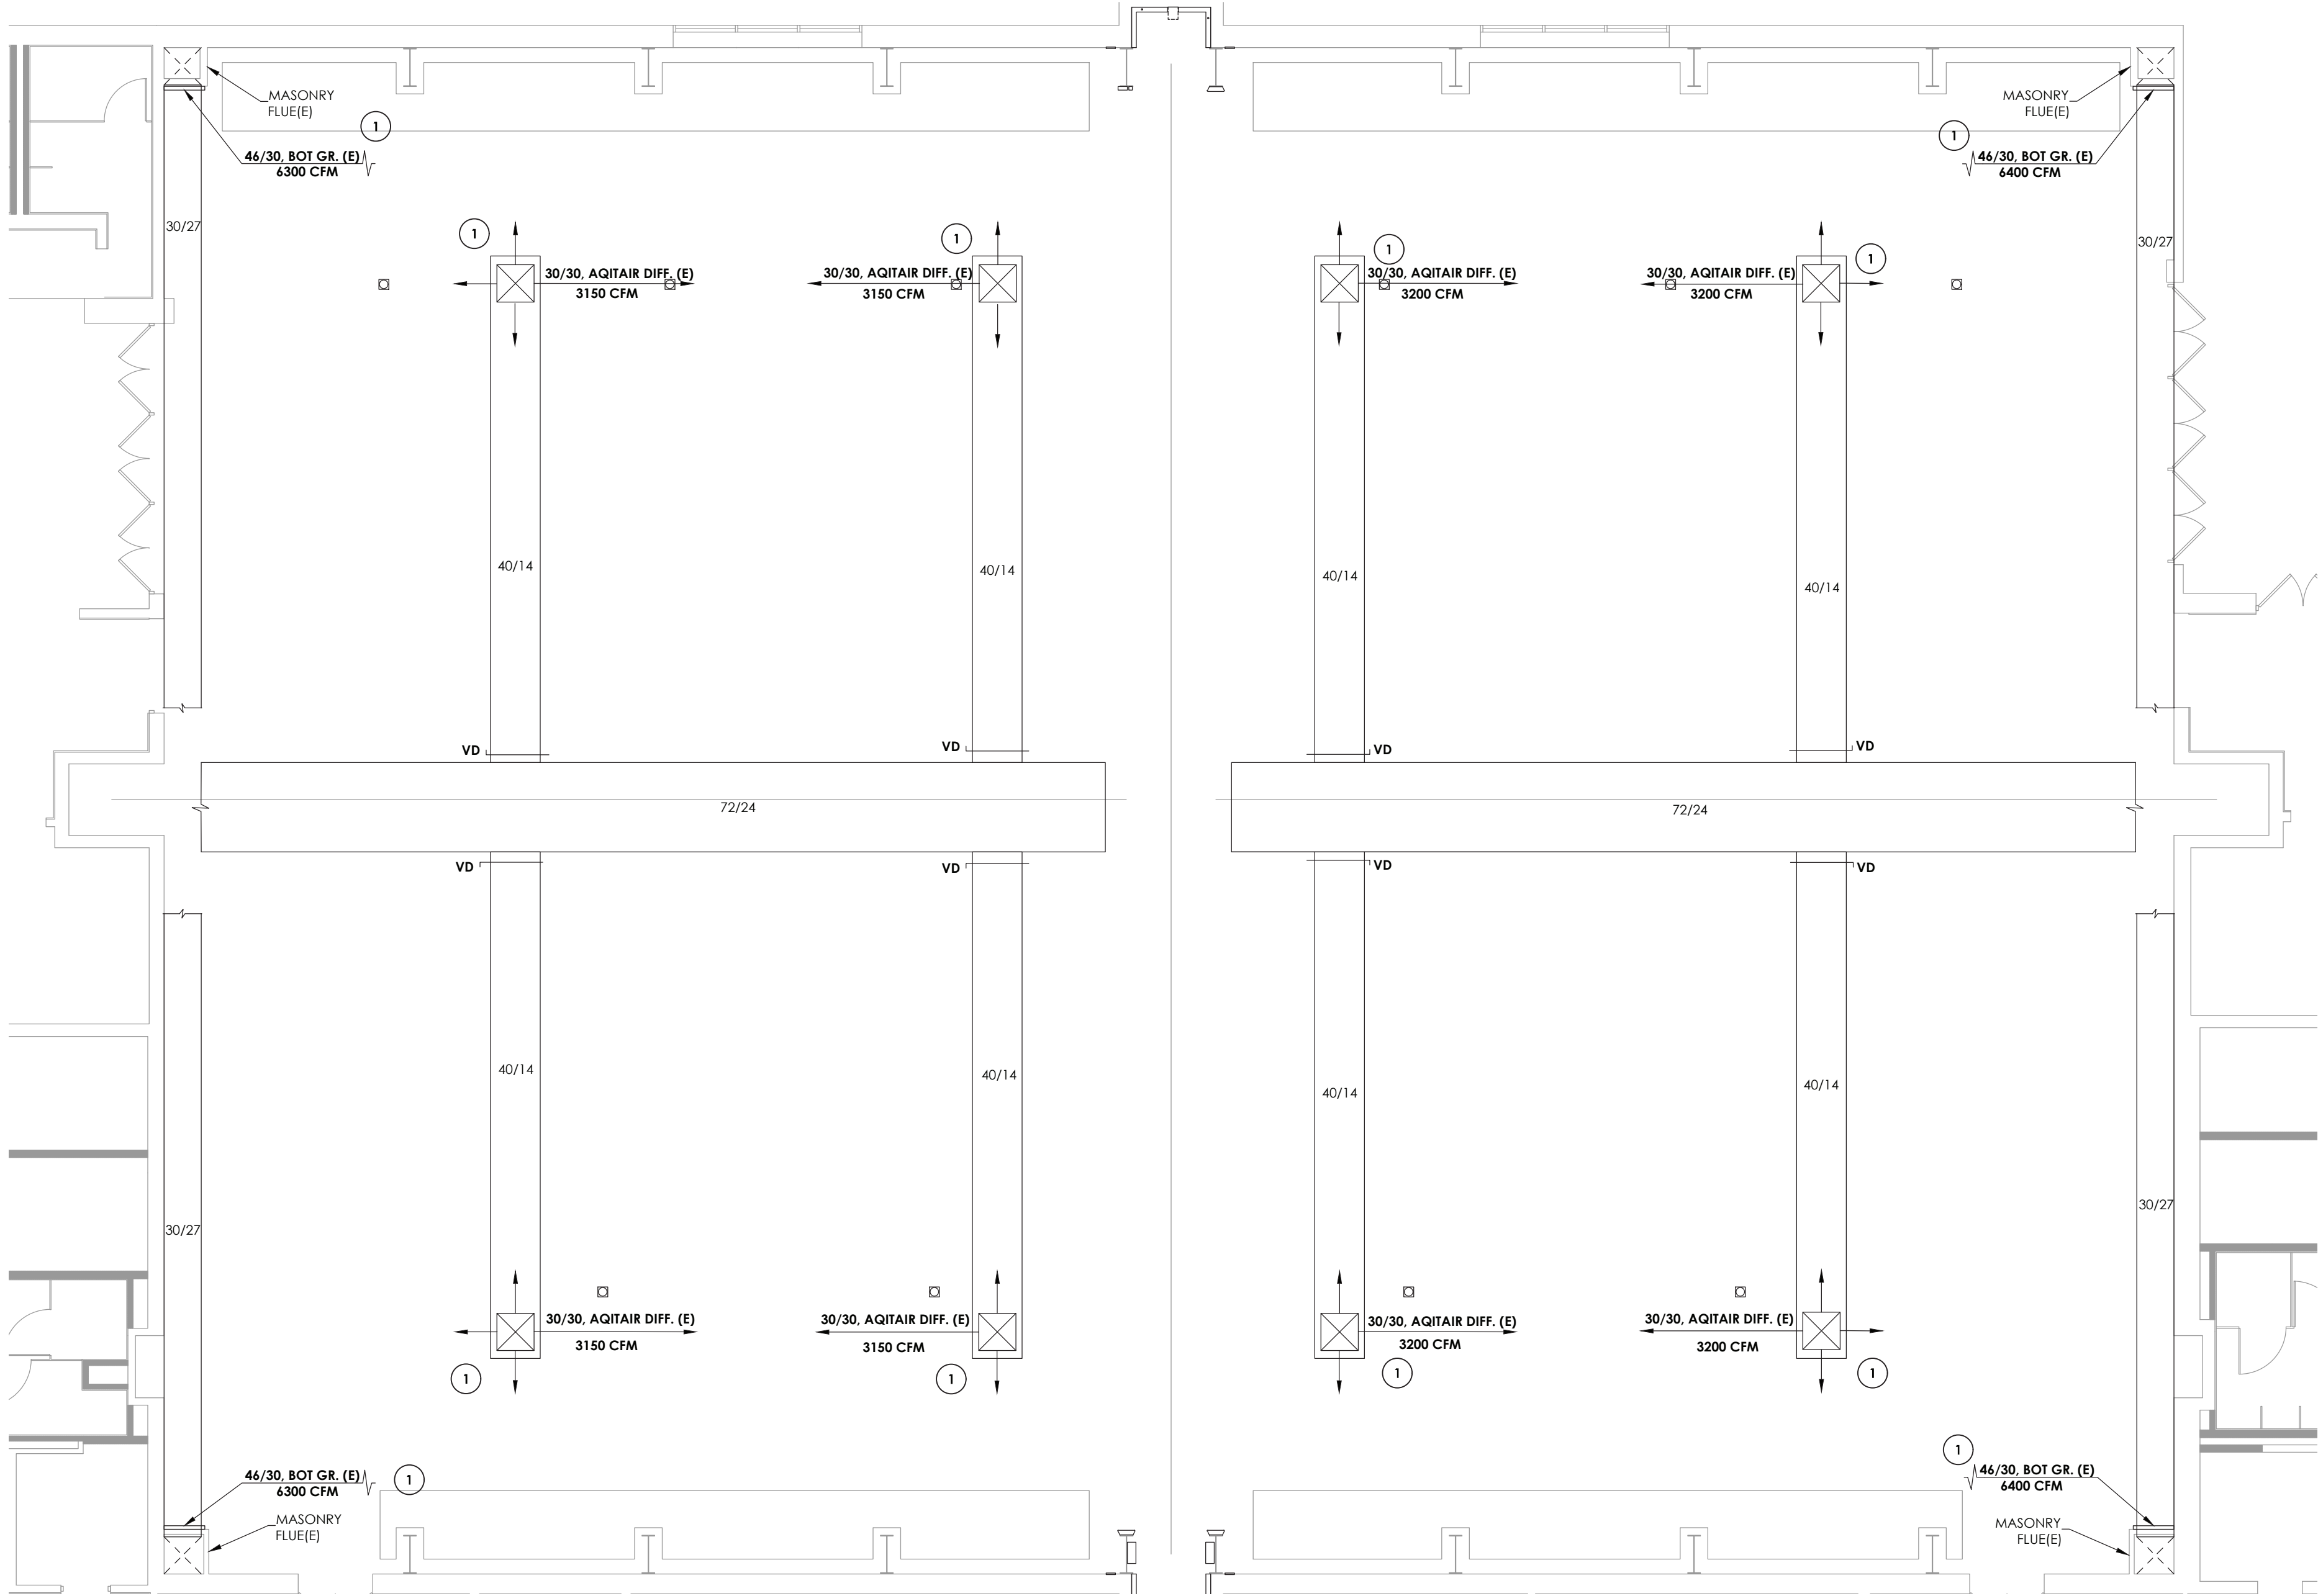

1
H201C
GYM HVAC NEW WORK PLAN
SCALE: 1/8" = 1'-0"

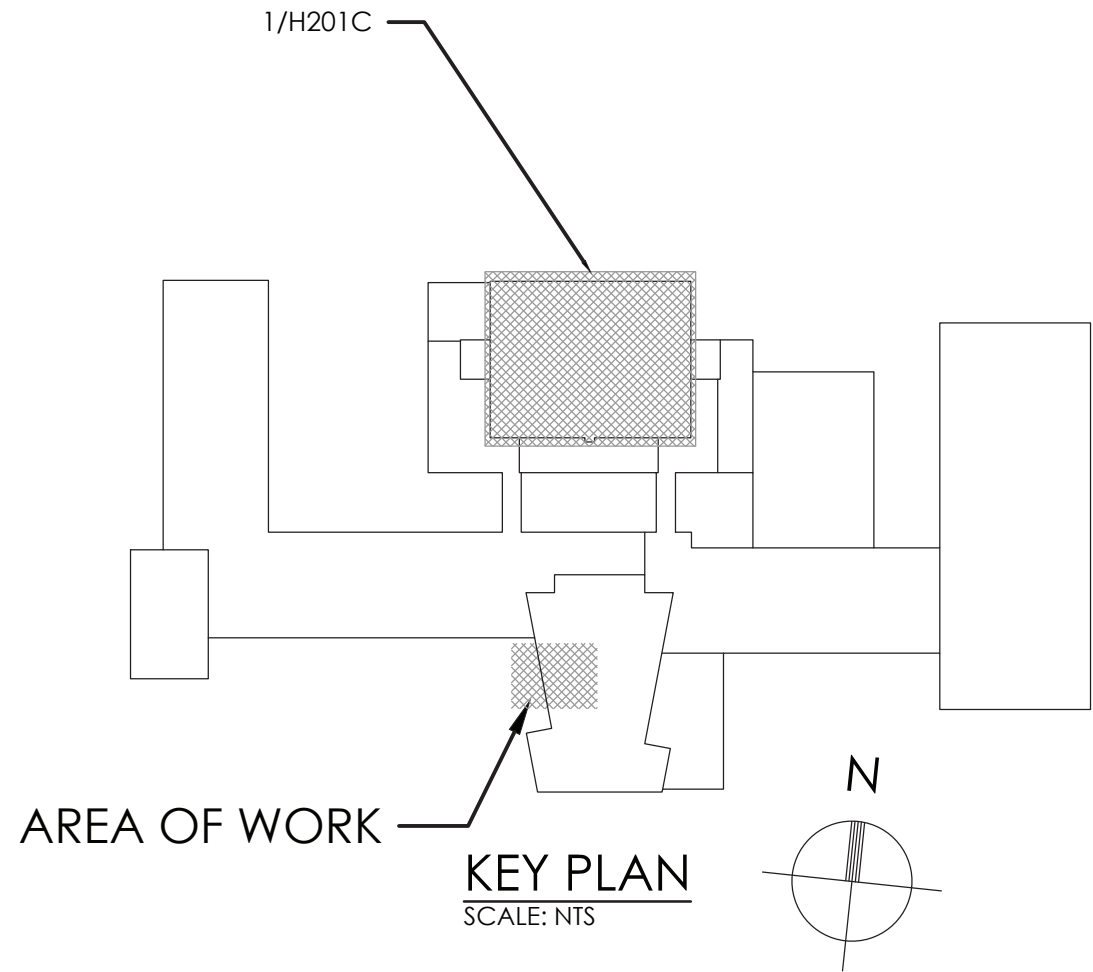

- GENERAL NOTE:**
1. ALL CONTROLS WORK SHALL BE PREFORMED BY DAY AUTOMATIONS. CONTACT scott.sullivan@dayautomation.com
 2. **ALT 1A:** INSTALL INSULATION ON EXISTING DUCTS FOR PHS-RTU-1 & PHS-RTU-2.

- KEY NOTES:**
- 1 EXISTING AQITAIR DIFFUSERS TO BE RE-BALANCED.



CPLteam.com
ARCHITECTURE • ENGINEERING • PLANNING

50 FRONT STREET, SUITE 202
NEWBURGH, NEW YORK 12550
TEL (800) 274-9000

REVISIONS		DESCRIPTION
NO.	DATE	BY

POUGHKEEPSIE CITY SCHOOL DISTRICT
2020 CAPITAL IMPROVEMENT PROJECT
PHASE 1B: BUILDING IMPROVEMENTS

- POUGHKEEPSIE HIGH SCHOOL: SED# 13-15-00-01-0-007-018
- POUGHKEEPSIE MIDDLE SCHOOL: SED# 13-15-00-01-0-008-021
- POUGHKEEPSIE ELEMENTARY SCHOOL: SED# 13-15-00-01-0-009-014
- KREGER ELEMENTARY SCHOOL: SED# 13-15-00-01-0-004-014
- WARRING ELEMENTARY SCHOOL: SED# 13-15-00-01-0-002-014
- WARRING ELEMENTARY SCHOOL: SED# 13-15-00-01-0-005-013
- WARRING ELEMENTARY SCHOOL: SED# 13-15-00-01-0-006-014
- COLLINSVILLE ELEMENTARY SCHOOL: SED# 13-15-00-01-0-001-014


DATE	DRAWN	CHECKED
10/20/2021	DJB	AJS

SCALE: AS NOTED


SHEET TITLE
HIGH SCHOOL FIRST
FLOOR HVAC TOILET
ROOM DEMOLITION
PLANS B

PROJECT NUMBER
14078.09


PHS
H201C
DRAWING NUMBER

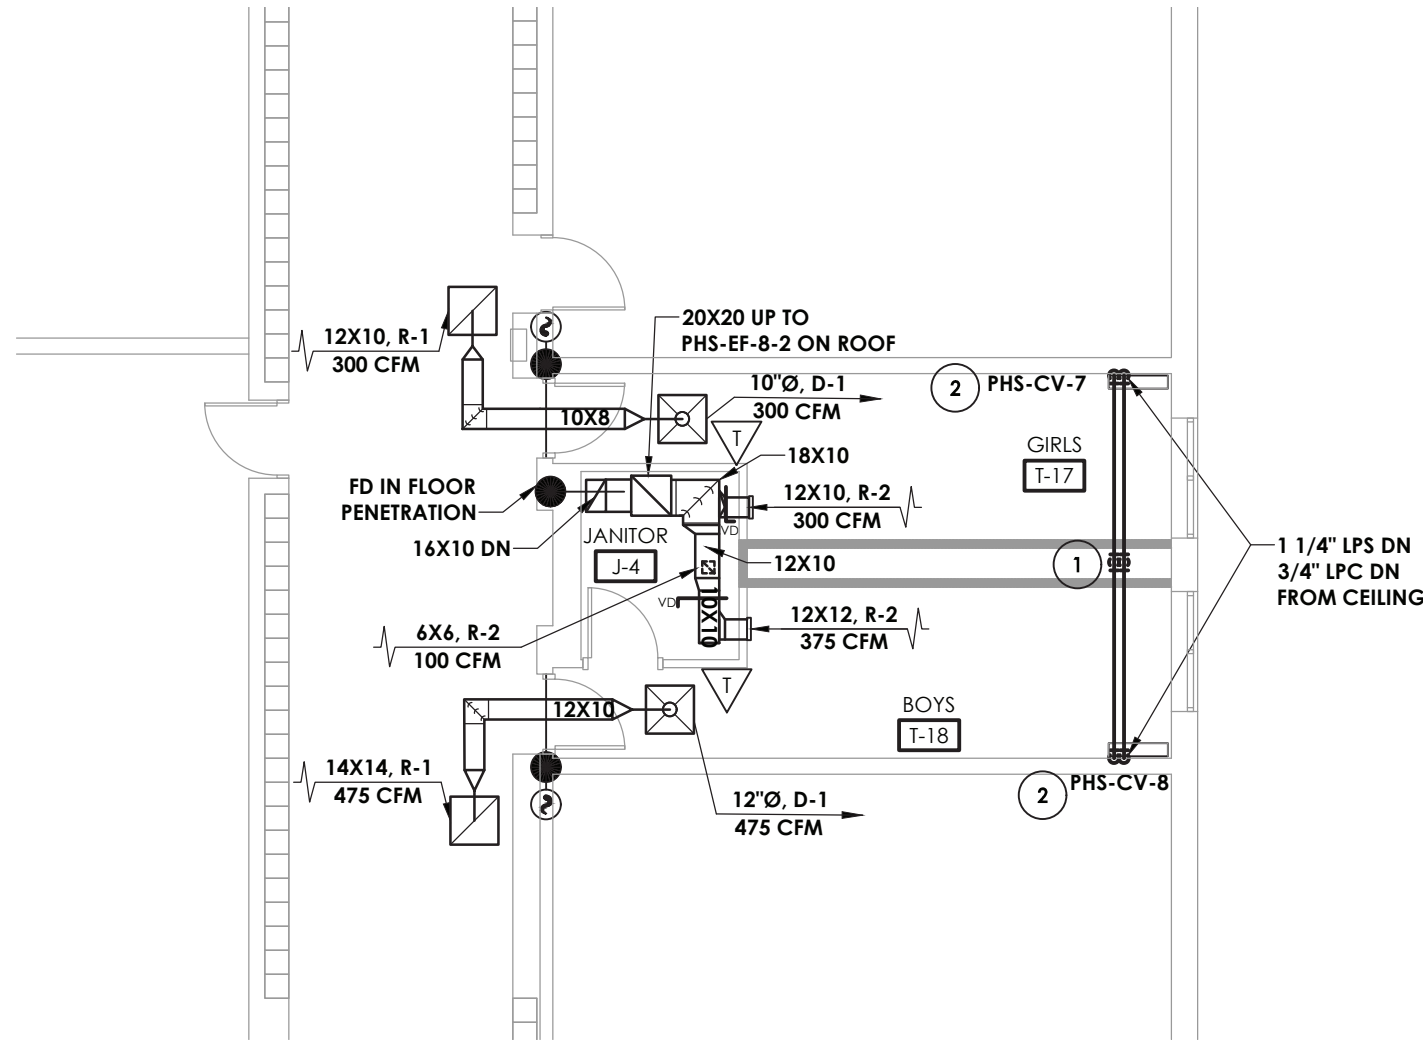


1
H202
SECOND FLOOR TOILET ROOMS T-17 & T-18 HVAC NEW WORK PLAN
SCALE: 1/8" = 1'-0"

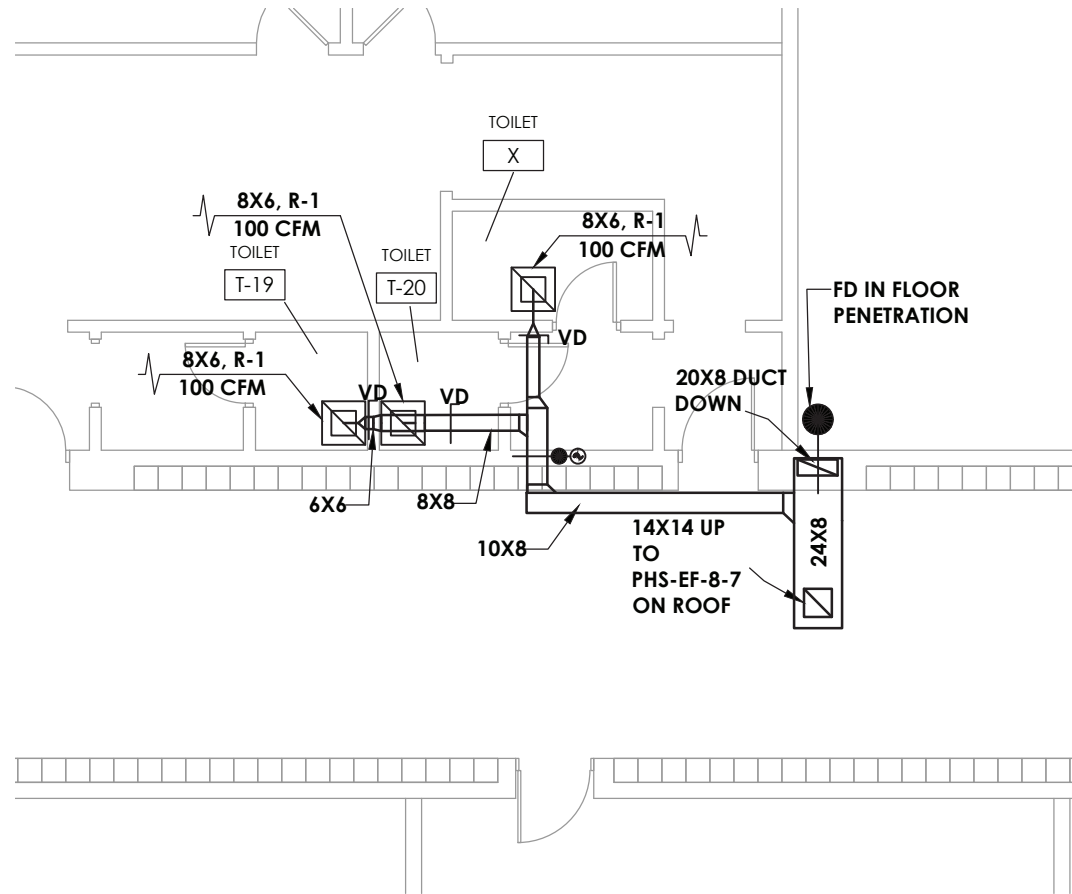


2
H202
SECOND FLOOR TOILET ROOMS T-19 & T-20 HVAC NEW WORK PLAN
SCALE: 1/8" = 1'-0"

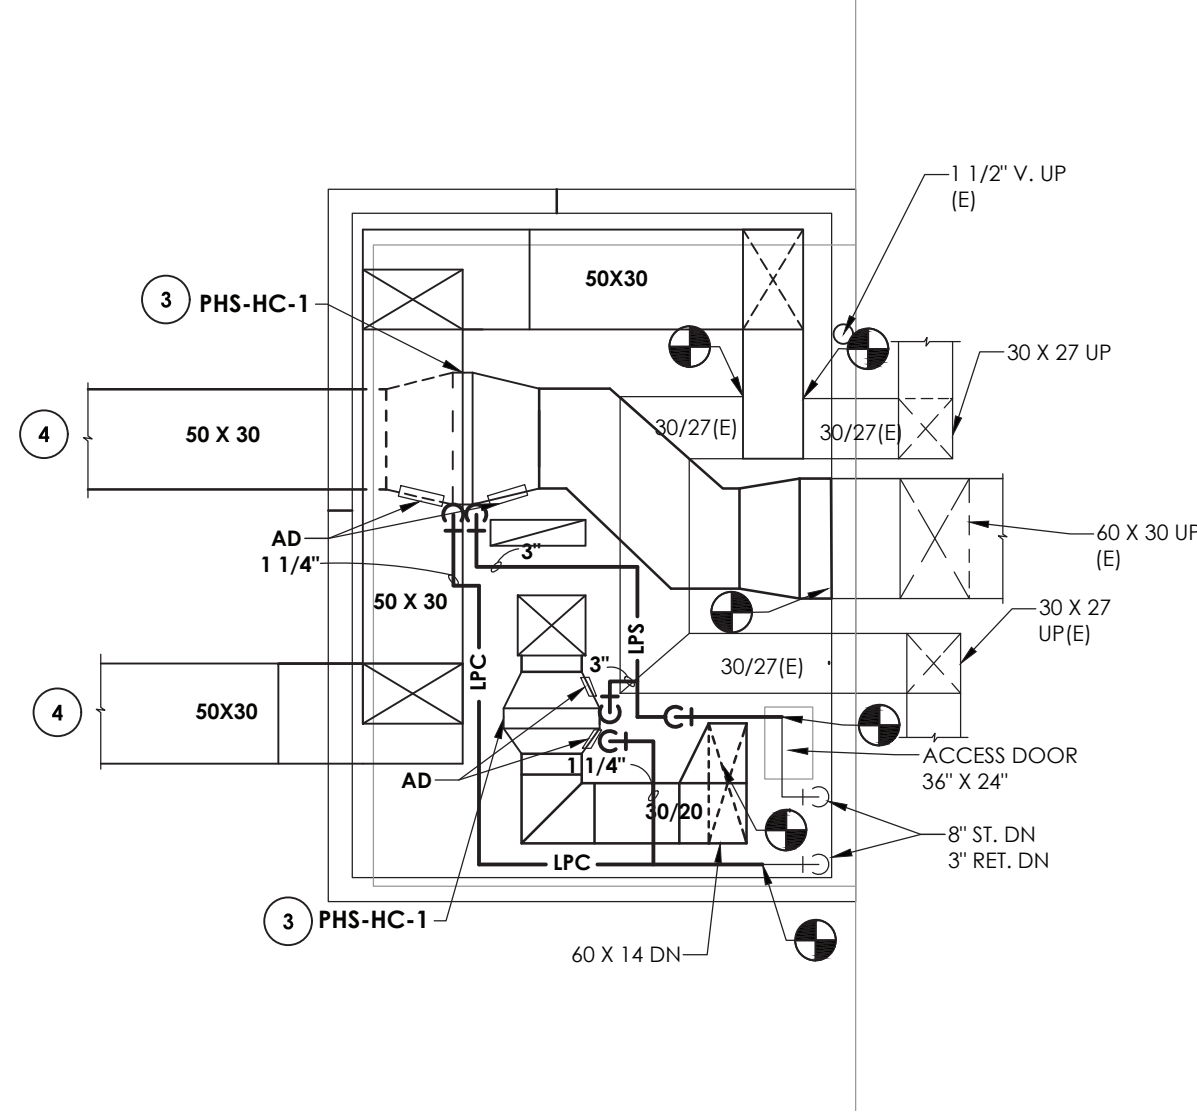


3
H202
FAN ROOM 1 HVAC NEW WORK PLAN (GIRLS)
SCALE: 1/4" = 1'-0"

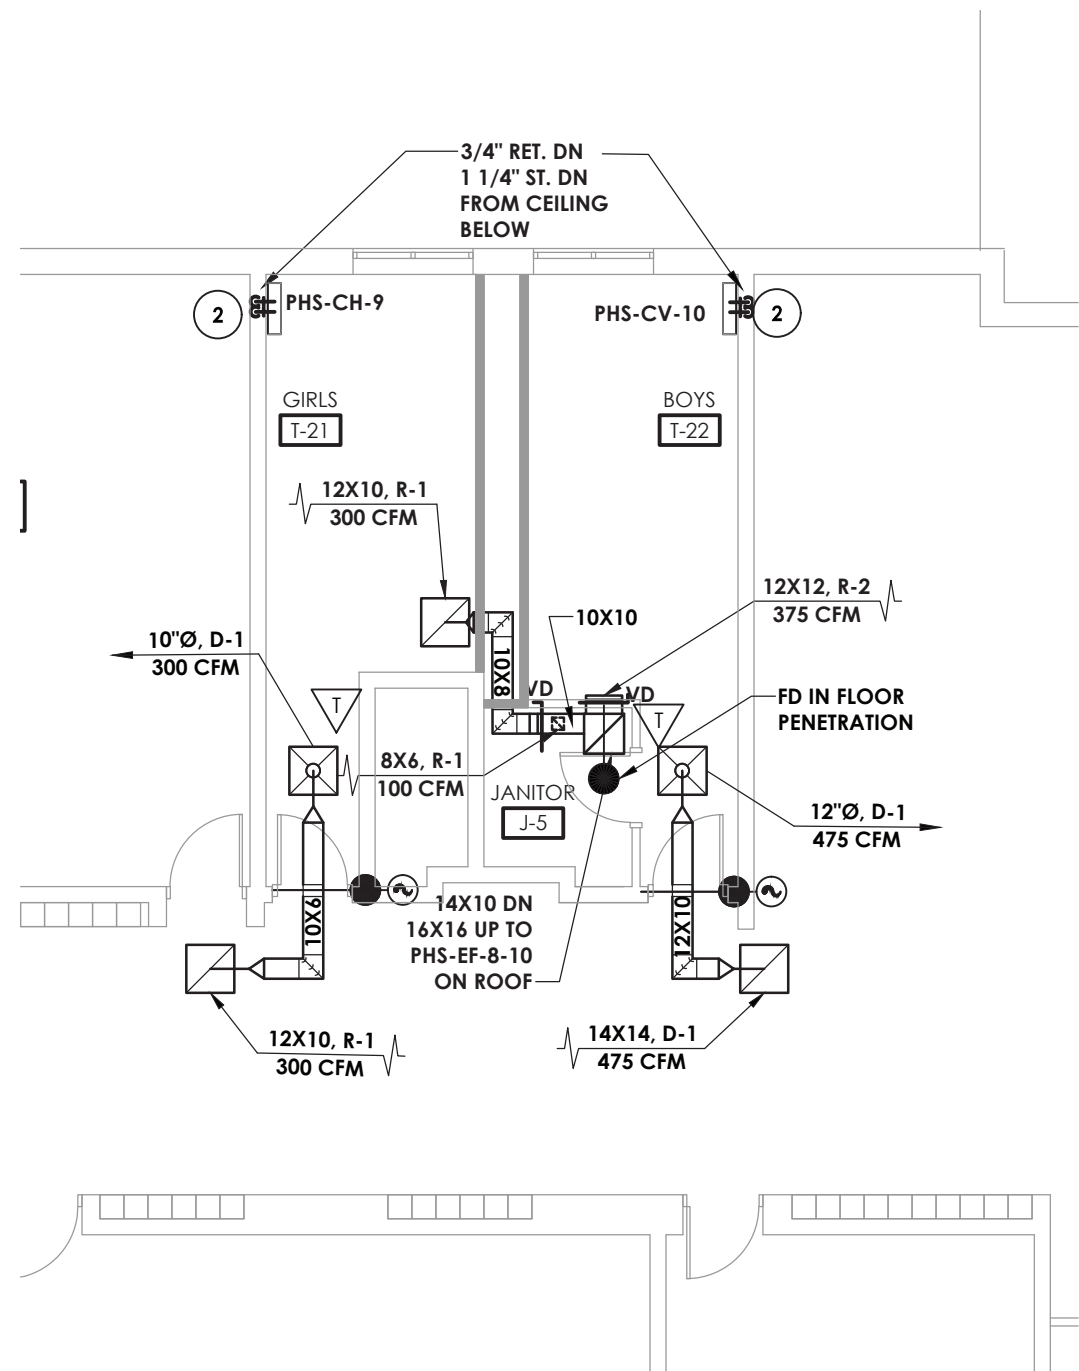


4
H202
SECOND FLOOR TOILET ROOMS T-21 & T-22 HVAC NEW WORK PLAN
SCALE: 1/8" = 1'-0"

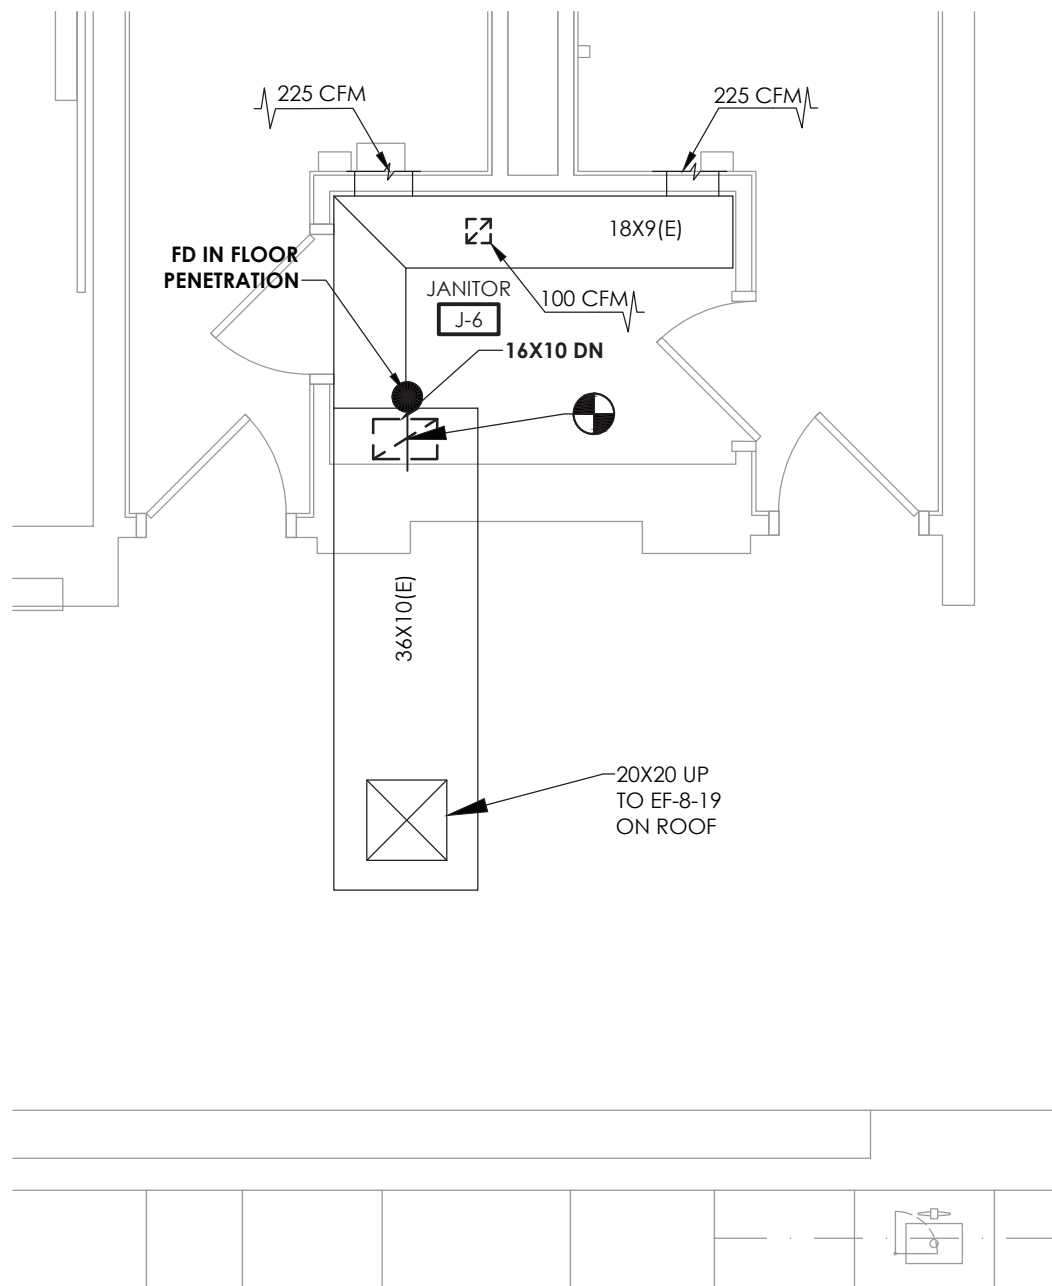

5
H202
SECOND FLOOR TOILET ROOMS T-23 & T-24 HVAC NEW WORK PLAN
SCALE: 1/4" = 1'-0"

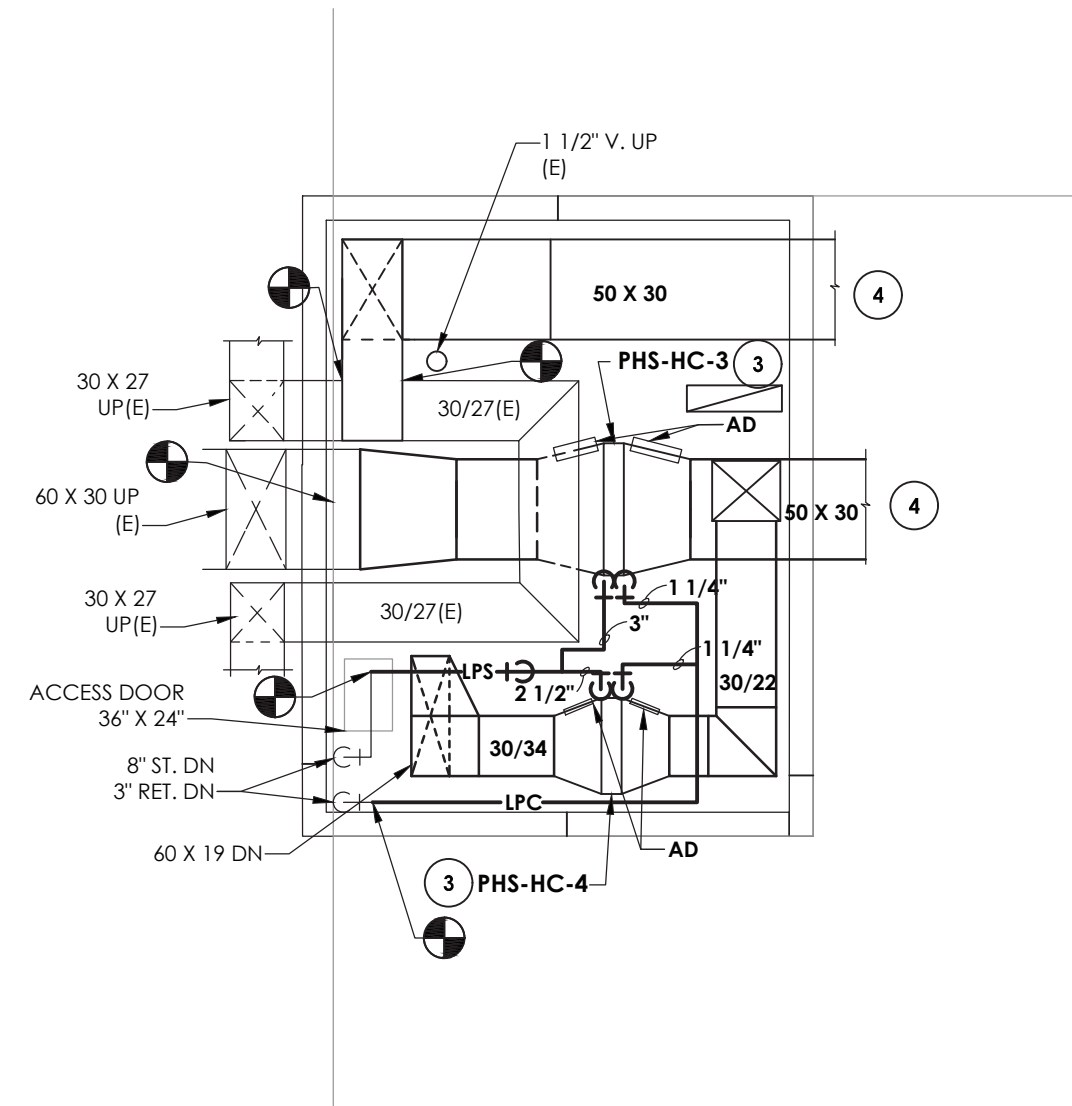

6
H202
FAN ROOM 2 HVAC NEW WORK PLAN (BOYS)
SCALE: 1/4" = 1'-0"

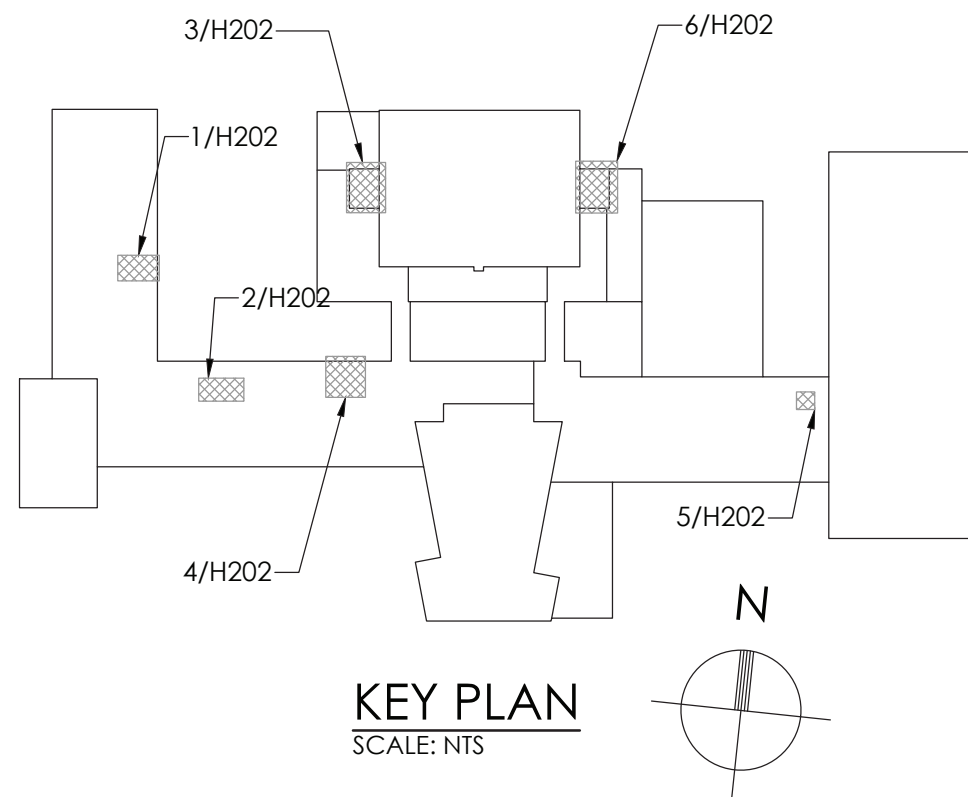

GENERAL NOTE:

1. ALL CONTROLS WORK SHALL BE PERFORMED BY TECHNICAL BUILDING SERVICES, INC.
CONTACT: ED ROCKSTROH
(P): (518) 885-4444
(E): edrockstroh@tbscontrols.com

KEY NOTES:

1. RUN NEW STEAM AND CONDENSATE PIPING UP THROUGH PIPE CHASE TO ABOVE CEILING.
2. CONTRACTOR SHALL PROVIDE NEW WALL MOUNTED CONVECTORS INCLUDING CONTROLS AND THERMOSTAT. SEE SCHEDULE.
3. CONNECT NEW STEAM COIL TO EXISTING LPS & LPC MAINS AT POINT INDICATED ON PLAN 3/H202 & 6/H202. SEE DETAILS.
4. SEE ROOF PLAN FOR CONTINUATION.

CPLteam.com
ARCHITECTURE • ENGINEERING • PLANNING

50 FRONT STREET, SUITE 202
NEWBURGH, NEW YORK 12550
TEL (800) 274-9000

REVISIONS	NO.	DATE	BY	DESCRIPTION



POUGHKEEPSIE CITY SCHOOL DISTRICT
2020 CAPITAL IMPROVEMENT PROJECT
PHASE 1B: BUILDING IMPROVEMENTS

- POUGHKEEPSIE HIGH SCHOOL: SED# 13-15-00-01-0-007-018
- POUGHKEEPSIE MIDDLE SCHOOL: SED# 13-15-00-01-0-008-021
- POUGHKEEPSIE ELEMENTARY SCHOOL: SED# 13-15-00-01-0-009-014
- KREGER ELEMENTARY SCHOOL: SED# 13-15-00-01-0-004-014
- MORSE ELEMENTARY SCHOOL: SED# 13-15-00-01-0-002-014
- WARRING ELEMENTARY SCHOOL: SED# 13-15-00-01-0-005-013
- COLLINSVILLE ELEMENTARY SCHOOL: SED# 13-15-00-01-0-001-014


DATE	DRAWN	CHECKED
10/20/2021	BKM	AJS

SCALE: AS NOTED

SHEET TITLE: HIGH SCHOOL SECOND FLOOR HVAC NEW WORK PLANS


PROJECT NUMBER
14078.09

PHS
H202
DRAWING NUMBER

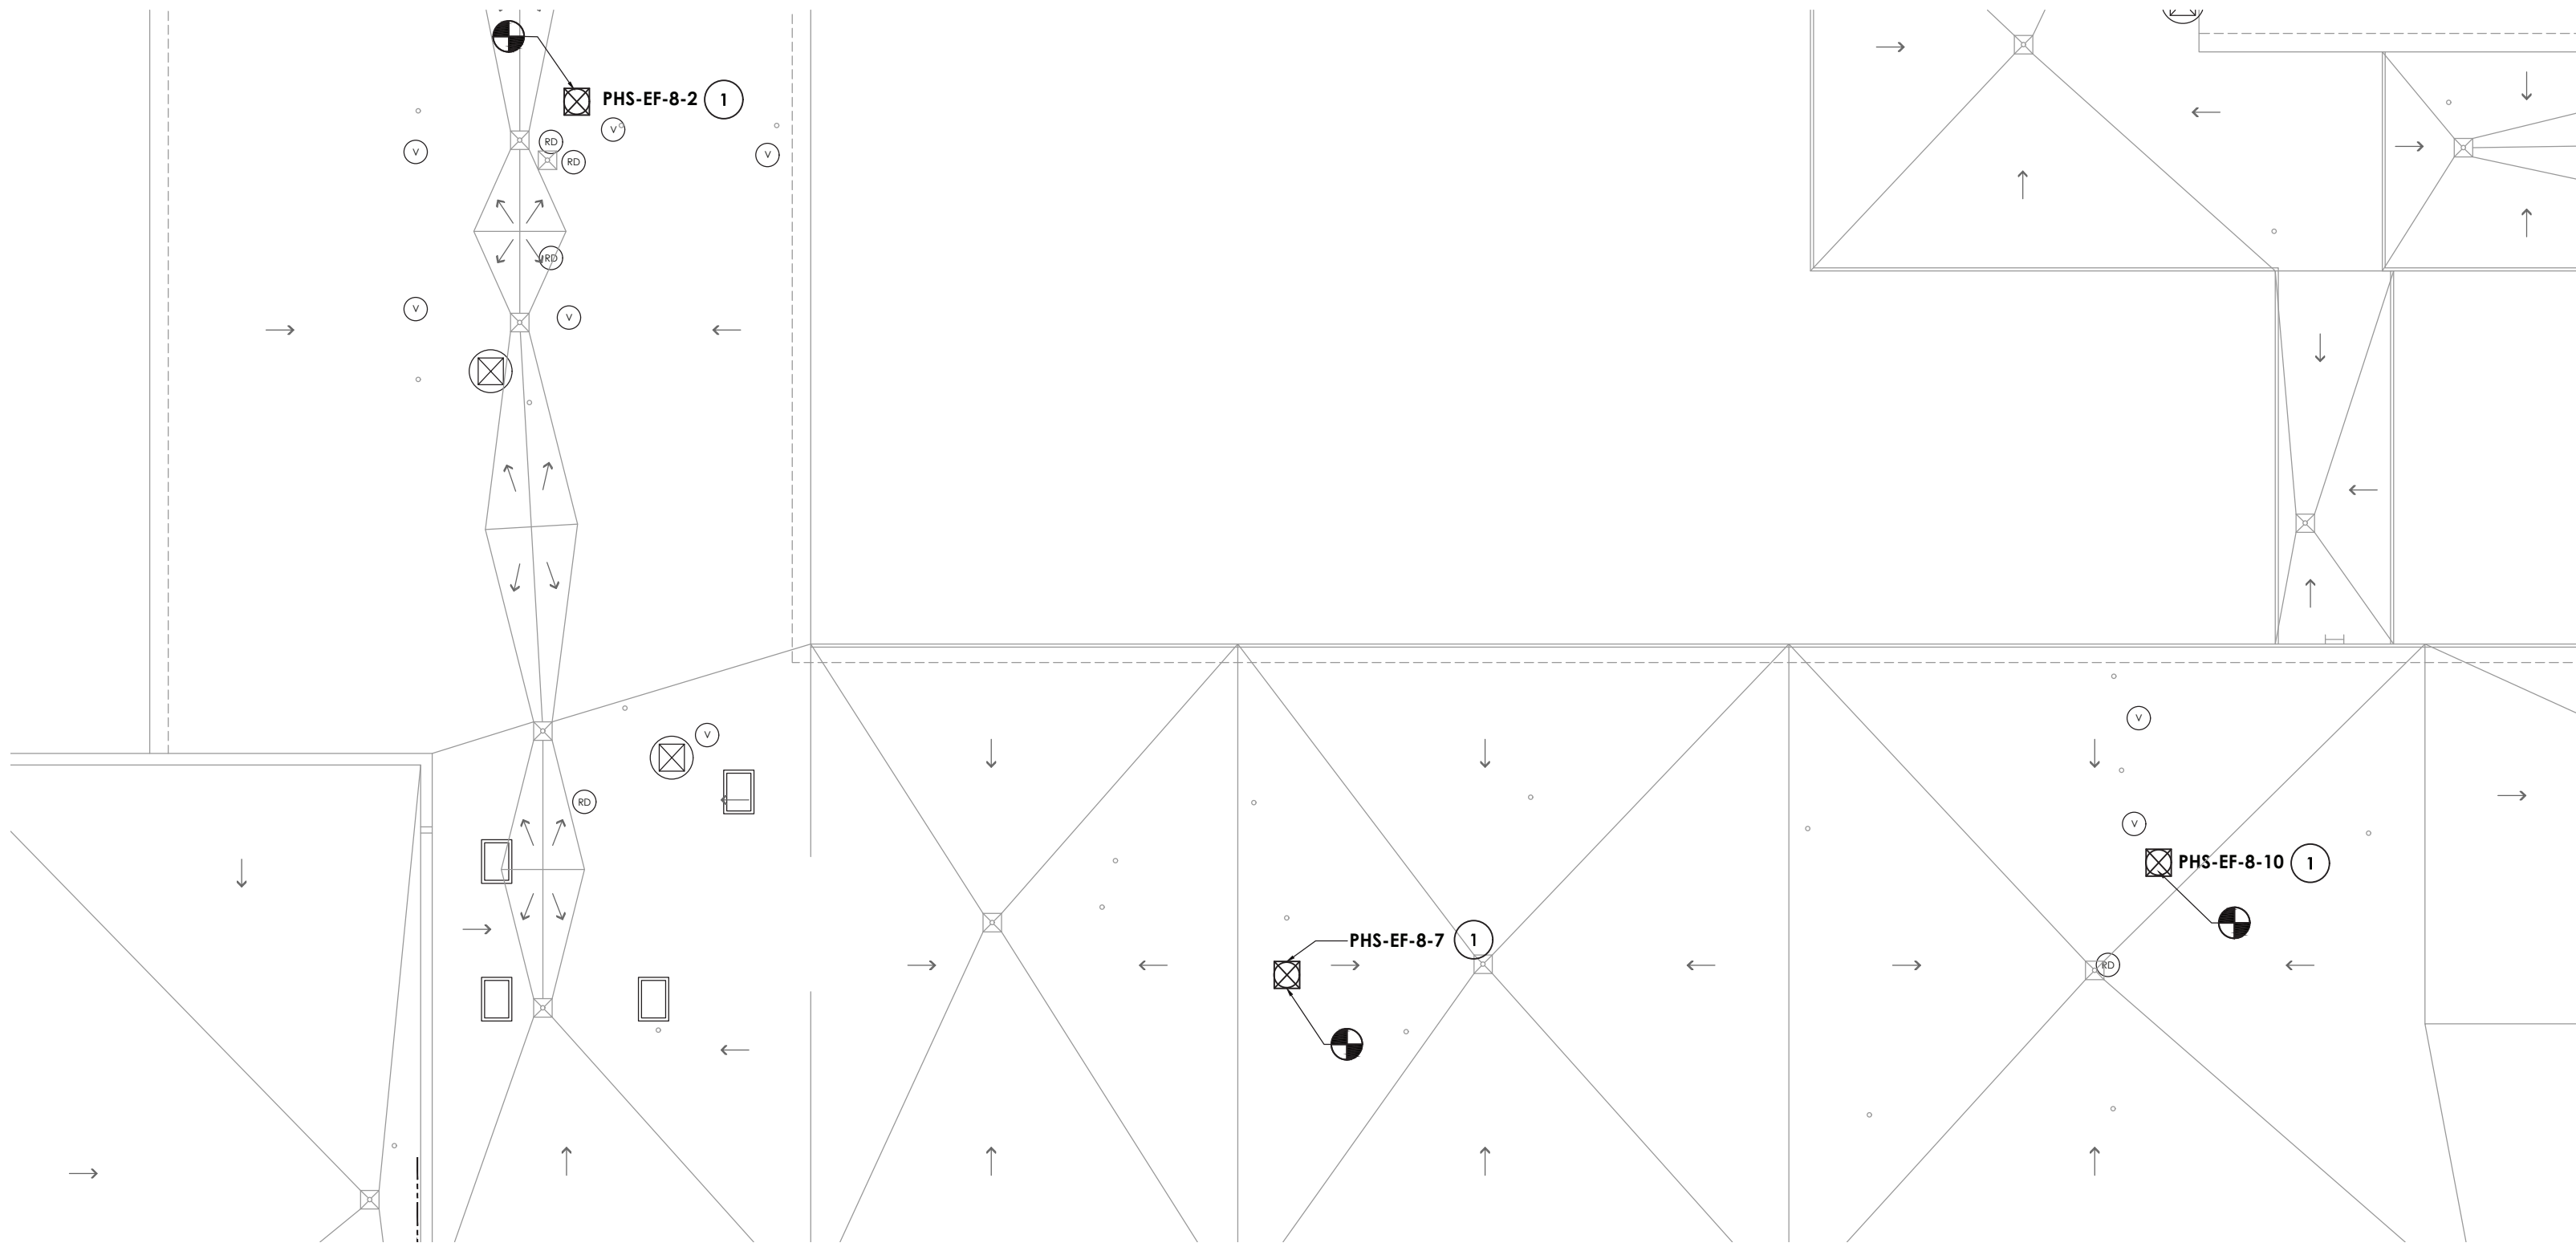


1
H203
SCALE: 1/16" = 1'-0"

ROOF HVAC NEW WORK PLAN

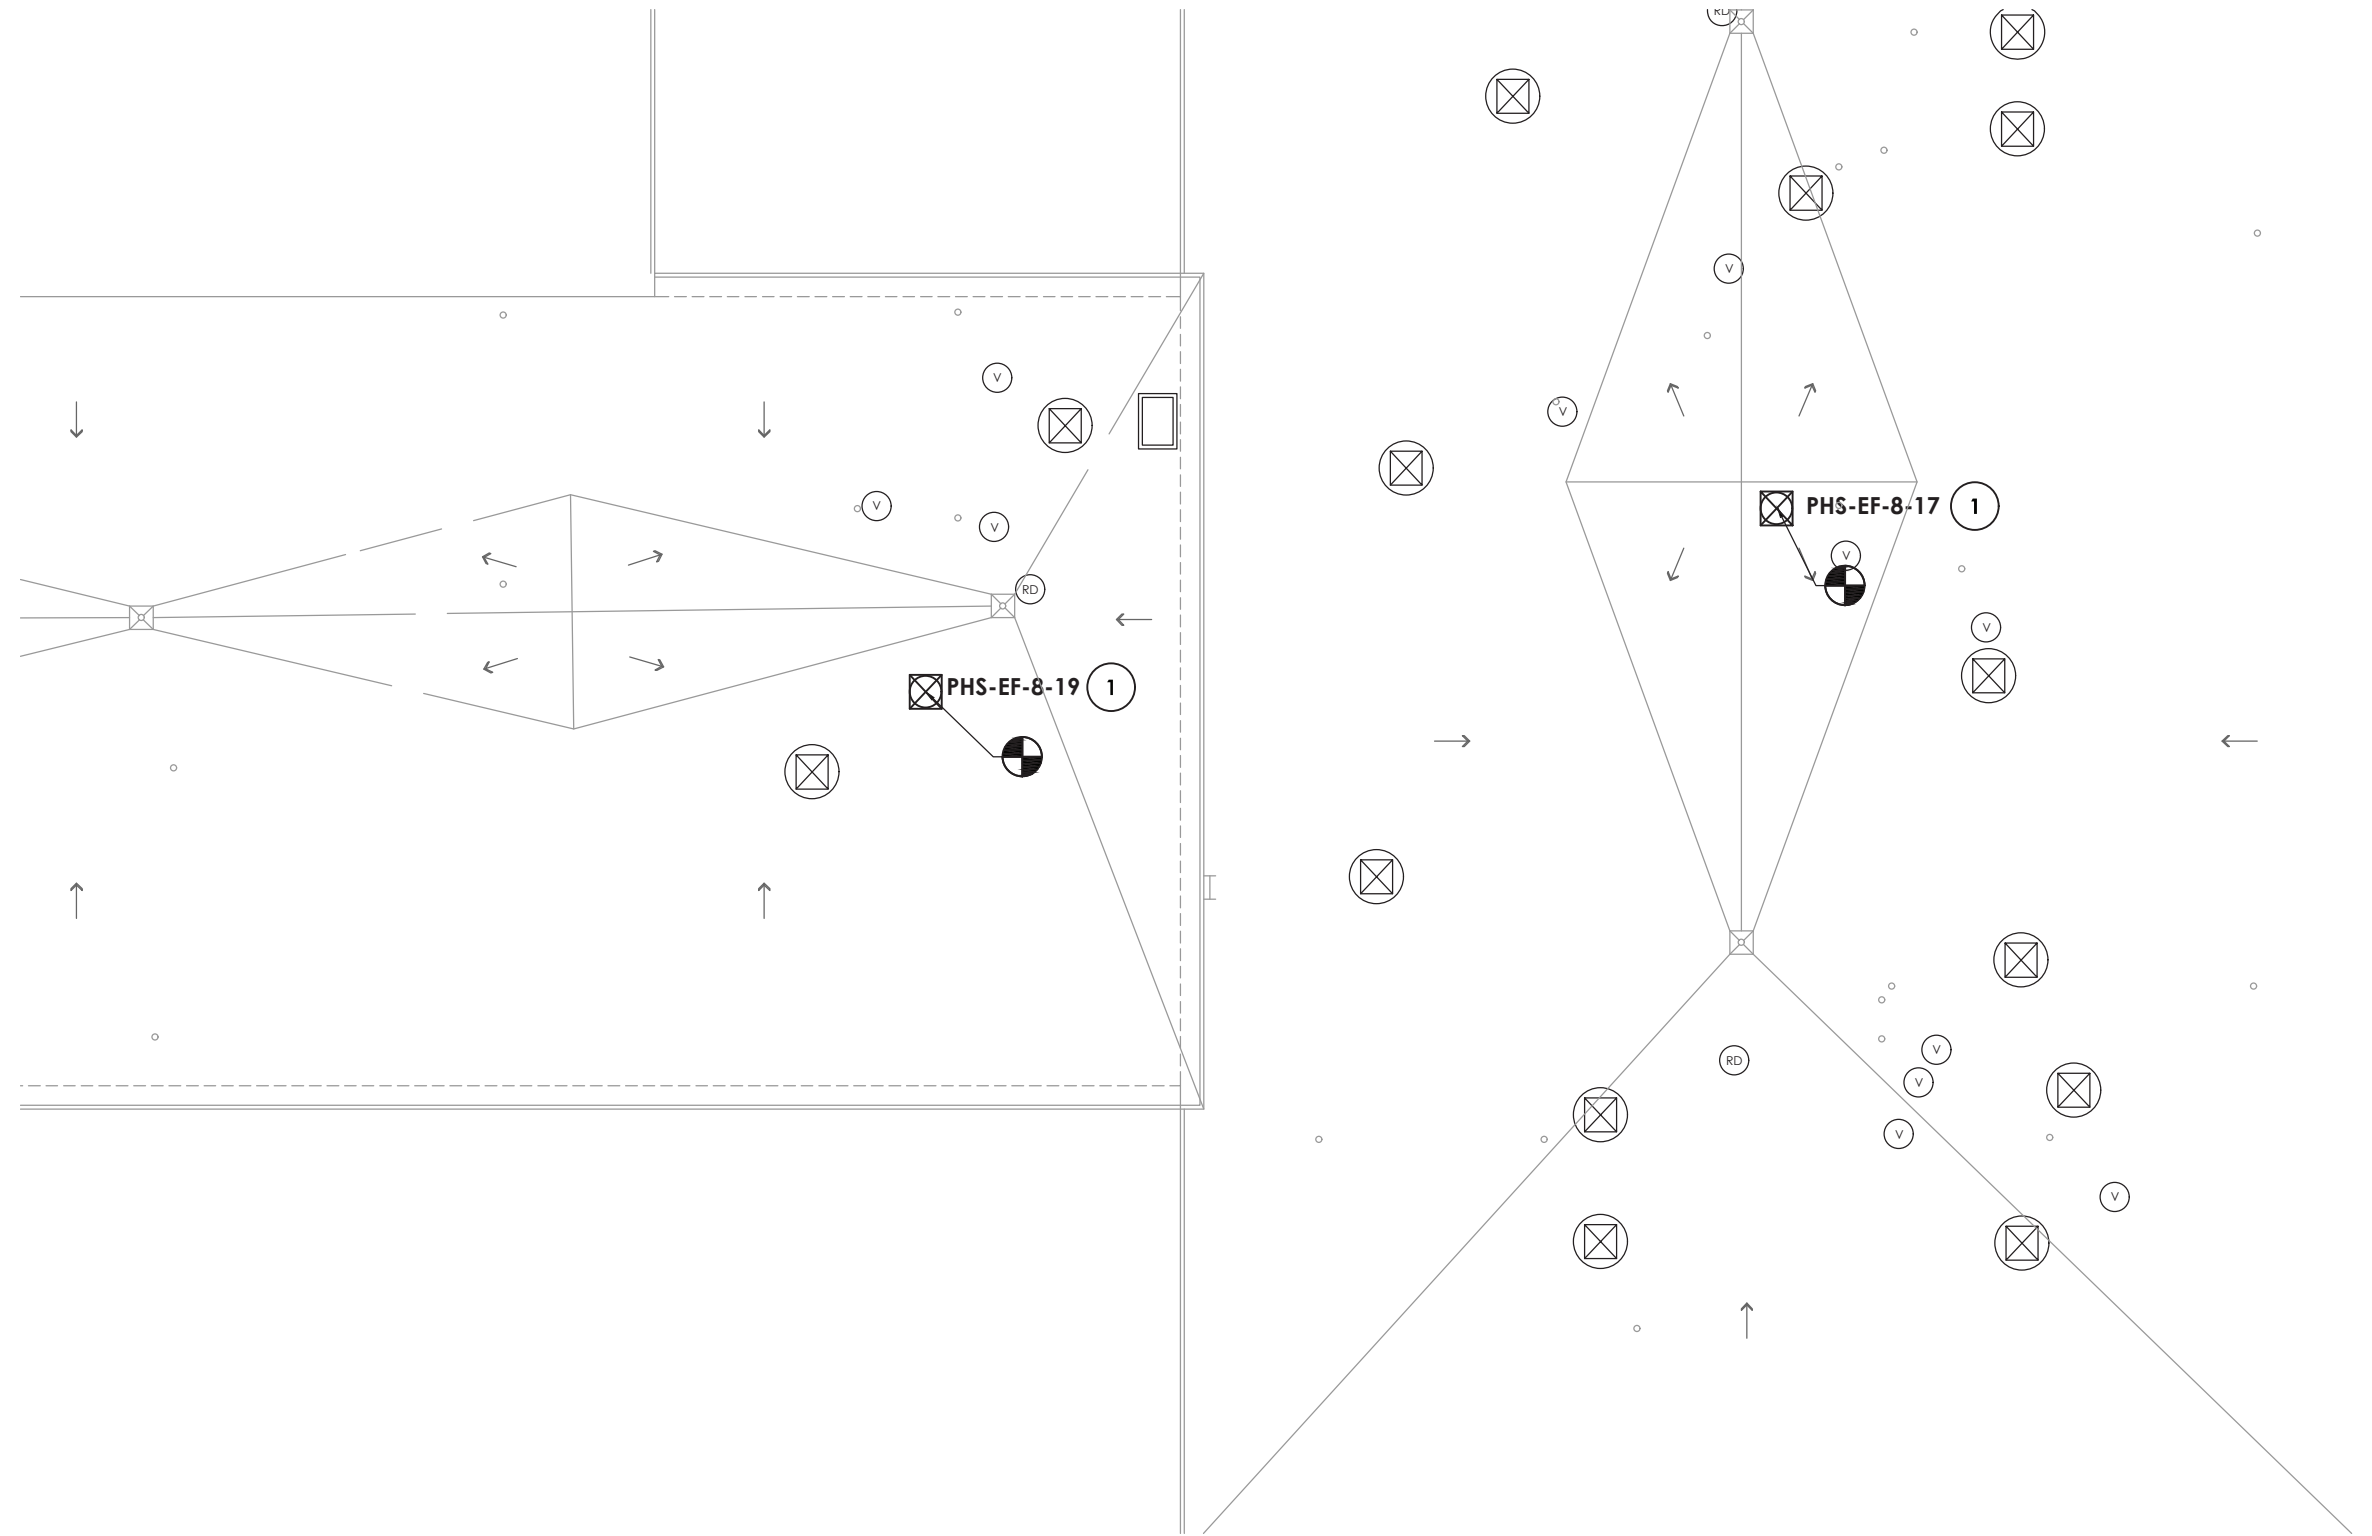


2
H203
SCALE: 1/16" = 1'-0"

ROOF HVAC NEW WORK PLAN

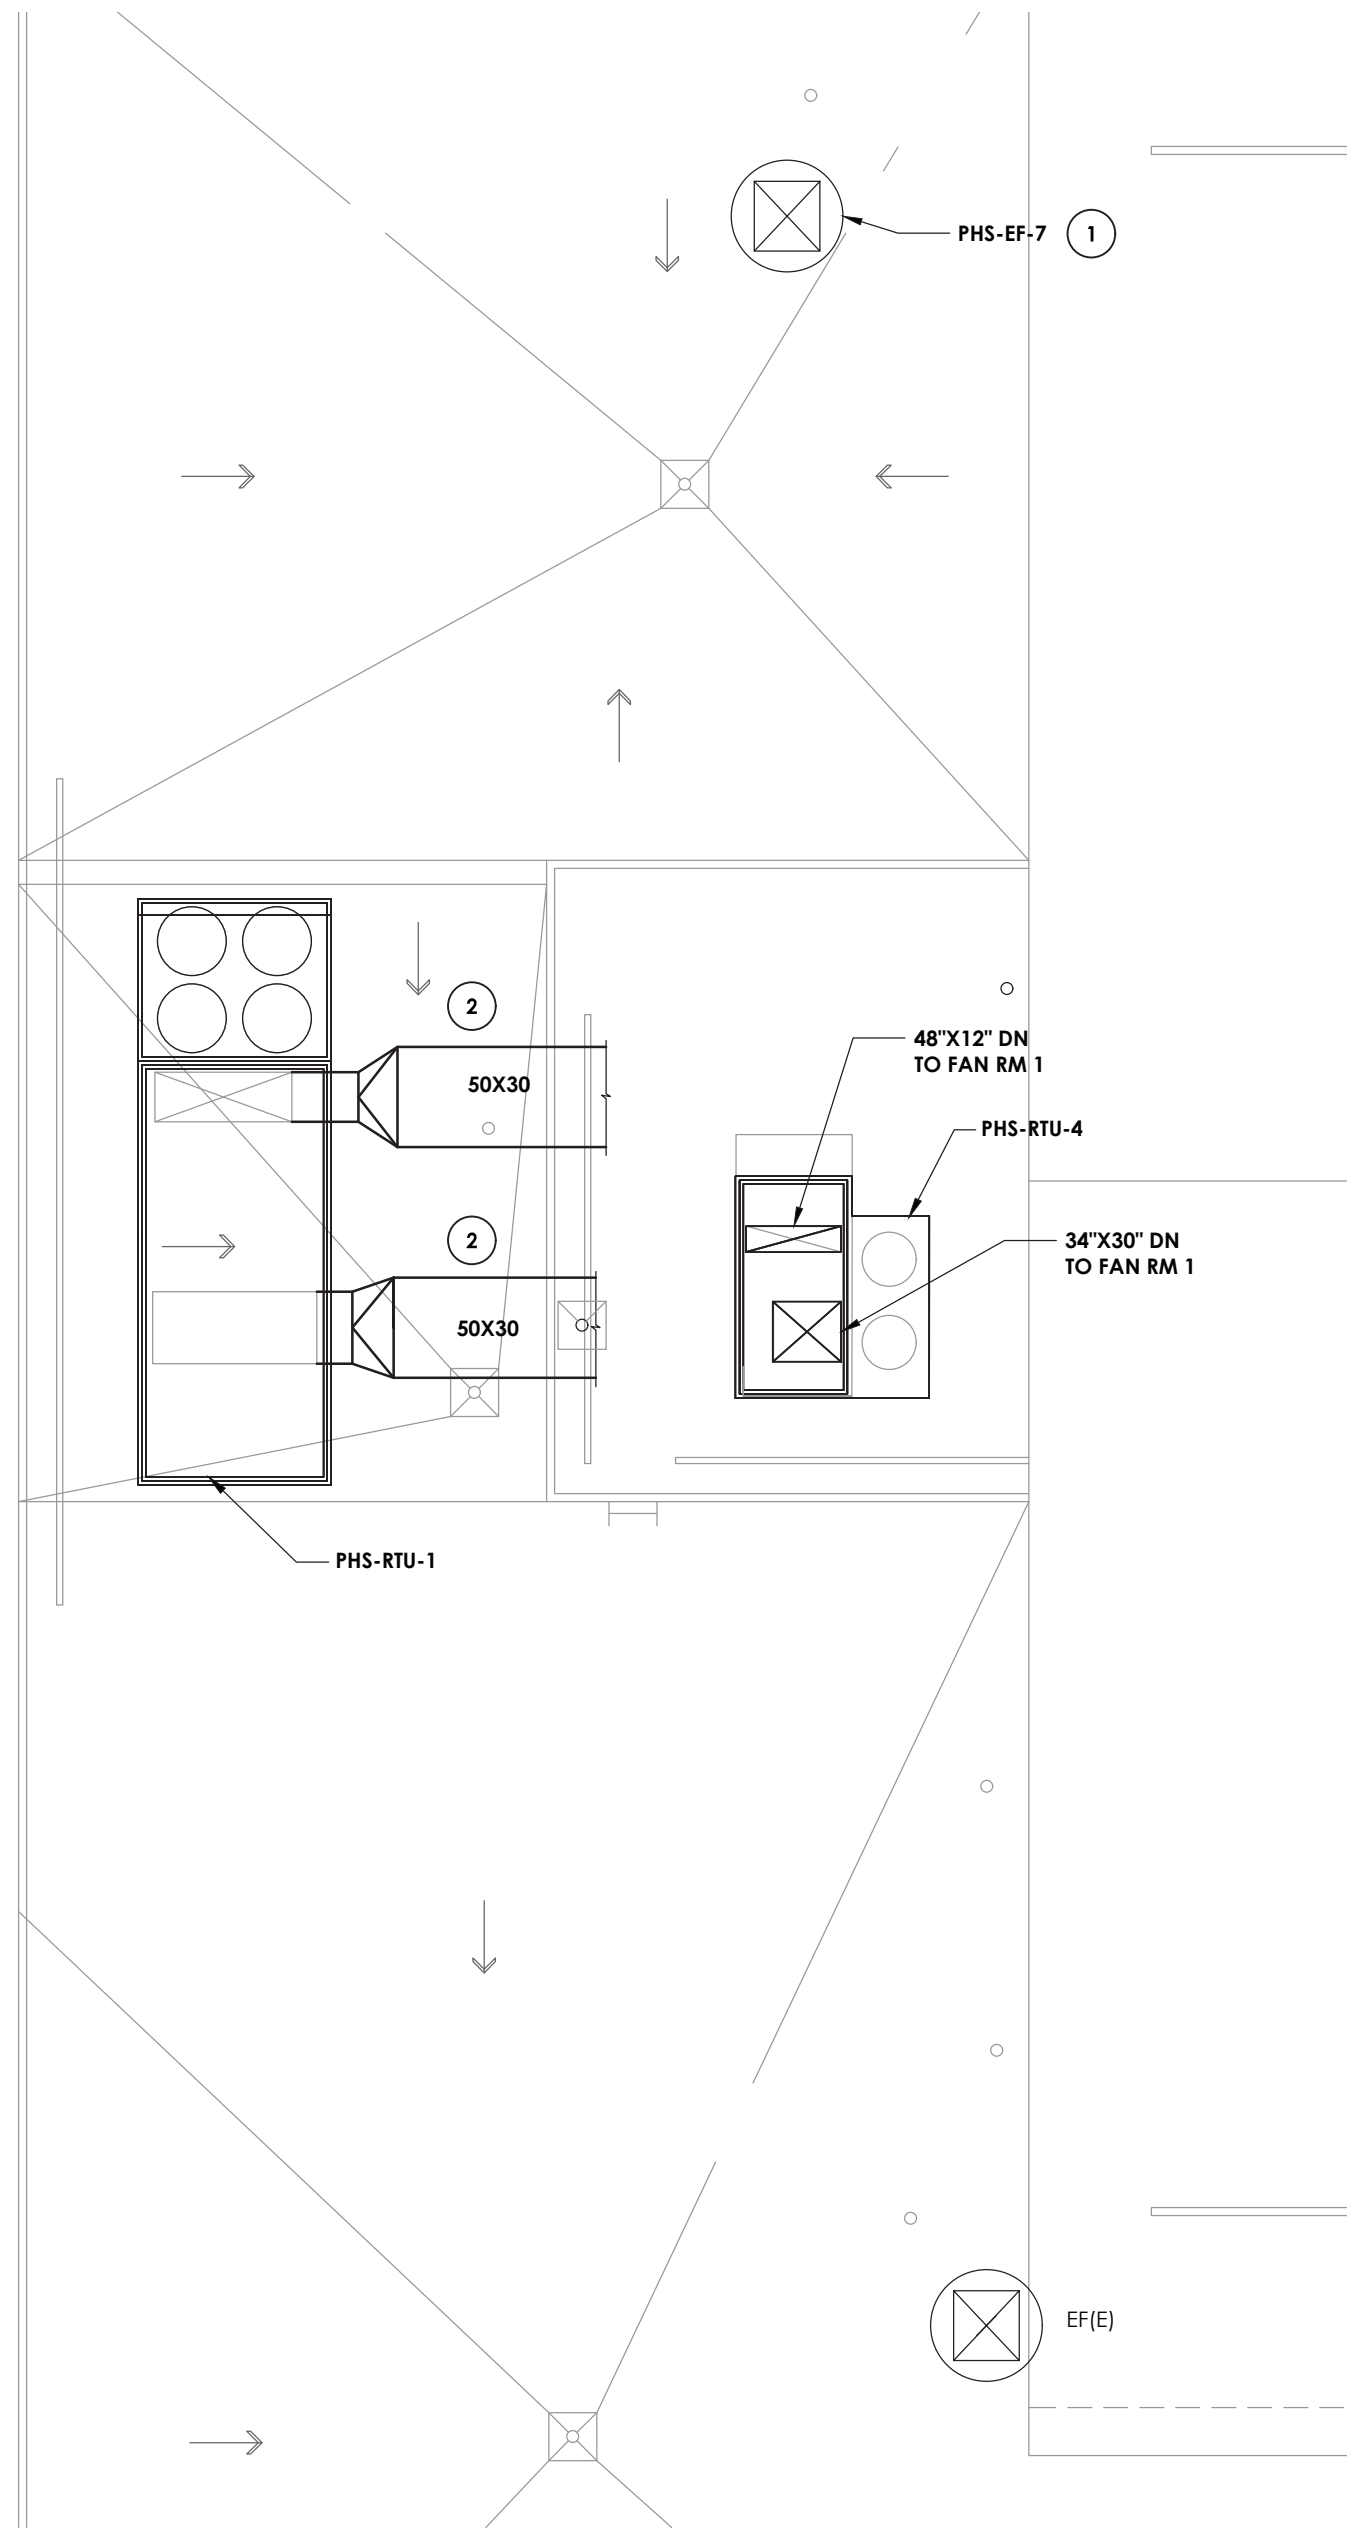


3
H203
SCALE: 1/8" = 1'-0"

ROOF HVAC NEW WORK PLAN

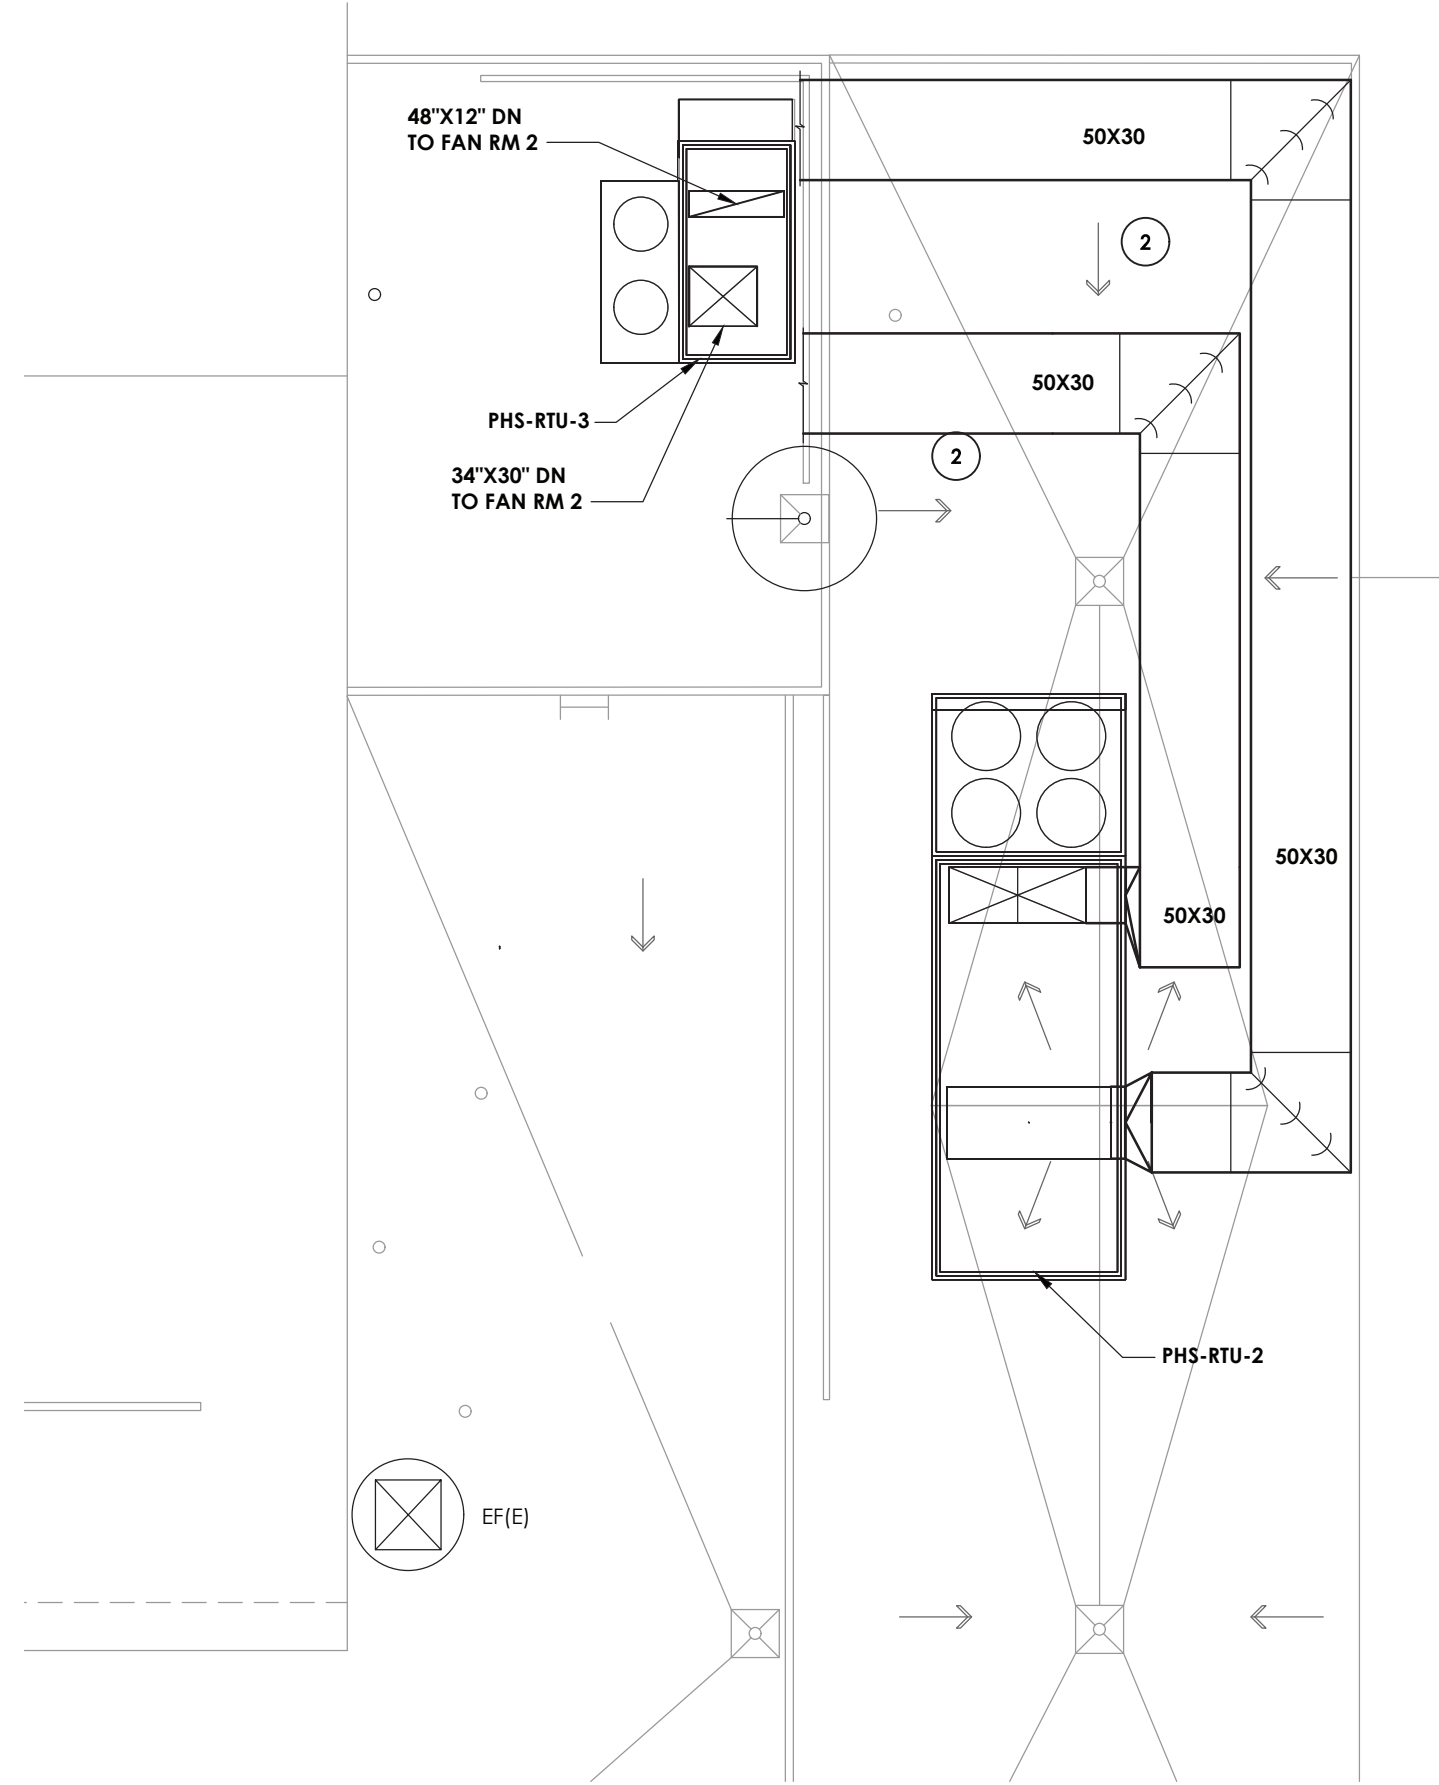


4
H203
SCALE: 1/8" = 1'-0"

ROOF HVAC NEW WORK PLAN

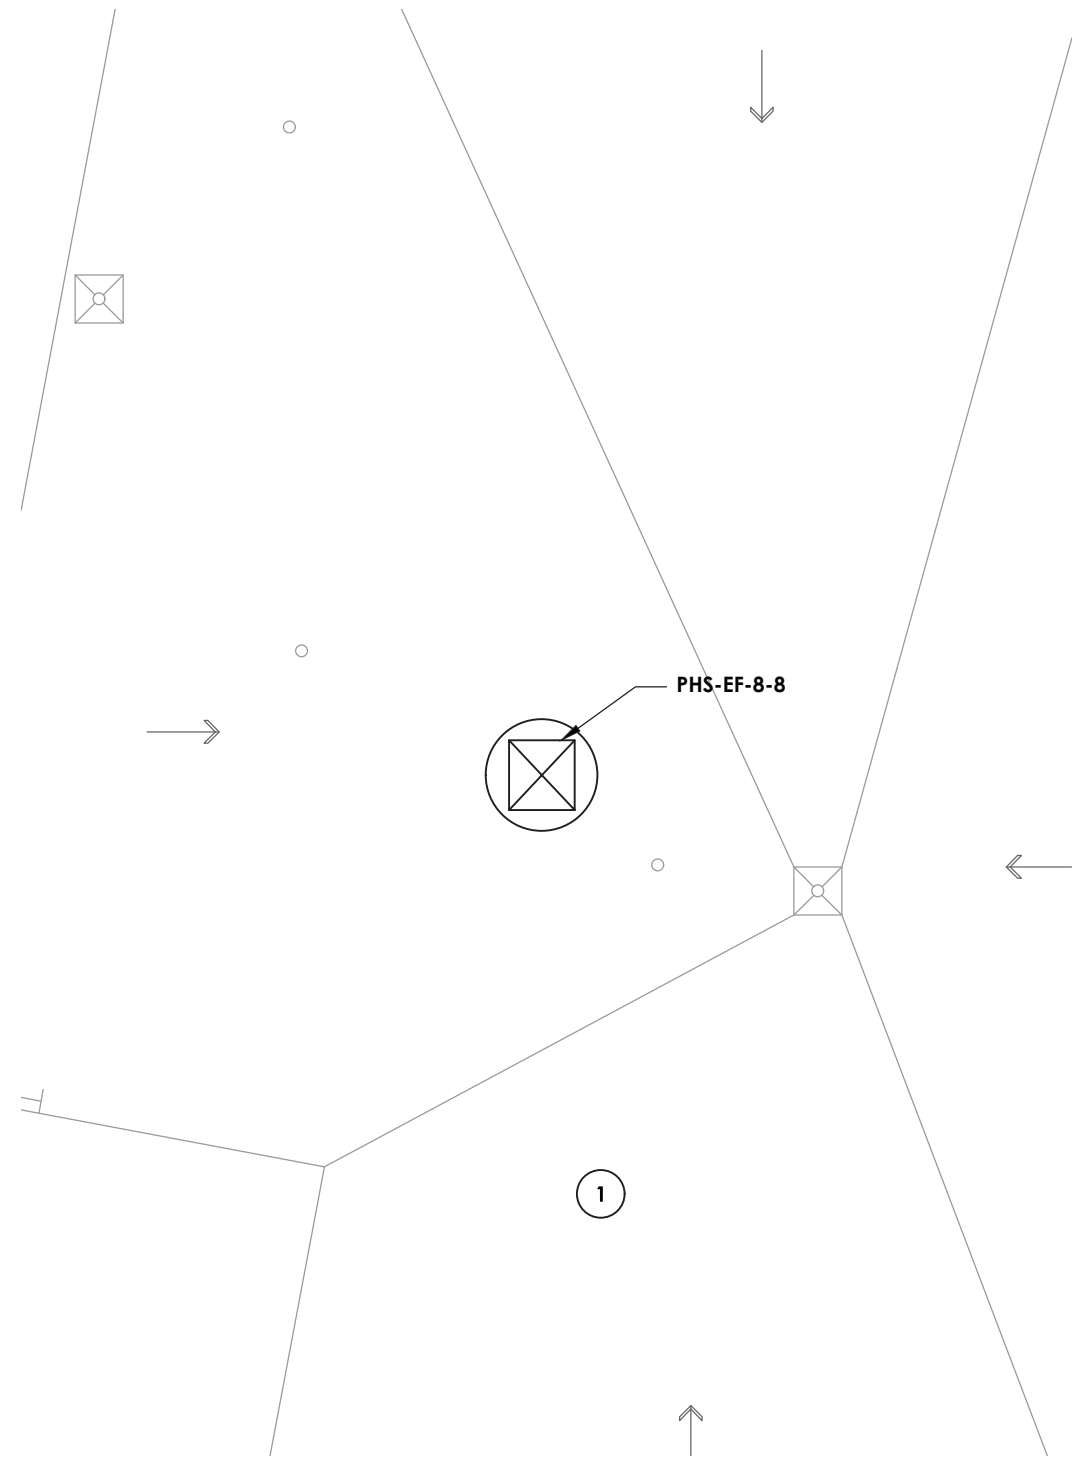

5
H203
SCALE: 1/8" = 1'-0"

ROOF HVAC NEW WORK PLAN

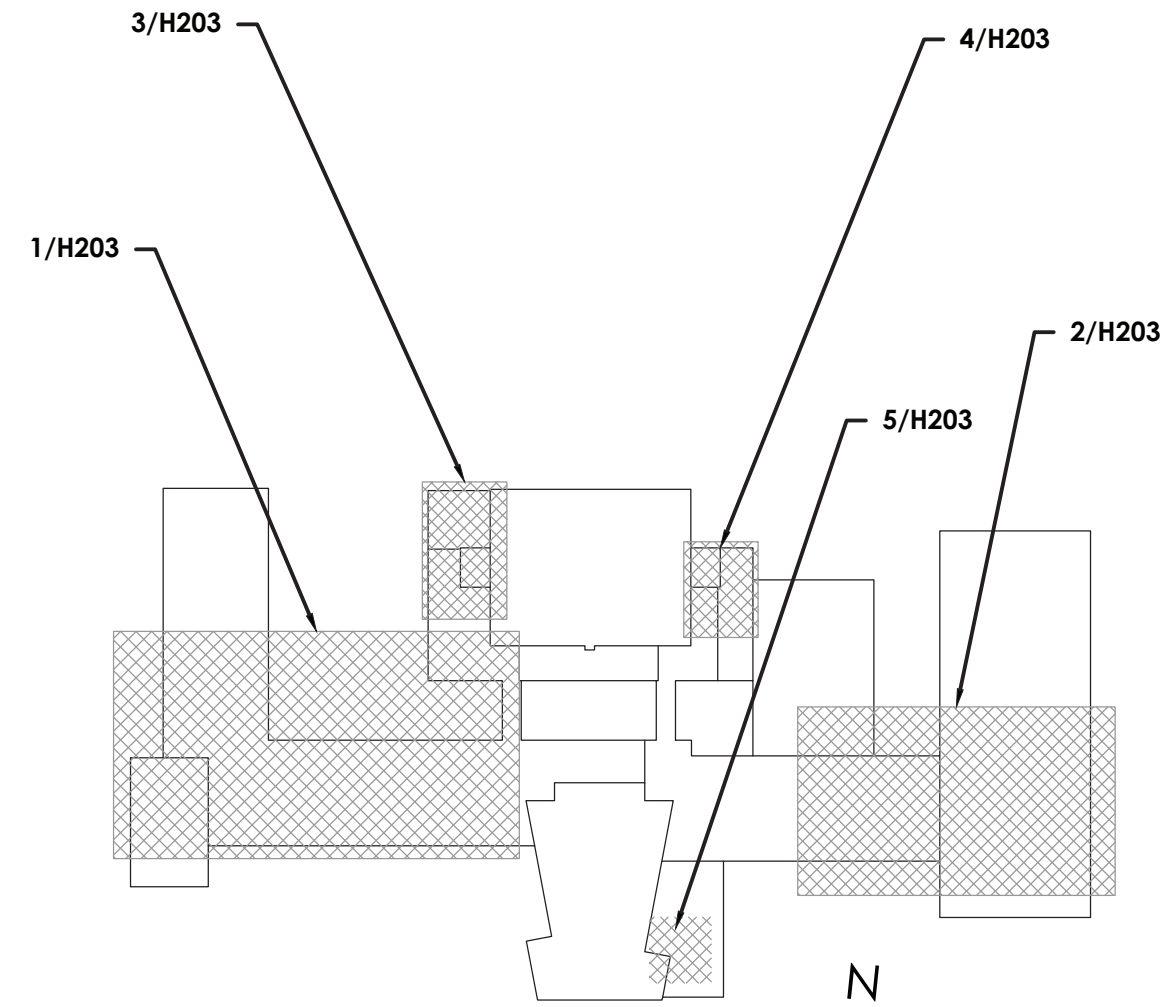

KEY PLAN
SCALE: NTS

KEY NOTES:

- 1 PROVIDE NEW EXHAUST FAN IN LOCATION OF REMOVED FAN. M.C. TO PROVIDE AND MARK OUT LOCATION OF NEW CURB. COORDINATE INSTALLATION OF CURB, CUTTING AND PATCHING WITH G.C.
- 2 PROVIDE EXTERNAL INSULATION. SEE DETAILS. RUN DUCT INTO EXISTING MECHANICAL ROOM, PROVIDE NEW LINTELS AND INFILL WITH LIKE CONSTRUCTION.



CPLteam.com
ARCHITECTURE • ENGINEERING • PLANNING

50 FRONT STREET, SUITE 202
NEWBURGH, NEW YORK 12550
TEL (800) 274-9000

REVISIONS		NO.	DATE	BY	DESCRIPTION



POUGHKEEPSIE CITY SCHOOL DISTRICT
2020 CAPITAL IMPROVEMENT PROJECT
PHASE 1B: BUILDING IMPROVEMENTS

- POUGHKEEPSIE HIGH SCHOOL: SED# 13-15-00-01-0-007-018
- POUGHKEEPSIE MIDDLE SCHOOL: SED# 13-15-00-01-0-008-021
- POUGHKEEPSIE ELEMENTARY SCHOOL: SED# 13-15-00-01-0-009-014
- KREGER ELEMENTARY SCHOOL: SED# 13-15-00-01-0-006-014
- WARRING ELEMENTARY SCHOOL: SED# 13-15-00-01-0-002-014
- WARRING ELEMENTARY SCHOOL: SED# 13-15-00-01-0-005-013
- WARRING ELEMENTARY SCHOOL: SED# 13-15-00-01-0-004-014
- COLUMBUS ELEMENTARY SCHOOL: SED# 13-15-00-01-0-001-014

DATE	DRAWN	CHECKED
10/20/2021	BKM	AJS
SCALE: AS NOTED		
SHEET TITLE		
HIGH SCHOOL HVAC ROOF NEW WORK PLAN		

PROJECT NUMBER
14078.09

PHS
H203
DRAWING NUMBER