


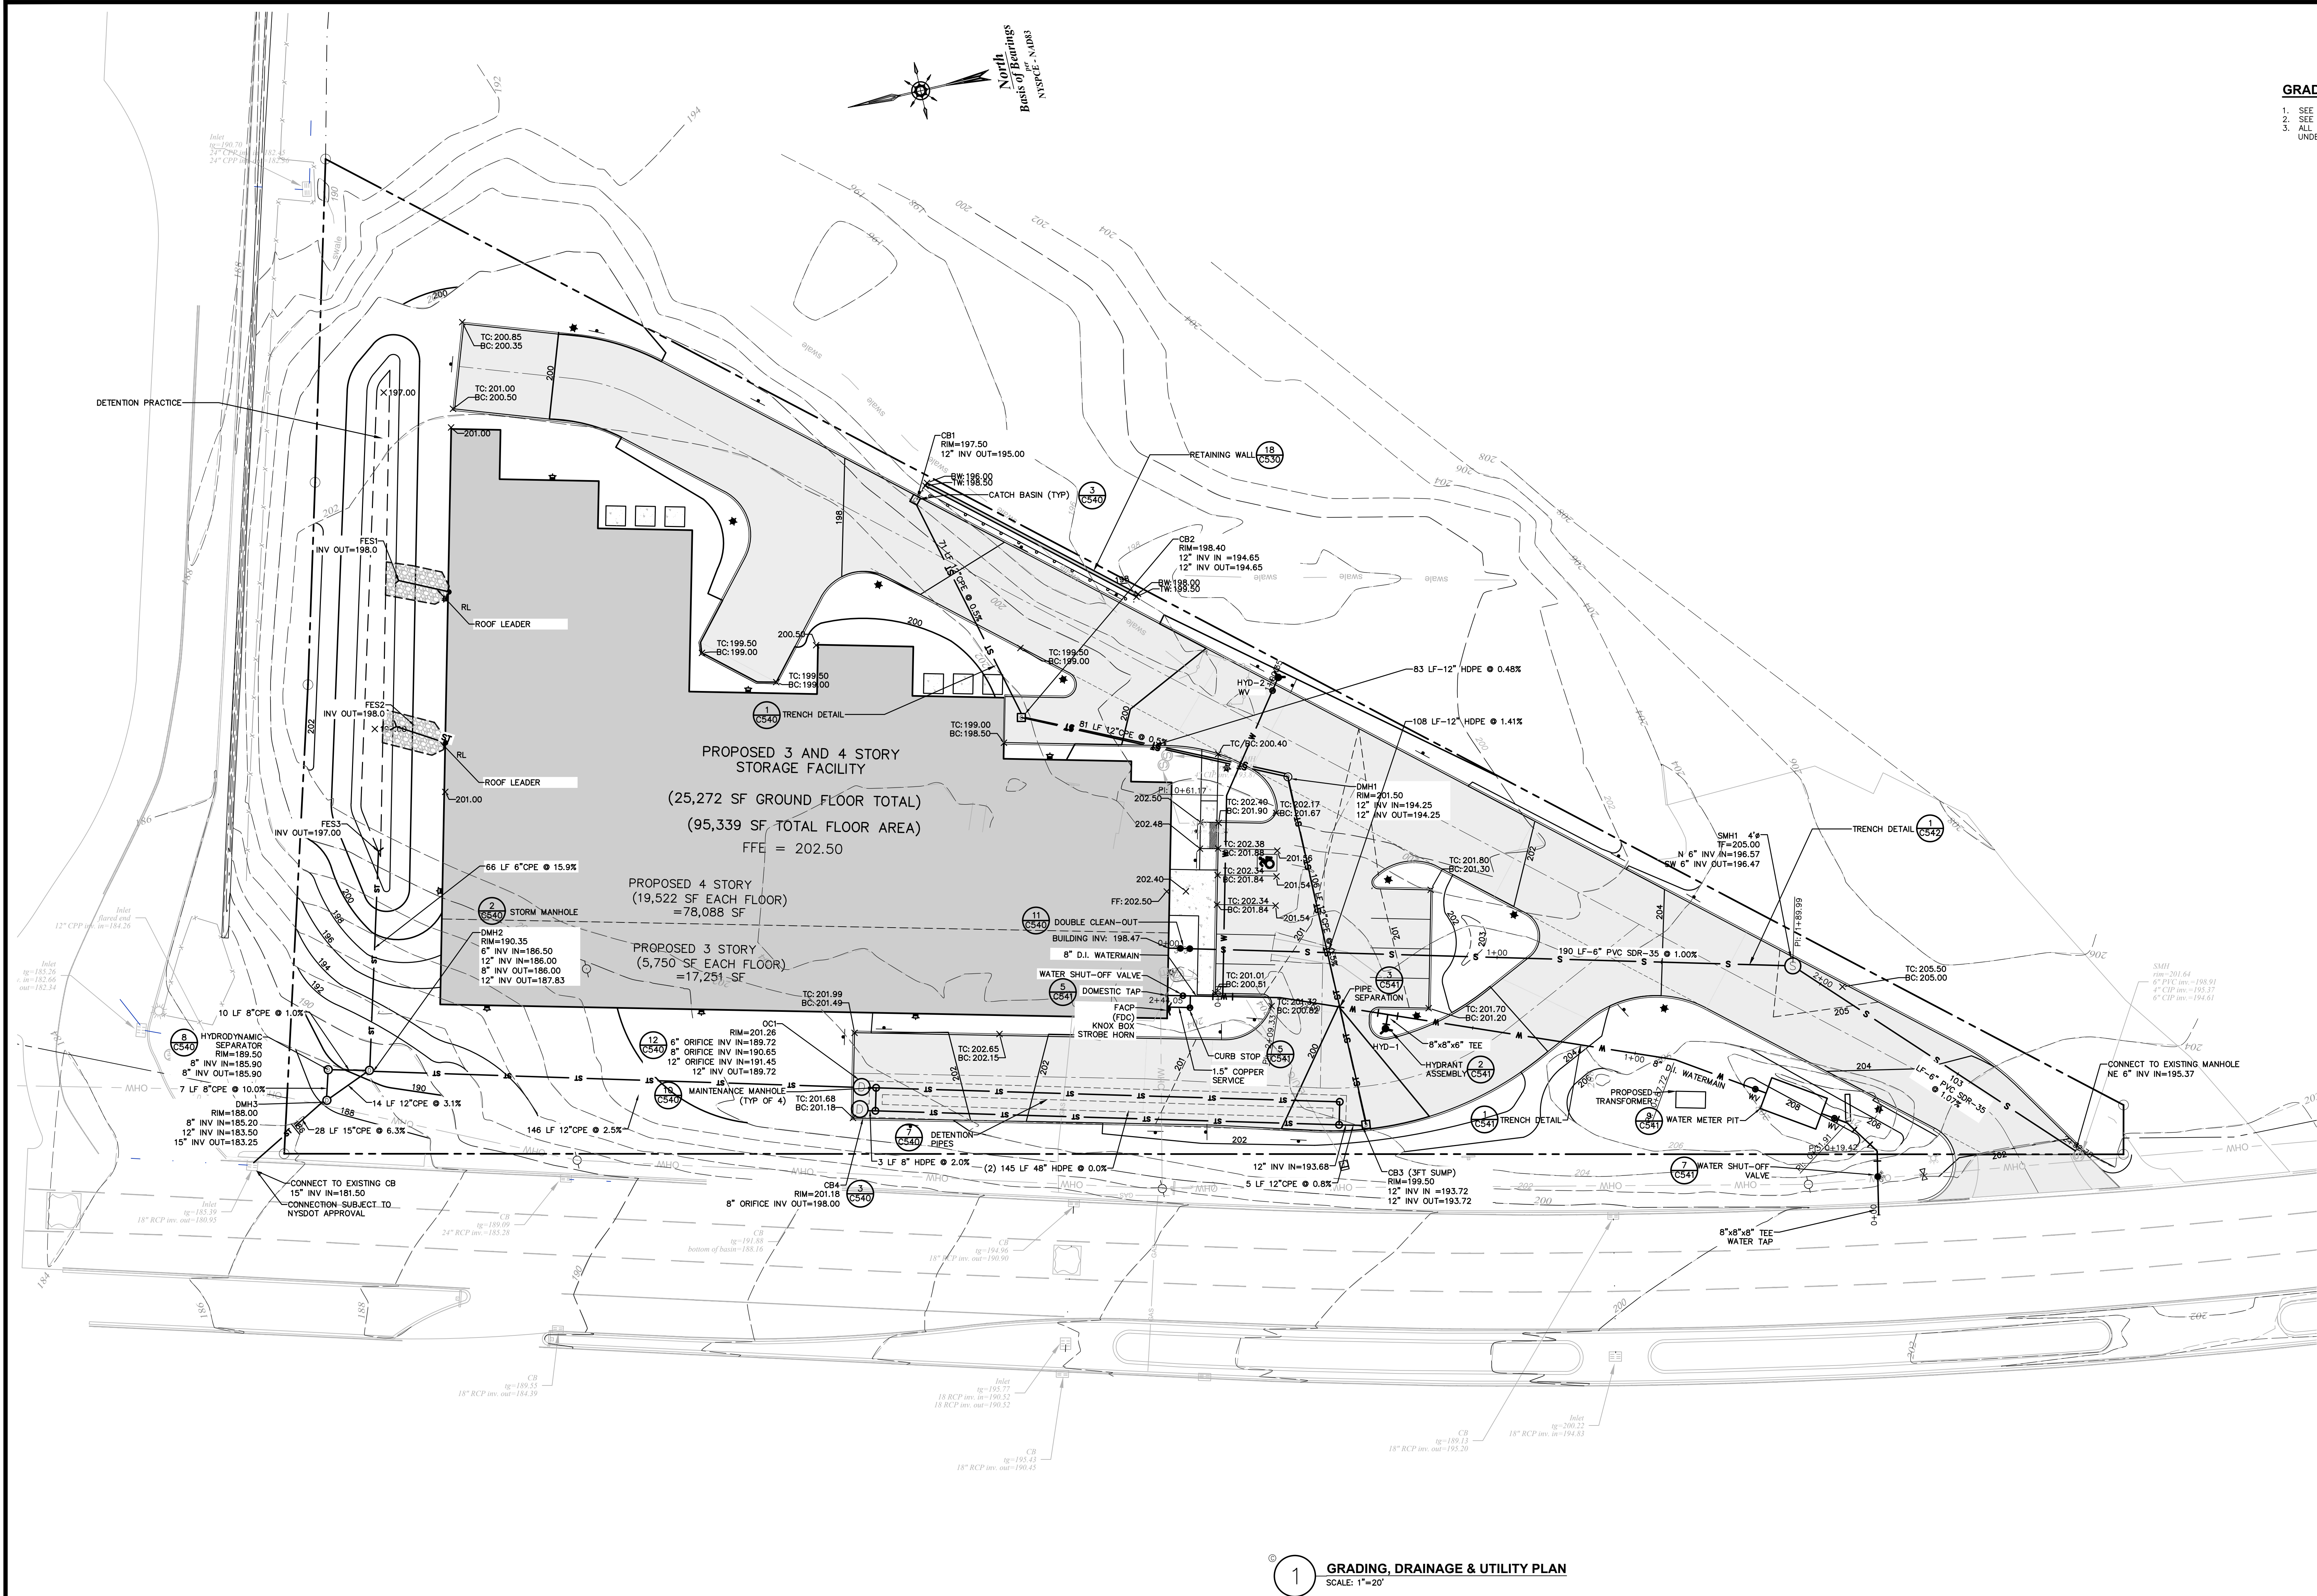

- GRADING & DRAINAGE & UTILITY NOTES:**
- SEE SHEET C002 FOR UTILITY, GRADING, & UTILITY NOTES.
 - SEE SHEETS C040, C041, AND C042 FOR DETAILS.
 - ALL UTILITIES INCLUDING ELECTRIC, COMMUNICATIONS, AND CABLE SHALL BE INSTALLED UNDERGROUND.

1 GRADING, DRAINAGE & UTILITY PLAN
SCALE: 1"=20'

ISSUED FOR SITE PLAN APPROVAL

0 1 2 3
ORIGINAL SCALE IN INCHES

Drawing Name: Z:\Projects\B0100-B0199\B0133-00 Diamond Point Development - 0910\DWG\01_C140_B0133-00_GRAD-DRAIN-UTILITY.dwg
Xref's Attached: VTB_B0133-00_150x45; Support_B0133-00_150x45; ENG_B0133-00_150x45; B0133-00
Date Printed: Jul 05, 2022, 10:55am

ALL RIGHTS RESERVED. COPY OR REPRODUCTION OF THIS DRAWING OR DOCUMENT, OR ANY PORTION THEREOF, WITHOUT THE EXPRESS WRITTEN PERMISSION OF CHAZEN ENGINEERING, LAND SURVEYING, LANDSCAPE ARCHITECTURE & GEOLOGY CO., D.P.C. IS PROHIBITED. THIS DRAWING OR DOCUMENT IS NOT INTENDED OR REPRESENTED TO BE SUITABLE FOR ANY PURPOSE OTHER THAN THE SPECIFIC PROJECT, APPLICATION AND SITUATION FOR WHICH IT WAS INTENDED. ANY MODIFICATION OF THIS DRAWING OR DOCUMENT, OR ANY USE FOR ANY PROJECT, APPLICATION OR SITUATION OTHER THAN THAT FOR WHICH IT WAS INTENDED, WILL BE AT USER'S SOLE RISK AND WITHOUT LIABILITY TO CHAZEN ENGINEERING, LAND SURVEYING, LANDSCAPE ARCHITECTURE & GEOLOGY CO., D.P.C.

IT IS A VIOLATION OF NEW YORK STATE EDUCATION LAW FOR ANY PERSON TO ALTER THIS DRAWING OR DOCUMENT IN ANY WAY, UNLESS HE OR SHE IS ACTING UNDER THE DIRECTION OF A LICENSED DESIGN PROFESSIONAL (PROFESSIONAL ENGINEER, LAND SURVEYOR, ARCHITECT, LANDSCAPE ARCHITECT OR GEOLOGIST). IF THIS DRAWING OR DOCUMENT IS ALTERED, THE ALTERING DESIGN PROFESSIONAL SHALL AFFIX TO THE DRAWING OR DOCUMENT HIS OR HER SEAL, THE NOTATION ALTERED BY HIS OR HER SIGNATURE, THE DATE OF SUCH ALTERATION, AND A SPECIFIC DESCRIPTION OF THE ALTERATION.

CHAZEN ENGINEERING, LAND SURVEYING,
LANDSCAPE ARCHITECTURE & GEOLOGY CO., D.P.C.

Office Locations
• Glen Falls, NY
• Troy, NY
• Poughkeepsie, NY
• White Plains, NY
• New York City, NY

www.chazencompanies.com
(888) 539-9073

rev.	date	description
2	05/23/22	REVISED PER TOWN COMMENTS
1	03/28/22	REVISED PER TOWN COMMENTS

1998 SOUTH ROAD - STORAGE FACILITY

GRADING, DRAINAGE, & UTILITY PLAN

TOWN OF POUGHKEEPSIE, DUTCHESS COUNTY, NEW YORK

designed	checked
SMD	CPL
date	scale
11/22/21	
project no.	82133.00
sheet no.	C140