

**888 resorts World Dr  
Monticello, NY 12701**

120 HUYSHOPE AVENUE  
SUITE 400  
HARTFORD, CT 06106  
860.247.9226

© 2021 JCJ Architecture

CONSULTANT: \_\_\_\_\_

**VANDERWEIL**

R.G. Vanderweil Engineers, LLP : 617.423.7423 TEL  
274 Summer Street : 617.423.7401 FAX  
Boston, MA 02210 : [vanderweil.com](http://vanderweil.com)


ISSUE	07/06/2022
JOB	30860.00
DRAWN	JDB
SCALE	1/8" = 1'-0"
REVISIONS	

### FIRST FLOOR POWER PLAN

E-10

POWER PLAN NOTES

- 1 FOR ELECTRICAL LEGEND AND GENERAL NOTES REFER TO DRAWING E-1  
2 FOR ELECTRICAL POWER ONE LINE & RISER DIAGRAMS, REFER TO DRAWINGS E-14 TO E-18.  
3 FOR EXACT MOUNTING HEIGHTS OF ALL DEVICES REFER TO ARCHITECTURAL PLANS AND  
ELEVATIONS. MOUNT DEVICES IN A COMMON VERTICAL PLANE, AND PROVIDE MULTI-GANG  
DEVICE PLATES WHEREVER POSSIBLE.  
4 CIRCUIT NUMBERS SHOWN ON DRAWINGS ARE FOR DESCRIPTIVE PURPOSES ONLY. EXACT  
CIRCUIT NUMBERS SHALL BE DETERMINED IN THE FIELD.  
5 ALL RECEPTACLES WITHIN CAFETERIA AND FOOD SERVICE AREAS SHALL BE GFI TYPE  
WITH WEATHERPROOF STAINLESS STEEL COVER.

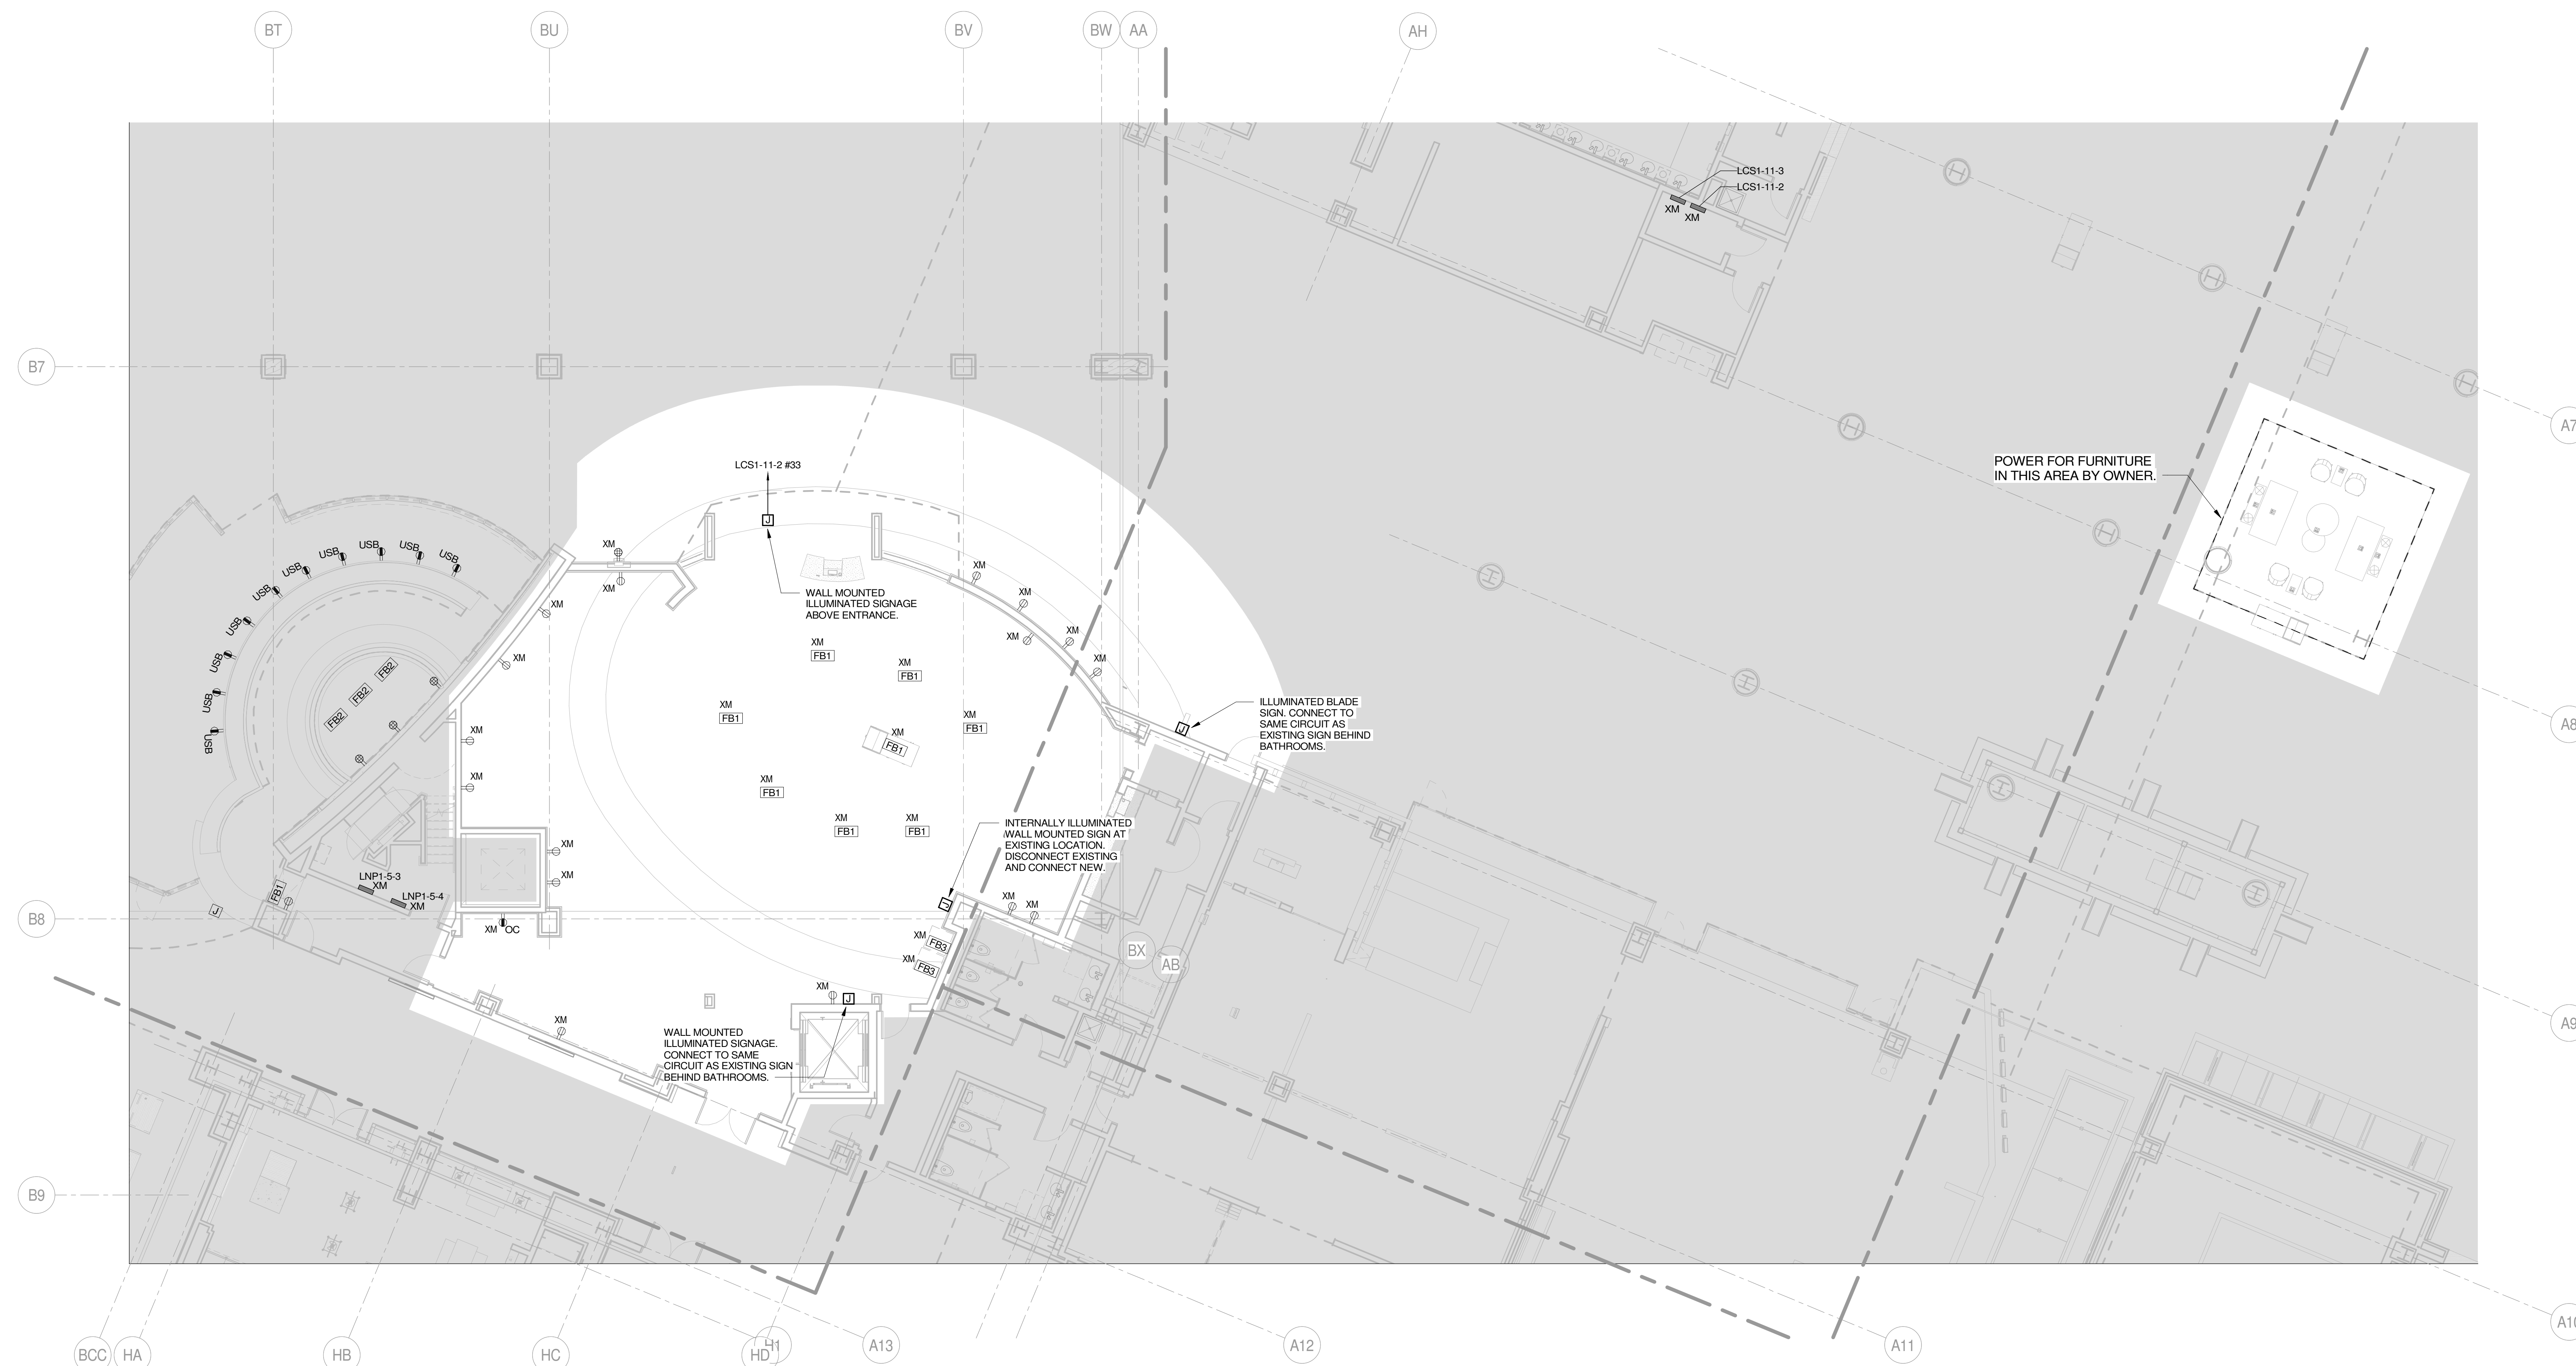

① FIRST FLOOR POWER PLAN  
1/8" = 1'-0"