
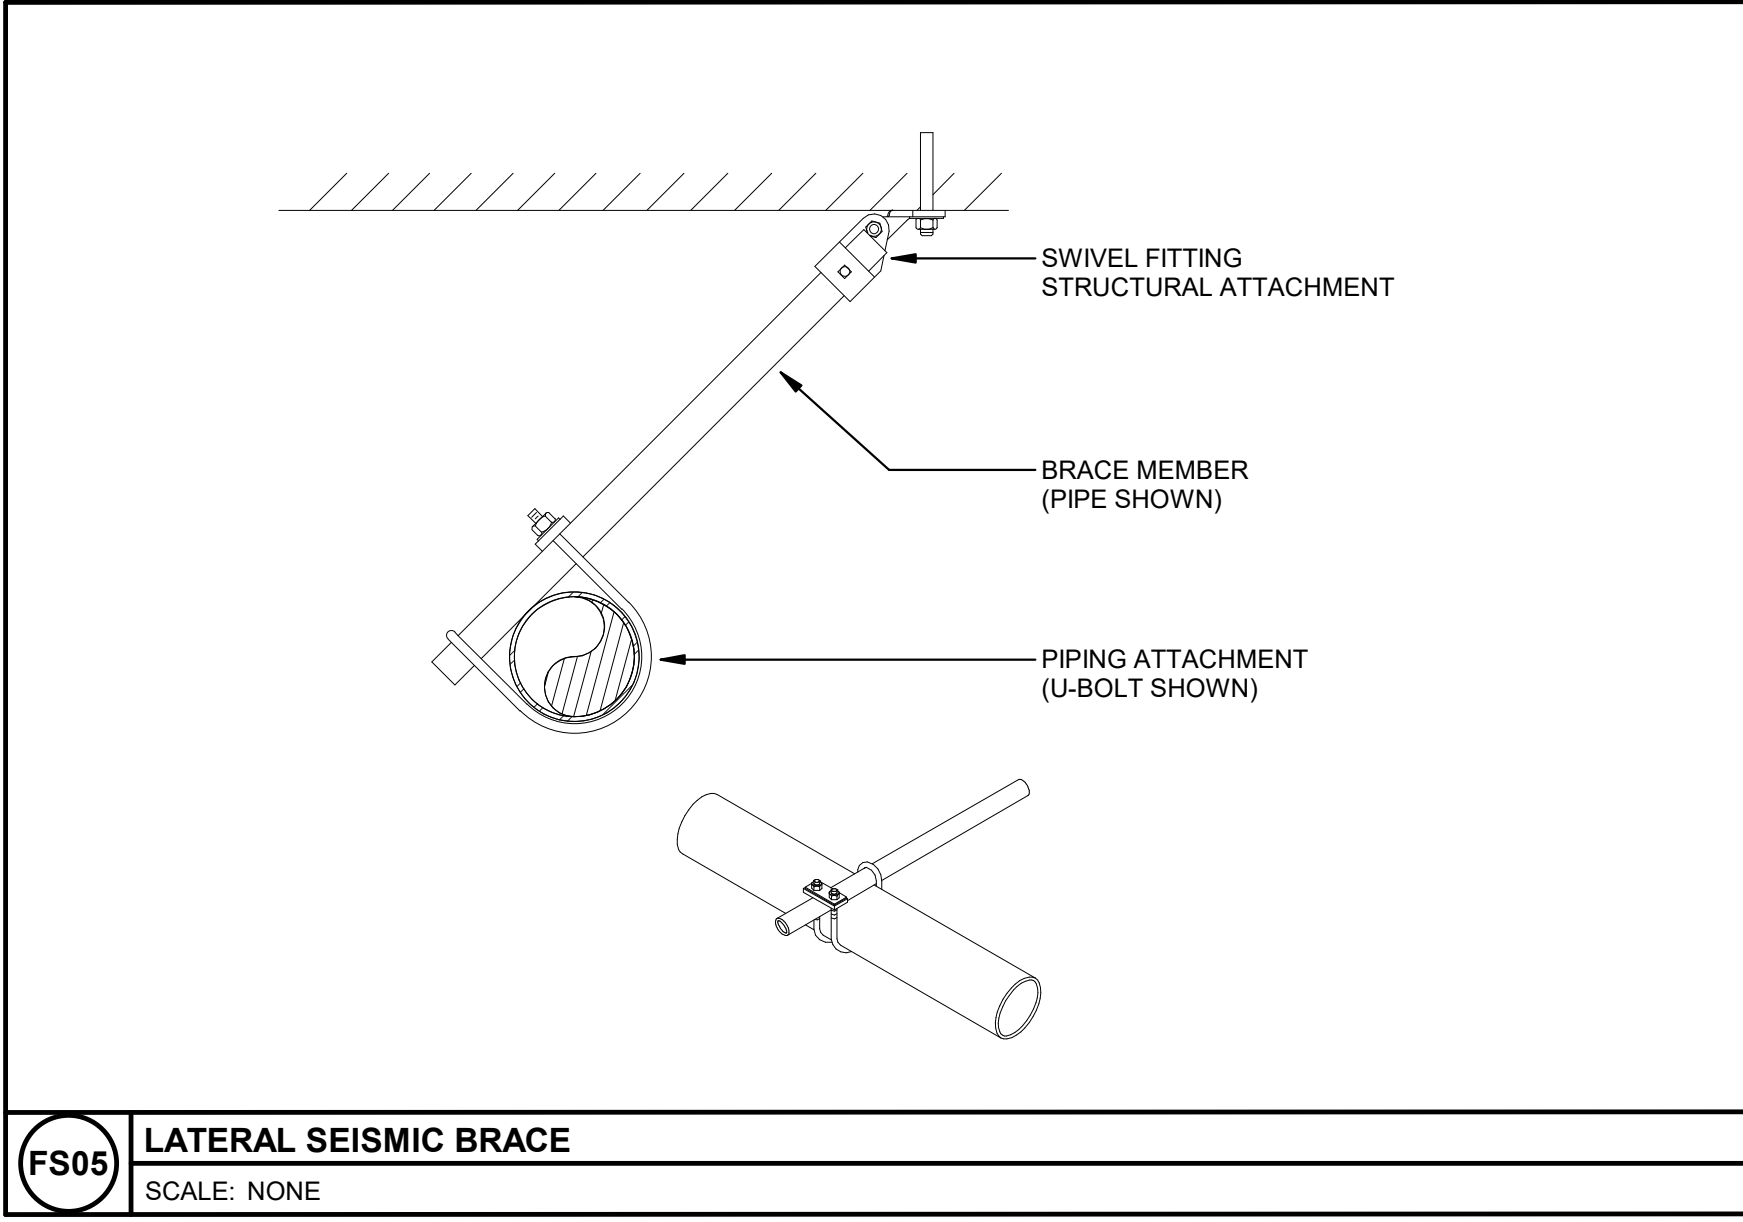
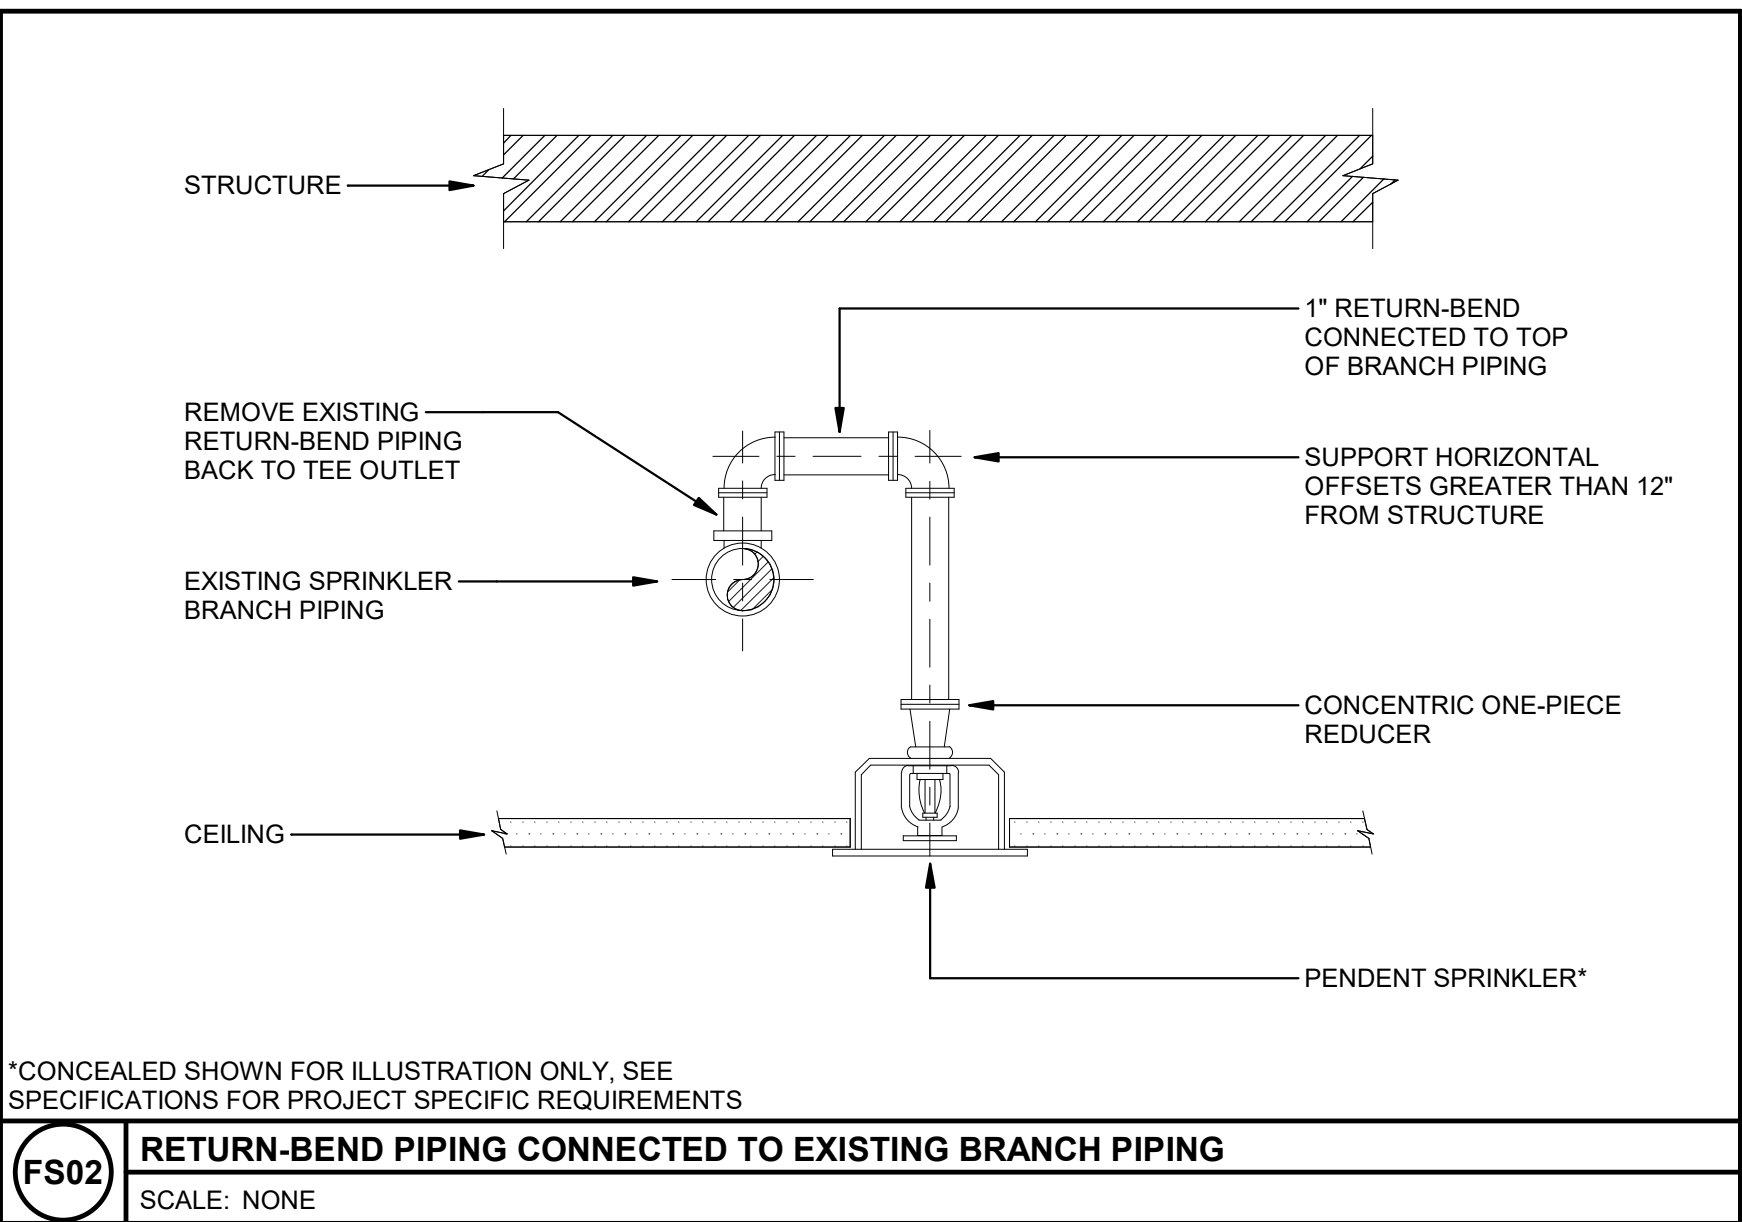
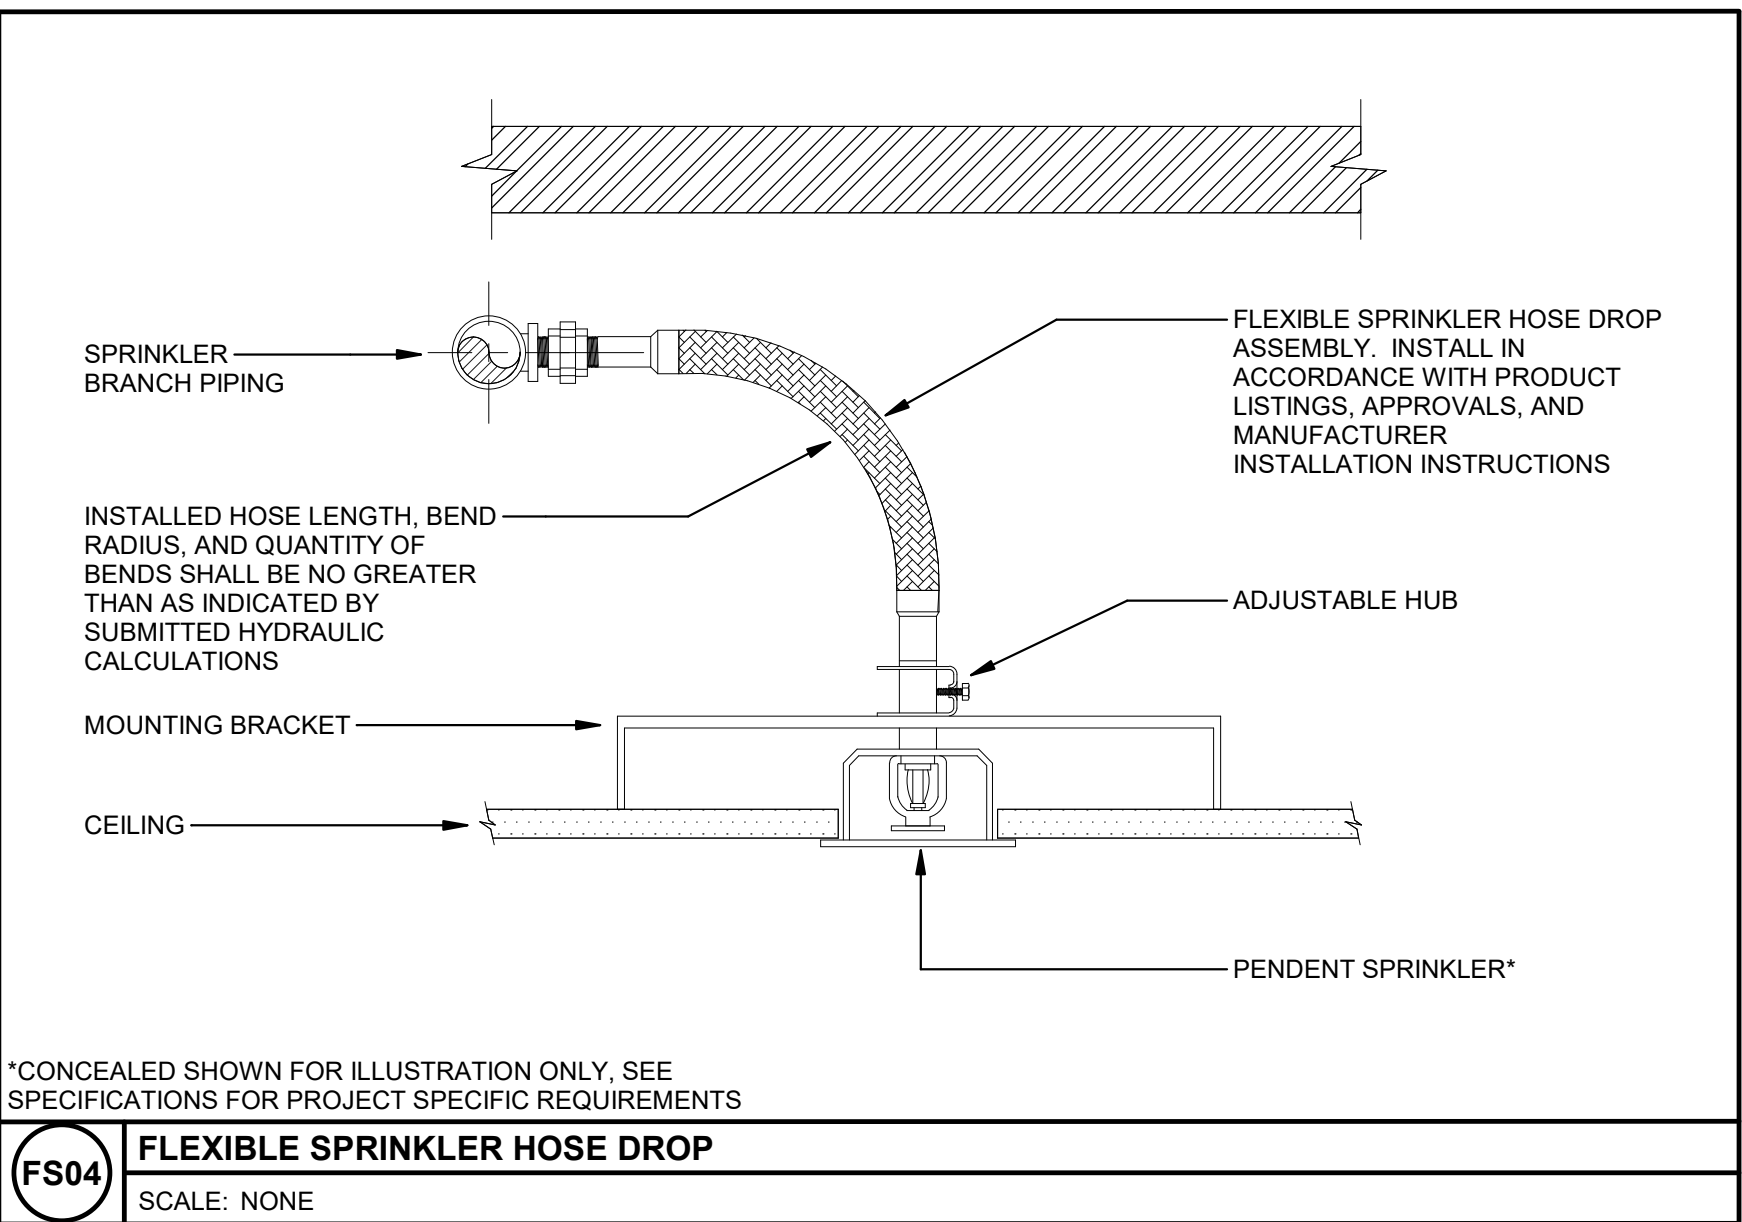
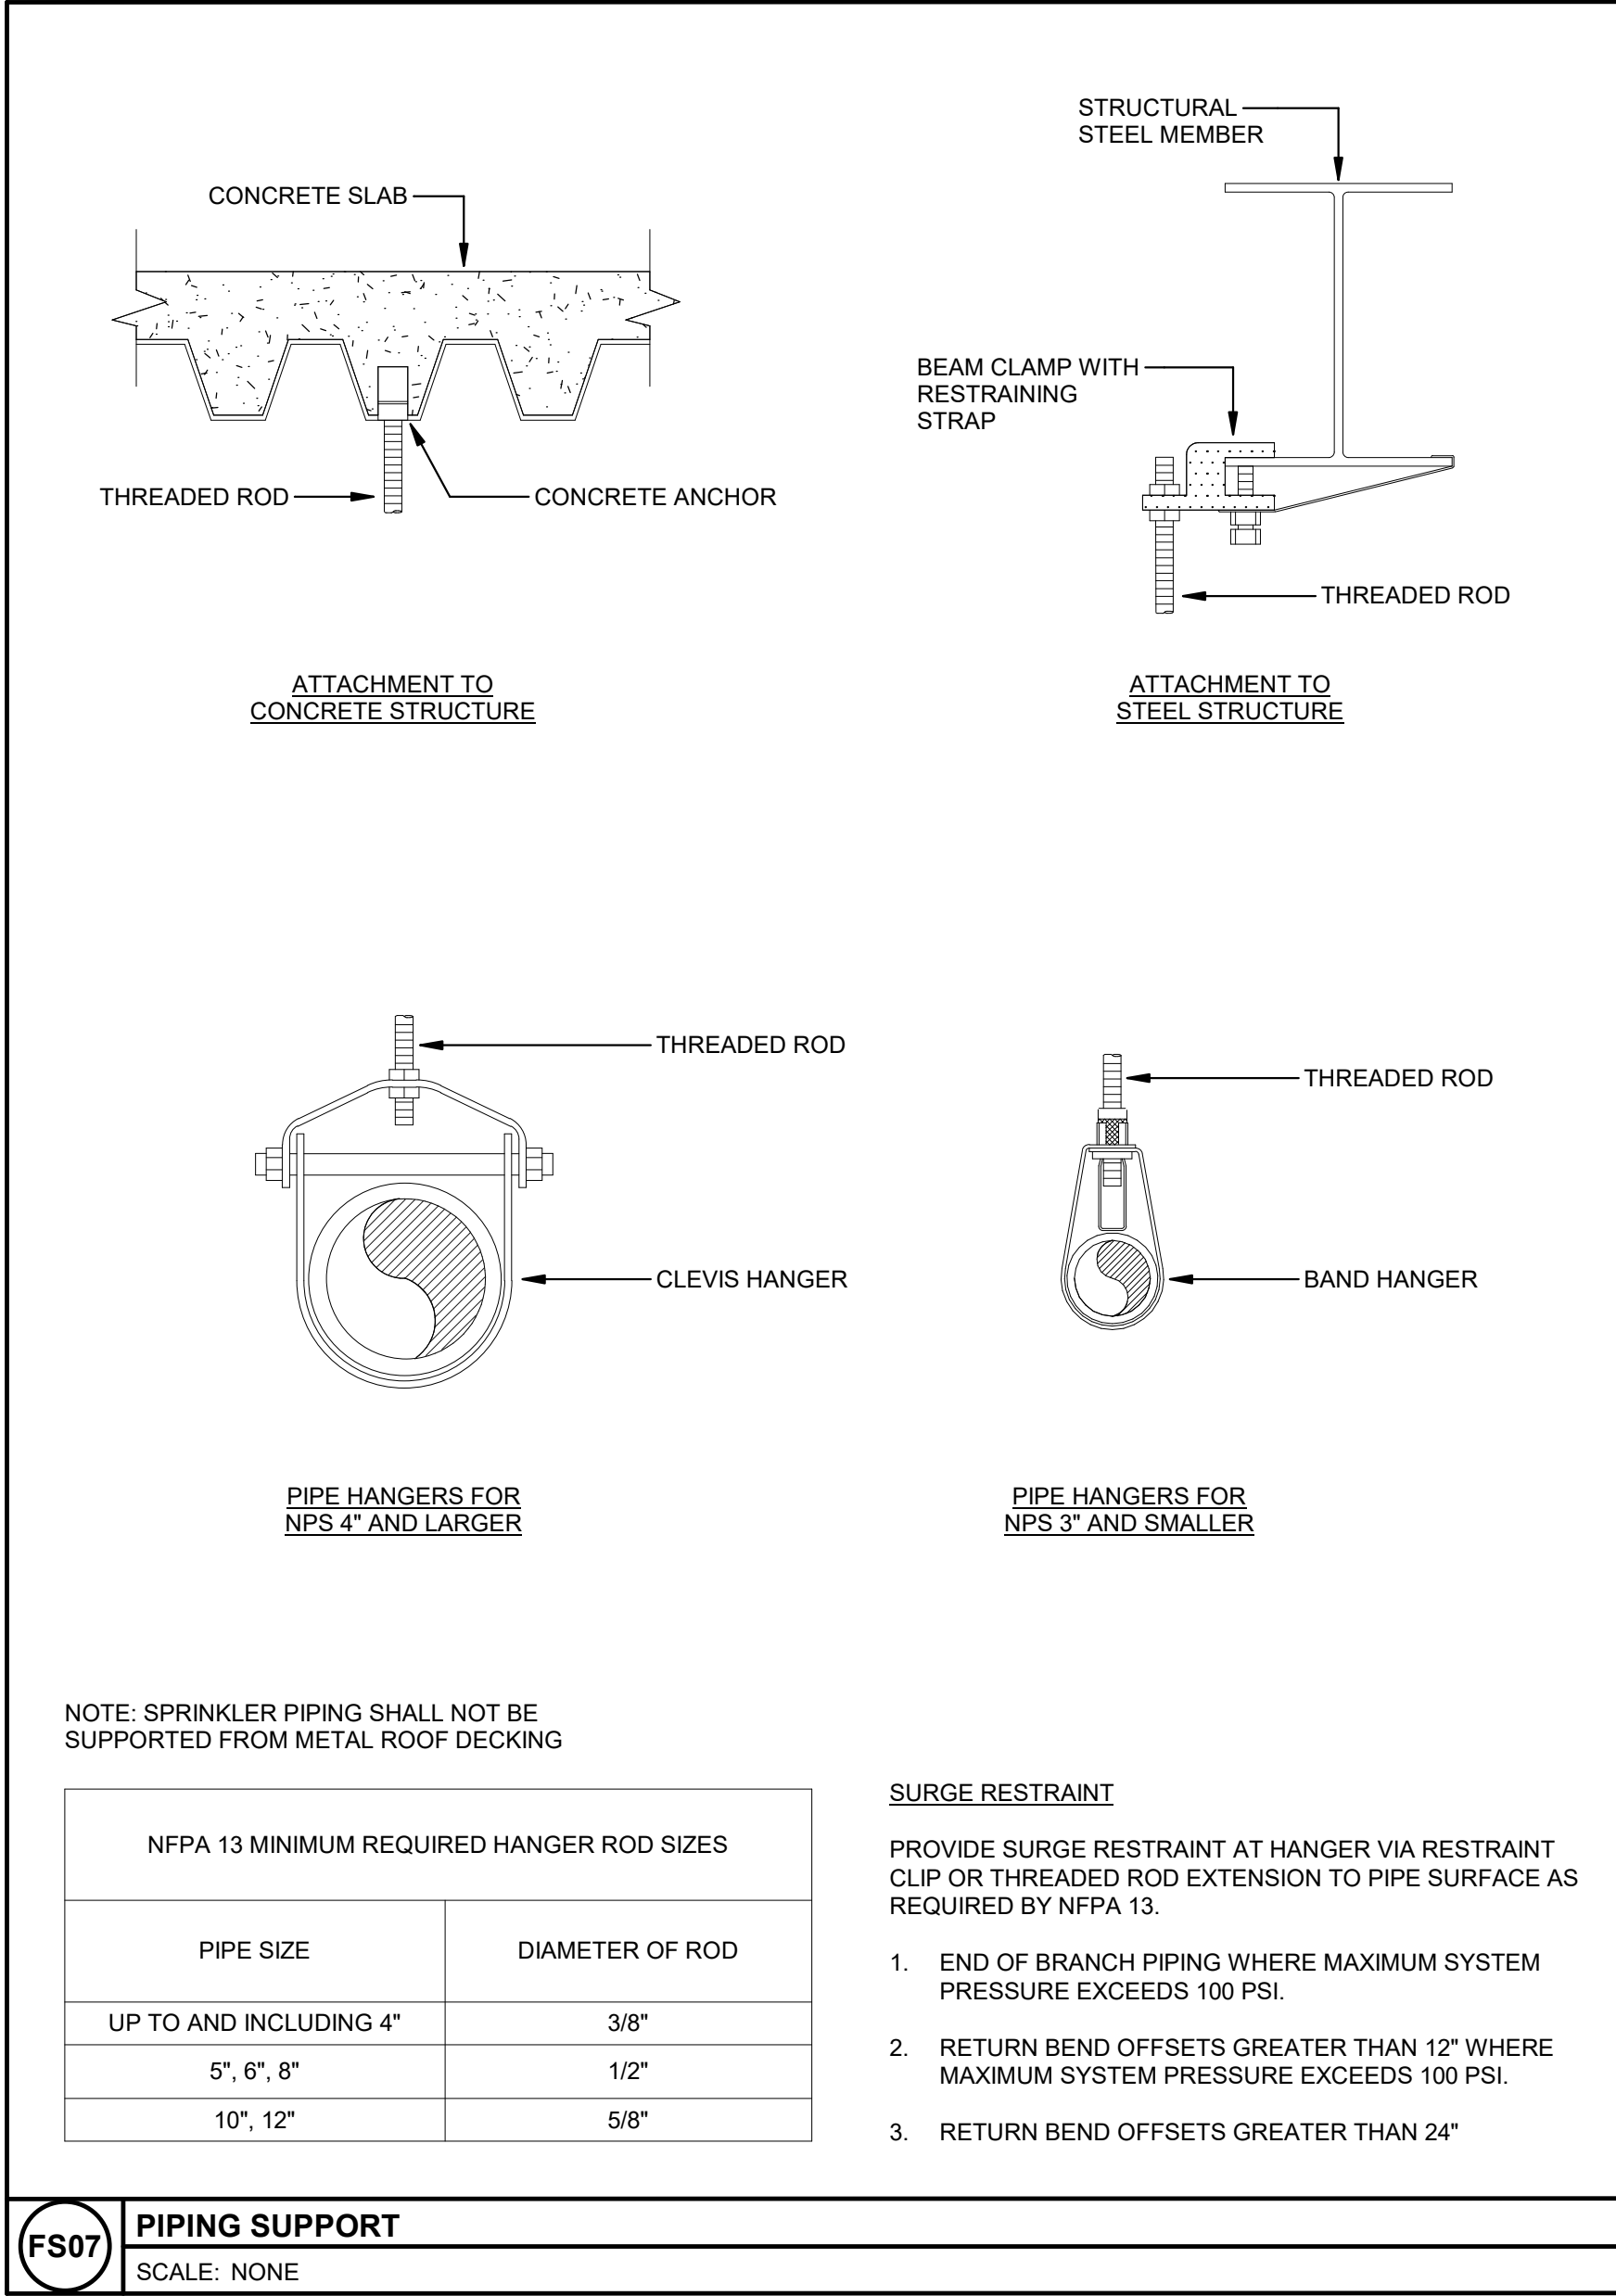
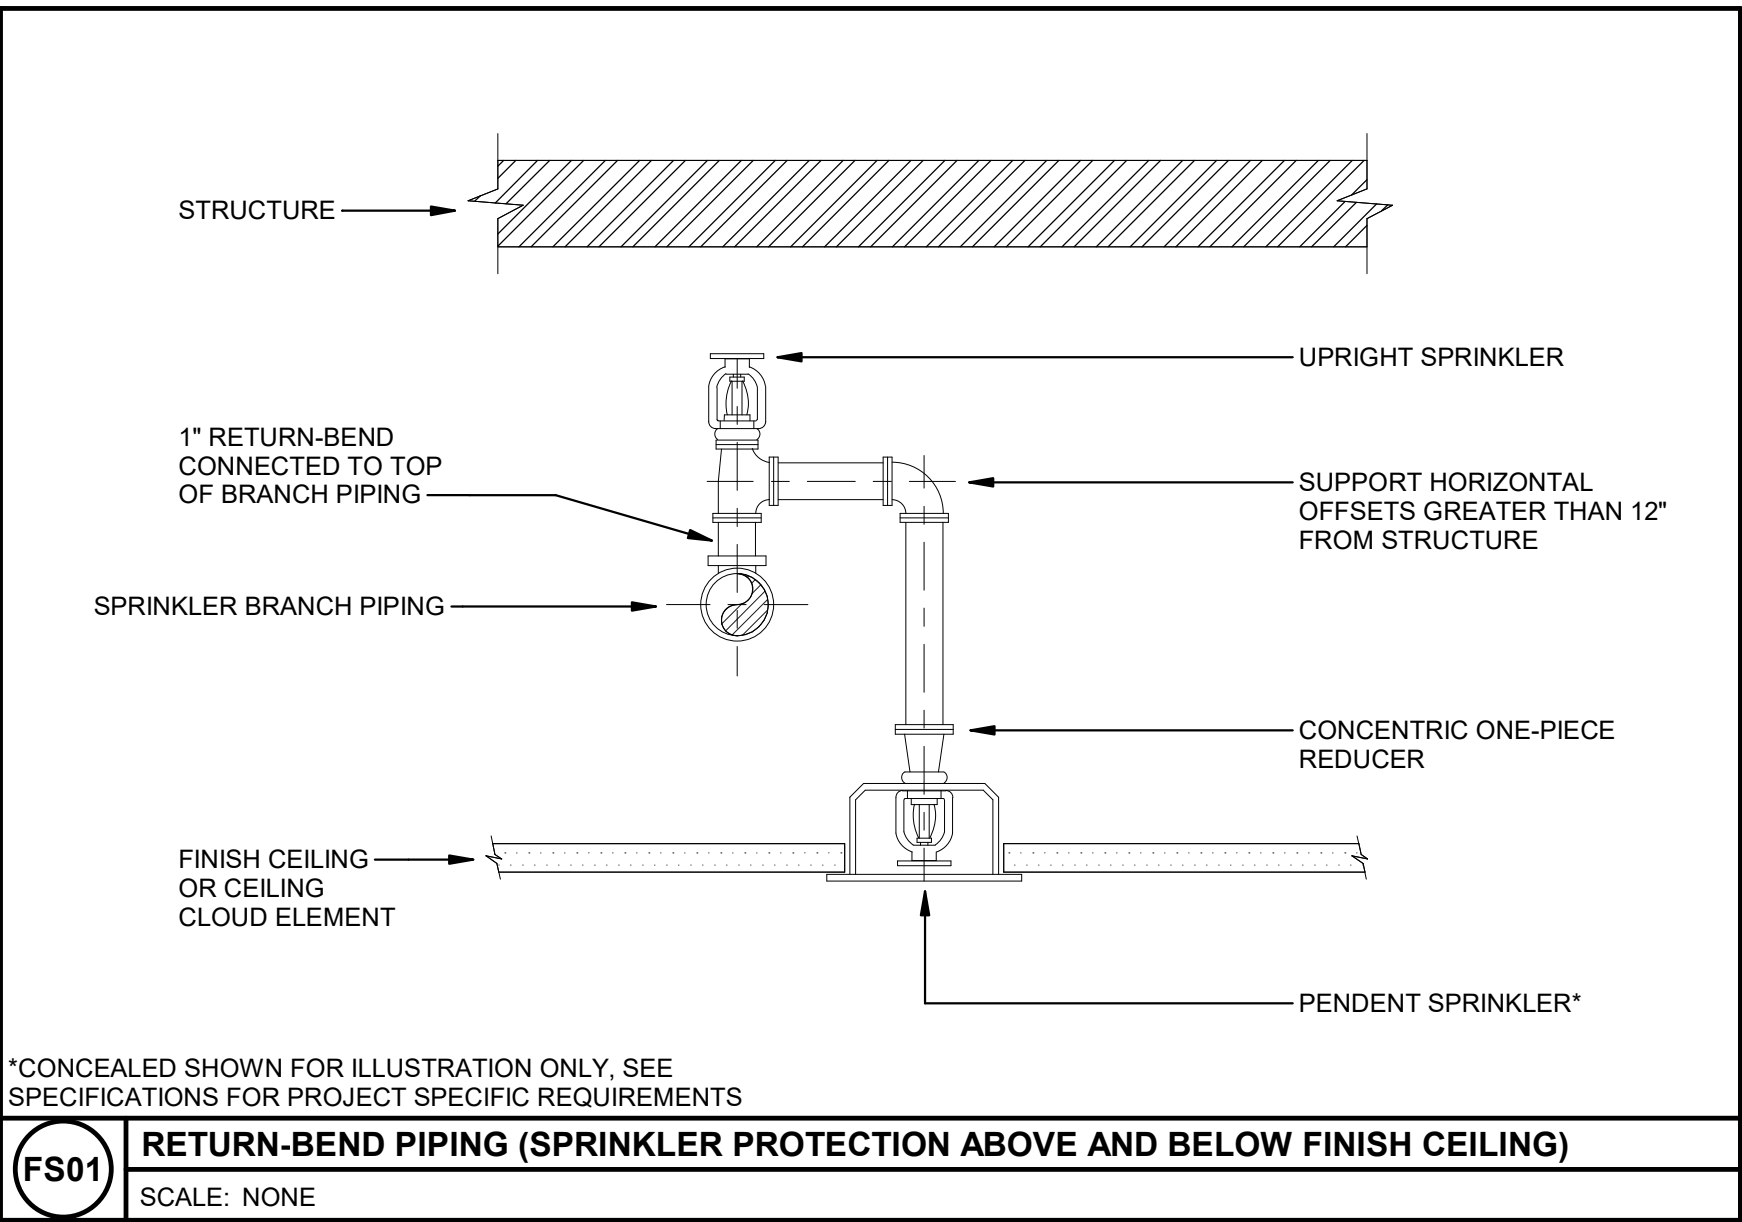
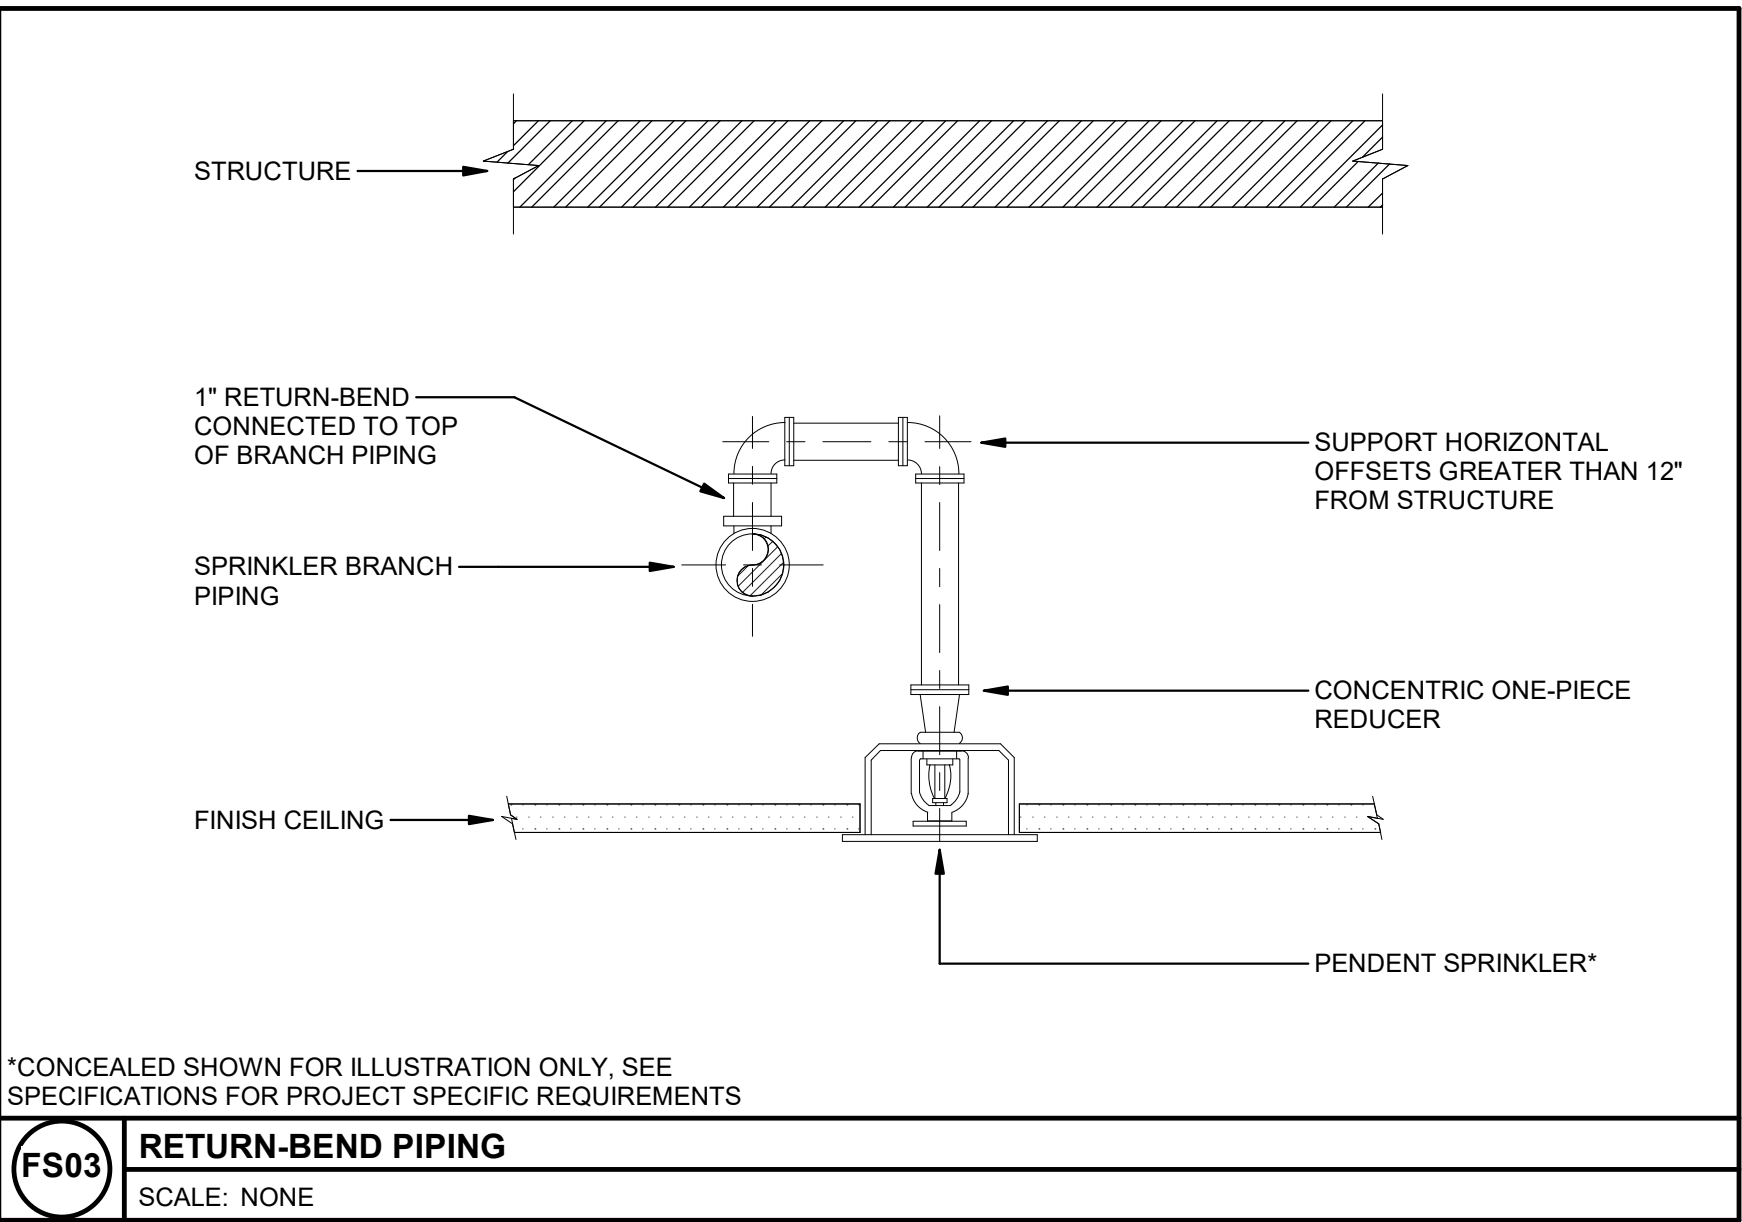


7/6/2022 2:23:42 PM DRAWING PRINTED FULL SIZE (ONLY) - 30"x42" DRAWING PRINTED HALF SIZE (ONLY) VAL LIT ON A SHEET TYPED WITH 1/8" OF EXTRA SPACE OR ALL FOUR SIDES. DRAWING PRINTED NEARLY THIRD SIZE (2 1/4" x 11 1/2") OF WILL LIT TIGHTLY ON TYPED INDIVIDUAL 1/2" x 14" 1/8" AND 1/2" VIEW SCALES WILL TRANSMIT BY MULTIPLYING THE DIMENSION BY 4 AND MARKING THE DIMENSION 1/4" FOR SCALES OF 3/4", 3/8", 3/16" AND 3/32" THE TRANSMISSION IS CLOSE ENOUGH TO USE THE DIMENSION AS SHOWN AND CHANGE THE NUMERATOR TO 1/4" IF IT WILL BE NEAREST TO 1/4" IF IT

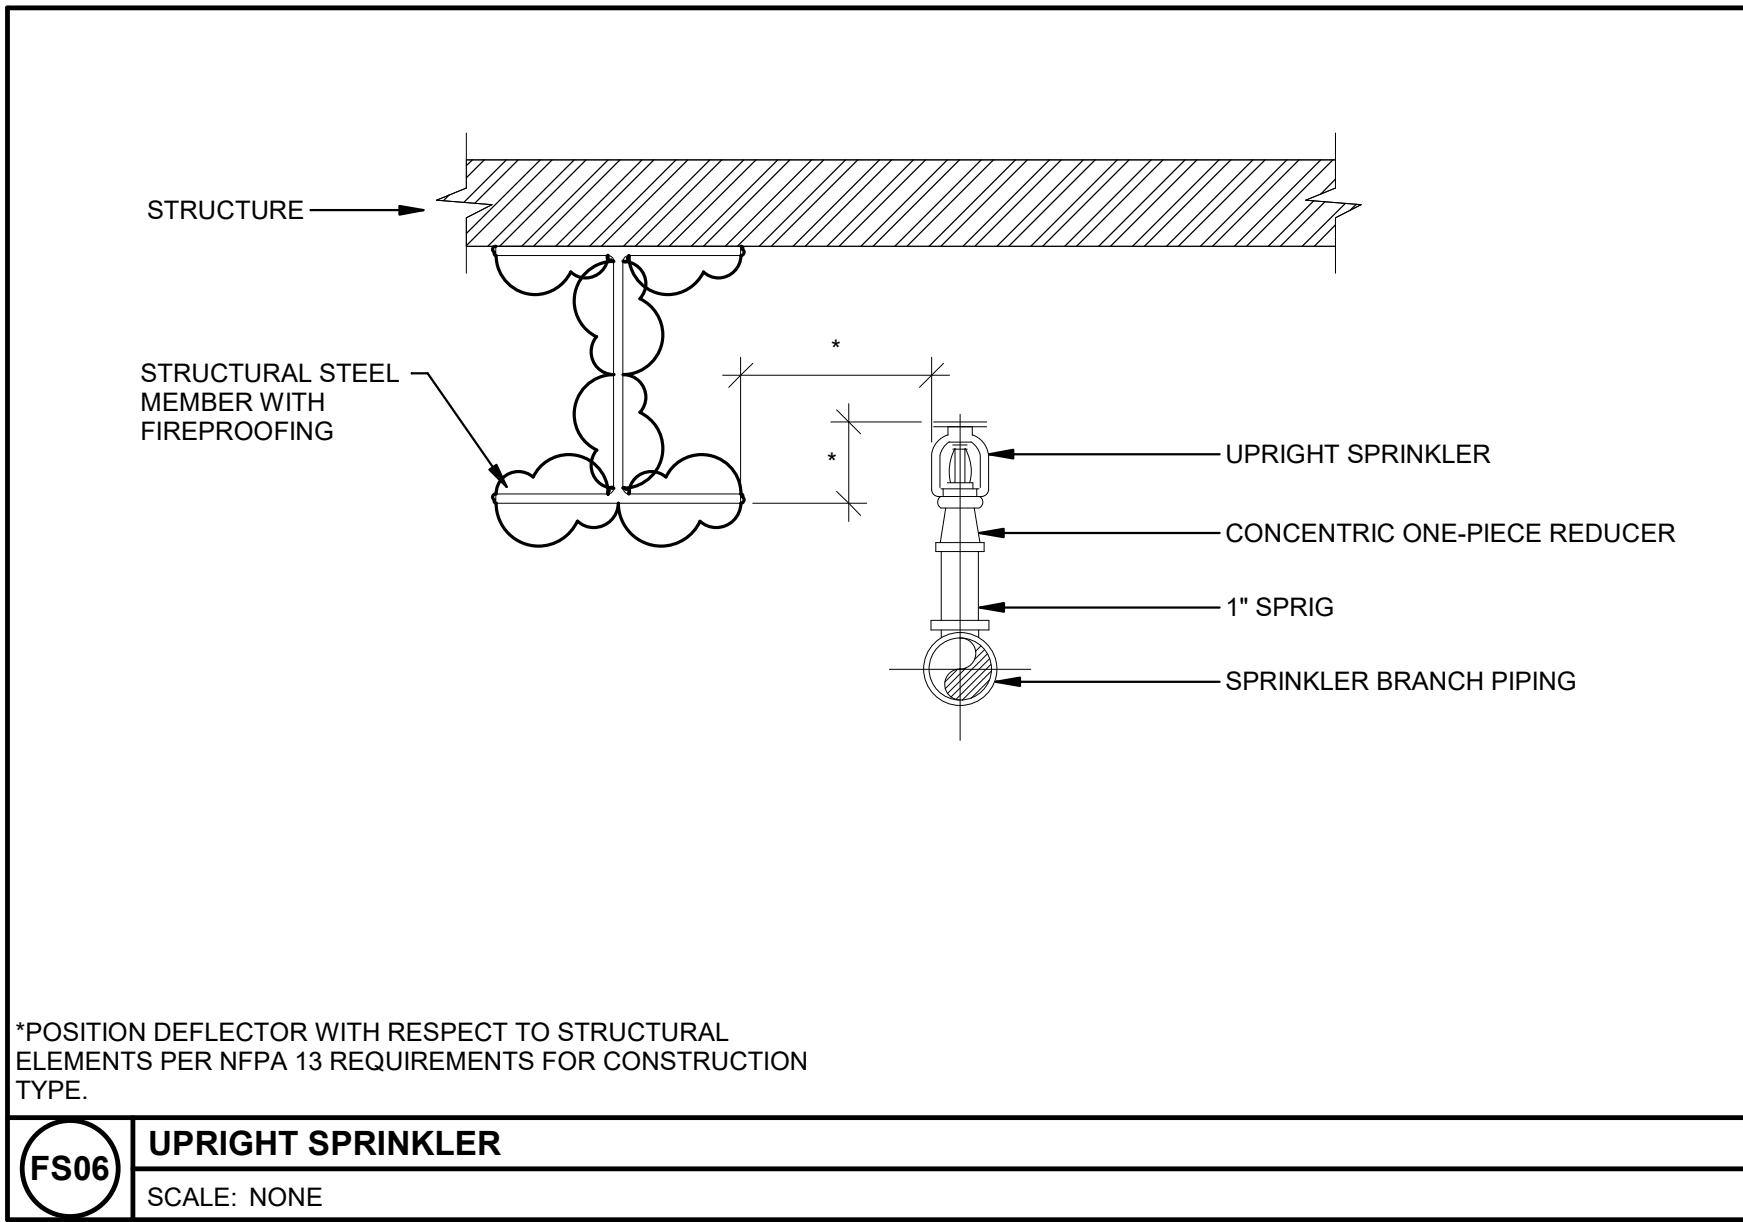

CROCKFORDS - RESORTS WORLD CATSKILLS

888 resorts World Dr
Monticello, NY 12701


JCJARCHITECTURE
120 HUYSHOPE AVENUE
SUITE 400
HARTFORD, CT 06106
860.247.9226

© 2021 JCJ Architecture

CONSULTANT:

VANDERWEIL
R.G. Vanderweil Engineers, LLP
274 Summer Street
Boston, MA 02210
617.423.7423 TEL
617.423.7461 FAX
vanderweil.com

BIDDING & CONSTRUCTION
07/06/2022

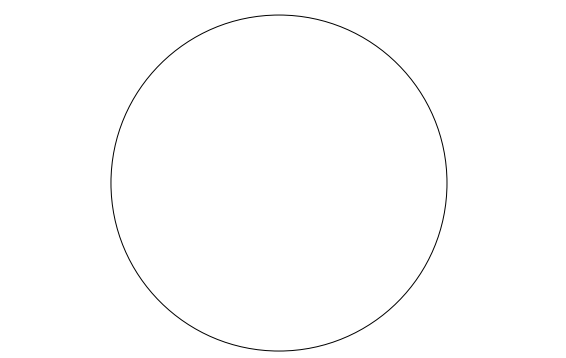

ISSUE 07/06/2022
JOB 30860.00
DRAWN Author
SCALE 1 : 10
REVISIONS
Date 1 Revision 1

FIRE PROTECTION DETAILS

FP-6