


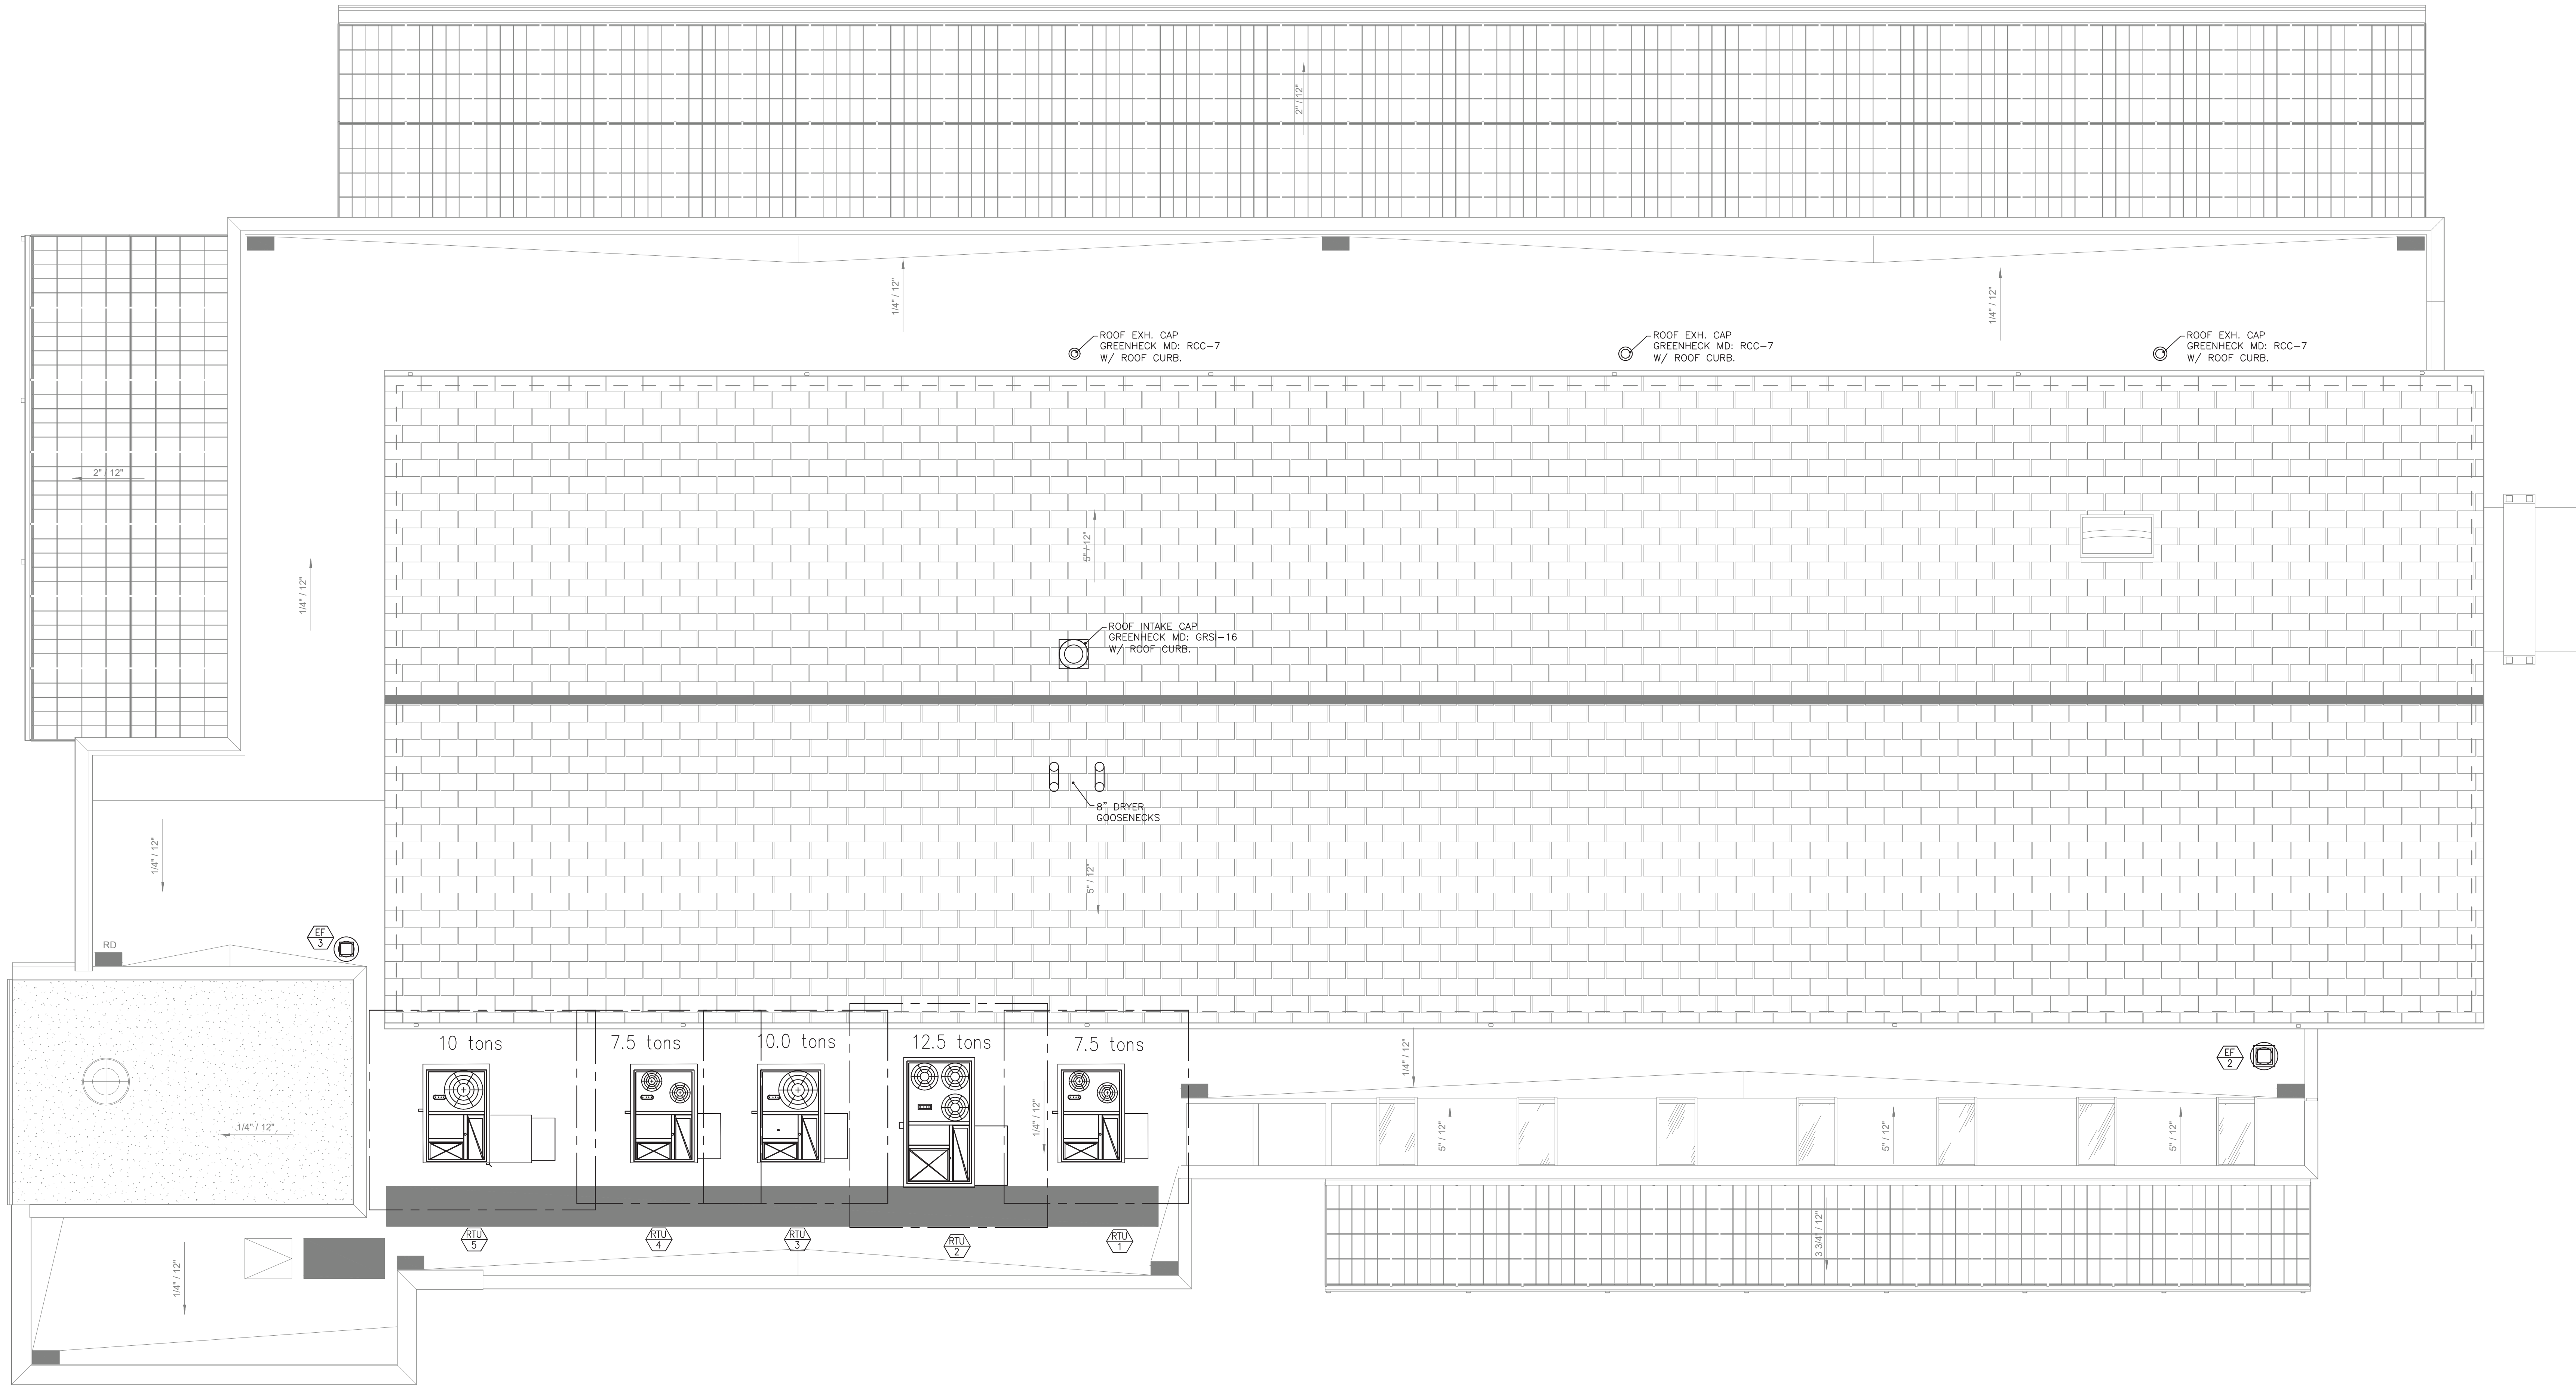

1 MECHANICAL ROOF PLAN
3/16" = 1'-0"

CDi
620 Pennsylvania Ave
Winchester, VA 22601
Phone 540-665-2846
Fax 540-667-3284

Comfort Design Inc.
Mechanical & Electrical
Engineers

Job # E2119

MECHANICAL
ROOF PLAN

CAPITAL PROJECT 1483
CONSTRUCTION OF A NEW ANIMAL SHELTER FACILITY
65 FIREMENS MEMORIAL DRIVE, POMONA, NY 10970

M2.02

DRAWN BY:	JLC
CHECKED BY:	CRS
SCALE:	AS NOTED
DATE:	20 OCT 2021
PROJECT NO.	2019
PROGRESS SET	☐
BID SET	☐
PERMIT SET	☐
CONSTRUCTION SET	☐

© 2021 RAUHAUS FREEDENFELD & ASSOCIATES, LLP

East Coast Office
97 Broadway
Pomona, NY 10970
T: 847.336.0300
F: 847.336.2557

West Coast Office
23101 Moulton Pkwy #106
Troy, CA 92653
T: 949.318.9500
F: 949.318.9559



rauhaus freedenfeld & associates

ARCHITECTS
SEAL

NO.	REVISION DESCRIPTION ADDENDUM #1	DATE
1		11.11.21