

777 Old Saw Mill River Road
Tarrytown, NY 10591-6707
T: 914.847.7400
F: 914.847.7991
www.regeneron.com

Building #17
Campus Expansion Child
Day-care Center

777 Old Saw Mill River Road
Mount Pleasant, NY 10591

Project No. B17-DAYCARE

Architect

Gensler

1700 Broadway, Suite 400
New York, NY 10019
(212) 492-1400 Phone
(212) 492-1472 Fax

Structural Engineer

Thornton Tomasetti
120 Broadway, 15th Floor
New York, NY 10271
(917) 661-7800 Phone
(917) 661-7801 Fax

MEP / IT / Security Engineer

Cosentini Associates

498 Seventh Avenue
New York, NY 10018
(212) 615-3800 Phone
(212) 615-3700 Fax

Civil Engineer

JMC


120 Bedford Road
Armonk, NY 10504
(914) 273-5225 Phone
(914) 273-2102 Fax

Landscape Architect

Langan

21 Penn Plaza, 360 West 31st Street, 8th Floor
New York, NY 10001
(212) 479-5400 Phone
(212) 479-5444 Fax

Key Plan

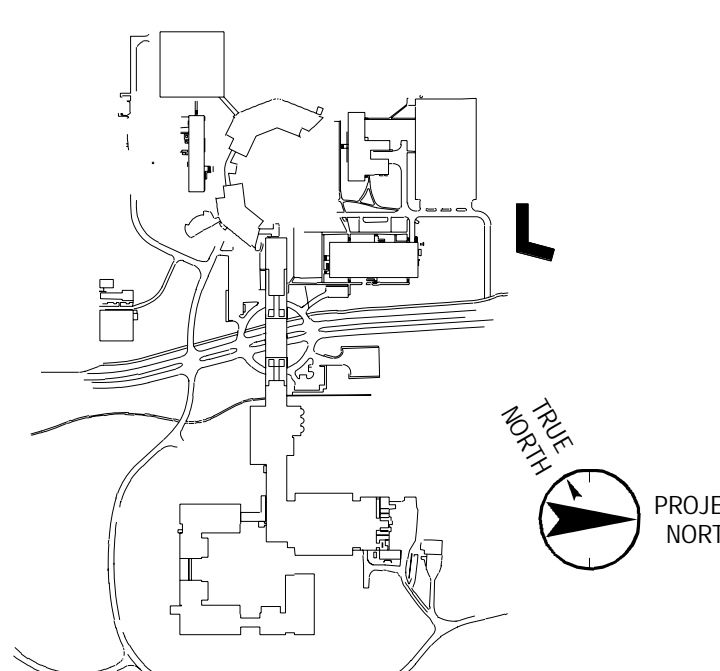

No. Date Description

0	05.20.2022	ISSUED FOR PERMIT
1	06.20.2022	100% CONSTRUCTION DOCUMENTS
2	07.01.2022	100% CONSTRUCTION DOCUMENTS-1

Plot Date: 07.01.2022

ALL DRAWINGS AND WRITTEN MATERIALS REPRESENTED ON THIS SHEET CONSTITUTE THE COPYRIGHTED WORK AND ARE THE SOLE PROPERTY OF REGENERON PHARMACEUTICALS. THIS SHEET SHALL NOT BE REPRODUCED OR COPIED IN WHOLE OR IN PART, NOR MAY ANY OF THE DRAWINGS OR WRITTEN MATERIALS BE REPRODUCED OR COPIED IN WHOLE OR IN PART, NOR MAY ANY OTHER WORK BE PRODUCED OR COPIED IN WHOLE OR IN PART, WITHOUT THE WRITTEN CONSENT OF REGENERON PHARMACEUTICALS. THE SHEET SHALL BE RETURNED TO REGENERON PHARMACEUTICALS UPON THE COMPLETION OF THE PROJECT WITHOUT THE EXPRESS WRITTEN CONSENT OF REGENERON PHARMACEUTICALS. REGENERON ASSUMES FULL RESPONSIBILITY FOR ANY AND ALL RISKS INVOLVED IN SUCH REUSE.

Professional Seal and Signature

Vendor Name: COSENTINI

Vendor Project No.: 210104

Discipline: Electrical

Drawn By: AI

ELECTRICAL LIGHTING PLAN -

1ST FLOOR

Scale: 1/8" = 1'-0"

Floor:

E-150

