





777 Old Saw Mill River Road  
Tarrytown, NY 10591-6707  
T: 914.847.7400  
F: 914.847.7991  
www.regeneron.com

Building #17  
Campus Expansion Child  
Day-care Center

777 Old Saw Mill River Road  
Mount Pleasant, NY 10591

Project No. B17-DAYCARE

Architect

**Gensler**

1700 Broadway, Suite 400  
New York, NY 10019  
(212) 492-1400 Phone  
(212) 492-1472 Fax

Structural Engineer

Thornton Tomasetti  
120 Broadway, 15th Floor  
New York, NY 10271  
(917) 661-7800 Phone  
(917) 661-7801 Fax

MEP / IT / Security Engineer

Cosentini Associates  
498 Seventh Avenue  
New York, NY 10018  
(212) 615-3600 Phone  
(212) 615-3700 Fax


Civil Engineer

JMC  
120 Bedford Road  
Armonk, NY 10504  
(914) 273-5225 Phone  
(914) 273-2102 Fax

Landscape Architect

Langan  
21 Penn Plaza, 360 West 31st Street, 8th Floor  
New York, NY 10001  
(212) 479-5400 Phone  
(212) 479-5444 Fax

Key Plan

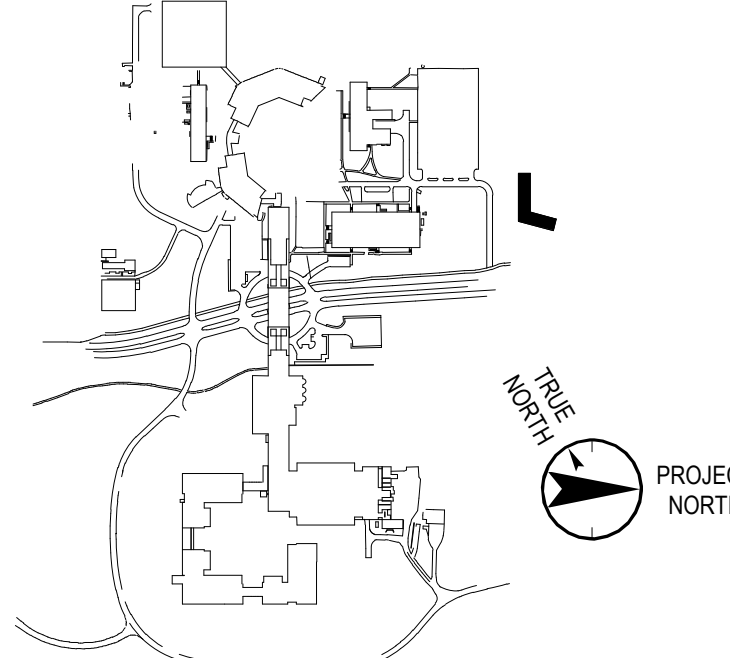

No. Date Description

0	06.20.2022	ISSUED FOR PERMIT
1	06.20.2022	100% CONSTRUCTION DOCUMENTS
2	07.01.2022	100% CONSTRUCTION DOCUMENTS-1

Plot Date: 07.01.2022

ALL DRAWINGS AND WRITTEN MATERIALS REPRESENTED ON THIS SHEET CONSTITUTE THE  
COPYRIGHTED WORK AND ARE THE SOLE PROPERTY OF REGENERON PHARMACEUTICALS.  
THIS SHEET MAY NOT BE REPRODUCED OR COPIED IN WHOLE OR IN PART, NOR MAY ANY  
OF THE DRAWINGS OR WRITTEN MATERIALS APPEAR HEREIN, BE INCORPORATED INTO  
ANOTHER WORK FOR ANY REASON WITHOUT THE WRITTEN CONSENT OF REGENERON  
PHARMACEUTICALS. THE SHEET MUST BE RETURNED UPON THE REQUEST OF  
REGENERON PHARMACEUTICALS. IF REGENERON NAMES OR AUTHORIZES REUSE OF ANY  
SUCH DOCUMENTS OR INFORMATION, PRODUCTS OF SUCH PROFESSIONAL OUTSIDE OF  
THE PROJECT WITHOUT THE EXPRESS WRITTEN CONSENT OF DESIGN PROFESSIONAL.  
REGENERON ASSUMES FULL RESPONSIBILITY FOR ANY AND ALL RISKS INVOLVED IN SUCH  
REUSE.

Professional Seal and Signature

Vendor Name: COSENTINI

Vendor Project No.: 210104

Discipline: Fire Suppression Drawn By: DH


FIRE SUPPRESSION 1ST

FLOOR PLAN

Scale: 1/8" = 1'-0"

Floor: 1ST

FX-101

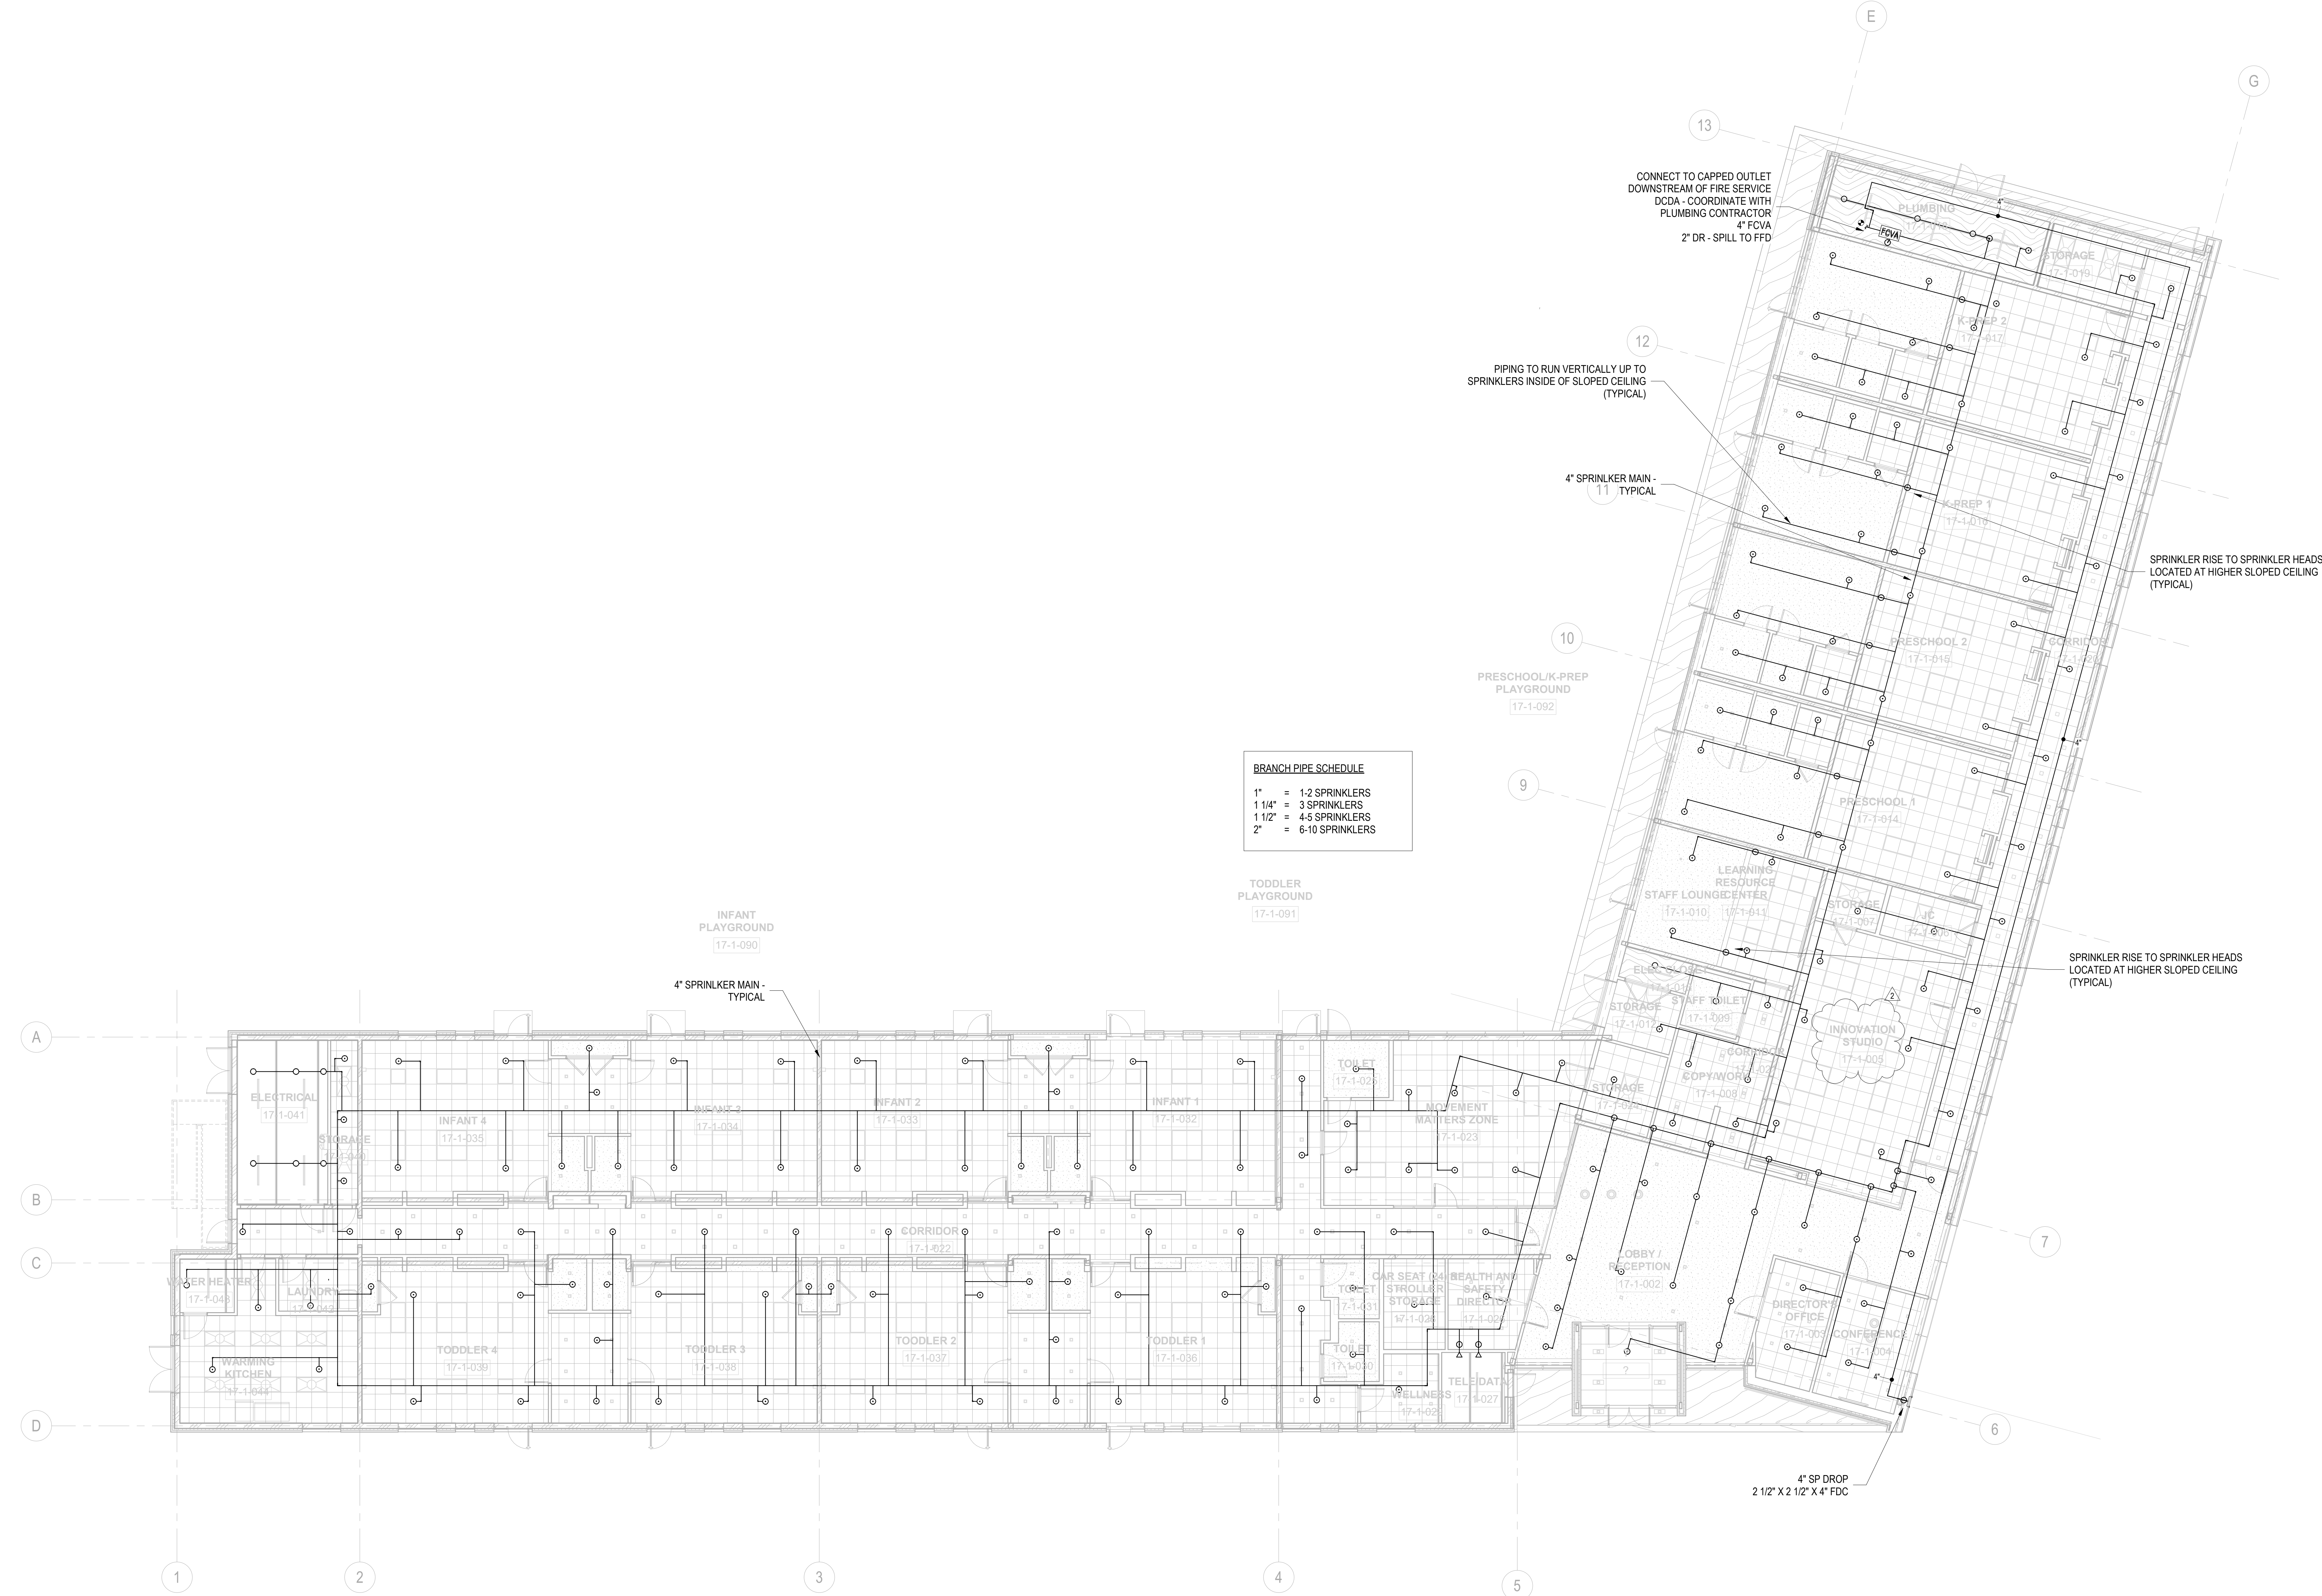

1 LEVEL 1 FIRE PROTECTION RCP  
1/8" = 1'-0"

TO THE BEST OF MY KNOWLEDGE, BELIEF AND  
PROFESSIONAL JUDGMENT, THESE PLANS AND  
SPECIFICATION ARE IN COMPLIANCE WITH THE  
2020 ENERGY CONSERVATION CODE OF NYS

This plan is approved only for work indicated on the  
application specification sheet. All other matters shown are  
not to be relied upon, or to be considered as either being  
approved or in accordance with applicable codes.

Alterations or additions to this engineering  
document by an unlicensed person is a violation  
of Chapter 16, Title VIII, Article 145 § 7209.2 of  
the New York State Education Law.

777 Old Saw Mill River Road  
Tarrytown, NY 10591-6707  
T: 914.847.7400  
F: 914.847.7991  
www.regeneron.com

Building #17  
Campus Expansion Child  
Day-care Center

899 Old Saw Mill River Road  
Mount Pleasant, NY 10591

Project No. B17-DAYCARE

Architect

**Gensler**

1700 Broadway, Suite 400  
New York, NY 10019  
(212) 492-1400 Phone  
(212) 492-1472 Fax

Structural Engineer

Thornton Tomasetti  
120 Broadway, 15th Floor  
New York, NY 10271  
(917) 661-7800 Phone  
(917) 661-7801 Fax

MEP / IT / Security Engineer

Cosentini Associates  
498 Seventh Avenue  
New York, NY 10018  
(212) 615-3600 Phone  
(212) 615-3700 Fax

Civil Engineer


JMC

120 Bedford Road  
Armonk, NY 10504  
(914) 273-5225 Phone  
(914) 273-2102 Fax

Landscape Architect

Langan  
21 Penn Plaza, 360 West 31st Street, 8th Floor  
New York, NY 10001  
(212) 479-5400 Phone  
(212) 479-5444 Fax

Key Plan

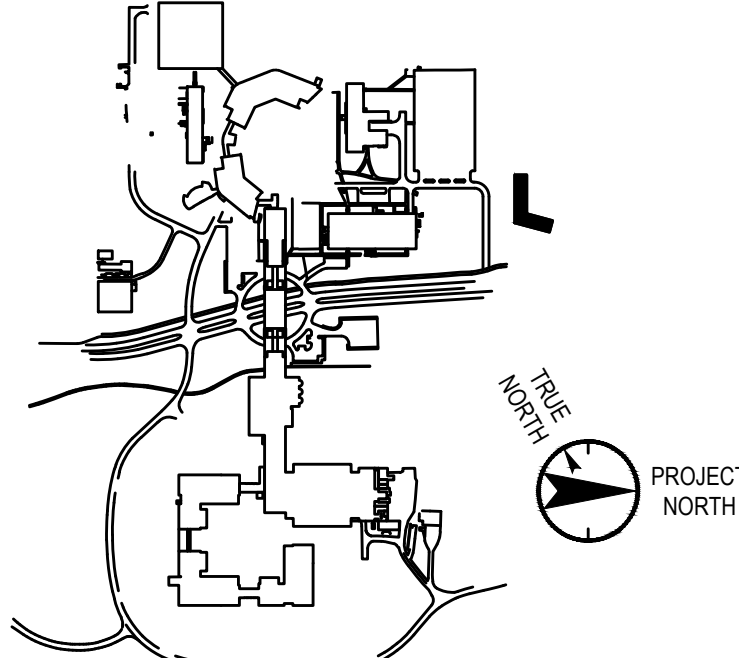

No.	Date	Description
0	05/20/2022	ISSUED FOR PERMIT
1	06/20/2022	100% CONSTRUCTION DOCUMENTS
2	07/01/2022	100% CONSTRUCTION DOCUMENTS-1

Plot Date: 07/01/2022





ALL DRAWINGS AND WRITTEN MATERIALS REPRESENTED ON THIS SHEET CONSTITUTE THE COPYRIGHTED WORK AND ARE THE SOLE PROPERTY OF REGENERON PHARMACEUTICALS. THIS SHEET MAY NOT BE REPRODUCED OR COPIED IN WHOLE OR IN PART, NOR MAY ANY OF THE DRAWINGS OR WRITTEN MATERIALS APPEARING HEREIN BE REPRODUCED OR COPIED IN WHOLE OR IN PART FOR ANY REASON WITHOUT THE WRITTEN CONSENT OF REGENERON PHARMACEUTICALS. THIS SHEET MAY BE REPRODUCED FOR THE PROJECT FOR REGENERON PHARMACEUTICALS. IF REGENERON MAKES OR AUTHORIZES REUSE OF ANY SUCH DOCUMENT OR INFORMATION FOR OTHER PROJECTS OR DESIGN PROFESSIONAL OUTSIDE OF THE PROJECT WITHOUT THE EXPRESS WRITTEN CONSENT OF REGENERON PHARMACEUTICALS, REGENERON ASSUMES FULL RESPONSIBILITY FOR ANY AND ALL ISSUES RESULTING THEREFROM.

Professional Seal and Signature

Vendor Name: COSENTINI  
Vendor Project No.: 210104  
Discipline: Fire Suppression Drawn By: DH  
FIRE SUPPRESSION  
DETAILS

Scale: NTS Floor: N/A

FX-500

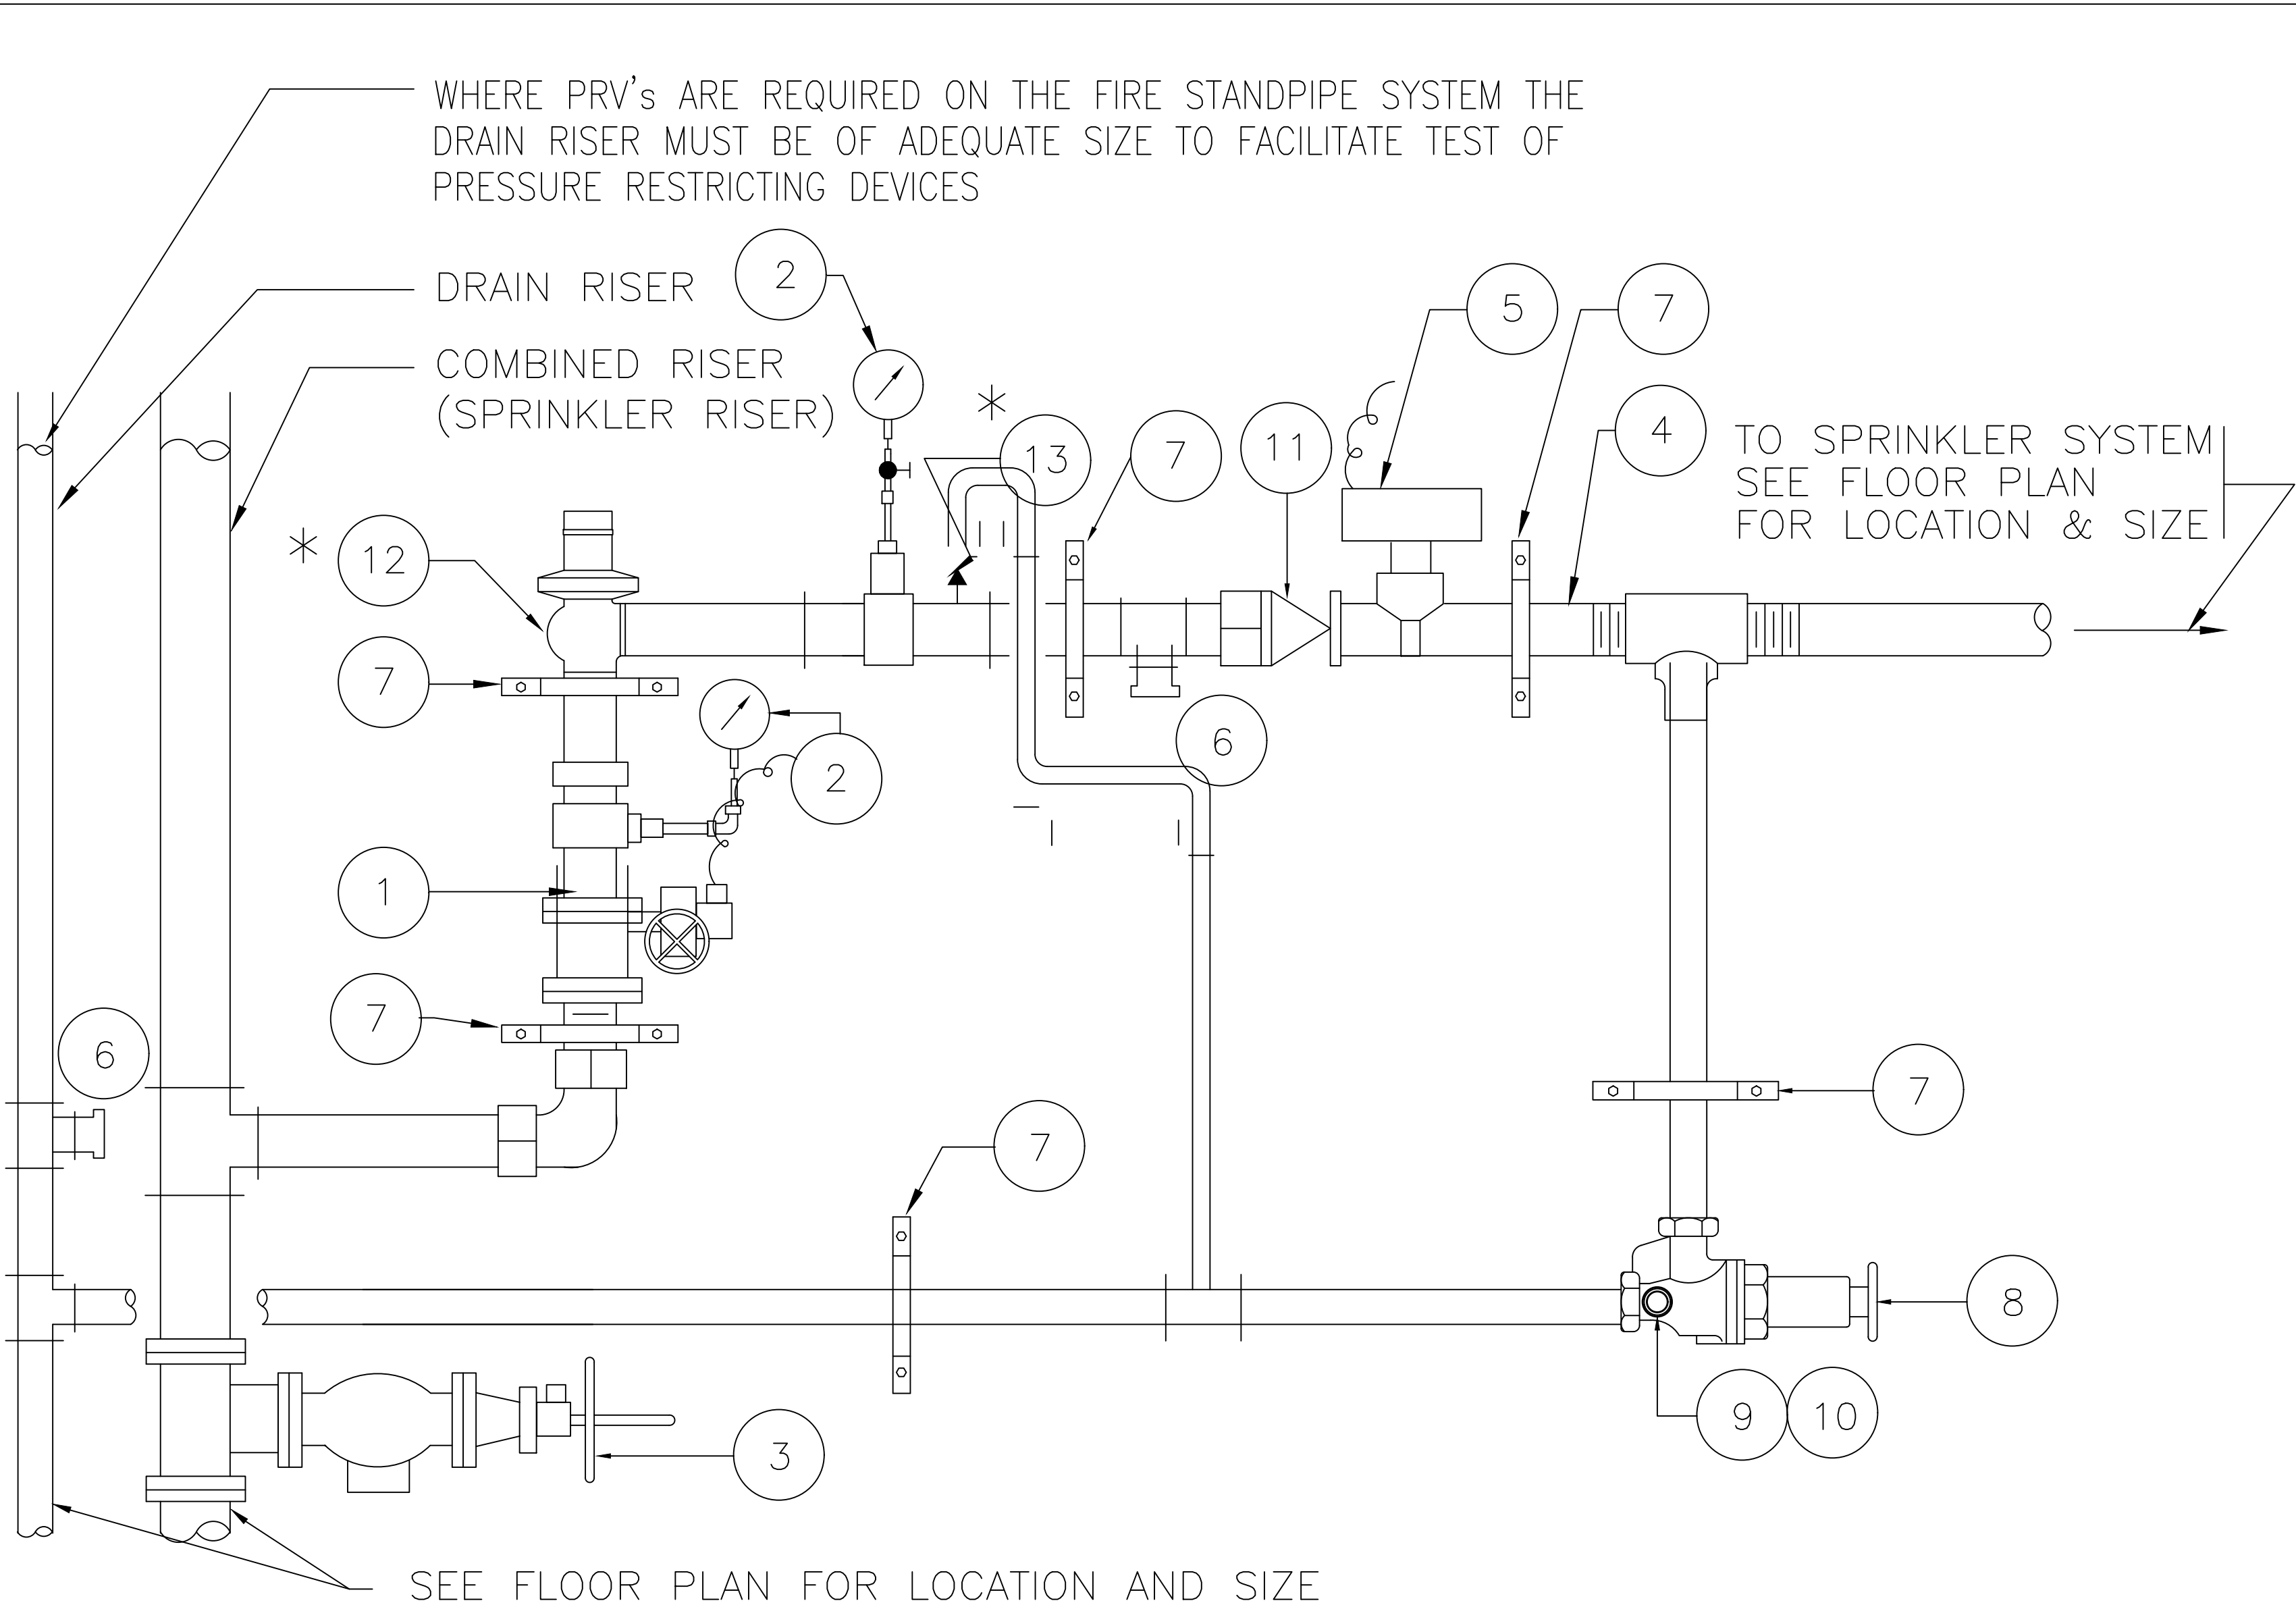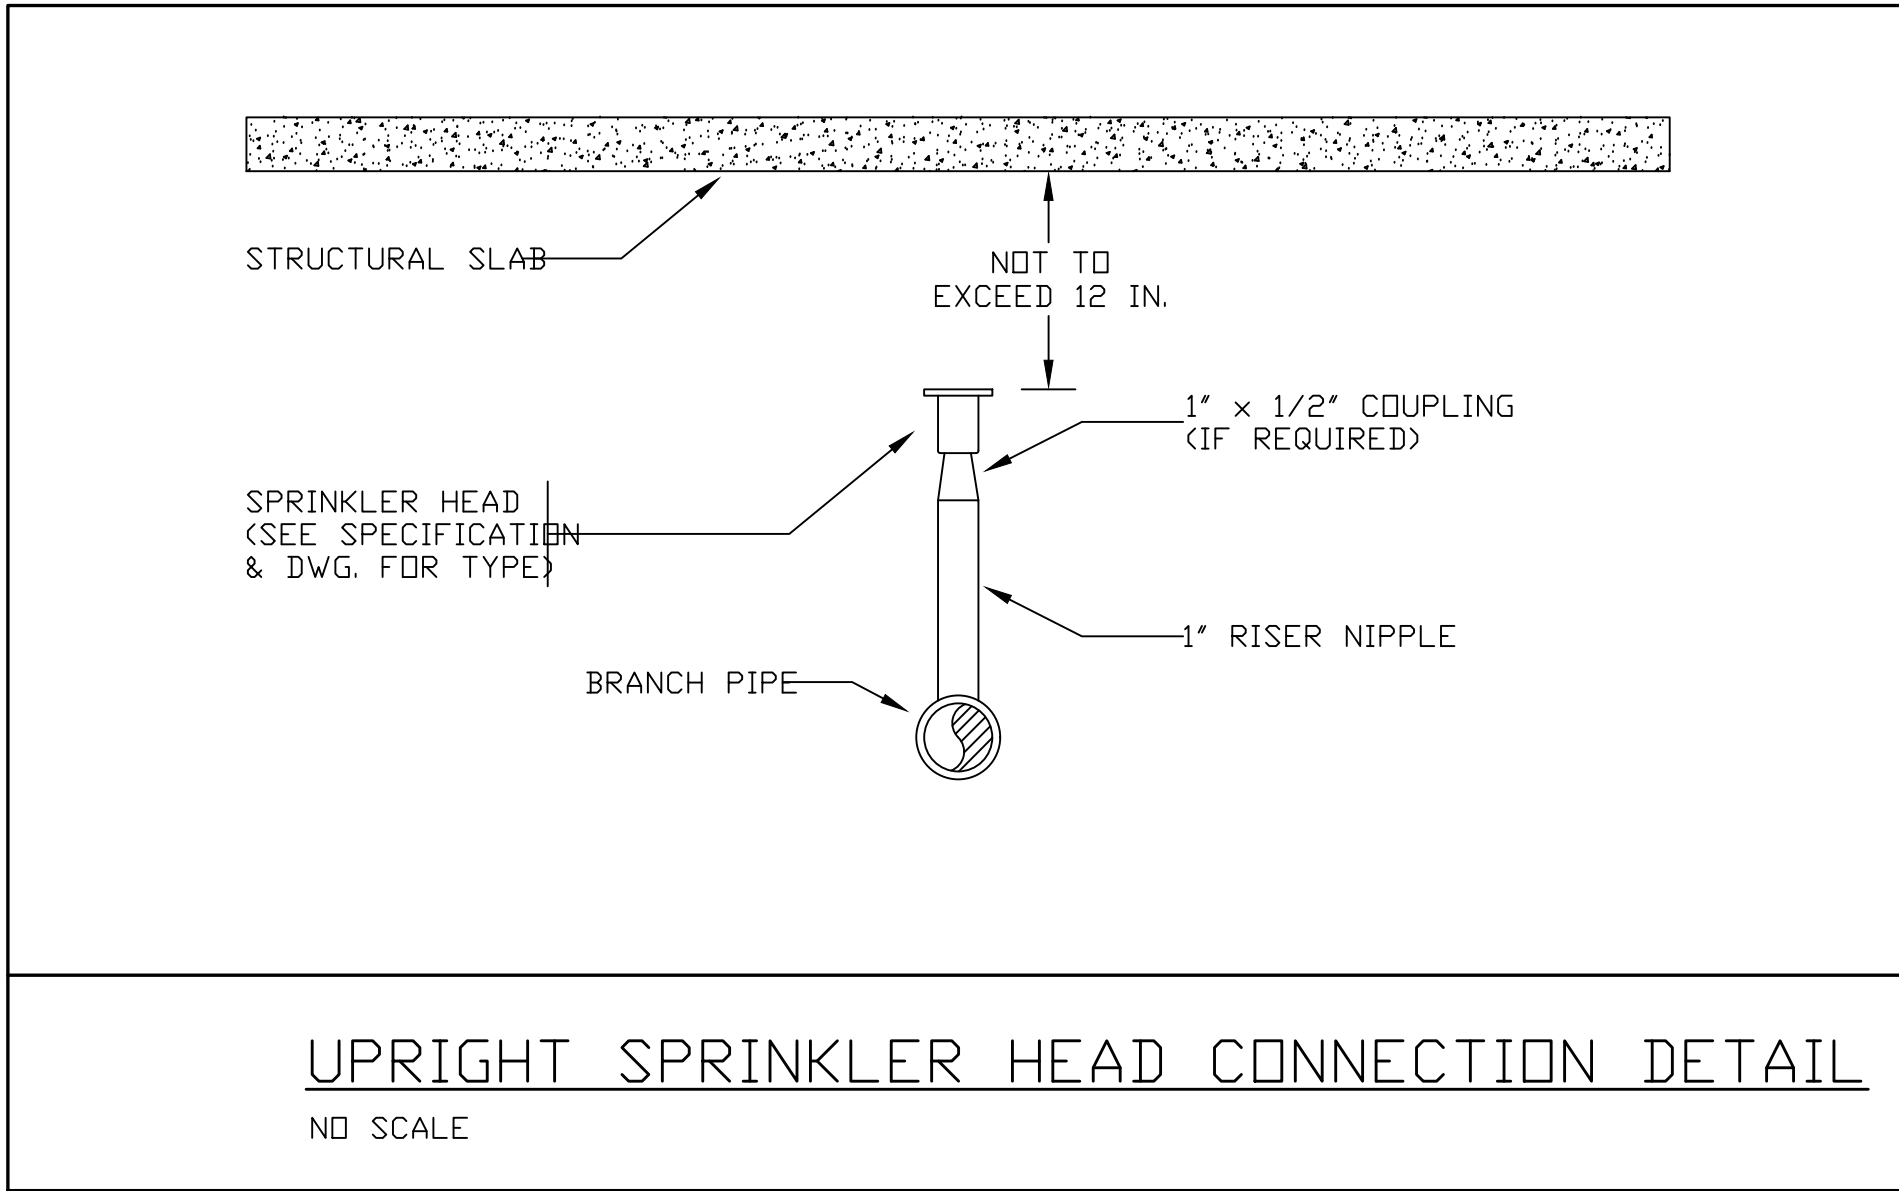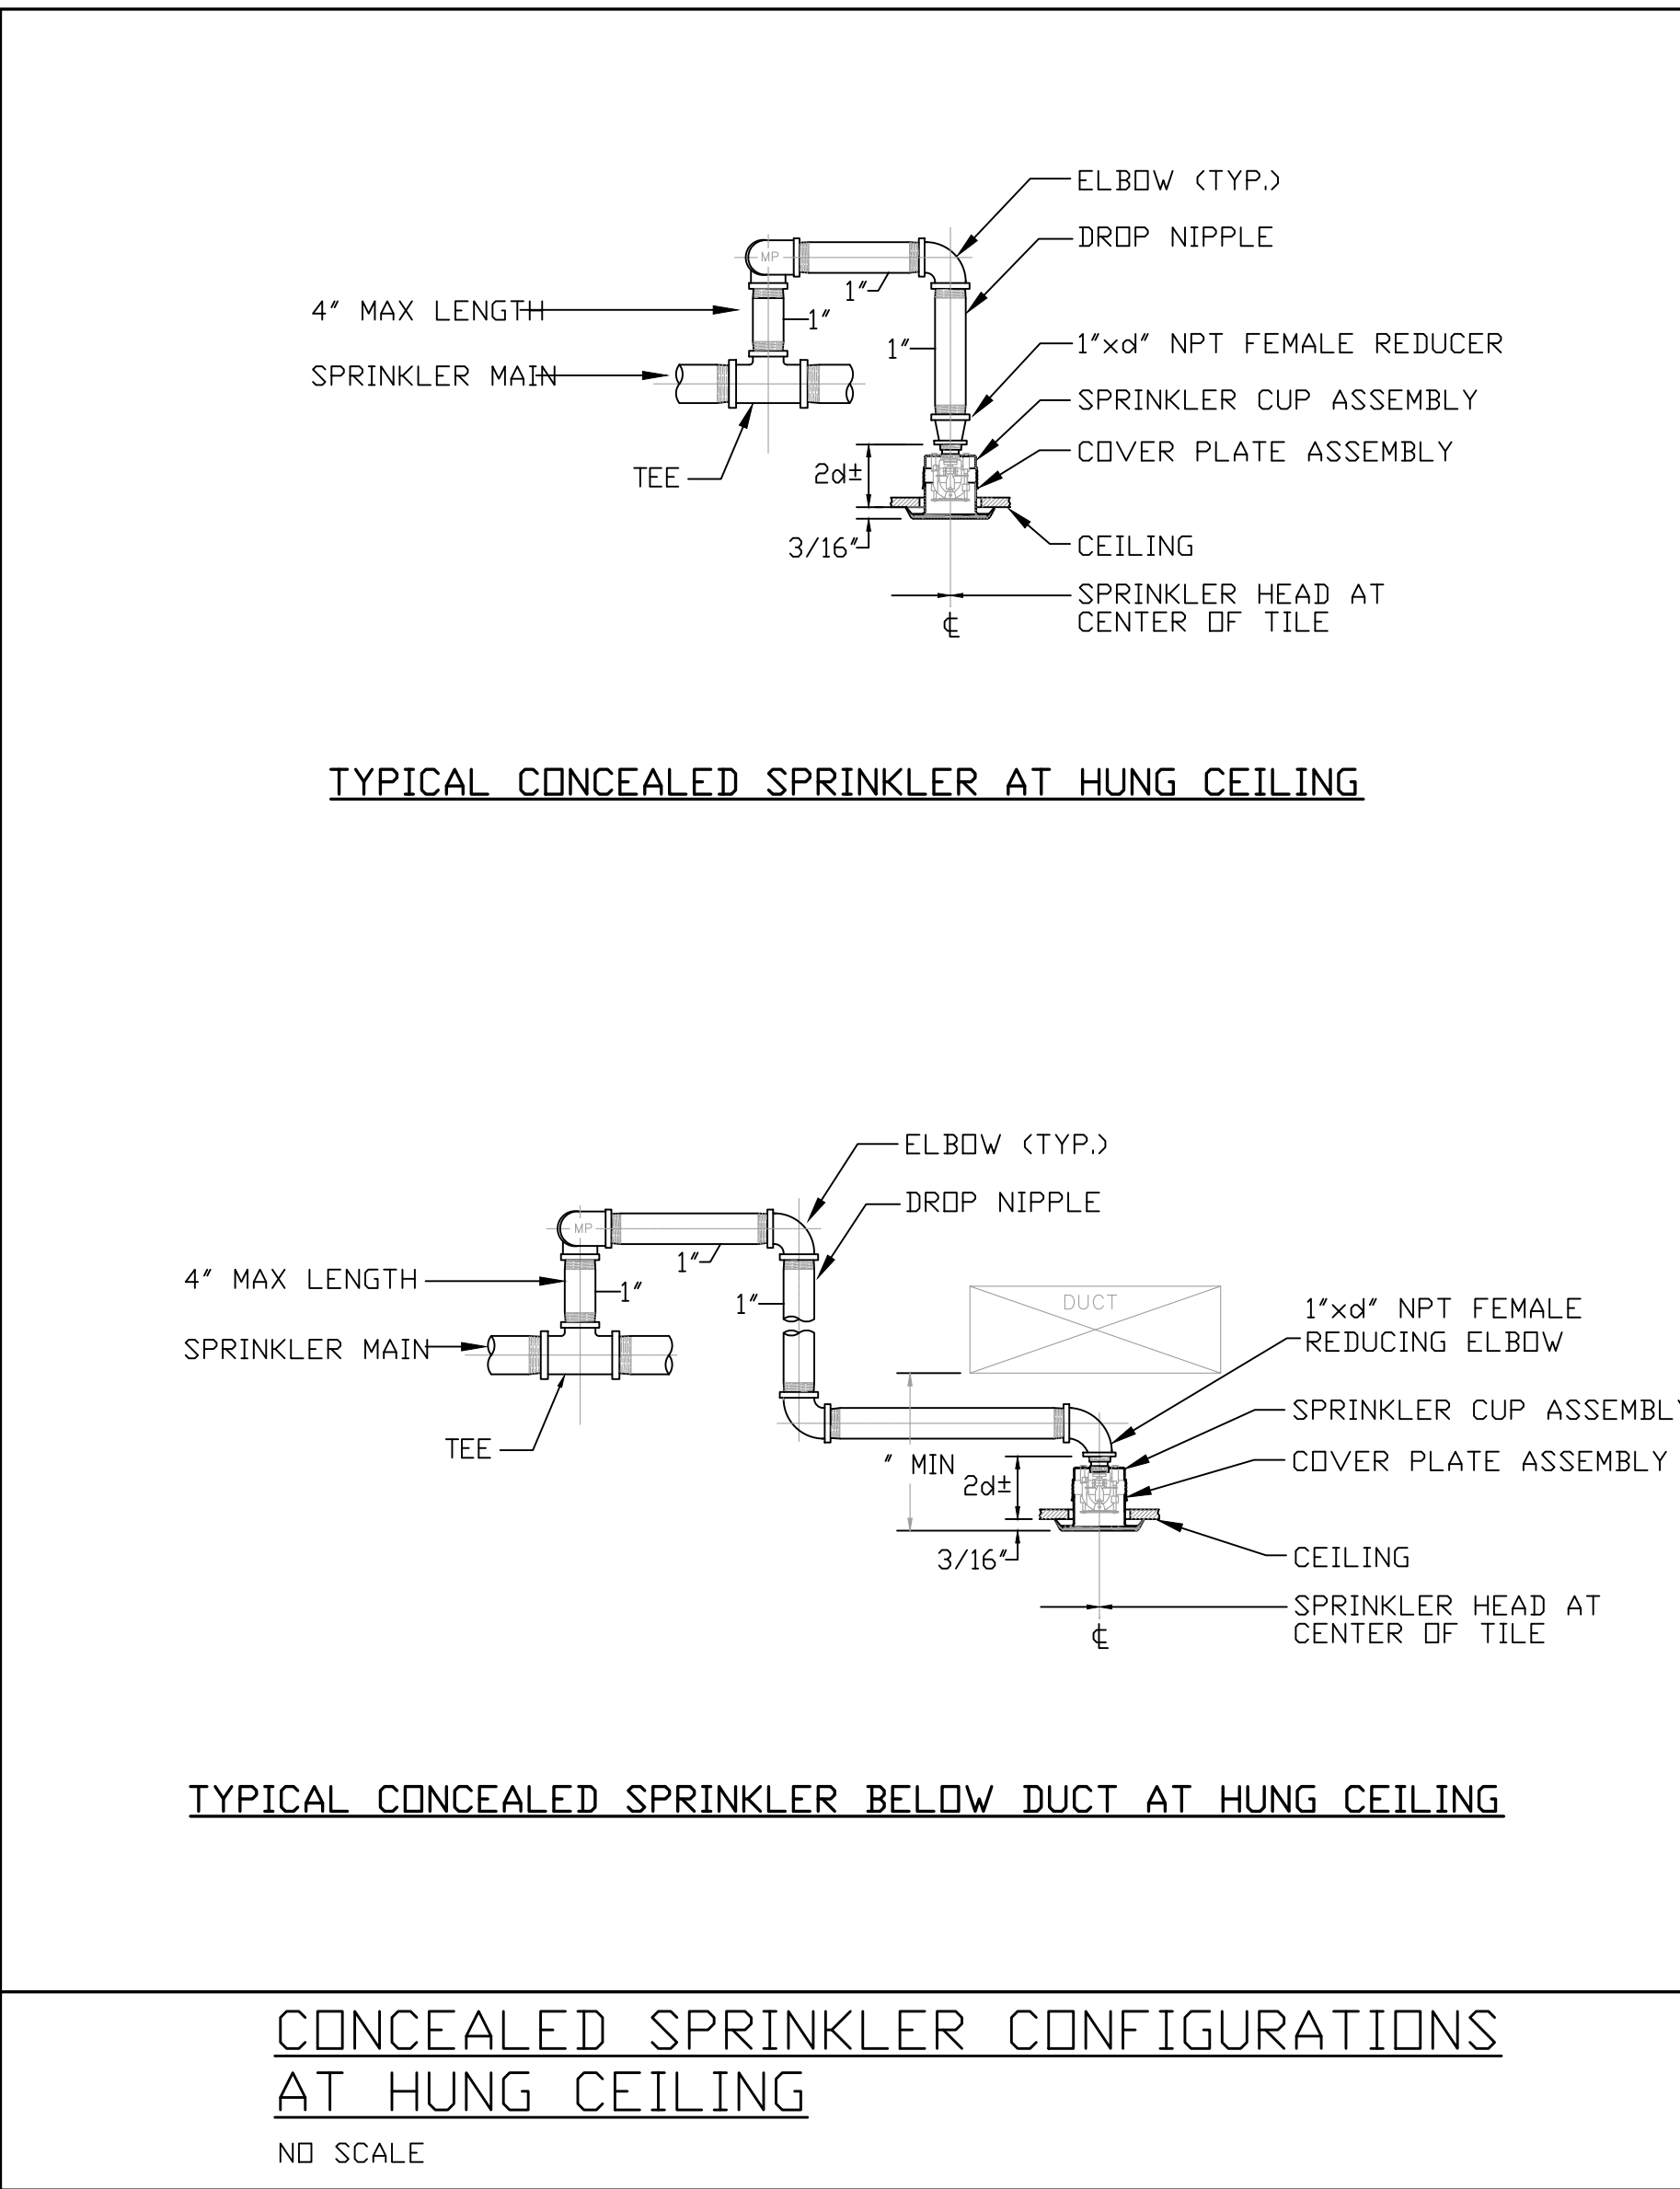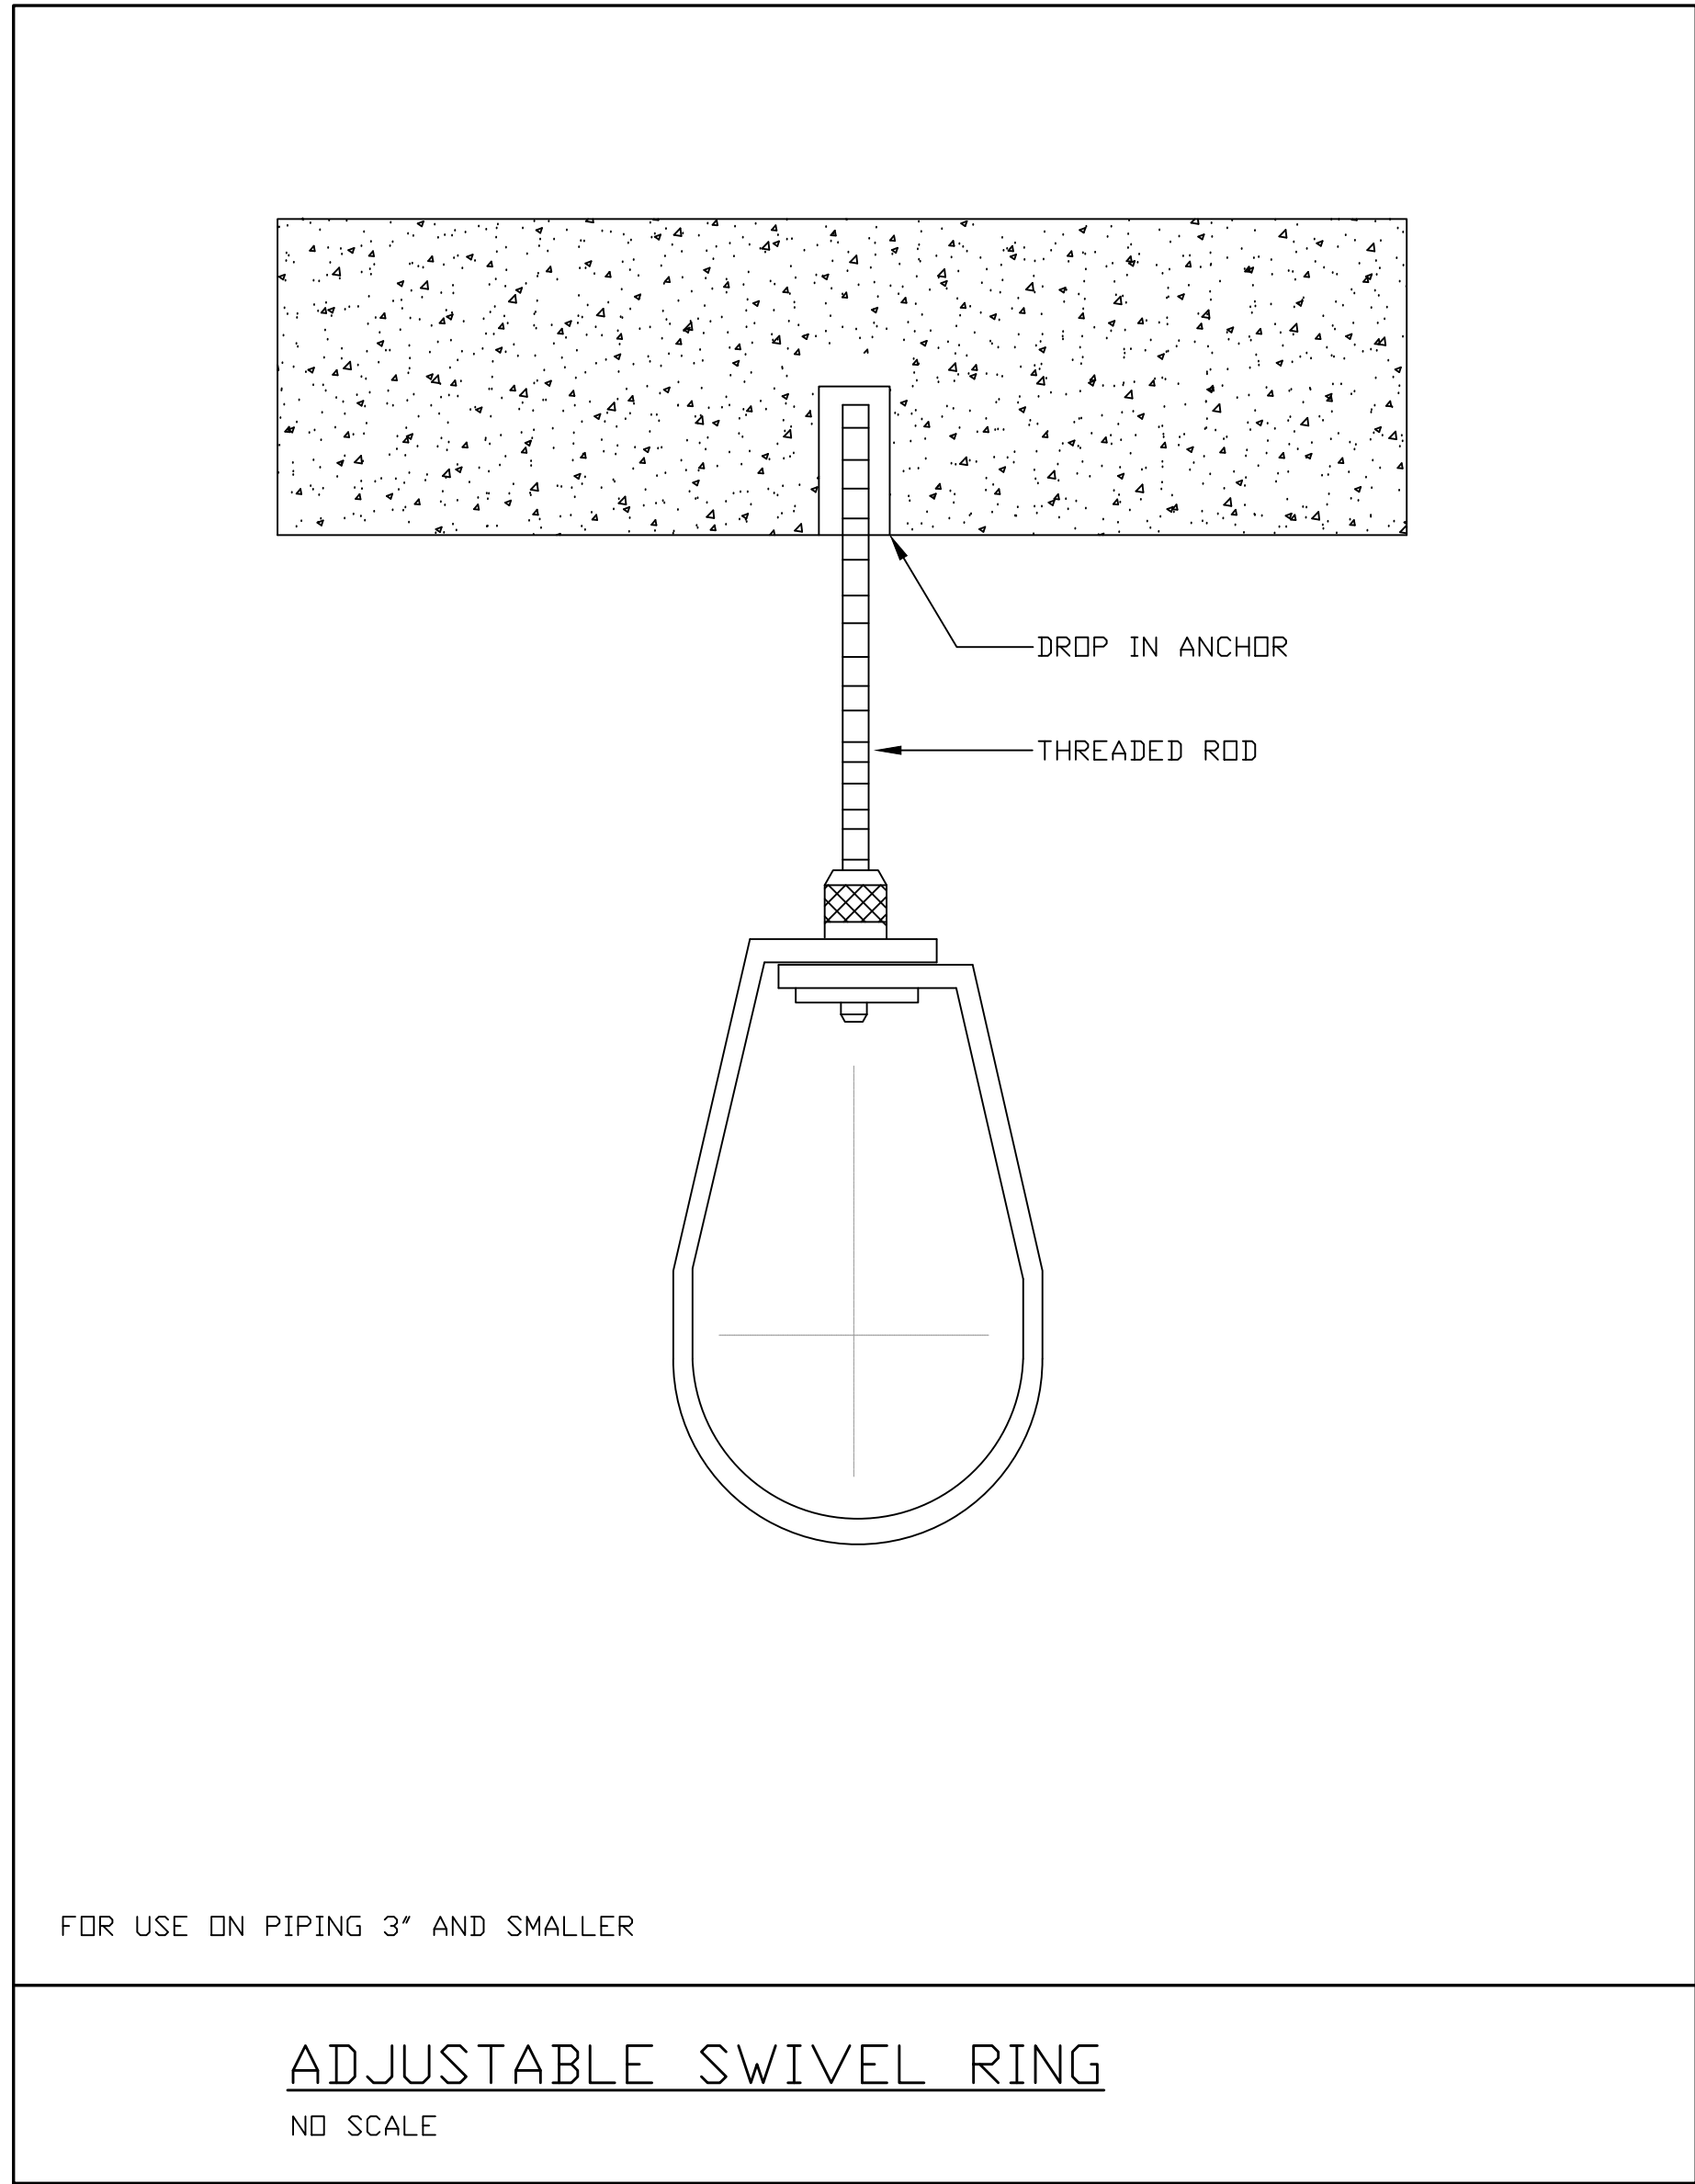

ITEM No.	Name	NOTES	ITEM No.	Name	NOTES
1	CONTROL VALVE WITH TAMPER SWITCH	175, 250, & 350 P.S.I. W.W.P. RATED VALVES, VALVE LOCATION AS PER FIRE PROTECTION RISER DIAGRAM.	9	(TESTMASTER) 1/2" TEST ORIFICE PLATE	
2	PRESSURE GAUGE WITH SHUTOFF COCK		10	SIGHT GLASS	
3	FIRE HOSE VALVE * (PROVIDE PRESSURE RESTRICTING DEVICE WHERE STATIC PRESSURE EXCEEDS 175 PSI.)		11	CHECK VALVE	
4	FEED MAIN				
5	WATERFLOW INDICATOR				
6	CAPPED OUTLET				
7	PIPE CLAMP				
8	GLOBE VALVE				

* 12	PRESSURE REGULATING VALVE (MODIFIED LESS WHEEL HANDLE WITH SECURED CAP — U.L., FM APPROVED TYPE) CLA-VAL OR ZURN OR APPROVED EQUAL
* 13	PRESSURE RELIEF VALVE (SET FOR 175 PSI MAX.) WITH FULL LINE SIZE DRAIN LINE
NOTES:	* PROVIDE WHEN SYSTEM PRESSURE EXCEEDS 175 PSI

COMBINED RISER WITH SPRINKLER VALVE RIG (FCVA)  
NO SCALE

TO THE BEST OF MY KNOWLEDGE, BELIEF AND PROFESSIONAL JUDGMENT, THESE PLANS AND SPECIFICATIONS ARE IN COMPLIANCE WITH THE 2020 ENERGY CONSERVATION CODE OF NYS

This plan is approved only for work indicated on the application specification sheet. All other matters shown are not to be relied upon, or to be considered as either being approved or in accordance with applicable codes.

Alterations or additions to this engineering document by an unlicensed person is a violation of Chapter 16, Title VIII, Article 145 § 7209.2 of the New York State Education Law.





777 Old Saw Mill River Road  
Tarrytown, NY 10591-6707  
T: 914.847.7400  
F: 914.847.7991  
www.regeneron.com

Building #17  
Campus Expansion Child  
Day-care Center

899 Old Saw Mill River Road  
Mount Pleasant, NY 10591

Project No. B17-DAYCARE

Architect

**Gensler**  
1700 Broadway, Suite 400  
New York, NY 10019  
(212) 492-1400 Phone  
(212) 492-1472 Fax

Structural Engineer

Thornton Tomasetti  
120 Broadway, 15th Floor  
New York, NY 10271  
(917) 661-7800 Phone  
(917) 661-7801 Fax

MEP / IT / Security Engineer

Cosentini Associates  
498 Seventh Avenue  
New York, NY 10018  
(212) 615-3600 Phone  
(212) 615-3700 Fax

Civil Engineer


JMC

120 Bedford Road  
Armonk, NY 10504  
(914) 273-5225 Phone  
(914) 273-2102 Fax


Landscape Architect

Langan

21 Penn Plaza, 360 West 31st Street, 8th Floor  
New York, NY 10001  
(212) 479-5400 Phone  
(212) 479-5444 Fax

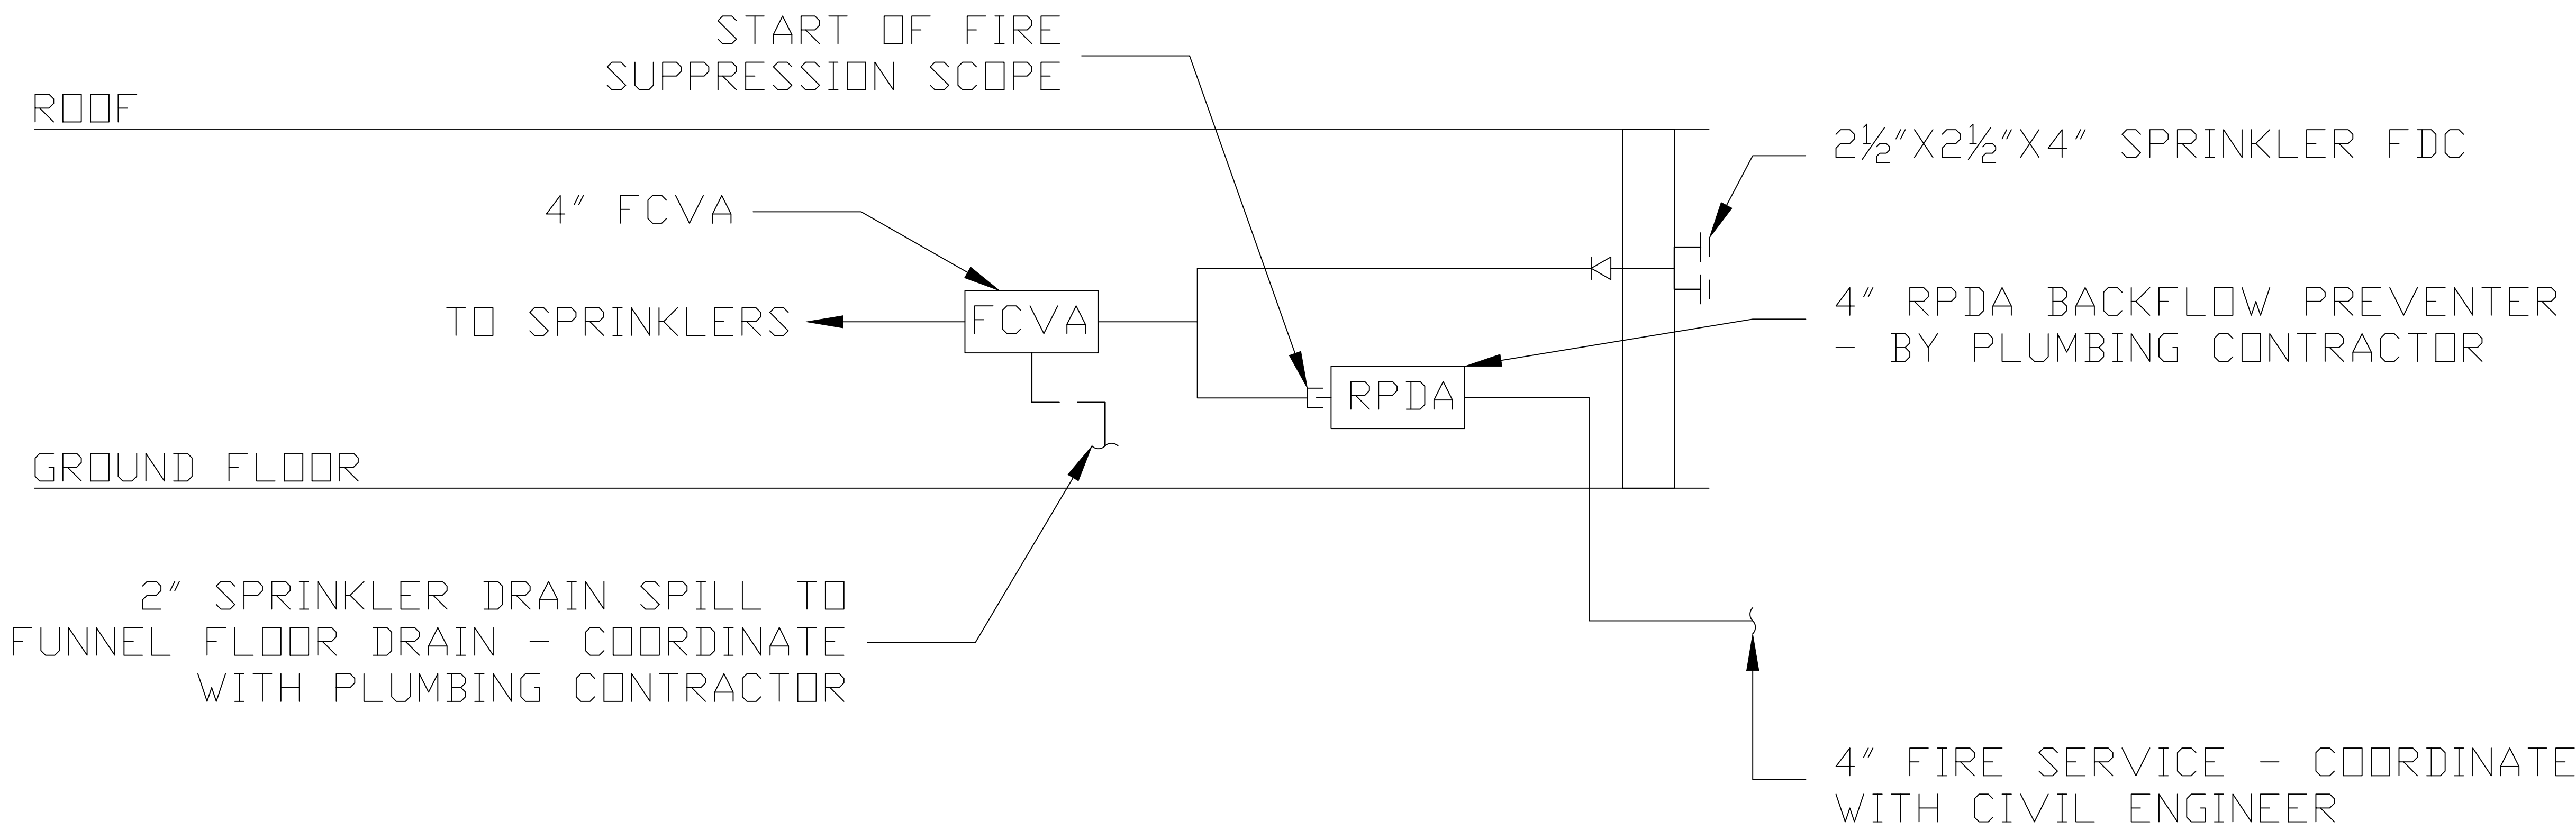

Key Plan

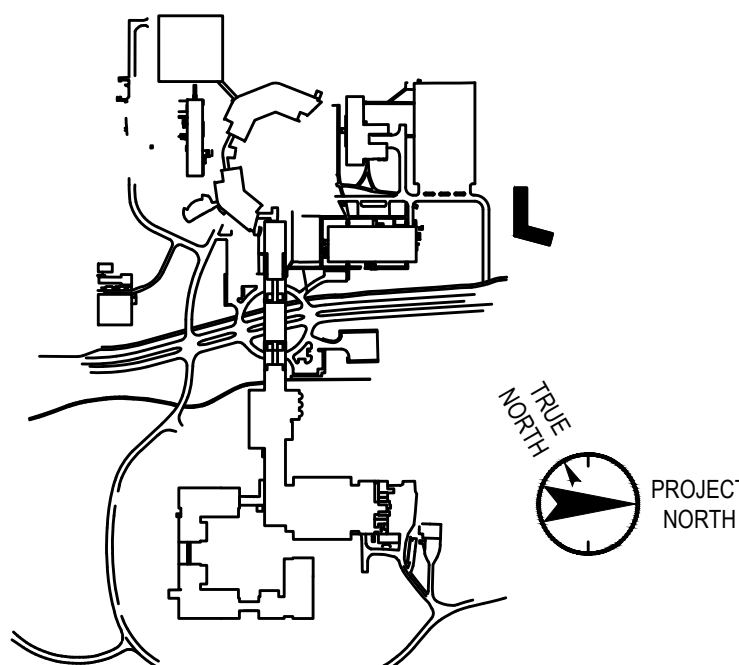

No.	Date	Description
0	05/20/2022	ISSUED FOR PERMIT
1	06/20/2022	100% CONSTRUCTION DOCUMENTS
2	07/01/2022	100% CONSTRUCTION DOCUMENTS-1

Plot Date: 07/01/2022

ALL DRAWINGS AND WRITTEN MATERIALS REPRESENTED ON THIS SHEET CONSTITUTE THE COPYRIGHTED WORK AND ARE THE SOLE PROPERTY OF REGENERON PHARMACEUTICALS. THIS SHEET MAY NOT BE REPRODUCED OR COPIED IN WHOLE OR IN PART, NOR MAY ANY OF THE DRAWINGS OR WRITTEN MATERIALS APPEARING HEREIN, BE REPRODUCED INTO ANOTHER WORK FOR ANY REASON WITHOUT THE WRITTEN CONSENT OF REGENERON PHARMACEUTICALS. THIS SHEET MUST BE RETURNED TO THE REQUESTOR BY REGENERON PHARMACEUTICALS. IF REGENERON MAKES OR AUTHORIZES REUSE OF ANY SUCH DOCUMENT OR INFORMATION PROVIDED BY DESIGN PROFESSIONAL OUTSIDE OF THE PROJECT WITHOUT THE EXPRESS WRITTEN CONSENT OF DESIGN PROFESSIONAL, REGENERON ASSUMES FULL RESPONSIBILITY FOR ANY AND ALL ISSUES RESULTING IN SUCH REUSE.

Professional Seal and Signature

Vendor Name: COSENTINI  
Vendor Project No.: 210104  
Discipline: Fire Suppression Drawn By: DH  
**FIRE SUPPRESSION  
RISER DIAGRAM**

Scale: NTS Floor: N/A

FX-700

TO THE BEST OF MY KNOWLEDGE, BELIEF AND PROFESSIONAL JUDGMENT, THESE PLANS AND SPECIFICATIONS ARE IN COMPLIANCE WITH THE 2020 ENERGY CONSERVATION CODE OF NYS

This plan is approved only for work indicated on the application specification sheet. All other matters shown are not to be relied upon, or to be considered as either being approved or in accordance with applicable codes.

Alterations or additions to this engineering document by an unlicensed person is a violation of Chapter 16, Title VIII, Article 145 § 7209.2 of the New York State Education Law.