



1 PARTIAL ELECTRICAL RISER (DANCE INSTRUCTIONAL FACILITIES)  
E-501.00 SCALE: NTS

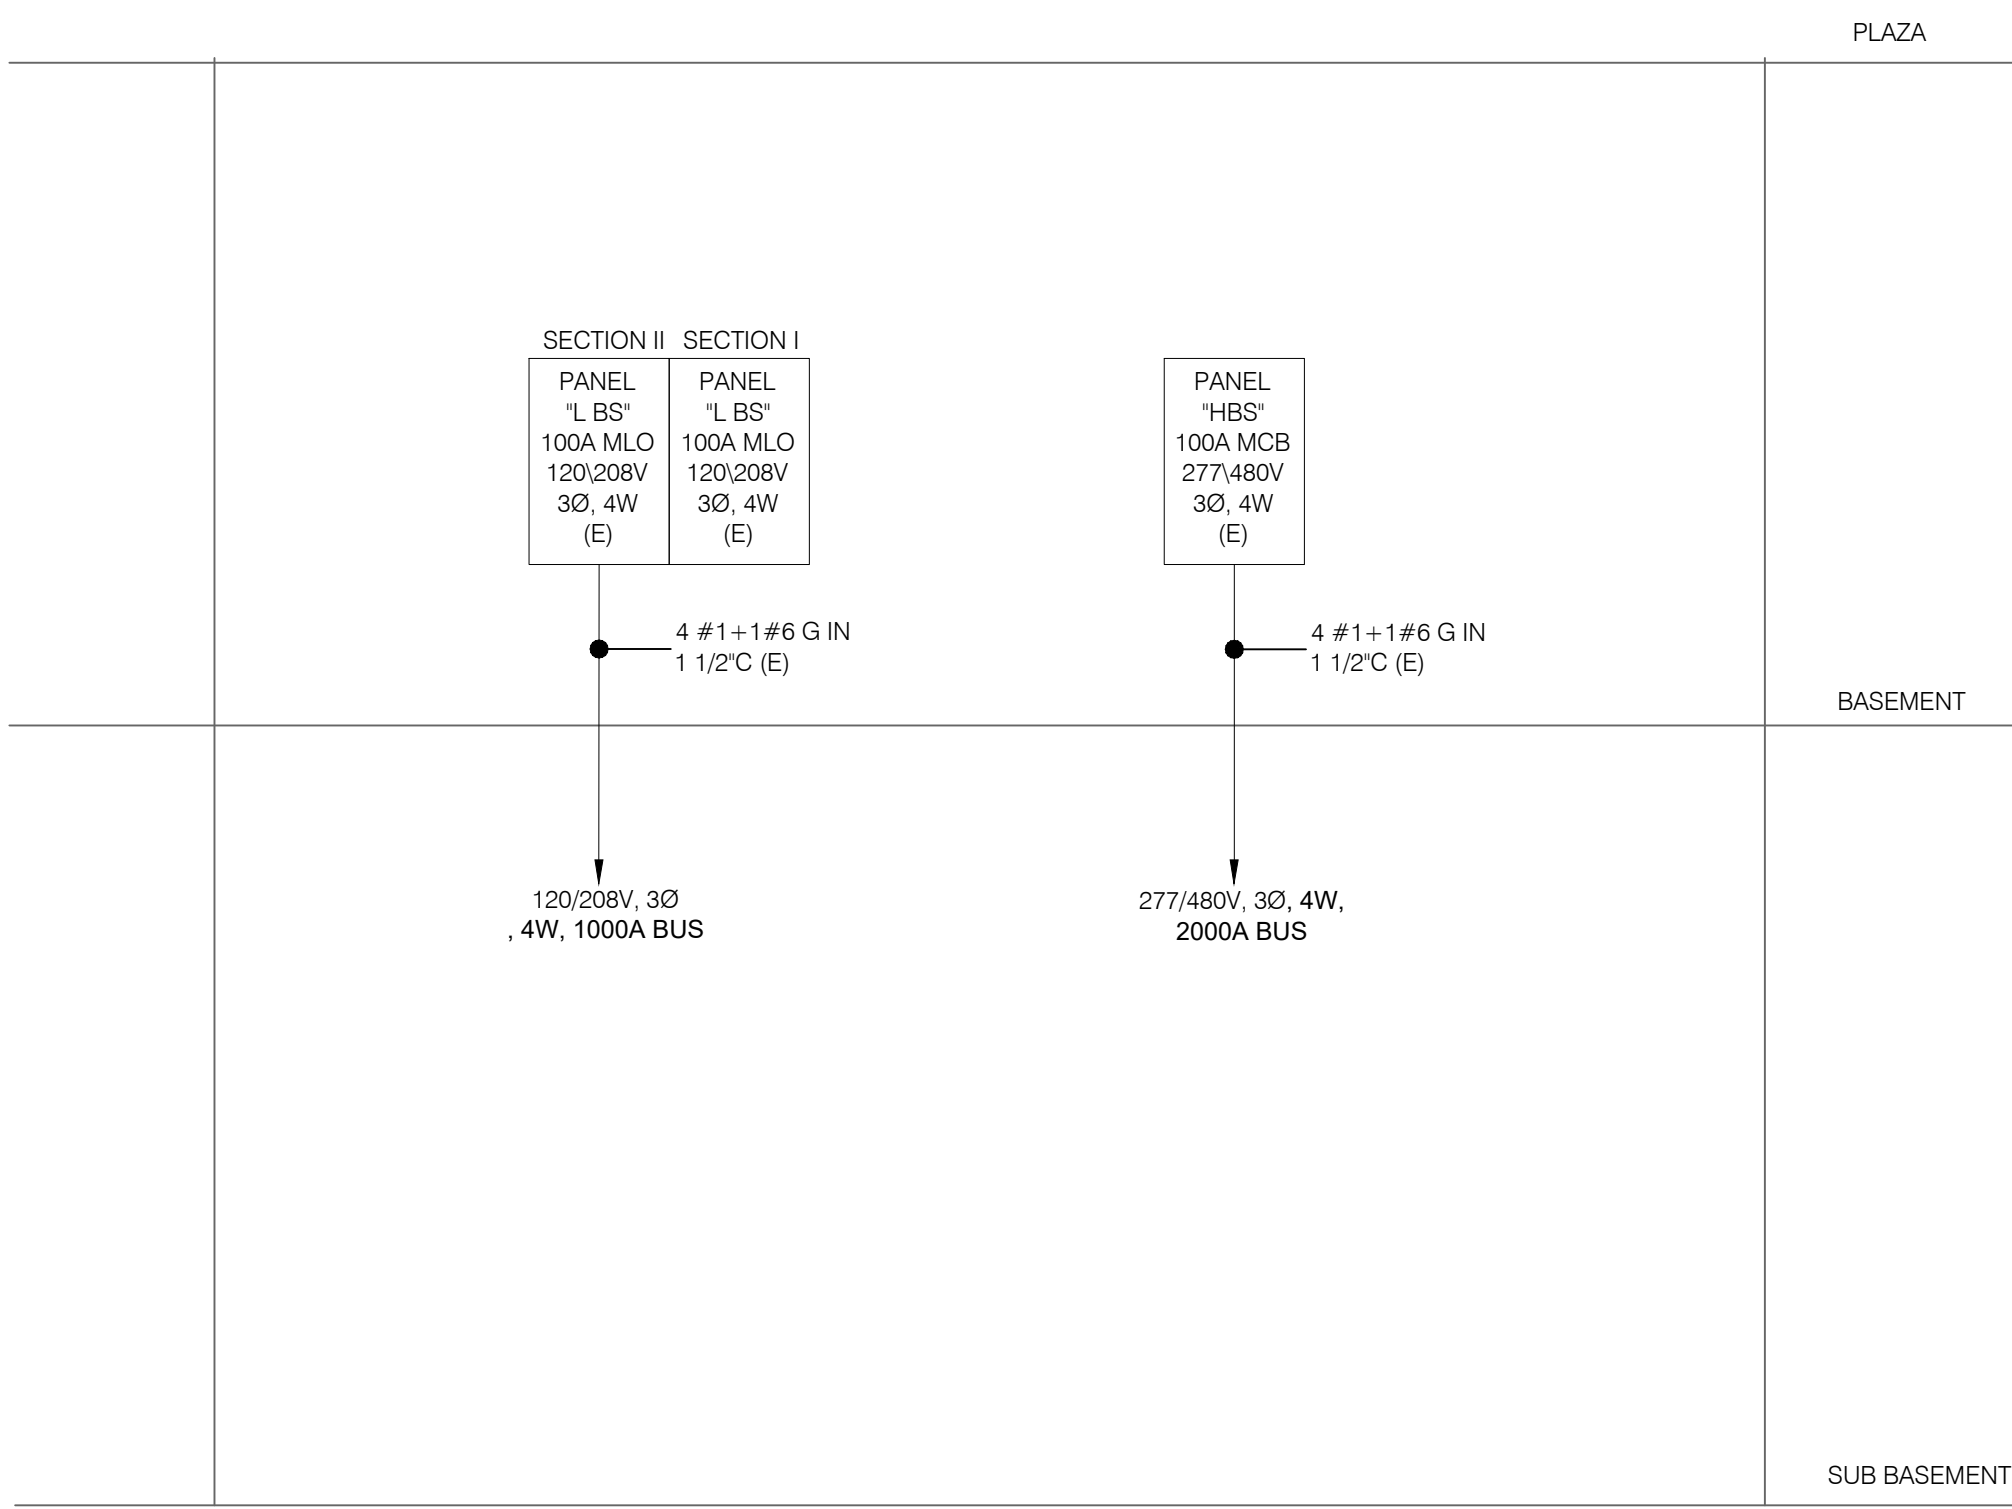

2 PARTIAL ELECTRICAL RISER (MUSICAL INSTRUCTIONAL FACILITIES)  
E-501.00 SCALE: NTS

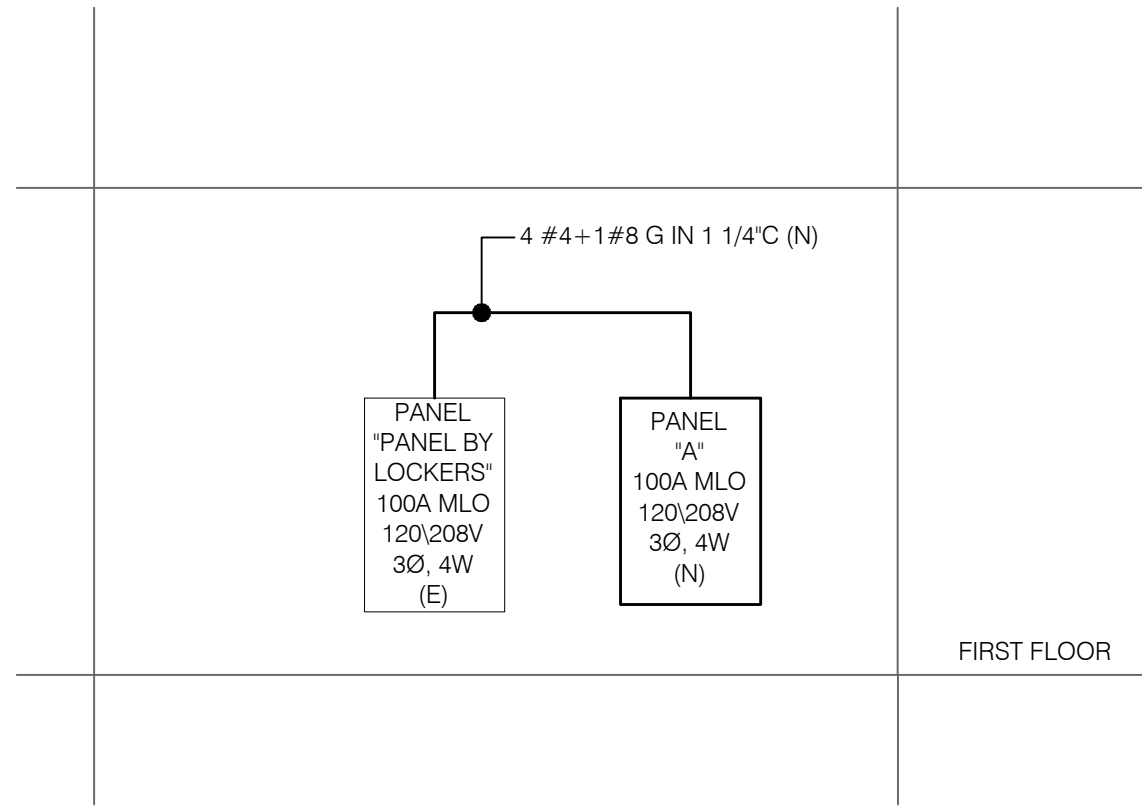

3 PARTIAL ELECTRICAL RISER (PHYSICAL EDUCATION )  
E-501.00 SCALE: NTS

GENERAL NOTES

1. UNLESS OTHERWISE NOTED, ALL ELECTRICAL EQUIPMENT, PANELS AND FEEDERS ARE EXISTING TO REMAIN AND SHOWN FOR REFERENCE ONLY.

RESTROOM RENOVATION  
PURCHASE COLLEGE  
STATE UNIVERSITY OF NEW YORK

735 Anderson Hill Rd.  
Purchase, NY 10577

PHASE 2:  
MUSIC BUILDING  
DANCE BUILDING  
PHYS. ED. BUILDING  
LIBRARY

Conditions

ALL IDEAS, DESIGNS, ARRANGEMENTS AND PLANS INDICATED OR REPRESENTED BY THIS DRAWING ARE OWNED BY, AND THE PROPERTY OF RONNETTE RILEY ARCHITECT AND WERE CREATED, PROVIDED AND DEVELOPED FOR THE USE OF, AND IN CONNECTION WITH THE NONE OF SUCH IDEAS, DESIGNS, ARRANGEMENTS OR PLANS SHALL BE USED BY OR DISCLOSED TO ANY PERSON, FIRM OR CORPORATION FOR ANY PURPOSE WHATSOEVER WITHOUT THE WRITTEN PERMISSION OF RONNETTE RILEY ARCHITECT.

© Copyright Ronnette Riley Architect 2020

Ronnette Riley *Architect*

494 Eighth Avenue, 15th Floor  
New York, NY 10001  
T 212 594 4015  
F 212 594 2868  
www.ronnetteriley.com

MEP Engineer

SETTY & Associates, Ltd  
149 W 36th Street, 8th floor  
New York, NY 10018  
T 646 253 9000  
F 646 224 8497

Rev	Date	Issue
	05 May 2022	Issue for Bid



Title **ELECTRICAL RISER  
DIAGRAMS**

Date	01-16-2020
Project No.	1944
Drawing By	
CHK By	
Scale	AS NOTED
DOB Rev	
<b>E-501.00</b>	