


1
FP060
BASEMENT LEVEL PLAN - FIRE PROTECTION REMOVALS
SCALE: 1/4" = 1'-0"

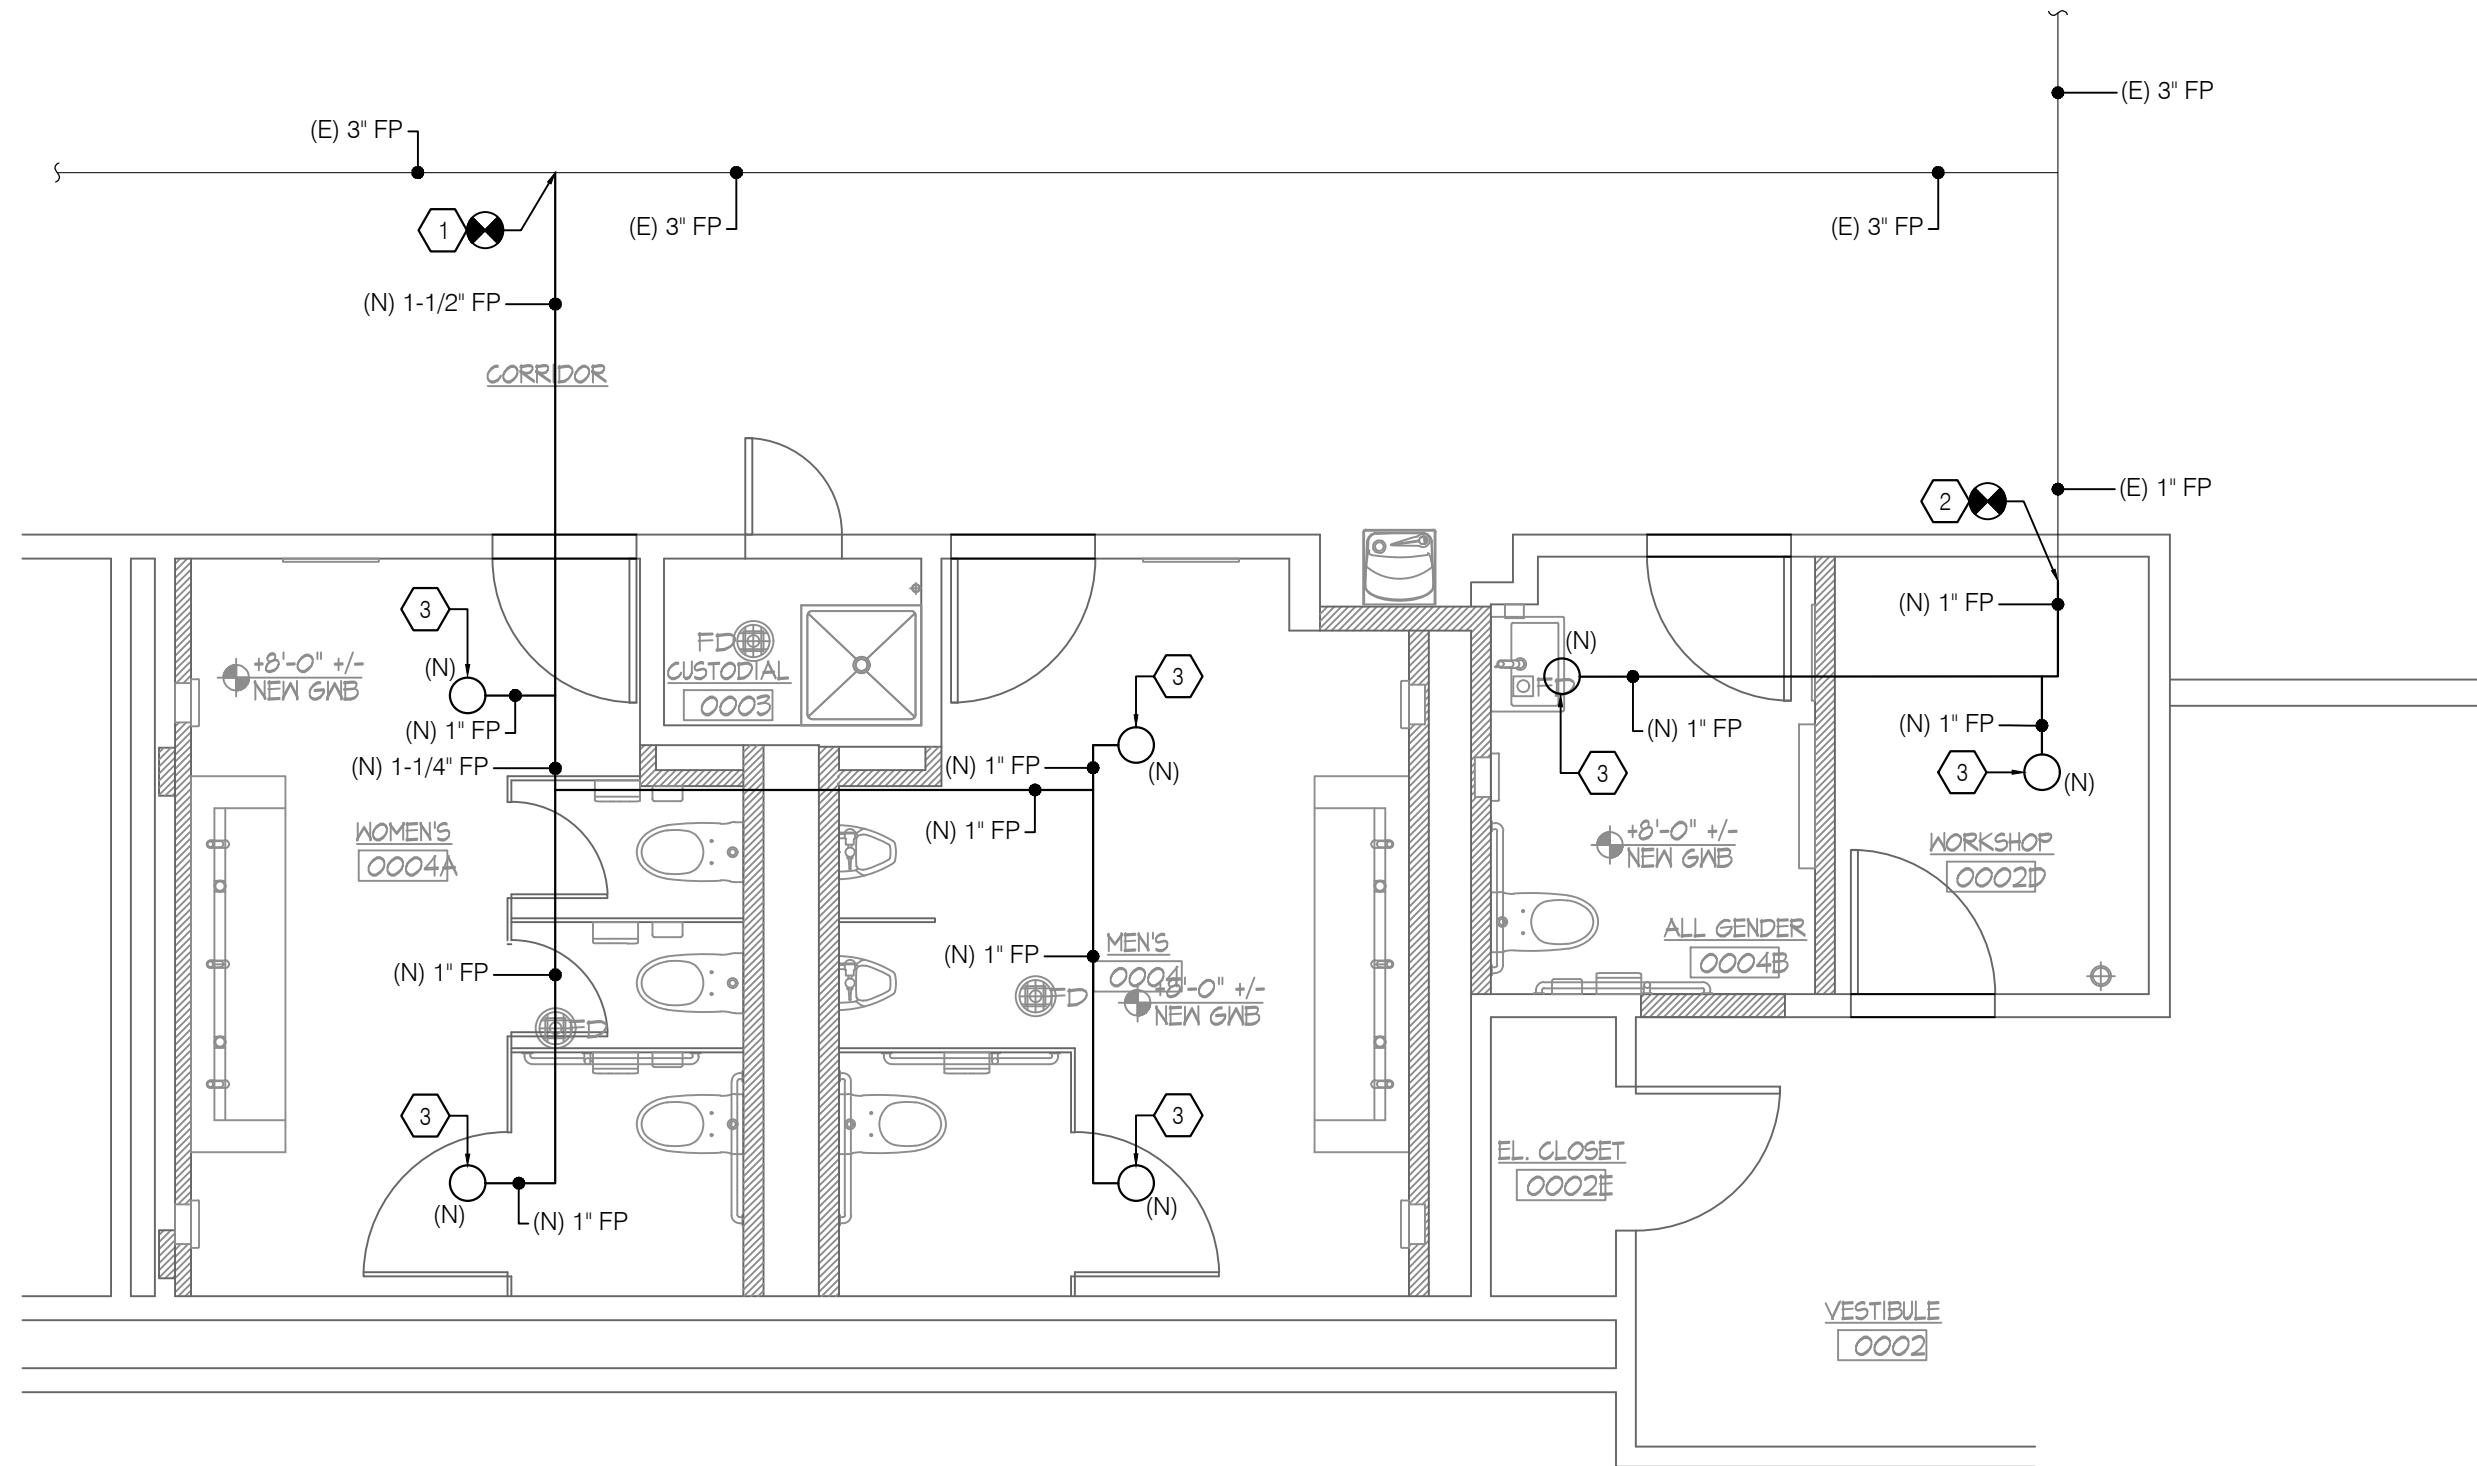

2
F-101.00
BASEMENT LEVEL PLAN - FIRE PROTECTION NEW WORK
SCALE: 1/4" = 1'-0"

DEMOLITION KEY NOTES

1.

CUT AND CAP EXISTING 1" FP PIPE AT THIS LOCATION.

2.

REMOVE EXISTING SPRINKLER HEAD.

3.

NO EXISTING SPRINKLER IN THIS AREA.

SHEET KEY NOTES

1.

CONNECT NEW 1-1/2" SPRINKLER PIPE TO EXISTING 3" SPRINKLER PIPE.

2.

CONNECT NEW 1" SPRINKLER PIPE TO EXISTING 1" SPRINKLER PIPE.

3.

CONCEALED SPRINKLER HEAD.

SPRINKLER LEGEND								
SYMBOL	MODEL	K FACTOR	TYPE	ORFICE	RESPONSE	FINISH	TEMP.	QTY.
	VICTAULIC V3801	5.6	CONCEALED	1/2"	QUICK	BRASS	155° F	6

RESTROOM RENOVATION
PURCHASE COLLEGE

STATE UNIVERSITY OF NEW YORK

735 Anderson Hill Rd.
Purchase, NY 10577

PHASE 2:
MUSIC BUILDING
DANCE BUILDING
PHYS. ED. BUILDING
LIBRARY

Conditions

ALL IDEAS, DESIGNS, ARRANGEMENTS AND PLANS INDICATED OR REPRESENTED BY THIS DRAWING ARE OWNED BY, AND THE PROPERTY OF, RONNETTE RILEY ARCHITECT AND WERE CREATED, DEVELOPED AND DEVELOPED FOR THE USE OF, AND IN CONNECTION WITH THE NONE OF SUCH IDEAS, DESIGNS, ARRANGEMENTS OR PLANS SHALL BE USED BY OR DISCLOSED TO ANY PERSON, FIRM OR CORPORATION FOR ANY PURPOSE WHATSOEVER WITHOUT THE WRITTEN PERMISSION OF RONNETTE RILEY ARCHITECT.

© Copyright Ronnette Riley Architect 2020


Ronnette Riley Architect

494 Eighth Avenue, 15th Floor
New York, NY 10001
T 212 594 4015
F 212 594 2868
www.ronnetteriley.com

MEP Engineer

SETTY & Associates, Ltd
149 W 36th Street, 8th floor
New York, NY 10018
T 646 253 9000
F 646 224 8497

Rev	Date	Issue
05 May 2022	Issue for Bid	

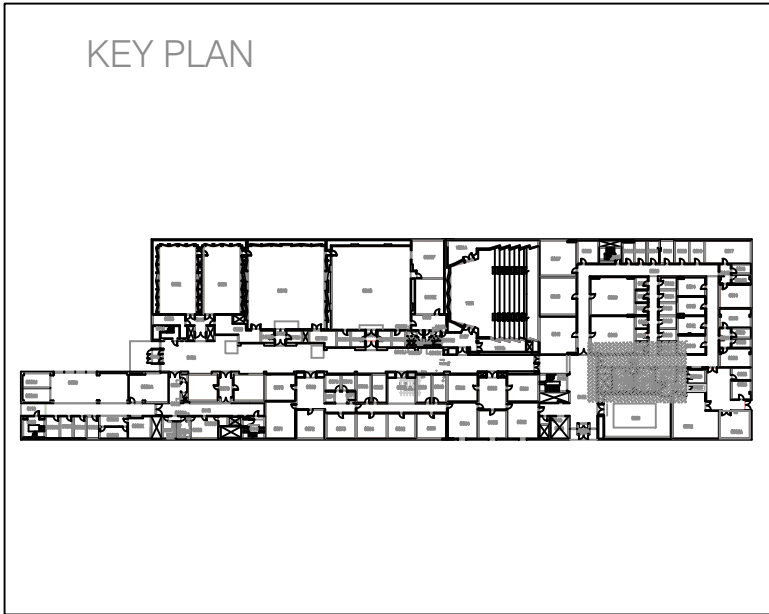

Title

MUSIC BUILDING - FIRE PROTECTION PLANS

Date	01-16-2020
Project No.	1944
Drawing By	CHS
CHK By	KB
Scale	AS NOTED
DOB Rev	
F-101.00	