


3

CONCEALED SPRINKLER DETAIL

F-701.00

SCALE: NOT TO SCALE

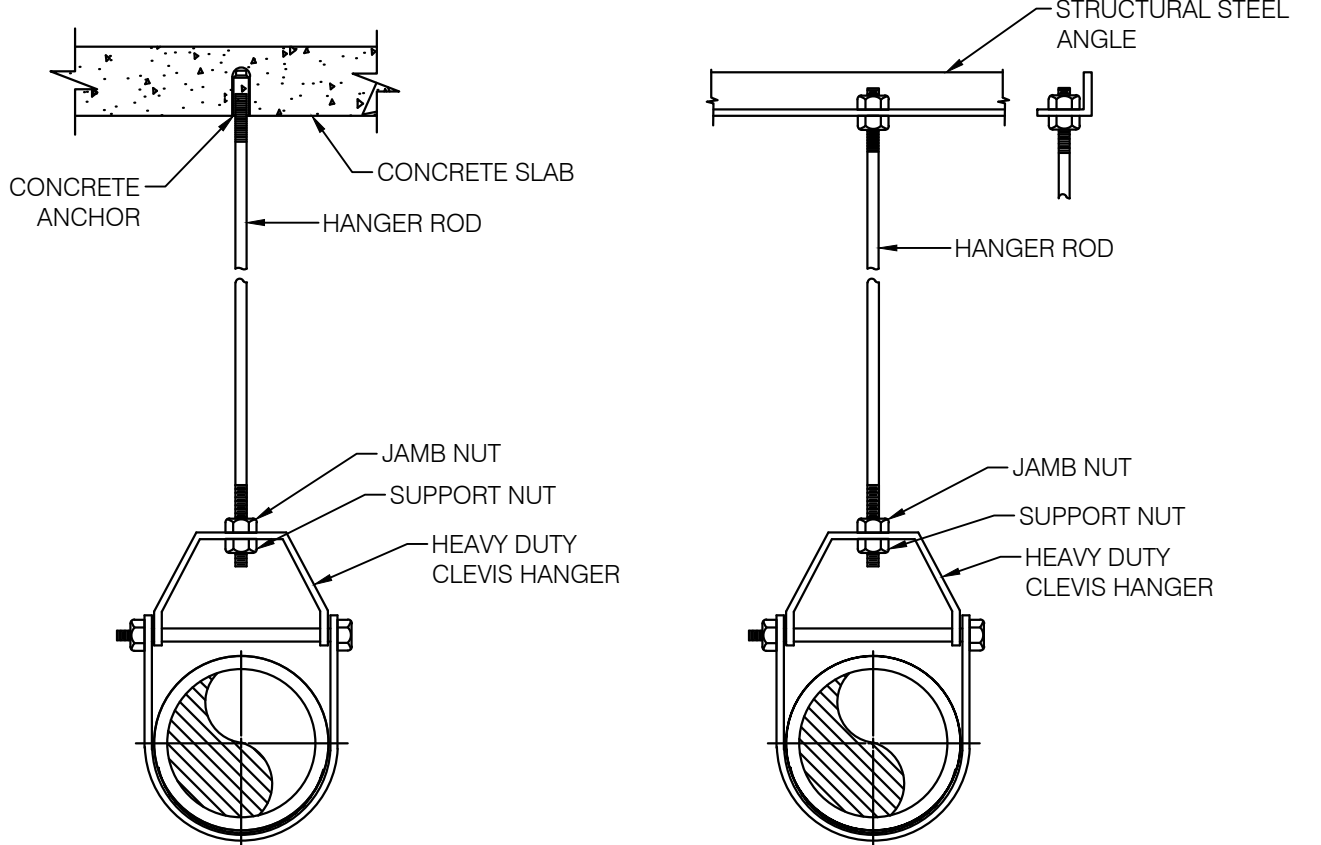

MAXIMUM DISTANCE BETWEEN HANGERS (FEET - INCHES)											
NOMINAL PIPE SIZE (IN INCHES)											
	1	1 1/4	1 1/2	2	2 1/2	3	3 1/2	4	5	6	8
STEEL PIPE EXCEPT THREADED LIGHT WALL	12 - 0	12 - 0	15 - 0	15 - 0	15 - 0	15 - 0	15 - 0	15 - 0	15 - 0	15 - 0	15 - 0
THREADED LIGHTWALL STEEL PIPE	12 - 0	12 - 0	12 - 0	12 - 0	12 - 0	12 - 0	N/A	N/A	N/A	N/A	N/A


2

PIPE SUPPORT DETAIL

F-701.00

SCALE: NOT TO SCALE

NOTE:
1. PIPING SLEEVE IS TO BE SCHEDULE 40 STEEL PIPING.

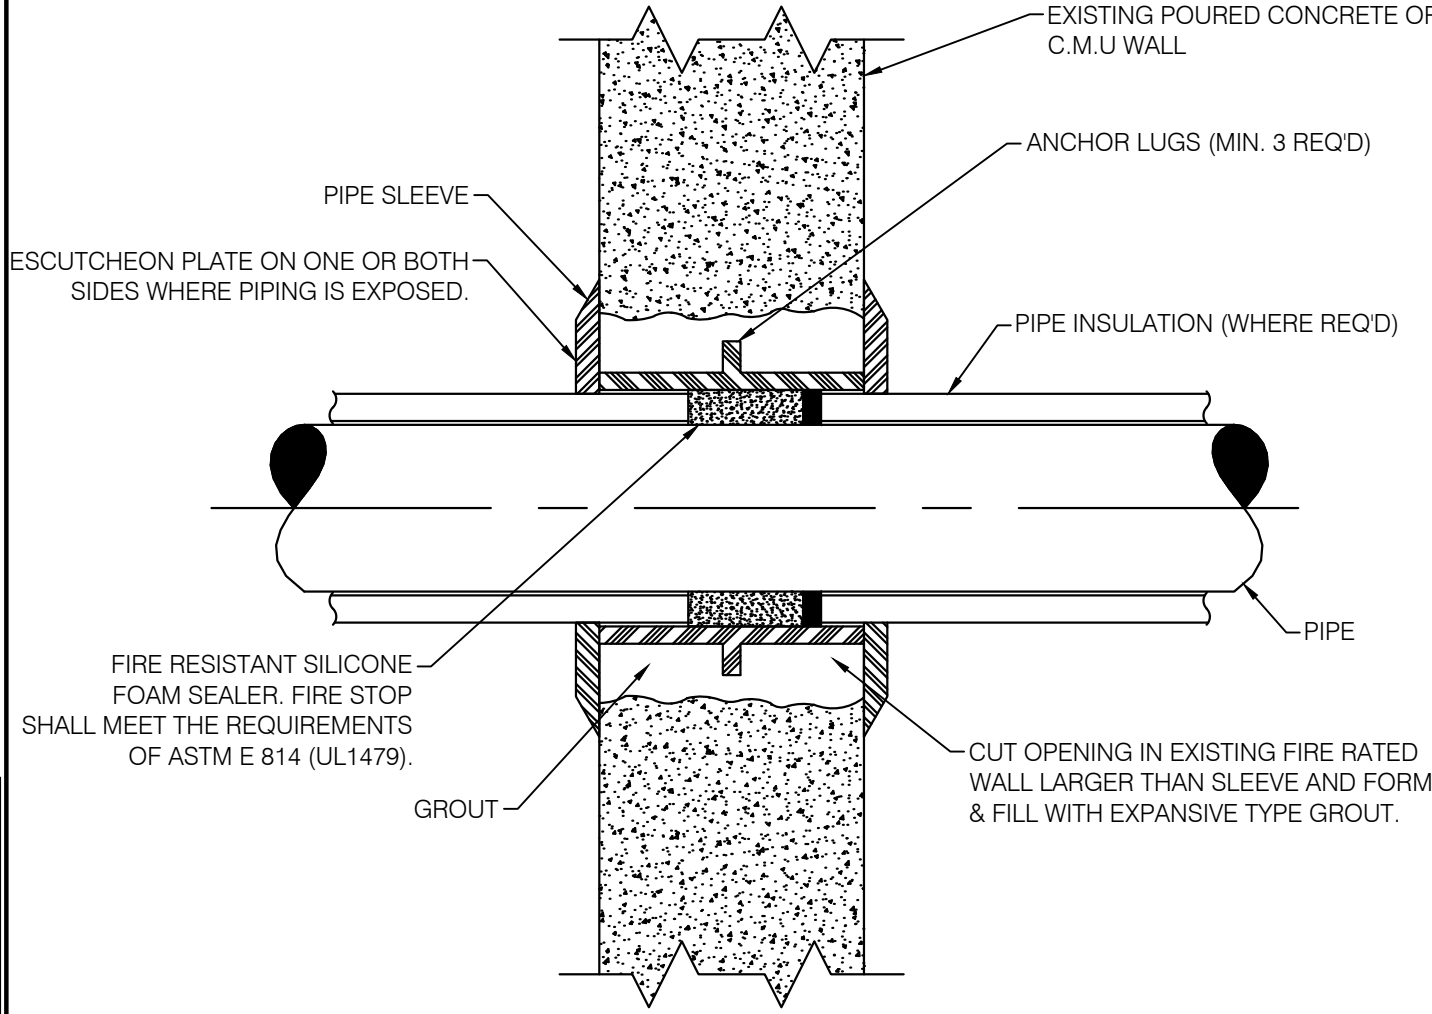

1

PIPE PENETRATION THROUGH FIRE RATED WALL

F-701.00

SCALE: NOT TO SCALE

RESTROOM RENOVATION

PURCHASE COLLEGE

STATE UNIVERSITY OF NEW YORK

735 Anderson Hill Rd.

Purchase, NY 10577

PHASE 2:

MUSIC BUILDING

DANCE BUILDING

PHYS. ED. BUILDING

LIBRARY

Conditions

ALL IDEAS, DESIGNS, ARRANGEMENTS AND PLANS INDICATED OR REPRESENTED BY THIS DRAWING ARE OWNED BY, AND THE PROPERTY OF RONNETTE RILEY ARCHITECT AND WERE CREATED, DEVELOPED AND DEVELOPED FOR THE USE OF, AND IN CONNECTION WITH THE PROJECT. NONE OF SUCH IDEAS, DESIGNS, ARRANGEMENTS OR PLANS SHALL BE USED BY OR DISCLOSED TO ANY PERSON, FIRM OR CORPORATION FOR ANY PURPOSE WHATSOEVER WITHOUT THE WRITTEN PERMISSION OF RONNETTE RILEY ARCHITECT.

© Copyright Ronnette Riley Architect 2020

Ronnette Riley Architect

494 Eighth Avenue, 15th Floor
New York, NY 10001
T 212 594 4015
F 212 594 2868
www.ronnetteriley.com

MEP Engineer

SETTY & Associates, Ltd
149 W 36th Street, 8th floor
New York, NY 10018
T 646 253 9000
F 646 224 8497

Rev

Date

Issue

05 May 2022

Issue for Bid

Title

FIRE PROTECTION DETAILS

Date

01-16-2020

Project No.

1944

Drawing By

CHS

CHK By

KB

Scale

AS NOTED

DOB Rev

F-701.00