



KEY MAP
SCALE: 1" = 1,500'

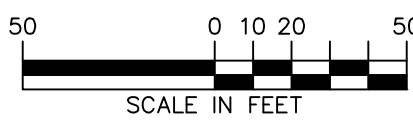

03/06/2023	REVISED BUILDING B STORM ROOF LEADERS	8
02/10/2023	REV. NEW LOT LINE, SITE GRADING & STORM	7
12/30/2022	REV. BUILDING A UTILITIES	6
12/16/2022	REV. PER WATERSHED INSPECTOR GENERAL COMMENTS	5
Date	Description	No.
Revisions		

WARNING: IT IS A VIOLATION OF THE NYS EDUCATION LAW ARTICLE 149 FOR ANY PERSON, UNLESS HE IS ACTING UNDER THE DIRECTION OF A LICENSED PROFESSIONAL ENGINEER, LAND SURVEYOR OR GEOLOGIST, TO ALTER THIS ITEM IN ANY WAY.

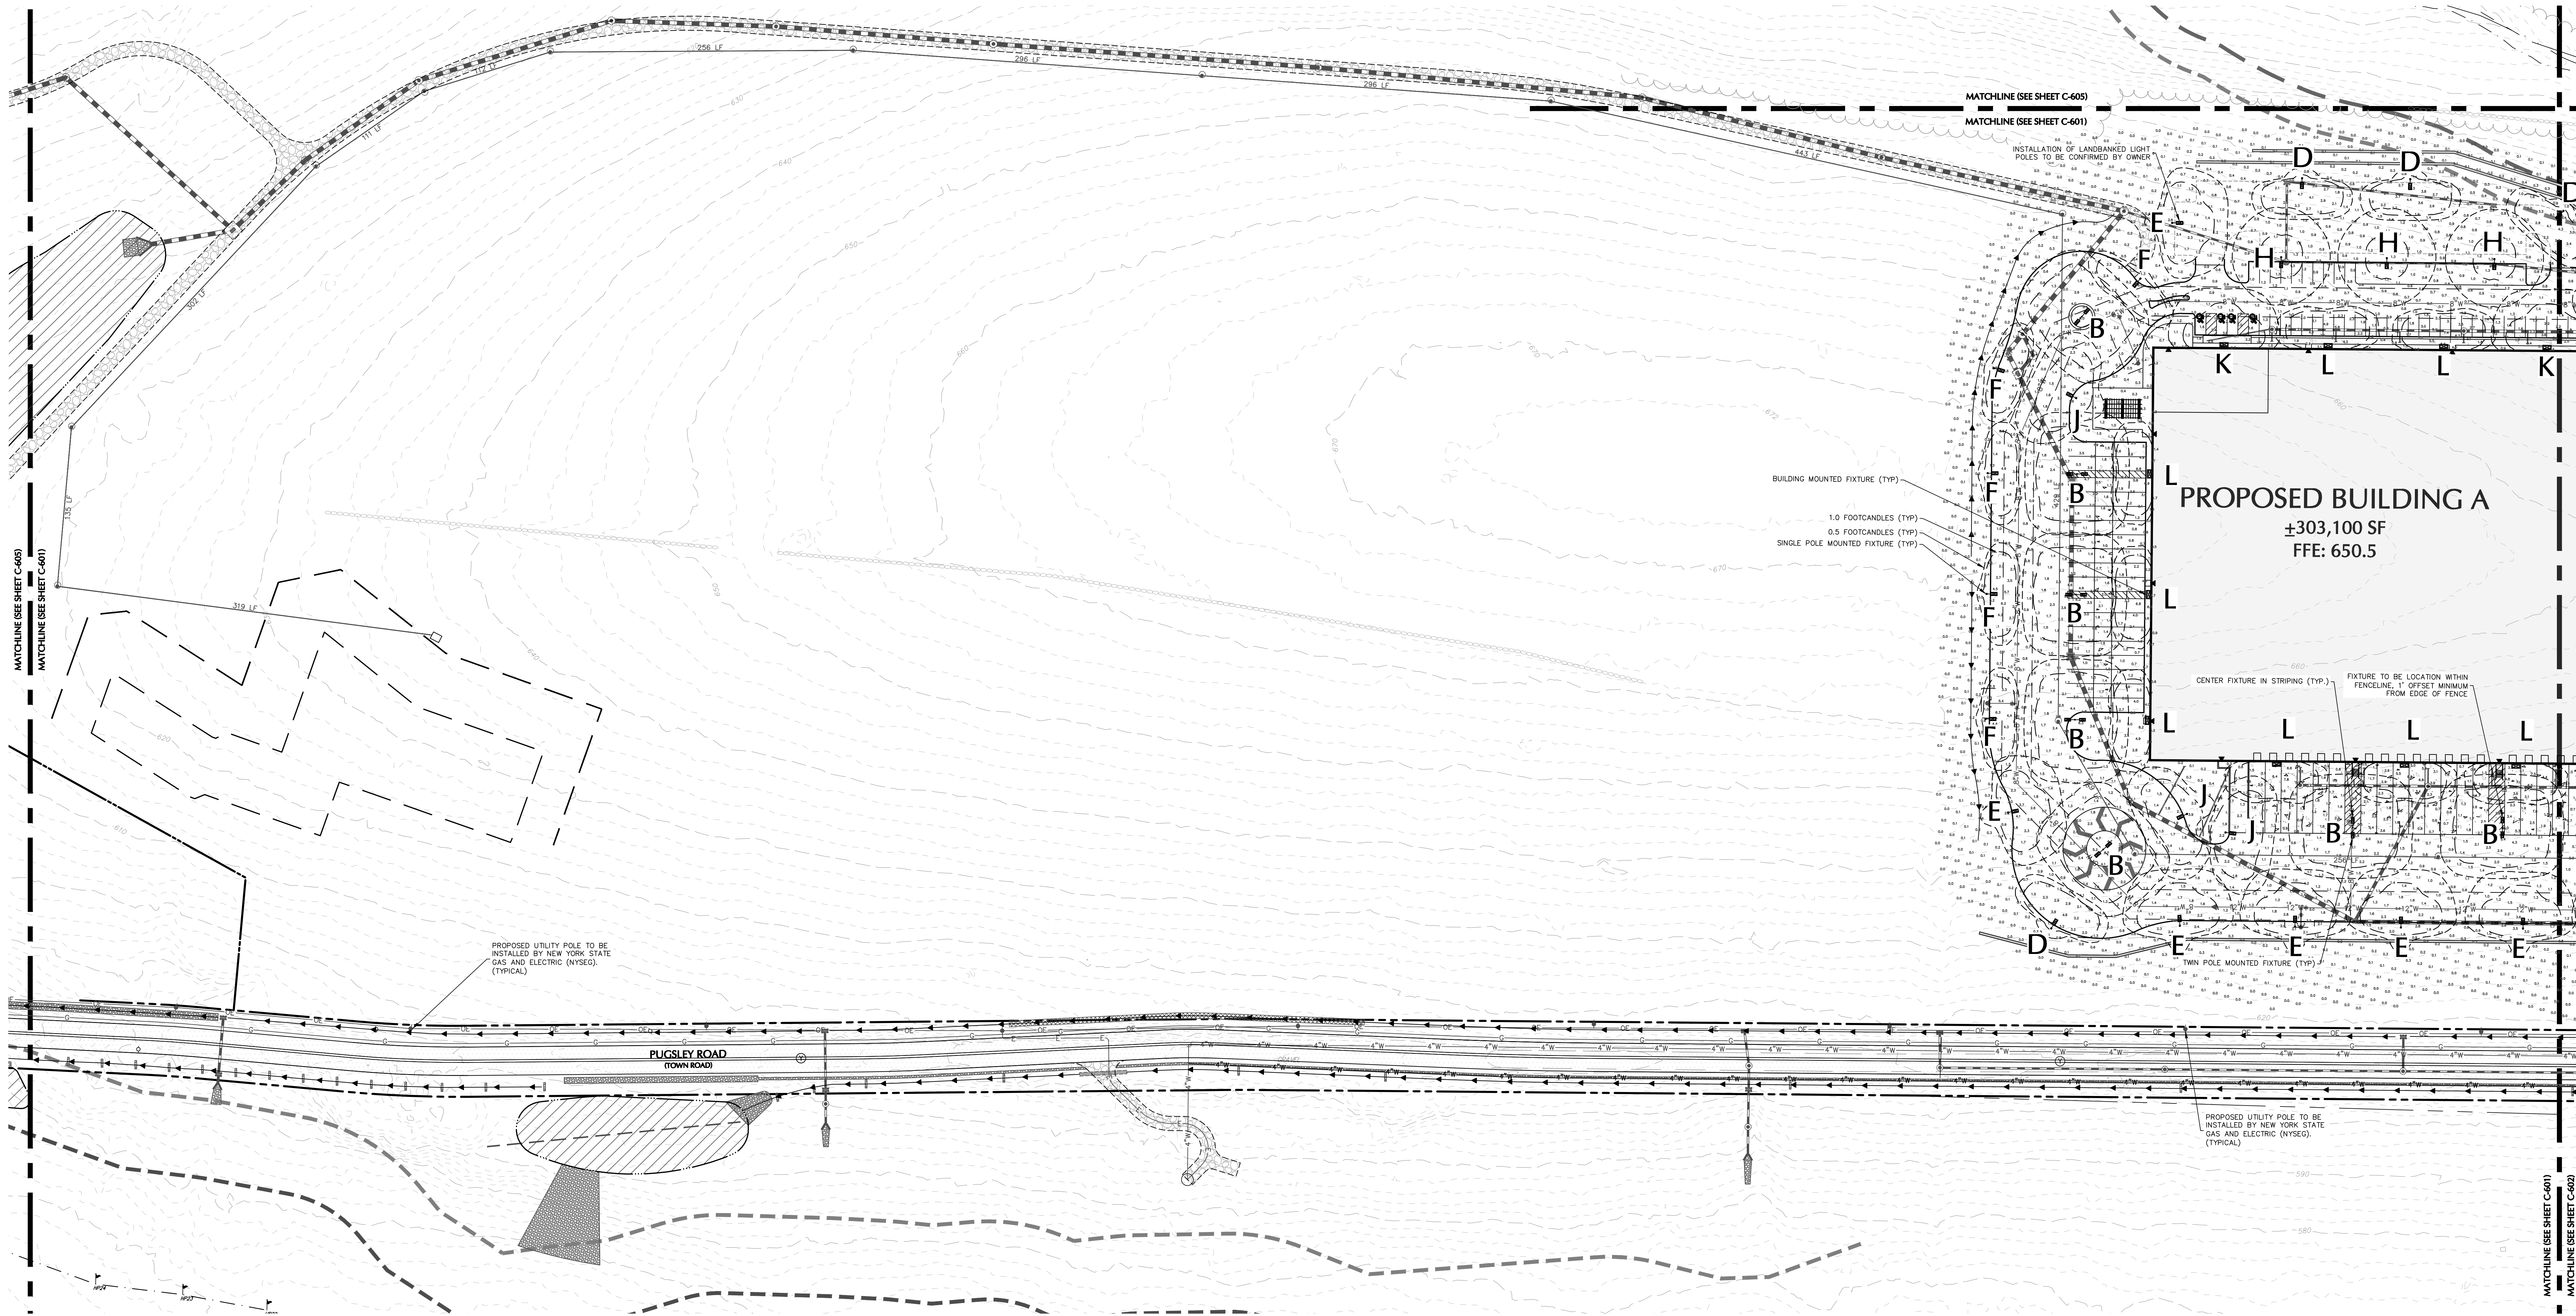

LANGAN
Langan Engineering, Environmental, Surveying,
Landscape Architecture, and Geology, D.P.C.
One North Broadway, Suite 910
White Plains, NY 10601
T: 914.323.7400 F: 914.323.7401 www.langan.com

Project
**LINCOLN LOGISTICS
BREWSTER**
TOWN OF SOUTHEAST
PUTNAM COUNTY NEW YORK

Drawing Title
LIGHTING PLAN A

Project No.
190065201
Date
1/28/2022
Drawn By
MJ
Checked By
MH

Drawing No.
C-601
Sheet **62** of **96**