


KEY MAP
SCALE: 1" = 1,500'

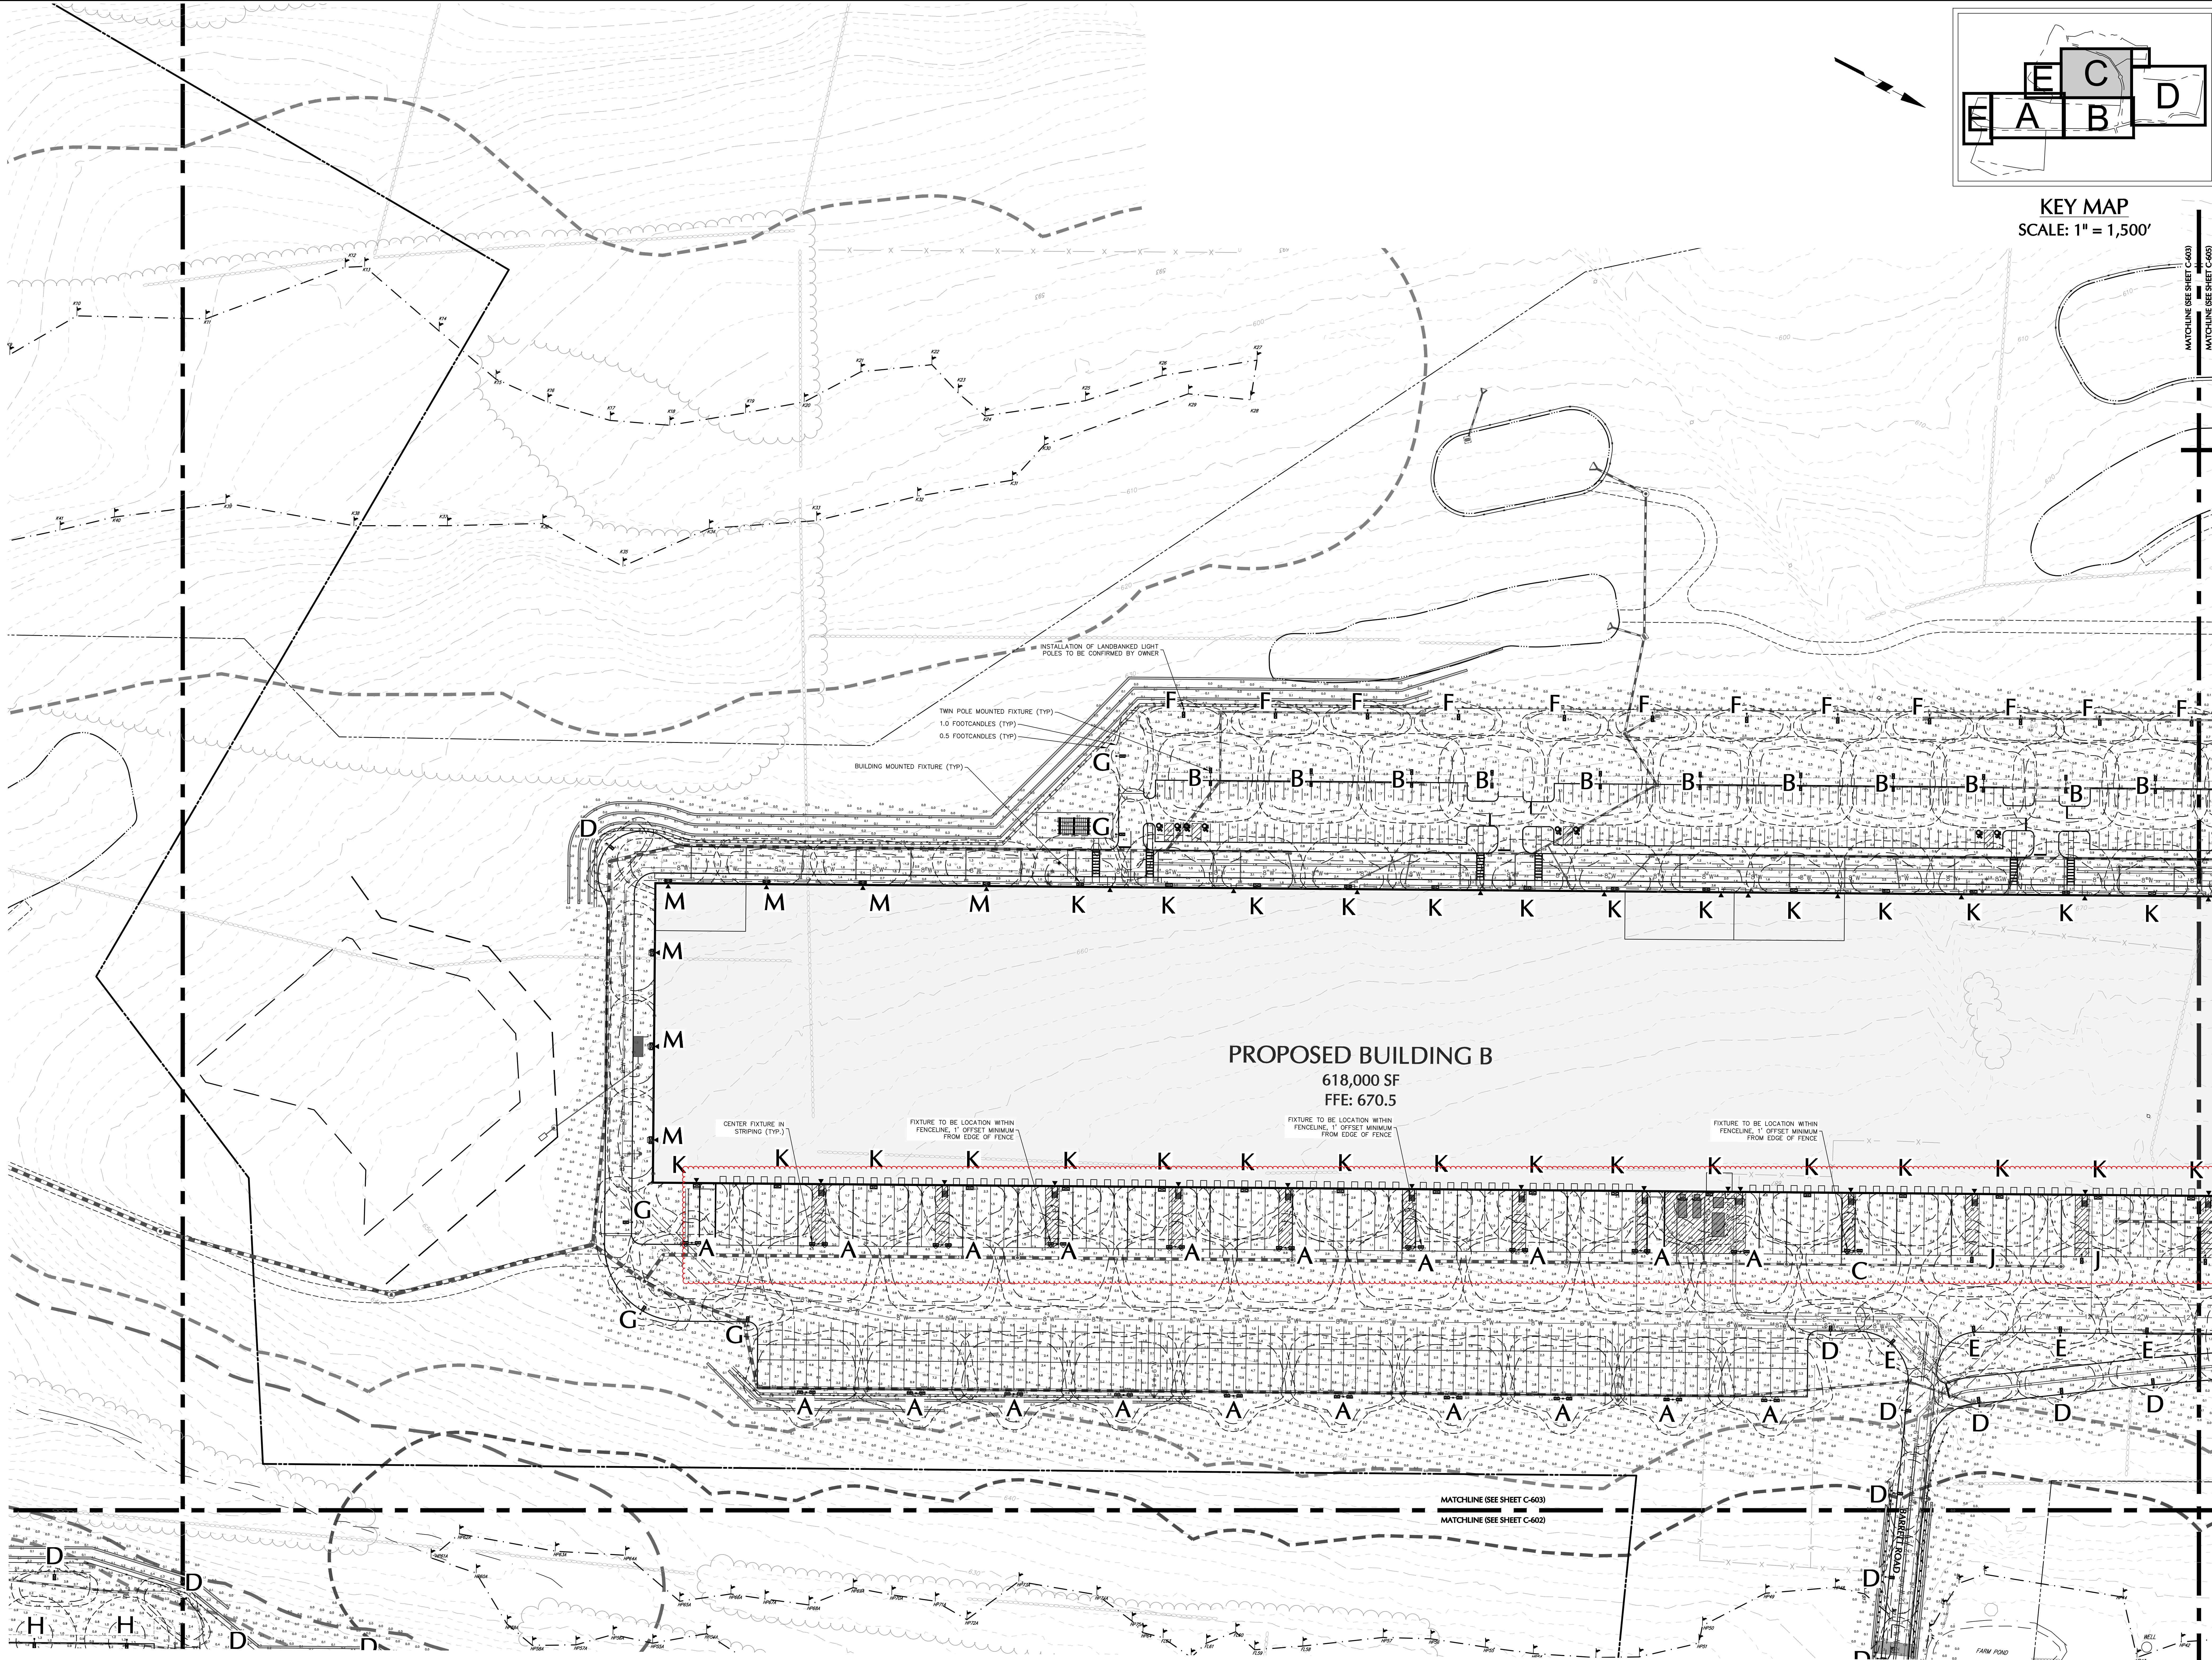

| Revisions | | | Revisions | | |
|------------|---------------------------------------|-----|------------|---|-----|
| Date | Description | No. | Date | Description | No. |
| 03/06/2023 | REVISED BUILDING B STORM ROOF LEADERS | 8 | 05/25/2023 | REV. NEW LOT LINE, SITE GRADING & STORM | 7 |
| 02/10/2023 | REV. BUILDING A UTILITIES | 6 | 12/30/2022 | REV. PER WATERSHED INSPECTOR GENERAL COMMENTS | 5 |
| 12/30/2022 | | | | | |

WARNING: IT IS A VIOLATION OF THE NYS EDUCATION LAW ARTICLE 149 FOR ANY PERSON, UNLESS HE IS ACTING UNDER THE DIRECTION OF A LICENSED PROFESSIONAL ENGINEER, LAND SURVEYOR OR GEOLOGIST, TO ALTER THIS ITEM IN ANY WAY.

Signature: [Signature]
Date: 05/25/2023
Title: [Title]
Professional Seal: [Seal]
Landscape Architect, R.L.A.
No. 001901

LANGAN
Langan Engineering, Environmental, Surveying,
Landscape Architecture, and Geology, D.P.C.
One North Broadway, Suite 910
White Plains, NY 10601
T: 914.323.7400 F: 914.323.7401 www.langan.com

Project: **LINCOLN LOGISTICS BREWSTER**
Town of Southeast
Putnam County
New York

Drawing Title: **LIGHTING PLAN C**

Project No.: **190065201**
Date: **1/28/2022**
Drawn By: **MJ**
Checked By: **MH**
Drawing No.: **C-603**
Sheet **64** of **96**