


Reconstruction To:
JV Forrestal Elementary School
Sargent Elementary School
South Ave Elementary School
Rombout Middle School
Beacon High School
Bus Maintenance Facility
Addition and Alteration to:
Glenham Elementary School
Beacon City School District
Beacon, New York

SED Control No. 13-02-00-01-0-002-021
SED Control No. 13-02-00-01-0-008-020
SED Control No. 13-02-00-01-0-003-016
SED Control No. 13-02-00-01-0-004-023
SED Control No. 13-02-00-01-0-020-012
SED Control No. 13-02-00-01-5-018-006

SED Control No. 13-02-00-01-0-006-022

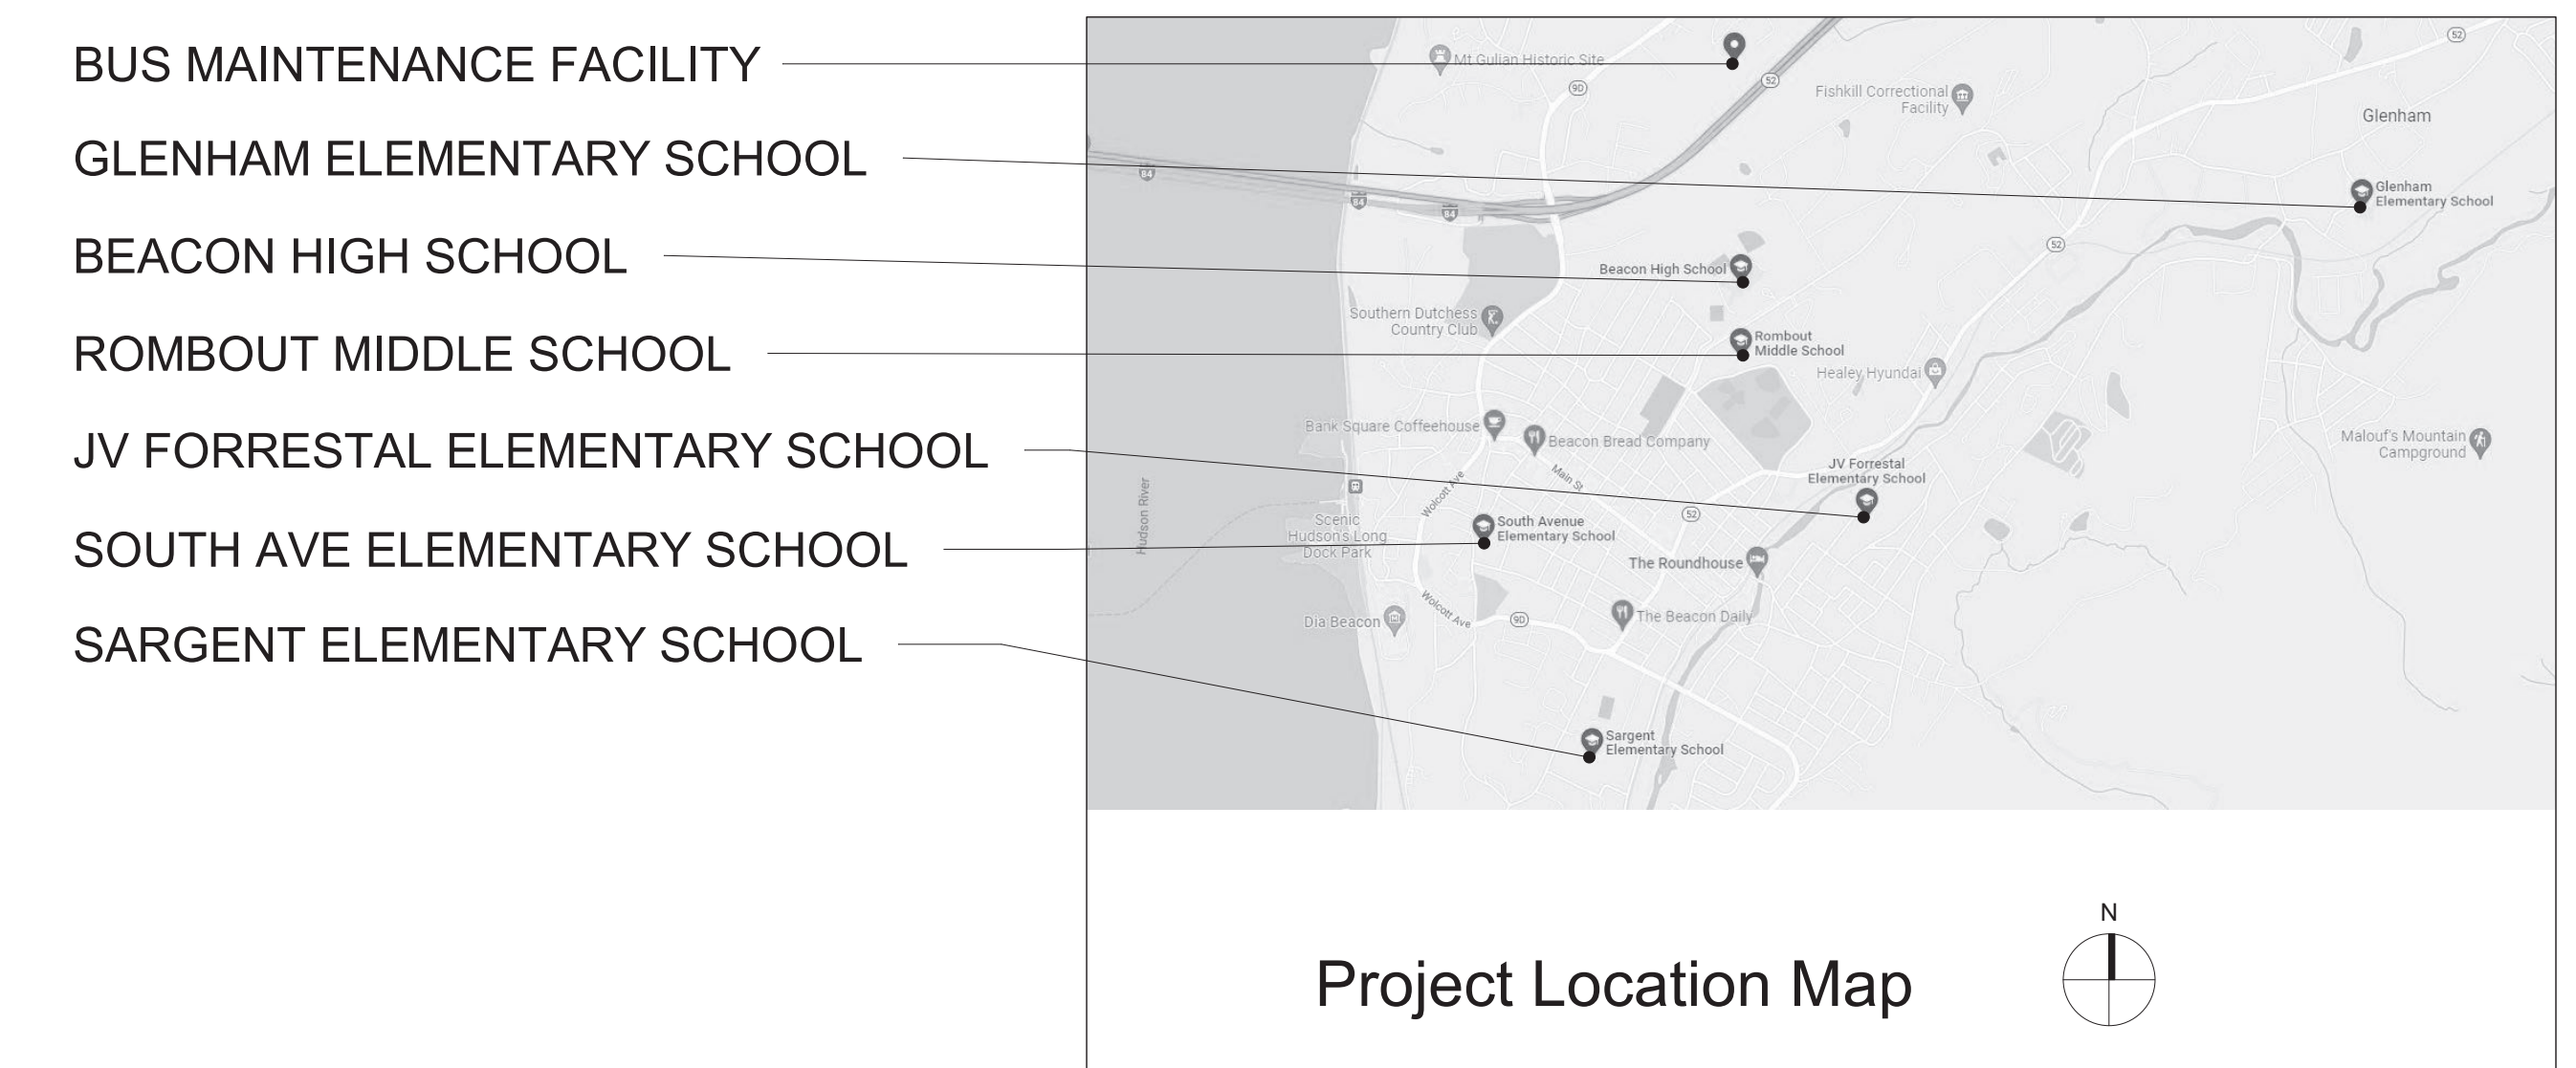

Drawing List

GENERAL

G002 Title Sheet

G100 Symbols and Abbreviations

Rombout Middle School

STRUCTURAL

ES130 Partial Framing Plans - Area F Schedules, and Details

Notes,

MECHANICAL

EM051 First Floor and Second Floor Key Plans

EM100 First Floor Demolition Plan - Partial Area A, Area B and Partial Area C

EM101 First Floor Demolition Plans - Area D and Partial Area F Roof Demolition Plan - Partial Area F

EM130 First Floor Plan - Partial Area A, Area B and Partial Areas C and E

EM131 First Floor Plans - Area D and Partial Area F and Roof Plan - Area D and Partial Areas C and F

EM500 Details and Controls

EM600 Schedules and Controls

ELECTRICAL

EE001 Site Electrical Plan

EE100 First Floor Demolition Plan - Area A

EE101 First Floor Demolition Plan - Areas B and E

EE102 First Floor Demolition Plan - Areas C and D

EE103 First Floor Demolition Plan - Area F

EE104 Second Floor Demolition Plan - Areas B and D

EE130 First Floor Lighting, Power & Communications Plan - Area A

EE131 First Floor Lighting, Power & Communications Plan - Areas B and E

EE132 First Floor Lighting, Power & Communications Plan - Areas C and D

EE133 First Floor Lighting, Power & Communications Plan - Area F

EE134 Second Floor Lighting, Power & Communications Plan - Areas B and D

EE160 Roof Power Plan - Areas C, D, E and F

EE400 Enlarged Lighting Plans - Areas A and B

EE401 Enlarged Power & Communications Plans - Areas A and B

EE500 Details

EE501 Details

EE600 Schedules

PLUMBING

EP050 First Floor Key Plan

EP400 Enlarged Art Room Plans

EP401 Enlarged Science Room Plans

EP402 Enlarged Kitchen Plans, Schedule and Details

Beacon City High School

CODE COMPLIANCE

FG350 Code Compliance Review

FG351 Code Compliance First Floor Key Plan

FG352 Code Compliance Second Floor Key Plan

ARCHITECTURAL

FA100 First Floor Demolition Plan - Area A

FA101 First Floor Demolition Plan - Area G

FA102 Second Floor Demolition Plan - Area C

FA130 First Floor Plan - Area A

FA131 First Floor Plan - Area G

FA133 Second Floor Plan - Area C

FA160 First Floor Reflected Ceiling Plan Area A

FA161 First Floor Reflected Ceiling Plan Area G

FA162 Second Floor Reflected Ceiling Plan Area C

FA400 Enlarged Plans - Area A

FA401 Enlarged Plans and Sections - Area G

FA402 Enlarged Second Floor Plan Area C

FA600 Door Schedule, Door, Window and Wall Types, and Details

FA920 Enlarged Plans and Elevations

STRUCTURAL

FS130 Partial Foundation and Framing Plan - Area G

FS500 Typical Details

MECHANICAL

FM051 First Floor Key Plan

FM052 Second Floor Key Plan

FM100 Partial Plans and Sections - Area G

FM101 Partial Second Floor Plans - Area C

FM500 Details and Schedule

ELECTRICAL

FE050 First Floor Key Plan

FE051 Second Floor Key Plan

FE400 First Floor Enlarged Plans

FE401 First Floor Enlarged Plans

FE402 Second Floor Enlarged Plans

FE500 Details

FE501 Details

PLUMBING

FP050 First Floor Key Plan

FP400 Enlarged Science Room Plans and Details

FP401 Enlarged Area G Plans, Details and Schedules

FP402 Enlarged Mechanical Room F302 Plan

Common

CIVIL

ZC500 Site Details

ZC501 Site Details

ZC502 Site Details

ZC503 Site Details

Drawn By:
Author

Date:
10/28/2022

Drawing Number:

Project No.:
279180-22004

AA130

BUILDING DESIGNATOR

DISCIPLINE DESIGNATOR

SHEET TYPE DESIGNATOR

SHEET SEQUENCE DESIGNATOR



TETRA TECH
ARCHITECTS & ENGINEERS

Architecture Engineering Planning for High Performance Facilities

Tetra Tech Engineers, Architects & Landscape Architects, P.C.

Volume 2 of 2

Set No.

BID SET

279180-22004

10/28/2022

ing Number:

G002

BID SET PRINTED AUGUST 8, 2023