



New York State
Parks, Recreation and
Historic Preservation

Governor Kathy Hochul

Commissioner Erik Kulesseid

IT IS A VIOLATION OF STATE EDUCATION LAW FOR ANY PERSON, UNLESS UNDER THE DIRECTION OF A LICENSED ARCHITECT/ENGINEER, TO ALTER THIS DOCUMENT IN ANYWAY. ALTERATIONS MUST HAVE THE SEAL AFFIXED ALONG WITH A DESCRIPTION OF THE ALTERATIONS, DATE AND ARCHITECTS/ENGINEER'S SIGNATURE. COPYRIGHT © 2023

Architect:

Saratoga Associates
21 Congress Street, Suite 201
Saratoga Springs, NY 12866

SARATOGA
ASSOCIATES

Landscape Architects, Architects,
Engineers, and Planners, P.C.

**Surveyor/ Structural/ MEP
Engineer:**

LaBella Associates
105 N. Tioga Street, Suite 200
Ithaca, NY 14850



LaBella

Certificate of Authorization Number:
Professional Engineering: 015281
Land Surveying: 017973
Geological: 018750

Palisades Region

Palisades Interstate Park Commission
Bear Mountain, New York 10911
(845) 786-2701
Executive Director: Joshua Laird

Project Title:

CAMP JUNIOR ON LAKE TIORATI -
PHASE 3

Project Location:

HARRIMAN STATE PARK

Key Plan

REVISIONS

Rev No	Description	Date

Drawn By:

KET, LLH

Design By:

LLH

Checked By:

CTS

Approved By:

CTS

Date:

3/16/23

Sheet Title:


RCP & ROOF
PLAN - LATRINE
#427

Bid Documents

Project Number:

21059.23

Seal and Signature

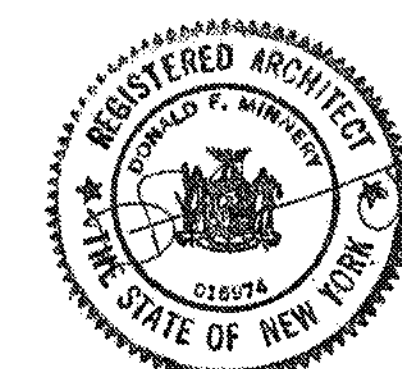

Drawing Number:

A111

GENERAL NOTES

1. ALL DIMENSIONS INDICATE CENTER LINE OF FIXTURE OR FACE OF WALL FINISH, UNLESS OTHERWISE NOTED.
2. CENTER CEILING MOUNTED LIGHT FIXTURES BETWEEN RAFTERS (TYPICAL).
3. SEE ELECT. DWGS FOR LIGHTING FIXTURE TYPES.
4. SEE STRUCTURAL DRAWINGS FOR FRAMING PLAN.

RCP SYMBOL LEGEND


- CEILING MOUNTED LIGHT FIXTURE (SURFACE MOUNTED)
- WALL MOUNTED LIGHT FIXTURE
- OS OCCUPANCY SENSOR
- EMERGENCY LIGHT FIXTURE

GENERAL ROOF NOTES


1. COORDINATE WORK WITH OTHER TRADES
2. WHERE SPECIFIC DETAILS ARE NOT INDICATED, PROVIDE MANUFACTURER'S STANDARD ROOFING DETAILS AT ALL PENETRATIONS, TERMINATIONS AND TRANSITIONS.
3. ICE & WATER SHIELD IS TO BE APPLIED AROUND ALL ROOF PENETRATIONS, ROOF OPENINGS, AND AT ALL ROOF EDGES. PRODUCT IS TO BE INSTALLED PER MANUFACTURER'S DIRECTION.

ROOF PLAN SYMBOL LEGEND

- ASPHALT SHINGLE ROOF
- ICE & WATER SHIELD
- WALL BELOW
- ROOF SLOPE
- EXHAUST VENT, SEE MECHANICAL DRAWINGS

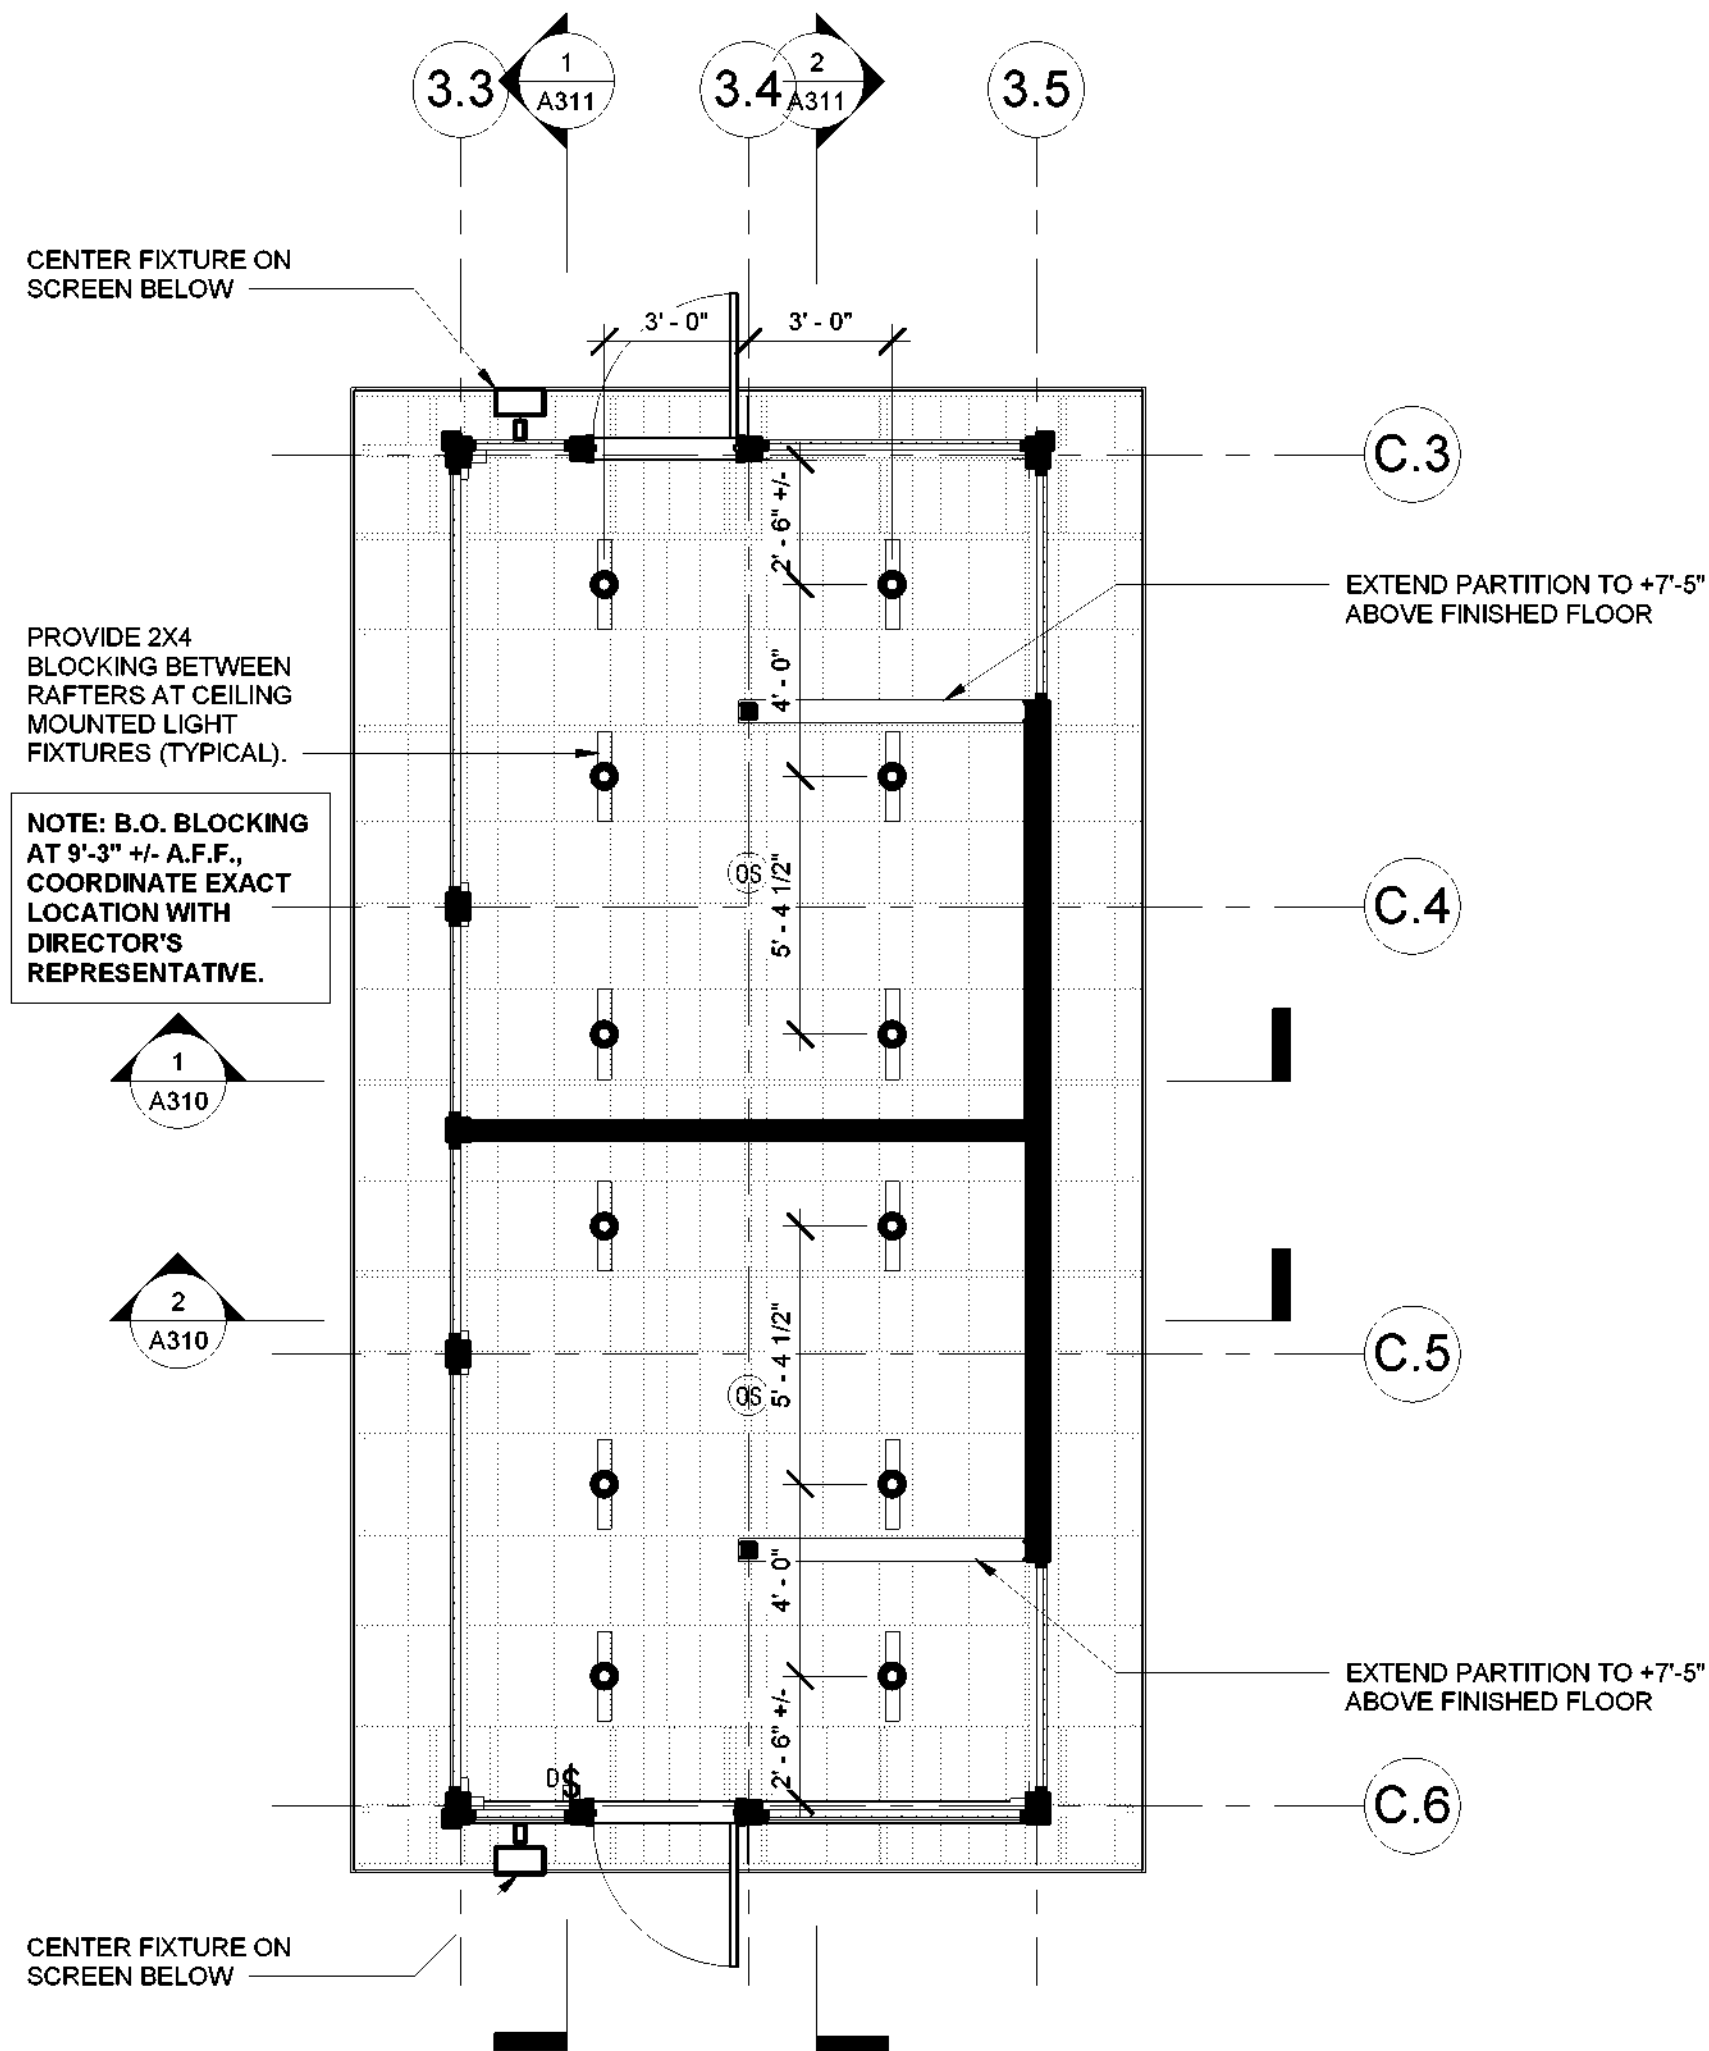

① BUILDING #427 REFLECTED CEILING PLAN
1/4" = 1'-0"

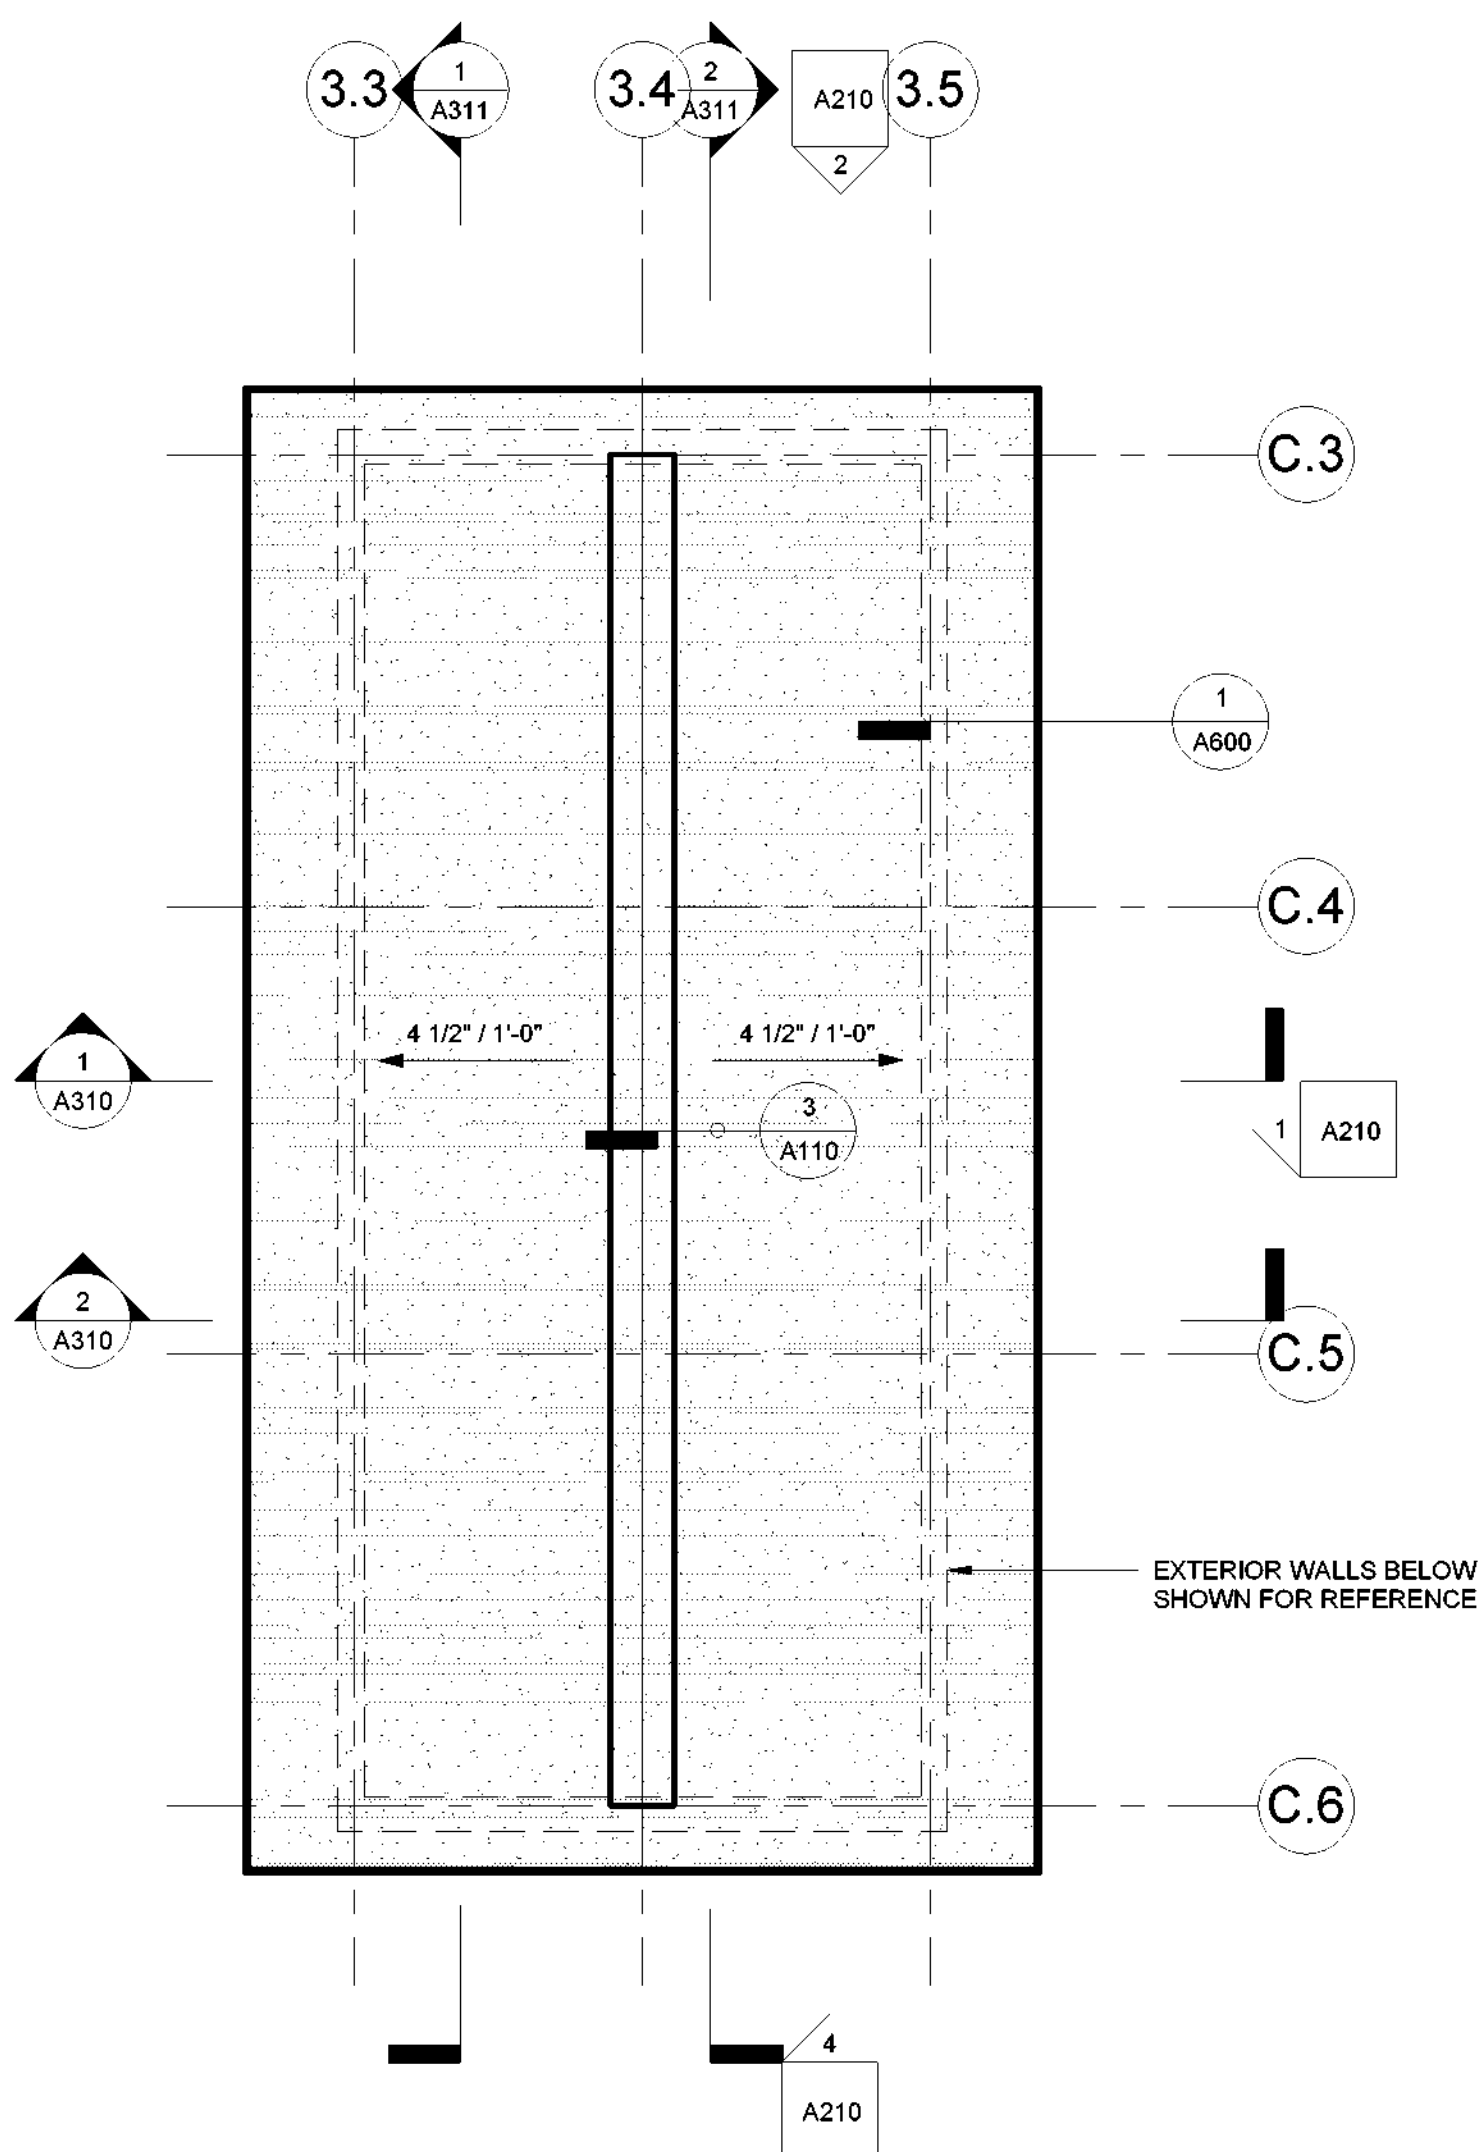

② LATRINE #427 ROOF PLAN
1/4" = 1'-0"