




3/31/2023 10:11:12 AM

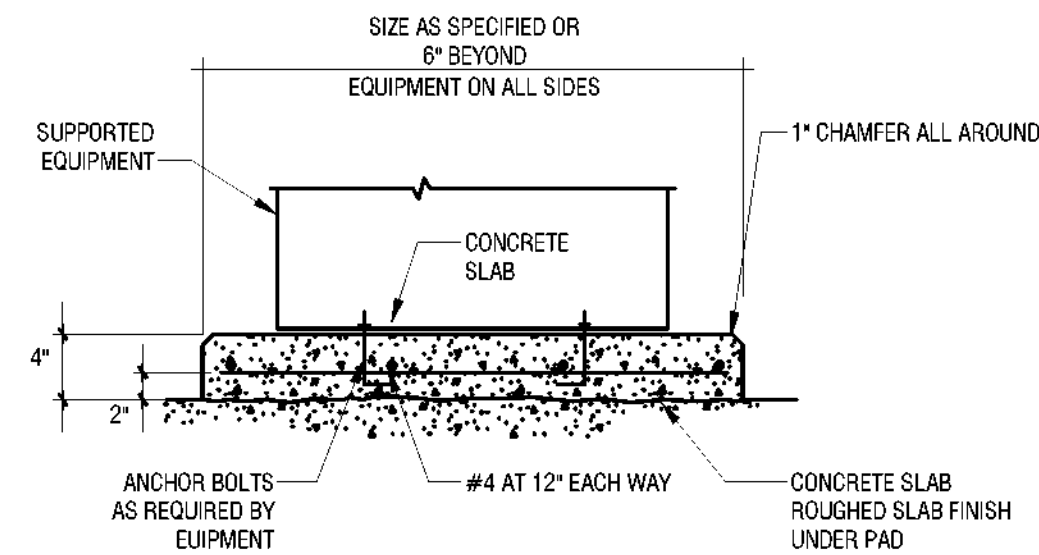


6 HOUSEKEEPING PAD DETAIL  
P102 NONE

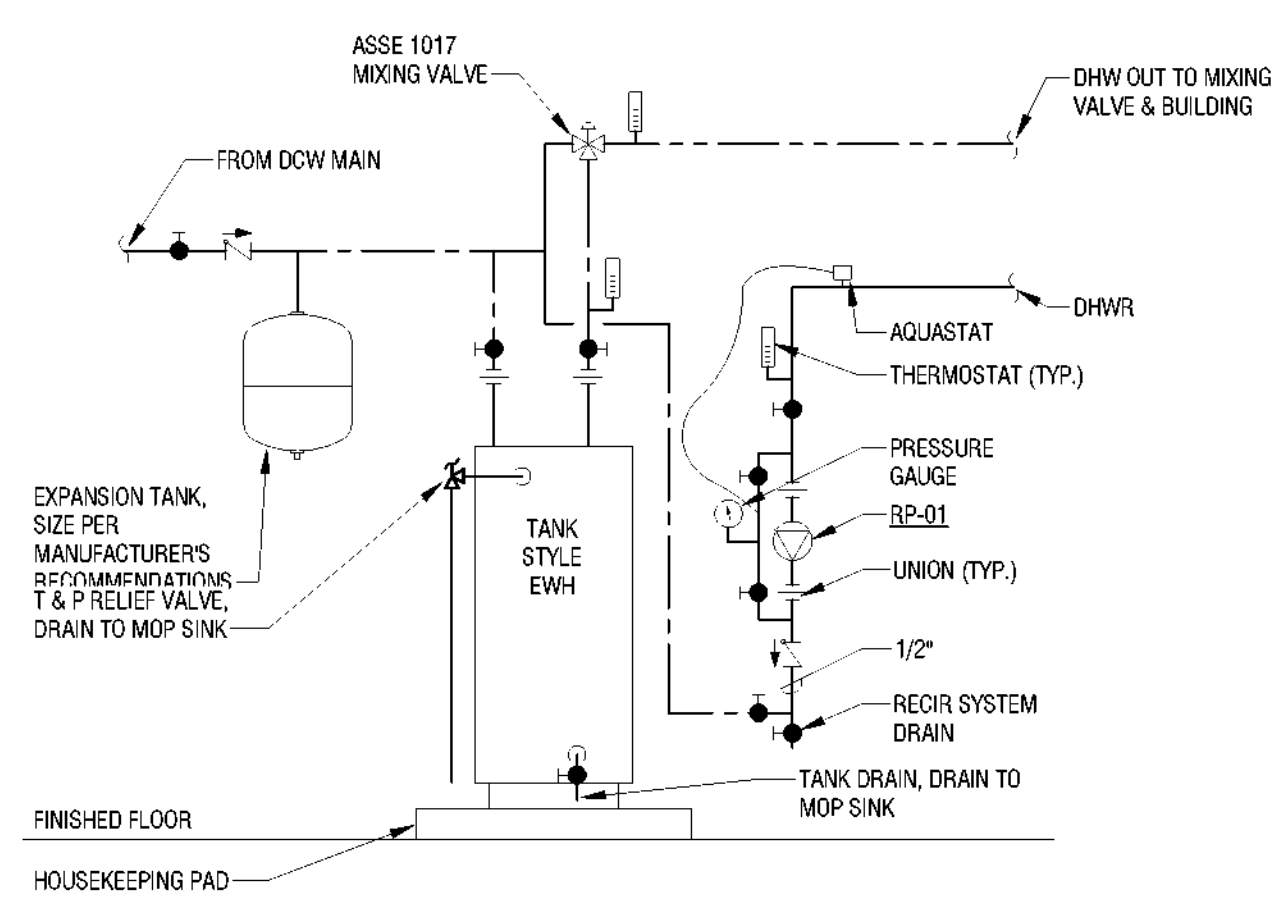


5 TANK TYPE ELECTRIC WATER HEATER DETAIL  
P102 NONE

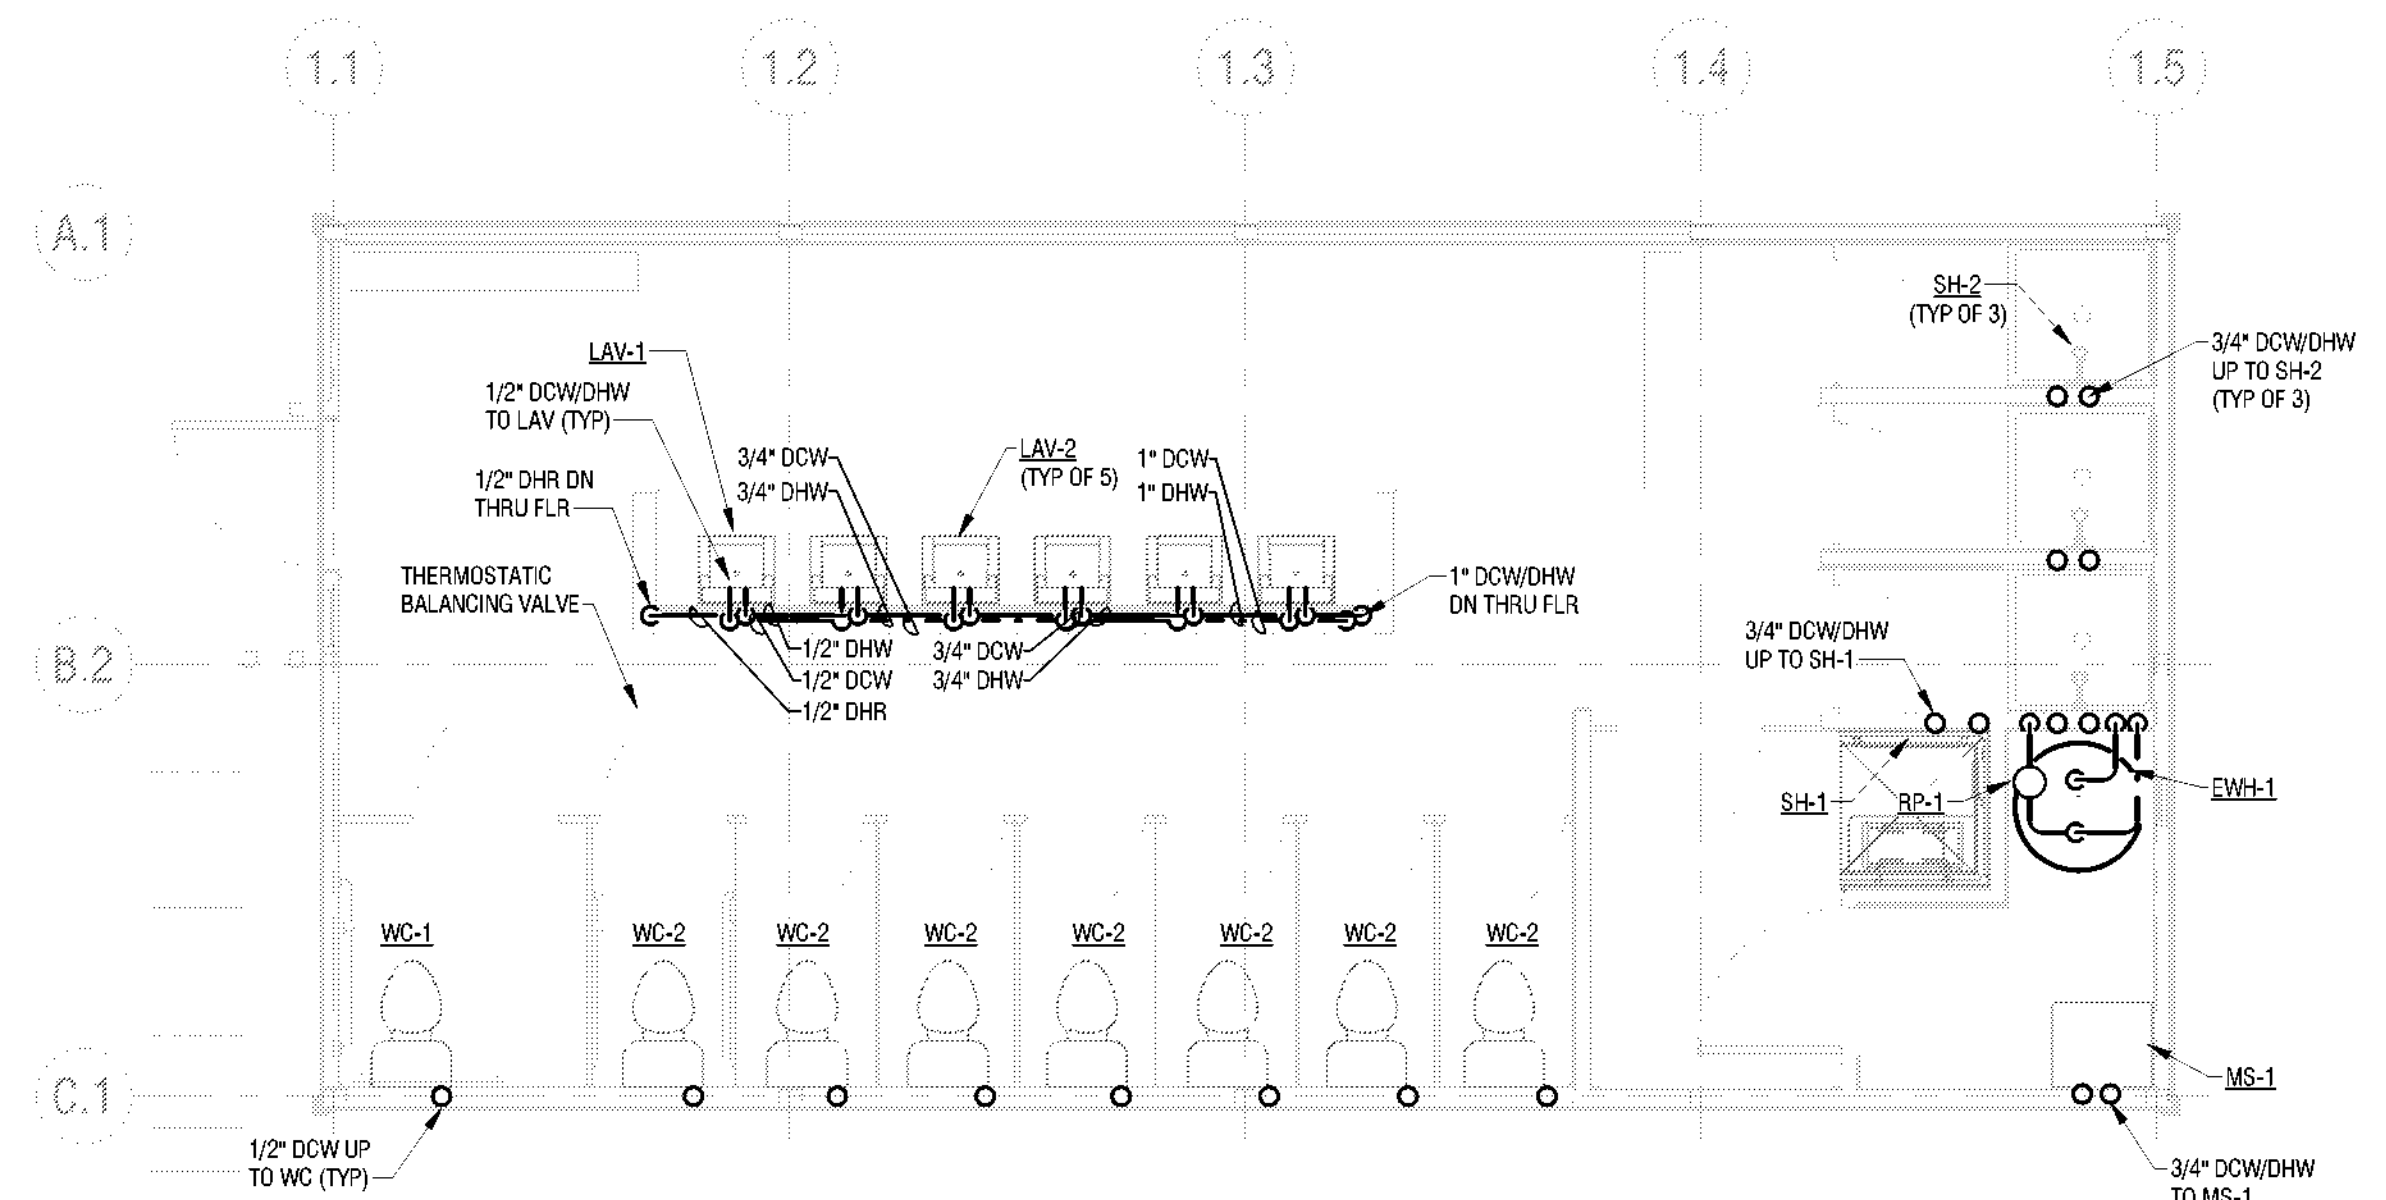


4 BATHHOUSE 231 AND 322 PLUMBING PLAN - DOMESTIC  
P102 1/4" = 1'-0"

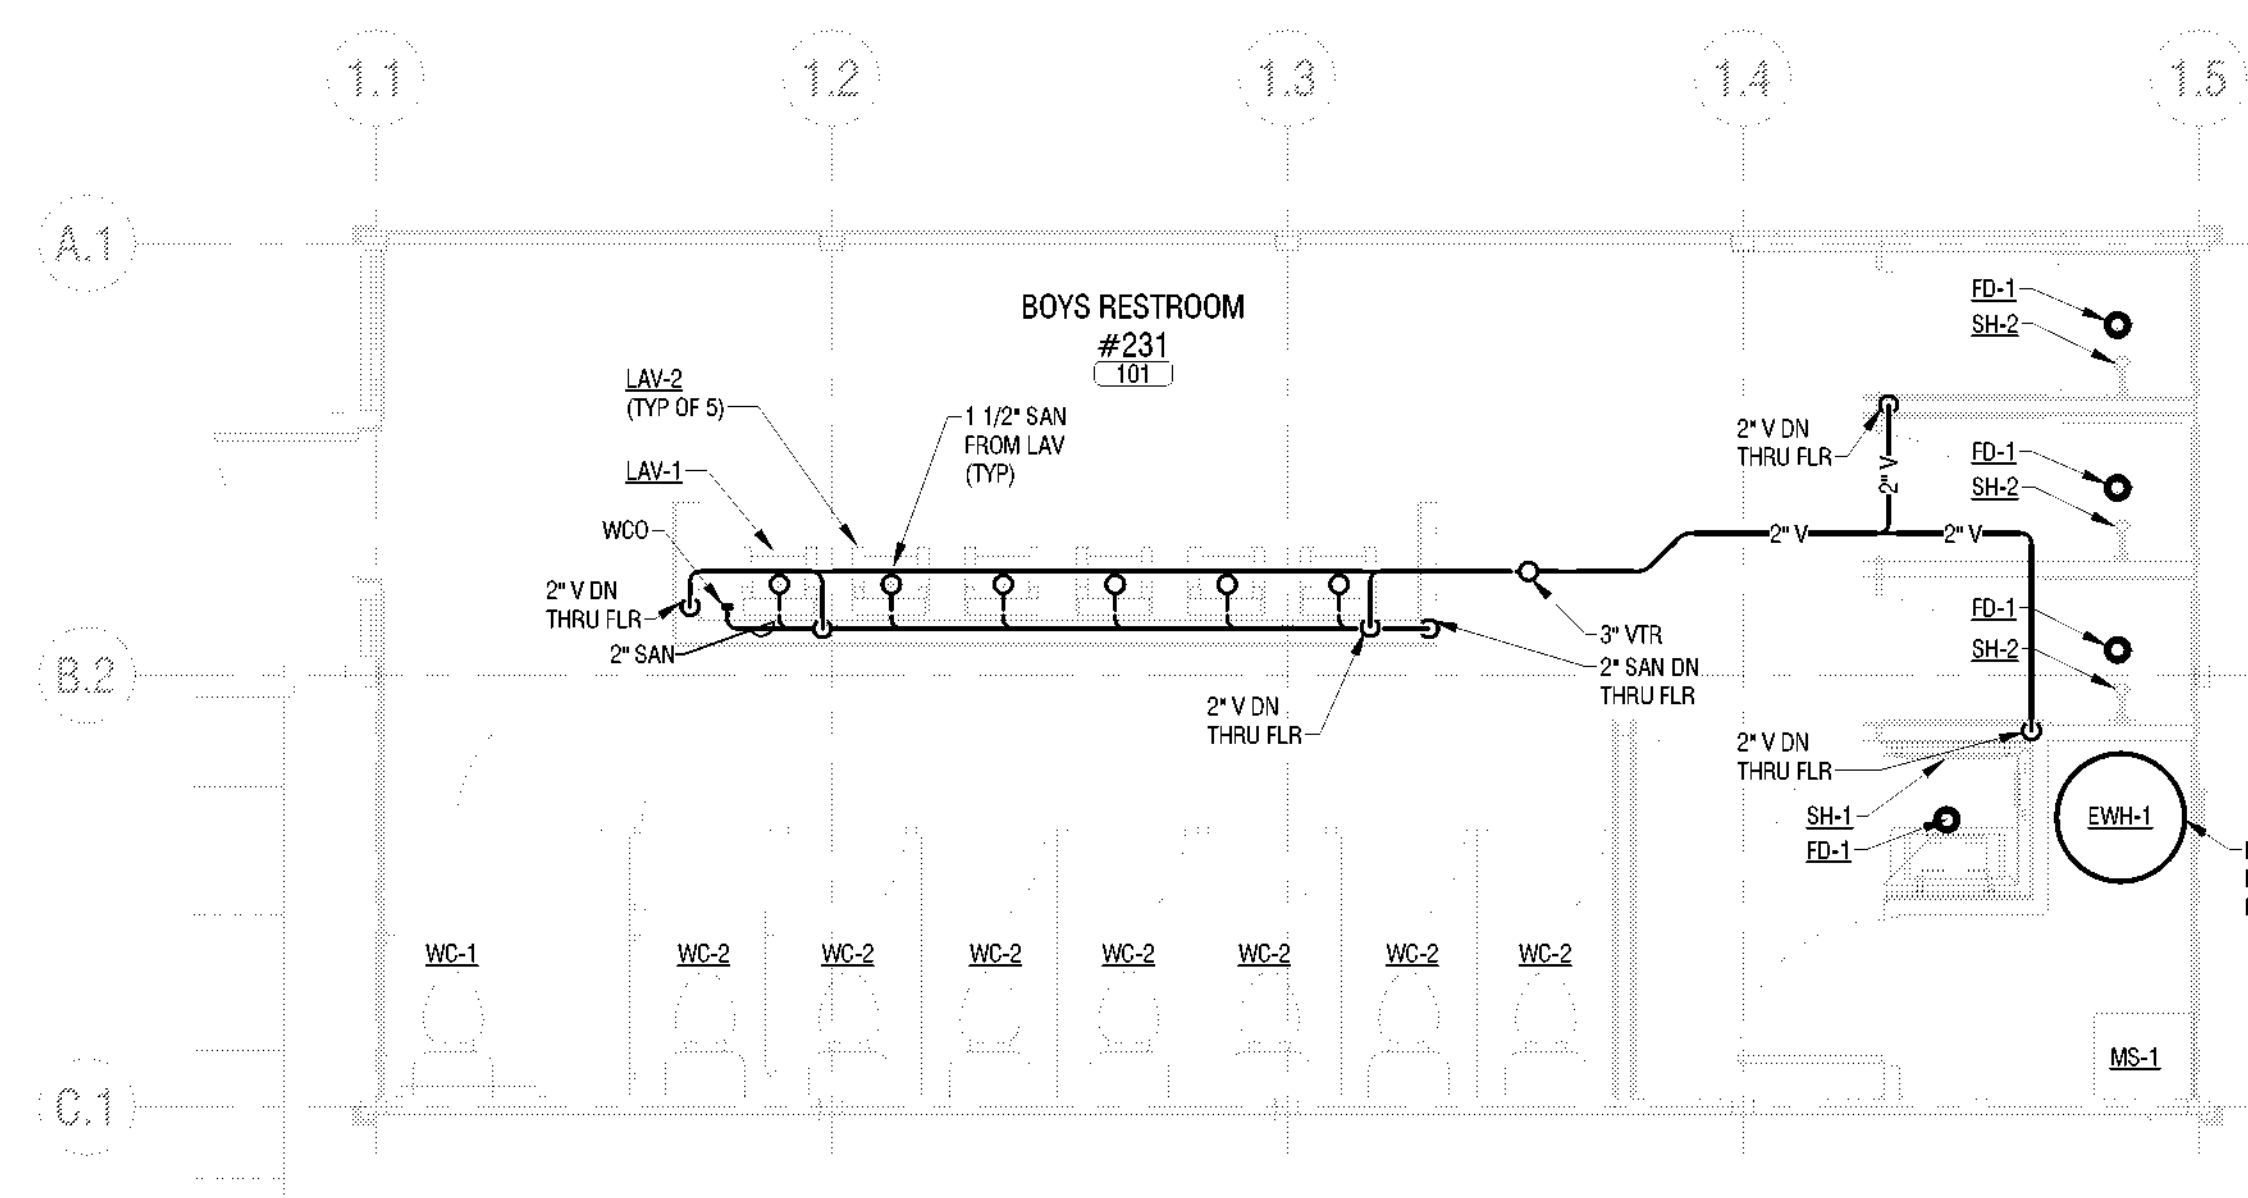

3 BATHHOUSE 231 AND 322 PLUMBING PLAN - SANITARY/VENT  
P102 1/4" = 1'-0"

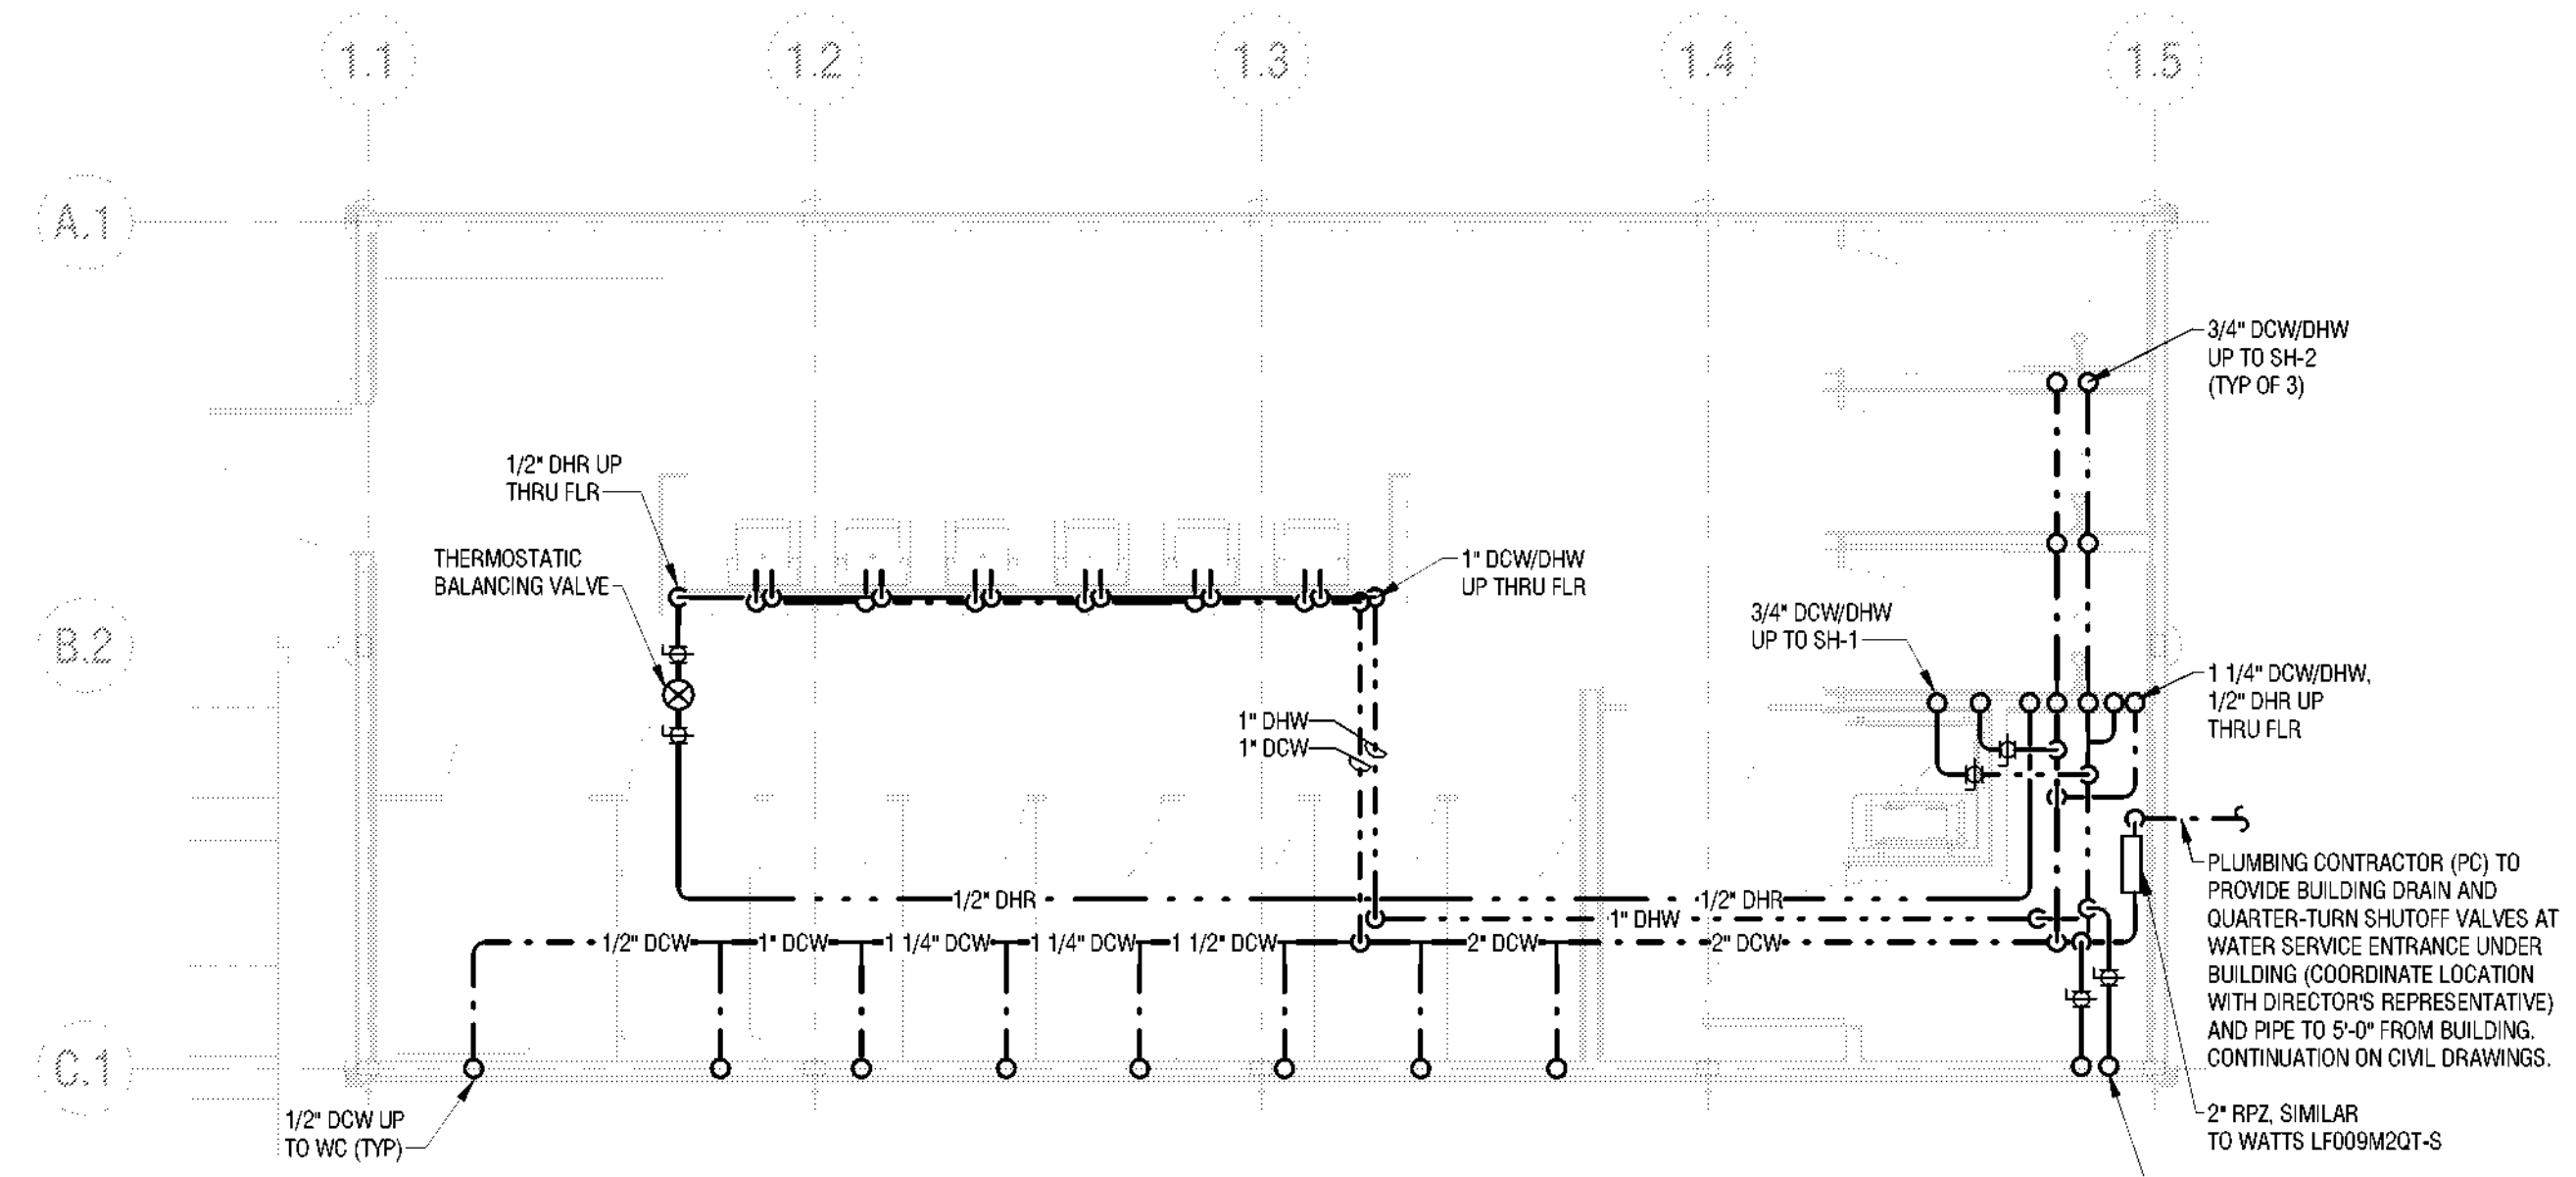

2 BATHHOUSE 231 & 322 PLUMBING PLAN - UNDERFLOOR DOMESTIC  
P102 1/4" = 1'-0"

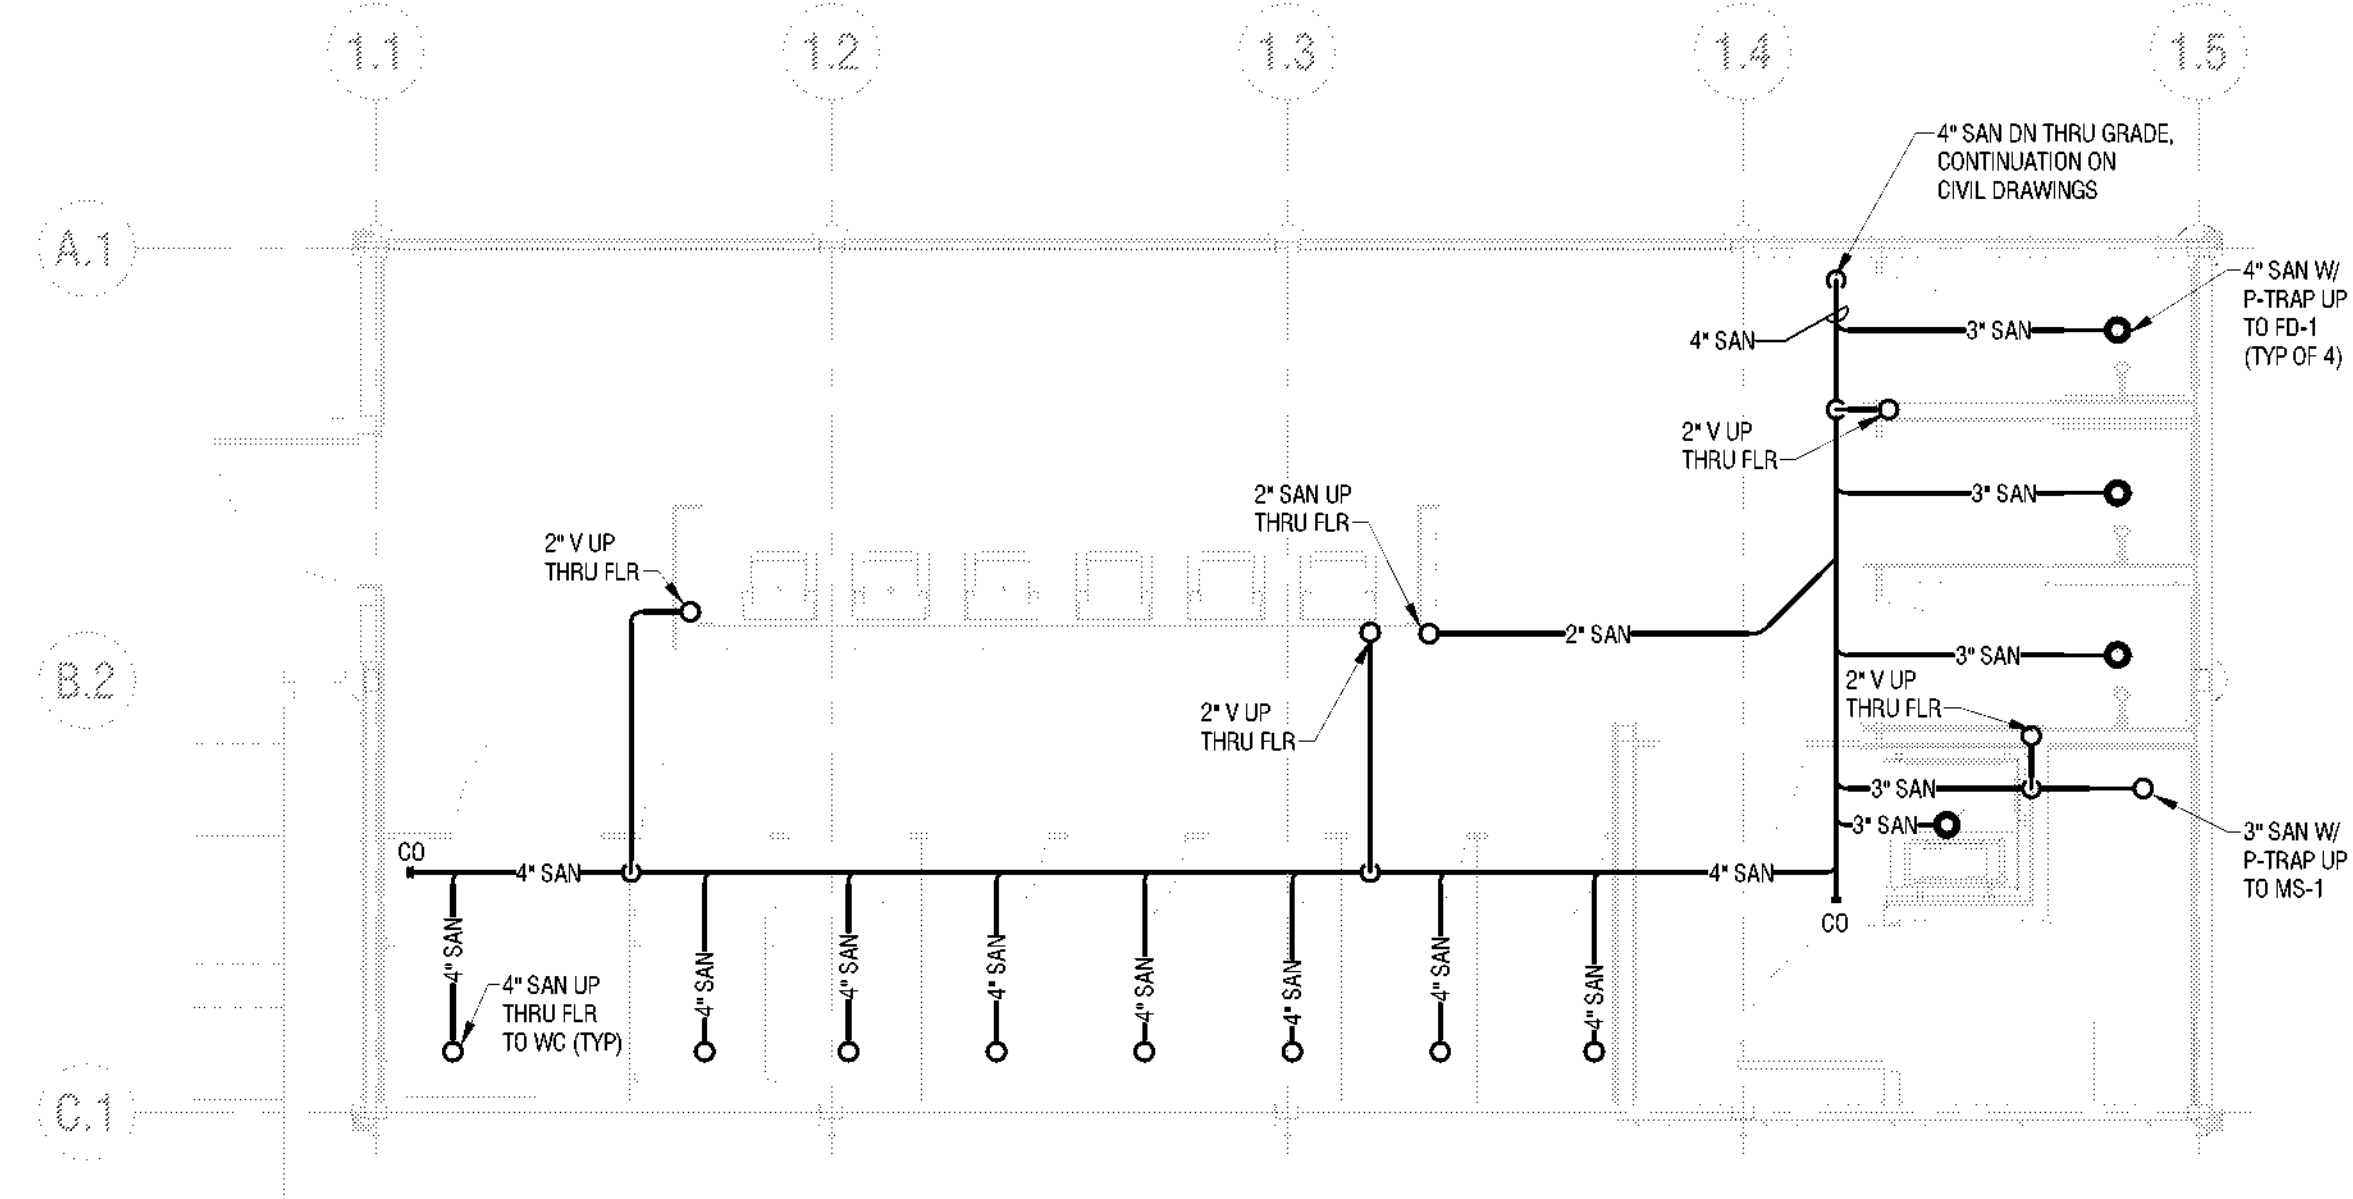

1 BATHHOUSE 231 & 322 PLUMBING PLAN - UNDERFLOOR SANITARY/VENT  
P102 1/4" = 1'-0"

New York State  
Parks, Recreation and  
Historic Preservation

Governor Kathy Hochul  
Commissioner Erik Kulesseid

IT IS A VIOLATION OF STATE EDUCATION LAW FOR ANY PERSON, UNLESS UNDER THE DIRECTION OF A LICENSED ARCHITECT/ENGINEER, TO ALTER THIS DOCUMENT IN ANYWAY. ALTERATIONS MUST HAVE THE SEAL AFFIXED ALONG WITH A DESCRIPTION OF THE ALTERATIONS, DATE AND ARCHITECTS/ENGINEER'S SIGNATURE. COPYRIGHT © 2023

**ARCHITECT:**  
Saratoga Associates  
21 Congress Street, Suite 201  
Saratoga Springs, NY 12866

**SARATOGA ASSOCIATES**  
Landscape Architects, Architects,  
Engineers, and Planners, P.C.

**SURVEYOR/STRUCTURAL/  
MEP ENGINEER:**

LaBella Associates  
300 State Street, Suite 2012  
Rochester, NY 14614

Certificate of Authorization Number:  
Professional Engineering: 018281  
Land Surveying: 017976  
Geological: 018750

**LaBella**  
ASSOCIATES

**Palisades Region**  
Palisades Interstate Park Commission  
Bear Mountain, New York 10911  
(845) 786-2701  
Executive Director: Joshua Laird

**Project Title:**  
CAMP JUNIOR ON LAKE TIORATI -  
PHASE 3

**Project Location:**  
HARRIMAN STATE PARK

**Key Plan**

Rev No	Description	Date

Drawn By:  
**NAF**

Design By:  
**NAF**

Checked By:  
**JMD**

Approved By:  
**JMD**

Date:  
**3/16/2023**

Sheet Title:  
**CAMP JUNIOR  
PLUMBING  
PLANS**

Bid Documents  
Project Number:  
**2222163.05**

Seal and Signature

EXP: 08/21/2025

Drawing Number:  
**P102**

Sheet: