


3/30/2023 8:46:13 AM

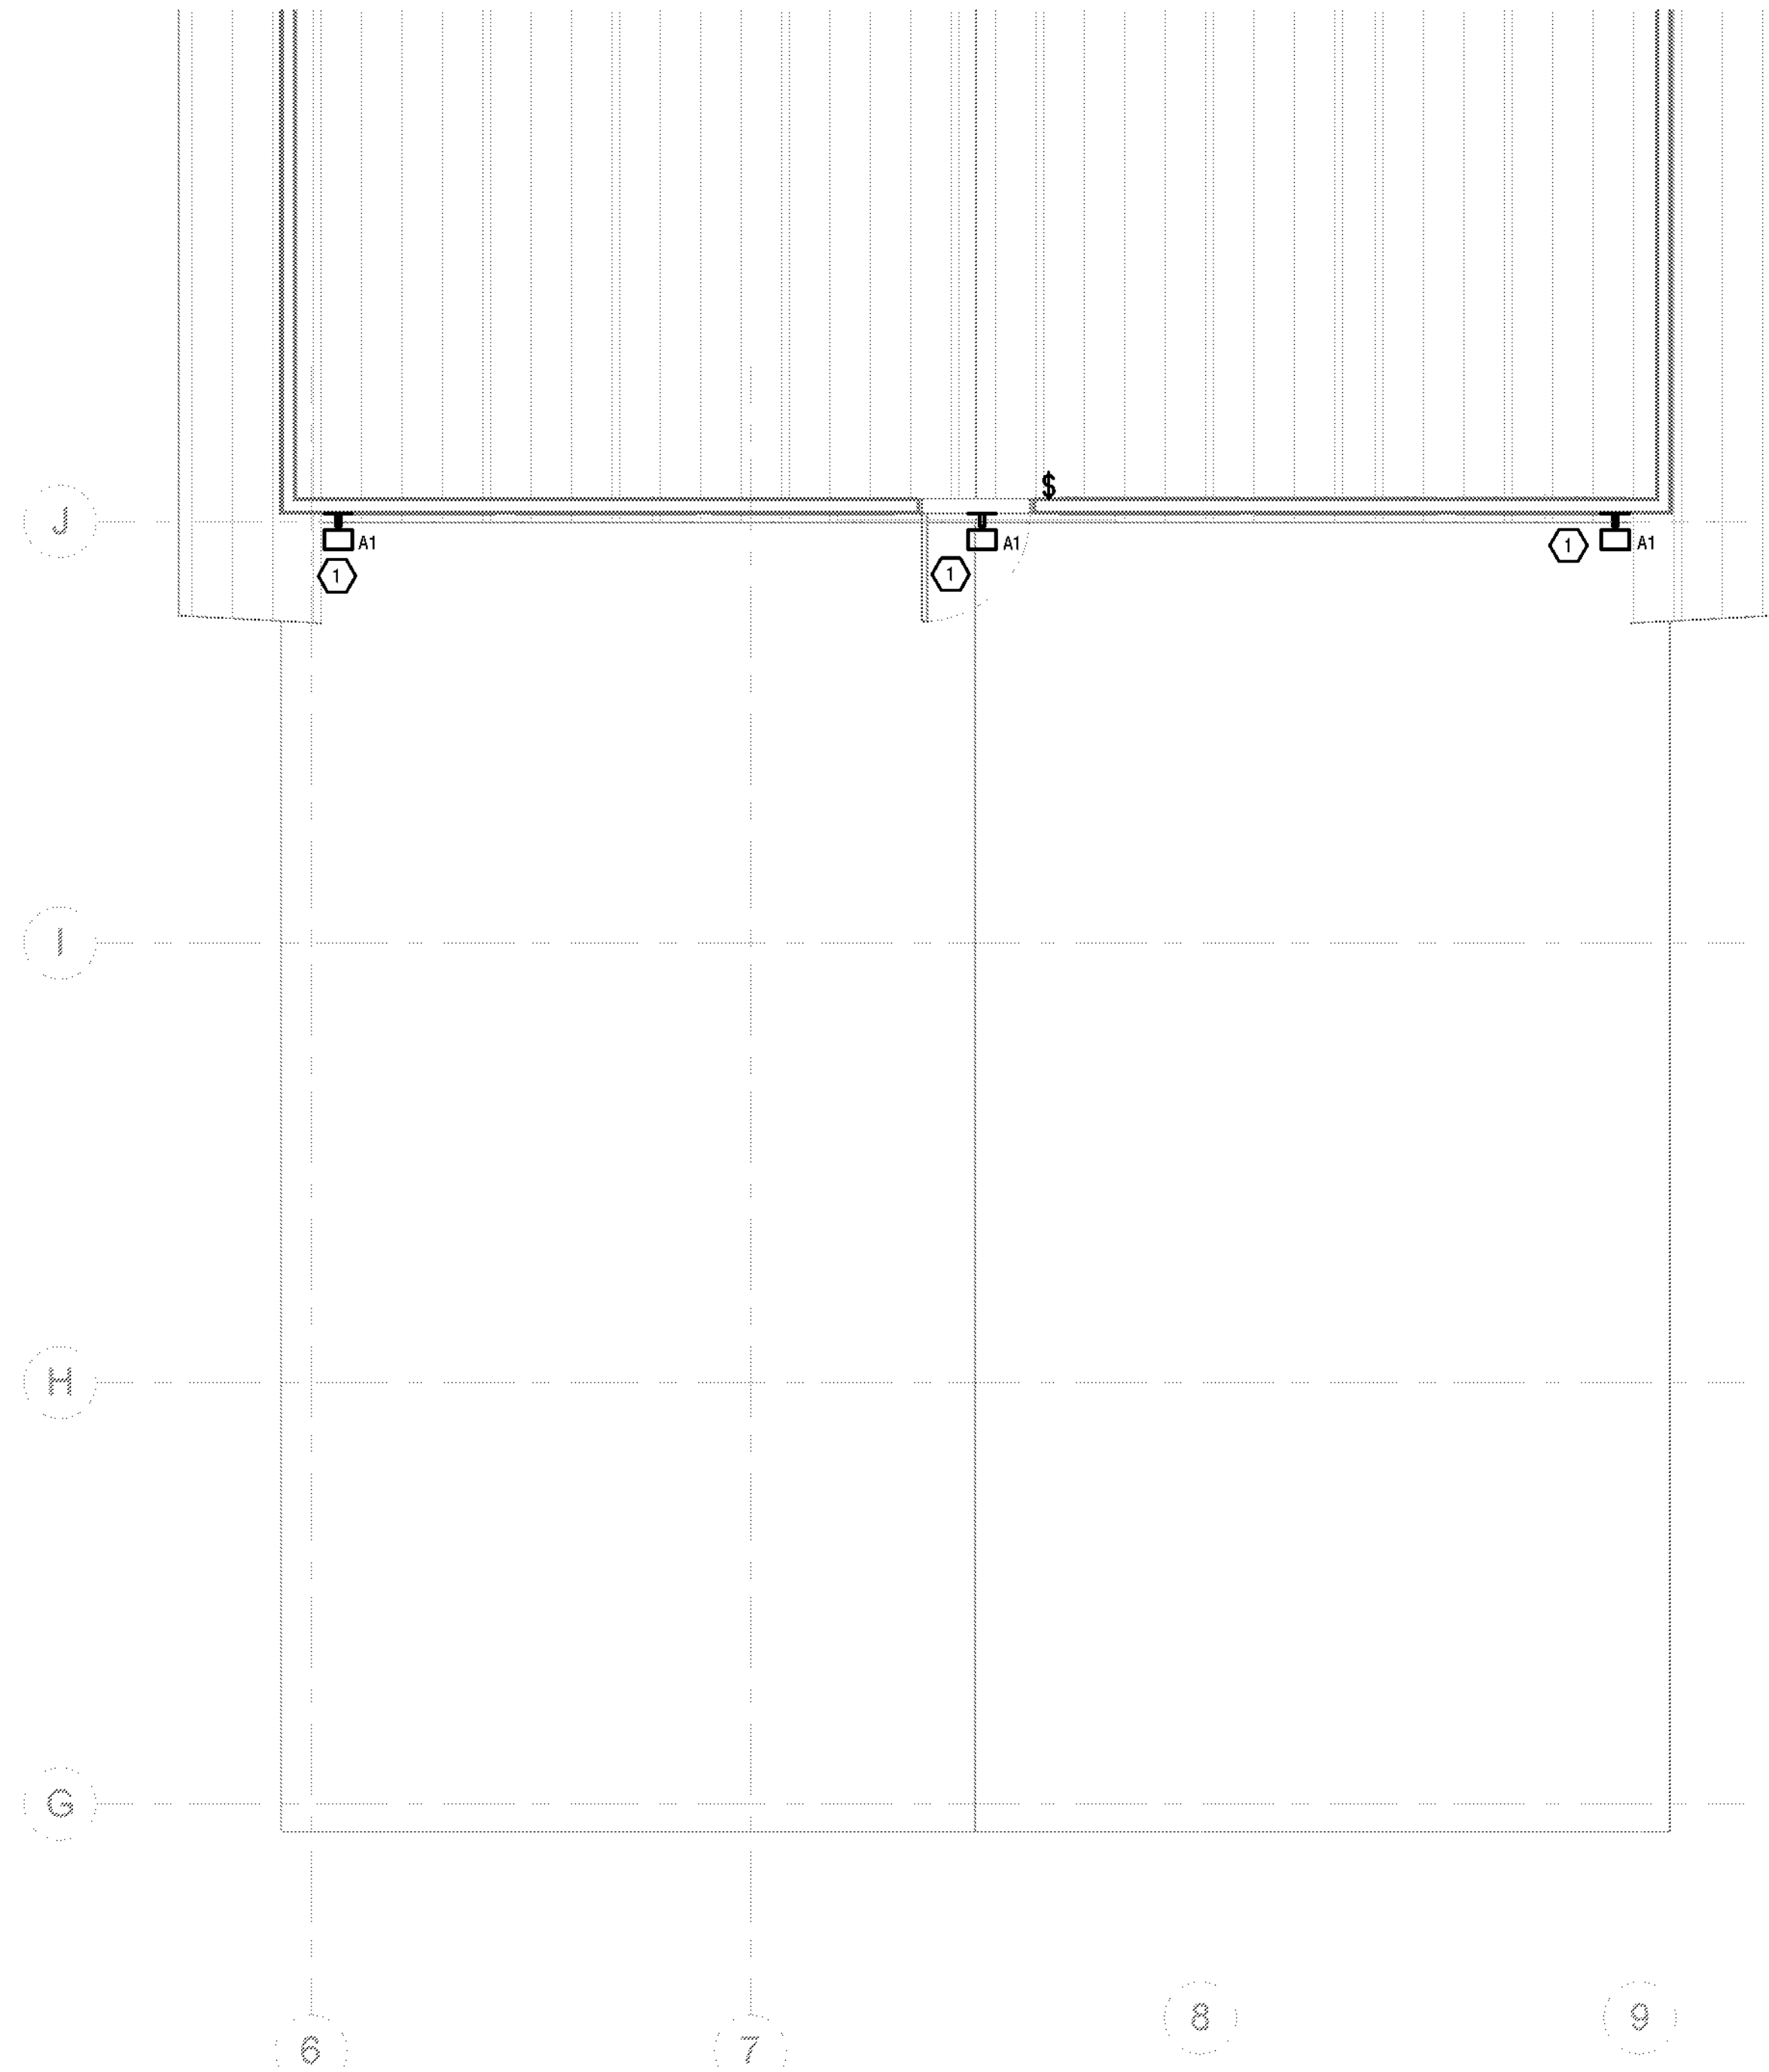

1 DINING HALL #404 CANOPY LIGHTING PLAN  
E104 1/4" = 1'-0"

KEYED NOTES:

- 1 MOUNT FIXTURE AT 10'-0" ABOVE FINISH FLOOR. CIRCUIT NEW LIGHTING FIXTURES USING 2#12, 1#12G IN 1/2" TO EXISTING CIRCUIT FEEDING THE EXIT SIGNS. ROUTE CONDUIT ON THE INSIDE OF THE BUILDING AND COME THROUGH EXTERIOR OF THE BUILDING AT THE LIGHT FIXTURES.



New York State  
Parks, Recreation and  
Historic Preservation

Governor Kathy Hochul

Commissioner Erik Kulesseid

IT IS A VIOLATION OF STATE EDUCATION LAW FOR ANY PERSON, UNLESS UNDER THE DIRECTION OF A LICENSED ARCHITECT/ENGINEER TO ALTER THIS DOCUMENT IN ANYWAY. ALTERATIONS MUST HAVE THE SEAL AFFIXED ALONG WITH A DESCRIPTION OF THE ALTERATIONS, DATE AND ARCHITECTS/ENGINEERS SIGNATURE. COPYRIGHT © 2023

ARCHITECT:

Saratoga Associates  
21 Congress Street, Suite 201  
Saratoga Springs, NY 12866

SARATOGA  
ASSOCIATES

Landscape Architects, Architects,  
Engineers, and Planners, P.C.

SURVEYOR/STRUCTURAL/  
MEP ENGINEER:

LaBella Associates  
300 State Street, Suite 201  
Rochester, NY 14614



LaBella

Certificate of Authorization Number:  
Professional Engineering: 015281  
Last Surveying: 017973  
Geological: 018750

Palisades Region

Palisades Interstate Park Commission  
Bear Mountain, New York 10911  
(845) 786-2701  
Executive Director: Joshua Laird

Project Title:  
CAMP JUNIOR ON LAKE TIORATI -  
PHASE 3

Project Location:  
HARRIMAN STATE PARK

Key Plan

REVISIONS

Rev No	Description	Date

Drawn By:

JJS

Design By:

JJS

Checked By:

NCH

Approved By:

NCH

Date:

3/16/23

Sheet Title:

DINING HALL  
#404 CANOPY  
LIGHTING  
PLANS

Bid Documents

Project Number:

21059.23

Seal and Signature



Drawing Number:

E104

Sheet: