




TRUCK FILL WALL HYDRANT DETAIL

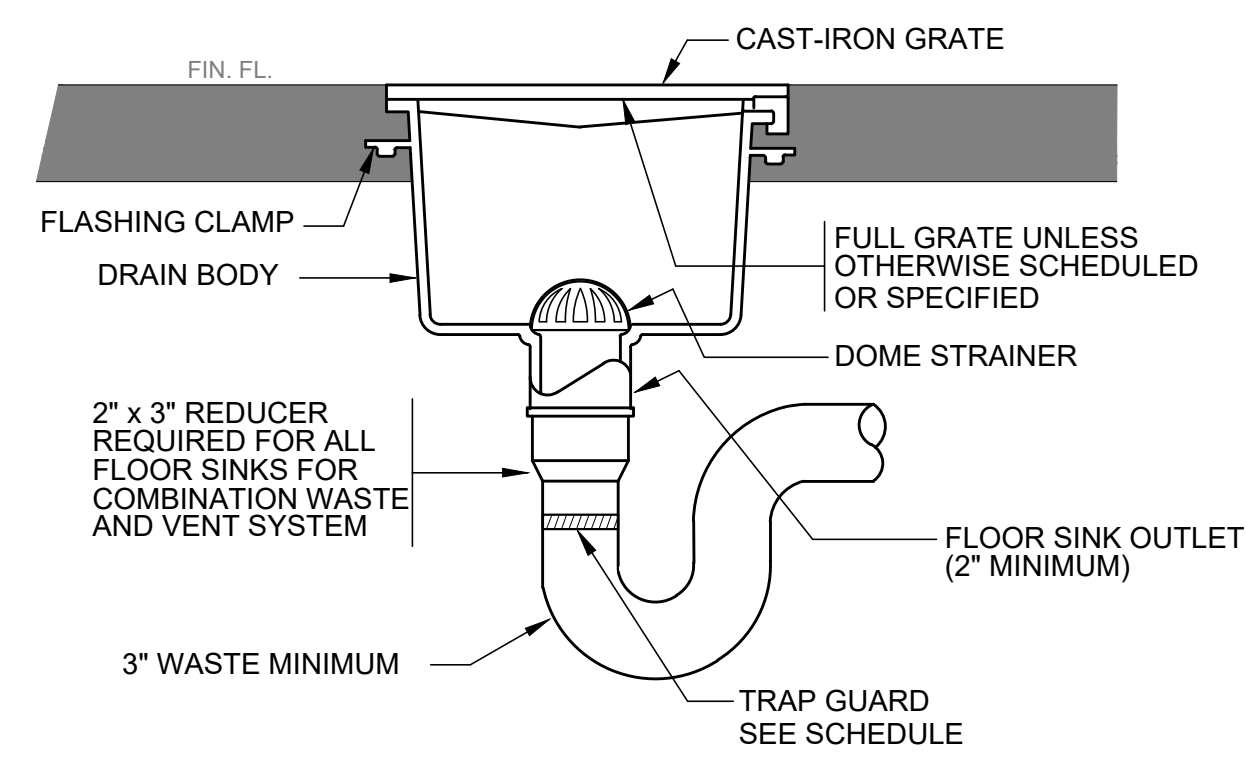

FLOOR SINK DETAIL

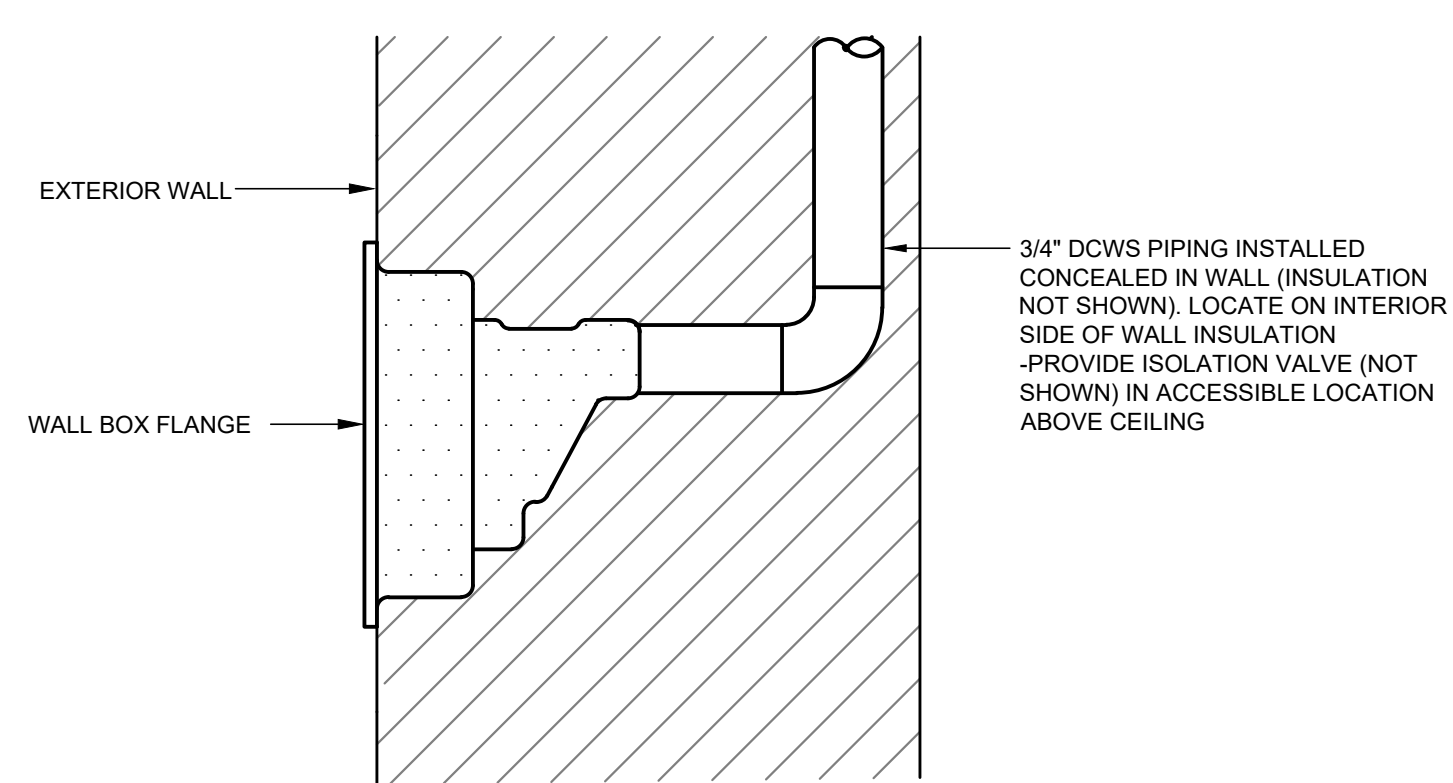


FREEZEPROOF WALL HYDRANT


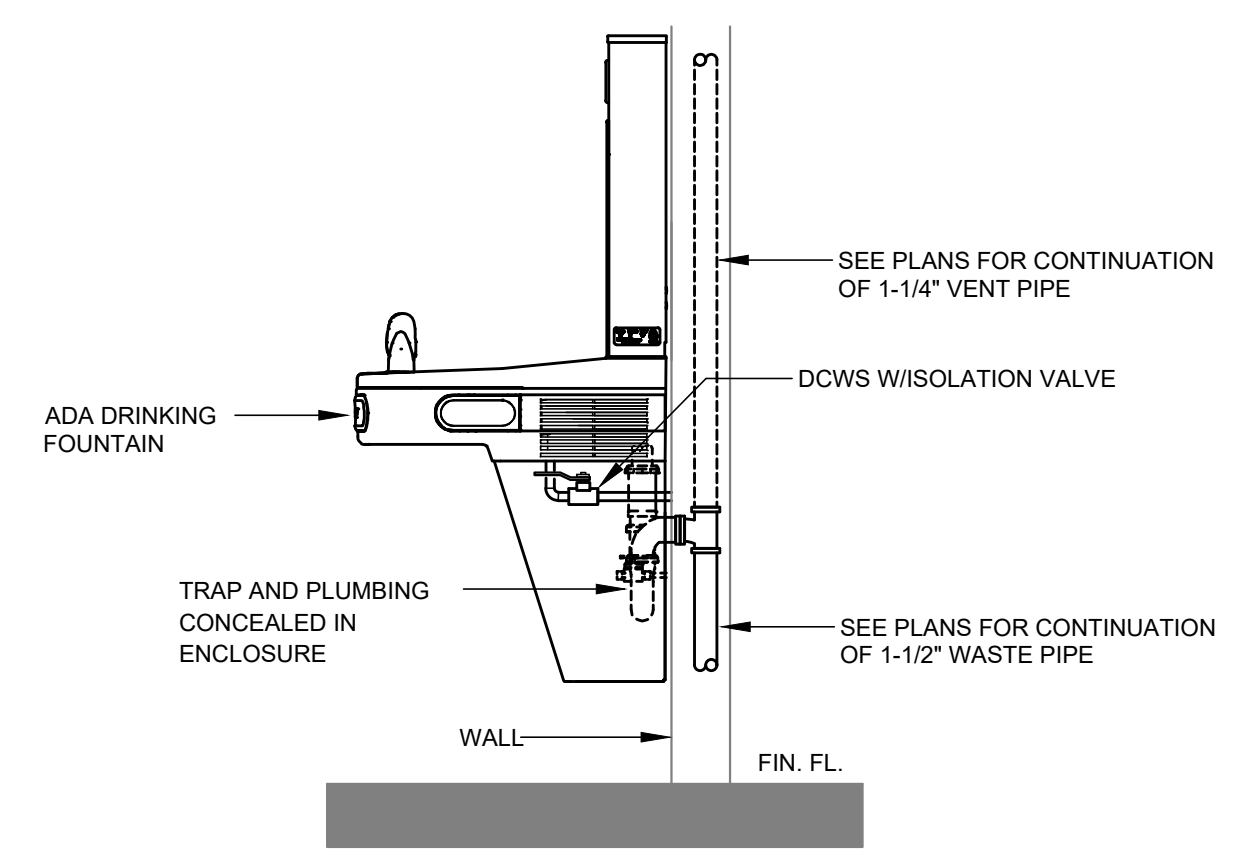


NOTES:
 1. SEE ARCH. PLANS FOR FIXTURE MOUNTING HEIGHTS.
 2. INSTALL IN ACCORDANCE WITH MANUFACTURER'S INSTRUCTIONS.



WALL-HUNG DRINKING FOUNTAIN DETAIL

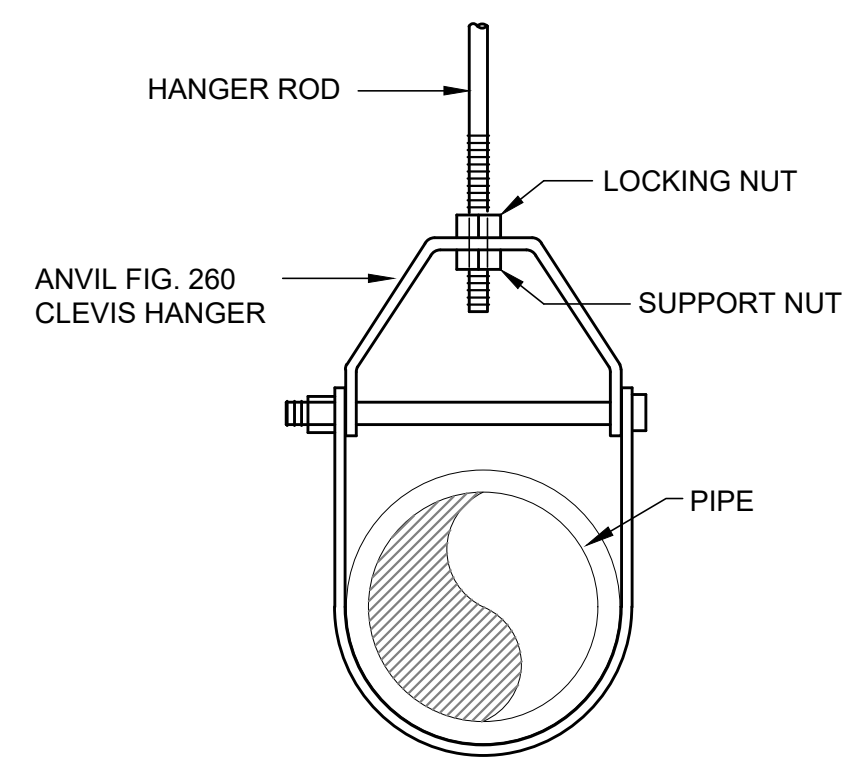


CLEVIS HANGER
- PIPE WITH NO INSULATION -

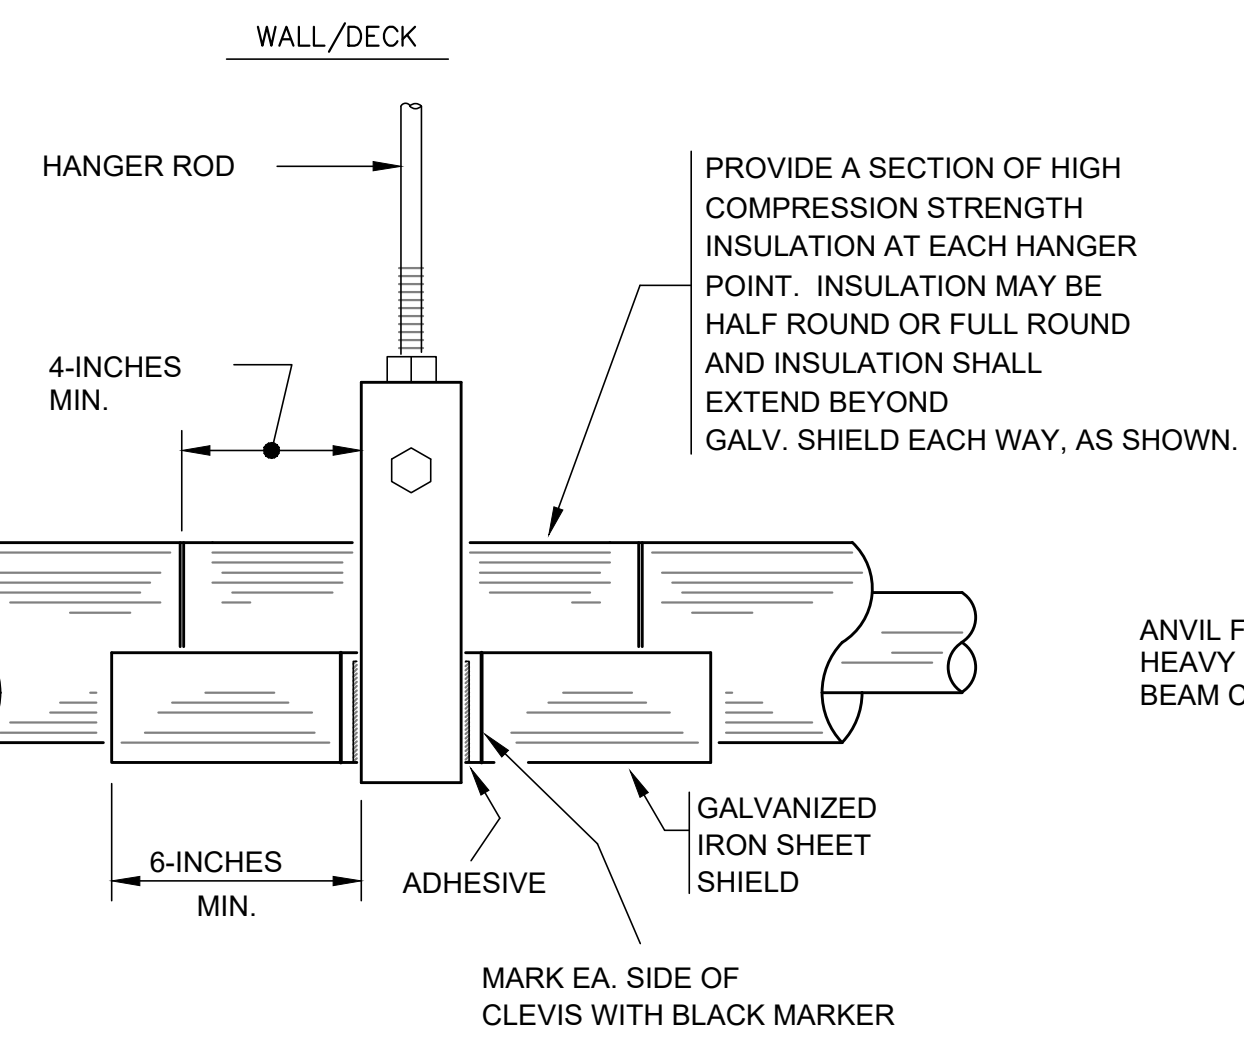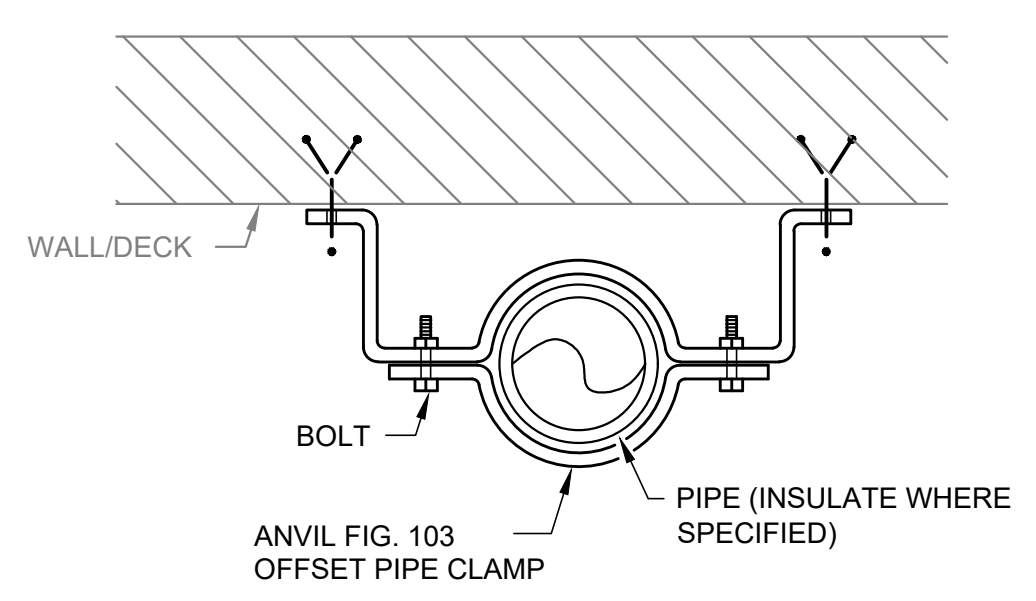


CLEVIS HANGER
- PIPE WITH EXTERNAL INSULATION -

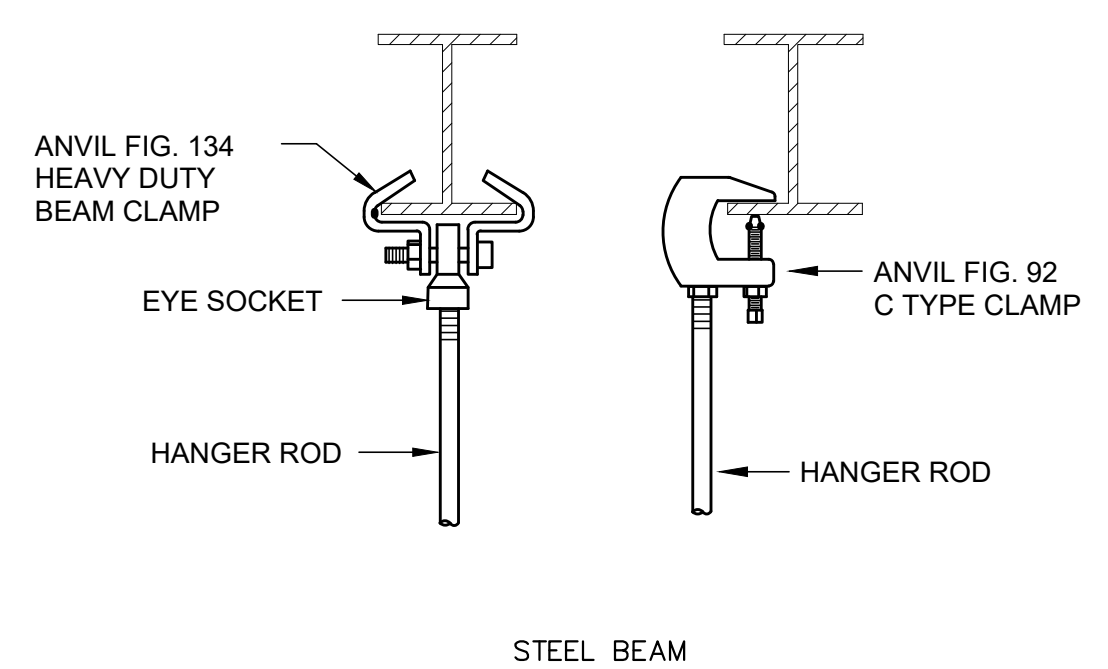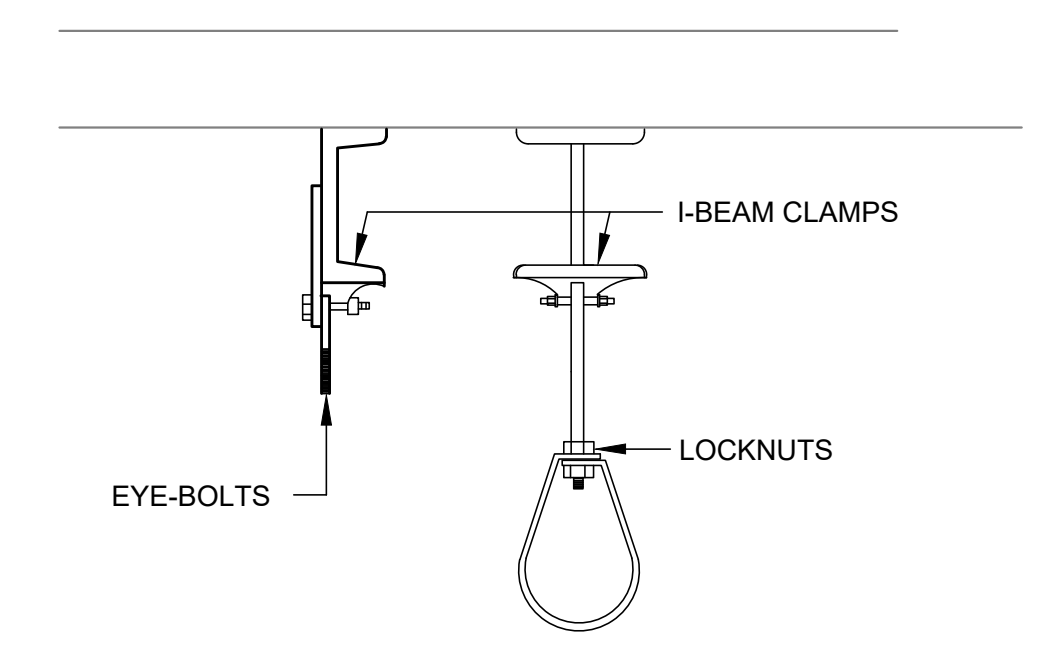

STEEL BEAM

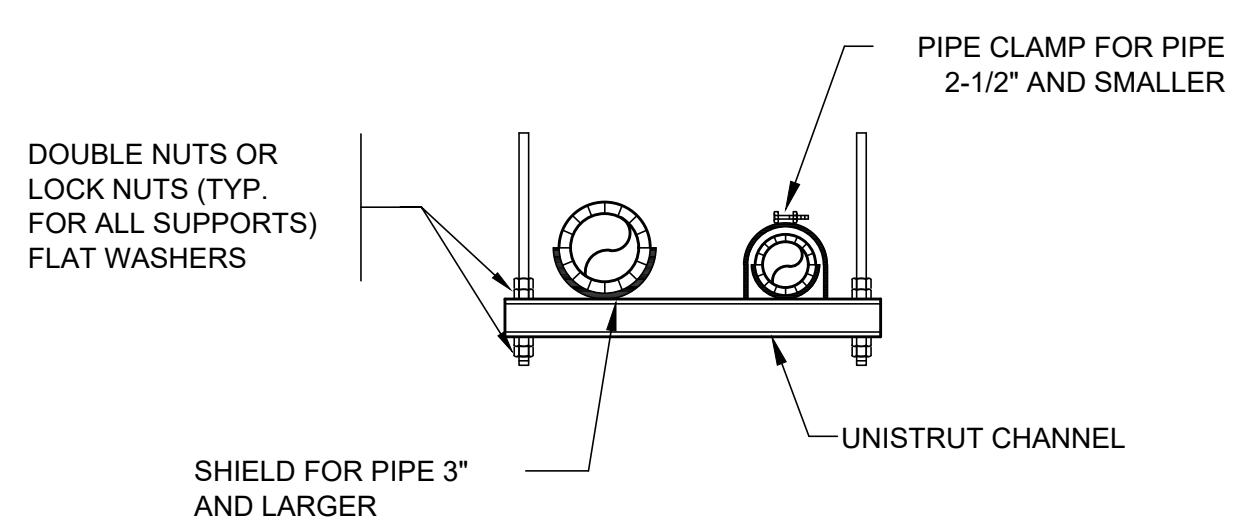

TYPICAL PIPE SUPPORT DETAILS

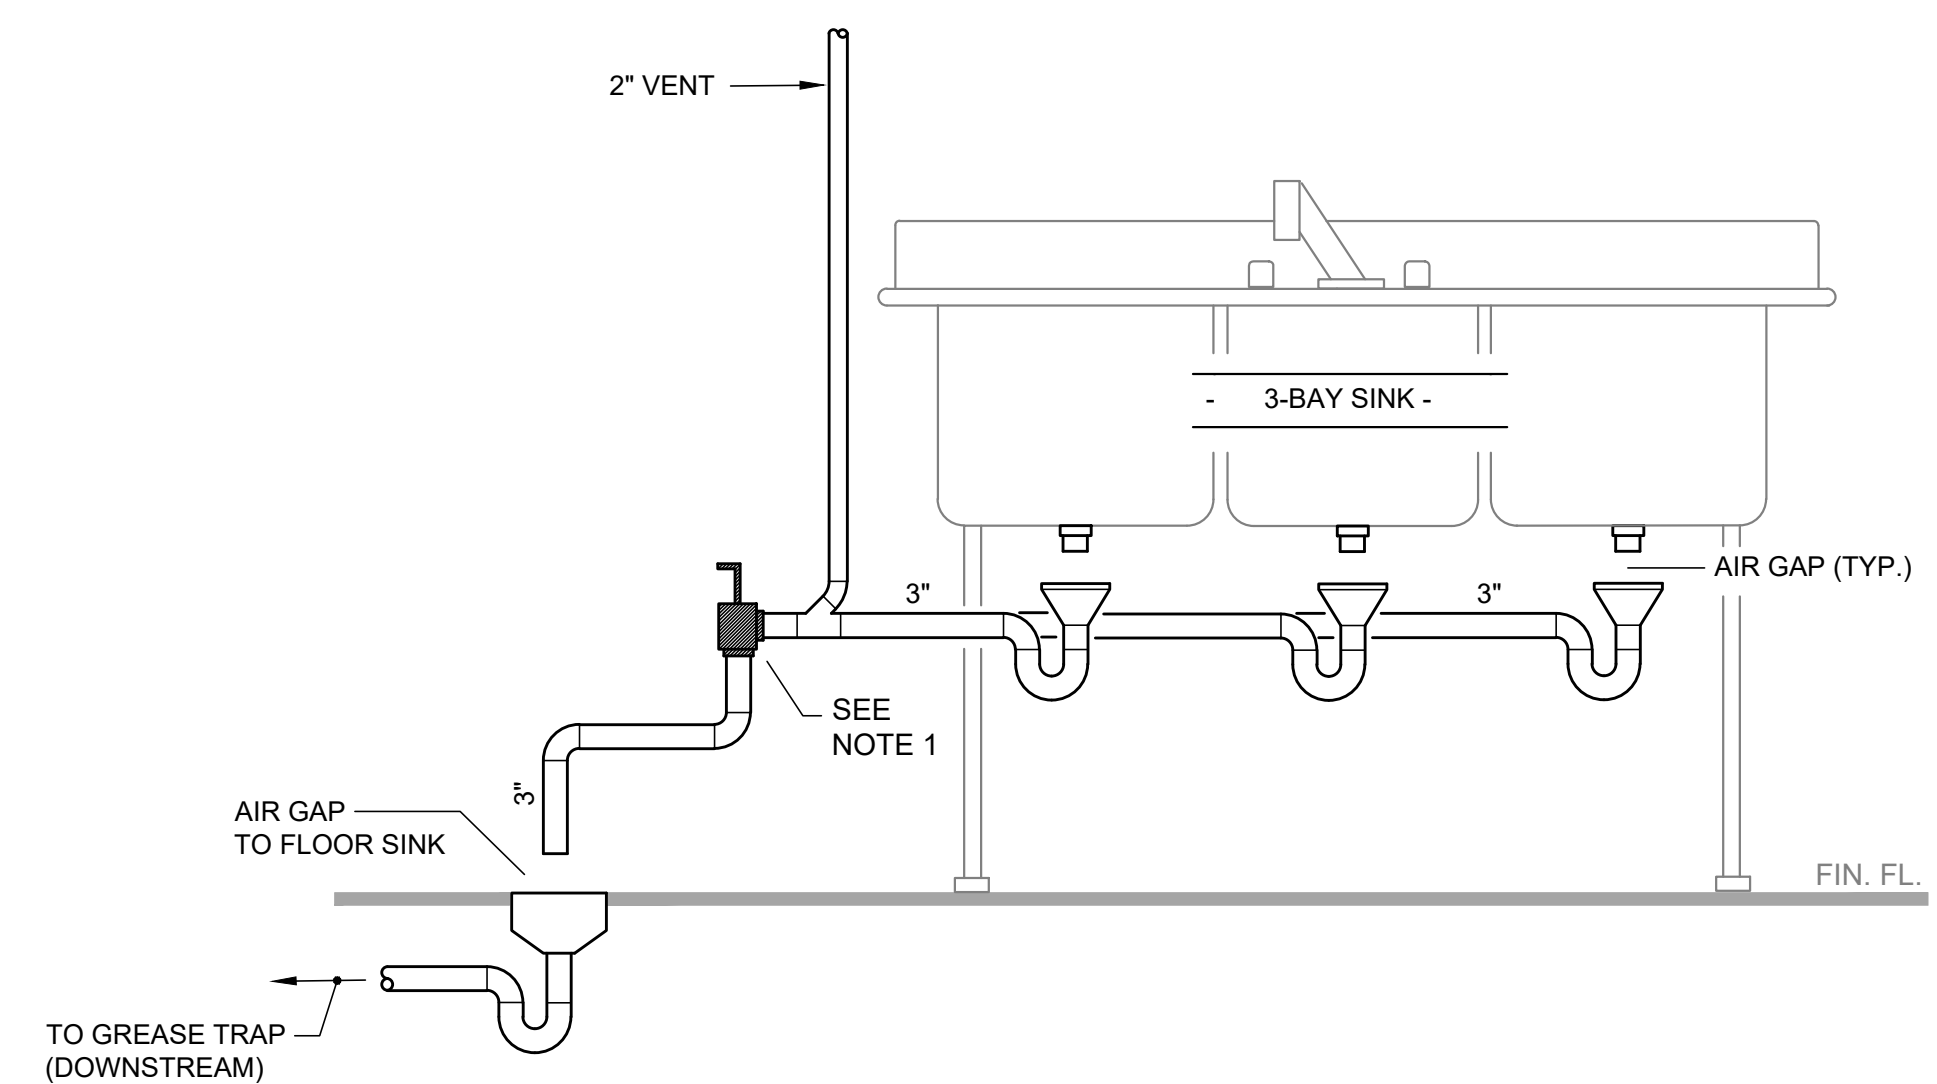

THREE-BAY SINK INSTALLATION DETAIL

NOTES:
 1. PROVIDE ANGLED FLOW CONTROL FITTING, ZURN MODEL Z1108-L. CENTERLINE OF FITTING SHALL BE INSTALLED AT A MAXIMUM OF 9-INCHES BELOW SINK BASIN.

DATE:	06/21/2023
DRAWN BY:	AOS
SCALE:	N.T.S.
REVIEWED BY:	TJH
PROJECT NO.:	20-2006
FILE:	



NO.	DATE	DESCRIPTION

PORT EWEN FIRE
DEPARTMENT, ULSTER, NEW
YORK

PLUMBING DETAILS

BID PLANS