


GAS FIRED WATER HEATER DETAIL

- LEGEND:
- DCWS DOMESTIC COLD WATER SUPPLY
 - DHWS DOMESTIC HOT WATER SUPPLY
 - DHWR DOMESTIC HOT WATER RETURN
 - TEMPERATURE AND PRESSURE RELIEF VALVE
 - GAS COCK
 - BALL VALVE
 - CIRCUIT BALANCE VALVE
 - UNION
 - CHECK VALVE
 - TEMPERATURE GAUGE


NOTE:

COORDINATE EXACT ROUTING OF INTAKE/VENT PIPING WITH STRUCTURE. DO NOT INSTALL EXCESSIVE OFFSETS/ELBOWS WHICH MAY CAUSE THE VENT/INTAKE PIPING TO EXCEED ALLOWABLE LENGTHS.


VENTING AND INTAKE PIPING SHALL BE INSTALLED IN ACCORDANCE WITH MANUF'S INSTRUCTIONS.

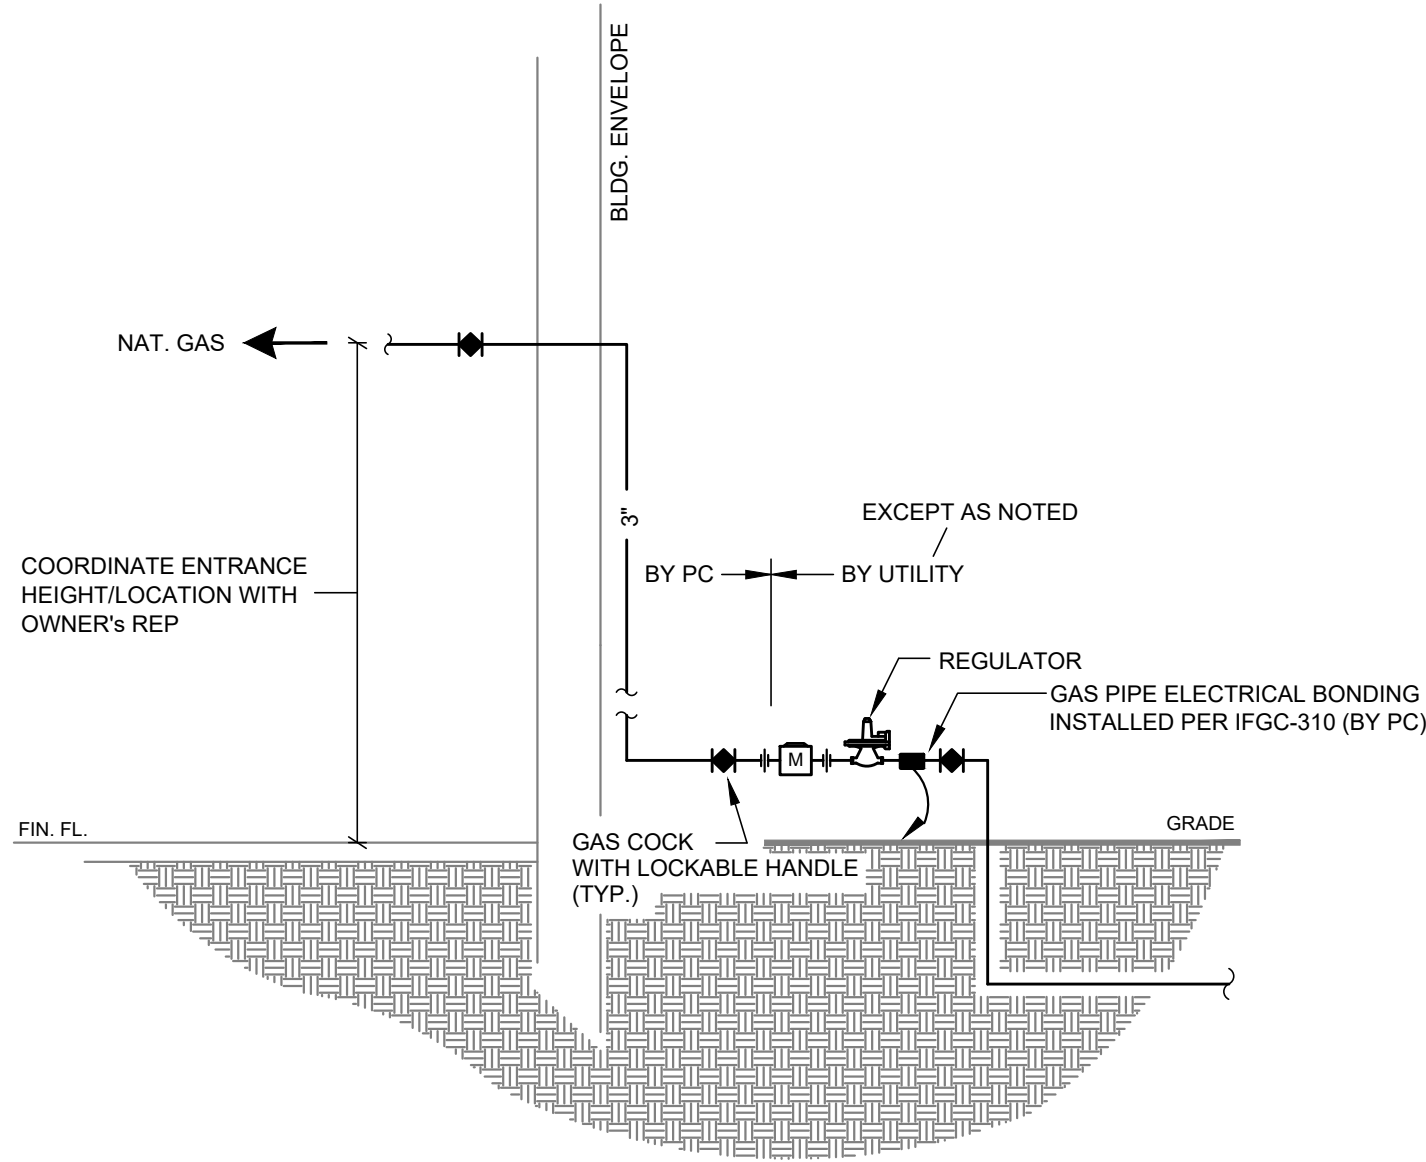


GAS SERVICE ENTRANCE DETAIL

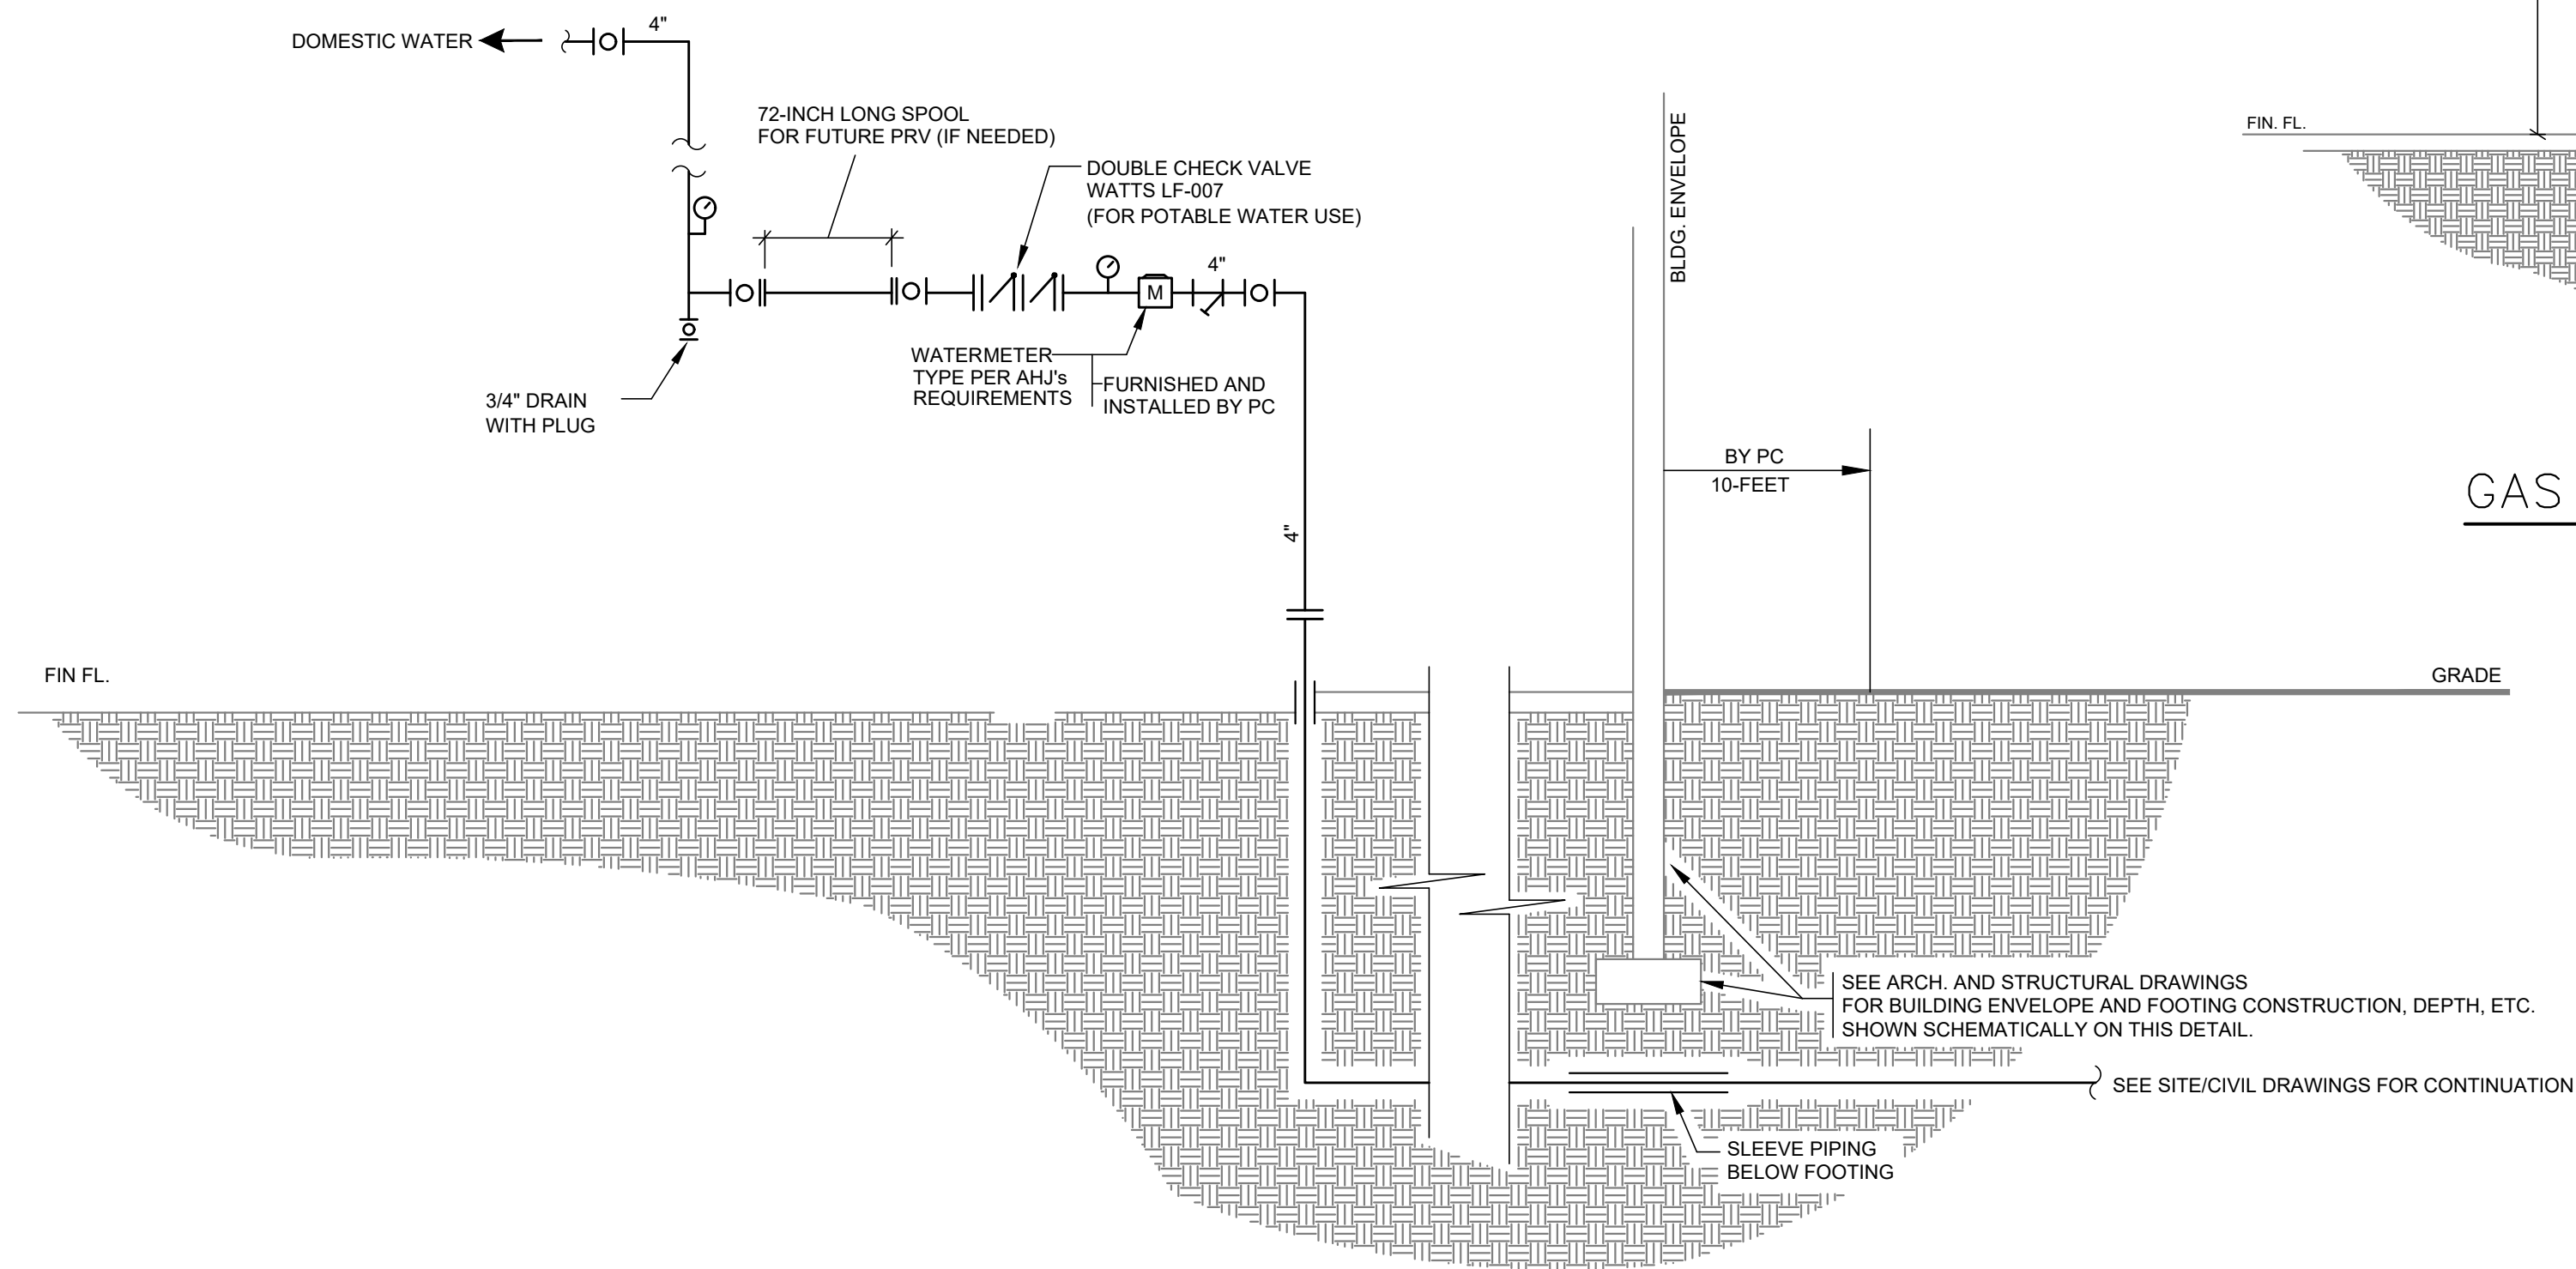

WATER SERVICE ENTRANCE DETAIL

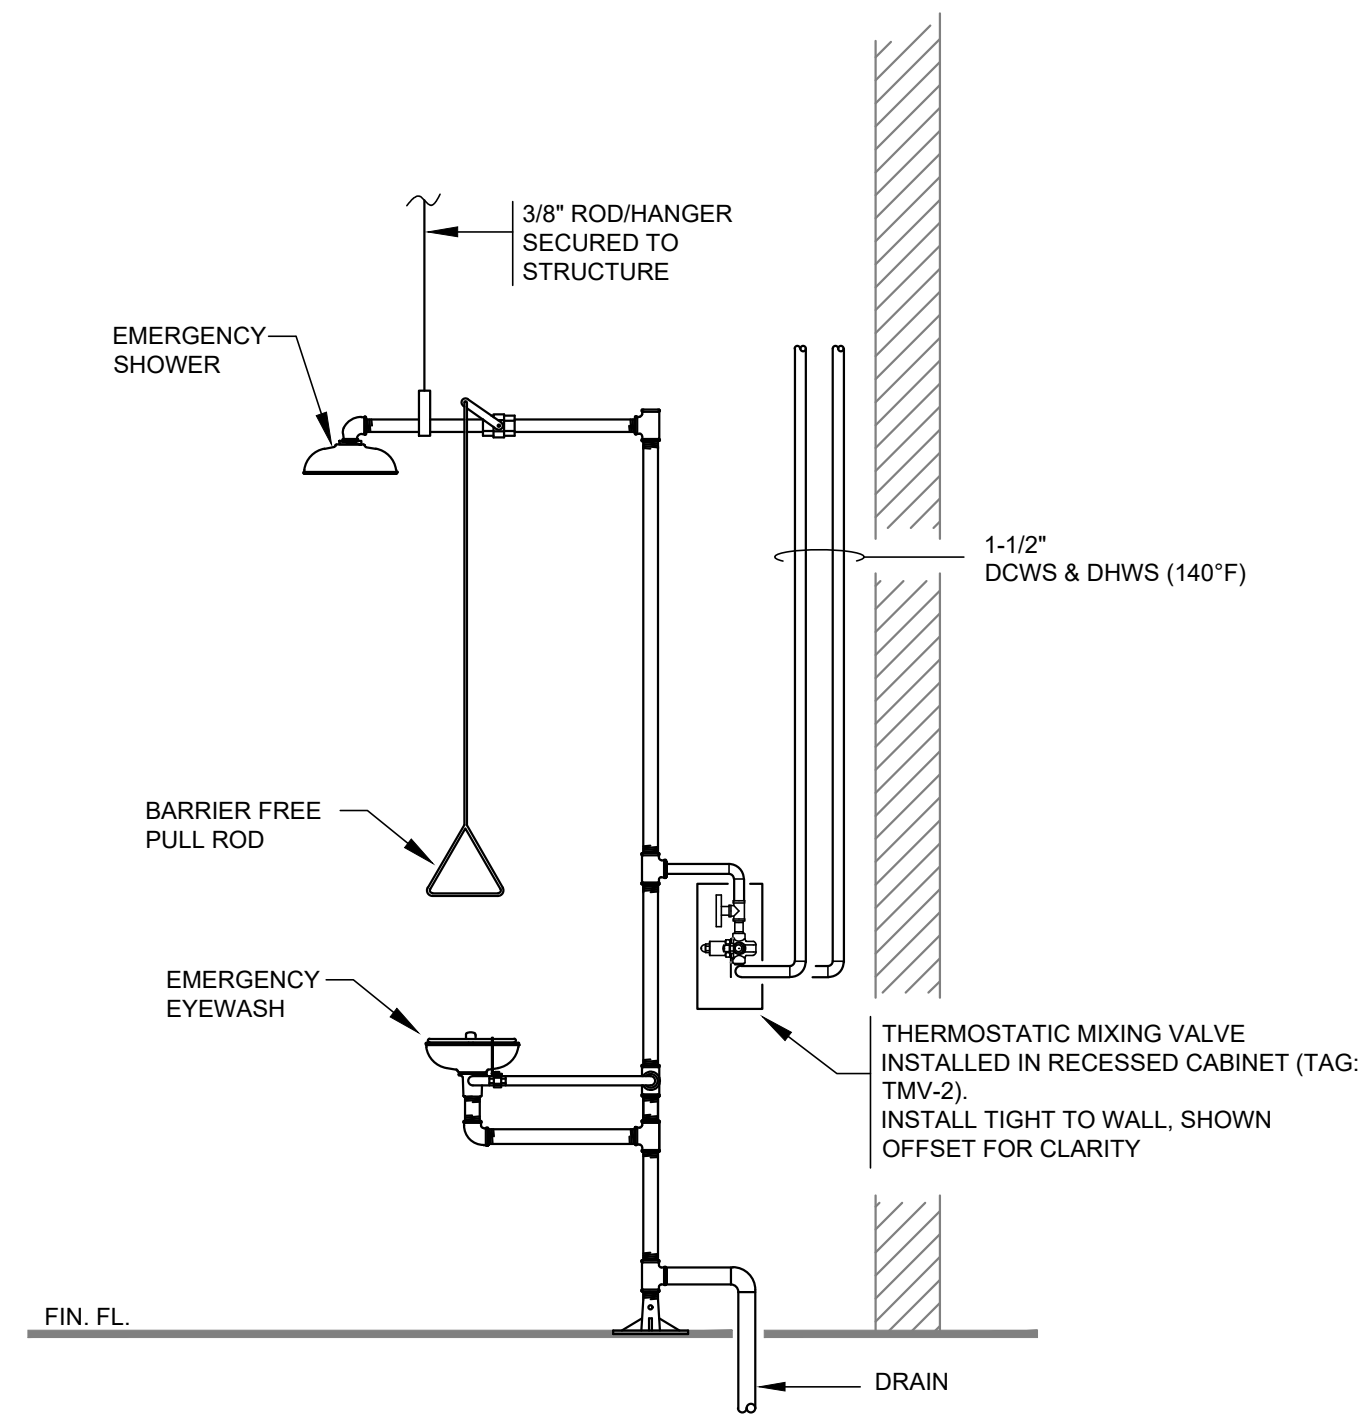


COMBINATION SHOWER/EYEWASH DETAIL

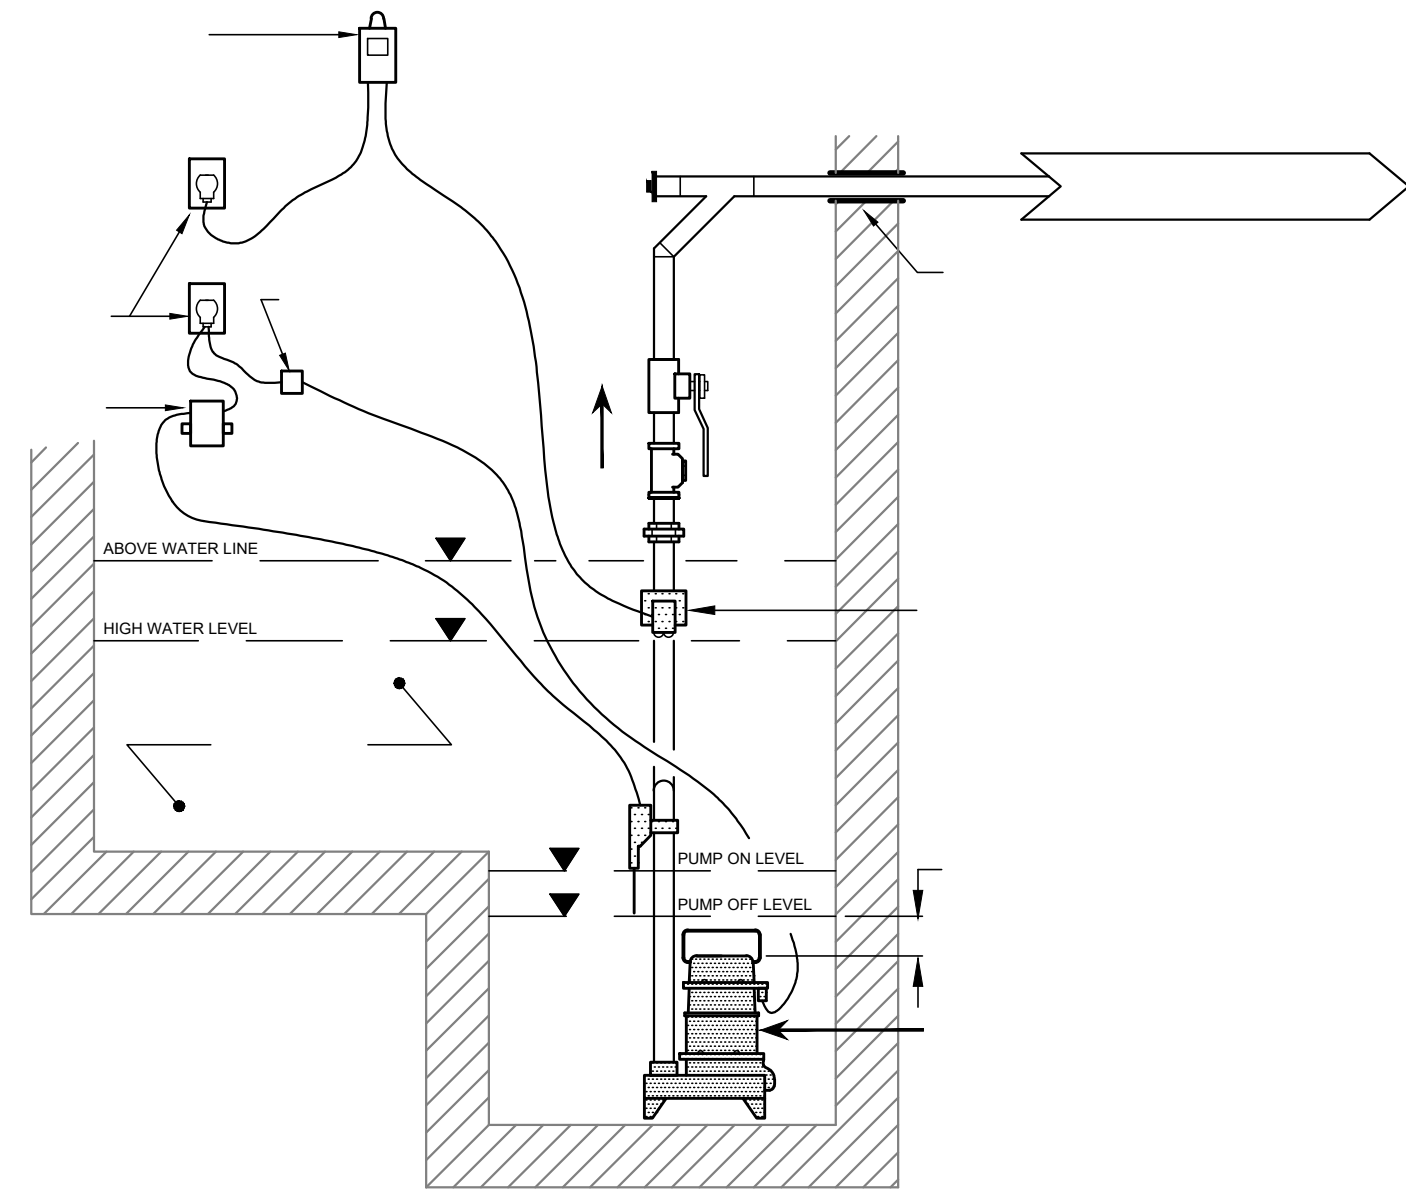

- LEGEND:
- -
 -

 ELEVATOR SUMP PUMP DETAIL



BID PLANS

DATE: 06/21/2023

DRAWN BY: AOS

SCALE: N.T.S.

REVIEWED BY: TJH

PROJECT NO.: 20-2006

FILE:



NO.	DATE	DESCRIPTION

PORT EWEN FIRE
DEPARTMENT, ULSTER, NEW
YORK

PLUMBING DETAILS

SHEET:
P503

WARNING - IT IS A VIOLATION OF NEW YORK EDUCATION LAW SECTION 7209.2, FOR ANY PERSON, UNLESS HE IS ACTING UNDER THE DIRECTION OF A LICENSED PROFESSIONAL ENGINEER OR LAND SURVEYOR, TO ALTER THIS DOCUMENT IN ANY WAY. IF ALTERED THE ALTERING PERSON SHALL COMPLY WITH THE REQUIREMENTS OF NEW YORK EDUCATION LAW SECTION 7209.2.