




7/2/21 3 Rockland Union Hill and Tallman PWS (a) Working Drawings (General) 21213 P-001.dwg Date Printed: 01/16/2023 10:08:32 AM

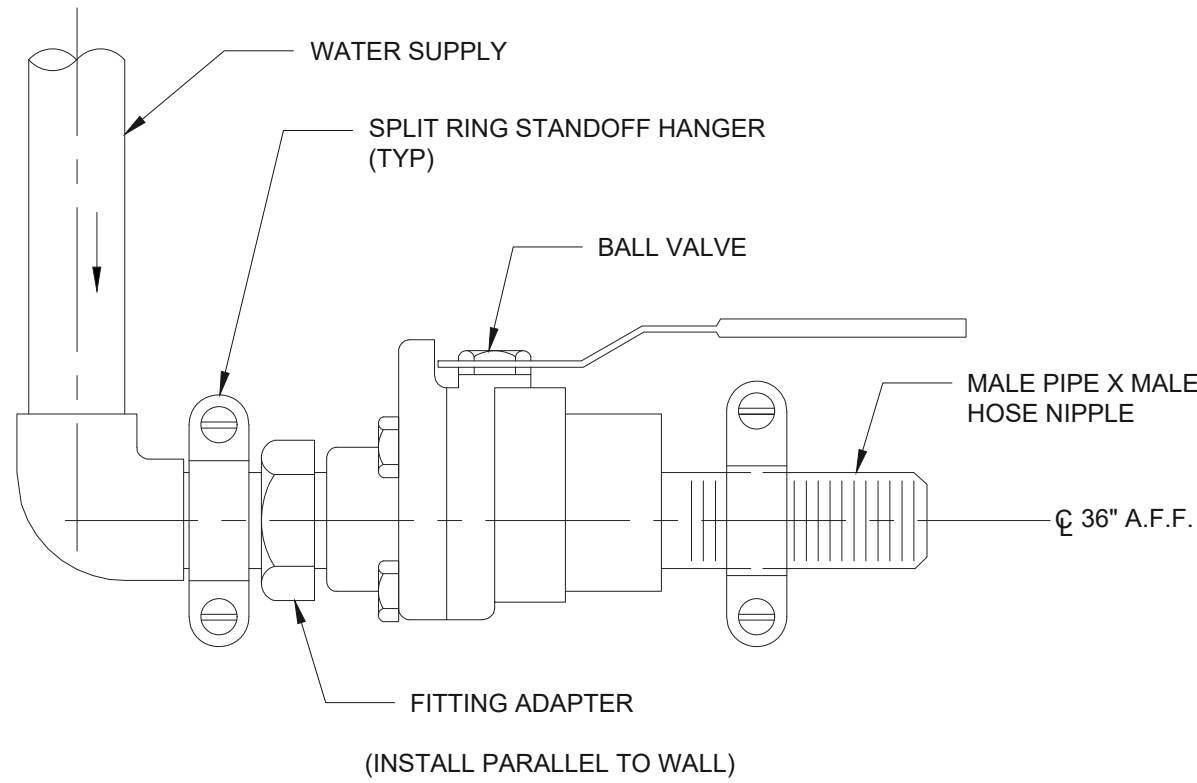


HOSE BIBB INSTALLATION
NOT TO SCALE

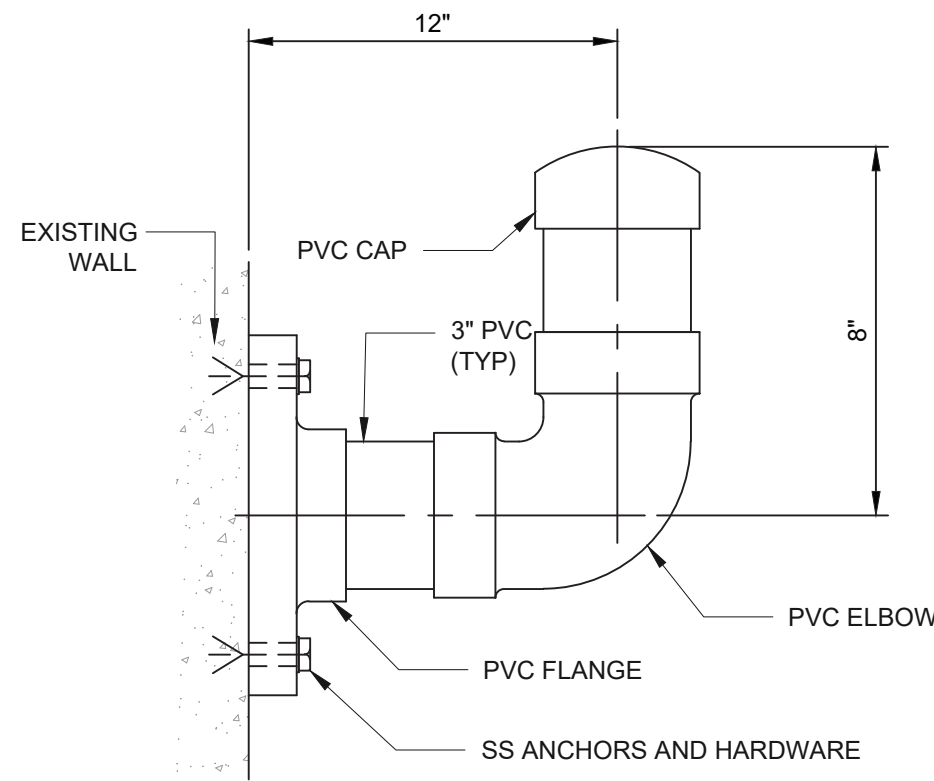


PVC HOSE RACK
NOT TO SCALE

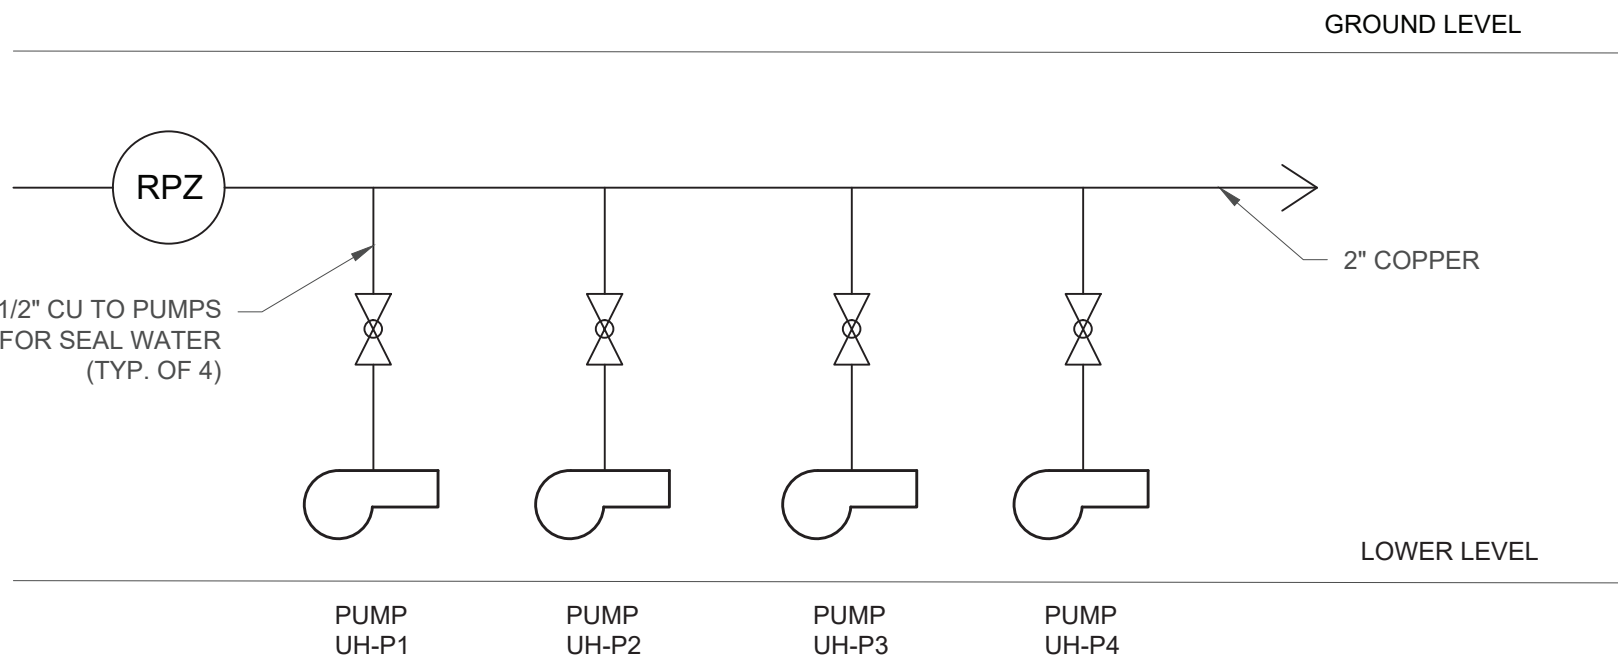

SEAL WATER RISER DIAGRAM
NOT TO SCALE

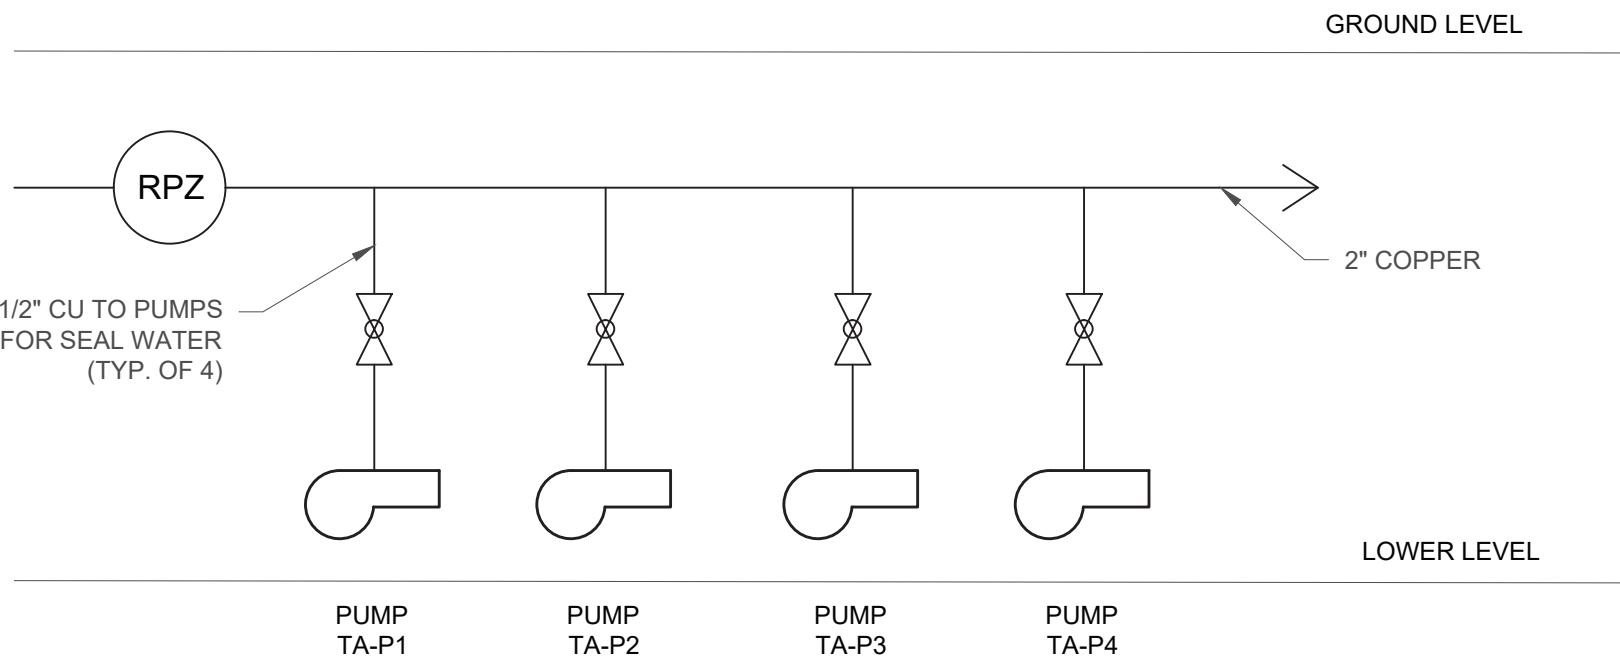

SEAL WATER RISER DIAGRAM
NOT TO SCALE

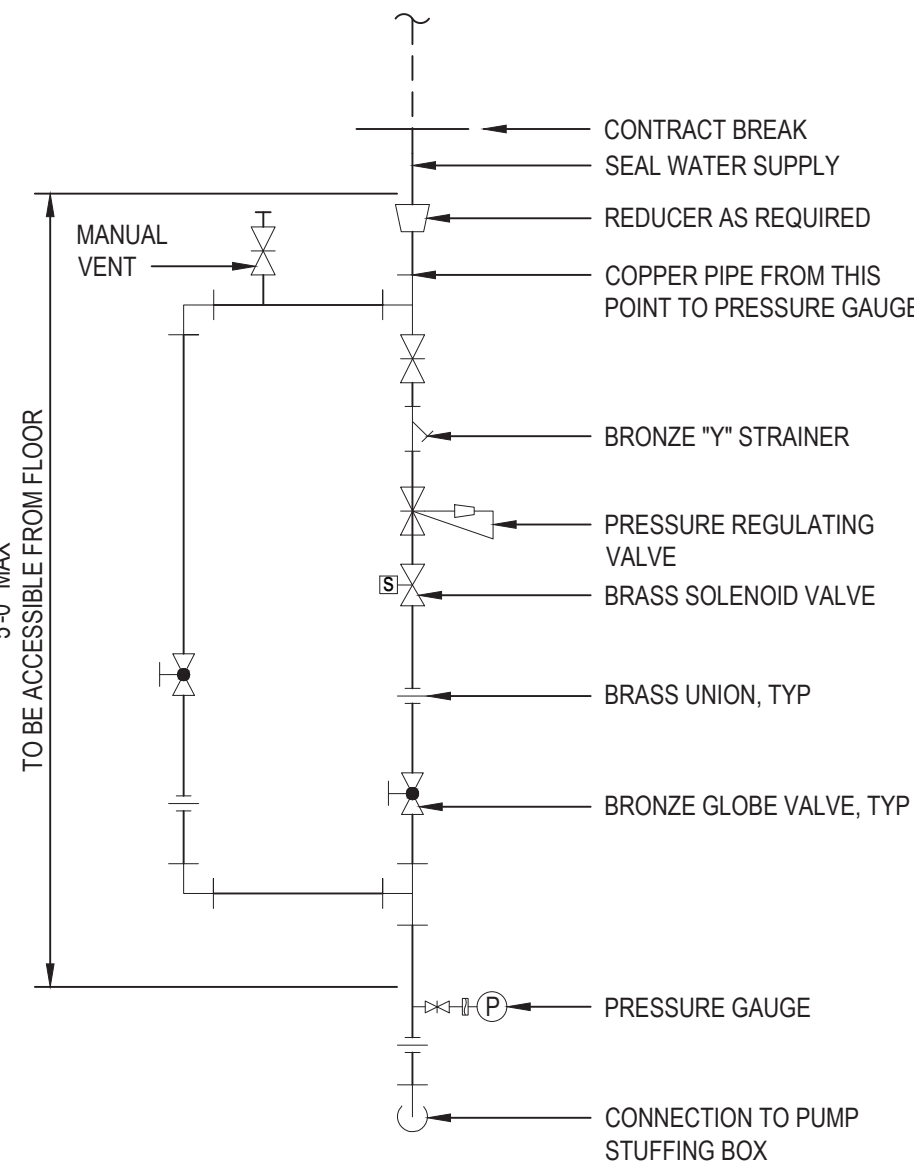

- NOTES:
- DIAPHRAGM SEAL AT PRESSURE GAUGE NOT REQUIRED IF POTABLE WATER USED AS SEAL WATER SUPPLY
 - SEAL WATER PIPING DOWNSTREAM OF REDUCER SAME SIZE AS STUFFING BOX CONNECTION WITH MINIMUM 3/8\"/>

SEAL WATER CONNECTION
NOT TO SCALE

©2021 Environmental Design & Research, Landscape Architecture, Engineering, & Environmental Services, D.P.C.
The following is paraphrased from the New York Education Law, Article 145, Section 7209, and Chapter II, Section 79-1.4, and applies to this drawing: "It is a violation of this law for any person unless he is acting under the direction of a licensed professional engineer, licensed landscape architect or licensed land surveyor to alter an item in any way, if an item bearing the seal of an engineer, landscape architect or land surveyor is altered, the altering engineer, landscape architect or land surveyor shall affix to the item his seal and the notation "altered by" followed by his signature and the date of such alteration and a specific description of the alteration".




EDR
a better environment


**Environmental
Design & Research,**
Landscape Architecture, Engineering
& Environmental Services, D.P.C.
217 Montgomery Street, Suite 1100
Syracuse, New York 13202
P. 315.471.0688

PROJECT TITLE: **UNION HILL AND TALLMAN
PUMP STATION UPGRADE**
PROJECT LOCATION: **ROCKLAND COUNTY, NEW YORK**
CLIENT: **ROCKLAND COUNTY SEWER DISTRICT No 1**
DRAWING TITLE: **PLUMBING DETAILS**

DRAWINGS ISSUED FOR / REVISIONS						EDR JOB# 21213	
CONTRACT 1	NO	DATE	ISSUED FOR / REVISION	BY	CHK	APP	SCALE: AS SHOWN DRAWN BY: TJF CHECKED BY: DRAWING NUMBER: P-001
	1	04/22	60 PERCENT DESIGN REVIEW	MJL			
	2	07/22	90 PERCENT DESIGN REVIEW	MJL	RRS	MET	
	3	09/22	FOR REGULATORY REVIEW	MJL	RRS	MET	
	4	01/23	100 PERCENT DESIGN REVIEW	MJL	RRS	MET	
	5	03/23	100 PERCENT DESIGN REVIEW	MJL	RRS	MET	
	6	06/23	FOR BID	MJL	RRS	MET	

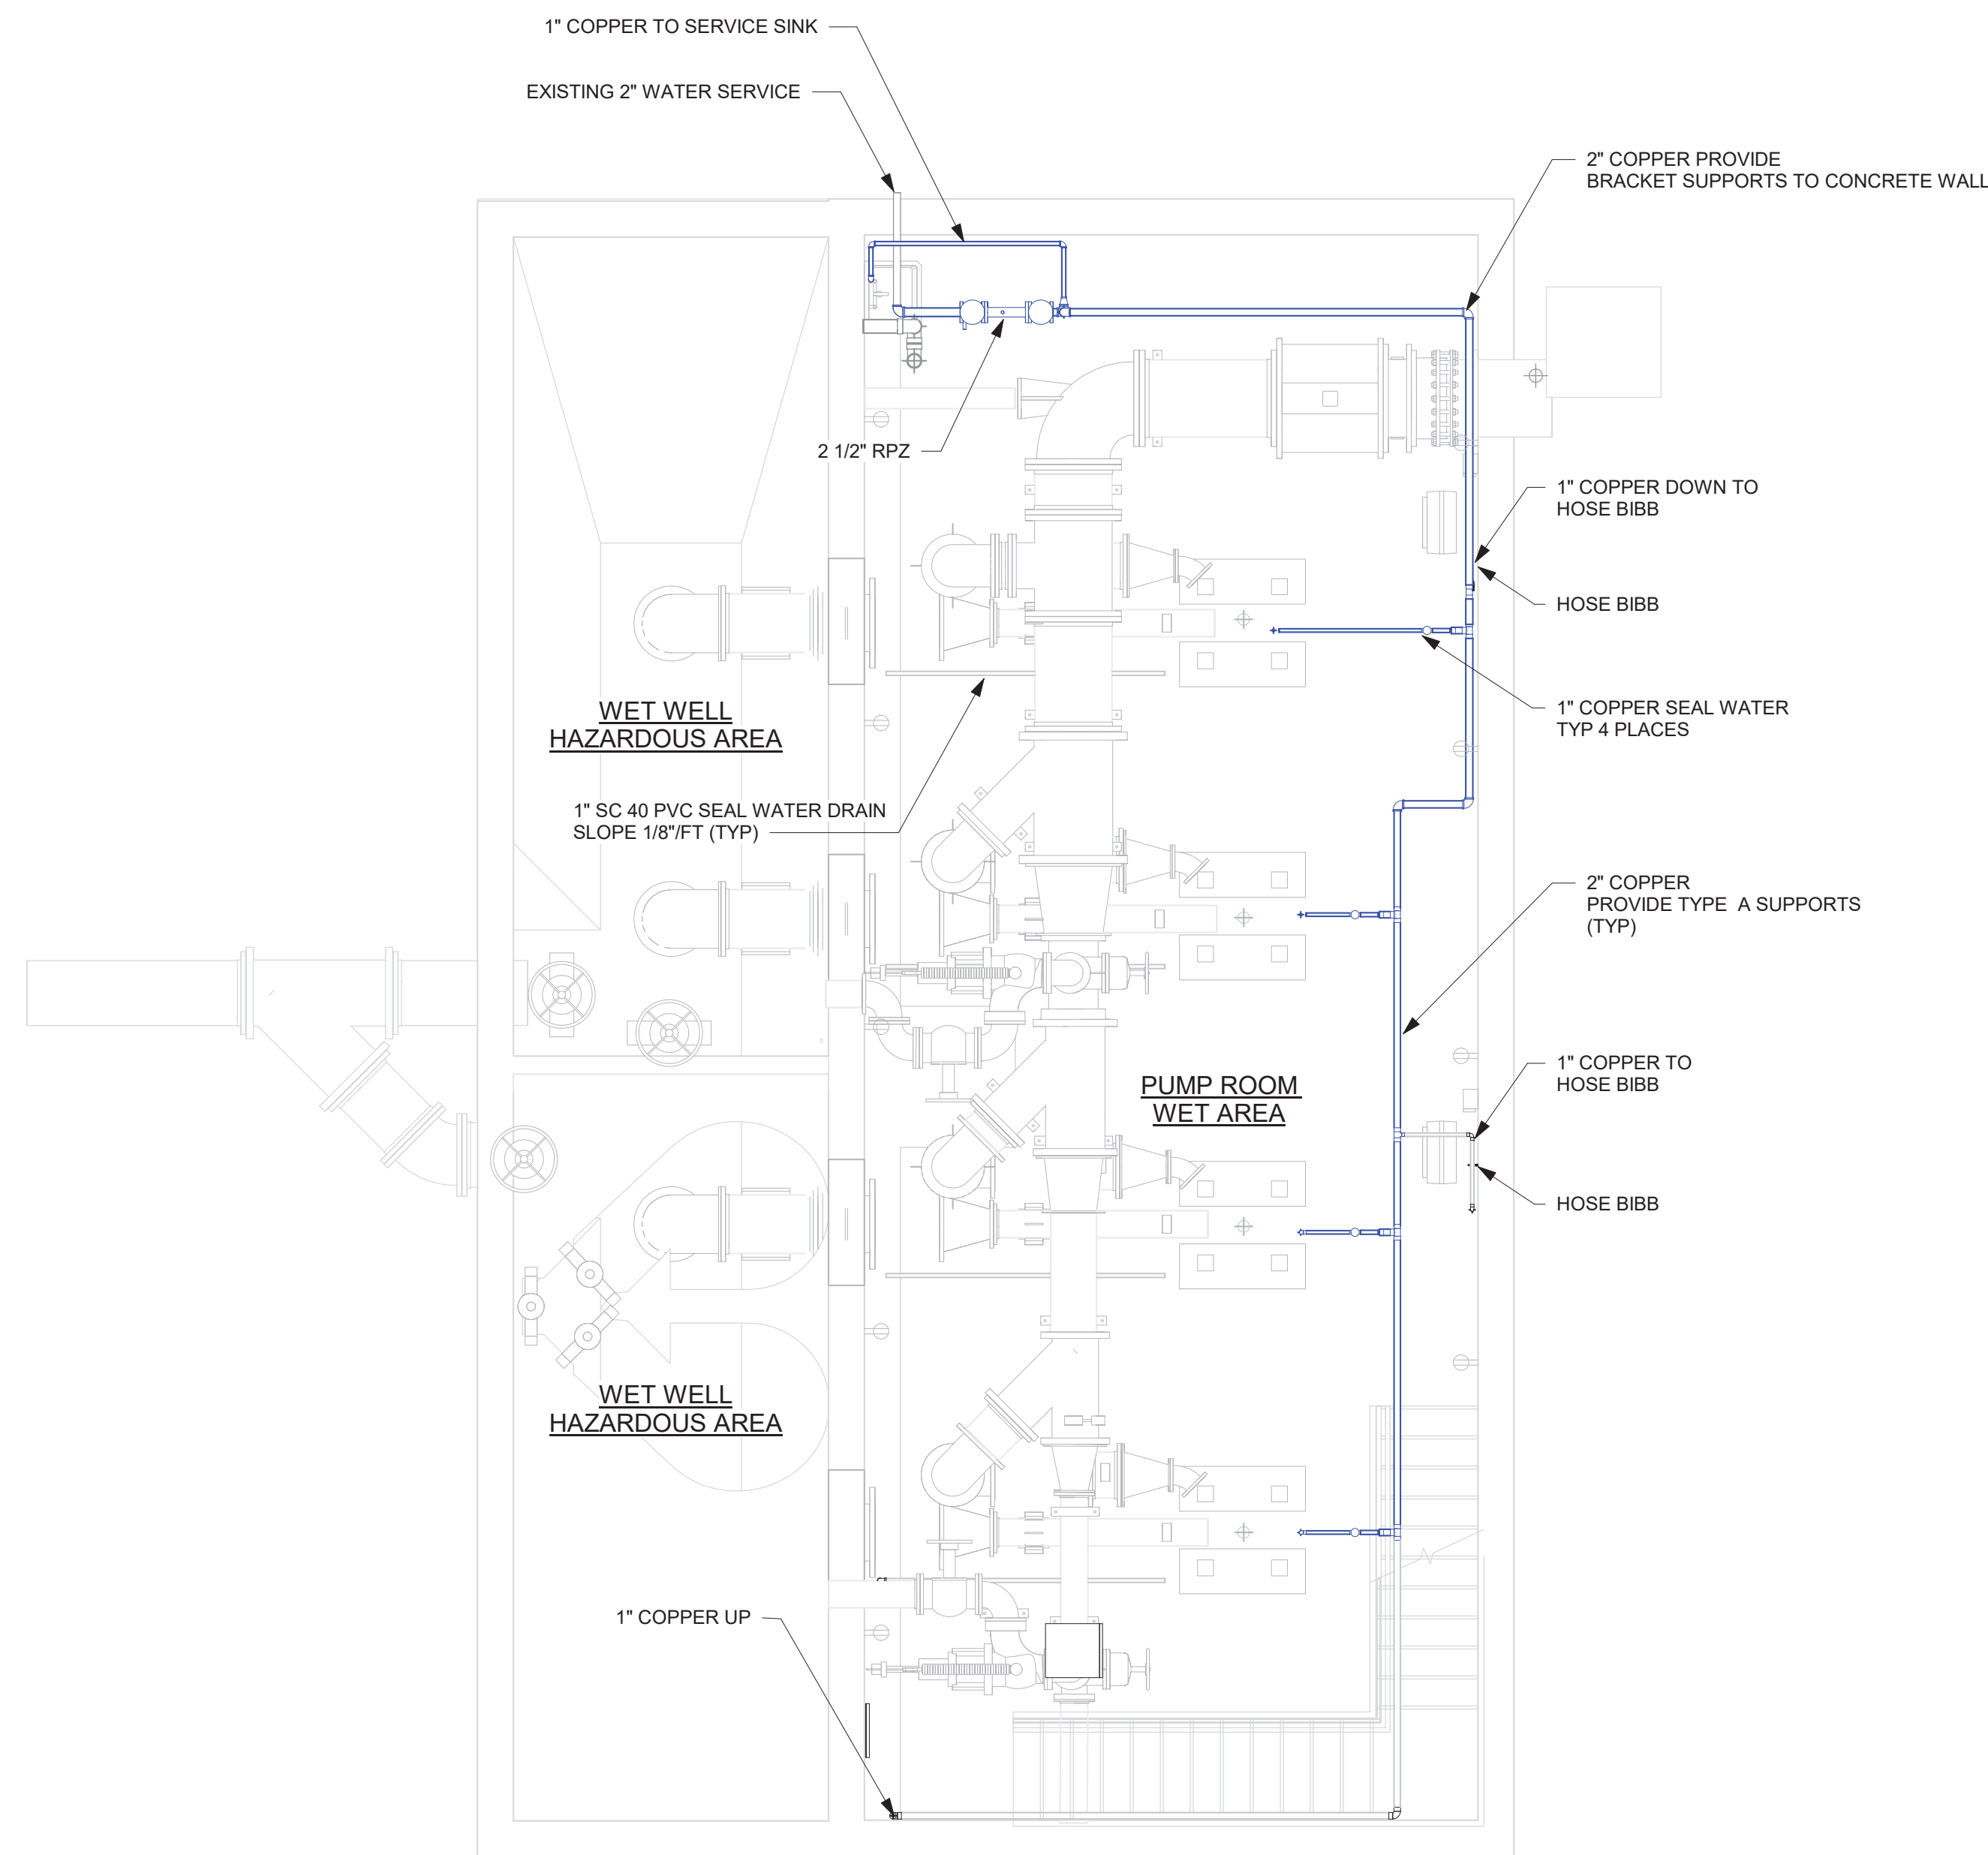

① LOWER LEVEL PLAN - PLUMBING
1/4" = 1'-0"

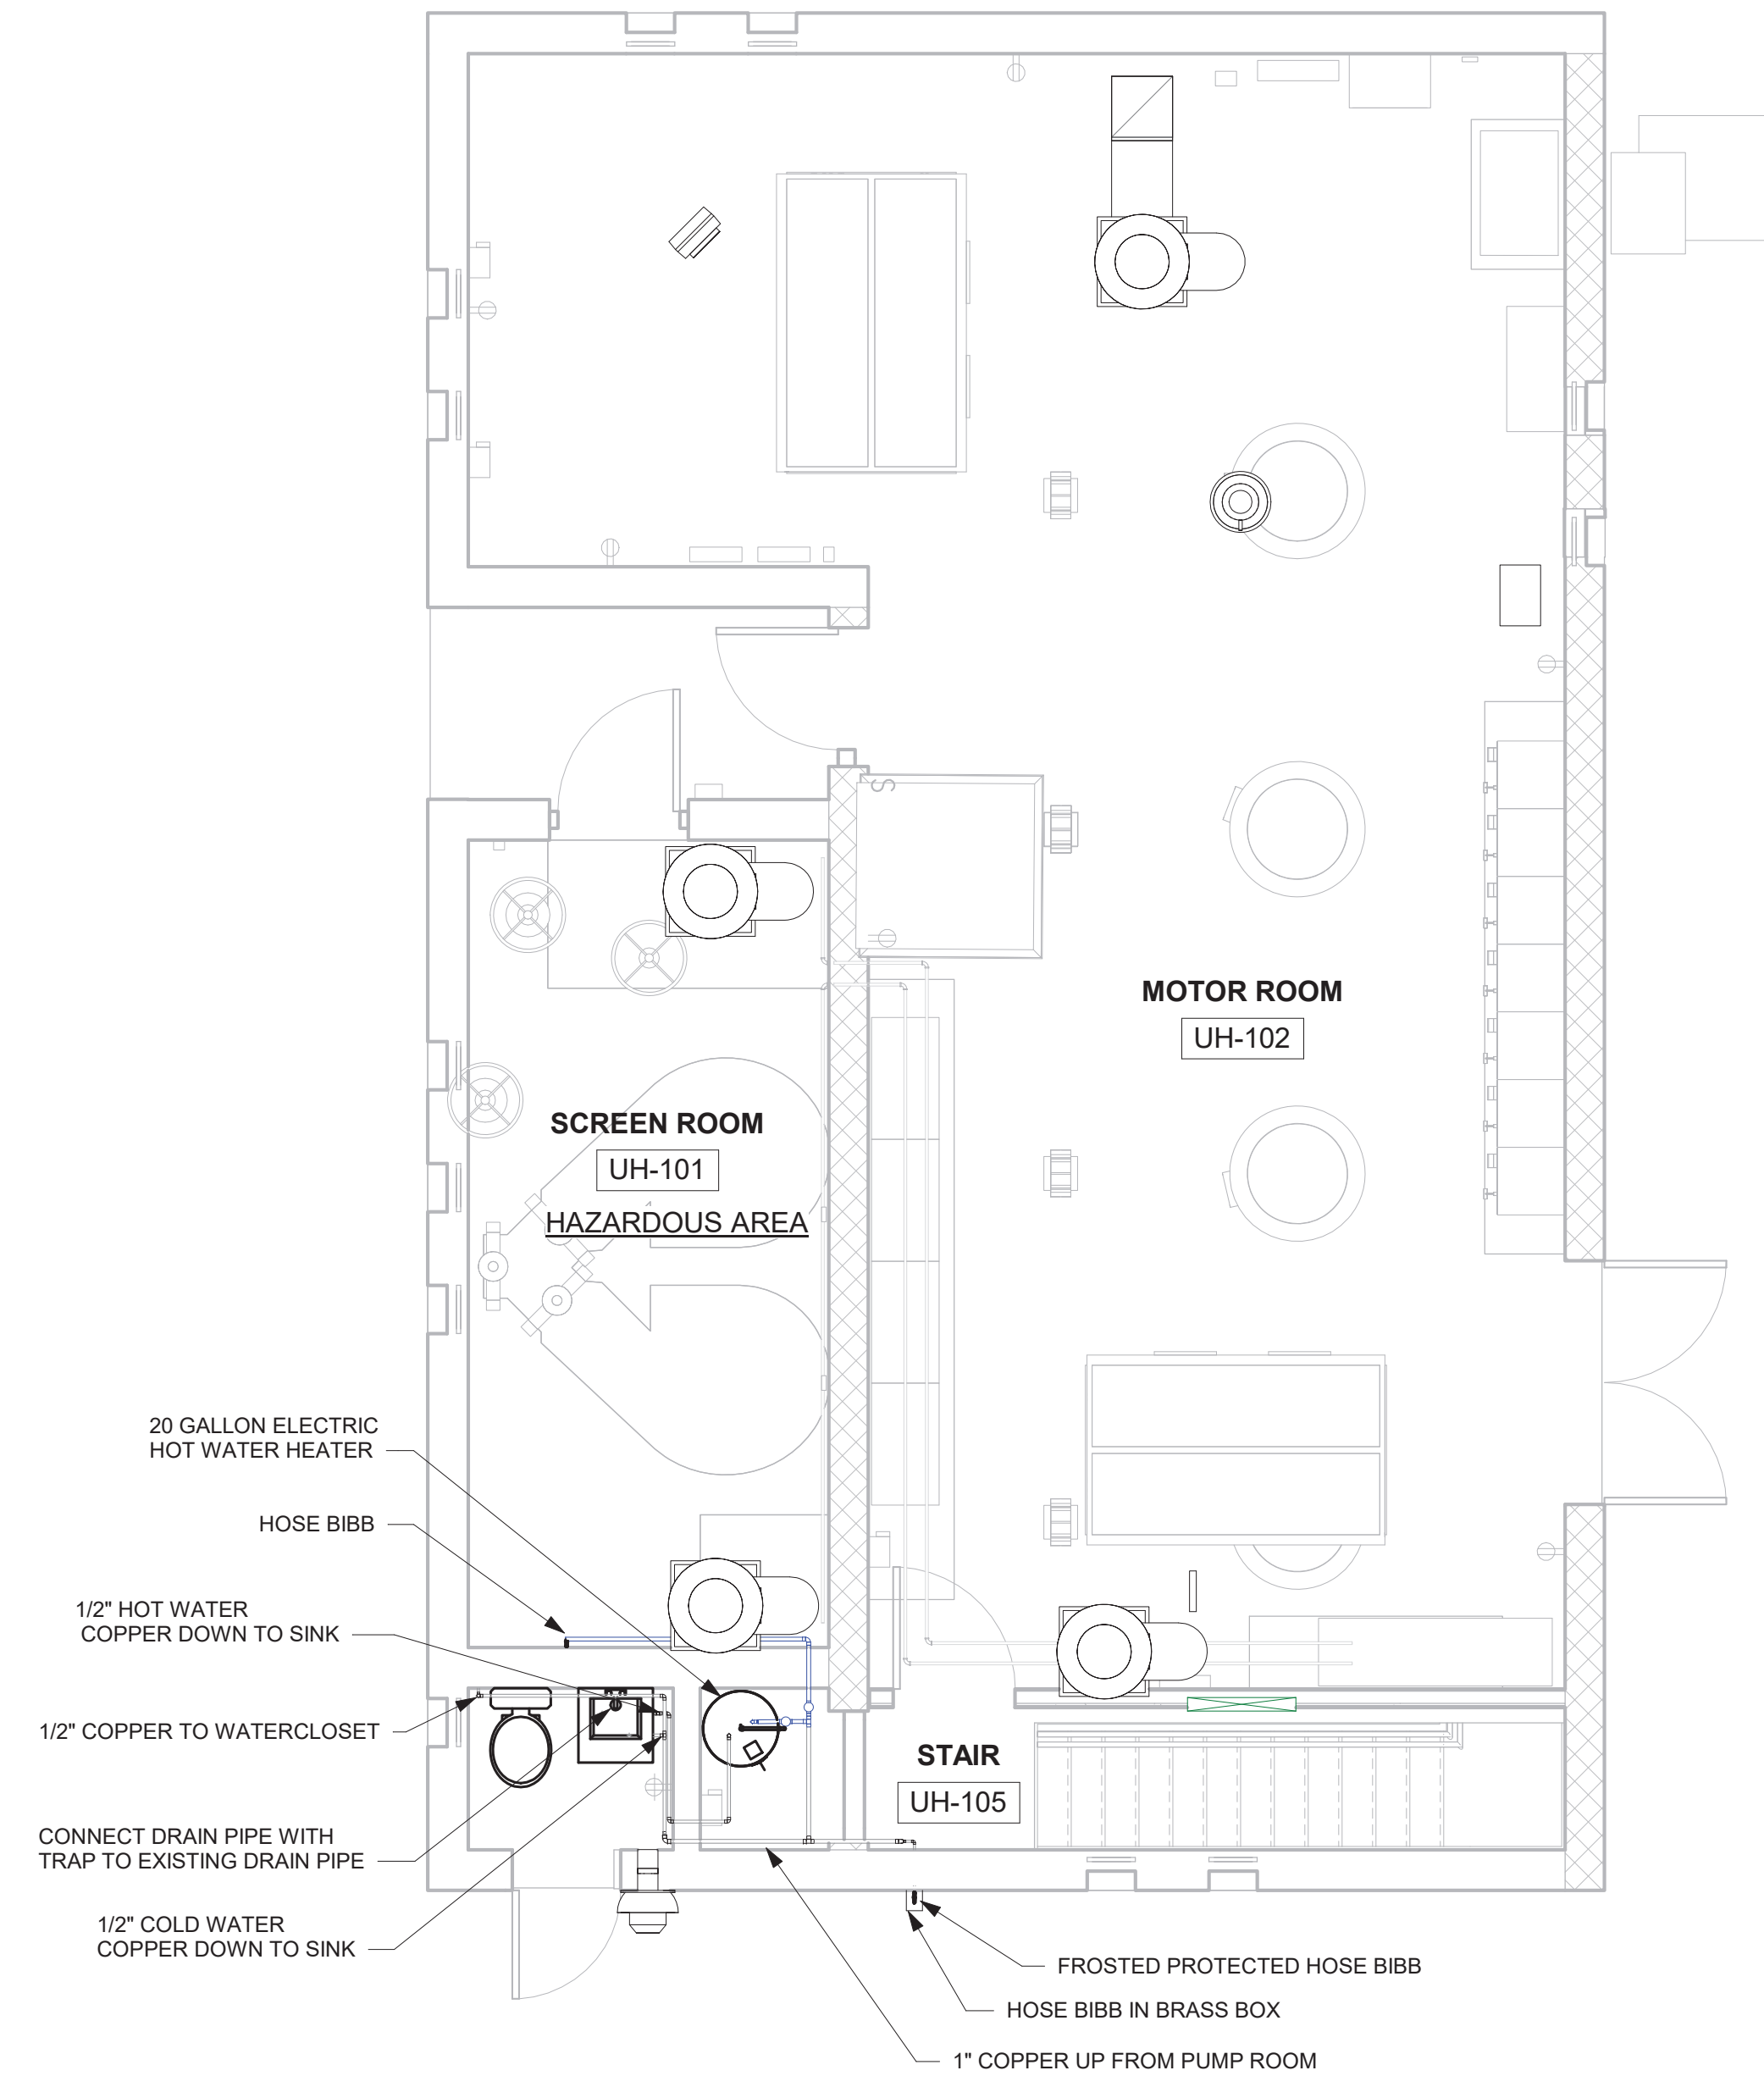

② GROUND FLOOR - PLUMBING
1/4" = 1'-0"



EDR
a better environment

**Environmental
Design & Research,**
Landscape Architecture, Engineering
& Environmental Services, D.P.C.
217 Montgomery Street, Suite 1100
Syracuse, New York 13202
P. 315.471.0688

PROJECT TITLE: **UNION HILL PUMP AND TALLMAN
AVE PUMP STATION UPGRADE**

PROJECT LOCATION: ROCKLAND COUNTY, NEW YORK

CLIENT: ROCKLAND COUNTY SEWER DISTRICT NO 1

DRAWING TITLE: **UNION HILL PUMP STATION LOWER AND GROUND FLOOR PLANS PLUMBING**

DRAWINGS ISSUED FOR / REVISIONS

NO.	DATE	ISSUED FOR / REVISIONS	BY	CHK	APP	DATE
1	04/22	60 PERCENT DESIGN REVIEW	LSE	JGD	GRL	06/2023
2	07/22	90 PERCENT DESIGN REVIEW	LSE	JGD	GRL	SCALE: 1/4" = 1'-0"
3	09/22	FOR REGULATORY REVIEW	MJL	RRS	MET	DRAWN BY: MJL
4	01/23	100 PERCENT DESIGN REVIEW	MJL	RRS	MET	CHECKED BY:
5	03/23	100 PERCENT DESIGN REVIEW	MJL	RRS	MET	DRAWING NUMBER:
6						

CONTRACT
1

CONTRACT # RFB-RC-SWR-2022-06

EDR JOB #: 21213

DATE: 06/2023


SCALE: 1/4" = 1'-0"

DRAWN BY: MJL

CHECKED BY:

DRAWING NUMBER:

P-101

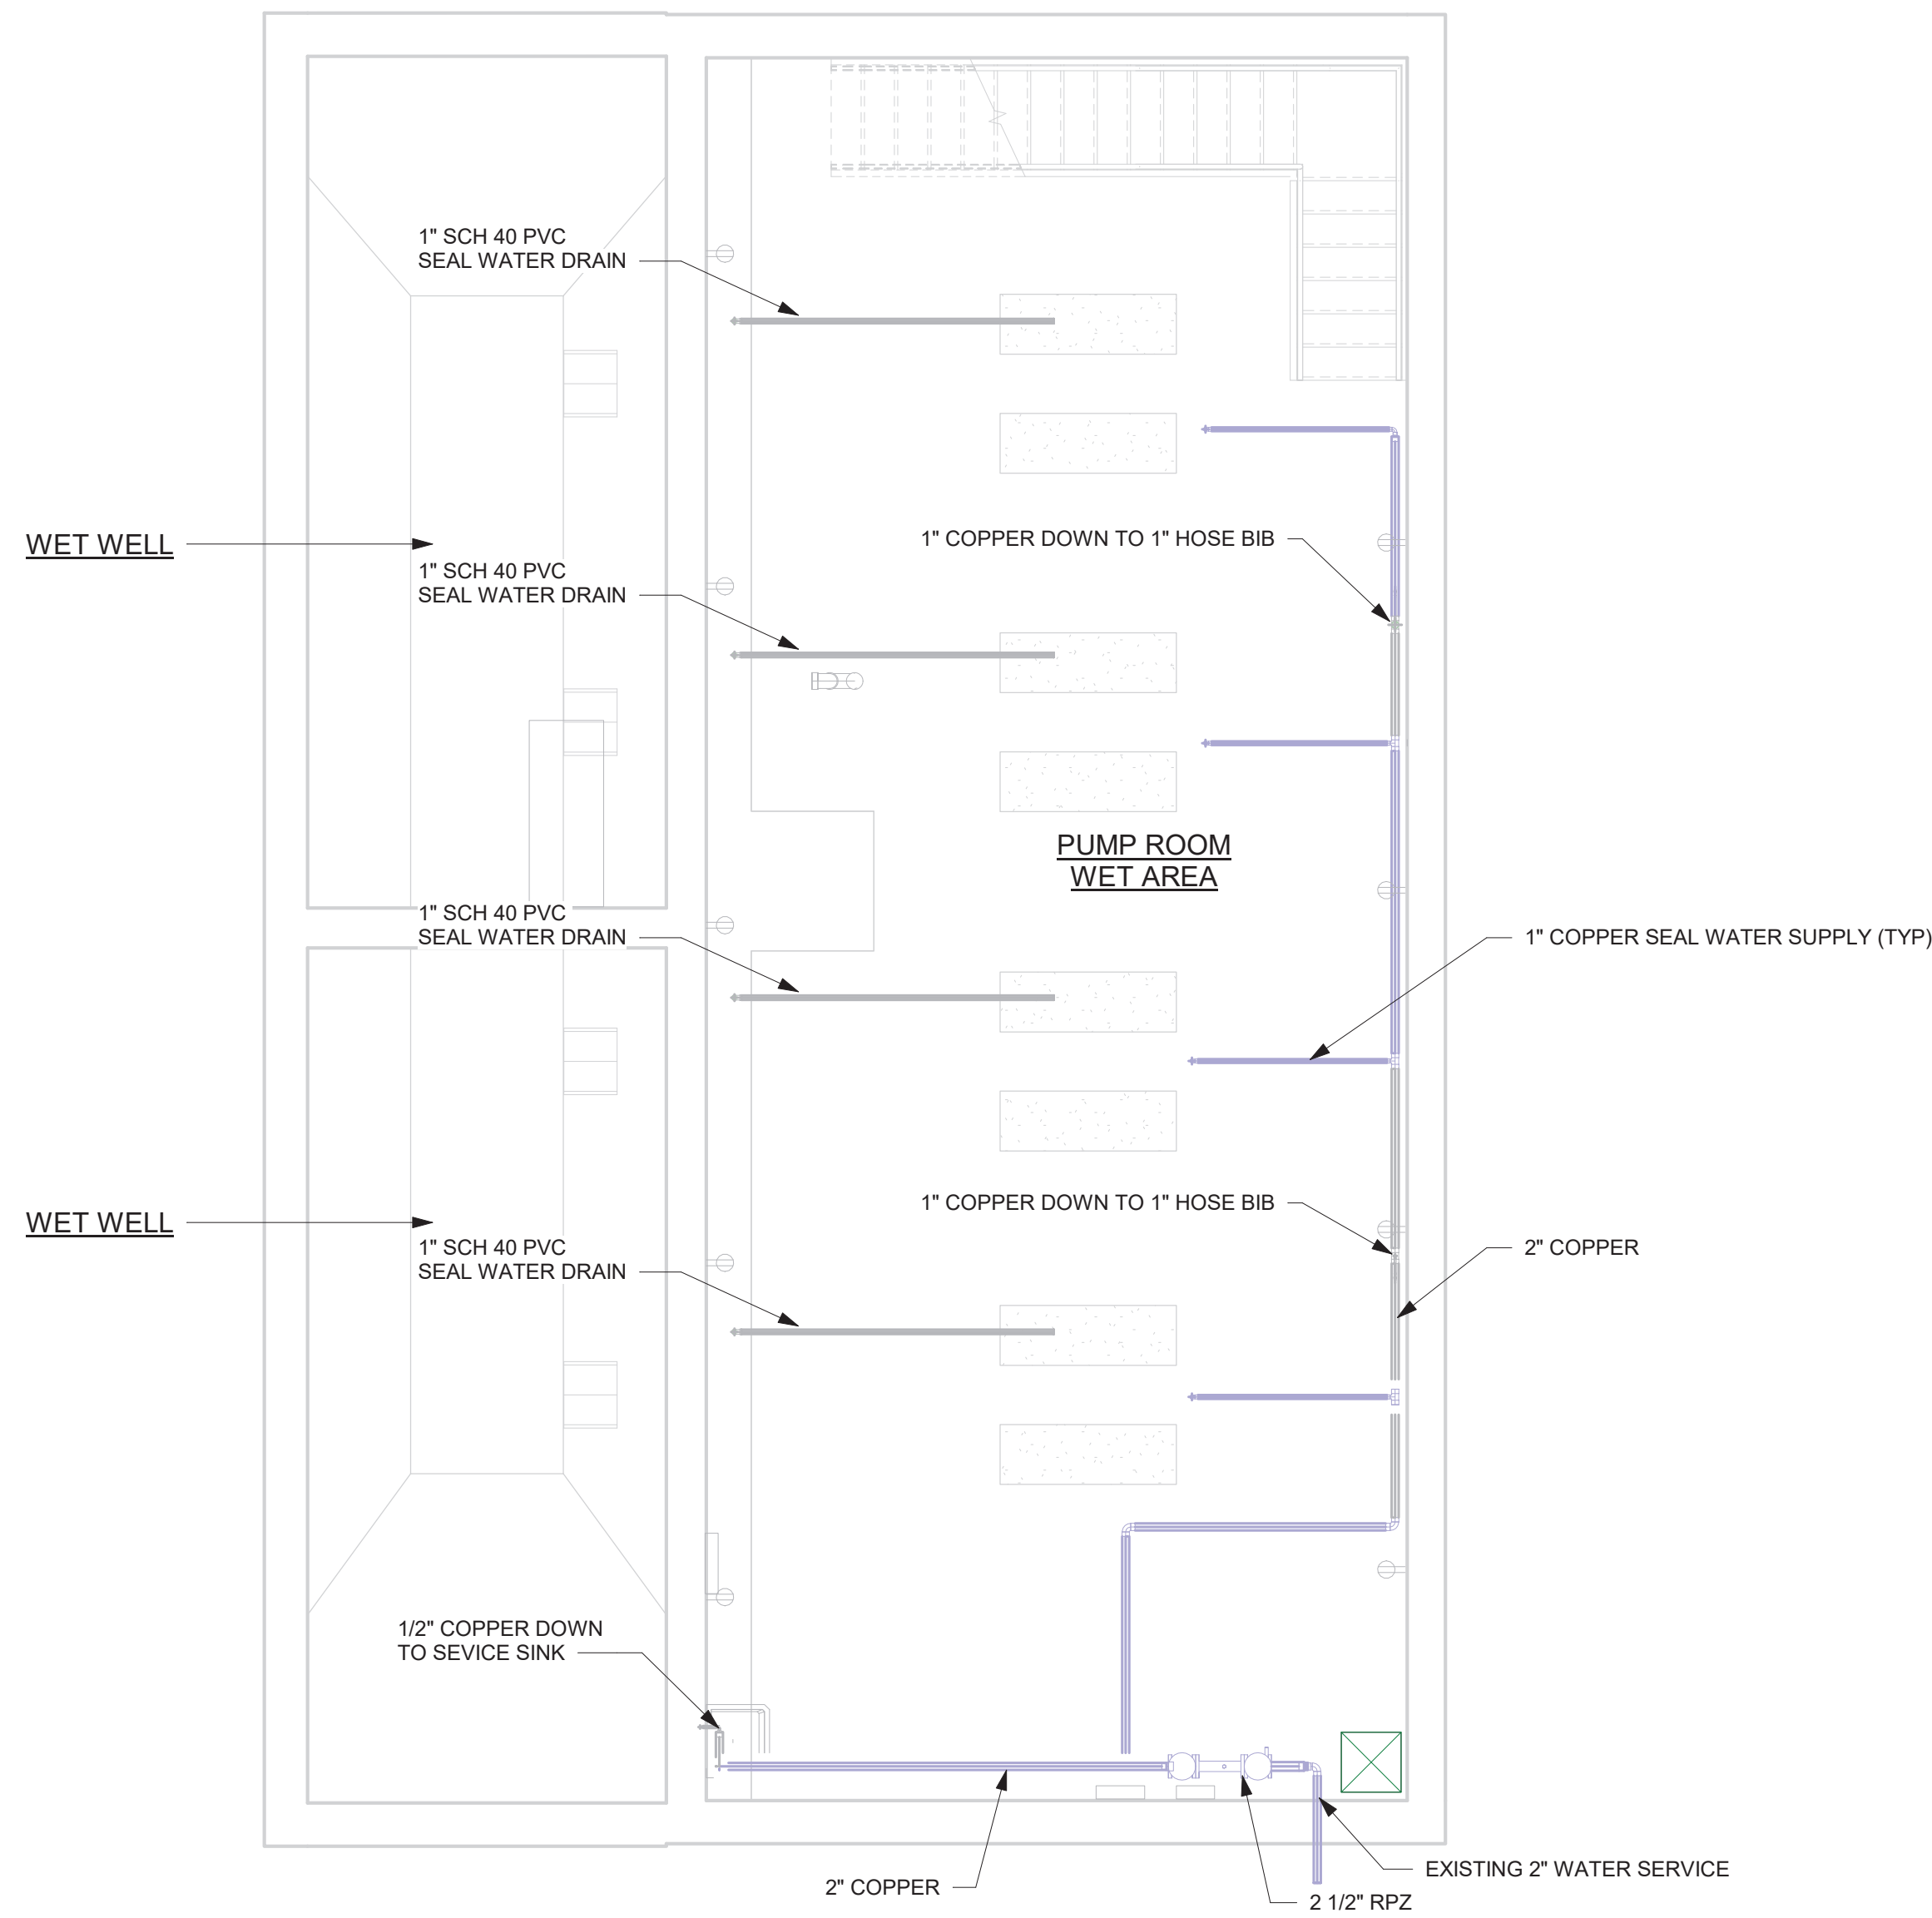

1 LOWER FLOOR - PLUMBING
1/4" = 1'-0"



**Environmental
Design & Research,**
Landscape Architecture, Engineering
& Environmental Services, D.P.C.
217 Montgomery Street, Suite 1100
Syracuse, New York 13202
P. 315.471.0688

PROJECT TITLE: UNION HILL AND TALLMAN AVE PUMP STATION UPGRADE				DRAWINGS ISSUED FOR / REVISIONS						CONTRACT # RFB-RC-SWR-2022-06	
				NO.	DATE	ISSUED FOR / REVISIONS	BY	CHK	APP	EDR JOB #: 21213	
PROJECT LOCATION: ROCKLAND COUNTY, NEW YORK				1	04/22	60 PERCENT DESIGN REVIEW	LSE	JGD	GRL	DATE: 06/2023	
CLIENT: ROCKLAND COUNTY SEWER DISTRICT No. 1				2	07/22	90 PERCENT DESIGN REVIEW	LSE	JGD	GRL	SCALE: 1/4" = 1'-0"	
DRAWING TITLE: TALLMAN PUMP STATION LOWER LEVEL PLUMBING				3	09/22	FOR REGULATORY REVIEW	MJL	RRS	MET	DRAWN BY: MJL	
CONTRACT 1				4	01/23	100 PERCENT DESIGN REVIEW	MJL	RRS	MET	CHECKED BY:	
				5	03/23	100 PERCENT DESIGN REVIEW	MJL	RRS	MET	DRAWING NUMBER:	
				6						P-201	