


- NOTES:
- REFER TO DRAWING G1 FOR SYMBOLS AND ABBREVIATIONS.
 - REFER TO DRAWING E5 FOR SWITCHBOARD AND PANELBOARD SCHEDULES.
 - CIRCUIT NUMBERS CORRESPOND TO RESPECTIVE CIRCUIT BREAKER IN PANELS AS INDICATED BELOW:
1 - DENOTES CIRCUIT 1 IN NEW 208/120V, 3 ϕ UTILITY PANEL 'UP.'

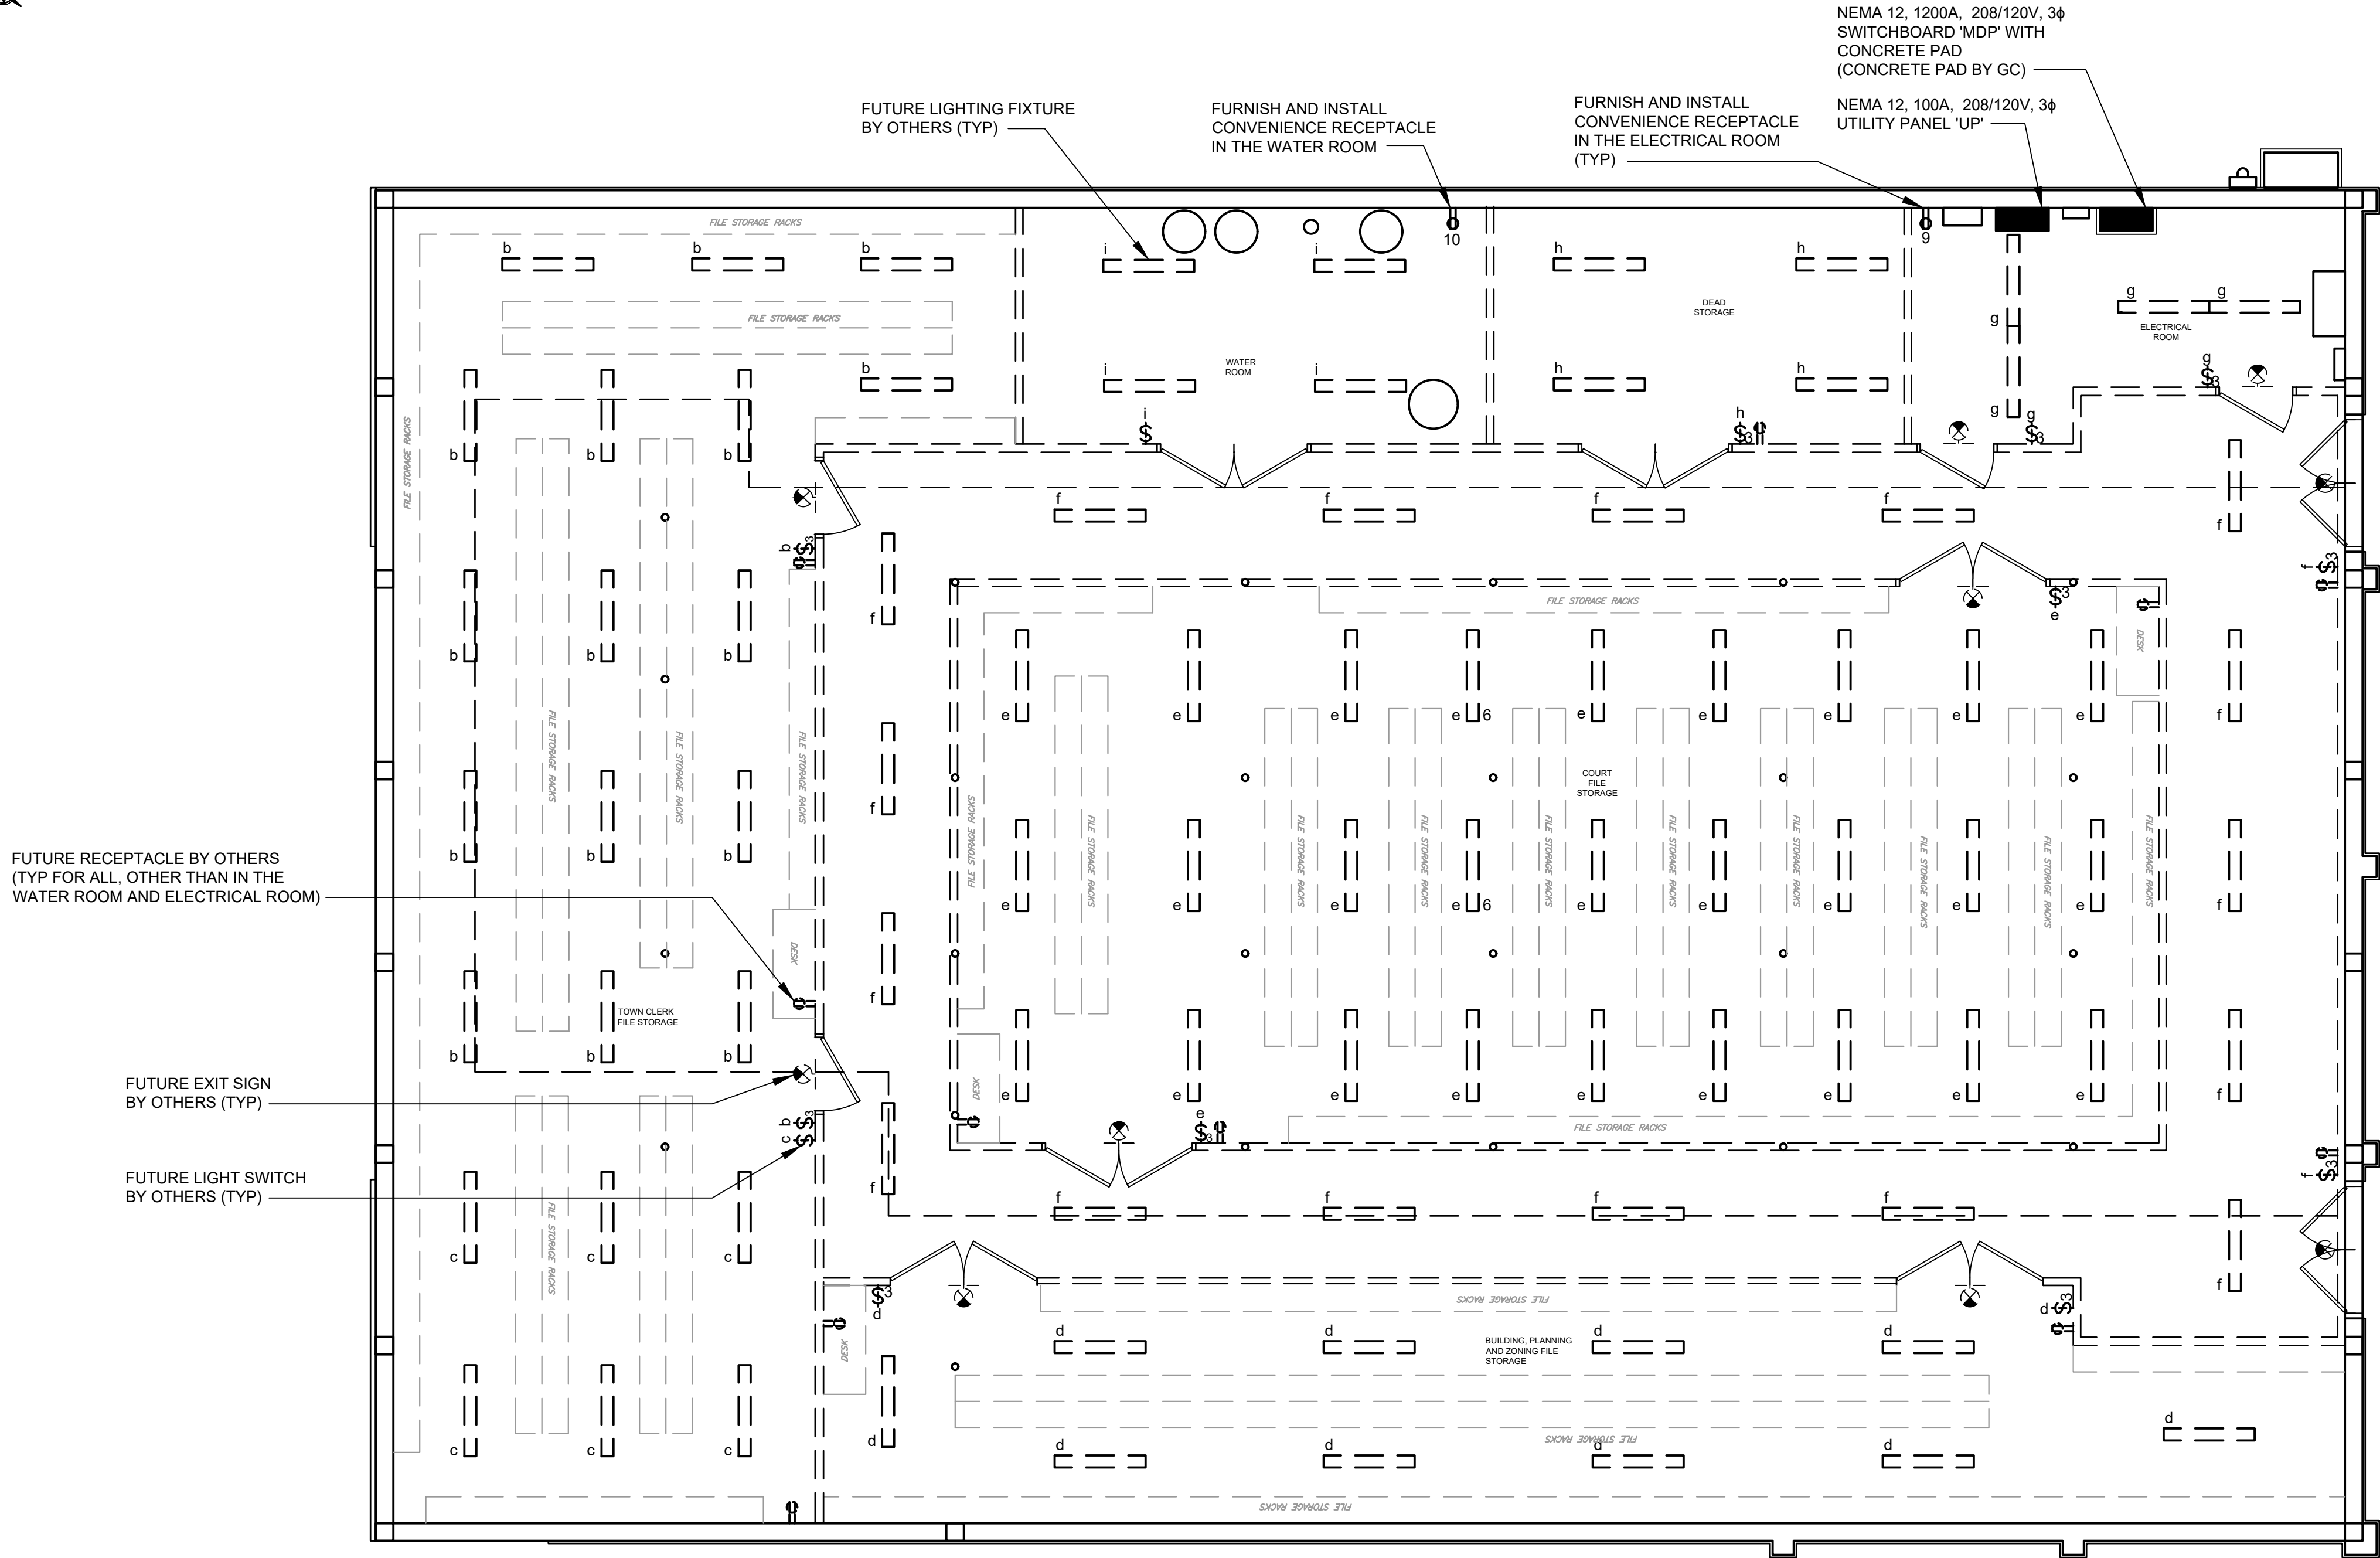

3/16"=1'-0" 6 4 2 0 5'

					UNAUTHORIZED ALTERATION OR ADDITION TO THIS DOCUMENT IS A VIOLATION OF SECTION 7209 OF THE NEW YORK STATE EDUCATION LAW.			TOWN OF BLOOMING GROVE		CONTRACT 2 BASEMENT LIGHTING PLAN ELECTRICAL	PROJECT NO. 5708		DRAWING NO. E4
					PROJECT ENGINEER: AE	DRAWN BY: MMD		ORANGE COUNTY	NEW YORK		DATE: AUGUST 2023		
					DESIGNED BY: MMD	CHECKED BY: MMD		LASSER PARK SENIOR CENTER			SCALE: 3/16" = 1'-0"		
NO.	DATE	REVISION			INT.								