 


1  
SP-100


BASE  
3/16"=1'-0"


$$3/16"=1'-0"$$







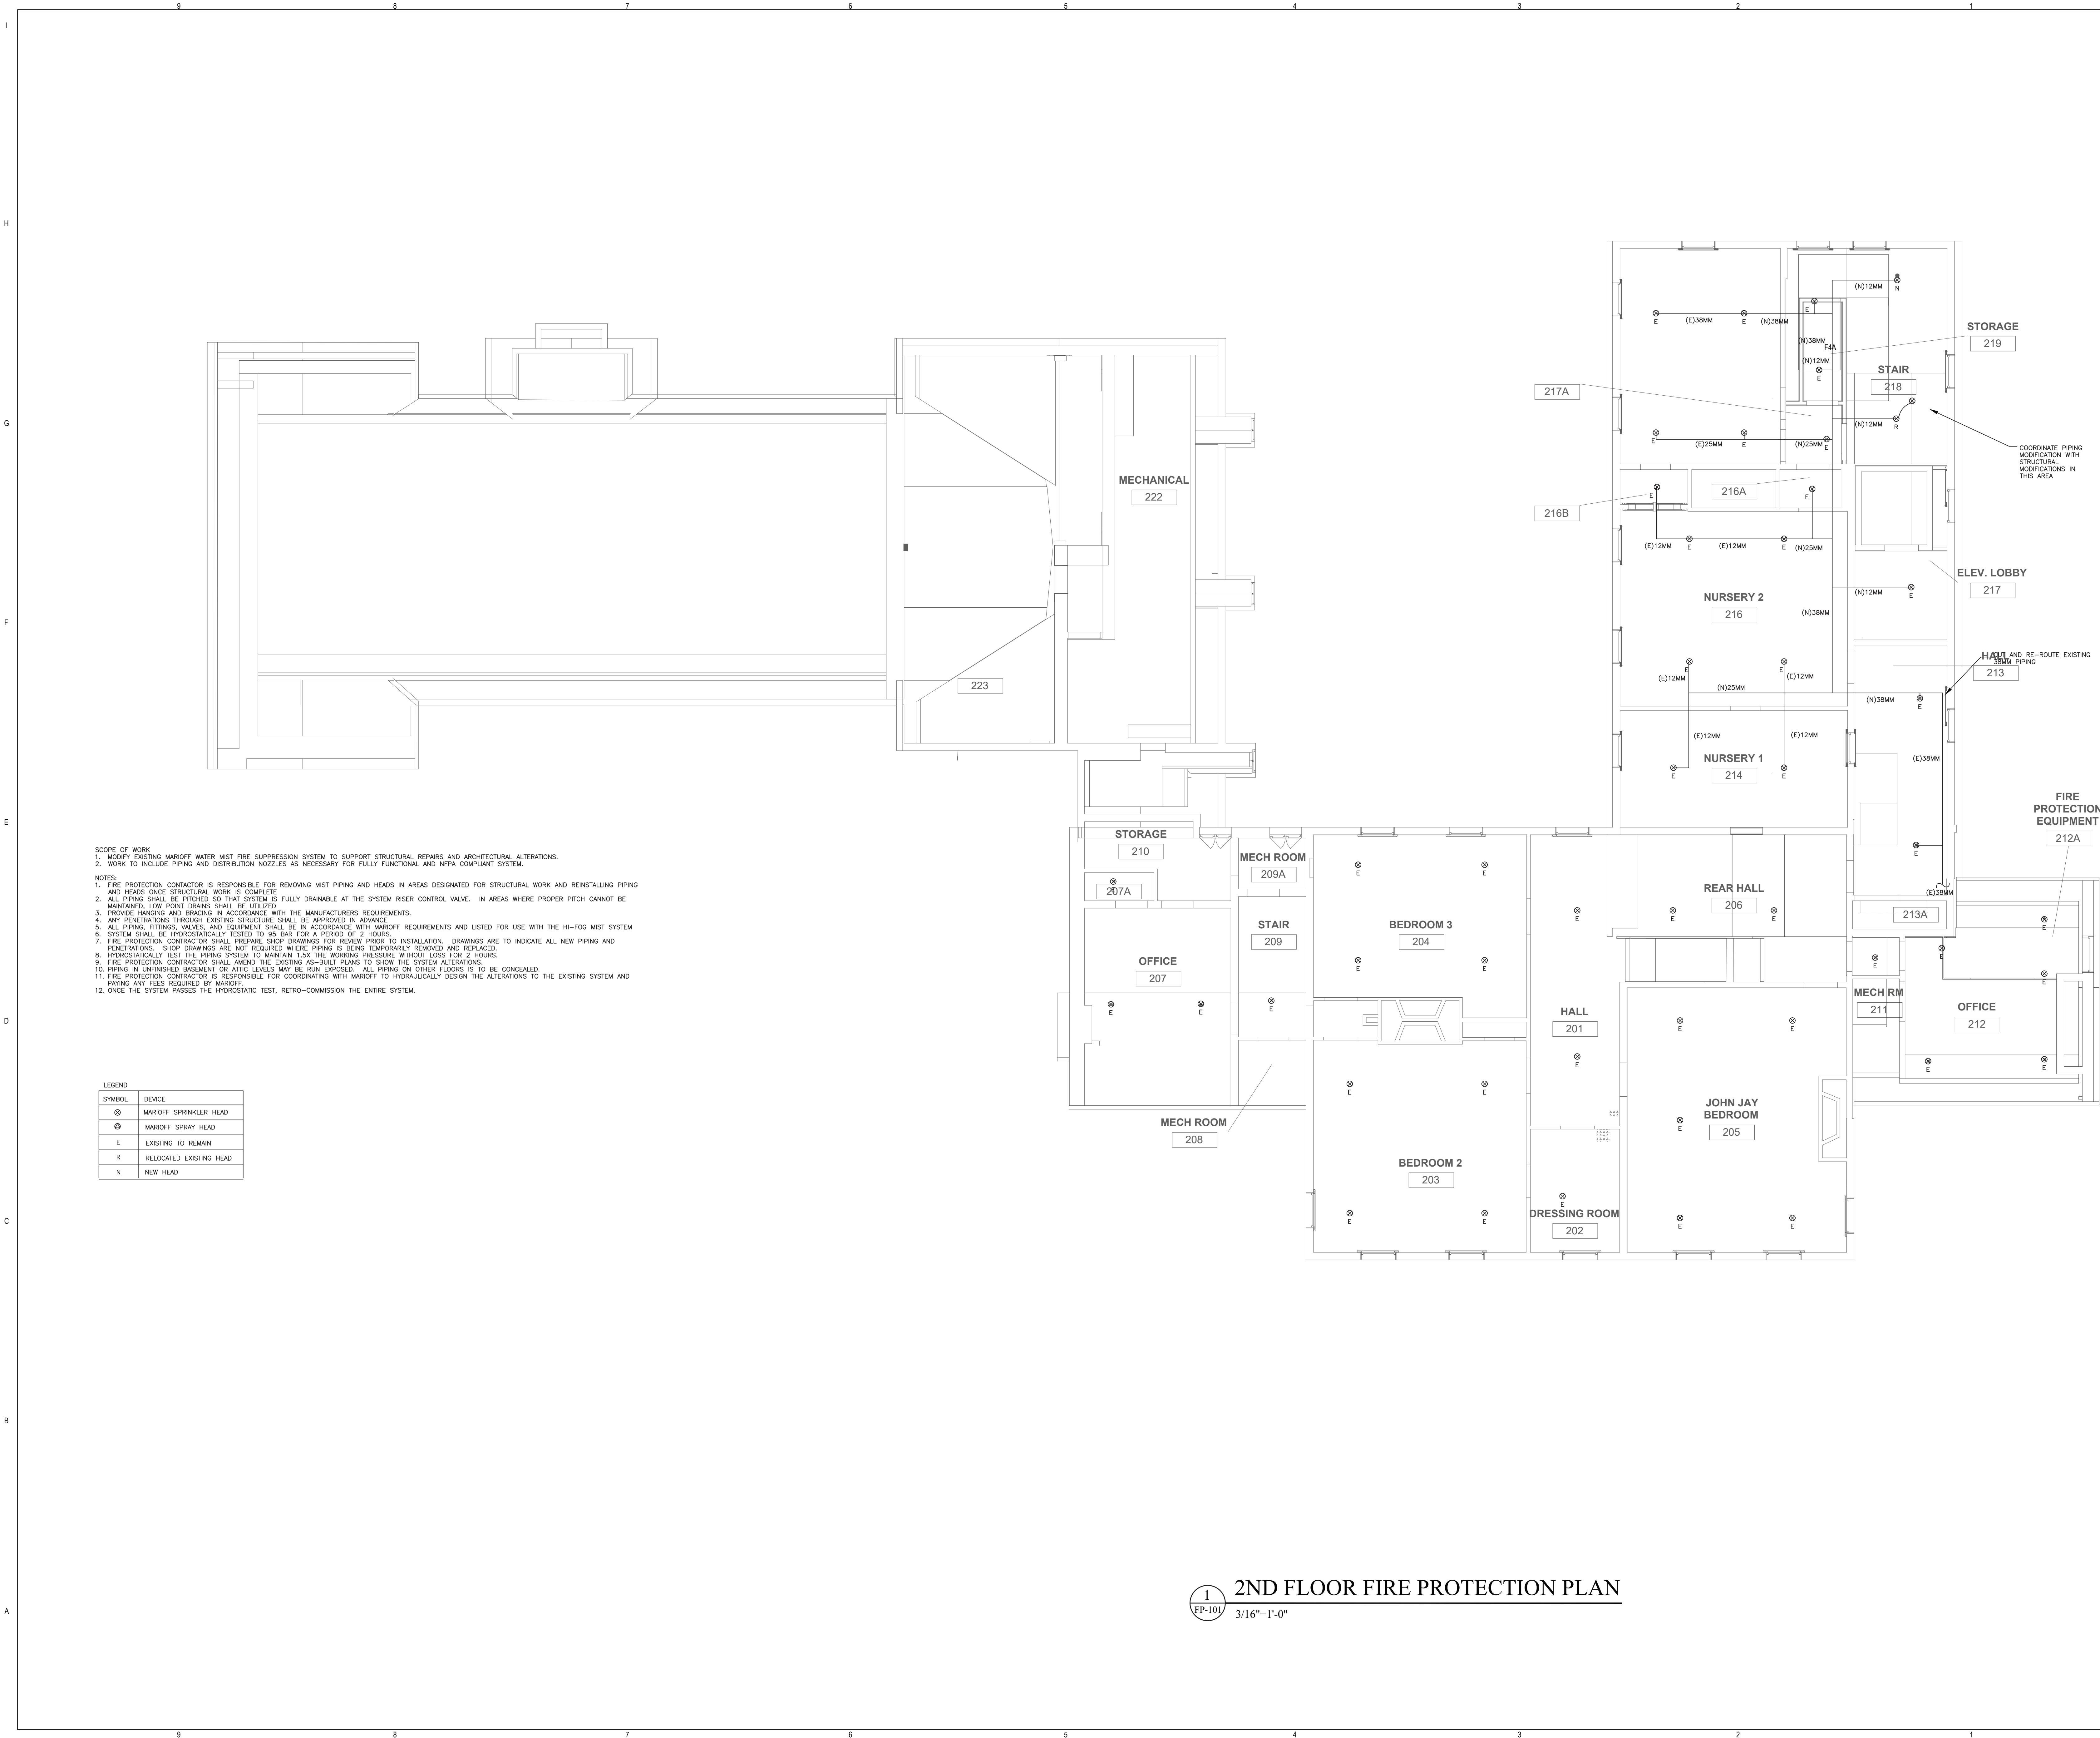

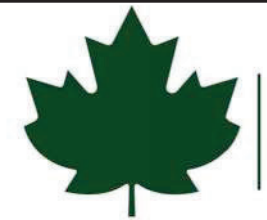


New York State  
Parks, Recreation and  
Historic Preservation

Governor Kathy HochulCommissioner Pro Tempore Randy Simons

IT IS A VIOLATION OF STATE EDUCATION LAW FOR ANY PERSON, UNLESS UNDER THE DIRECTION OF A LICENSED ARCHITECT/ENGINEER TO ALTER THIS DOCUMENT IN ANYWAY. ALTERATIONS MUST HAVE THE SEAL AFFIXED ALONG WITH A DESCRIPTION OF THE ALTERATIONS, DATE AND ARCHITECT/ENGINEER'S SIGNATURE.

Architectural Consultant  
BEYER BLINDER BELLE ARCHITECTS & PLANNERS  
100 BROADWAY, 20TH FLOOR, NEW YORK, NY 10071

BEYER  
BLINDER  
BELLE

Structural Consultant  
THORNTON TOMASETTI  
100 BROADWAY, 15TH FLOOR, NEW YORK, NY 10071

Thornton  
Tomasetti

MEP / FP / IT Consultant  
LANDMARKS FACILITIES GROUP  
202 EAST AVENUE, NORWALK, CT 06855

LFG  
LANDMARKS  
FACILITIES  
GROUP, INC.

Civil Consultant  
CMA CONSULTING, INC.  
3 WINNERS CIRCLE, PO BOX 808, ALBANY, NY 12205

CMA

Landscape Consultant  
RHODESIDE HAWWELL LANDSCAPE ARCHITECTURE  
347 WEST 36TH STREET, SUITE 1001, NEW YORK, NY 10018

RHI

Lighting Consultant  
HLB LIGHTING  
38 EAST 32ND STREET, 11TH FLOOR, NEW YORK, NY 10018

HLB

Signage Consultant  
LVCK - A BEYER BLINDER BELLE STUDIO  
100 BROADWAY, 20TH FLOOR, NEW YORK, NY 10071

LVCK


NYS OPRHP Taconic Region  
9 Old Post Rd, PO Box 308  
Staatsburg, NY 12580  
(845) 889 - 4100

Regional Director: Linda Cooper  
Capital District Manager: Garrett Jobson

Project Title:  
John Jay Homestead Site And Building  
Enhancements

Project Location:  
400 Jay Street  
Katonah NY 10536

Key Plan

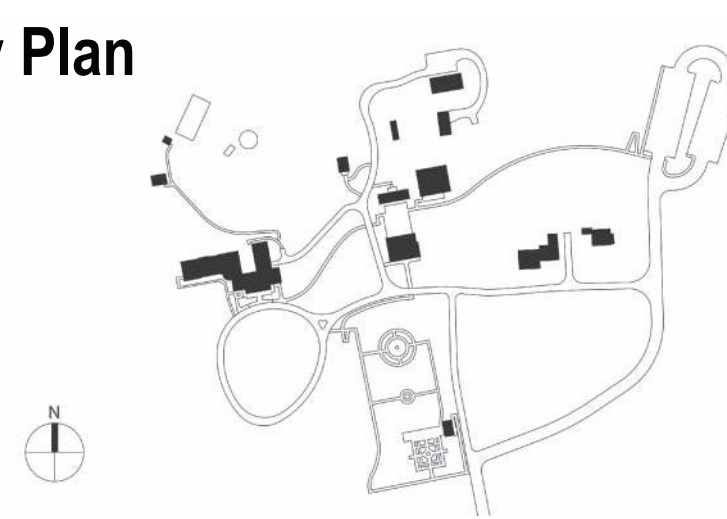

REVISIONS

Rev No	Description	Date

Drawn By:  
LFG

Design By:  
LFG


Checked By:  
LFG

Approved By:  
LFG

DATE  
07/10/24

Sheet Title  
BEDFORD HOUSE - 2ND  
FLOOR FIRE  
PROTECTION PLAN

Seal and Signature





Drawing Number  
SP-102

Project Number:  
TA-JJ-2023-001

Sheet:  
316 of 327



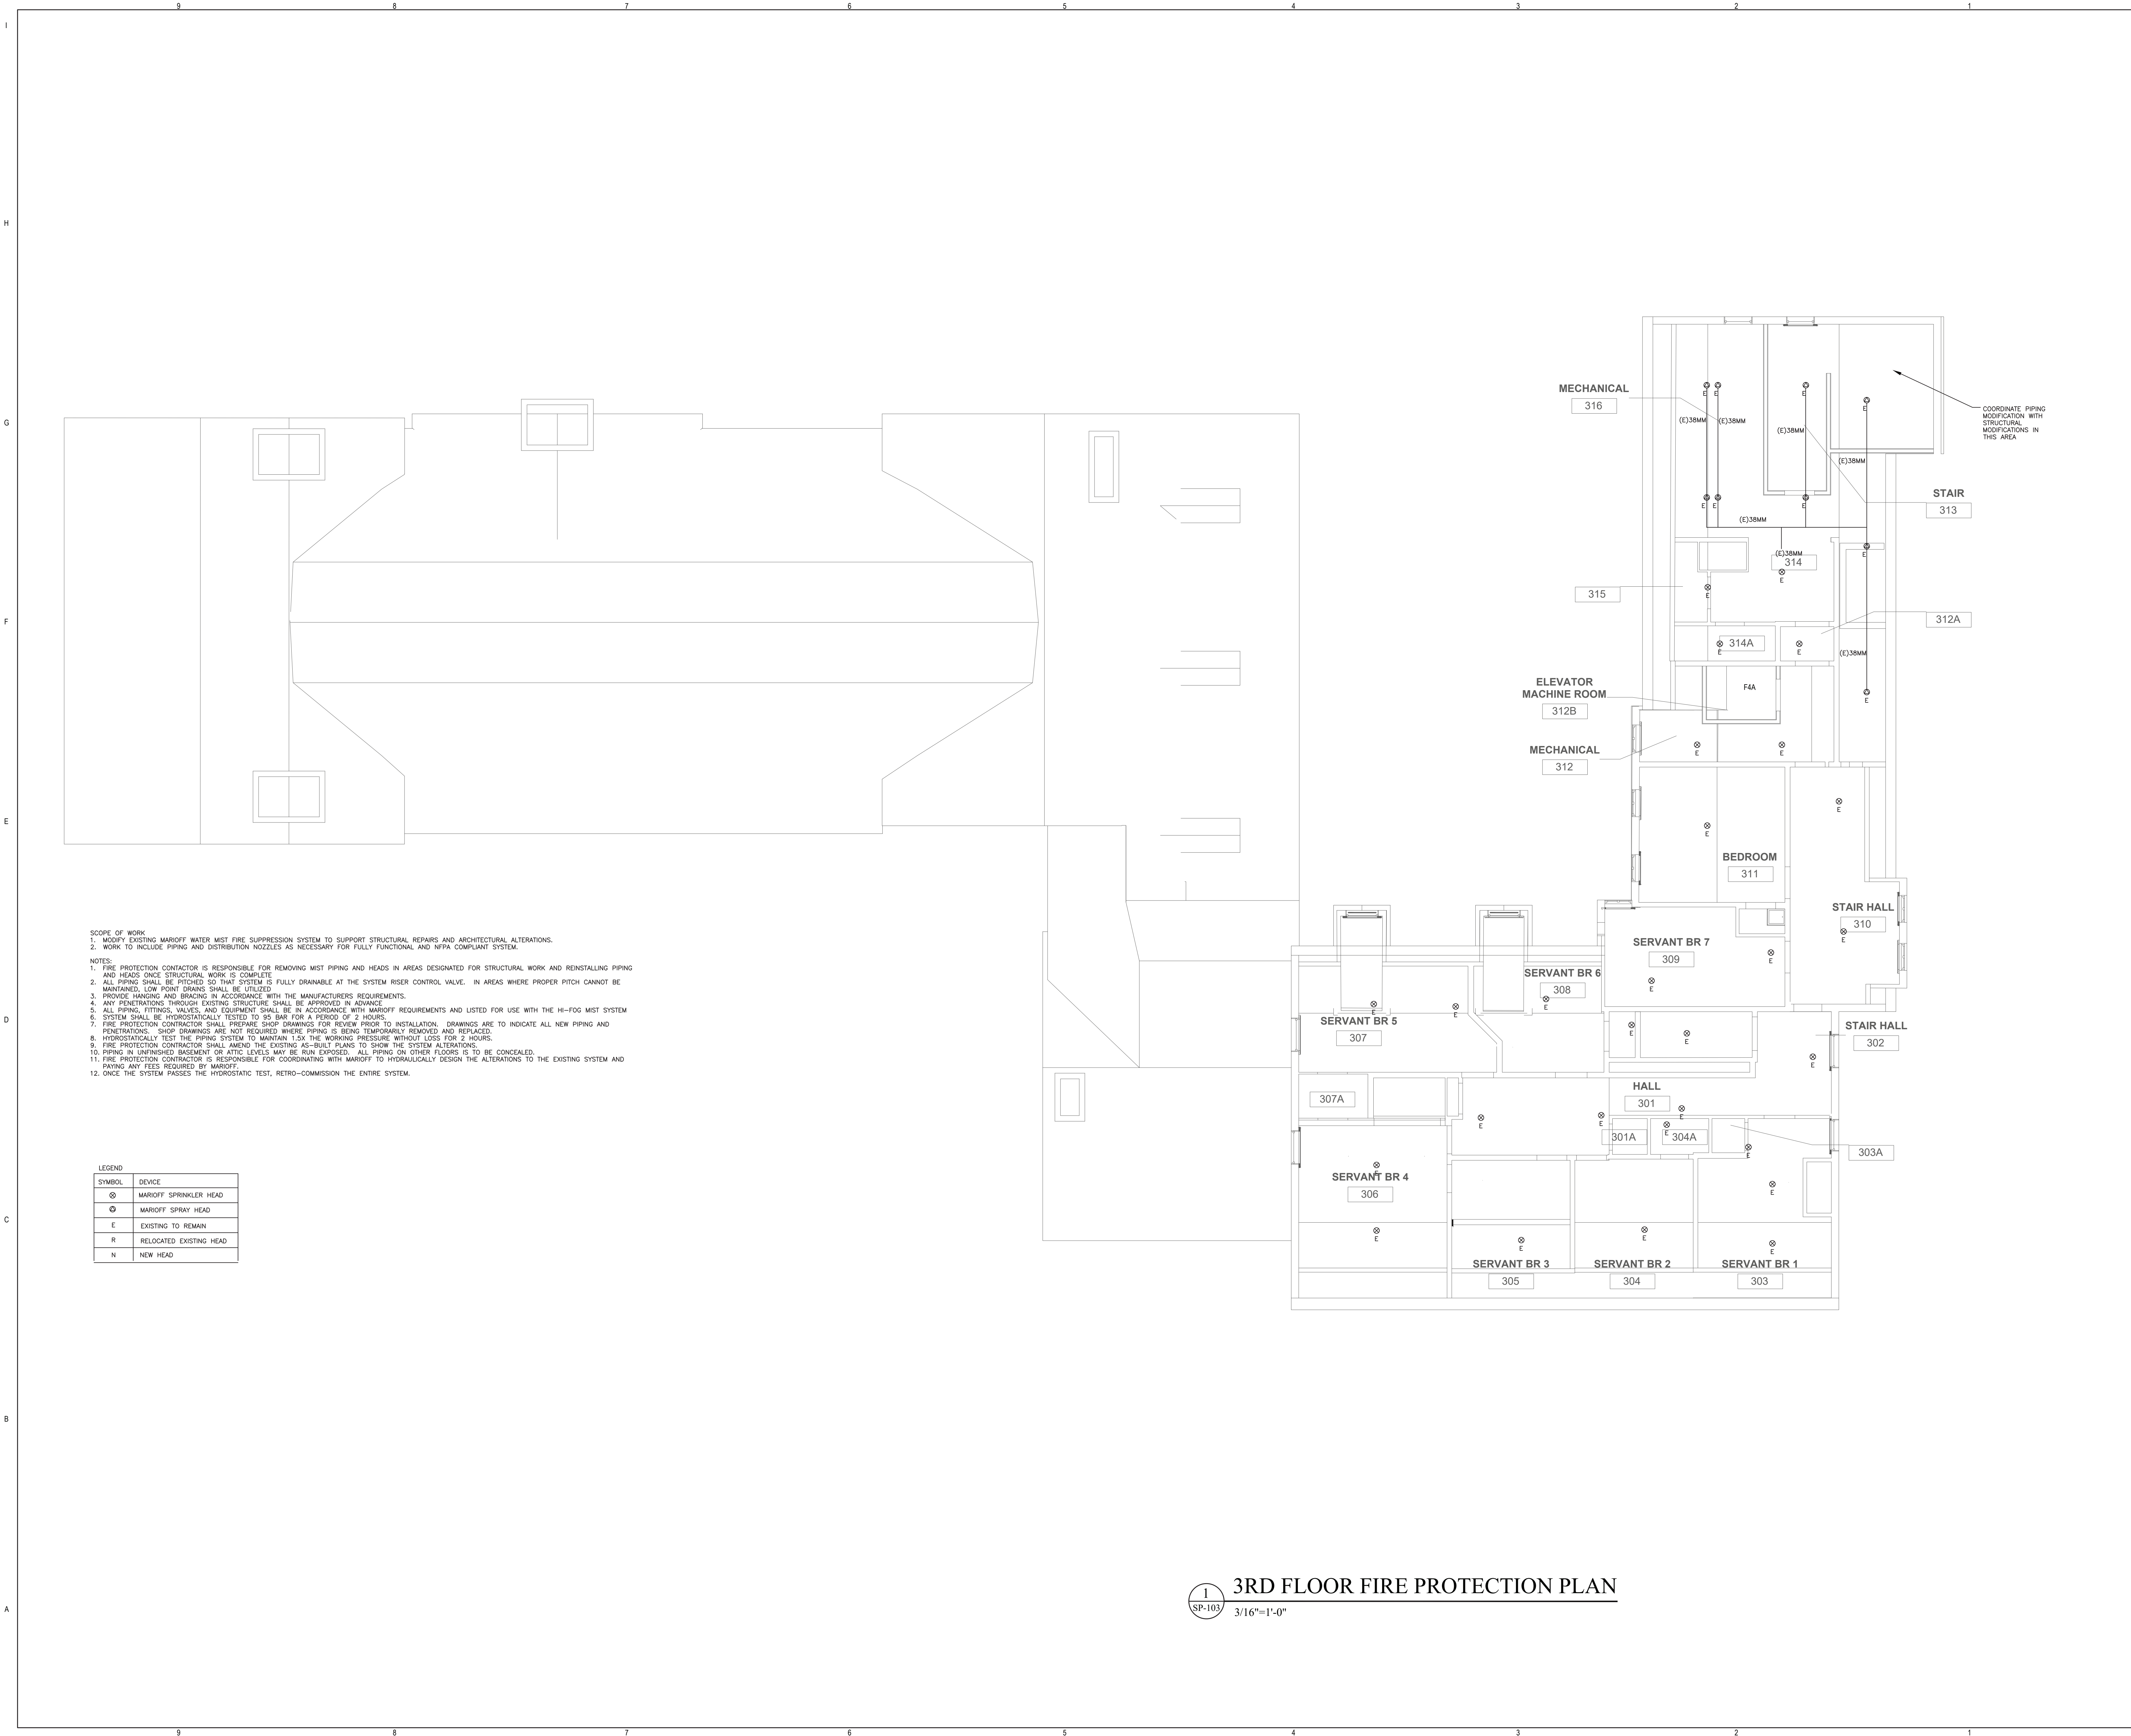



Governor Kathy HochulCommissioner Pro Tempore Randy Simons

IT IS A VIOLATION OF STATE EDUCATION LAW FOR ANY PERSON, UNLESS UNDER THE DIRECTION OF A LICENSED ARCHITECT/ENGINEER TO ALTER THIS DOCUMENT IN ANYWAY. ALTERATIONS MUST HAVE THE SEAL AFFIXED ALONG WITH A DESCRIPTION OF THE ALTERATIONS, DATE AND ARCHITECT/ENGINEER'S SIGNATURE.

**Architectural Consultant**  
BEYER BLINDER BELLE ARCHITECTS & PLANNERS  
100 BROADWAY, 20TH FLOOR, NEW YORK, NY 10071

**BEYER BLINDER BELLE**

**Structural Consultant**  
THORNTON TOMASETTI  
100 BROADWAY, 15TH FLOOR, NEW YORK, NY 10071

**Thornton Tomasetti**

**MEP / FP / IT Consultant**  
LANDMARKS FACILITIES GROUP  
200 EAST AVENUE, NORWALK, CT 06855

**LFG**  
LANDMARKS FACILITIES GROUP, INC.

**Civil Consultant**  
CMA CONSULTING, INC.  
3 WINNERS CIRCLE, PO BOX 808, ALBANY, NY 12205

**CMA**

**Landscape Consultant**  
RHODESIDE HAWWELL LANDSCAPE ARCHITECTURE  
347 WEST 36TH STREET, SUITE 1201, NEW YORK, NY 10018

**RHI**

**Lighting Consultant**  
HLB LIGHTING  
38 EAST 32ND STREET, 11TH FLOOR, NEW YORK, NY 10018

**HLB**

**Signage Consultant**  
LVCK - A BEYER BLINDER BELLE STUDIO  
100 BROADWAY, 20TH FLOOR, NEW YORK, NY 10071

**LVCK** | A Beyer Blinder Belle Studio


**NYS OPRHP Taconic Region**  
9 Old Post Rd, PO Box 308  
Staatsburg, NY 12580  
(845) 889 - 4100

Regional Director: Linda Cooper  
Capital District Manager: Garrett Jobson

**Project Title:**  
John Jay Homestead Site And Building Enhancements

**Project Location:**  
400 Jay Street  
Katonah NY 10536

**Key Plan**

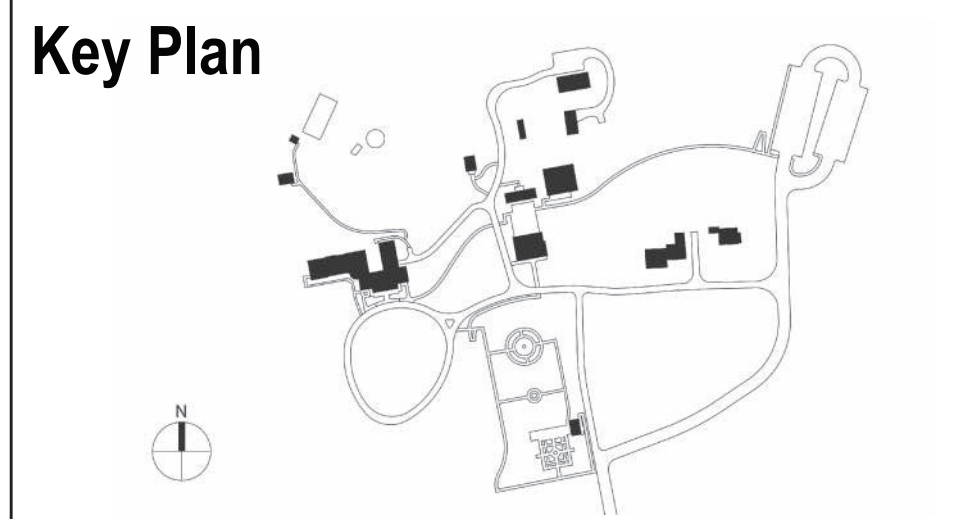

REVISIONS		
Rev No	Description	Date

Drawn By:  
LFG


Design By:  
LFG

Checked By:  
LFG

Approved By:  
LFG

DATE  
07/10/24

Seal and Signature



**Sheet Title**  
  
BEDFORD HOUSE - 3RD FLOOR FIRE PROTECTION PLAN

**Drawing Number**  
  
**SP-103**

Project Number:  
TA-JJ-2023-001

Sheet:  
317 of 327