


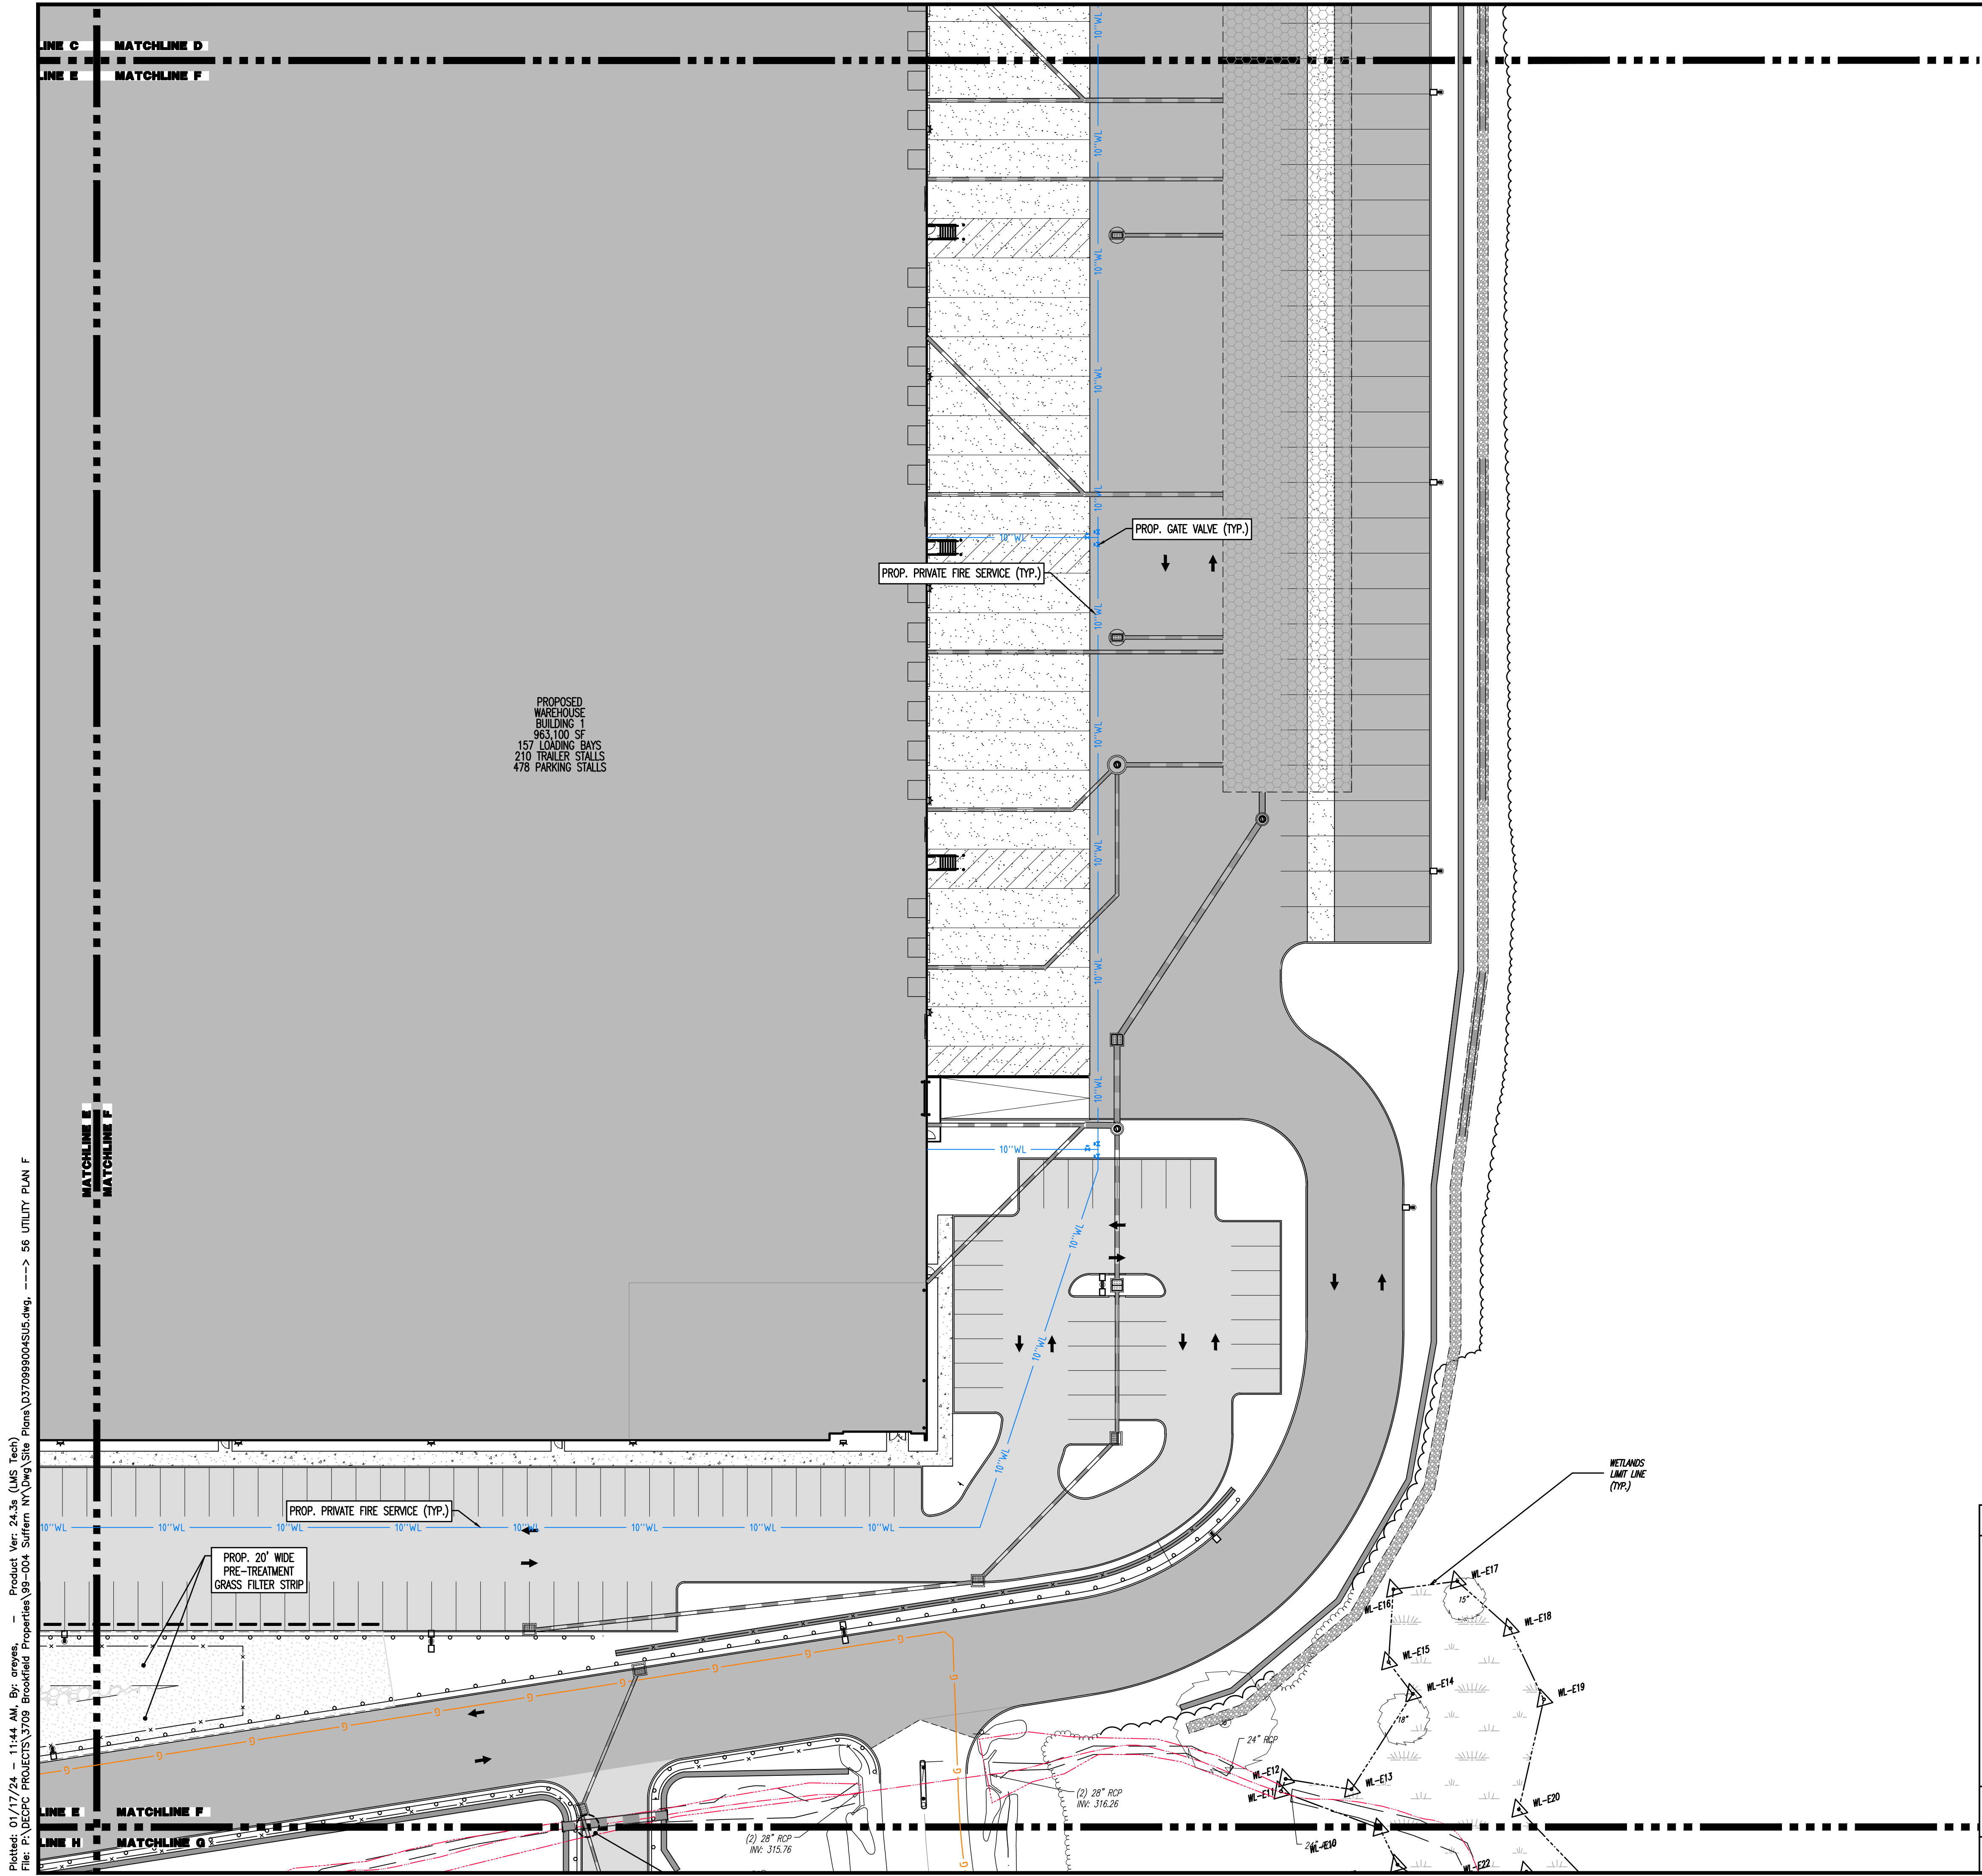

PAVEMENT LEGEND

[Symbol]	PROPOSED STANDARD PAVEMENT
[Symbol]	PROPOSED HEAVY DUTY PAVEMENT
[Symbol]	PROPOSED STANDARD CONCRETE
[Symbol]	PROPOSED HEAVY DUTY CONCRETE

KEY MAP

GRADING/UTILITY GRAPHIC LEGEND

[Symbol]	EXIST. CABLE LINE	[Symbol]	PROP. CABLE LINE
[Symbol]	EXIST. ELECTRIC LINE	[Symbol]	PROP. ELECTRIC LINE
[Symbol]	EXIST. FIBER OPTIC LINE	[Symbol]	PROP. FIBER OPTIC LINE
[Symbol]	EXIST. GAS LINE	[Symbol]	PROP. GAS LINE
[Symbol]	EXIST. OVERHEAD WIRES	[Symbol]	PROP. OVERHEAD WIRES
[Symbol]	EXIST. TELEPHONE LINE	[Symbol]	PROP. TELEPHONE LINE
[Symbol]	EXIST. UNDERGROUND ELEC./TELE. SERVICE (NO. & SIZE OF CONDUITS NOT DEFINED)	[Symbol]	PROP. UNDERGROUND ELEC./TELE. SERVICE (NO. & SIZE OF CONDUITS NOT DEFINED)
[Symbol]	EXIST. WATER LINE	[Symbol]	PROP. WATER LINE
[Symbol]	EXIST. SANITARY SEWER LINE	[Symbol]	PROP. SANITARY SEWER LINE
[Symbol]	EXIST. STORM DRAIN LINE	[Symbol]	PROP. STORM DRAIN LINE
[Symbol]	EXIST. MINOR CONTOUR & ELEVATION	[Symbol]	PROP. FINISH GRADE CONTOUR & ELEVATION
[Symbol]	EXIST. MAJOR CONTOUR & ELEVATION		
[Symbol]	EXIST. MONITORING WELL		
[Symbol]	APPROX. TEST PIT LOCATION		
[Symbol]	EXIST. SPOT ELEVATIONS	[Symbol]	PROP. GRADE SPOT ELEV.
[Symbol]	EXIST. GUTTER ELEV.	[Symbol]	PROP. TOP OF CURB & FINISHED GRADE ELEV.
[Symbol]	EXIST. TOP OF CURB ELEV.	[Symbol]	PROP. FINISHED FLOOR ELEV.
[Symbol]	EXIST. FINISH FLOOR ELEV.	[Symbol]	PROP. TOP OF WALL & FINISHED GRADE @ LOW SIDE OF WALL (ACTUAL BOTTOM OF WALL FOOTING TO BE ESTABLISHED BY WALL DESIGNER)
[Symbol]	EXIST. GARAGE FLOOR ELEV.	[Symbol]	PROP. TOP OF EXTENDED CURB (Q1) FINISHED GRADE @ HIGH SIDE OF EXTENDED CURB & (Q2) FINISHED GRADE @ LOW SIDE OF EXTENDED CURB
[Symbol]	EXIST. FIRE HYDRANT	[Symbol]	PROP. DIRECTION OF DRAINAGE FLOW ARROW
[Symbol]	EXIST. WATER VALVE	[Symbol]	PROP. WATER VALVE
[Symbol]	EXIST. GAS VALVE	[Symbol]	PROP. GAS VALVE
[Symbol]	EXIST. GAS METER	[Symbol]	PROP. STORM CLEANOUT
[Symbol]	EXIST. ELECTRIC METER	[Symbol]	PROP. SANITARY CLEANOUT
[Symbol]	EXIST. ELECTRIC BOX	[Symbol]	PROP. AREA LIGHT
[Symbol]	EXIST. CLEAN OUT	[Symbol]	PROP. OUTLET CONTROL STRUCTURE
[Symbol]	EXIST. WELL	[Symbol]	PROP. DRAINAGE MANHOLE
[Symbol]	EXIST. WATER SHUT OFF VALVE	[Symbol]	PROP. SANITARY SEWER MANHOLE
[Symbol]	EXIST. TELEPHONE BOX	[Symbol]	PROP. "A" INLET
[Symbol]	EXIST. CABLE TV BOX	[Symbol]	PROP. "B" INLET
[Symbol]	EXIST. UTILITY POLE	[Symbol]	PROP. "E" INLET
[Symbol]	EXIST. GUY WIRE	[Symbol]	PROP. YARD INLET
[Symbol]	EXIST. LIGHT POLE	[Symbol]	PROP. FLARED END SECTION
[Symbol]	EXIST. BUILDING LIGHT	[Symbol]	PROP. HEADWALL
[Symbol]	EXIST. SHOE BOX LIGHT		
[Symbol]	EXIST. COBRA LIGHT POLE		
[Symbol]	EXIST. TRAFFIC SIGNAL POLE		
[Symbol]	EXIST. MANHOLE		
[Symbol]	EXIST. "A" INLET		
[Symbol]	EXIST. "B" INLET		
[Symbol]	EXIST. "E" INLET		
[Symbol]	EXIST. YARD INLET		
[Symbol]	EXIST. FLARED END SECTION		
[Symbol]	EXIST. HEADWALL		

SEE SHEET 03 OF 132 FOR UTILITY PLAN NOTES

GRAPHIC SCALE

1 INCH = 30 FT.

THIS PLAN SET IS FOR PERMITTING PURPOSES ONLY AND MAY NOT BE USED FOR CONSTRUCTION

DYNAMIC ENGINEERING

LAND DEVELOPMENT CONSULTING • PERMITTING • GEOTECHNICAL • ENVIRONMENTAL • SURVEY • PLANNING & ZONING

1954 Main Street
Lake Como, NJ 07719
T: 732.974.0198
F: 732.974.3521
www.dynamiceng.com

LAKE COMO, NEW JERSEY T: 732.974.0198 | CHESTER, NEW JERSEY T: 908.879.9229 | NEWARK, NEW JERSEY T: 973.753.7200 | TOMS RIVER, NEW JERSEY T: 732.478.0000
ALLEN, TEXAS T: 972.534.2100 | AUSTIN, TEXAS T: 512.444.2044 | HOUSTON, TEXAS T: 281.789.6400 | DELRAY BEACH, FLORIDA T: 561.921.8570
NEWTON, PENNSYLVANIA T: 267.683.0276 | PHILADELPHIA, PENNSYLVANIA T: 215.253.4868 | SEAFORD, PENNSYLVANIA T: 610.295.4400

TITLE: **UTILITY PLAN F**

PROJECT: **IV2. ROCKLAND LOGISTICS, LLC
PROPOSED INDUSTRIAL PARK AT 25 OLD MILL ROAD
SECTION 55.22 BLOCK 1, LOT 1; SECTION 55.37, BLOCK 1, LOT 31
OLD MILL ROAD AND HEMION ROAD (CR 93)
VILLAGE OF SUFFERN, ROCKLAND COUNTY, NEW YORK**

JOB No: 3709-99-004
DATE: 12/17/2021
DRAWN BY: CAM
SCALE: (H) 1"=30'
(V)
DESIGNED BY: JMS
SHEET No:
CHECKED BY: JMS
ZAK
811 PROTECT YOURSELF
ALL STATES REQUIRE NOTIFICATION OF
CONCRETE, METALS, OR ANY OTHER
PREPARING TO DIGGING THE SERVICE
FOR STATE SPECIFIC DIRECT PHONE NUMBERS VISIT:
WWW.CALL811.COM

ZACHARY A. KAMM
PROFESSIONAL ENGINEER
NEW YORK LICENSE No. 107071

JOSHUA M. SERNALD
PROFESSIONAL ENGINEER
NEW YORK LICENSE No. 106639

56
OF 132
Rev. # 5

Plotted: 01/17/24 - 11:44 AM, By: areyes, Product Ver: 24.3s (JMS Tech)
File: P:\VEPC PROJECTS\3709 Brookfield Properties\99-004 Suffern NY\DWG\Site Plans\370999004SU5.dwg, ----> 56 UTILITY PLAN F

COPYRIGHT © 2024 - DYNAMIC ENGINEERING CONSULTANTS, PC - ALL RIGHTS RESERVED