




Peter J. Bonni

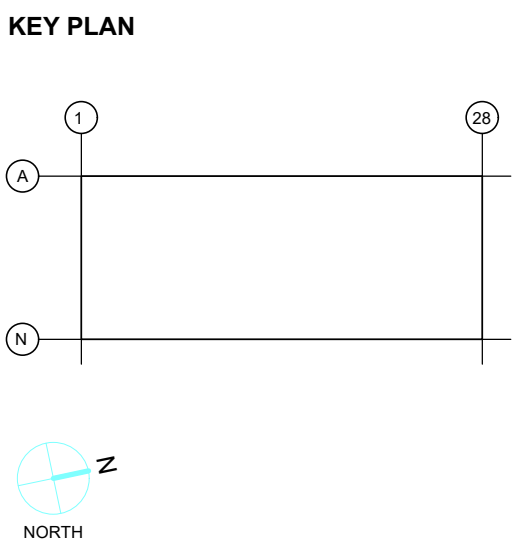

SUBMITTALS		
NO.	DATE	DESCRIPTION
A	11.20.2024	ISSUE FOR REVIEW
B	02.02.2024	ISSUE FOR REVIEW
0	02.09.2024	ISSUE FOR PERMIT


PROJECT NO.
AS397-22 | NY154

DRAWN BY
NGF

SHEET TITLE
PARTIAL WAREHOUSE LIGHTING PLAN

SHEET NO.

E2.1

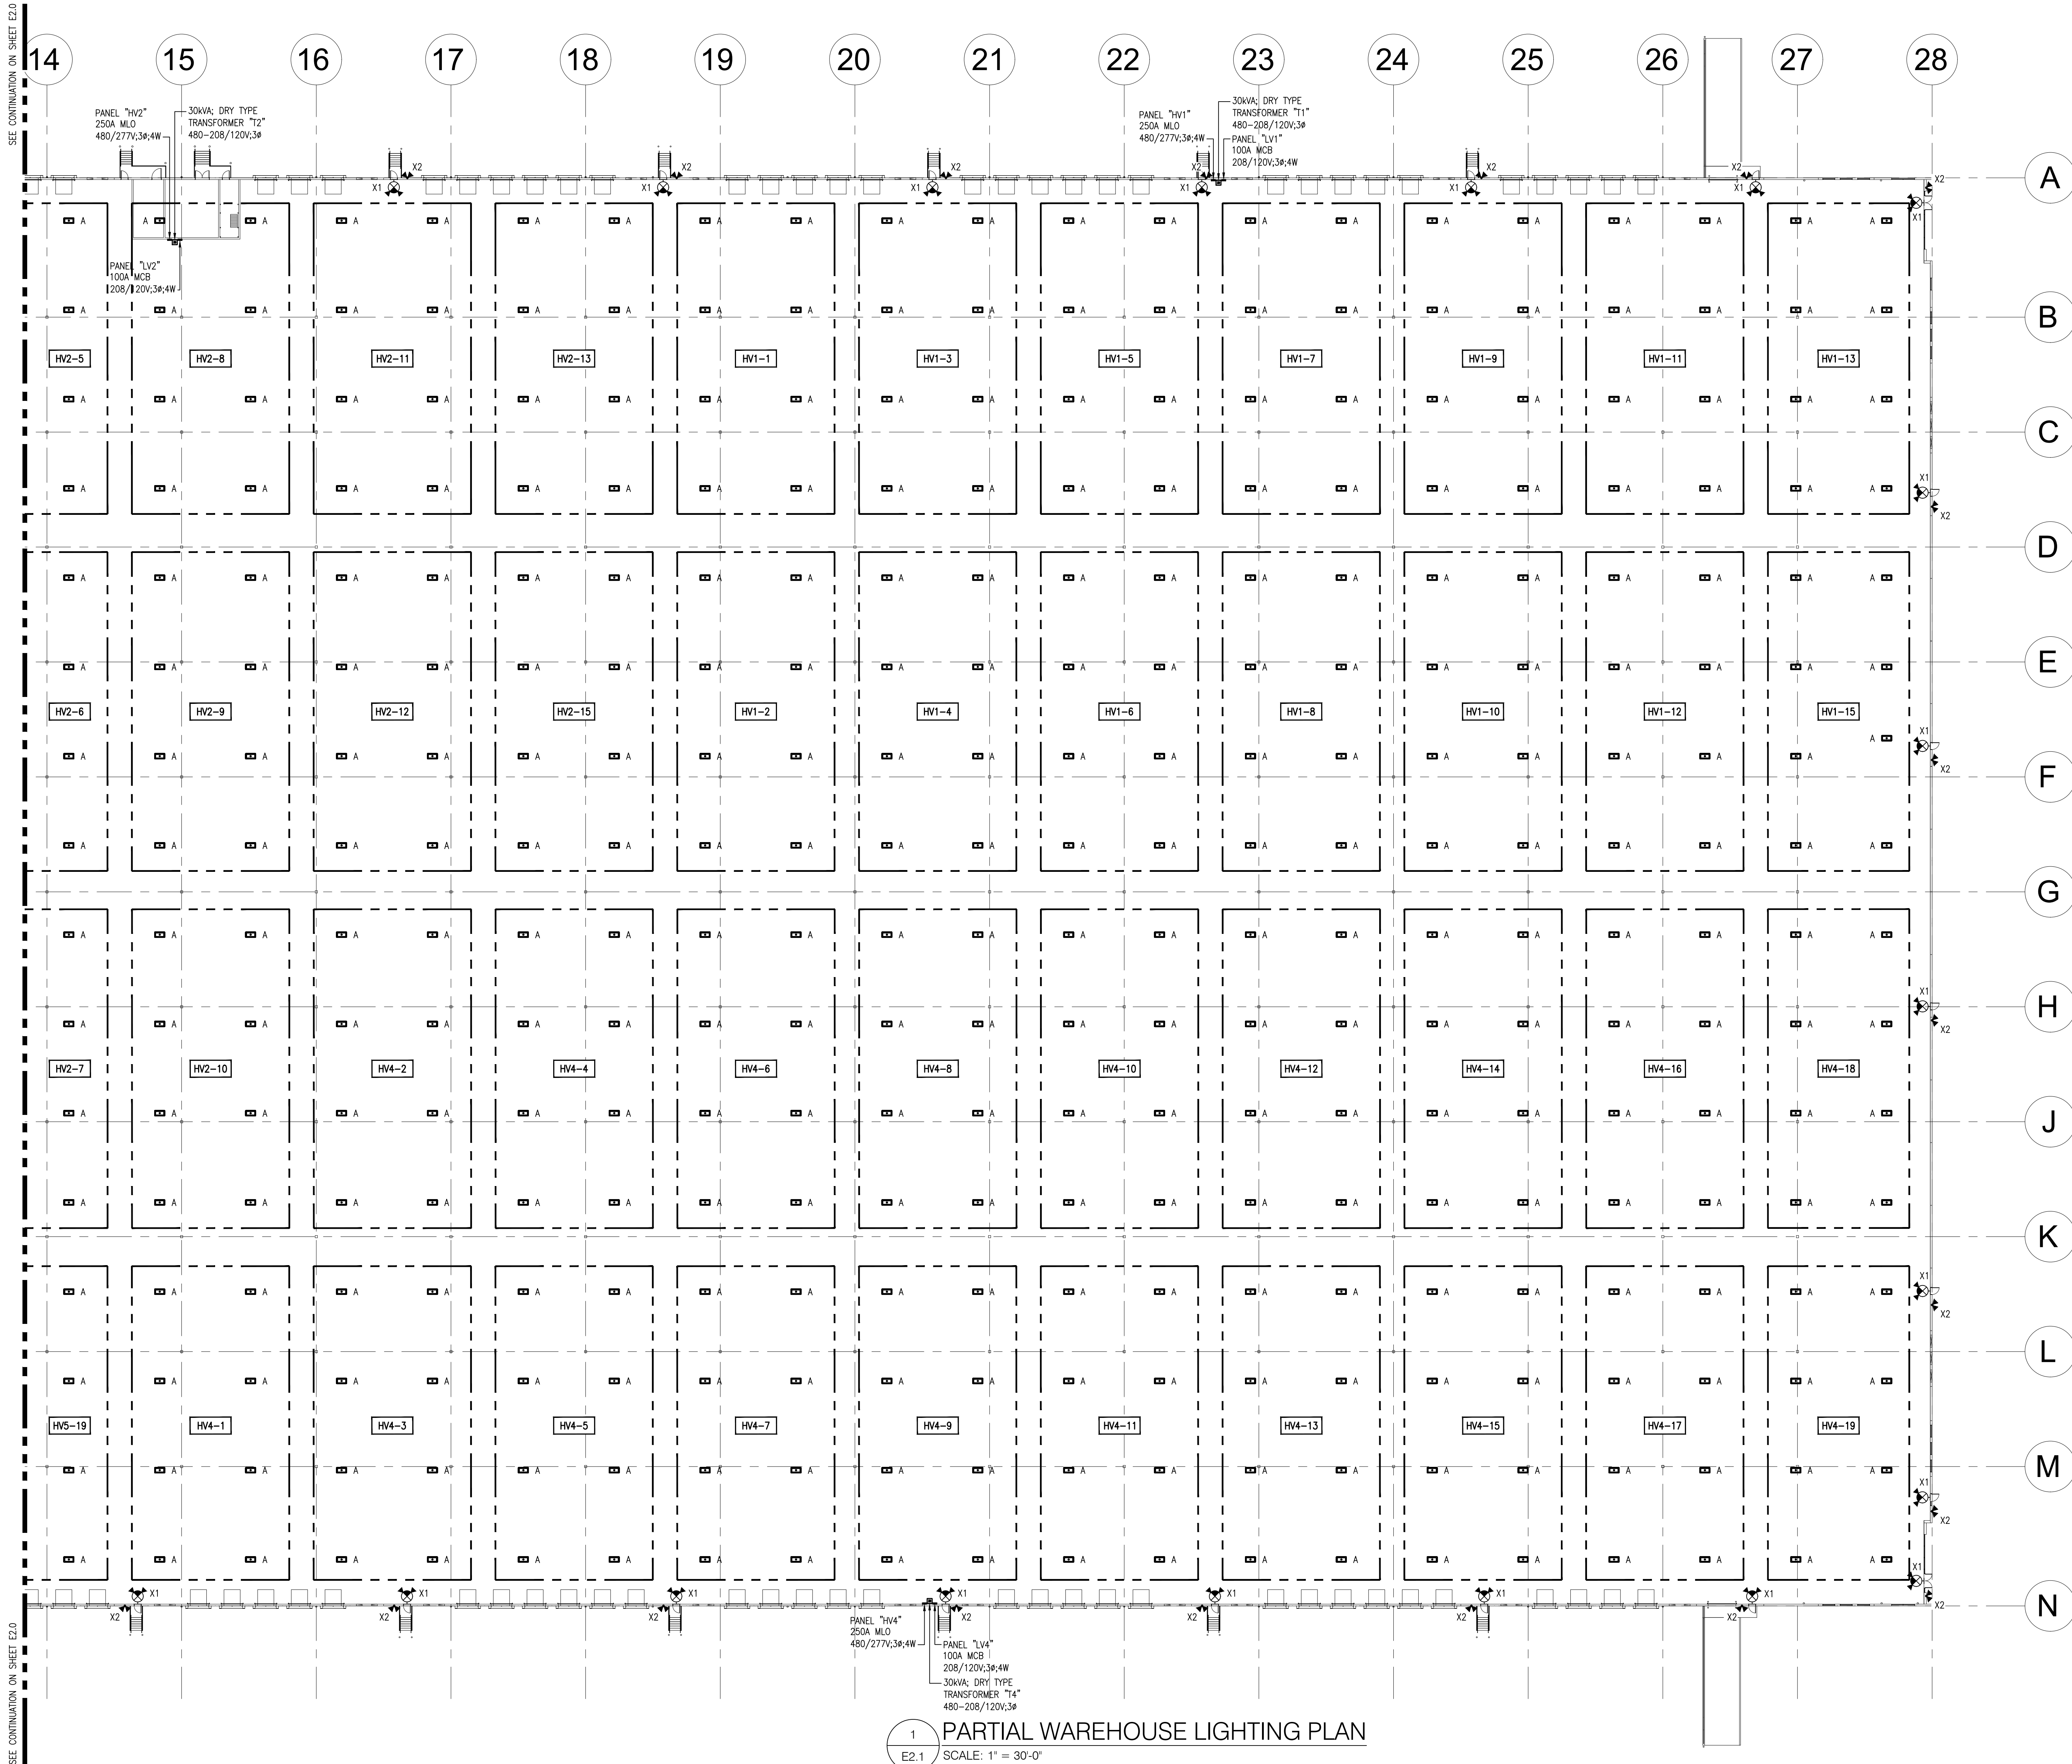

1
E2.1 **PARTIAL WAREHOUSE LIGHTING PLAN**
SCALE: 1" = 30'-0"

- NOTES:
- ALL SHOWN IS NEW & BY EC UNLESS SPECIFICALLY NOTED OTHERWISE
 - ALL EXIT SIGNAGE & EMERGENCY LIGHTING TO BE WIRED TO LOCAL LIGHTING CIRCUIT AND AHEAD OF ALL SWITCHING
 - ALL LIGHTING FIXTURES WITHIN THE SPECIFIED AREA SHALL BE CIRCUITED TO THE CIRCUIT NUMBER(S) INDICATED ON THIS PLAN, UNLESS NOTED OTHERWISE. SEE PANEL SCHEDULES ON DRAWING E6.0 FOR ADDITIONAL INFORMATION.

Calculation Summary						
Label	Units	Avg	Max	Min	Avg/Min	Max/Min
Building 1 Workplane	Fc	28.10	31.7	14.0	2.01	2.26