

1
ESP1.0

ELECTRICAL SITE PLAN


SCALE: 1" = 45'-0"

NOTES:

1. ALL SHOWN IS NEW & BY EC UNLESS SPECIFICALLY NOTED OTHERWISE

SEE CONTINUATION ON SHEET ESP1.1

SEE CONTINUATION ON SHEET ESP1.1

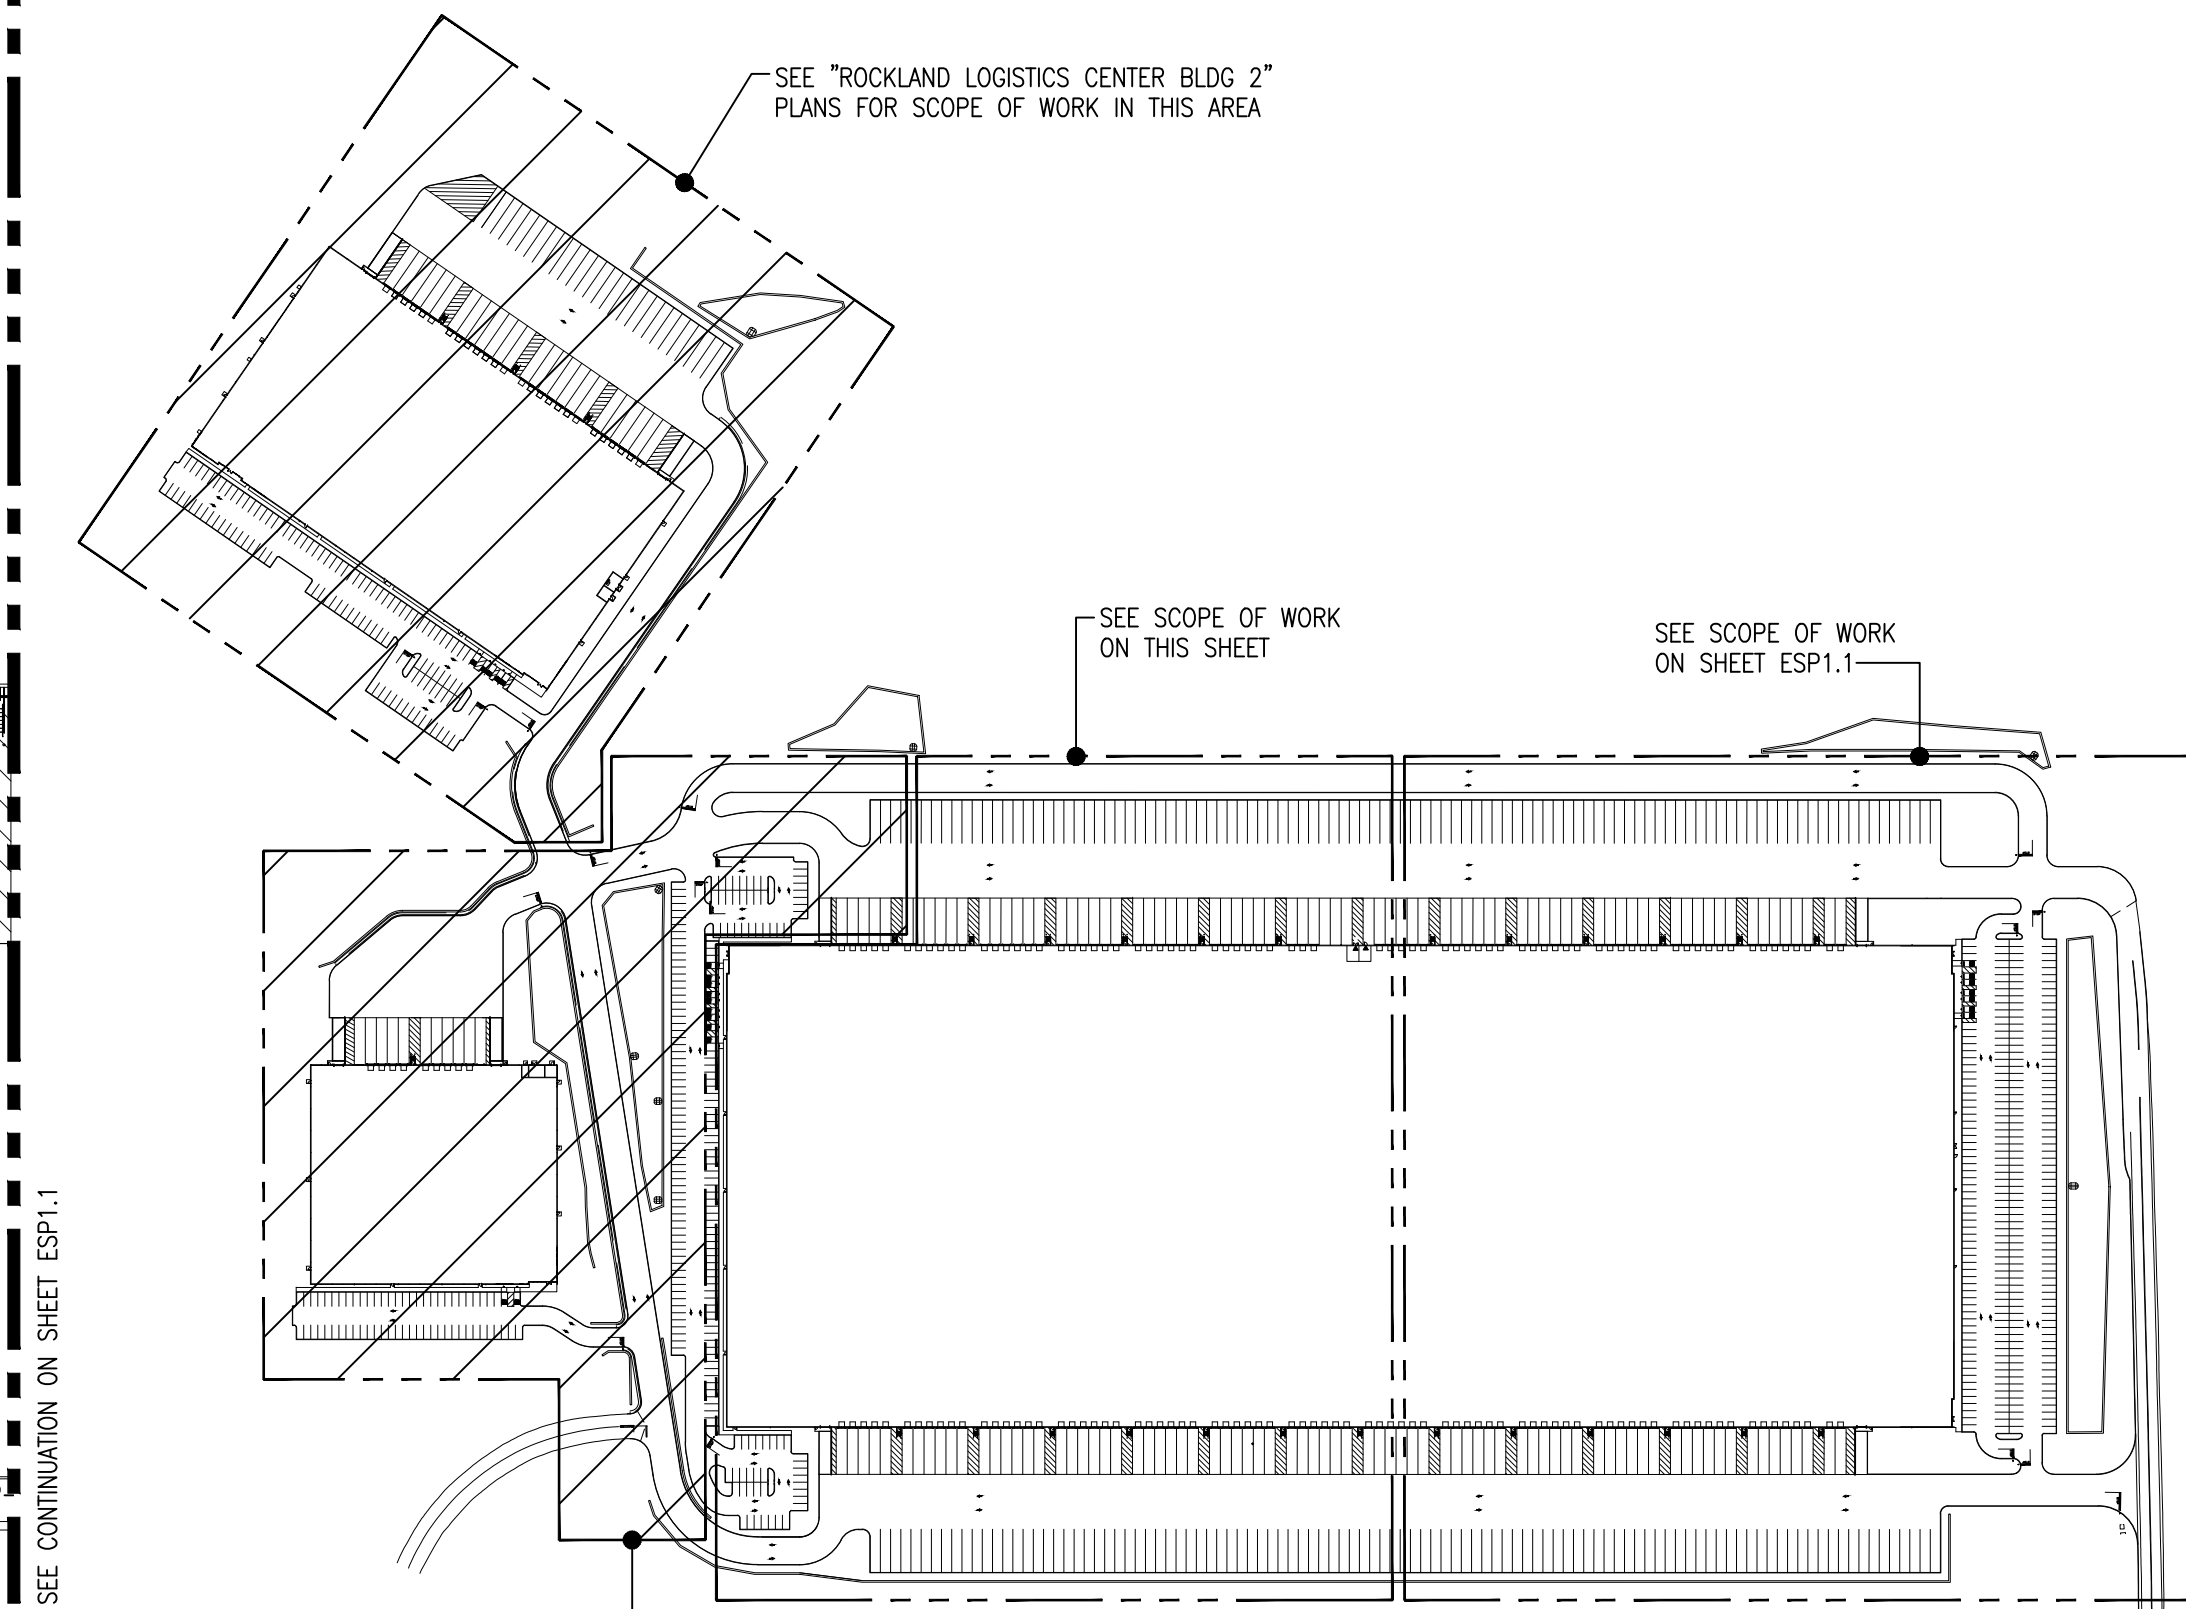

KEYPLAN

SCALE: NONE

DESIGNER / BUILDER

ARCO
DESIGN/BUILD

44 SOUTH BROADWAY, SUITE 1003

WHITE PLAINS, NY 10601

P: 914.821.5535

F: 914.306.6010

ADB | **DESIGN SERVICES**

PROJECT TITLE

ROCKLAND LOGISTICS CENTER BLDG 1

25 OLD MILL RD.

SUFFERN, NY 10901

OWNER

BROOKFIELD PROPERTIES
1 MEADOWLANDS PLAZA, SUITE 802
EAST RUTHERFORD, NJ 07073

ARCHITECT

ADB / DESIGN SERVICES LLC
44 SOUTH BROADWAY, SUITE 1003
WHITE PLAINS, NY 10601

CIVIL ENGINEER

DYNAMIC ENGINEERING CONSULTANTS
1904 MAIN STREET
LAKE COMO, NJ 07719

STRUCTURAL ENGINEER

ADB STRUCTURAL ENGINEERING
325 S. ALABAMA ST., SUITE 200
INDIANAPOLIS, IN 46204

MECHANICAL ENGINEER

NATIONAL DESIGN BUILD SERVICES
11840 BORMAN DRIVE
MARYLAND HEIGHTS, MO 63146

ELECTRICAL ENGINEER

FXB ENGINEERING
5 CHRISTY DRIVE, SUITE 307
CHADDS FORD, PA 19317

PLUMBING ENGINEER

MCCARTHY ENGINEERING
2500 E HIGH STREET, SUITE 630
POTTSTOWN, PA 19464

FIRE PROTECTION ENGINEER

S.A. COMUNALE
2900 NEWPARK DRIVE
BARBERTON, OH 44203

SEAL


NY License #: 077635-1

NY License Expiration Date: 04/30/2026



Peter J. Bonner

KEY PLAN

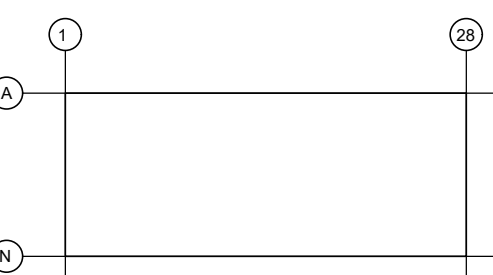

NORTH

SUBMITTALS

NO.	DATE	DESCRIPTION
A	11.20.2024	ISSUE FOR REVIEW
B	02.02.2024	ISSUE FOR REVIEW
0	02.09.2024	ISSUE FOR PERMIT

PROJECT NO.

AS397-22 | NY154

DRAWN BY

NGF

SHEET TITLE

ELECTRICAL SITE LIGHTING PLAN

SHEET NO.

ESP1.0