



1 ENLARGED LIGHTING PLAN  
E4.0 SCALE: 1/4" = 1'-0"

- NOTES:
- ALL SHOWN IS NEW & BY EC UNLESS SPECIFICALLY NOTED OTHERWISE
  - ALL EXIT SIGNAGE & EMERGENCY LIGHTING TO BE WIRED TO LOCAL LIGHTING CIRCUIT AND AHEAD OF ALL SWITCHING
  - ALL LIGHTING FIXTURES WITHIN THE SPECIFIED AREA SHALL BE DISCUTED TO THE CIRCUIT NUMBER(S) INDICATED ON THIS PLAN, UNLESS NOTED OTHERWISE. SEE PANEL SCHEDULES ON DRAWING E6.0 FOR ADDITIONAL INFORMATION.
  - VERIFY ALL FIXTURE LOCATIONS, WATTAGES, AND FIXTURE CATALOG NUMBERS WITH OWNER & GC PRIOR TO PURCHASING/INSTALLATION.

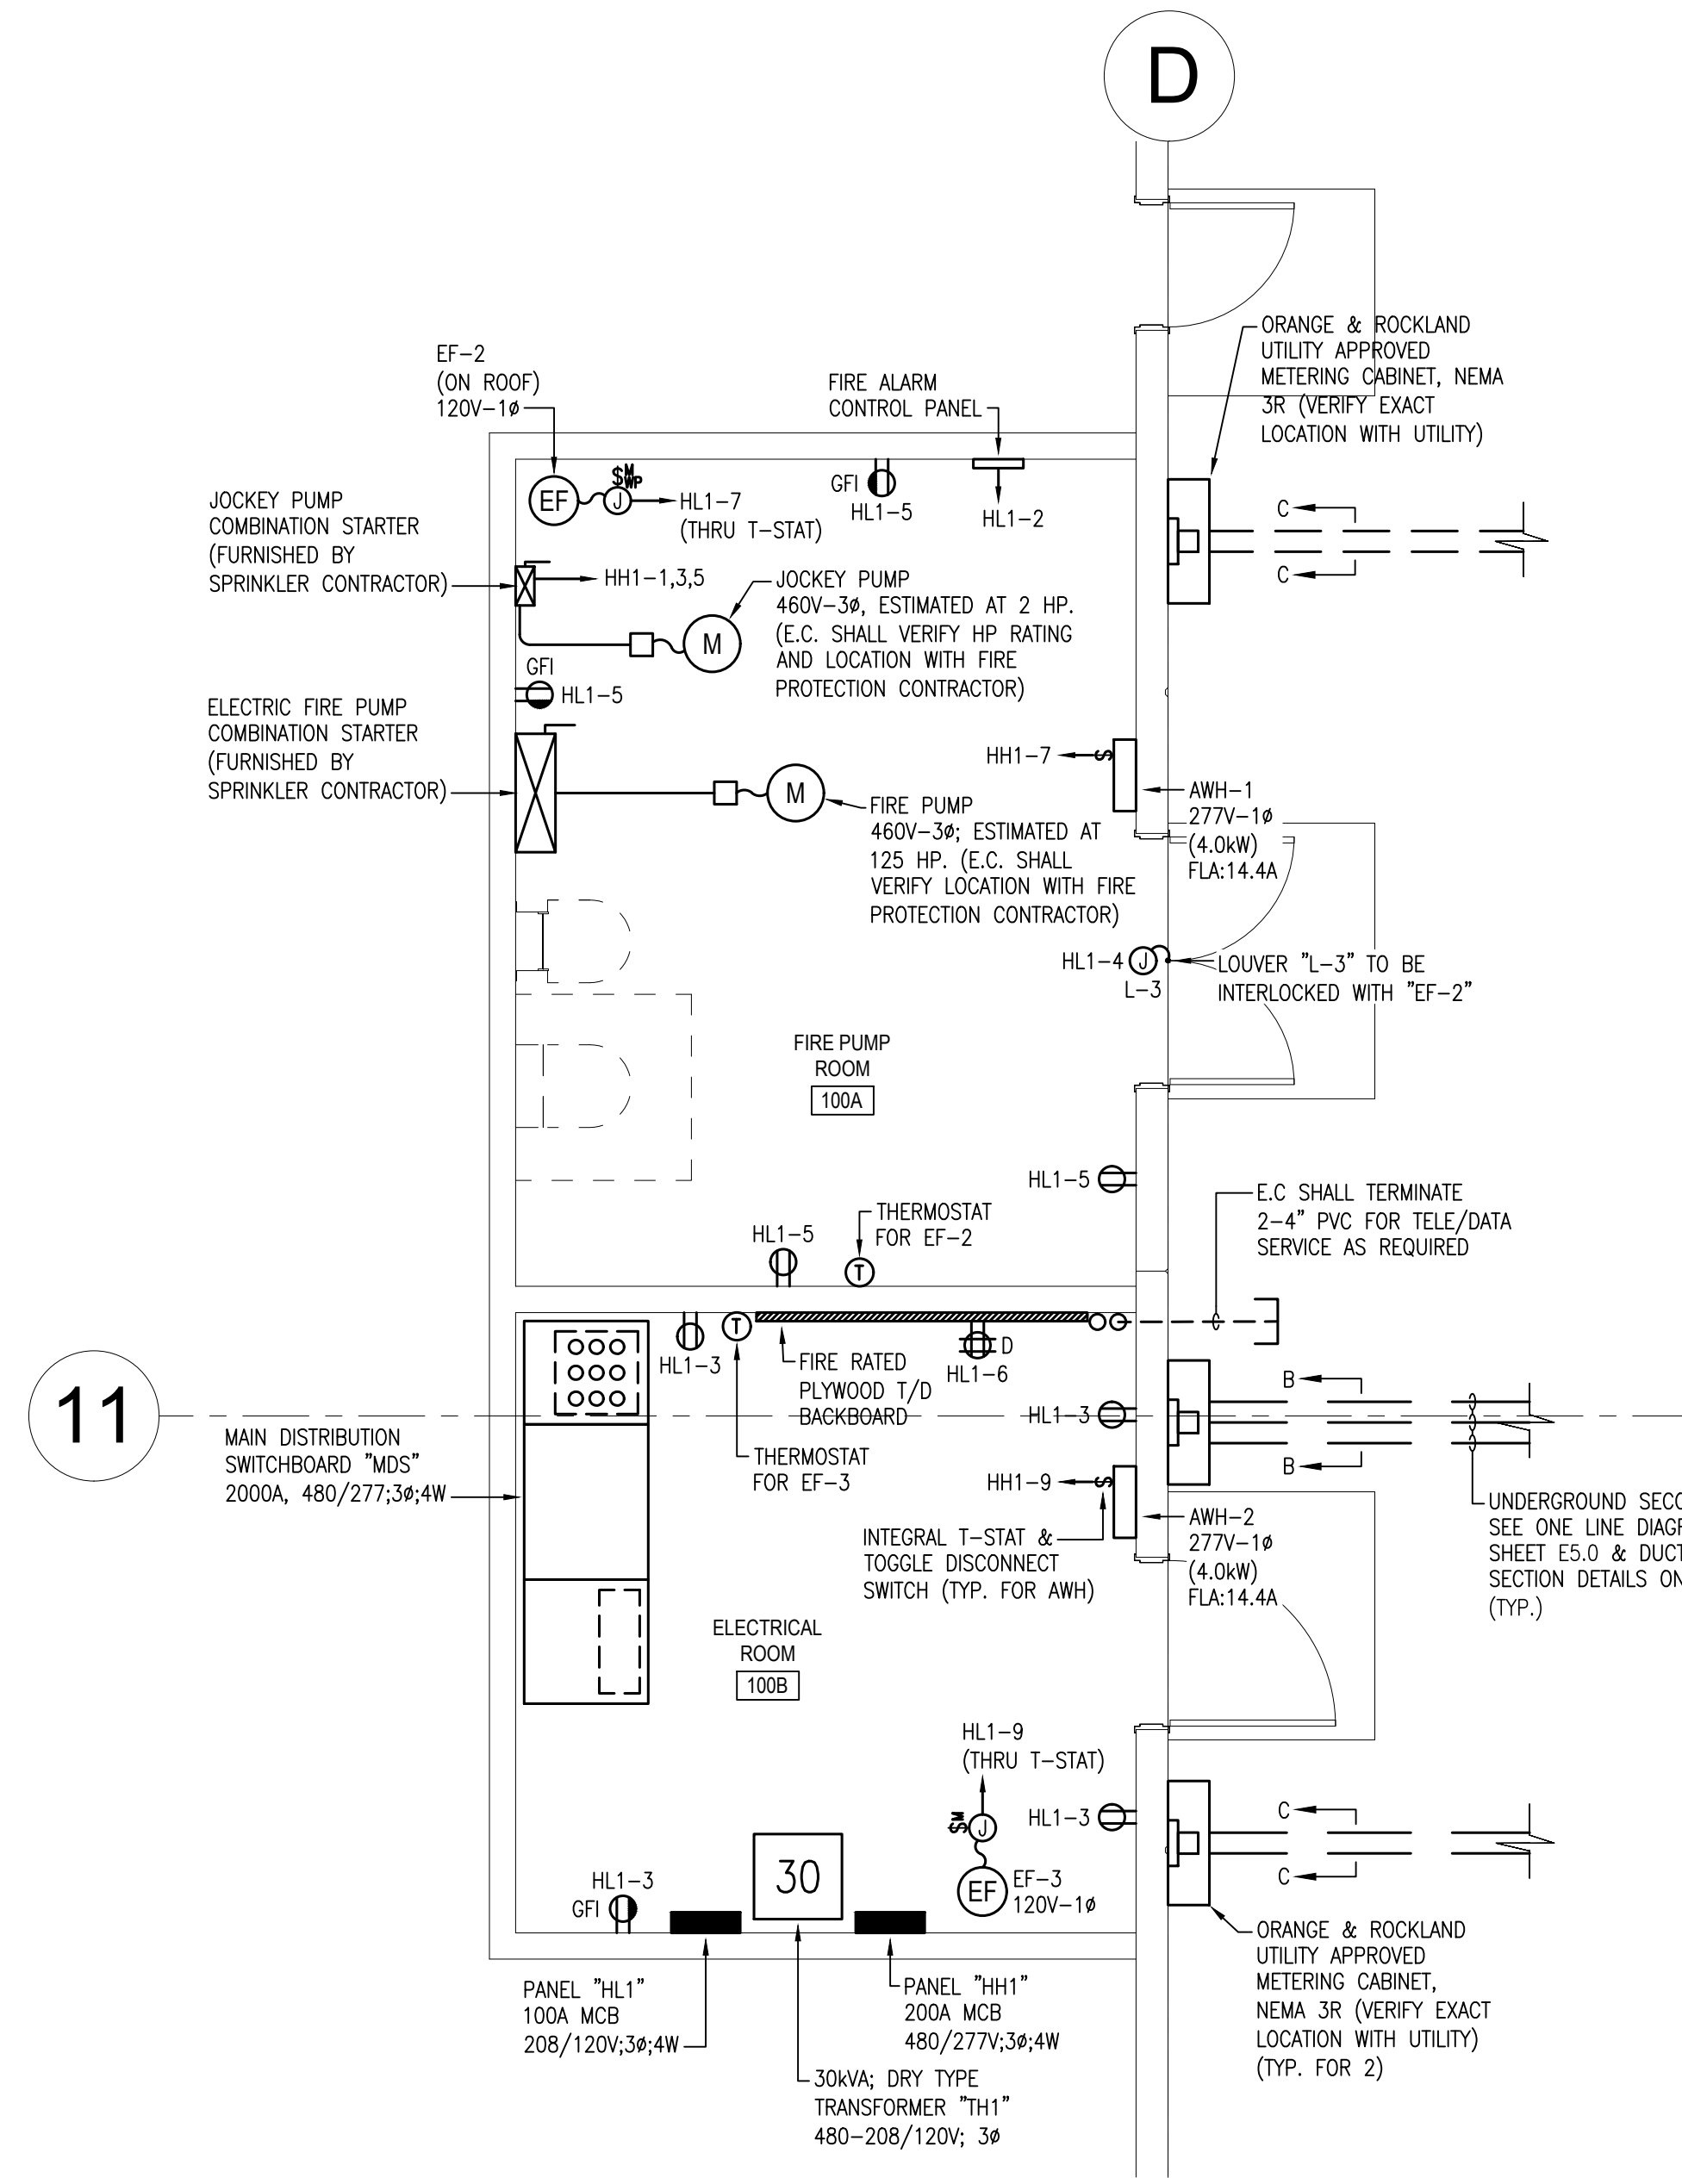

2 ENLARGED POWER PLAN  
E4.0 SCALE: 1/4" = 1'-0"

- NOTES:
- ALL SHOWN IS NEW & BY EC UNLESS SPECIFICALLY NOTED OTHERWISE.
  - E.C. SHALL VERIFY ALL MECHANICAL/HVAC EQUIPMENT LOCATIONS AND ELECTRICAL REQUIREMENTS WITH MECHANICAL/HVAC DRAWINGS PRIOR TO INSTALLATION.

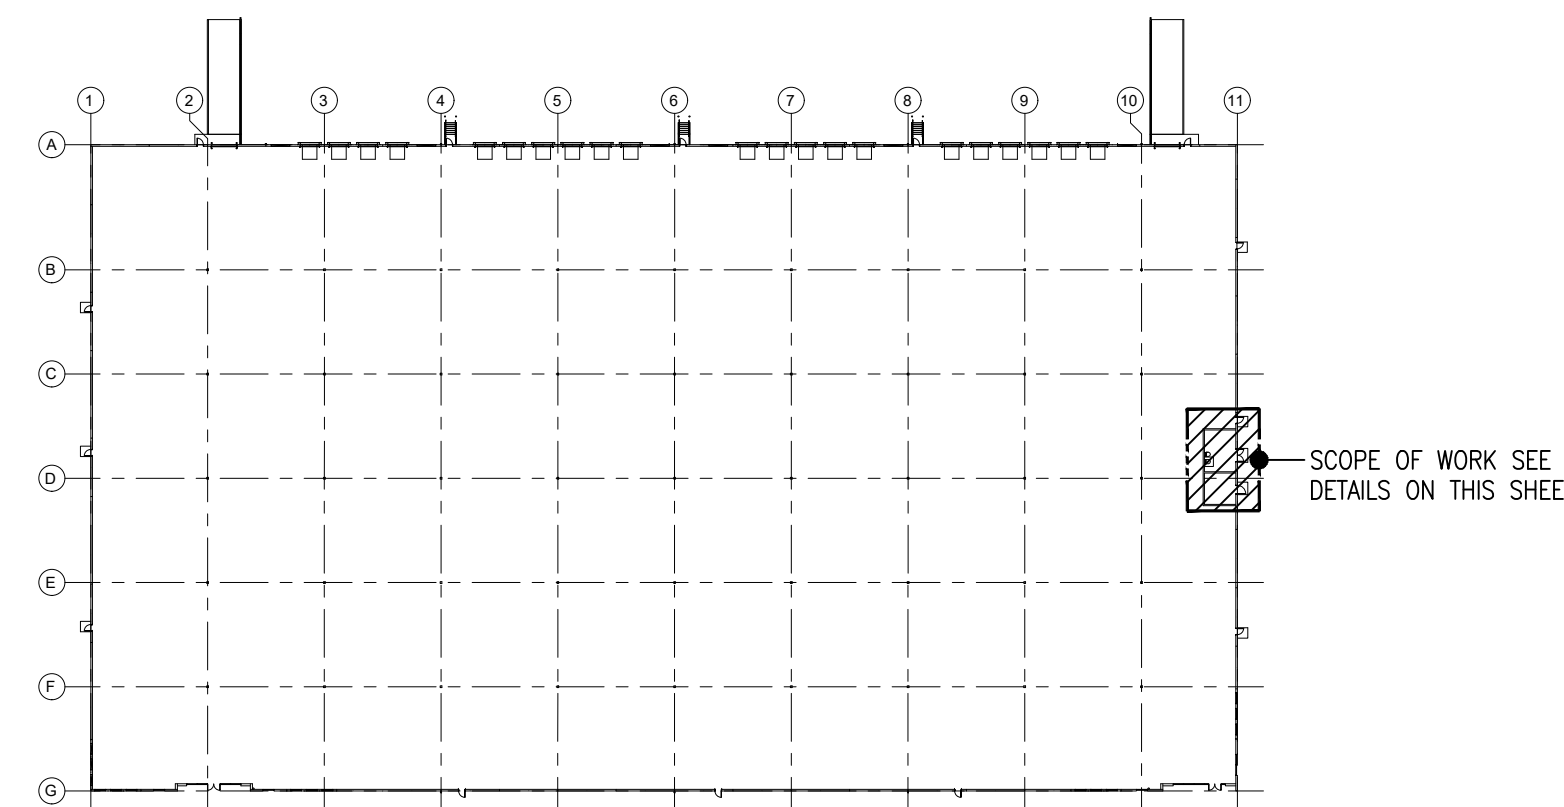

KEY PLAN  
SCALE: NONE