



Plumbing Fixture Schedule										NOTES
DWG LABEL	ROUGH-IN CONNECTION SIZE (INCHES)				BARRIER FREE	AGE GROUP	RIM HEIGHT	DESCRIPTION		
	SAN	VENT	CW	HW						
WC "A"	4	2	1	-	NO	ADULT	15"	VITREOUS CHINA, FLOOR MOUNTED, BOTTOM OUTLET WITH BATTERY OPERATED SENSOR FLUSH VALVE AND SEAT.	1, 2, 3	
WC "B"	4	2	1	-	YES	ADULT	16.5"	ACCESSIBLE, VITREOUS CHINA, FLOOR MOUNTED, BOTTOM OUTLET WITH BATTERY OPERATED SENSOR FLUSH VALVE AND SEAT.	1, 2, 3	
WC "C"	4	2	1	-	NO	ADULT	15"	VITREOUS CHINA, WALL MOUNTED WITH SUPPORT, TOP SPUD, BATTERY OPERATED SENSOR FLUSH VALVE AND SEAT.	1, 2, 3	
WC "D"	4	2	1	-	YES	ADULT	17"	ACCESSIBLE, VITREOUS CHINA, WALL MOUNTED WITH SUPPORT, TOP SPUD, BATTERY OPERATED SENSOR FLUSH VALVE AND SEAT.	1, 2, 3	
UR "A"	2	1 1/2	3/4	-	NO	ADULT	24"	VITREOUS CHINA, WALL MOUNTED WITH SUPPORT, TOP SPUD AND BATTERY OPERATED SENSOR FLUSH VALVE.	1, 2, 3	
UR "B"	2	1 1/2	3/4	-	YES	ADULT	17"	ACCESSIBLE, VITREOUS CHINA, WALL MOUNTED WITH SUPPORT, TOP SPUD AND BATTERY OPERATED SENSOR FLUSH VALVE.	1, 2, 3	
LAV "A"	1 1/2	1 1/2	1/2	1/2	NO	ADULT	31"	VITREOUS CHINA, WALL MOUNTED WITH SUPPORT, MANUAL, TWO-HANDLE COMMERCIAL FAUCET, SUPPLIES, TAILPIECE AND TRAP.	1, 2, 3	
LAV "B"	1 1/2	1 1/2	1/2	1/2	YES	ADULT	34"	ACCESSIBLE, VITREOUS CHINA, WALL MOUNTED WITH SUPPORT, ACCESSIBLE, MANUAL, TWO-HANDLE COMMERCIAL FAUCET, SUPPLIES, OFFSET TAILPIECE AND VANDAL RESISTANT TRAP.	1, 2, 3	
SINK "A"	1 1/2	1 1/2	1/2	1/2	NO	-	-	PLASTIC LAUNDRY TUB, FREESTANDING.	1, 2	
MR "A"	3	2	3/4	3/4	NO	-	-	24" x 24" FLOOR MOUNT RECEPTOR W/ SERVICE SINK FAUCET, RIM GUARD, DRAIN, HOSE AND BRACKET, AND MOP BRACKET.	1, 2, 3	
SHR "A"	-	-	1/2	1/2	YES	ADULT	-	ACCESSIBLE, FACTORY-FABRICATED, RECESSED SHOWER CABINET WITH VALVE ON LEFT/ SEAT ON RIGHT, SEVERE SERVICE HEAD, DIVERTER VALVE, HAND-HELD SHOWER SPRAY, RECESSED SOAP DISH AND VANDAL RESISTANT SCREWS.	1, 2, 3	
SHR "B"	-	-	1/2	1/2	YES	ADULT	-	ACCESSIBLE, FACTORY-FABRICATED, RECESSED SHOWER CABINET WITH VALVE ON RIGHT/ SEAT ON LEFT, SEVERE SERVICE HEAD, DIVERTER VALVE, HAND-HELD SHOWER SPRAY, RECESSED SOAP DISH AND VANDAL RESISTANT SCREWS.	1, 2, 3	
EWV "A"	1 1/2	1 1/2	1/2	-	YES	ADULT	-	WALL MOUNTED, ACCESSIBLE, DUAL HEIGHT, PRESSURE WATER COOLER WITH FILTERED BOTTLE FILLING STATION.	1, 2, 3	
INT WH	-	-	3/4	-	-	-	-	CONCEALED OUTLET, SELF DRAINING MODERATE CLIMATE WALL HYDRANT.	1, 2	
FD "A"	4	2	-	-	-	-	-	MEDIUM DUTY, CAST-IRON FLOOR DRAIN WITH 7" DIAMETER NICKEL BRONZE STRAINER, DEEP-SEAL P-TRAP AND TRAP SEAL DEVICE.		
NOTES:										
1. SIZES INDICATED ARE MINIMUM. LARGER SIZES SPECIFICALLY INDICATED ON DRAWINGS SUPERCEDE MINIMUM SIZES INDICATED IN THIS SCHEDULE.										
2. PROVIDE TERMINATION STYLE AND SIZE FOR FIXTURE CONNECTIONS AS INDICATED BY FIXTURE MANUFACTURER.										
3. REFER TO TOILET ROOM PLANS ON ARCHITECTURE DRAWINGS FOR FIXTURE CENTERLINE DIMENSIONS.										

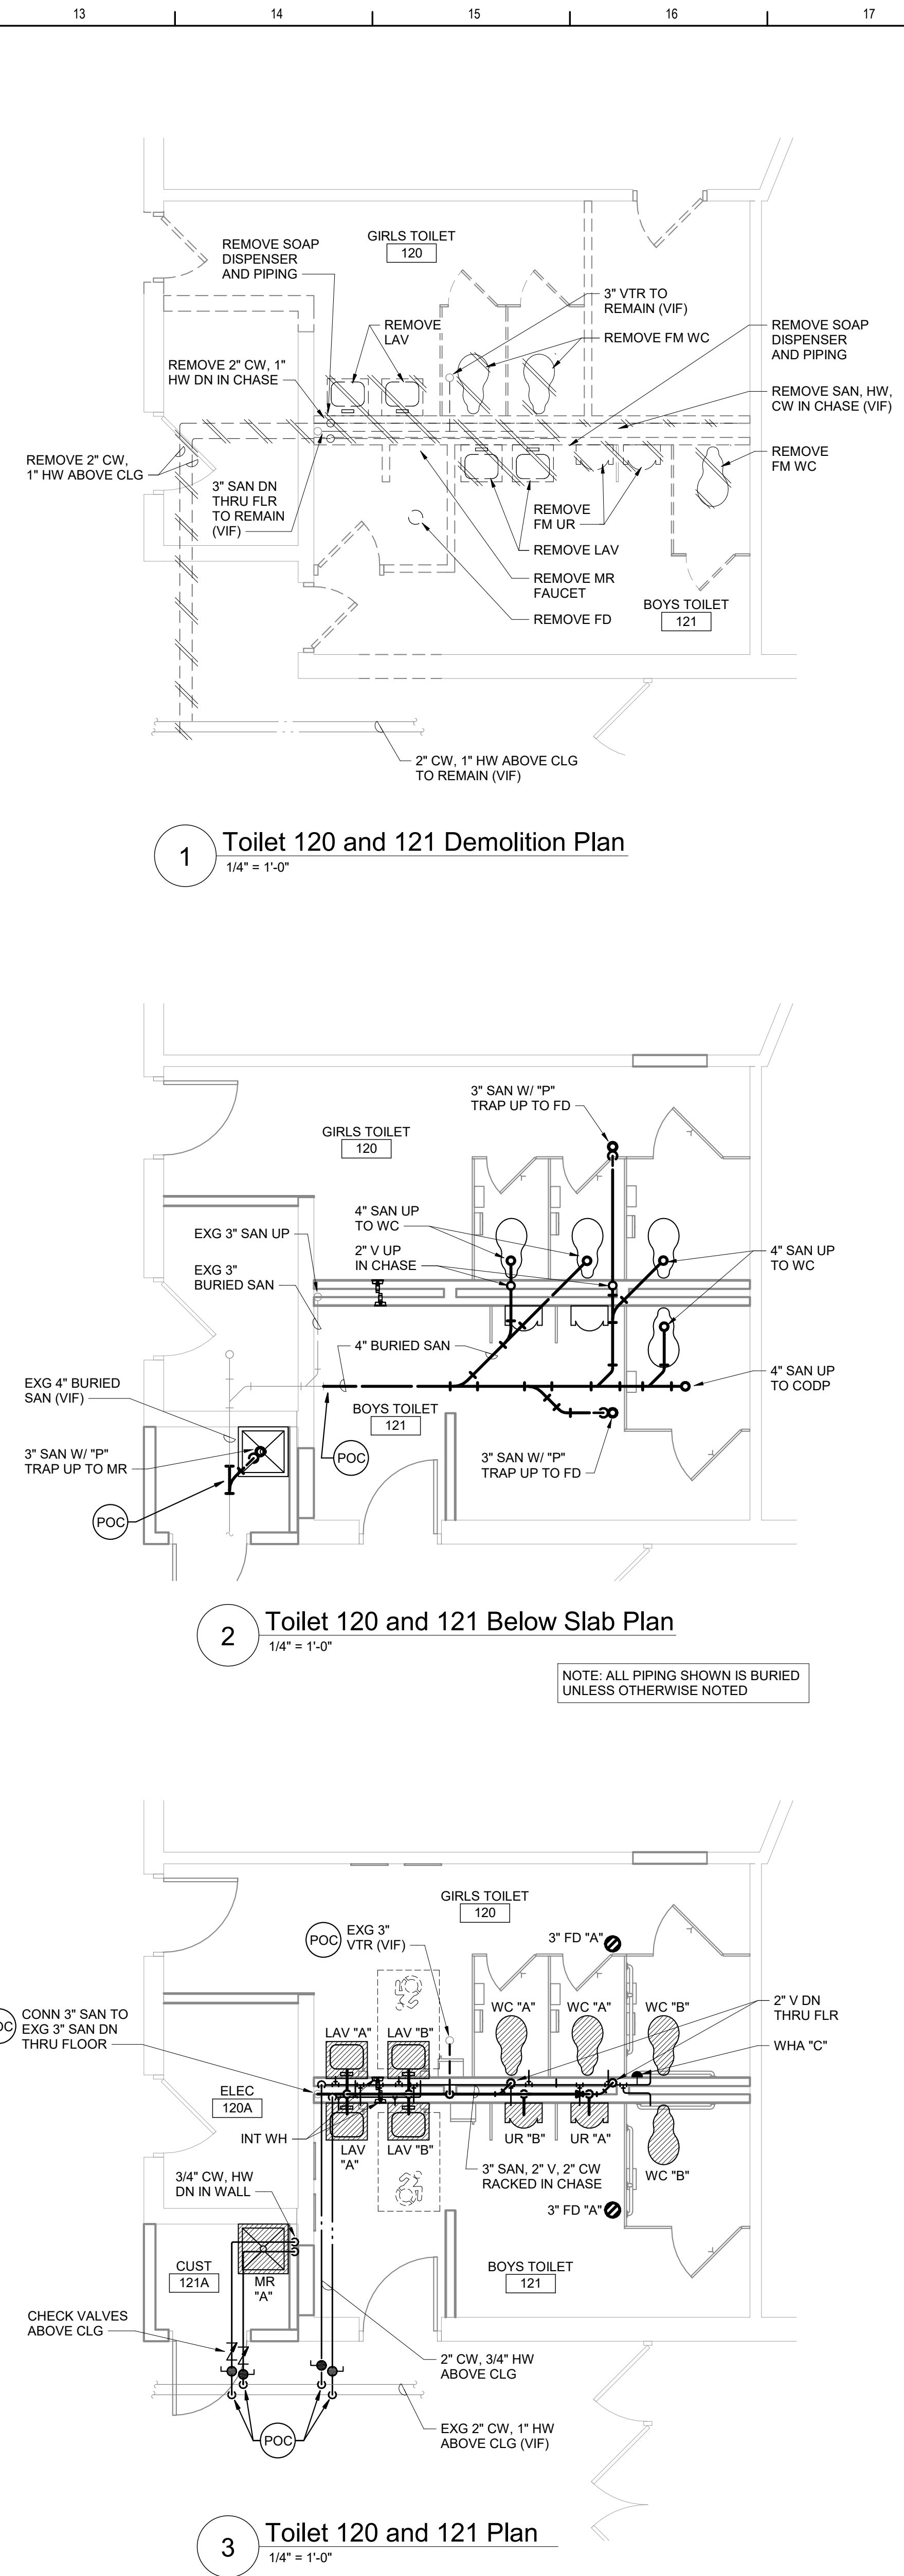


- Plan Notes**
- A. REFER TO DRAWING NO. AP050 FOR GENERAL NOTES.
 - B. REMOVE PLUMBING FIXTURES INDICATED, INCLUDING ASSOCIATED PIPING, FASTENERS, SUPPORTS, ETC., BACK TO POINTS OF CONCEALMENT WITHIN OR BEHIND REMAINING WALLS, BELOW FLOORS OR ABOVE CEILINGS.
 - C. REMOVE ABANDONED ACCESSIBLE PIPING TO MAIN BRANCHES, STACKS OR RISERS AS REQUIRED TO ELIMINATE EXPOSED PIPING AND DEAD END PIPING RUNS LONGER THAN 1'-0". COORDINATE CONCEALMENT OF PIPING WITH FINAL CONSTRUCTION OF WALLS, FLOORS AND CEILINGS.

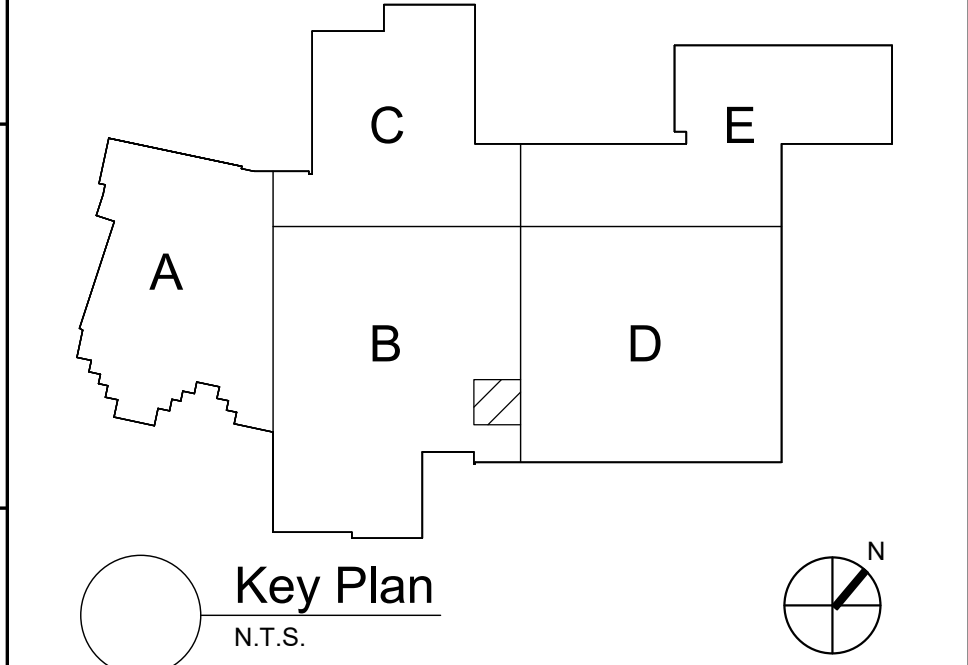

S.E.D. Control No. 62-18-01-06-0-007-019

Rev. No.	Date	Description

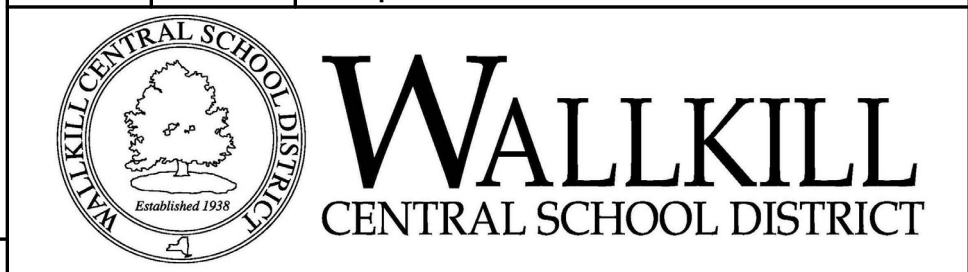

complex world | CLEAR SOLUTIONS

Tetra Tech Engineers, Architects & Landscape Architects, P.C.

BID SET



Walkkill Central School District
Walkkill, New York

Reconstruction to:
Walkkill Senior High School

Enlarged Toilet Room Plans, Details
and Schedule

Drawn By: BCL	Date: 06/30/2023	Drawing Number:
Project No.: 17597-22002	AP404	