

GENERAL NOTES


- ON ALL ROOFS AN INFRARED CAMERA WAS USED TO SURVEY THE INSULATION IN THE ROOF SYSTEM. WHERE NECESSARY NUCLEAR METER READINGS WERE TAKEN TO VERIFY THE FINDINGS OF THE INFRARED CAMERA.
- WET AREAS ARE IDENTIFIED ON ROOF PLANS BY HATCHING. IRREGULARLY SHAPED WET AREAS MAY HAVE BEEN SQUARED OFF.
- WET AREAS ARE IDENTIFIED ON ROOF PLAN INTEREAS APPROXIMATE CORRESPONDING LOCATIONS.
- ALL ROOF TOP EQUIPMENT MAY NOT HAVE BEEN SHOWN.
- ALL EQUIPMENT LOCATIONS APPROXIMATE.

PLAN SYMBOLS

- DRY INSULATION
- 1 SQ. FT. OR LESS OF WET INSULATION
- 25 DAMP TO WET INSULATION
NUMBER ADJACENT TO SYMBOL INDICATES APPROXIMATE SIZE OF WET AREA IN SQUARE FEET.
- 25RW RANDOM WET AREA
RANDOM WET DEFINES AN AREA THAT CONTAINS A CLOSELY GROUPED MIXTURE OF DRY, DAMP AND WET INSULATION. THE RANDOM DISPERSMENT OF THE DAMP AND WET INSULATION MAKES IT IMPOSSIBLE OR IMPRACTICAL TO ISOLATE AND IDENTIFY EACH DAMP OR WET SPOT.
- TEST CORE
- T-1 THERMOGRAPH
- 10 NUCLEAR MOISTURE READING
- ⊕ ROOF DRAIN
- ☒ ROOF TOP EQUIPMENT
- ☐ CHIMNEY
- SL SKYLIGHT
- H HATCH

PART ROOF PLAN - WALLKILL SENIOR HIGH SCHOOL

SCALE : 1/16" = 1' - 0"

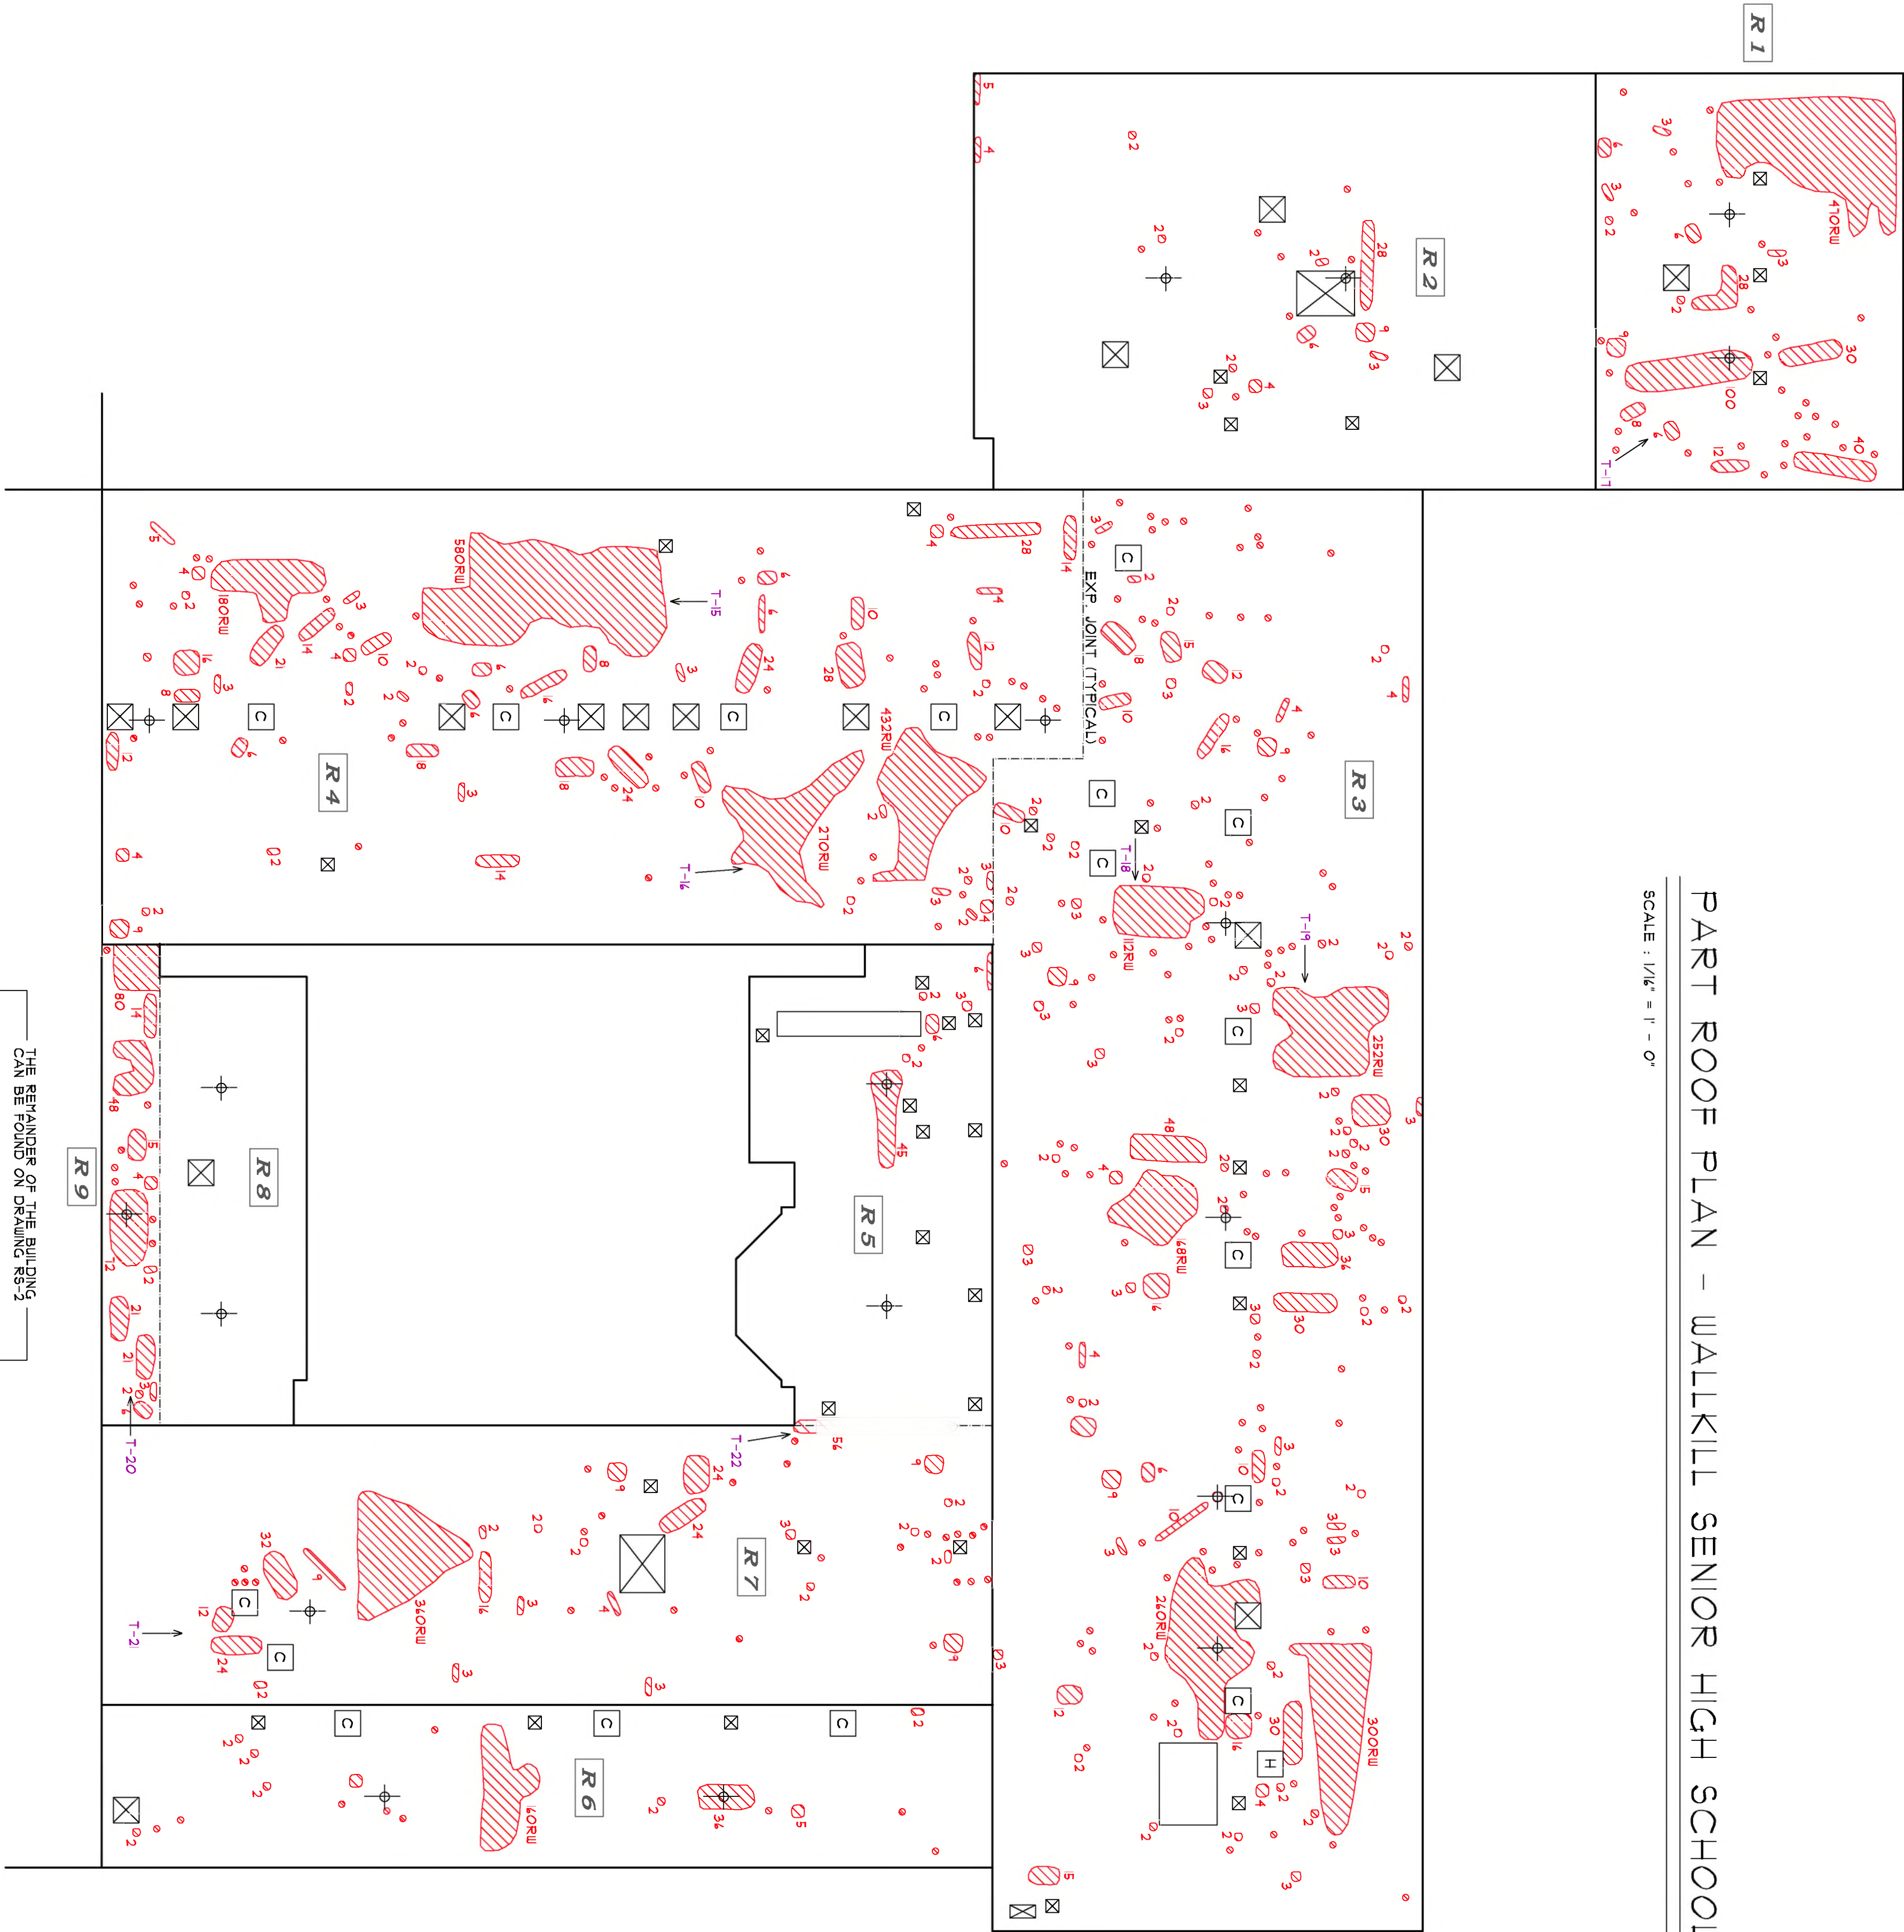

CLIENT:
TETRA TECH ARCHITECTS & ENGINEERS
10 BROWN ROAD
ITHACA, NY 14850

BUILDING:
WALLKILL CENTRAL SCHOOL DISTRICT
WALLKILL SENIOR HIGH SCHOOL
WALLKILL, NY 12581

SURVEY DATES	JOB NO.
MOISTURE: 6/14/22	22-0401-05
ASBESTOS:	

SCALE: 1/16" = 10'	DRAWING NO. RS-11
--------------------	-------------------