



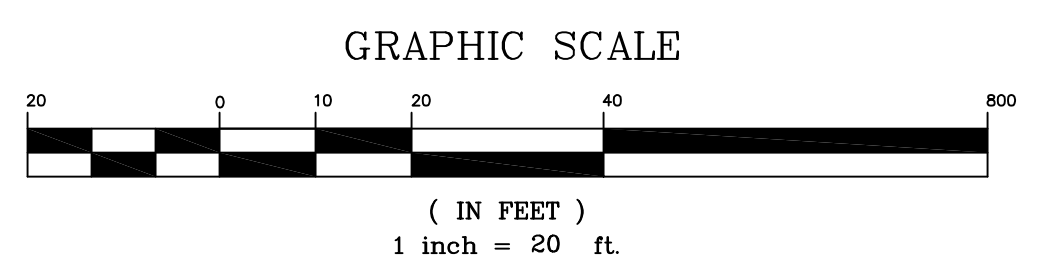

LOOMIS AVENUE

RIDGE STREET

WASHINGTON STREET

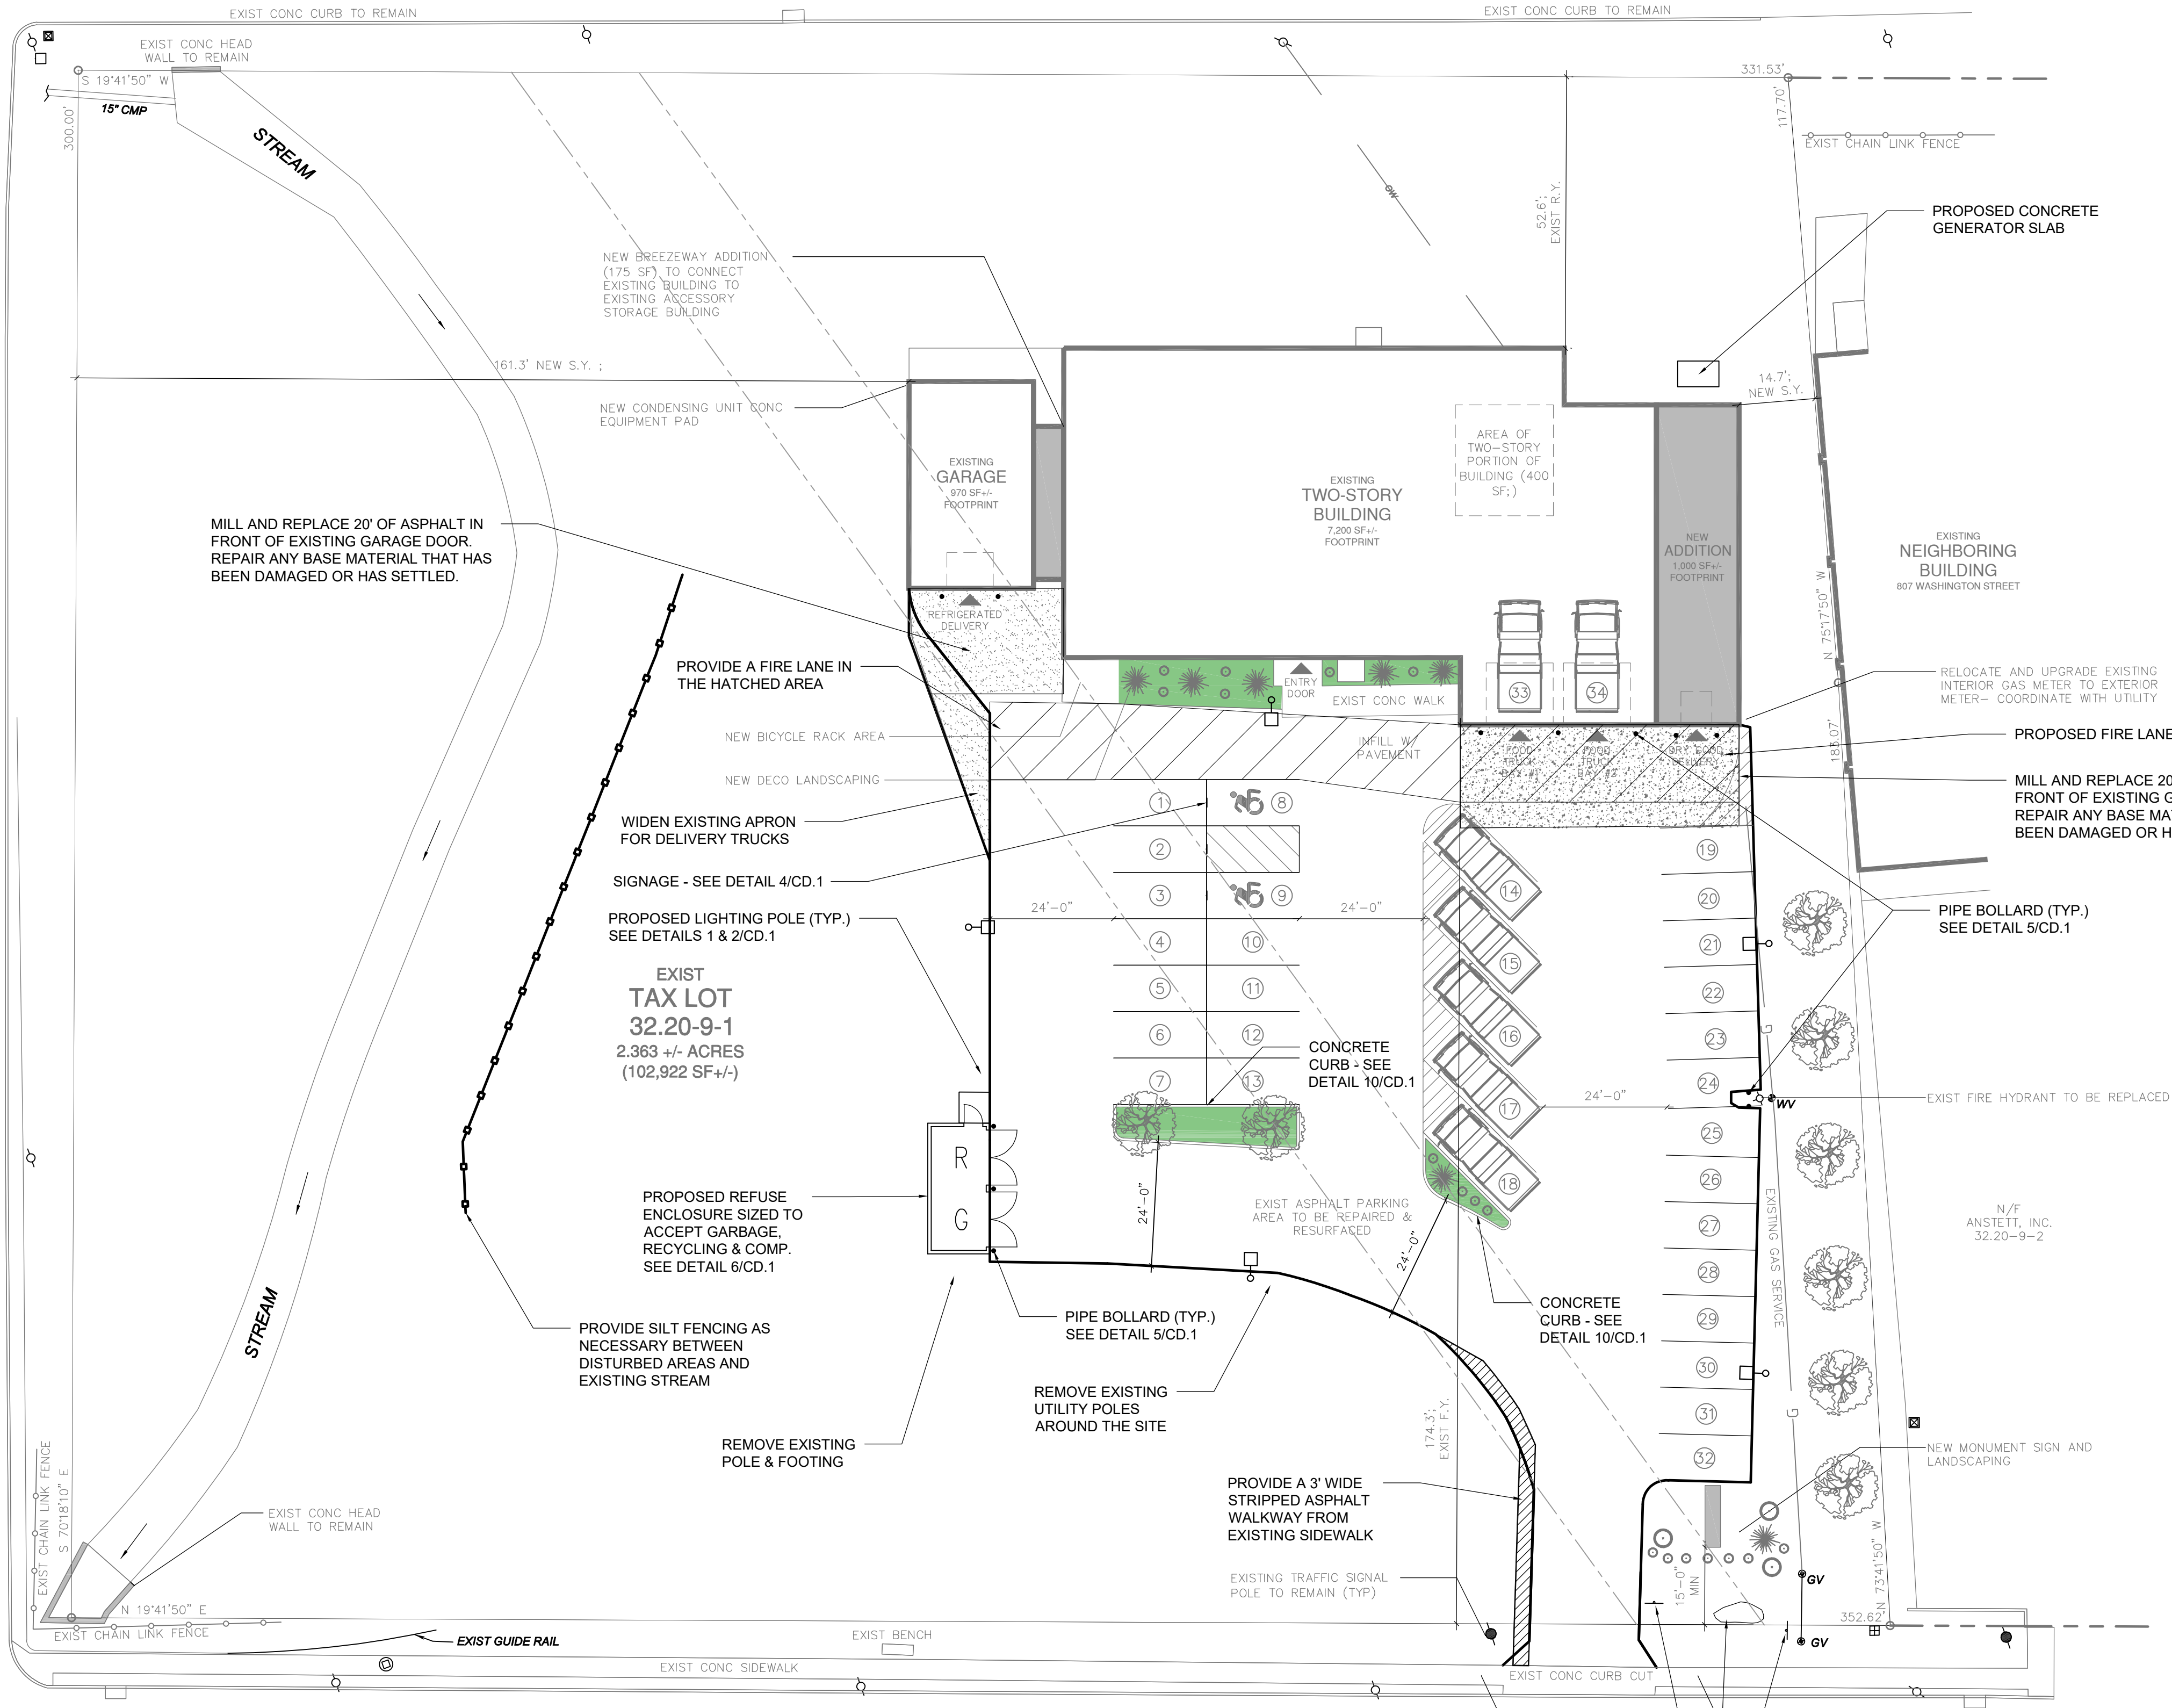

**Dig Safely. New York**  
Dig Safely and Dig Safely New York are used under license from Dig Safe System, Inc.

- Call Before You Dig
- Wait The Required Time
- Confirm Utility Response
- Respect The Marks
- Dig With Care

**800-962-7962**  
[www.digsafelynewyork.com](http://www.digsafelynewyork.com)

IT IS A VIOLATION OF NEW YORK STATE EDUCATION LAW FOR ANY PERSONS TO ALTER THESE PLANS, SPECIFICATIONS, OR REPORTS IN ANY WAY, UNLESS ACTING UNDER THE DIRECTION OF A LICENSED PROFESSIONAL ENGINEER OR LAND SURVEYOR.

Mark A. Day, PE	
05-03-24	
04-17-24	
03-19-24	
02-20-24	
01-24-24	
2021:288	License No. 069646

**DAY STOKOSA**  
ENGINEERING P.C.

3 Van Wyck Lane  
Wappingers Falls, New York  
(845)-223-3202

**PROJECT**  
Peekskill Firehouse Kitchen Incubator  
701 Washington Street  
City of Peekskill Westchester County, New York

<b>Proposed Site Plan</b>		
SCALE 1" = 20'	DRAWN BY MAD	<b>SP.1</b>
DATE 11-02-23	CHECKED BY MAD	